


FOUNDATION PLAN

SCALE 1/8" = 1'-0"

ROOM FINISH SCHEDULE

ROOM	FL.	BASE	WALLS	CLG.	CIGHT	REMARKS
GYM.	COMP.	VINYL	5/8" PTD SHTRK E.C.	INSUL	22'	MANUAL FIRE ALARMS TO BE INSTALLED AT P.E. CODES
STAGE	W.D.	DO	DO	DO	DO	
STOR.	PTD CONC.	DO	DO	DO	DO	
LOCK. RMS.	DO	DO	DO	SUS.	10'N.	VAPOR RESISTANT CEIL. TRUSS - ALUM. CLAD GRID
TOILETS (LOCKER ROOMS)	DO	DO	DO	DO	DO	DO
LUNCH RM.	VATILE	DO	DO	DO	DO	
BAUD ROOM	DO	DO	DO	DO	DO	
CORRIDOR	CARPET	DO	DO	DO	DO	ALL CORRIDOR CHAILINGS TO BE ONE-HOUR CLIPPED DOWN
SHOWER	PTD. CONC.	DO	PTD. BLOCK	DO	DO	DO
STOR. (SMALL)	PTD. CONC.	DO	5/8" PTD SHTRK E.C.	DO	DO	
TOILETS (PUBLIC)	C. TILE	CERAM.	DO	DO	DO	

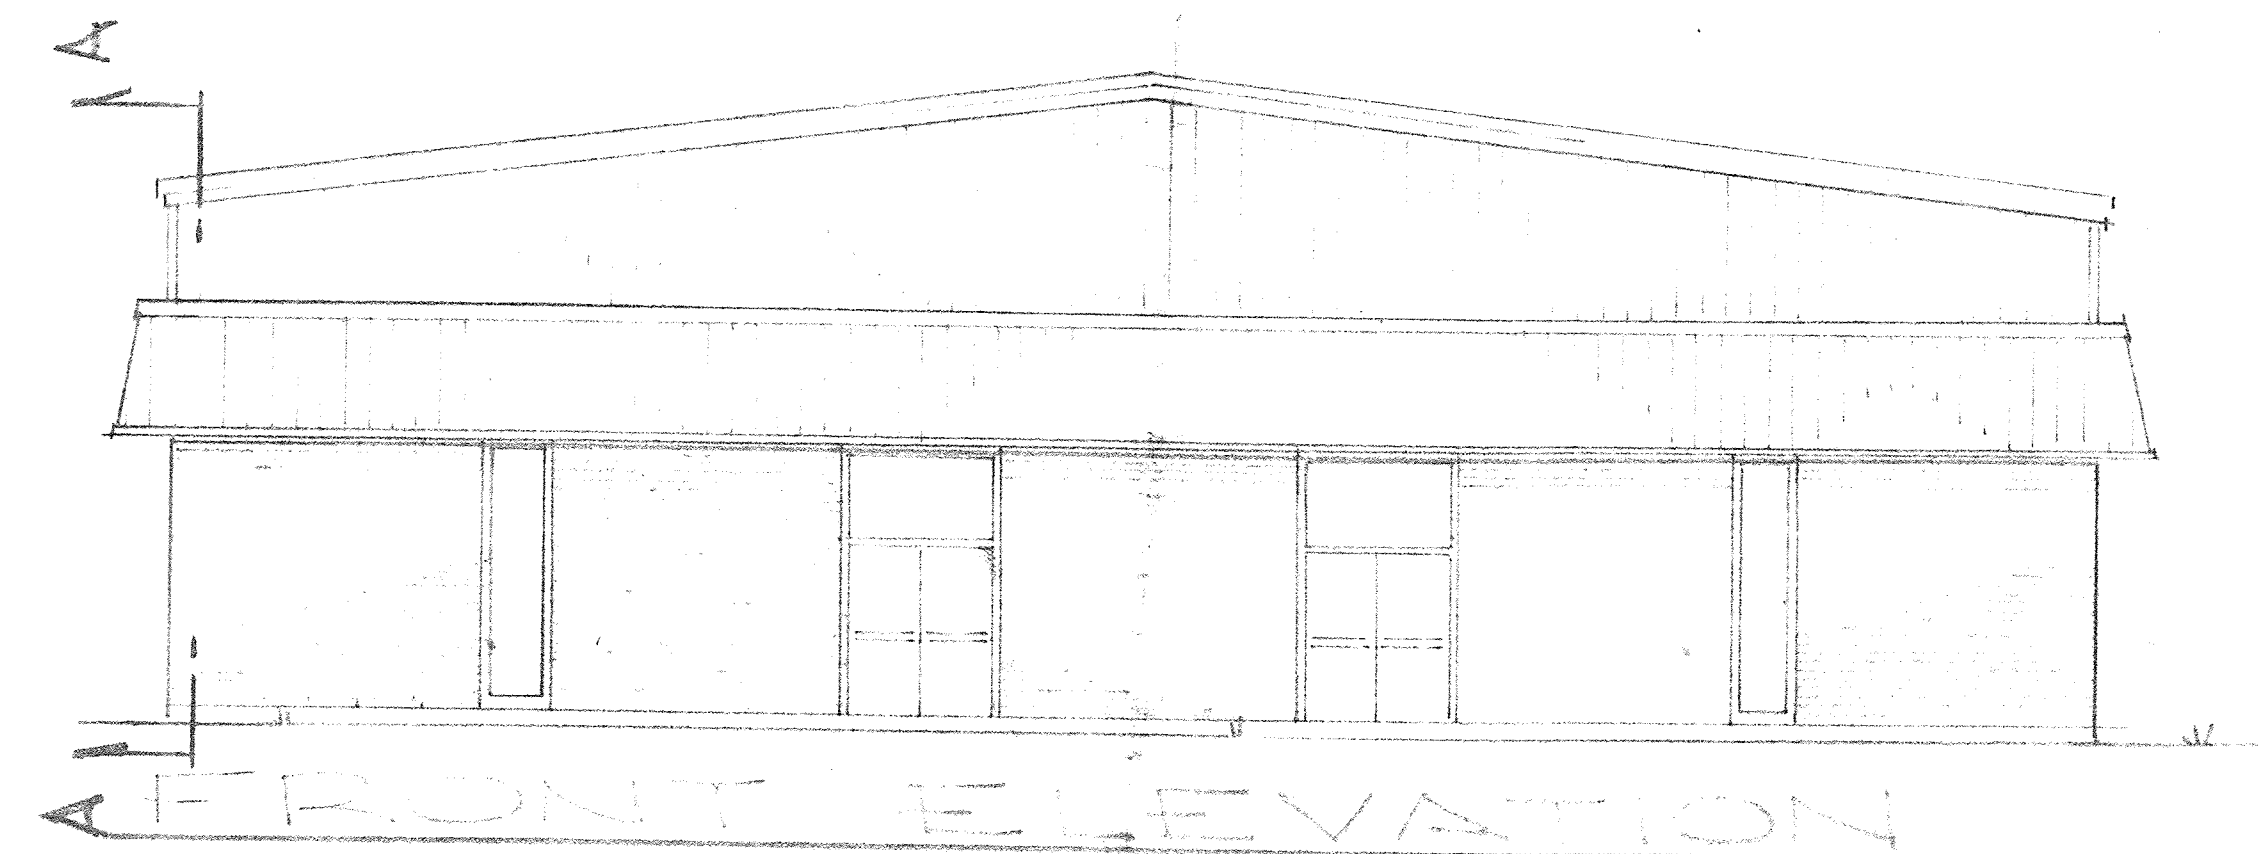

WILMINGTON CHRISTIAN ACADEMY  
N. COLLEGE ROAD

DATE July 1980 SH. 1 OF 7 FOUNDATION & ELEVATIONS GYM