



GRACE BAPTIST  
07001



FLOOR PLAN SCALE: 1/8" = 1'-0"

Calclg = 12-12  
Sched/46 = 23,993.44  
24,466.44 - 134  
17,192 - 9.1  
316,174.4 = 786.0

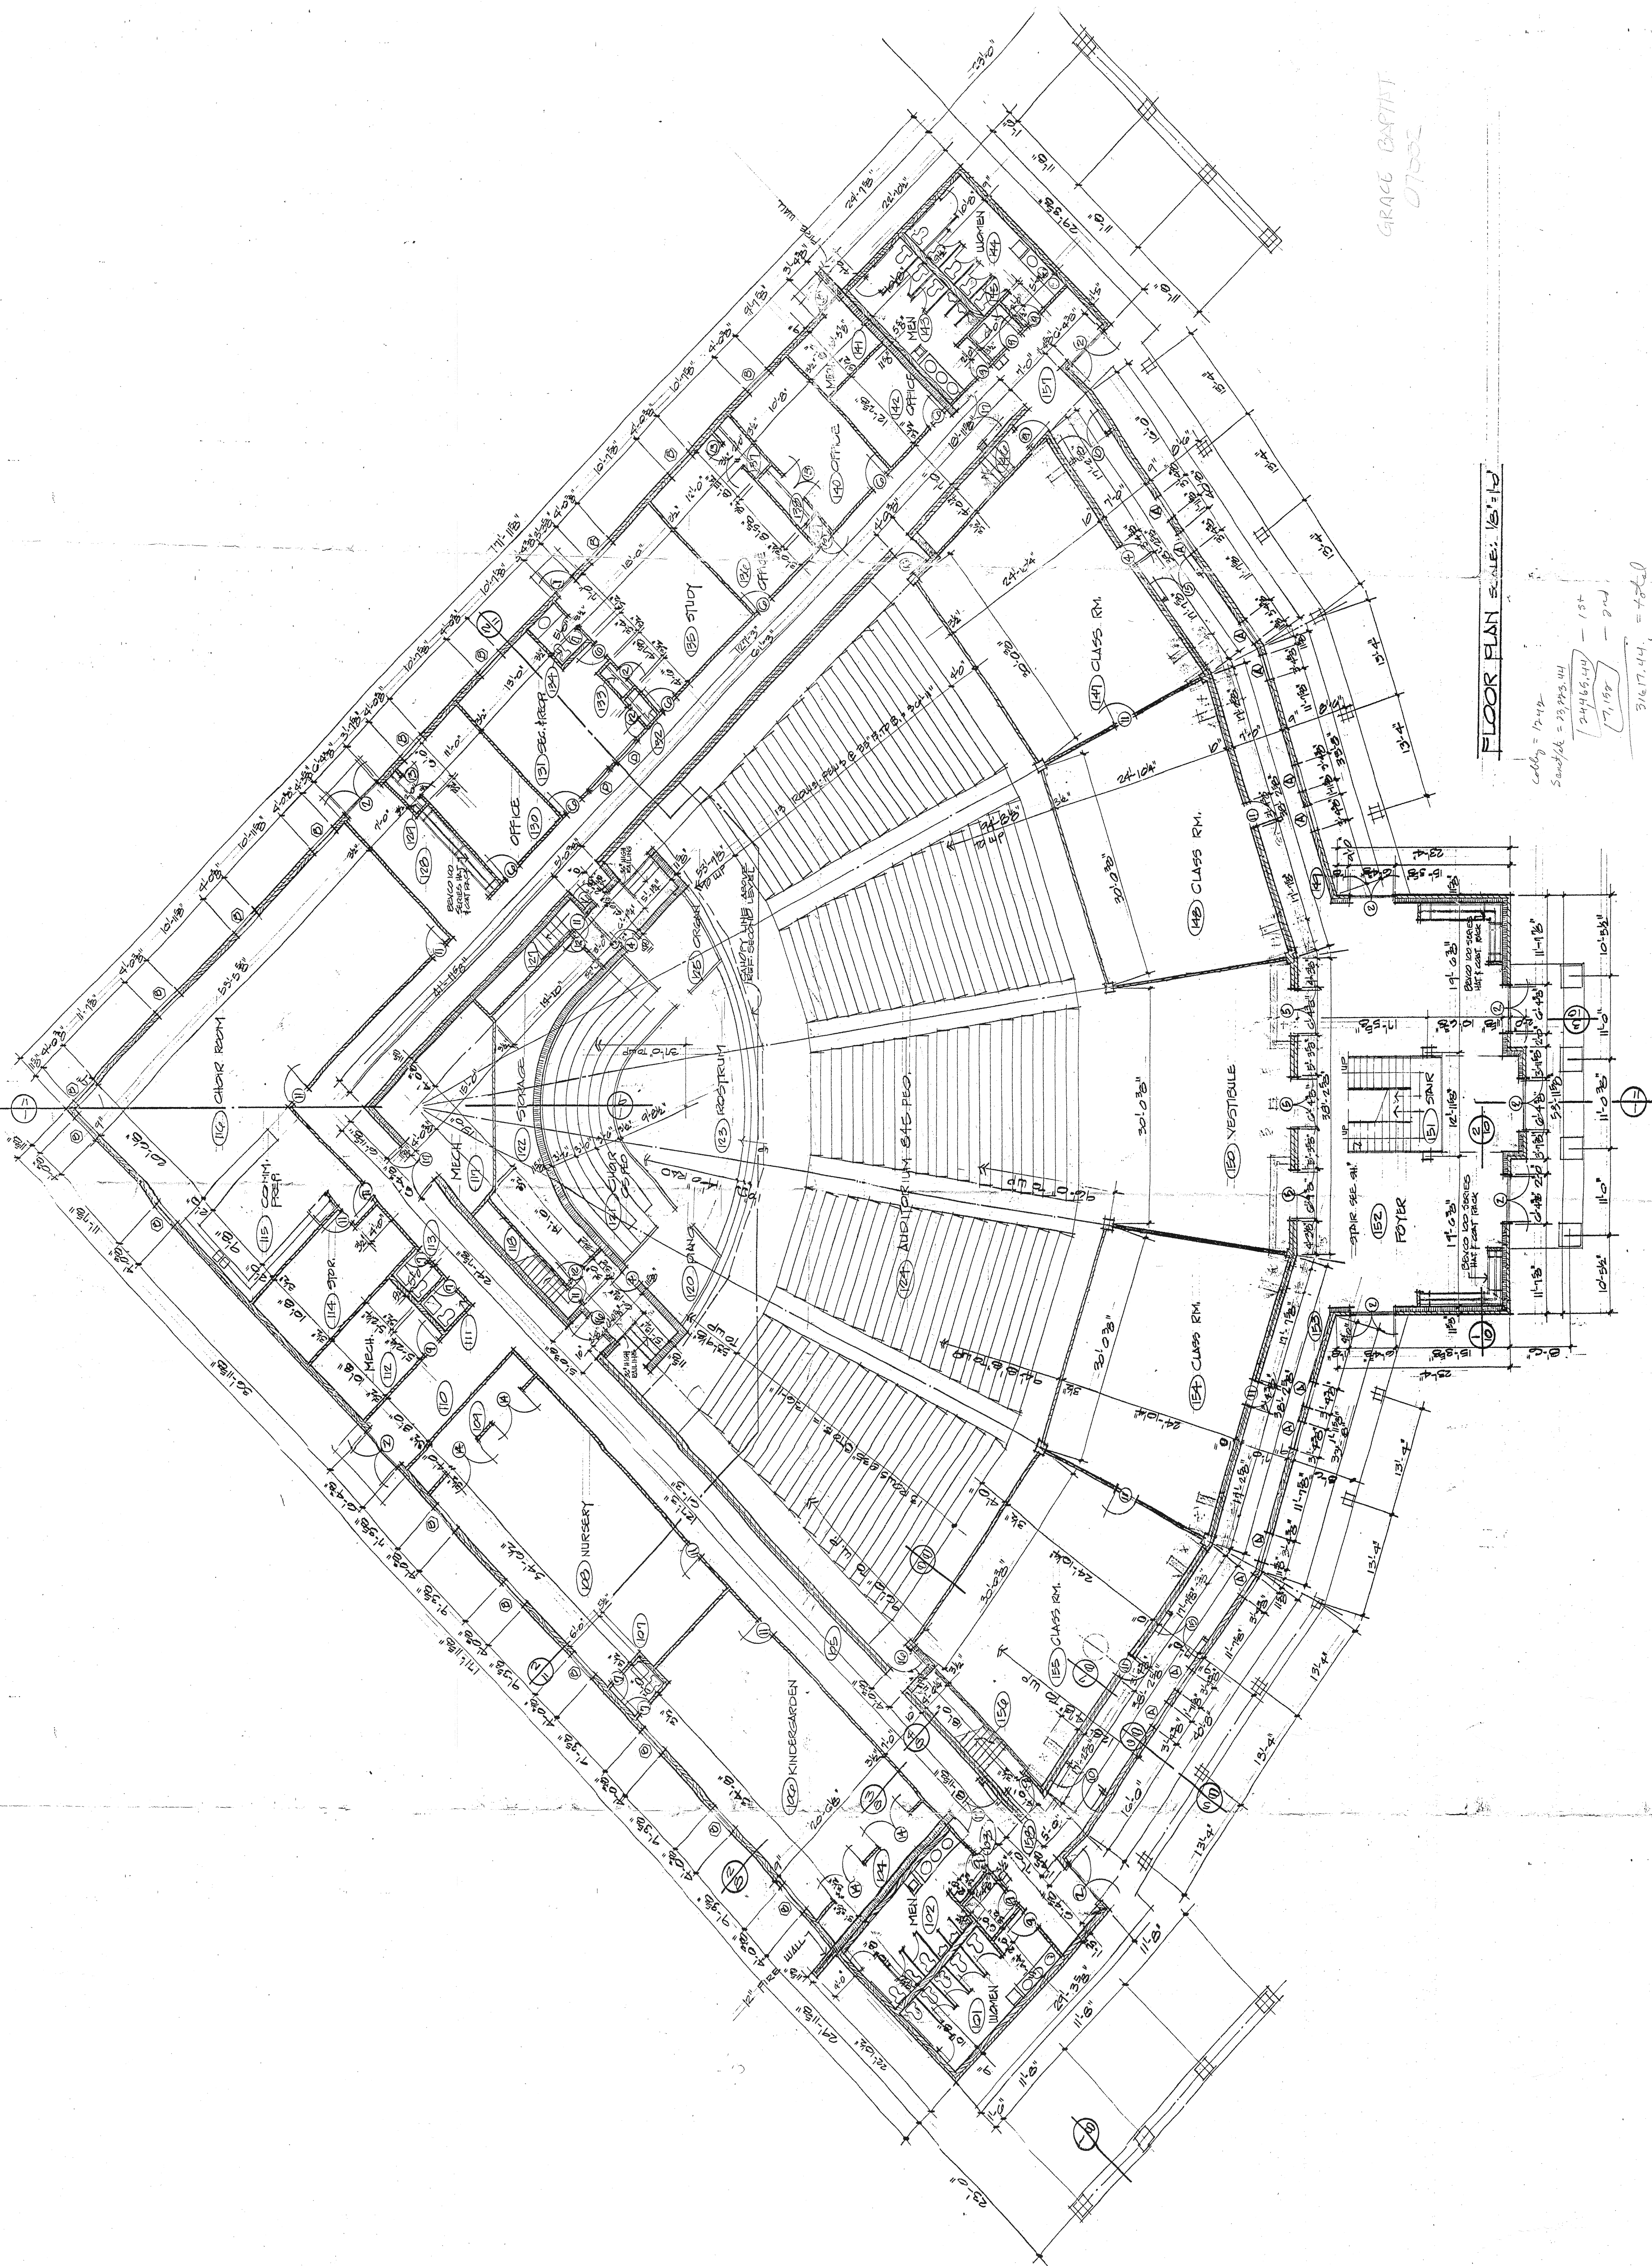

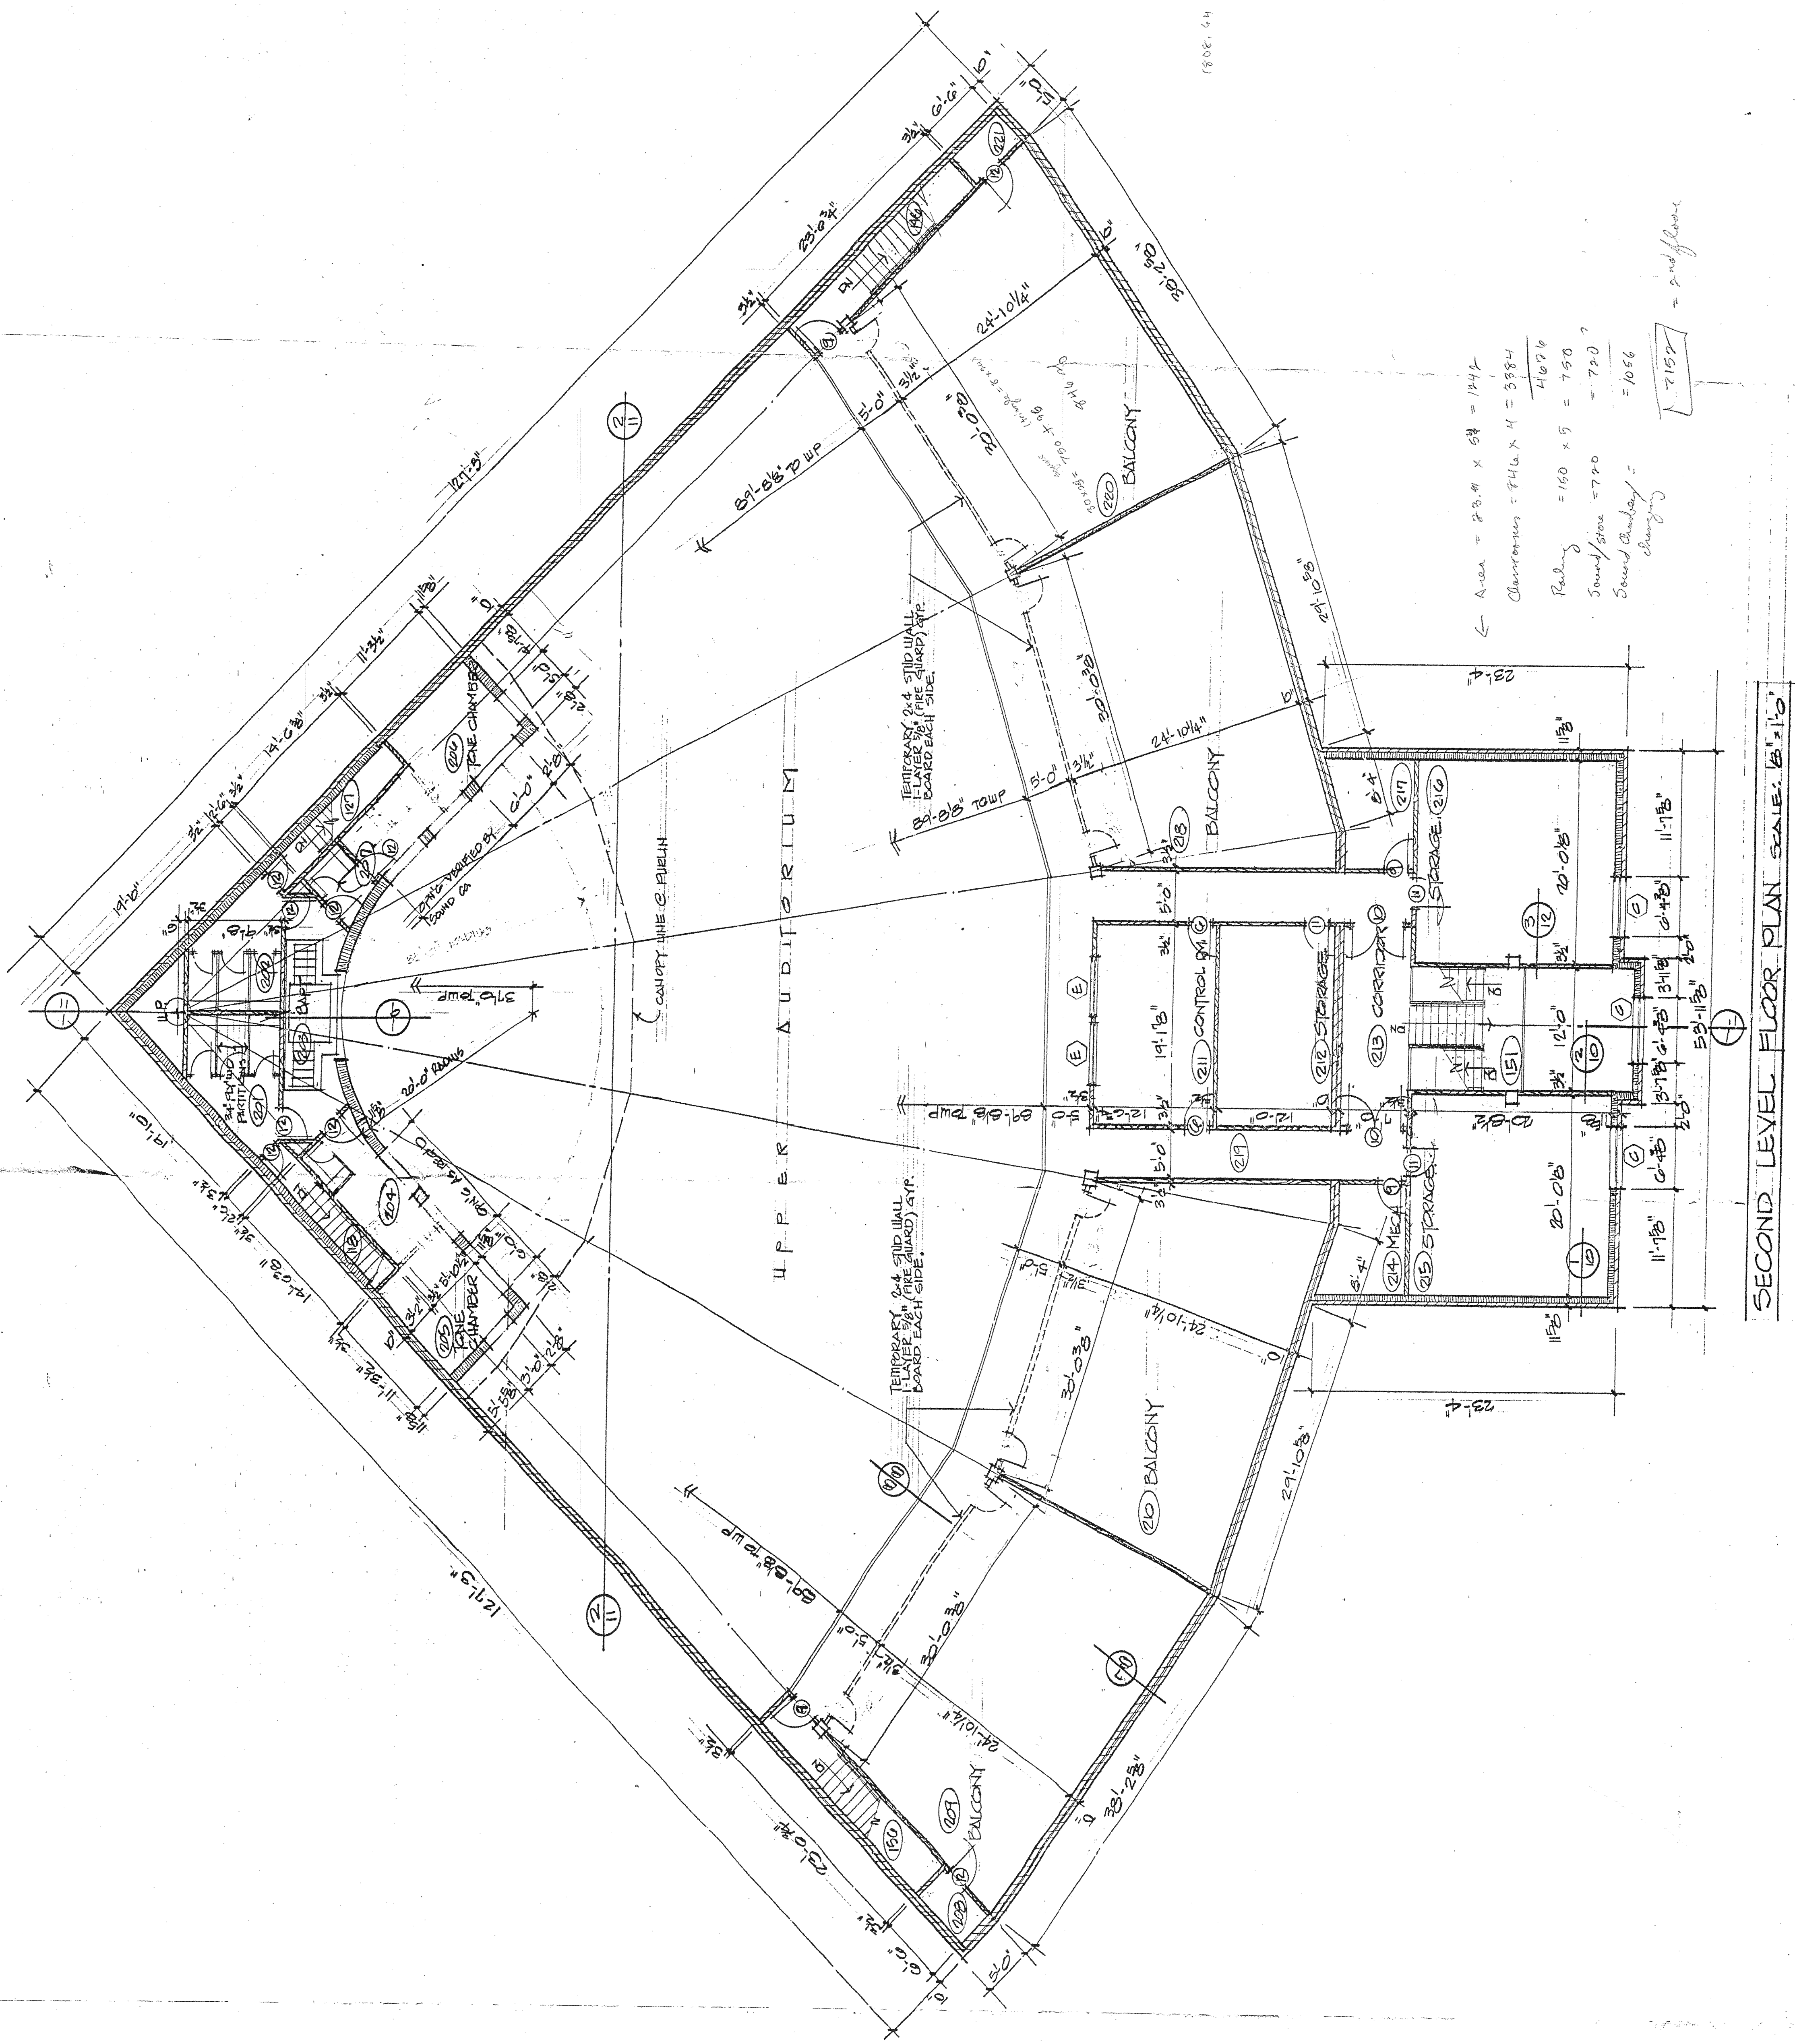


Area = 23.4 x 64 = 1497  
 Characters = 446 x 4 = 3384  
 Reading = 140 x 5 = 700  
 Sound/Spe = 720  
 Sound Amplify = 1056  
 7157 = 2nd floor

SECOND LEVEL FLOOR PLAN SCALE: 1/8" = 1'-0"




ELECTRICAL SYMBOLS	
SYMBOL	DESCRIPTION
○	CEILING OUTLET - LETTER DENOTES TYPE
○-H	BRACKET FUTURE - LETTER DENOTES TYPE
□	FLUORESCENT FIXTURE
⬤	EXIT LIGHT
○-H	DUPLEX CONVENIENCE OUTLET - 100V RECEPTACLE - NO DENOTES HEIGHT ABOVE FLOOR
○	FLOOR CONVENIENCE OUTLET - 100V RECEPTACLE
○-H	WEATHERPROOF OUTLET - 100V
○	220V RECEPTACLE
○	220V FLOOR RECEPTACLE
S	SINGLE POLE SWITCH
S-3	THREE WAY SWITCH
S-4	FOUR WAY SWITCH
⊖	THERMOSTAT
⊖	TELEPHONE OUTLET (FLOOR and WALL MOUNTED)
⊖	TELEVISION ANTENNA OUTLET
⊖	PANEL BOARD
⊖	MOTOR
⊖	MOTOR STARTER
⊖	DISCONNECT SWITCH
⊖	BRANCH CIRCUIT RUN CONCEALED IN CEILING OR WALL
⊖	BRANCH CIRCUIT RUN CONCEALED IN FLOOR SLAB
⊖	HOMERUN TO PANEL BOARD
⊖	MICROPHONE OUTLET
⊖	MICROPHONE
⊖	SPEAKER
⊖	VOLUME CONTROL
⊖	MASTER VOLUME CONTROL
⊖	AMPLIFIER (NUMBER DENOTES WATTS)

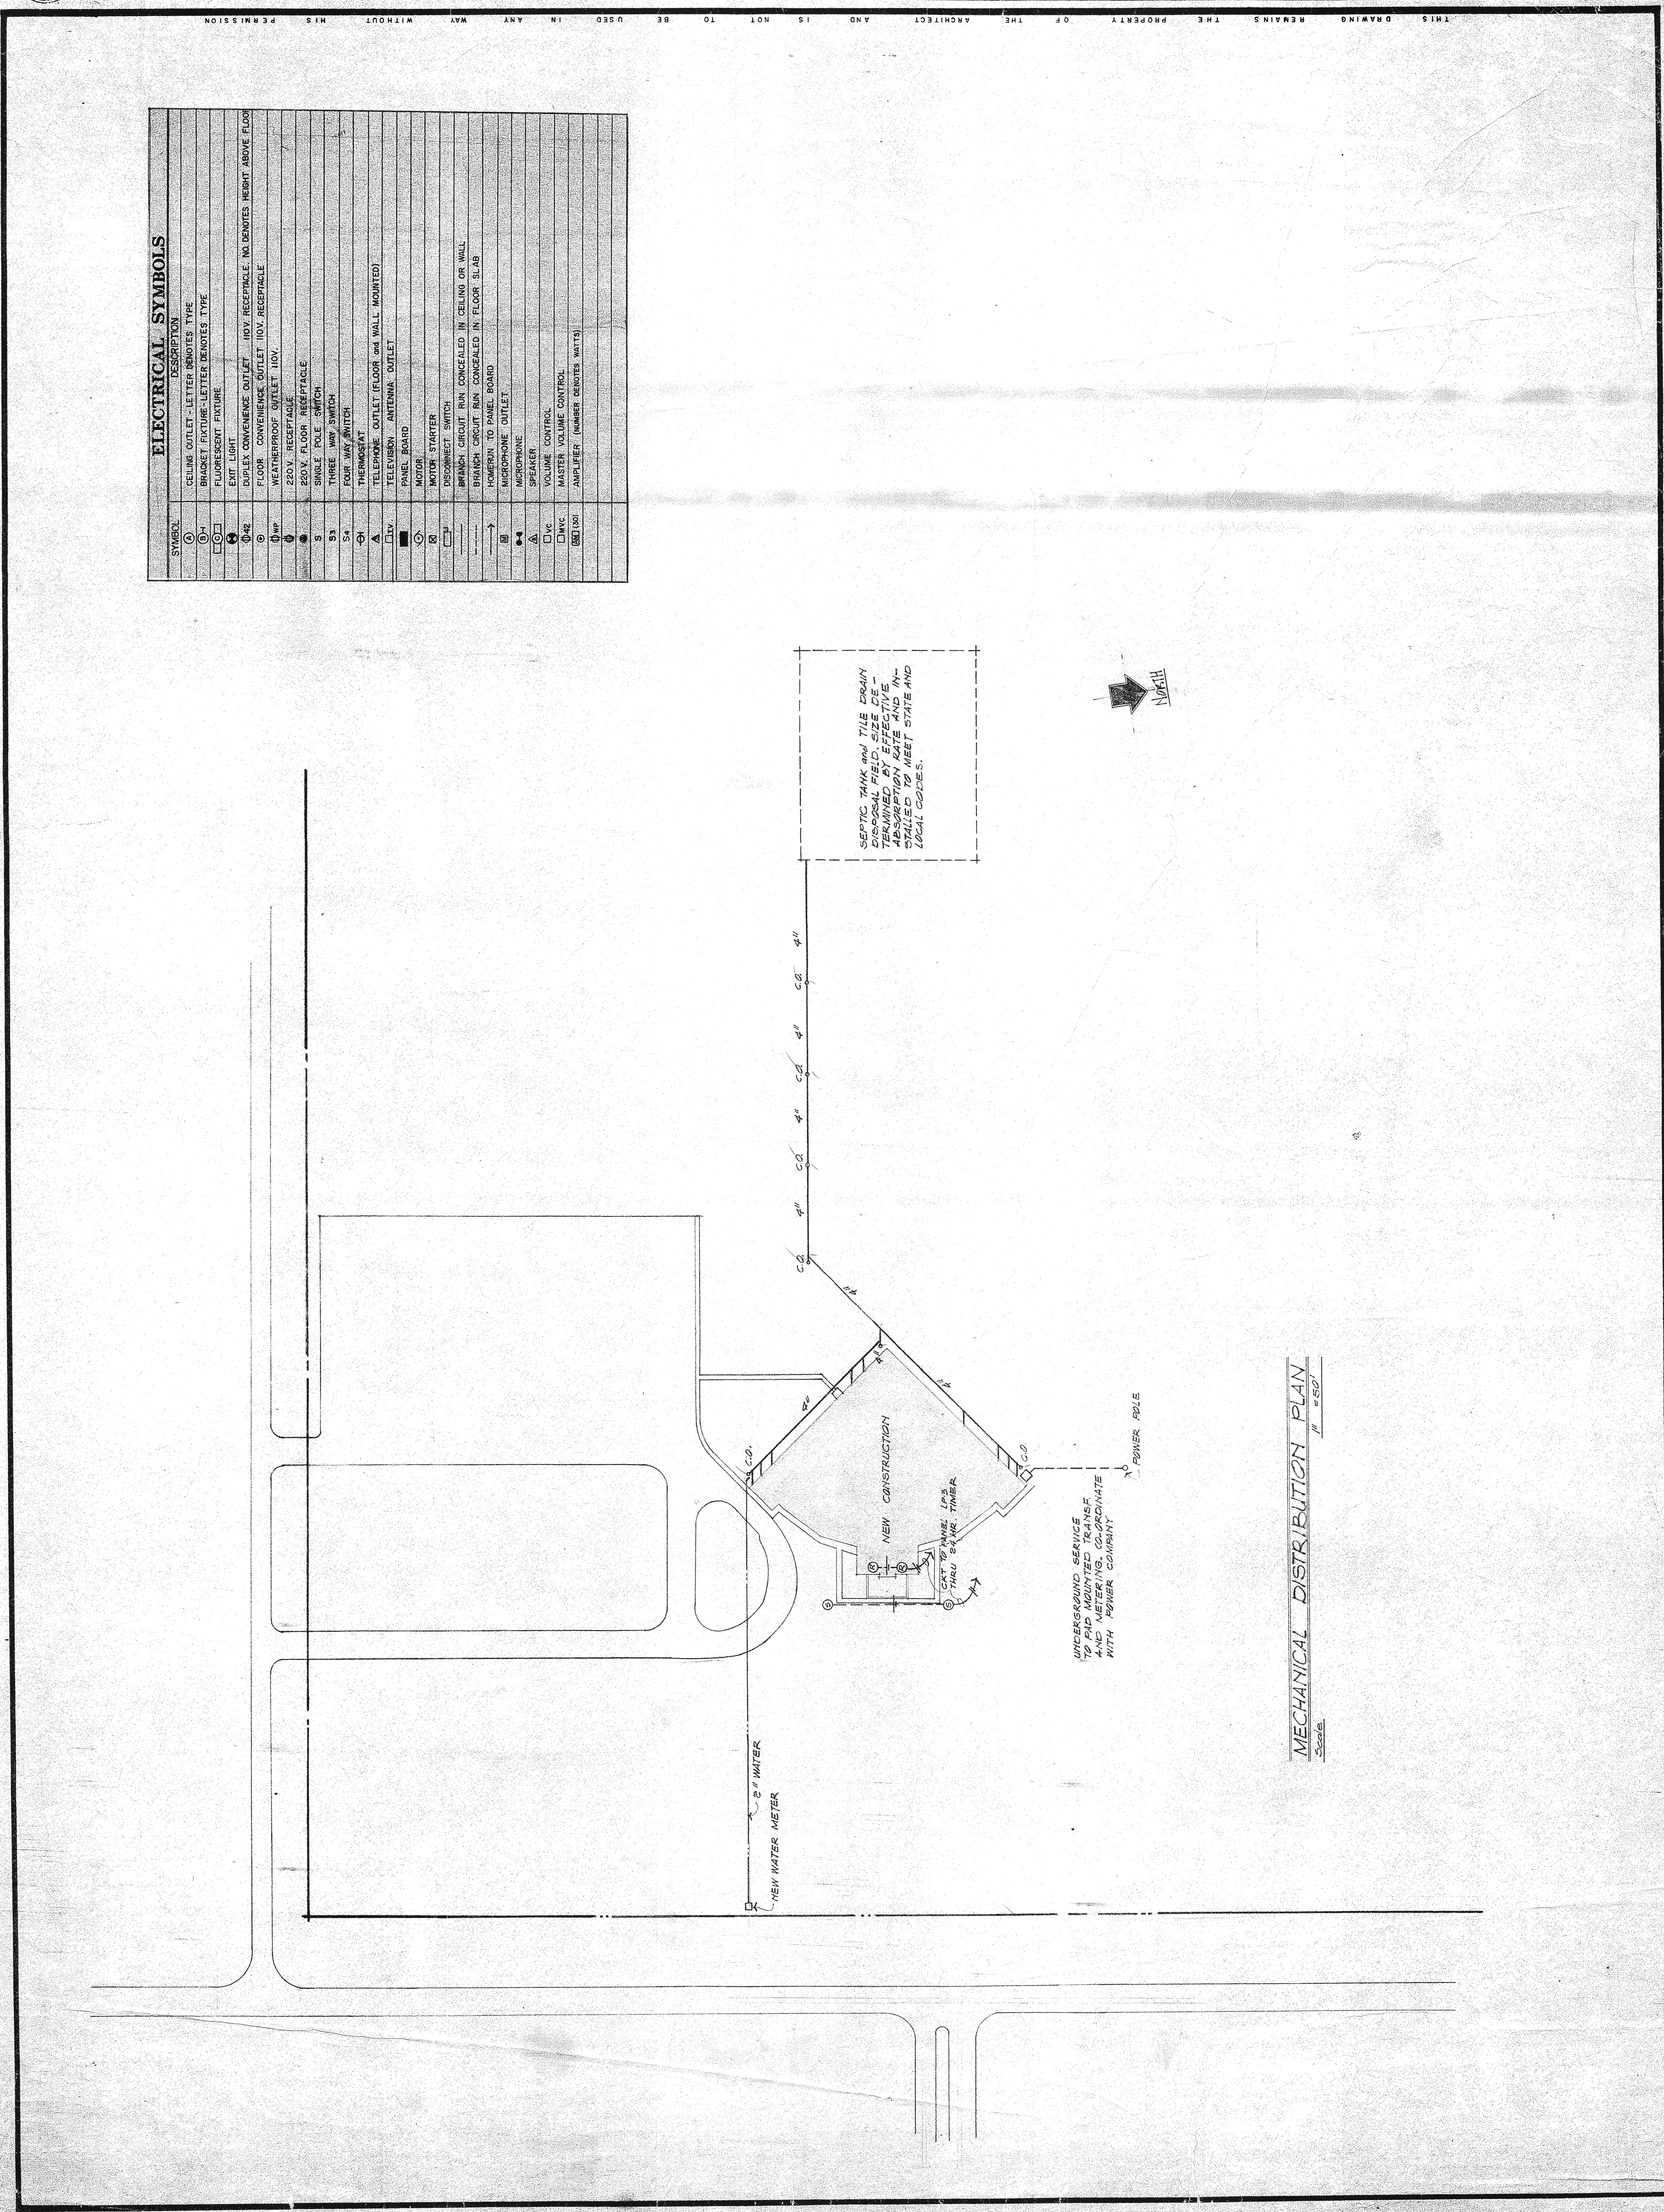



WARK	WPS OR MODEL	LAMPS	MOUNTING
A	MC WALLEN C249-1A	1-500 3-75	PENDANT
B	MC WALLEN C249-1B	1-500 3-12	PENDANT
C	MC WALLEN C249-1C	8-75	SURFACE
D	PRESCLITE 7545-17ES-1	1-500	WALL BRACKET
E	PRESCLITE 7039-7AB	1-800	RECESSED
F	PRESCLITE 1018-7AD	1-75	SURFACE
G	PRESCLITE 7007	2-60	SURFACE
H	PRESCLITE 7015-BA-3	1-150	RECESSED
I	PRESCLITE 7017-M-G-C	2-100	WALL BRACKET
J	PRESCLITE WA 400-1	4-42	SURFACE
K	LITHONIA WA 400-1	4-42	SURFACE
L	PRESCLITE 703AM-7	1-150	RECESSED
M	PRESCLITE 175B-745-OL	1-75	SEMI-RECESSED
N	PRESCLITE 7403S (HARDEN)	1-150	SURFACE
O	PARCELINE REFLECTOR	1-100	SURFACE
P	PRESCLITE 7330-D	1-100 MV	SAFIRE
Q	WIDE LITE SW 400-1WB-150	1-400 MV	ROAD
R			
S			
T			
U			
V			
W			
X			
Y			
Z			
AA			
AB			
AC			
AD			
AE			
AF			
AG			
AH			
AI			
AJ			
AK			
AL			
AM			
AN			
AO			
AP			
AQ			
AR			
AS			
AT			
AU			
AV			
AW			
AX			
AY			
AZ			
BA			
BB			
BC			
BD			
BE			
BF			
BG			
BH			
BI			
DJ			
DK			
DL			
DM			
DN			
DO			
DP			
DQ			
DR			
DS			
DT			
DU			
DV			
DW			
DX			
DY			
DZ			
EA			
EB			
EC			
ED			
EE			
EF			
EG			
EH			
EI			
EJ			
EK			
EL			
EM			
EN			
EO			
EP			
EQ			
ER			
ES			
ET			
EU			
EV			
EW			
EX			
EY			
EZ			
FA			
FB			
FC			
FD			
FE			
FF			
FG			
FH			
FI			
FJ			
FK			
FL			
FM			
FN			
FO			
FP			
FQ			
FR			
FS			
FT			
FU			
FV			
FW			
FX			
FY			
FZ			
GA			
GB			
GC			
GD			
GE			
GF			
GG			
GH			
GI			
GJ			
GK			
GL			
GM			
GN			
GO			
GP			
GQ			
GR			
GS			
GT			
GU			
GV			
GW			
GX			
GY			
GZ			
HA			
HB			
HC			
HD			
HE			
HF			
HG			
HH			
HI			
HJ			
HK			
HL			
HM			
HN			
HO			
HP			
HQ			
HR			
HS			
HT			
HU			
HV			
HW			
HX			
HY			
HZ			
IA			
IB			
IC			
ID			
IE			
IF			
IG			
IH			
II			
IJ			
IK			
IL			
IM			
IN			
IO			
IP			
IQ			
IR			
IS			
IT			
IU			
IV			
IW			
IX			
IY			
IZ			
JA			
JB			
JC			
JD			
JE			
JF			
JG			
JH			
JI			
JJ			
JK			
JL			
JM			
JN			
JO			
JP			
JQ			
JR			
JS			
JT			
JU			
JV			
JW			
JX			
JY			
JZ			
KA			
KB			
KC			
KD			
KE			
KF			
KG			
KH			
KI			
KJ			
KK			
KL			
KM			
KN			
KO			
KP			
KQ			
KR			
KS			
KT			
KU			
KV			
KW			
KX			
KY			
KZ			
LA			
LB			
LC			
LD			
LE			
LF			
LG			
LH			
LI			
LJ			
LK			
LL			
LM			
LN			
LO			
LP			
LQ			
LR			
LS			
LT			
LU			
LV			
LW			
LX			
LY			
LZ			
MA			
MB			
MC			
MD			
ME			
MF			
MG			
MH			
MI			
MJ			
MK			
ML			
MM			
MN			
MO			
MP			
MQ			
MR			
MS			
MT			
MU			
MV			
MW			
MX			
MY			
MZ			
NA			
NB			
NC			
ND			
NE			
NF			
NG			
NH			
NI			
NJ			
NK			
NL			
NM			
NN			
NO			
NP			
NQ			
NR			
NS			
NT			
NU			
NV			
NW			
NX			
NY			
NZ			
OA			
OB			
OC			
OD			
OE			
OF			
OG			
OH			
OI			
OJ			
OK			
OL			
OM			
ON			
OO			
OP			
OQ			
OR			
OS			
OT			
OU			
OV			
OW			
OX			
OY			
OZ			
PA			
PB			
PC			
PD			
PE			
PF			
PG			
PH			
PI			
PJ			
PK			
PL			
PM			
PN			
PO			
PP			
PQ			
PR			
PS			
PT			
PU			
PV			
PW			
PX			
PY			
PZ			
QA			
QB			
QC			
QD			
QE			
QF			
QG			
QH			
QI			
QJ			
QK			
QL			
QM			
QN			
QO			
QP			
QQ			
QR			
QS			
QT			
QU			
QV			
QW			
QX			
QY			
QZ			
RA			
RB			
RC			
RD			
RE			
RF			
RG			
RH			
RI			
RJ			
RK			
RL			
RM			
RN			
RO			
RP			
RQ			
RR			
RS			
RT			
RU			
RV			
RW			
RX			
RY			
RZ			
SA			
SB			
SC			
SD			
SE			
SF			
SG			
SH			
SI			
SJ			
SK			
SL			
SM			
SN			
SO			
SP			
SQ			
SR			
SS			
ST			
SU			
SV			
SW			
SX			
SY			
SZ			
TA			
TB			
TC			
TD			
TE			
TF			
TG			
TH			
TI			
TJ			
TK			
TL			
TM			
TN			
TO			
TP			
TQ			
TR			
TS			
TT			
TU			
TV			
TW			
TX			
TY			
TZ			
UA			
UB			
UC			
UD			
UE			
UF			
UG			
UH			
UI			
UJ			
UK			
UL			
UM			
UN			
UO			
UP			
UQ			
UR			
US			
UT			
UU			
UV			
UW			
UX			
UY			
UZ			
VA			
VB			
VC			
VD			
VE			
VF			
VG			
VH			
VI			
VJ			
VK			
VL			
VM			
VN			
VO			
VP			
VQ			
VR			
VS			
VT			
VU			
VV			
VW			
VX			
VY			

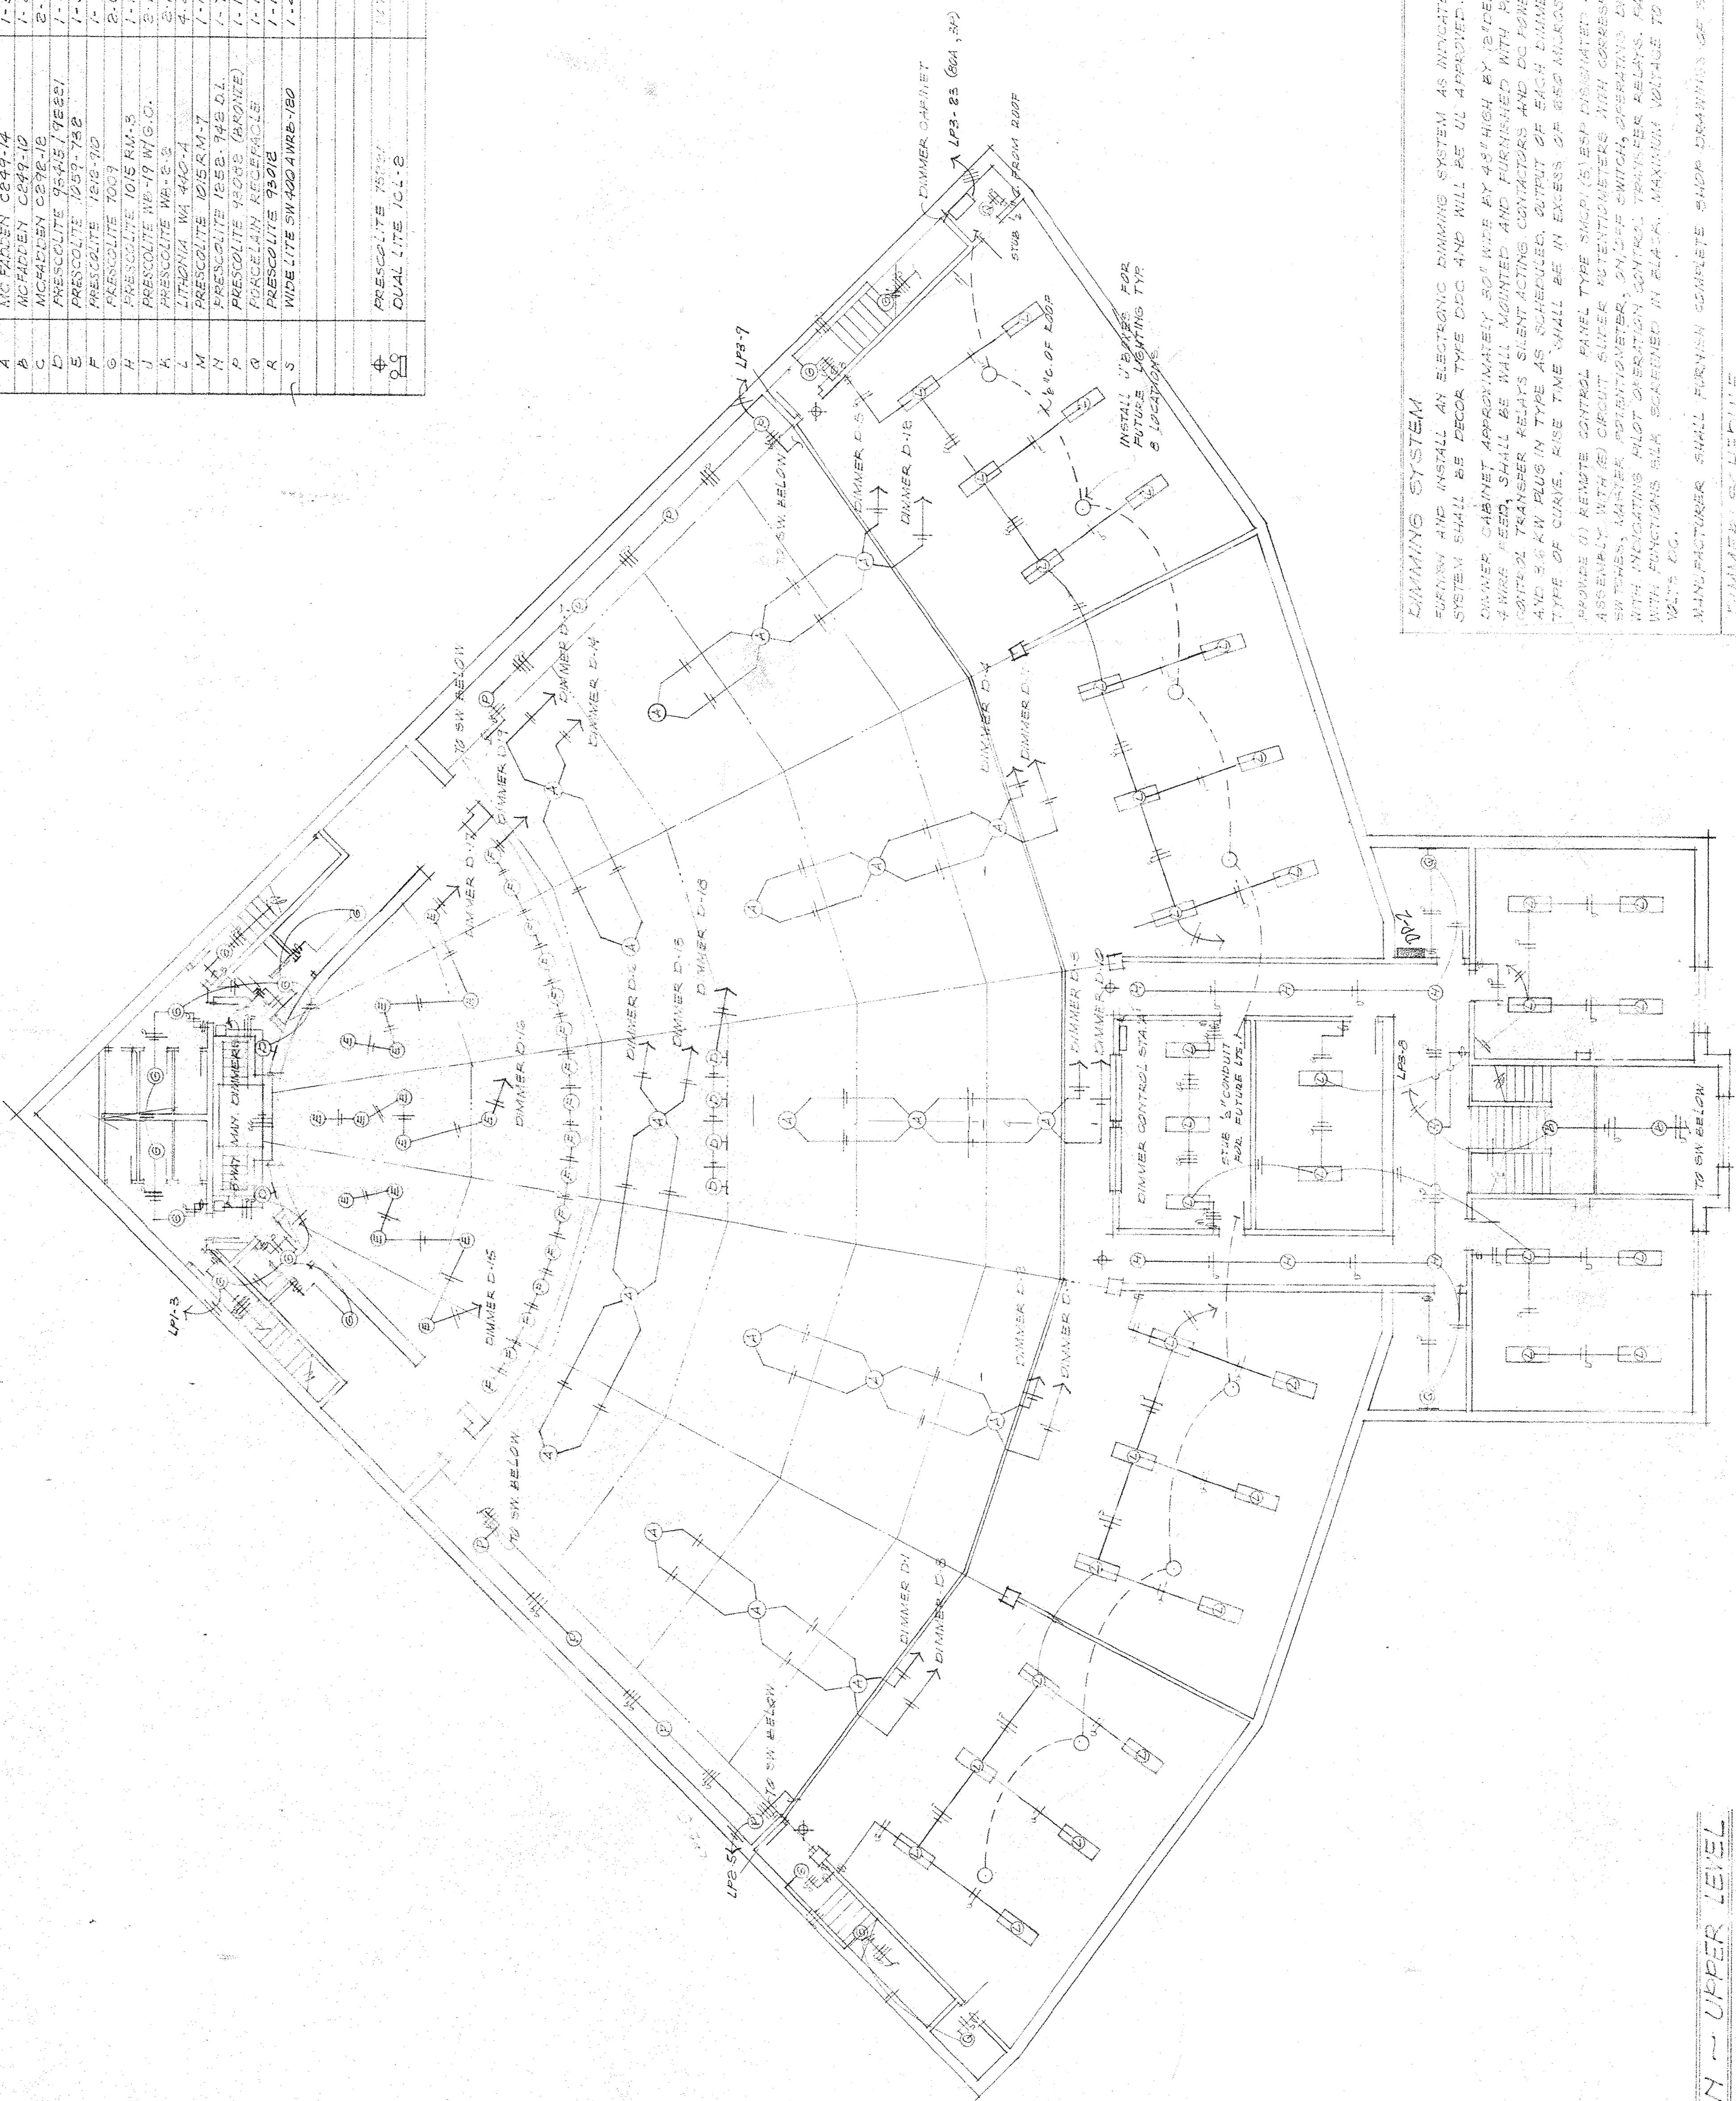[illegible][illegible]

734010 - UPPER LEVEL LIGHTING PLAN -



