



Printed 4/18/2014

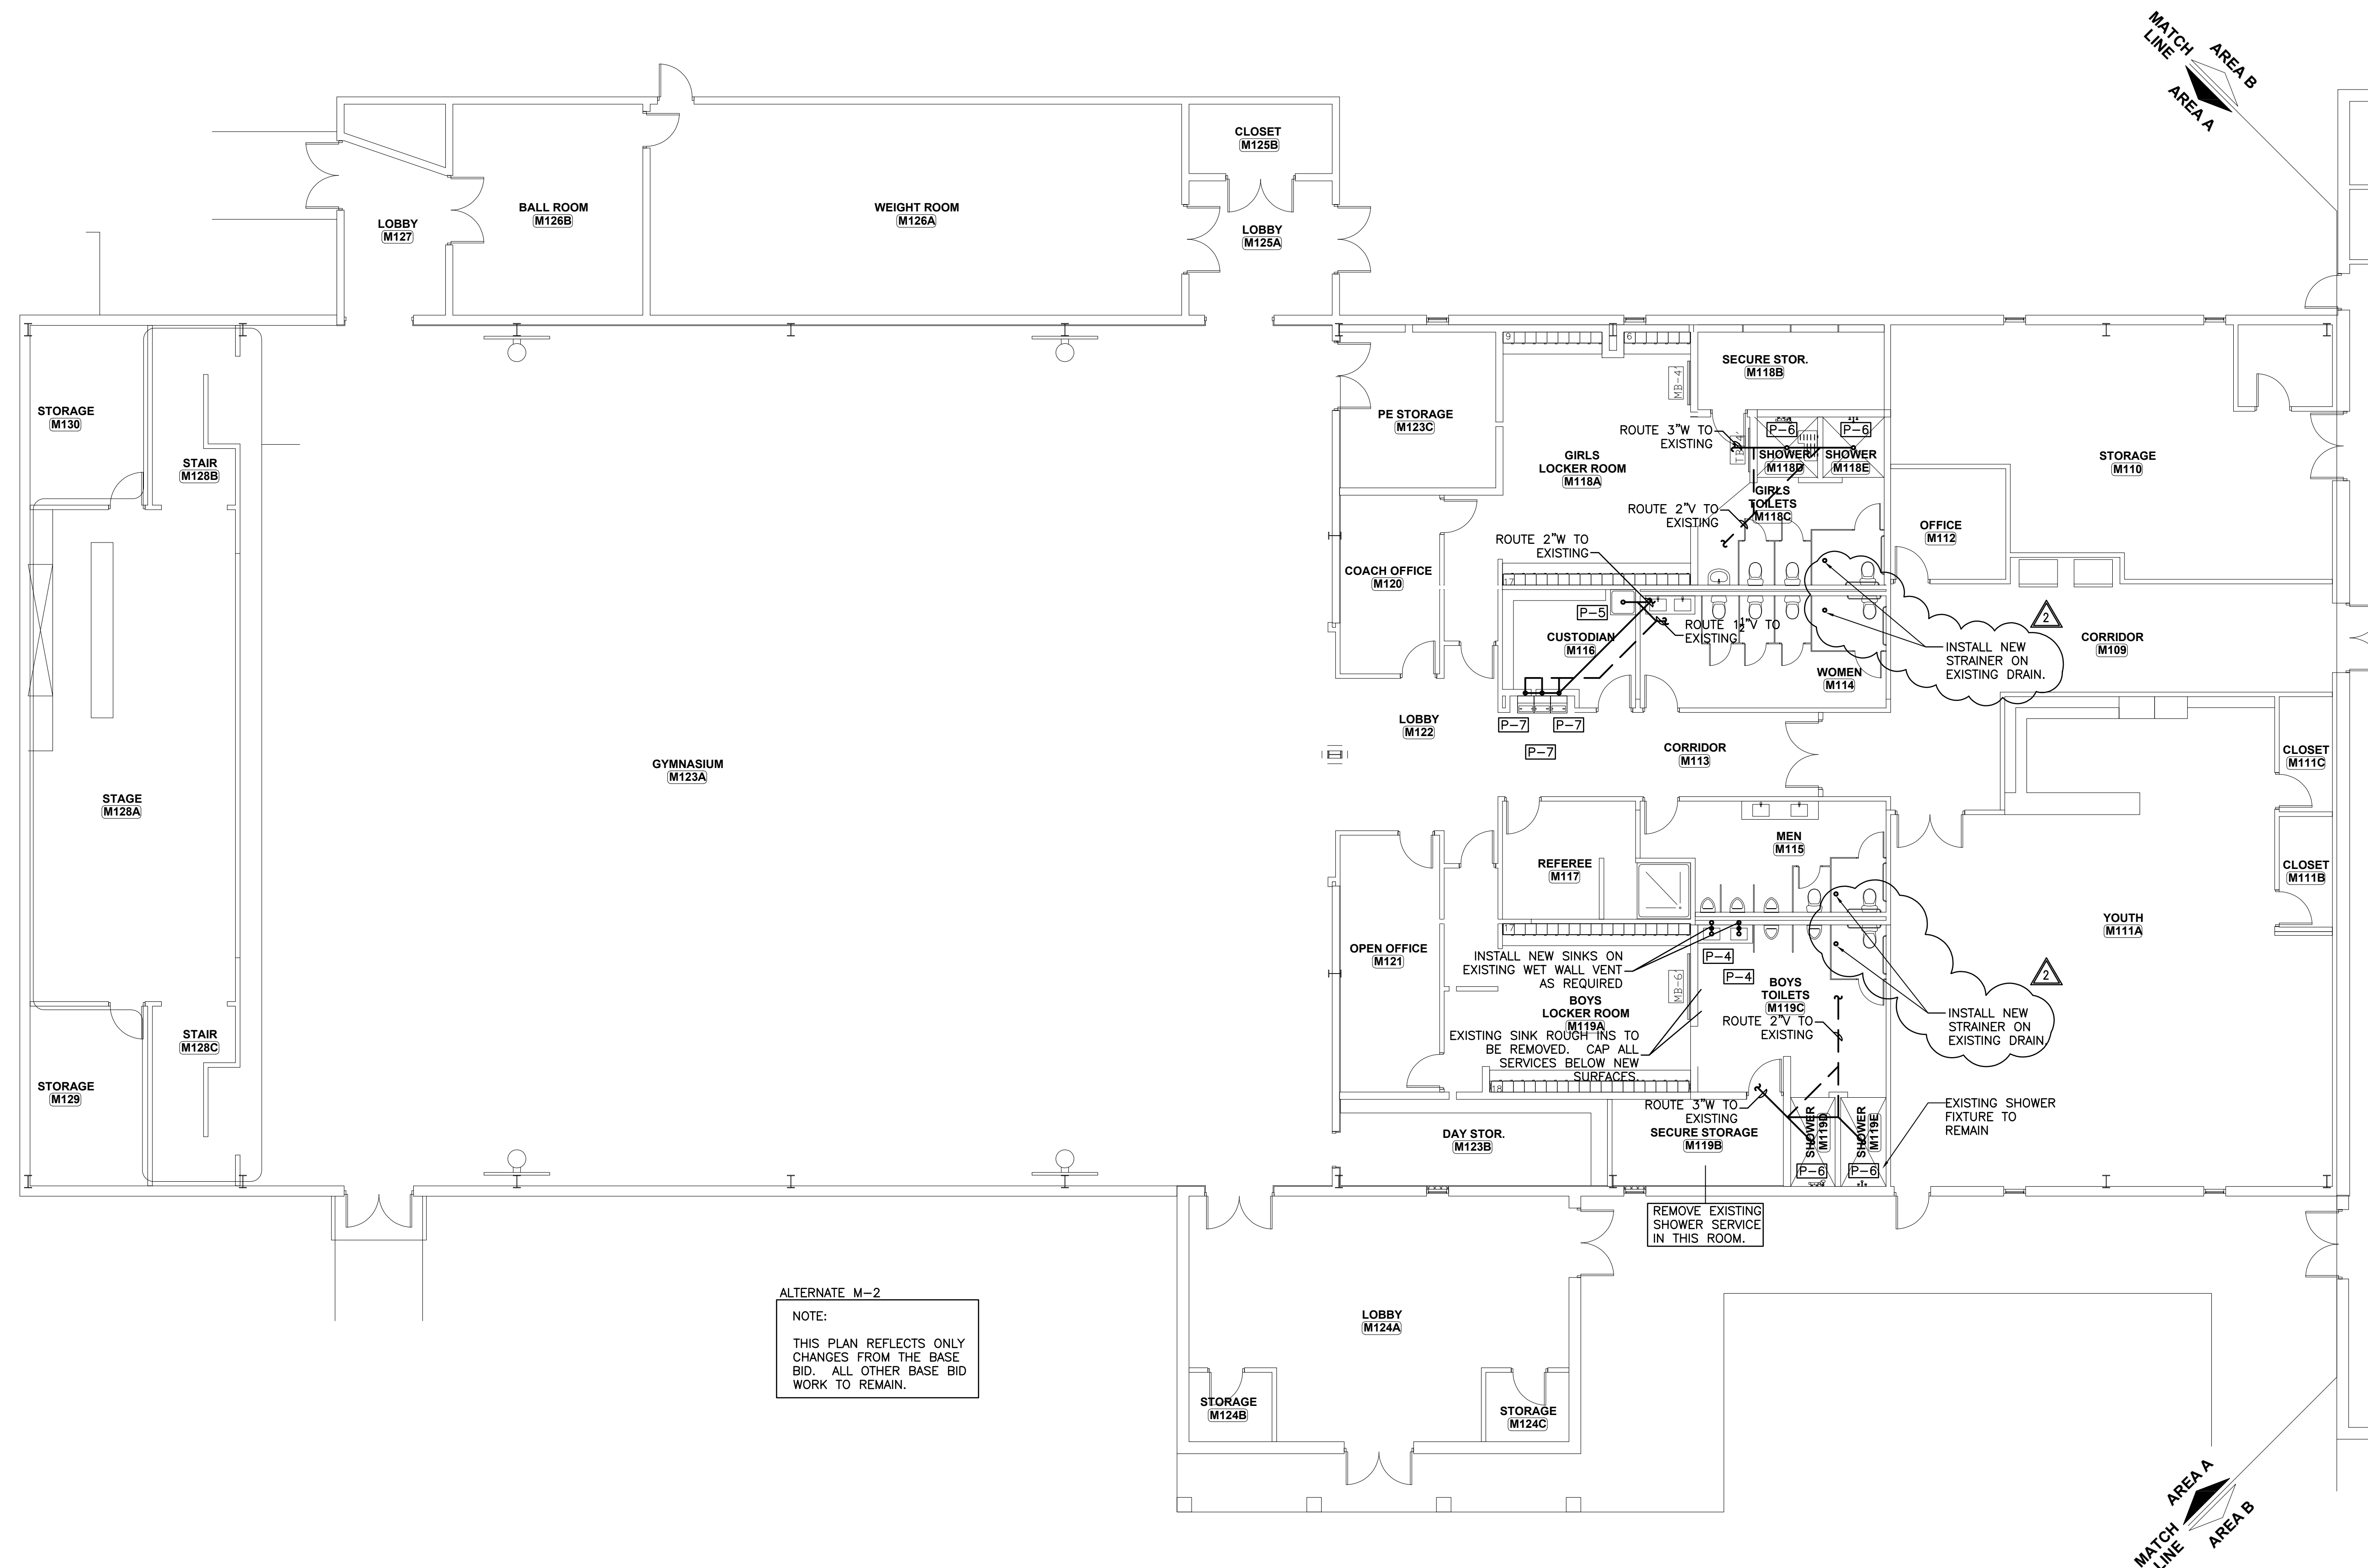

ALTERNATE M-2  
NOTE:  
THIS PLAN REFLECTS ONLY  
CHANGES FROM THE BASE  
BID. ALL OTHER BASE BID  
WORK TO REMAIN.

MESHAW BUILDING (ALT BID)  
FIRST FLOOR PLAN AREA A – PLUMBING – WASTE  
SCALE: 1/8"=1'-0"

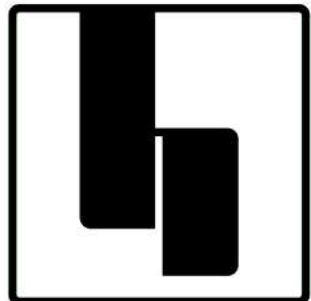

hostetlerarchitecture

■ ARCHITECTURE ■ PLANNING


3967 MARKET STREET  
WILMINGTON, NC 28403

PHONE: 910.612.1119


www.hostetlerarchitecture.com

CONSULTANTS

10755

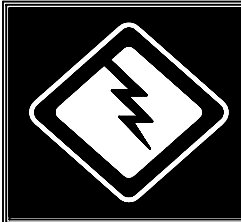

McDOWELL CONSULTING  
ENGINEERS, INC.  
P.O. BOX 367  
HAMPSTEAD, NC 28443  
TEL.(910) 270-3747 FAX 270-3779  
NC LICENSE NO. C-2546

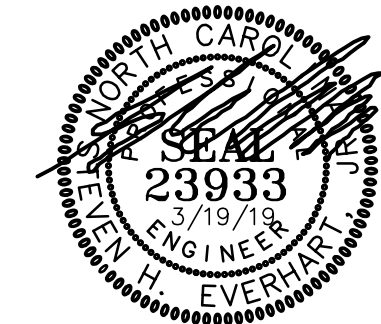

RENOVATIONS TO

# GRACE BAPTIST CHURCH

WILMINGTON  
NORTH CAROLINA

CONSTRUCTION DOCUMENTS : 2.8.19

## REVISIONS

MARK	DATE	DESCRIPTION
2	4.9.19	BIDDER CLARIFICATIONS
1		
1		
1		

DRAWN BY: KSG PROJ. MGR: SE

SHEET CONTENT

MESHAW BUILDING (ALT BID)  
FIRST FLOOR PLAN - AREA A  
ALTERNATE  
PLUMBING - WASTE

JOB NO.  
18013

SHEET  
P102

©2011