


ADD ALTERNATE - L4


ADD ALTERNATE - L8

FOR CONTINUATION

FOR CONTINUATION

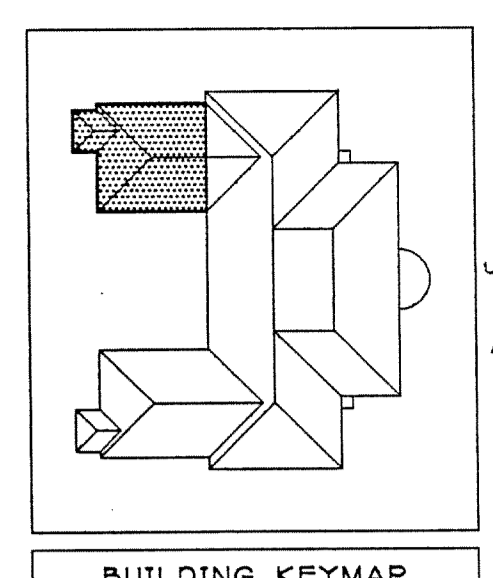


JEFFERIES AND FARIS ASSOCIATES
ARCHITECTS • PLANNERS
SEA TOWERS, SUITE 201
2002 EASTWOOD ROAD
WILMINGTON, N.C. 28403
TEL: 910.256.6633
FAX: 910.256.9088

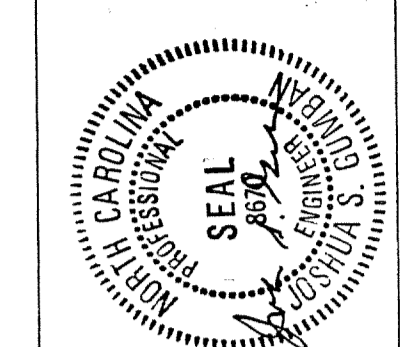

SCIENCE BUILDING
UNIVERSITY OF NORTH CAROLINA AT WILMINGTON
CODE 44388 ITEM 301 ID#6089280301A

SERVICE FITTING SCHEDULE

EXAMPLE: INDICATES TYPE OF FITTING ABBREVIATED INDIVIDUALLY ON FLOOR PLANS.
LA-10- NUMERICAL REFERENCE OF FITTING ELEV. A = 7" IF B = 21" OR LESS
SEE DRAWING LF-16. A = 9" IF B > 21"

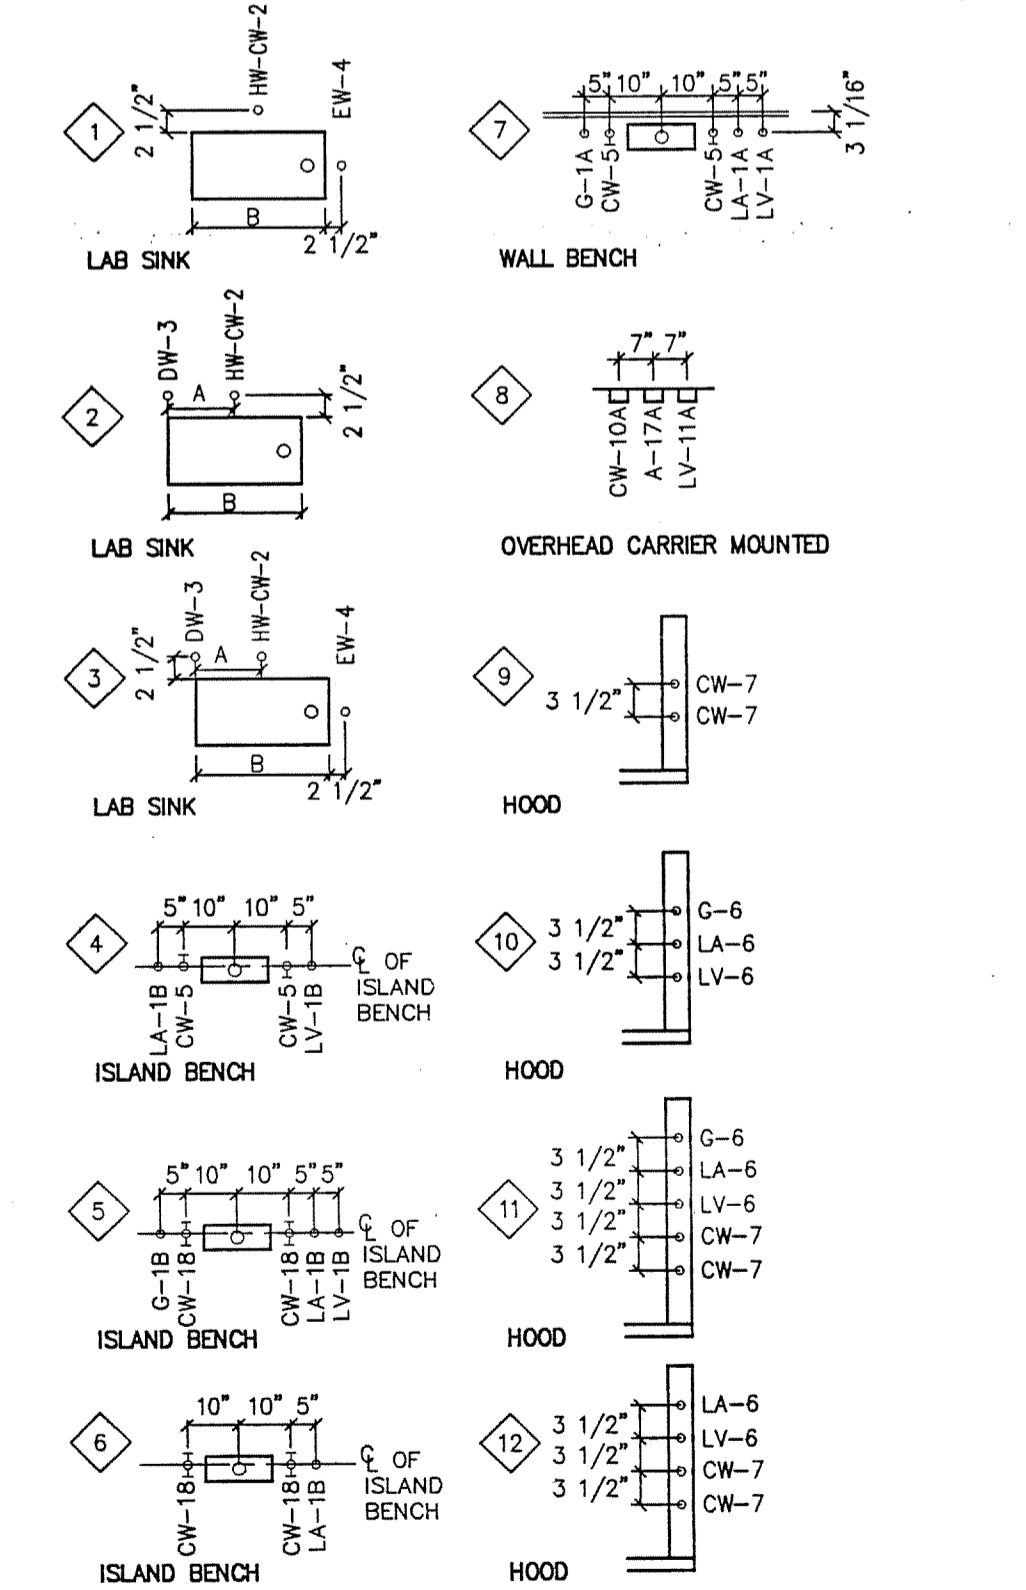

SECOND FLOOR
SCALE: 1/4" = 1'-0"

AREA SIX
AS BUILT

Earl Walls Associates
Laboratory Design Consultants
5348 Carrol Canyon Road
San Diego, California 92121
(619)457-2400

NO.	DATE	REVISIONS
1	9-15-95	REVISED CLEAN ROOM 2257

DATE: 5/16/94
PROJECT#: 8962
DESIGNED BY: PJK
DRAWN BY: LRH, DCK
CHECKED BY: PJK
CHECKED BY:

SHEET NO.:
LF11