



SCIENCE BUILDING
UNIVERSITY OF NORTH CAROLINA AT WILMINGTON
CODE 44300 ITEM 301 ID#6089280301A

SHEET TITLE:

FIRST FLOOR PLAN - AREA TWO
WEST


AREA TWO
AS BUILT

SHEET NO.:
LF2

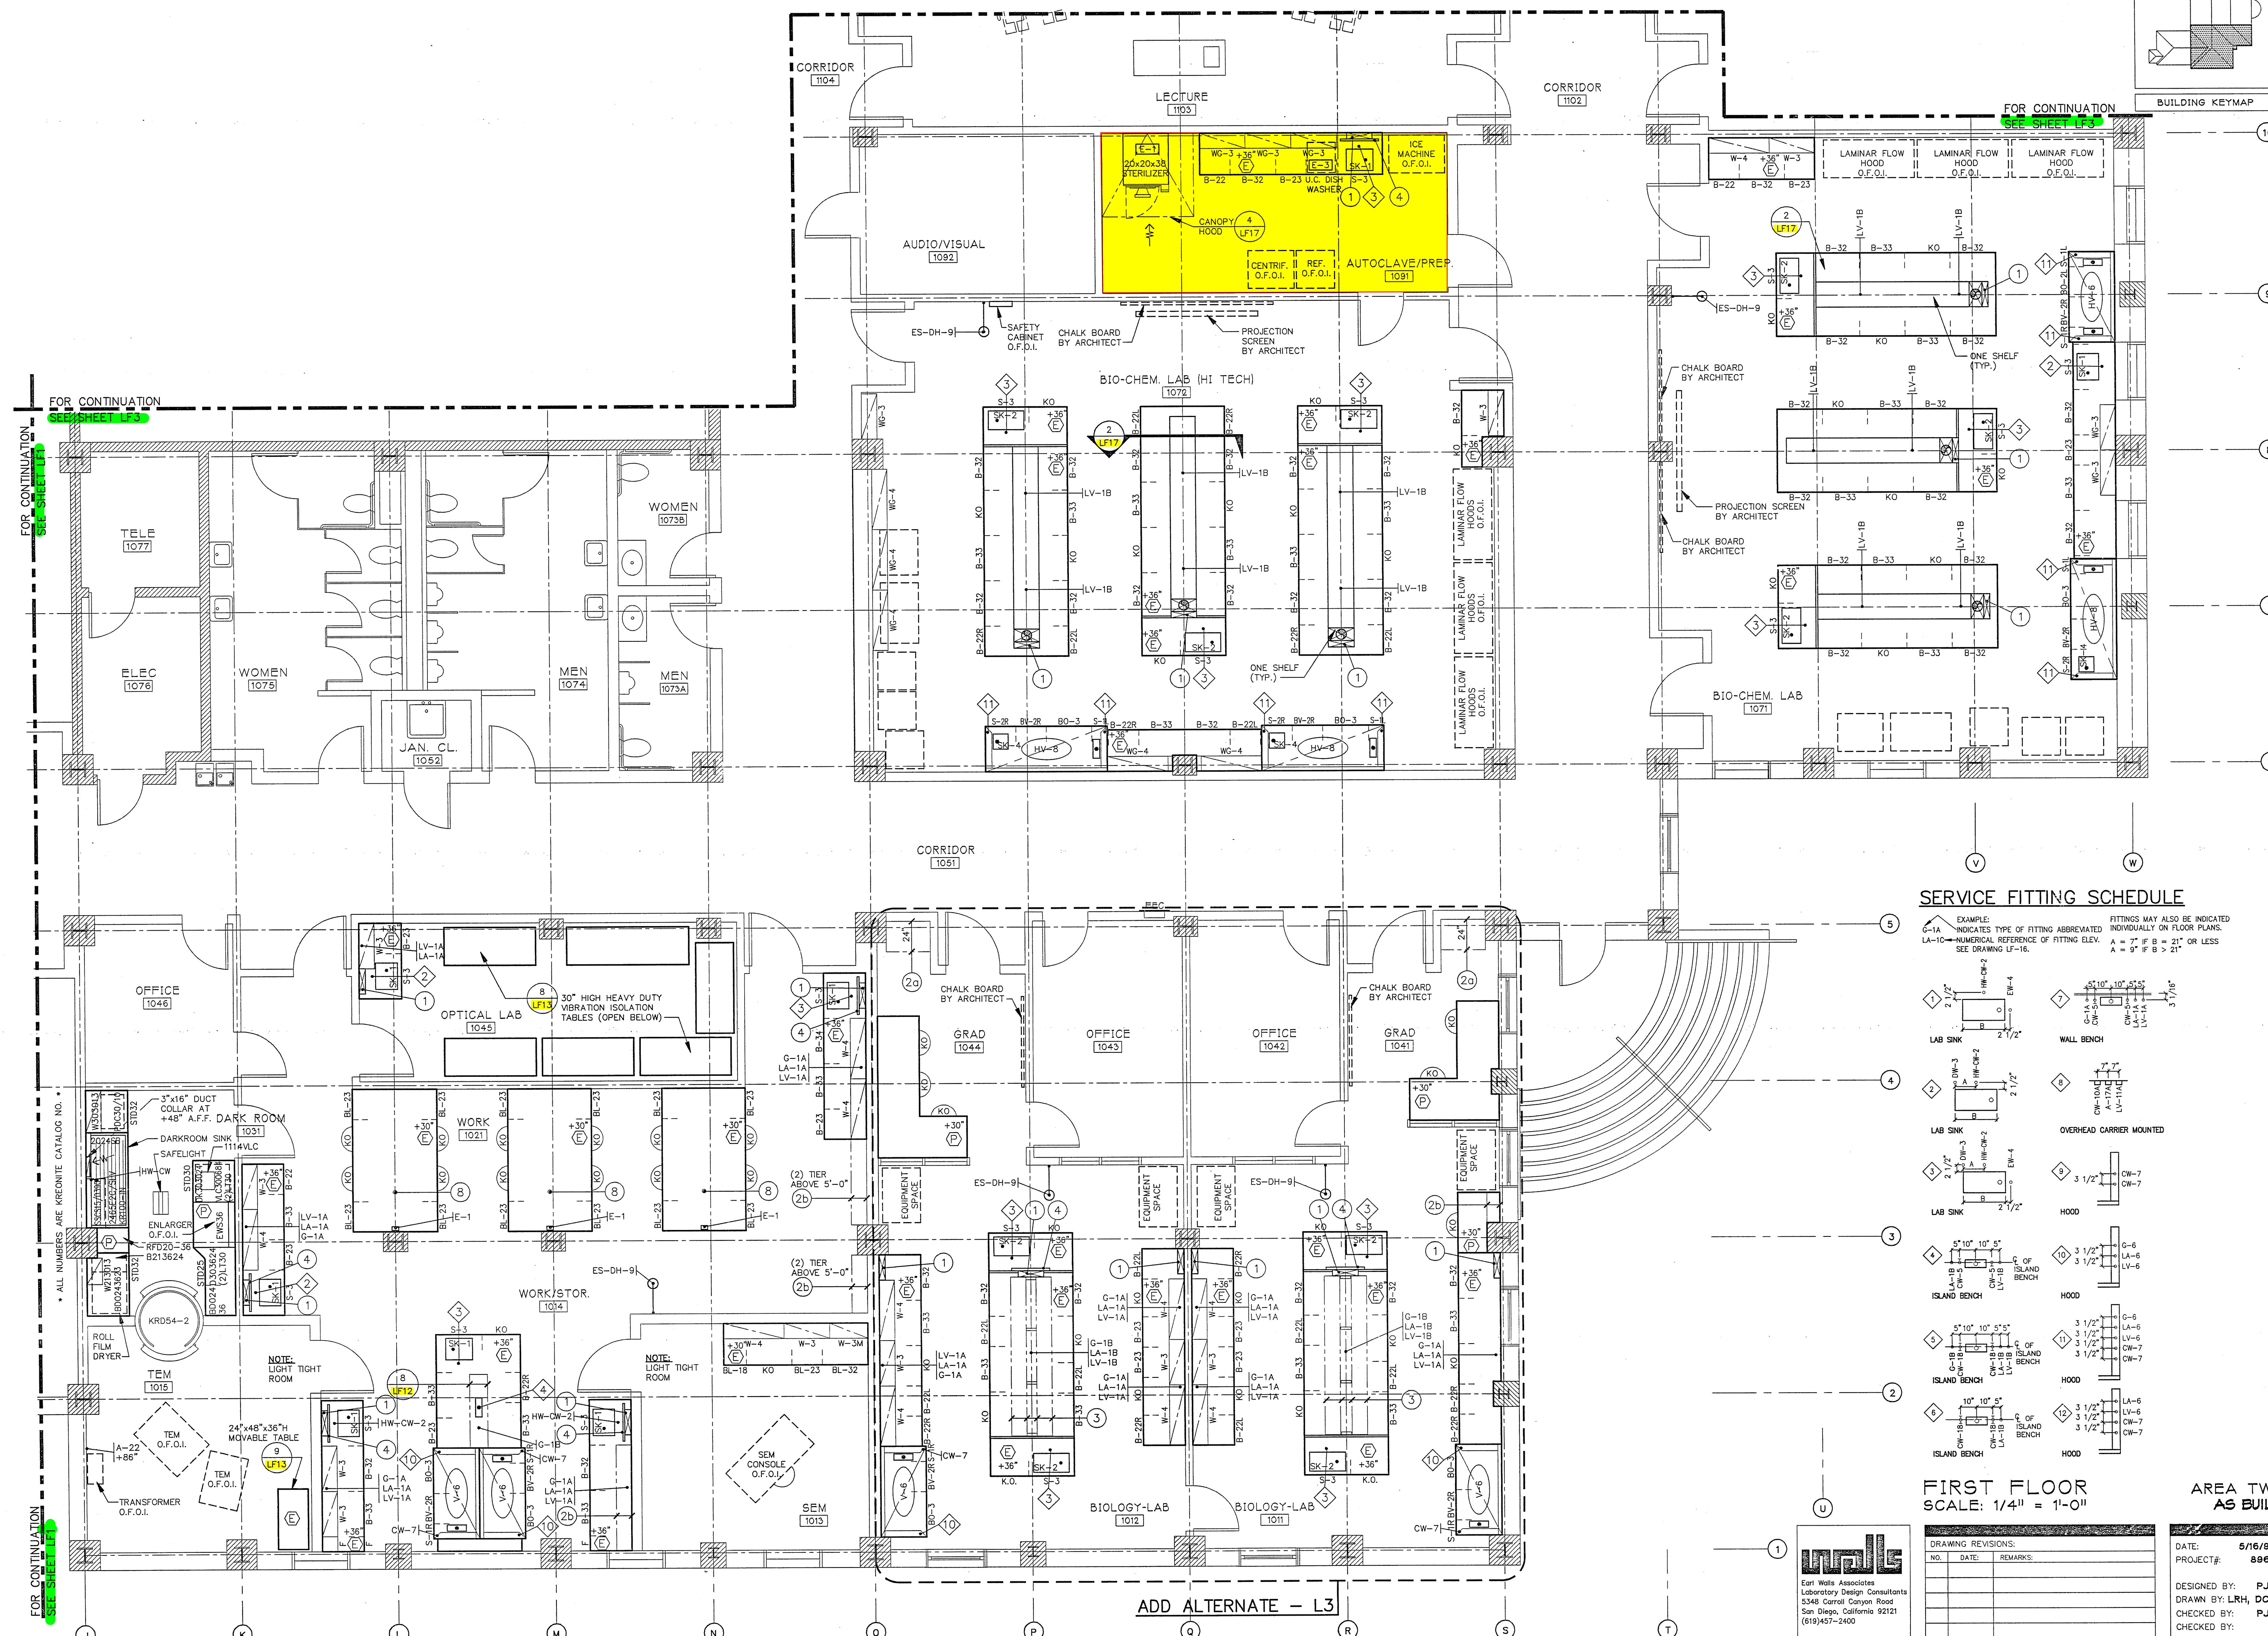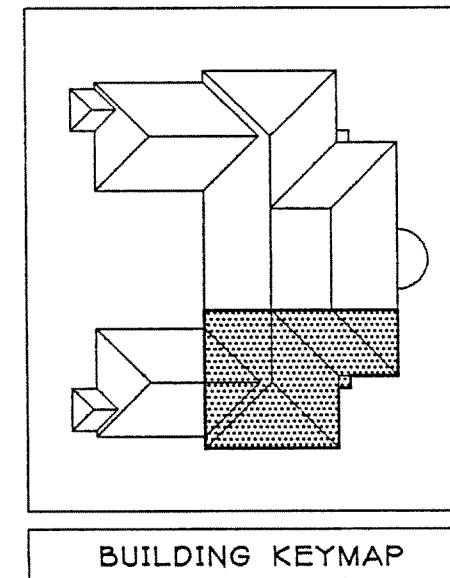

SERVICE FITTING SCHEDULE

EXAMPLE:
LA-10 INDICATES TYPE OF FITTING ABBREVIATED INDIVIDUALLY ON FLOOR PLANS.
LA-10 NUMERICAL REFERENCE OF FITTING ELEV. A = 7" IF B = 21" OR LESS
SEE DRAWING LF-1B. A = 9" IF B > 21"

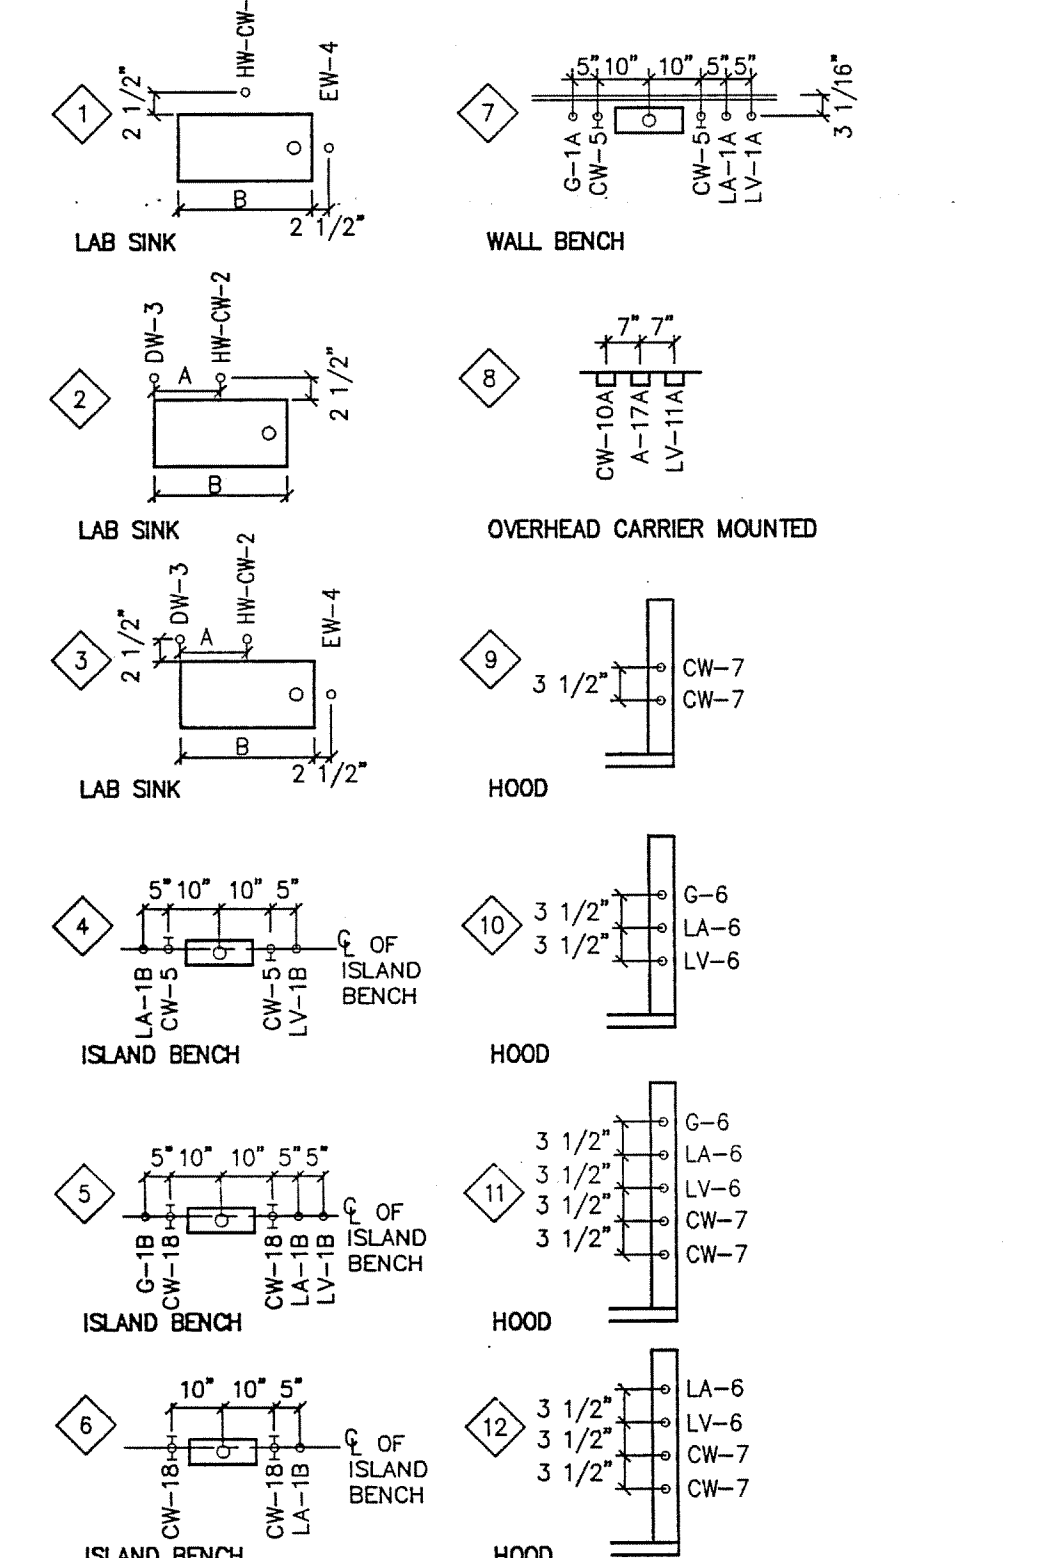

FIRST FLOOR
SCALE: 1/4" = 1'-0"

DRAWING REVISIONS:		
NO.	DATE	REMARKS

DATE: 5/16/94
PROJECT#: 8962
DESIGNED BY: PJK
DRAWN BY: LRH, DCK
CHECKED BY: PJK

Earl Walls Associates
Laboratory Design Consultants
5348 Carroll Canyon Road
San Diego, California 92121
(619) 457-2400

ADD ALTERNATE - L3

FOR CONTINUATION
SEE SHEET LF-1

FOR CONTINUATION
SEE SHEET LF-1

FOR CONTINUATION
SEE SHEET LF-1