



SCIENCE BUILDING
 UNIVERSITY OF NORTH CAROLINA AT WILMINGTON
 CODE 44988 ITEM 301 ID#0084280801A

SHEET TITLE:

FIRST FLOOR PLAN - AREA THREE
 WEST

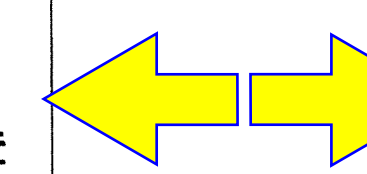


SHEET NO.:
LF3

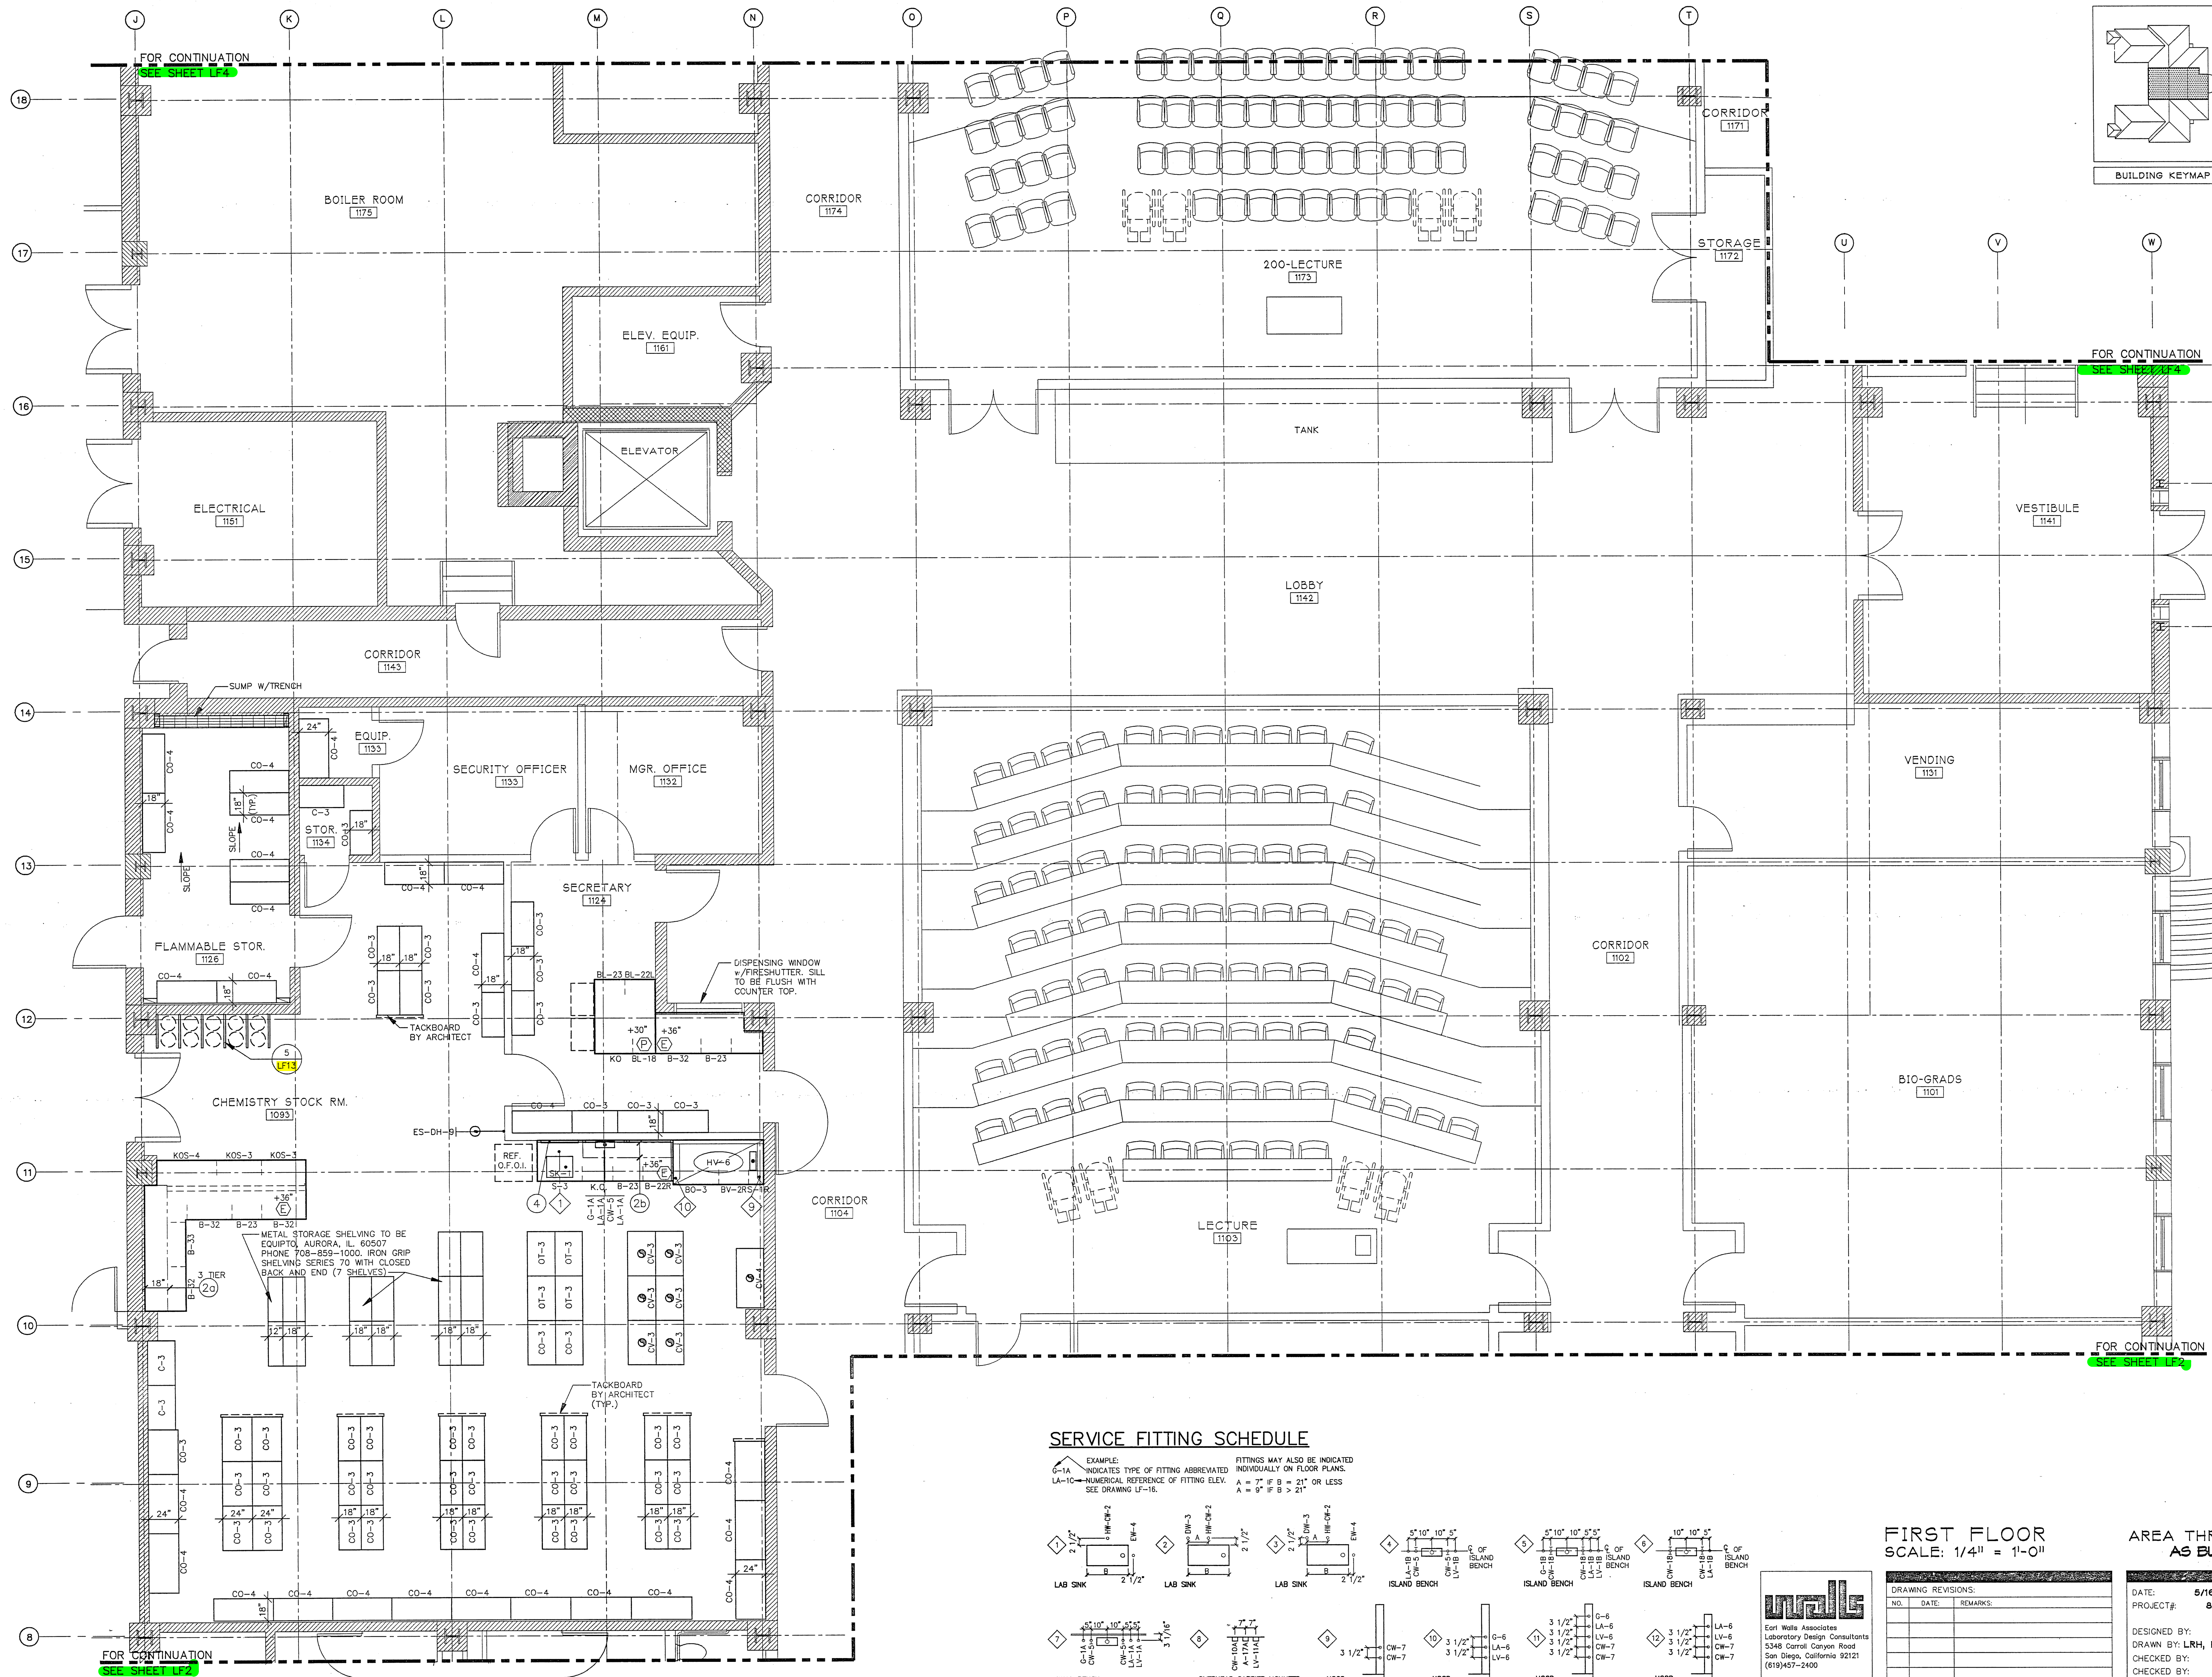

SERVICE FITTING SCHEDULE

EXAMPLE:
 G-1A INDICATES TYPE OF FITTING ABBREVIATED
 LA-10 NUMERICAL REFERENCE OF FITTING ELEV.
 SEE DRAWING U-16.

FITTINGS MAY ALSO BE INDICATED INDIVIDUALLY ON FLOOR PLANS.
 A = 7" IF B = 21" OR LESS
 A = 9" IF B > 21"

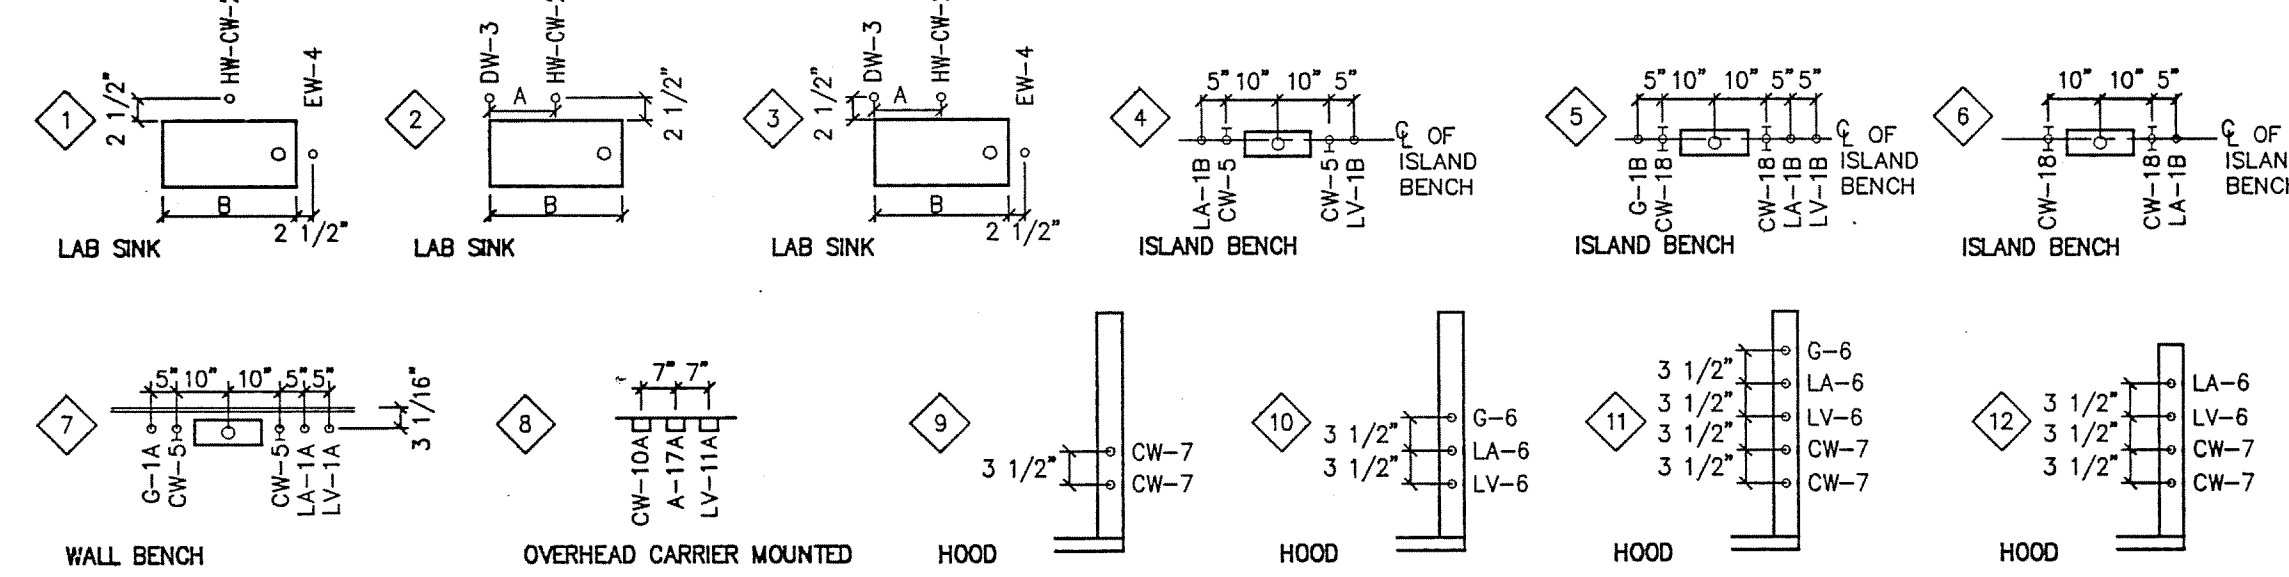

FIRST FLOOR
 SCALE: 1/4" = 1'-0"

AREA THREE
 AS BUILT

DRAWING REVISIONS:		
NO.	DATE	REMARKS

DATE: 5/16/94
 PROJECT#: 8962
 DESIGNED BY: PJK
 DRAWN BY: LRH, DCK
 CHECKED BY: PJK

unwall
 Carl Wall Associates
 Laboratory Design Consultants
 5348 Carroll Canyon Road
 San Diego, California 92121
 (619) 457-2400