

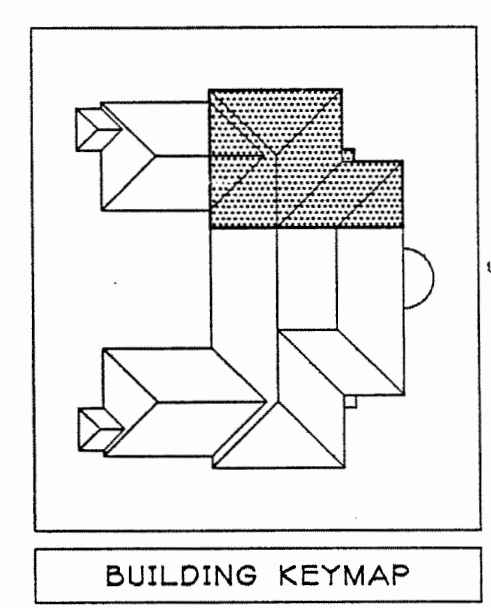


NOTE:
1. DISPOSER SHALL BE IN-SINK-ERATOR COMMERCIAL MODEL
No. SS-50-5 w/COMPLETE ACCESSORY PACKAGE #5.

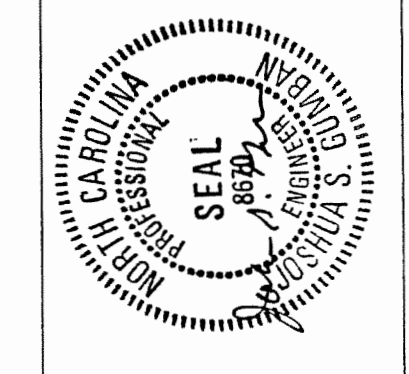

JEFFERIES AND FARIS ASSOCIATES
ARCHITECTS • PLANNERS
SEA TOWERS, SUITE 201
2002 EASTWOOD ROAD
WILMINGTON, NC 28403
TEL: 910.256.6633
FAX: 910.256.9088

SERVICE FITTING SCHEDULE

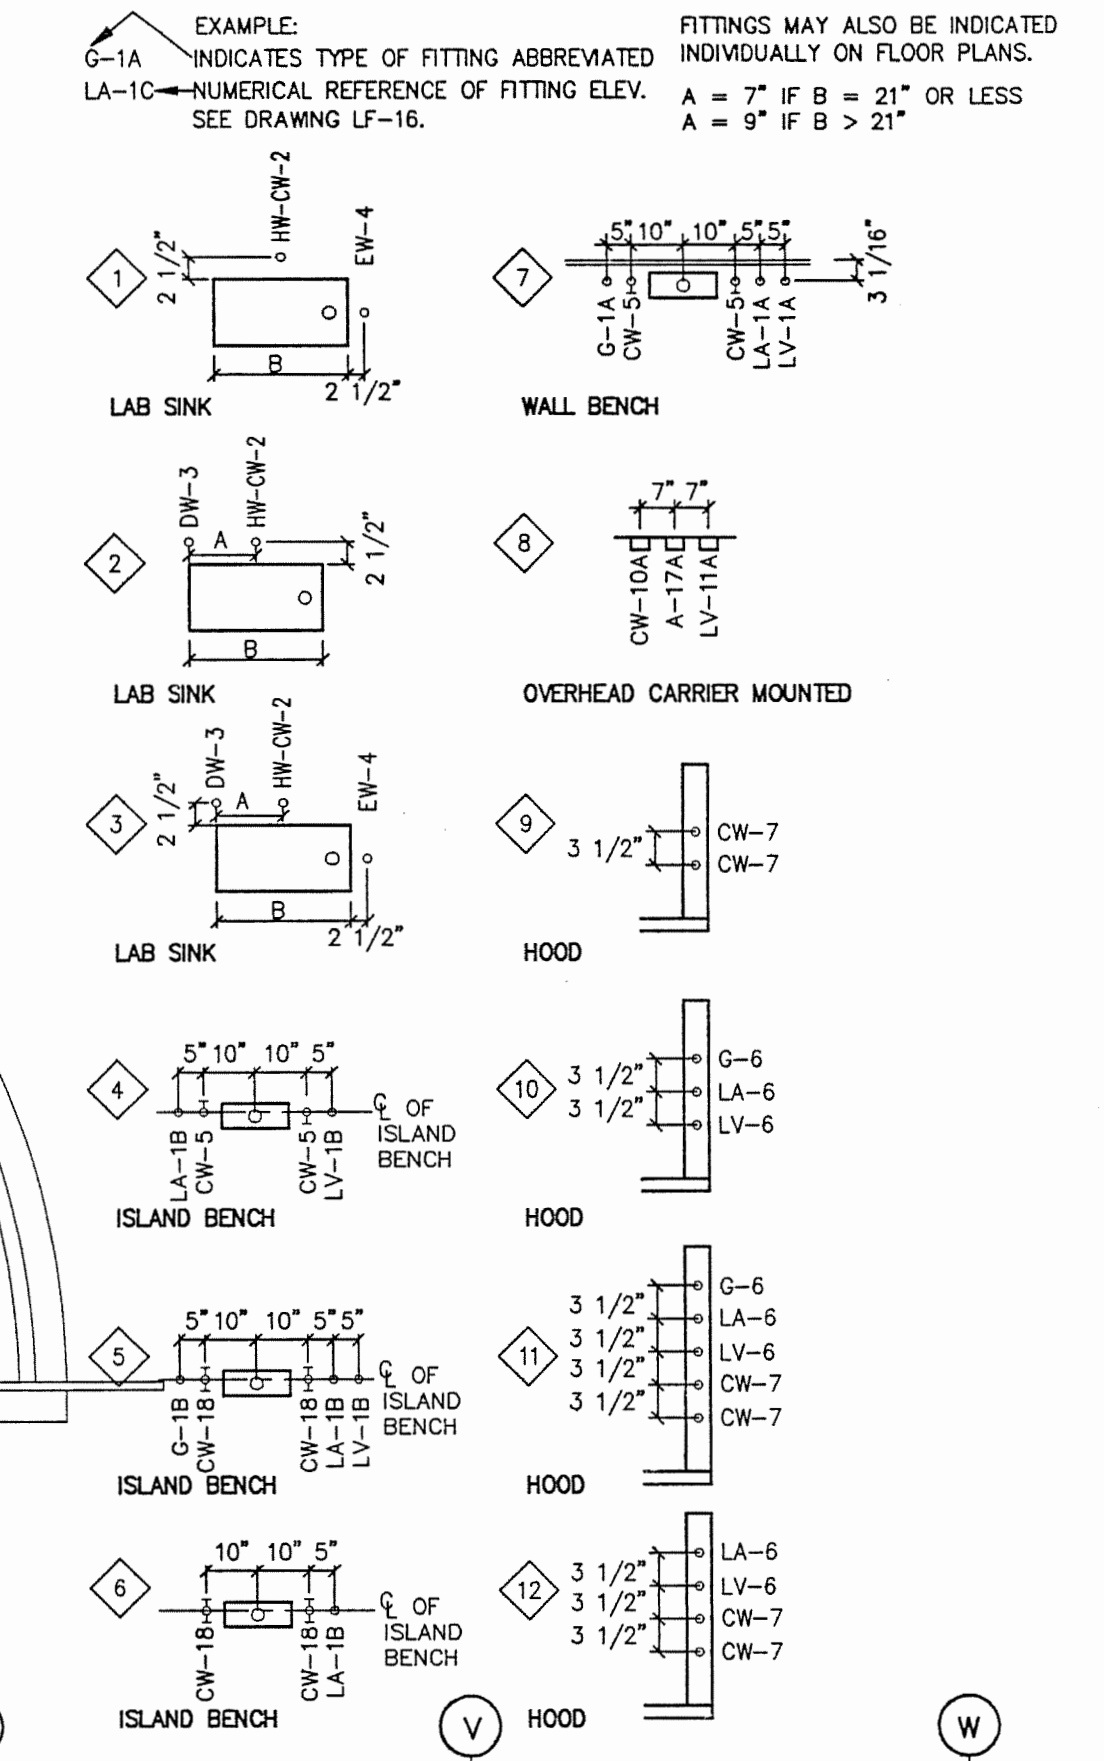

SCIENCE BUILDING
UNIVERSITY OF NORTH CAROLINA AT WILMINGTON
CODE 44386 ITEM 301 ID#60892B0301A

SHEET TITLE:

FIRST FLOOR PLAN - AREA FOUR
EAST

FIRST FLOOR
SCALE: 1/4" = 1'-0"

AREA FOUR
AS BUILT

NO.	DATE	REVISIONS
1	5/16/94	PROJECT# 8962
2		DESIGNED BY: PJK
3		DRAWN BY: LRM, DCK
4		CHECKED BY: PJK

SHEET NO.:
LF4

WALL
Earl Wells Associates
Laboratory Design Consultants
5348 Carroll Canyon Road
San Diego, California 92121
(619)457-2400