


SCIENCE BUILDING  
UNIVERSITY OF NORTH CAROLINA AT WILMINGTON  
CODE 41888 ITEM 301 ID#004280301A

SHEET TITLE:

SECOND FLOOR PLAN - AREA ONE  
WEST

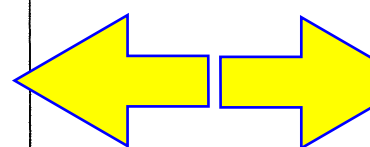

SHEET NO.:

LF6

ADD ALTERNATE - L5


FOR CONTINUATION  
SEE SHEET LF7

ADD ALTERNATE - L7

FOR CONTINUATION  
SEE SHEET LF7

SERVICE FITTING SCHEDULE

EXAMPLE:  
G-1A INDICATES TYPE OF FITTING ABBREVIATED INDIVIDUALLY ON FLOOR PLANS.  
LA-10 NUMERICAL REFERENCE OF FITTING ELEV. SEE DRAWING LF-16.  
FITTINGS MAY ALSO BE INDICATED INDIVIDUALLY ON FLOOR PLANS.  
A = 7" IF B = 21" OR LESS  
A = 9" IF B > 21"

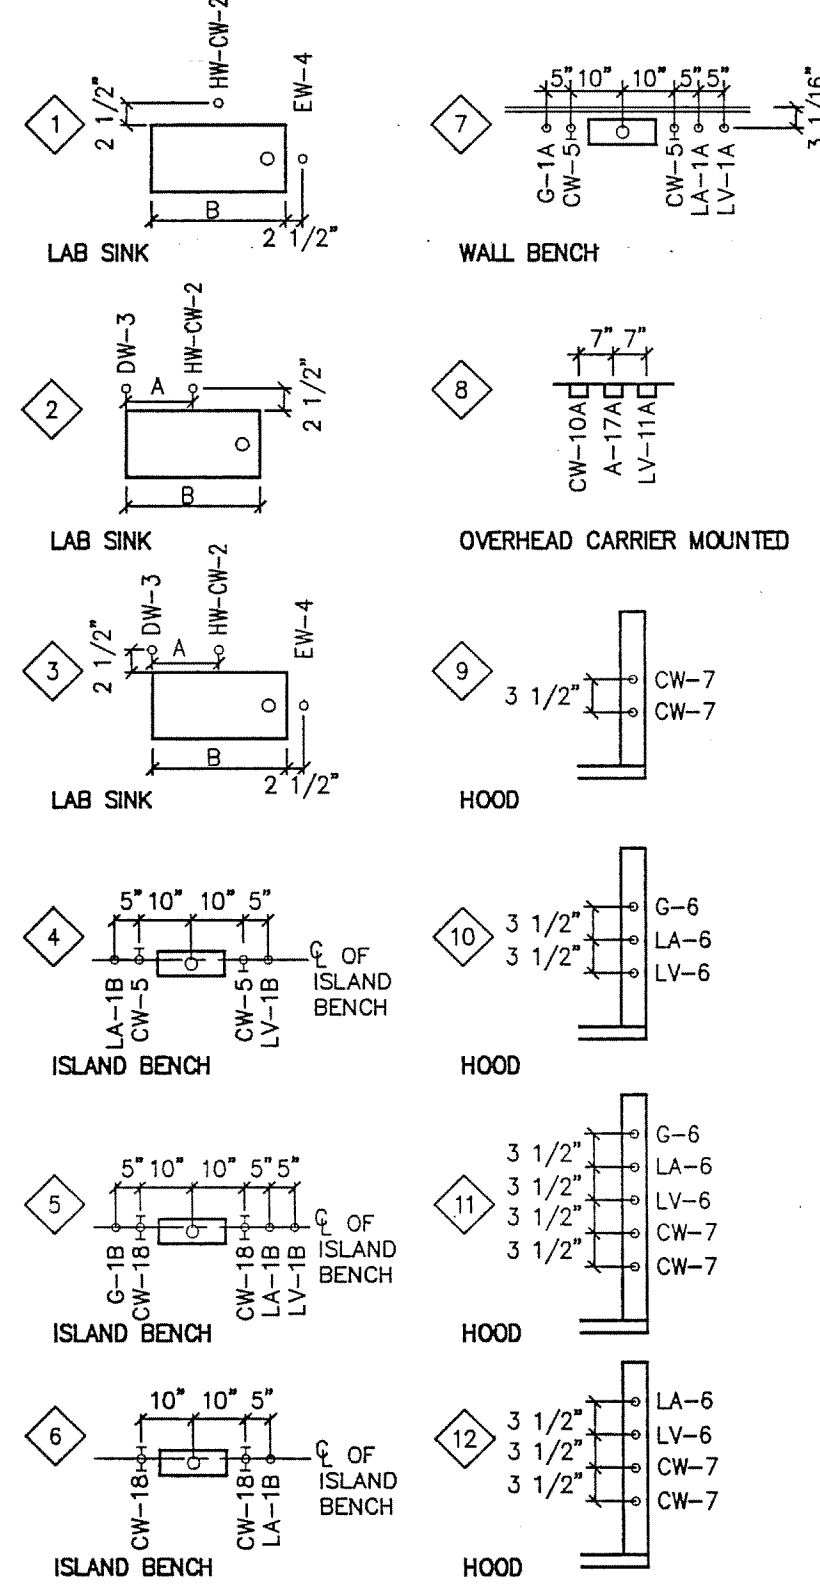

SECOND FLOOR  
SCALE: 1/4" = 1'-0"

AREA ONE  
AS BUILT

DRAWING REVISIONS:		
NO.	DATE	REMARKS

DATE: 6/16/84  
PROJECT#: 8962  
DESIGNED BY: PJK  
DRAWN BY: LRH, DCK  
CHECKED BY: PJK  
CHECKED BY:

WALL  
Earl Walls Associates  
Laboratory Design Consultants  
5348 Carroll Canyon Road  
San Diego, California 92121  
(619)457-2400

