


NOTE: ALL BRANCH LINES 1" U.N.O.

SP4 01
SECOND FLOOR - WEST - SPRINKLER
FLOOR PLAN
SCALE: 1/8" = 1'-0"

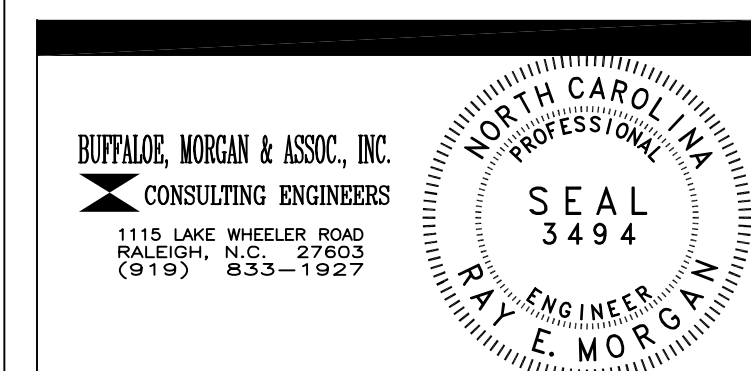

DRAWING REVISIONS:		
NO.	DATE:	REMARKS:

DATE: 16 MAY 1994
PROJECT#: 9305
DESIGNED BY: DLH
DRAWN BY: RDH II
CHECKED BY: WMP
CHECKED BY: REM