


SP5
01
SECOND FLOOR - EAST - SPRINKLER
FLOOR PLAN
SCALE: 1/8" = 1'-0"

NOTE: ALL BRANCH LINES 1" U.N.O.

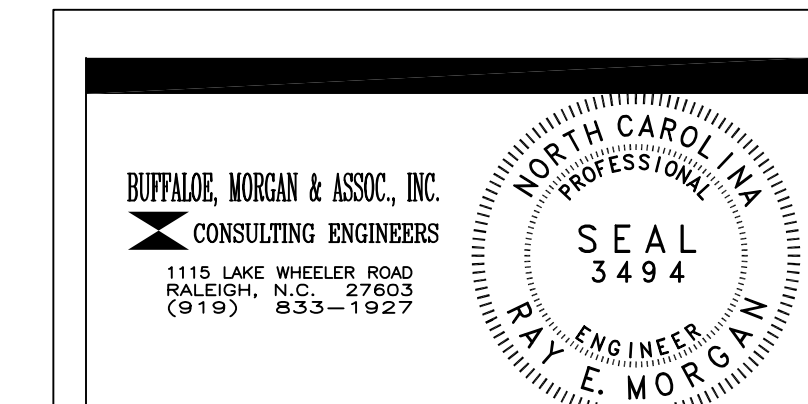

DRAWING REVISIONS:		
NO.	DATE:	REMARKS:
1	2/8/95	SPRINKLER HEADS ADDED
2	2/20/95	SPRINKLER HEADS ADDED
3	2/23/95	PIPING REVISIONS

DATE:	16 MAY 1994
PROJECT#:	9305
DESIGNED BY:	DLH
DRAWN BY:	RDH II
CHECKED BY:	WMP
REVIEWED BY:	REM