



CALCULATED AREA 'B'
3087 SQ. FT.
0.17 GPM/SQ. FT.

NOTE: ALL BRANCH LINES 1" U.N.O.

KEY PLAN

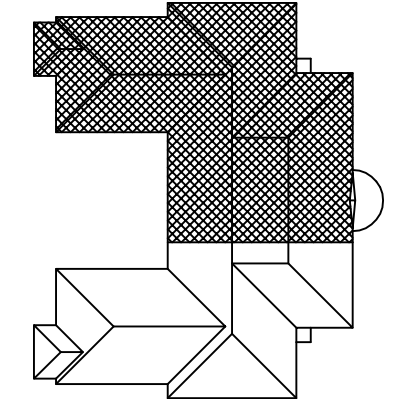

SP7
01
ATTIC - EAST - SPRINKLER
FLOOR PLAN
SCALE: 1/8" = 1'-0"

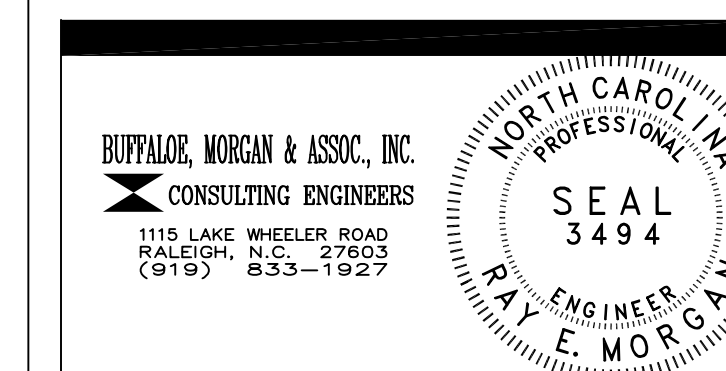

DRAWING REVISIONS:		
NO.	DATE	REMARKS

DATE: 16 MAY 1994
PROJECT#: 9305
DESIGNED BY: DLH
DRAWN BY: RDH II
CHECKED BY: WMP
CHECKED BY: REM

SP7
02
DRAIN
RISER
NO SCALE

