

PLUMBING LEGEND

GAS PIPING

CONNECT NEW TO EXISTING





JEFFERIES AND FARIS
ASSOCIATES

ARCHITECTS • PLANNERS

SEA TOWERS SUITE 201
2002 EASTWOOD ROAD
WILMINGTON, N.C. 28403

TEL: 910.256.6633
FAX: 910.256.9088

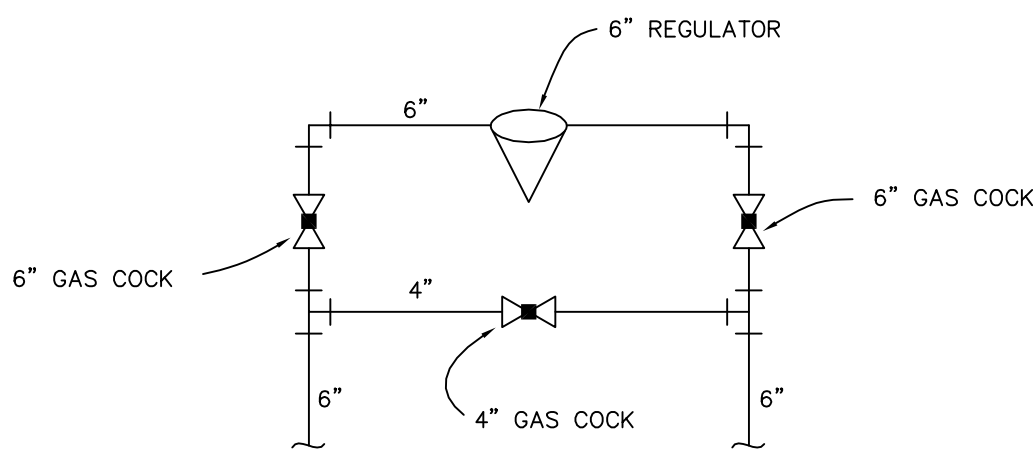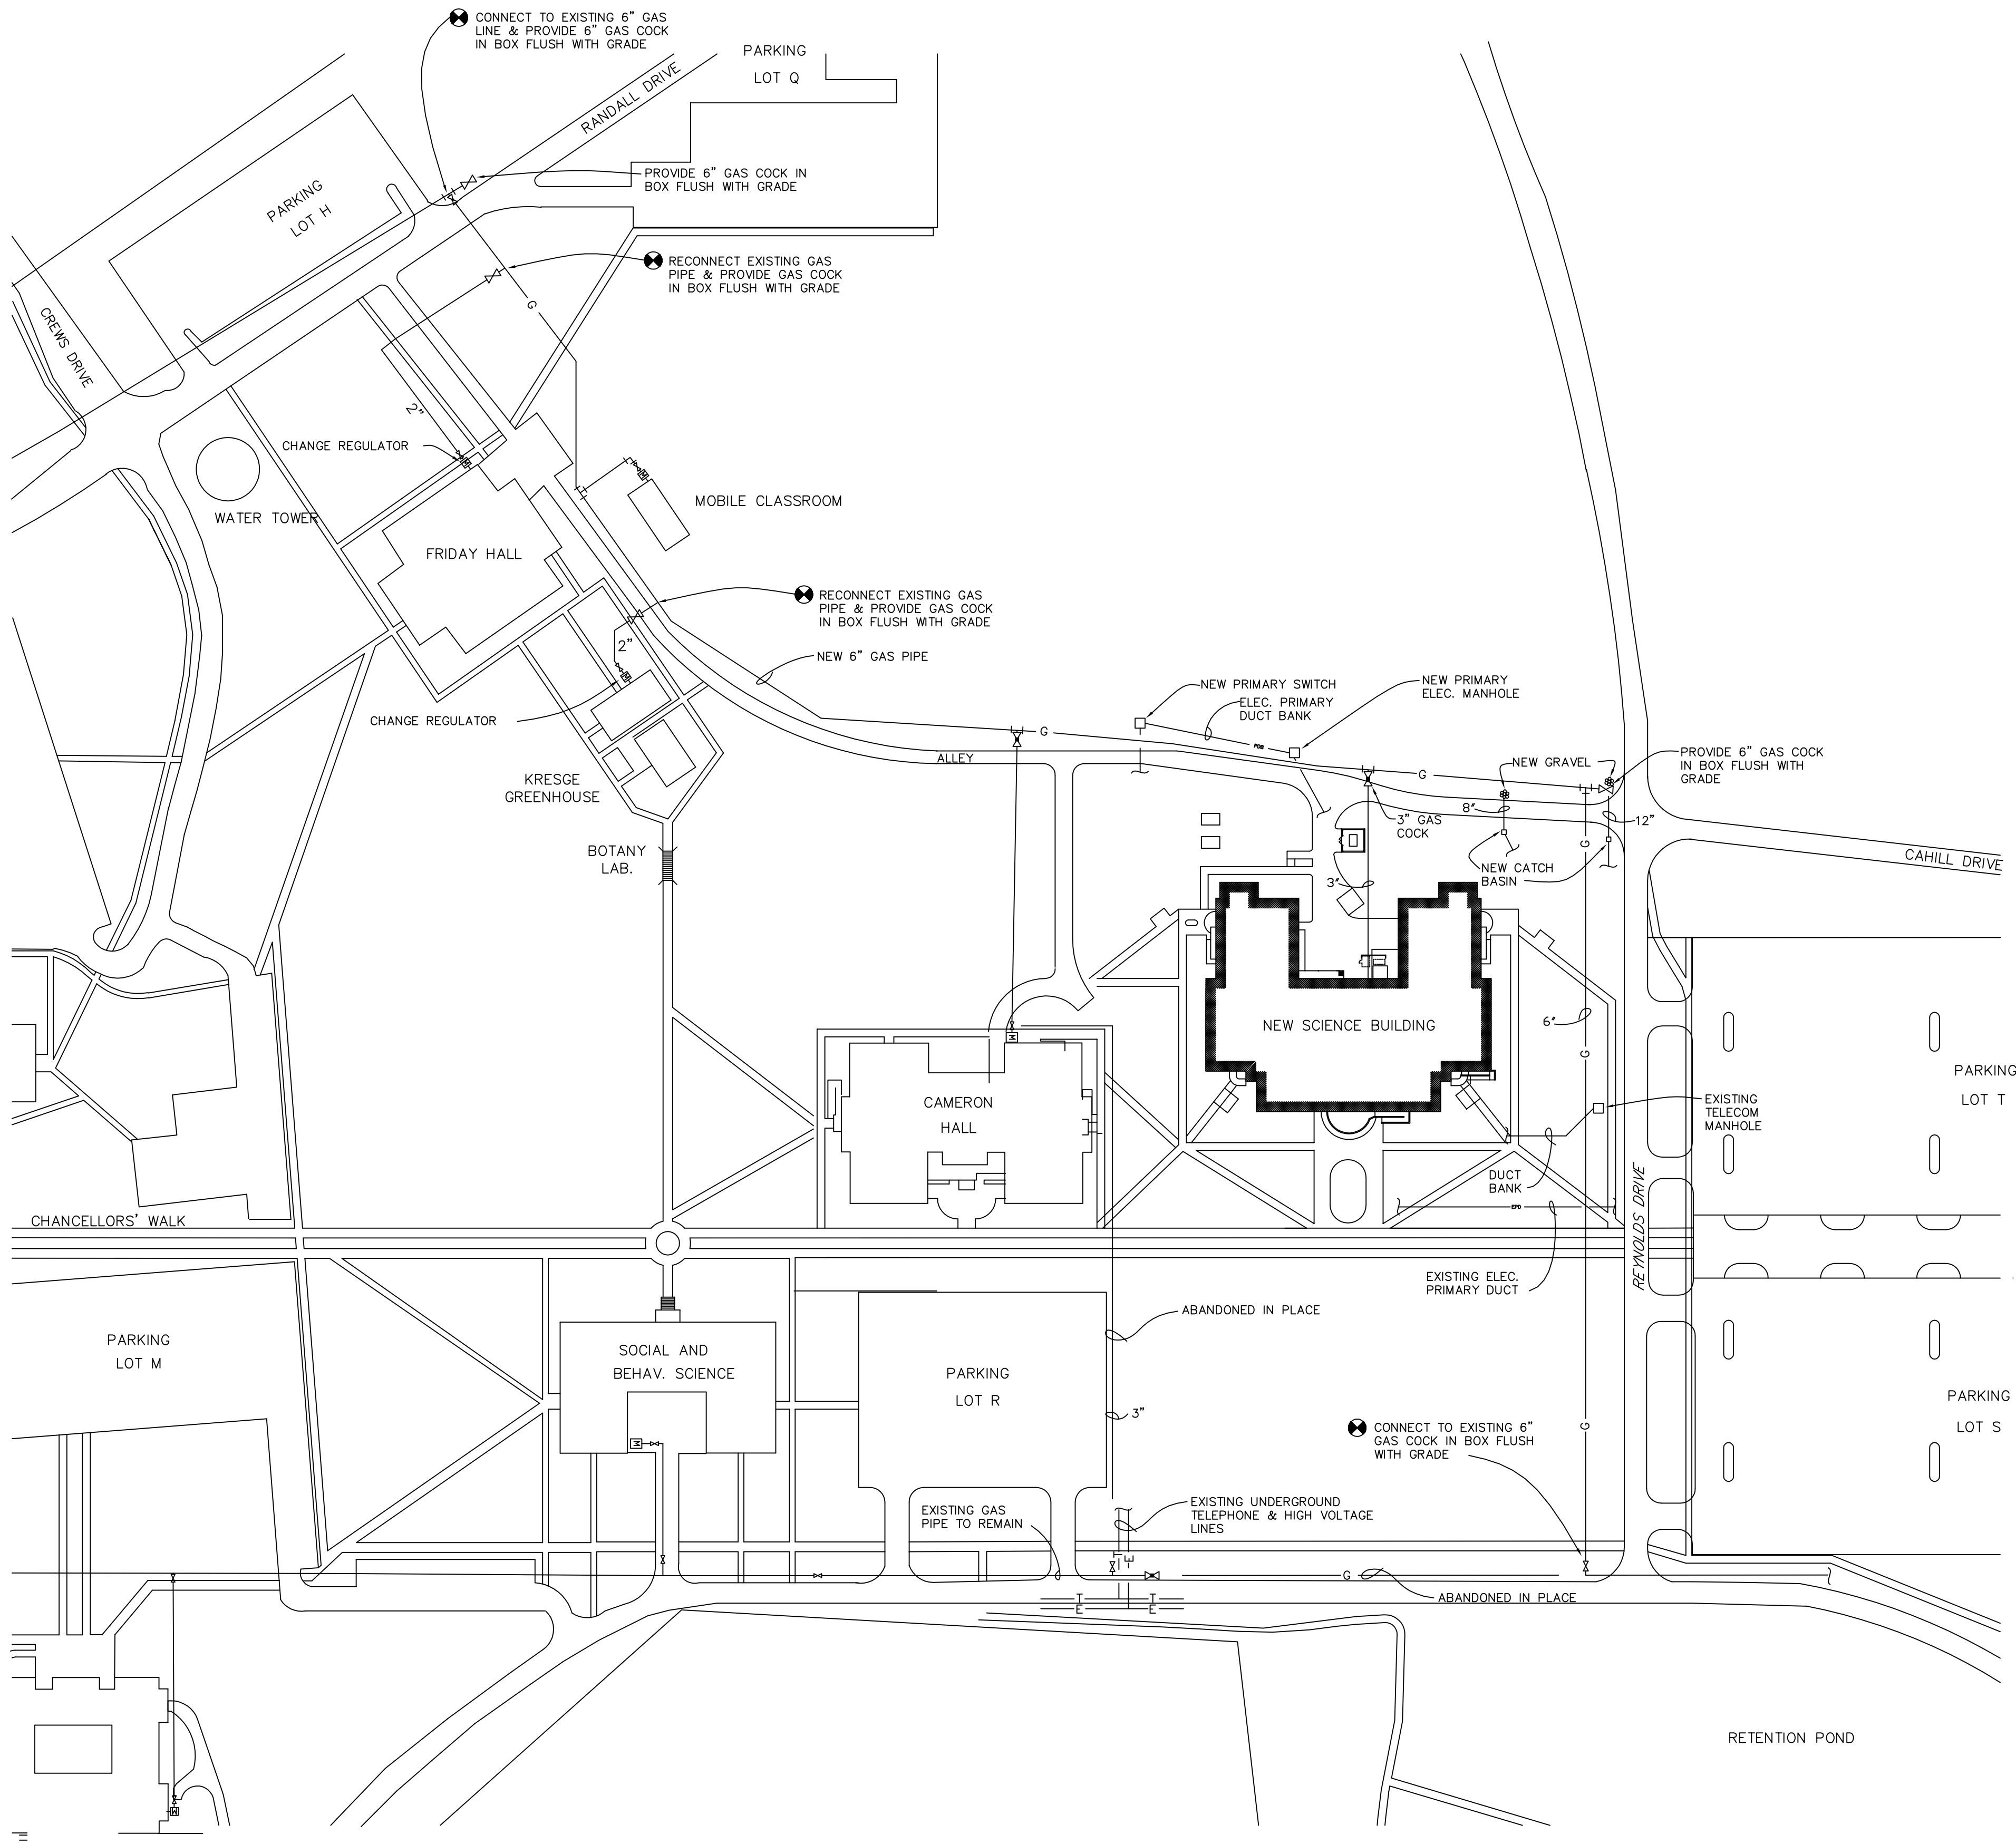

RECORD DRAWING
JANUARY 1998

BUFFALO, MORGAN & ASSOC., INC.

CONSULTING ENGINEERS

115 LAKE WHEELER ROAD
RALEIGH, N.C. 27603
(919) 833-1927

THIS DOCUMENT
ORIGINALLY ISSUED
AND SEALED BY:
RAY E. MORGAN
349 RAY, ON (1-11-90), AND
REVISED ON (1-13-98).
THIS MEDIA SHALL
NOT BE
CONSIDERED A
CERTIFIED DOCUMENT

DRAWING REVISIONS:		
NO.	DATE:	REMARKS:

DATE:	11 JAN. 95
PROJECT#:	9305
DESIGNED BY:	CRR
DRAWN BY:	RDH II
CHECKED BY:	WMP
CHECKED BY:	REM

SHEET NO.:

P1A

Of 8

P1A	MODIFICATIONS AT GAS SERVICE ENTRANCE
02	DETAIL
	NO SCALE

P1A

GAS PIPE REVISIONS

PARTIAL CAMPUS PLAN

SCALE: 1" = 100'

SCIENCE BUILDING
UNIVERSITY OF NORTH CAROLINA AT WILMINGTON
CODE 48928 ITEM 301 ID#6089280301A

SHEET TITLE:

FLOOR/DIRECTION
SHEET CONTENTS