



KEY PLAN

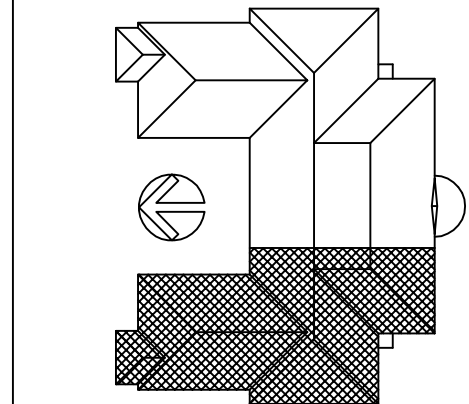

P2
01

FIRST FLOOR - WEST - PLUMBING
FLOOR PLAN
SCALE: 1/8" = 1'-0"

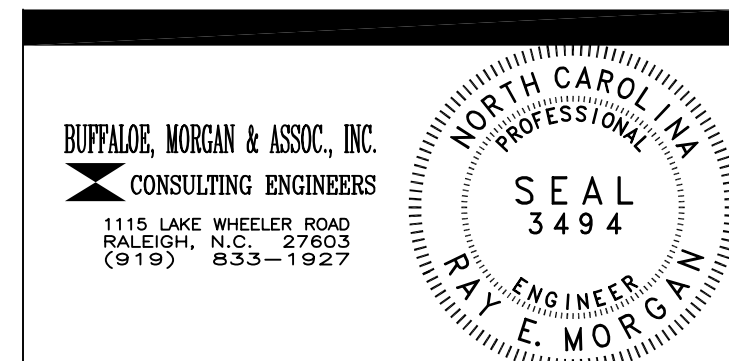

DRAWING REVISIONS:		
NO.	DATE:	REMARKS:

DATE: 16 MAY 1994
PROJECT#: 9305
DESIGNED BY: CRR
DRAWN BY: RDH II
CHECKED BY: WMP
CHECKED BY: REM

SHEET NO.:
P2
OF 7