

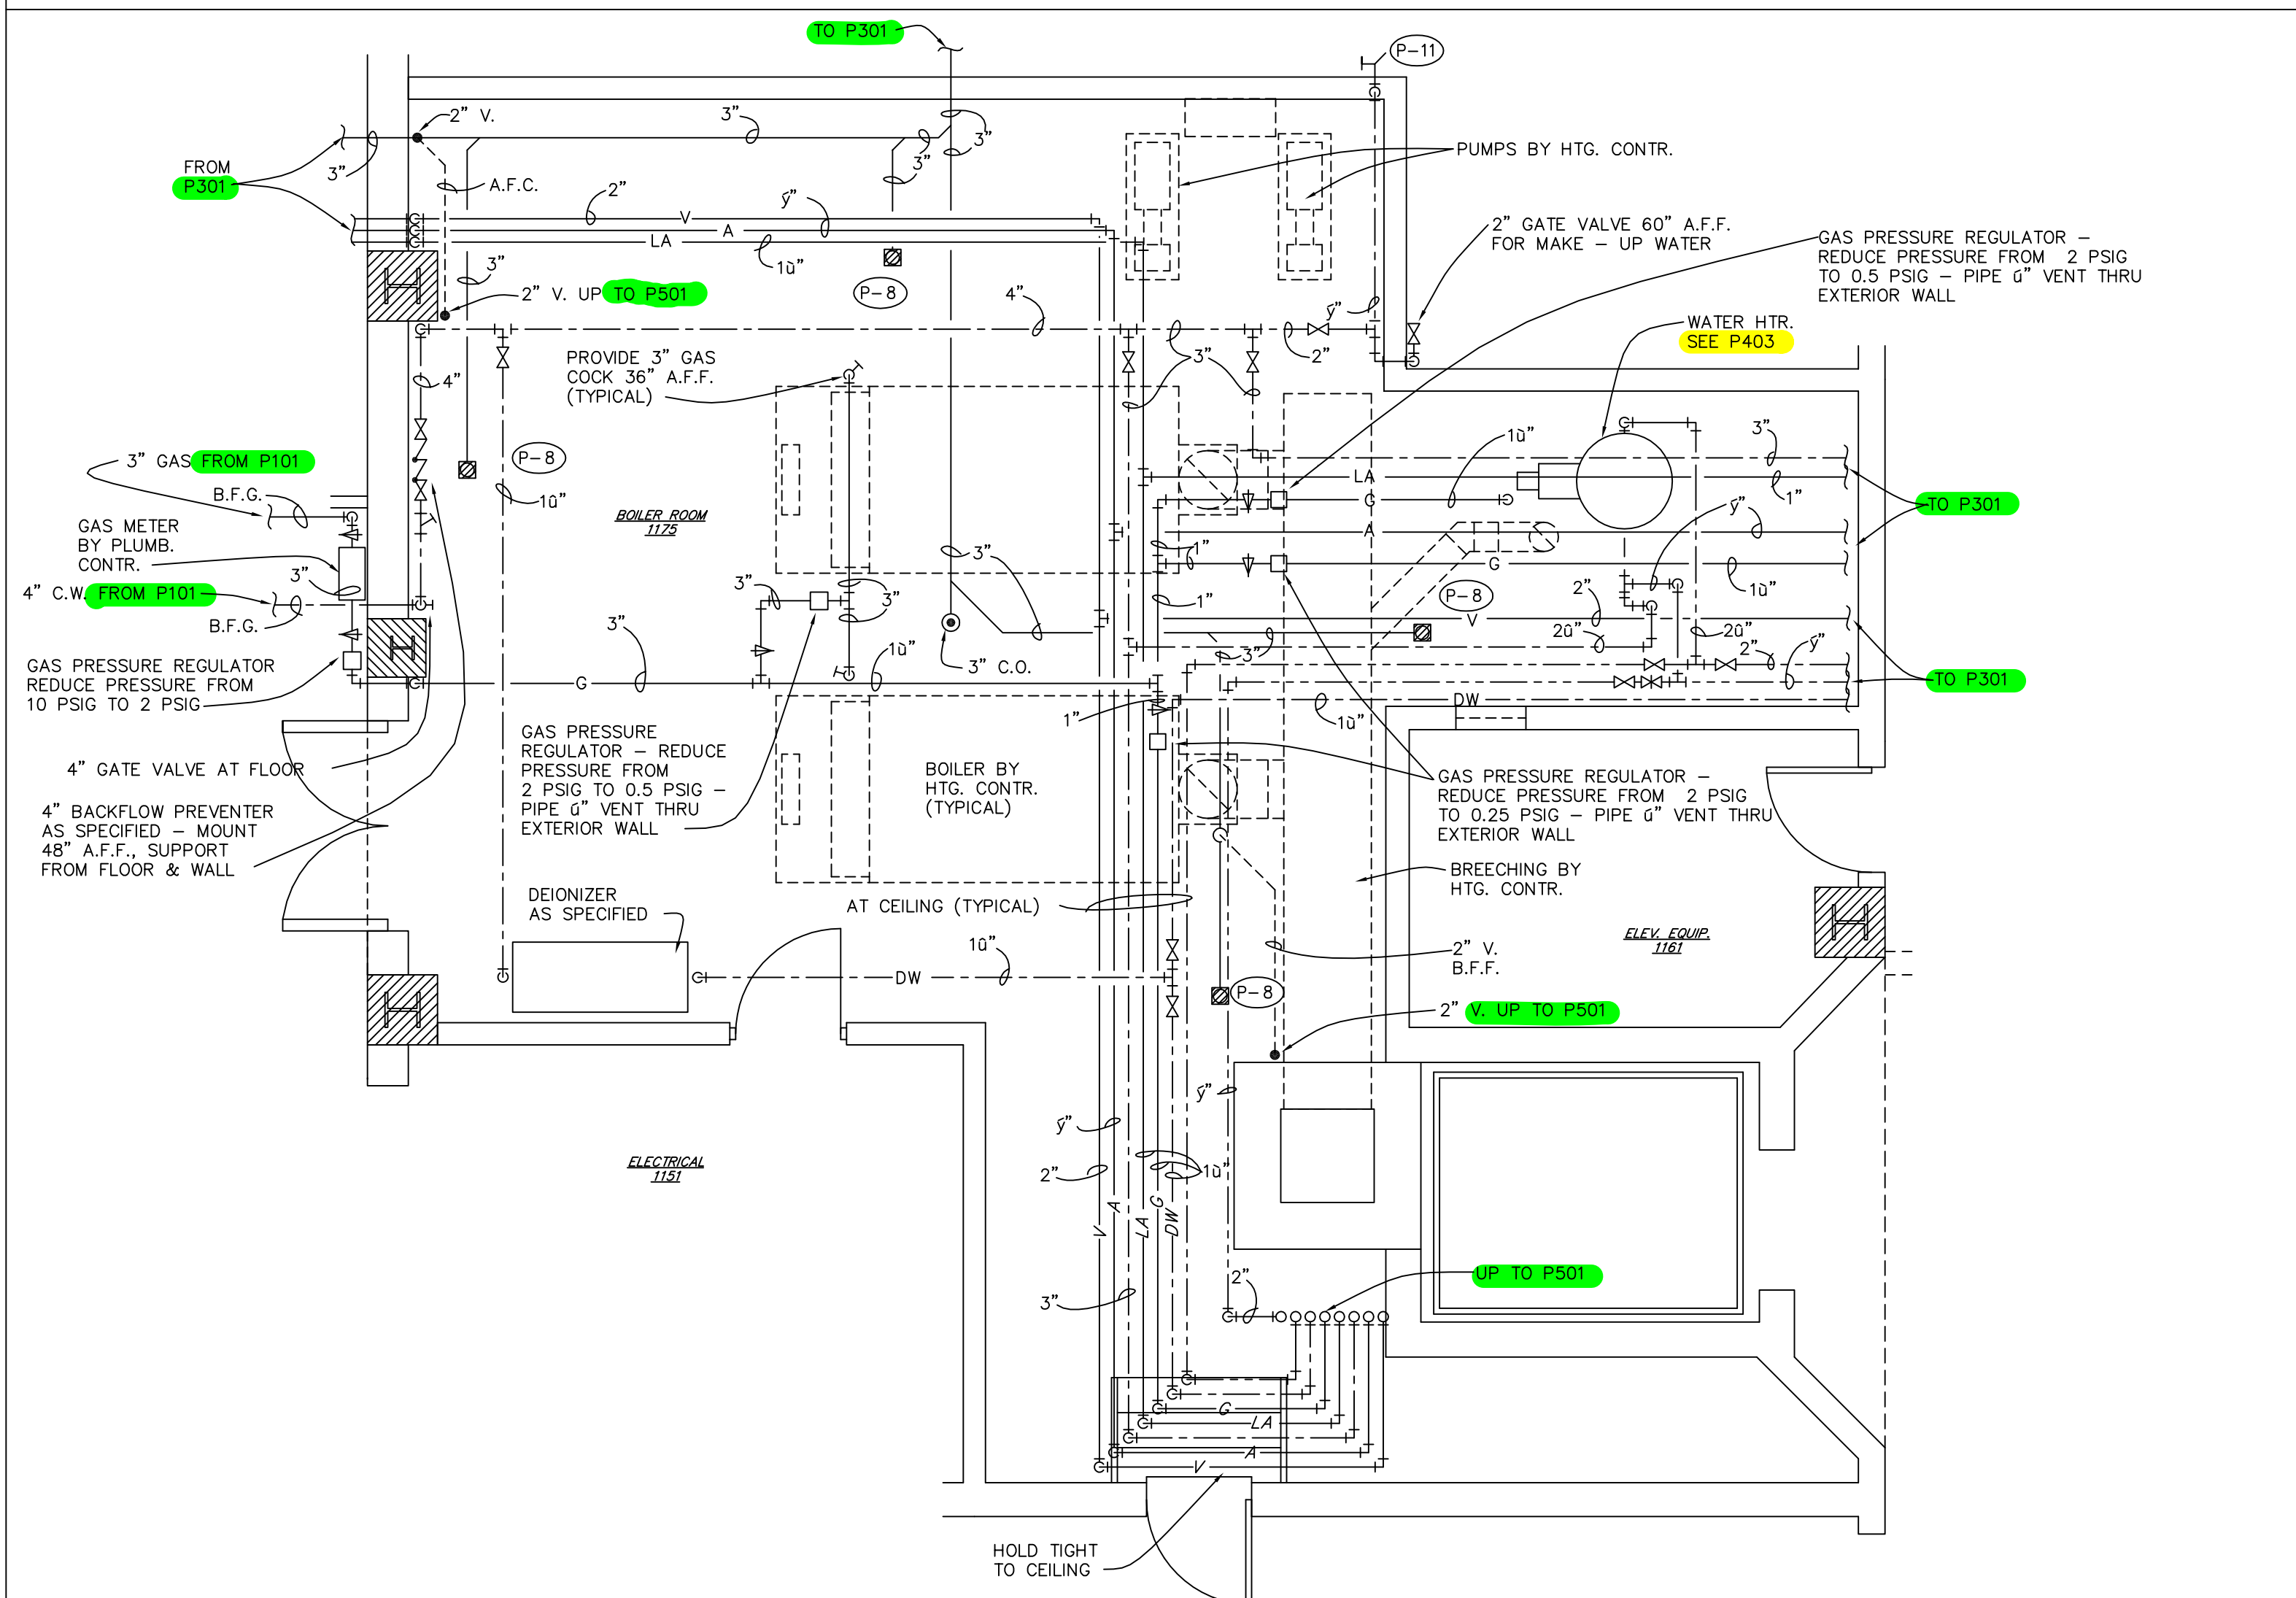


P5
01
P4
01

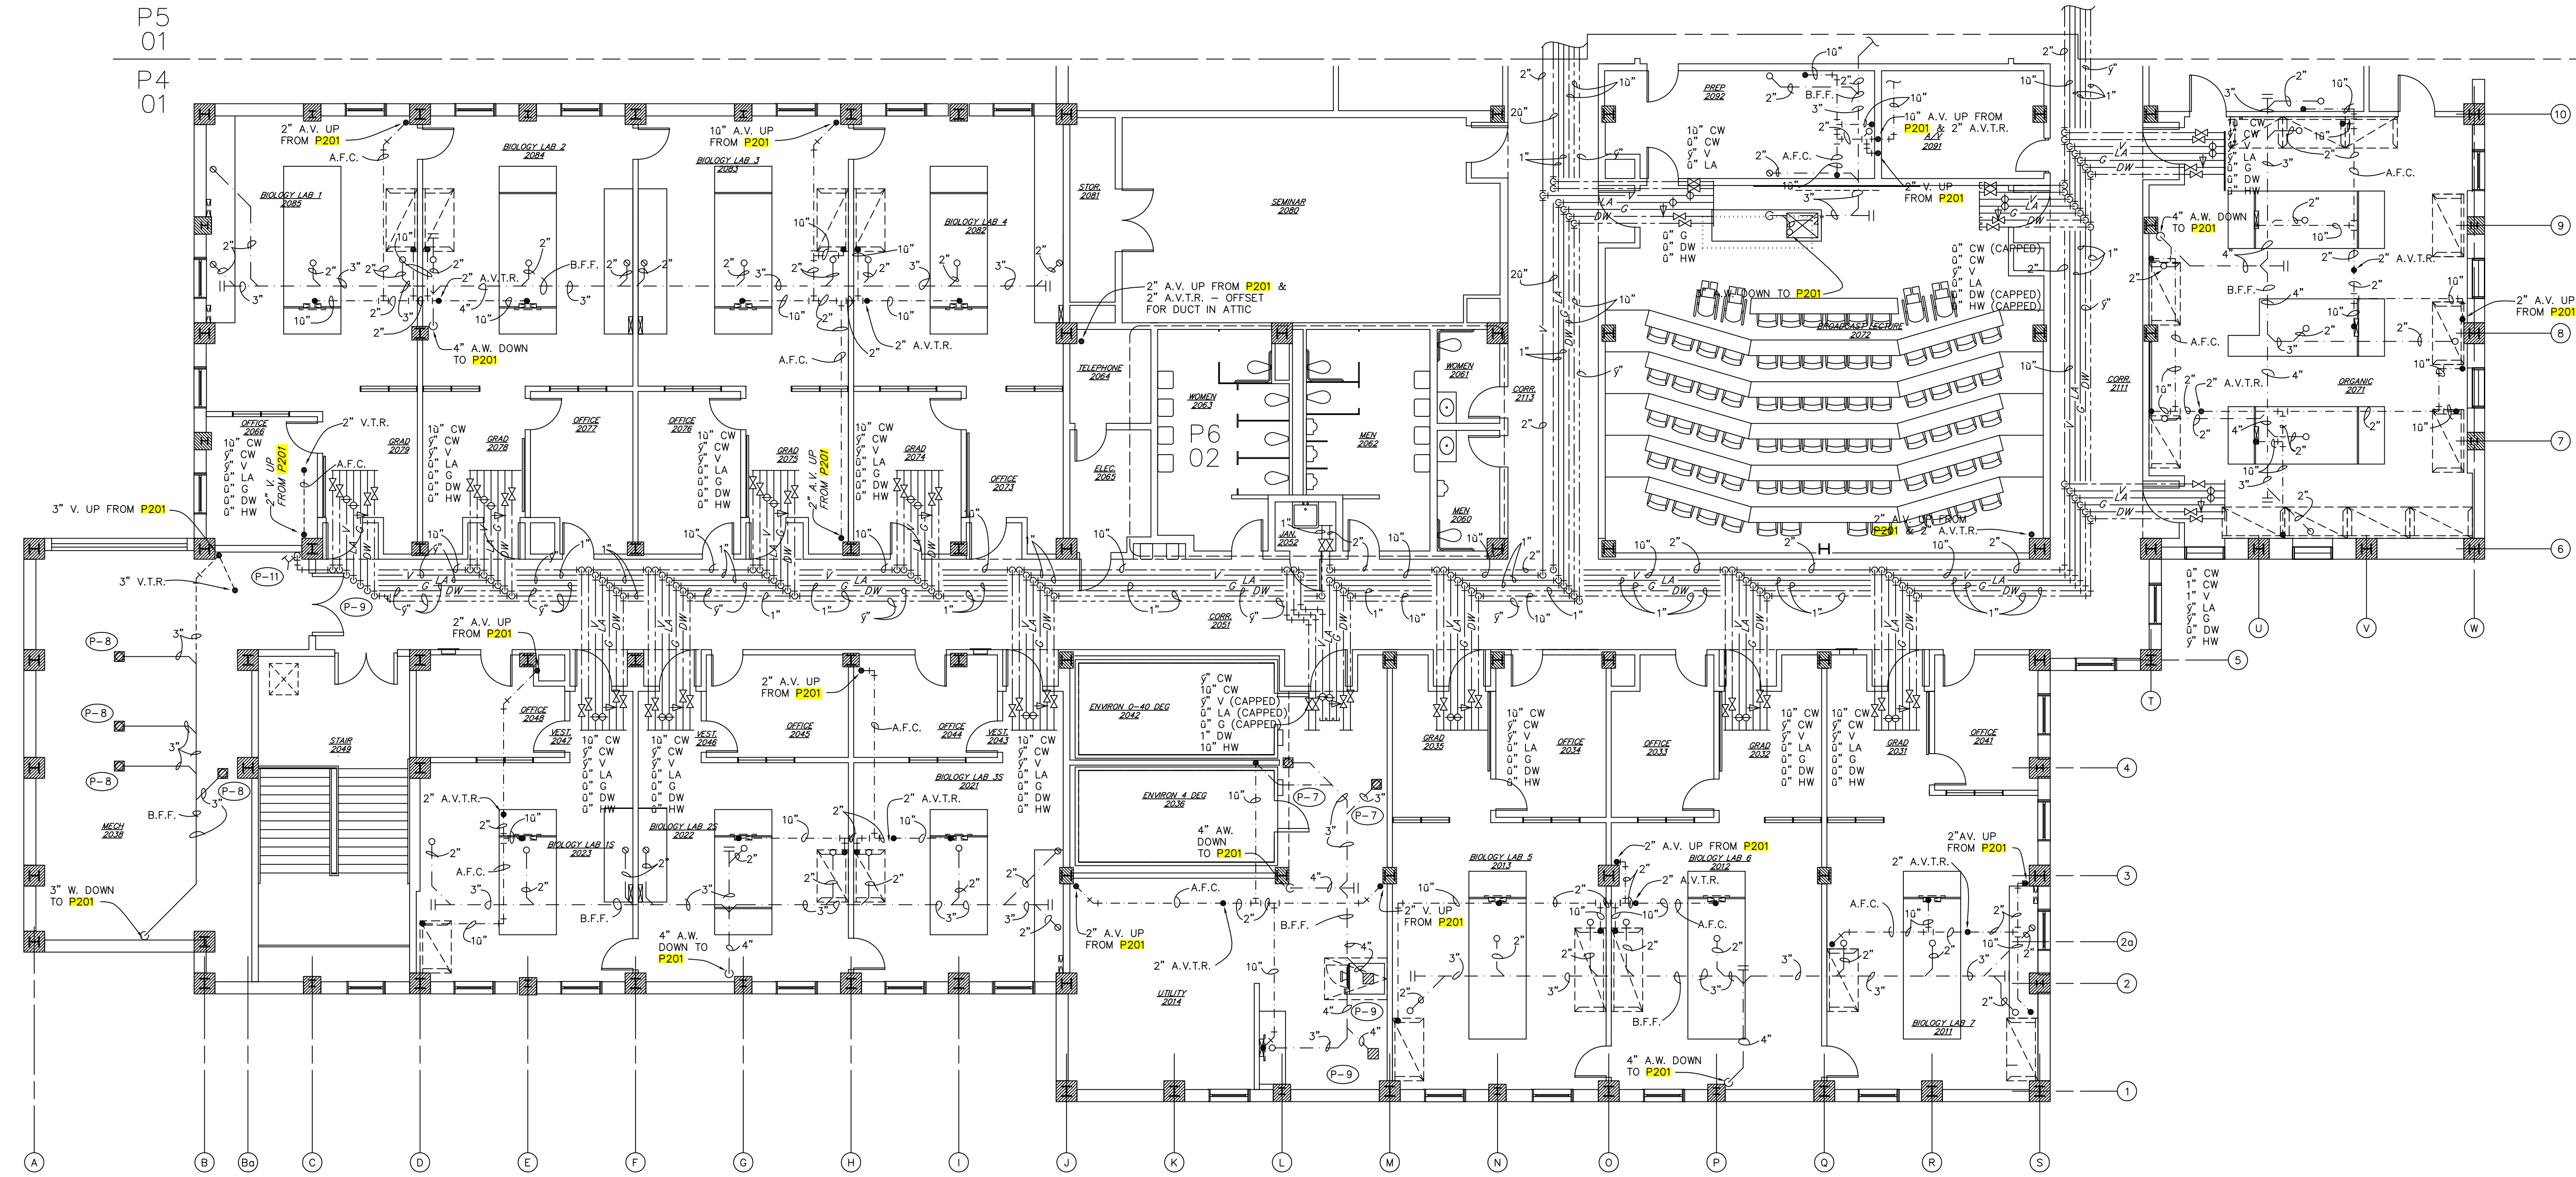


P4
02
MECH ROOM
ENLARGED PLAN
SCALE: 1/4" = 1'-0"

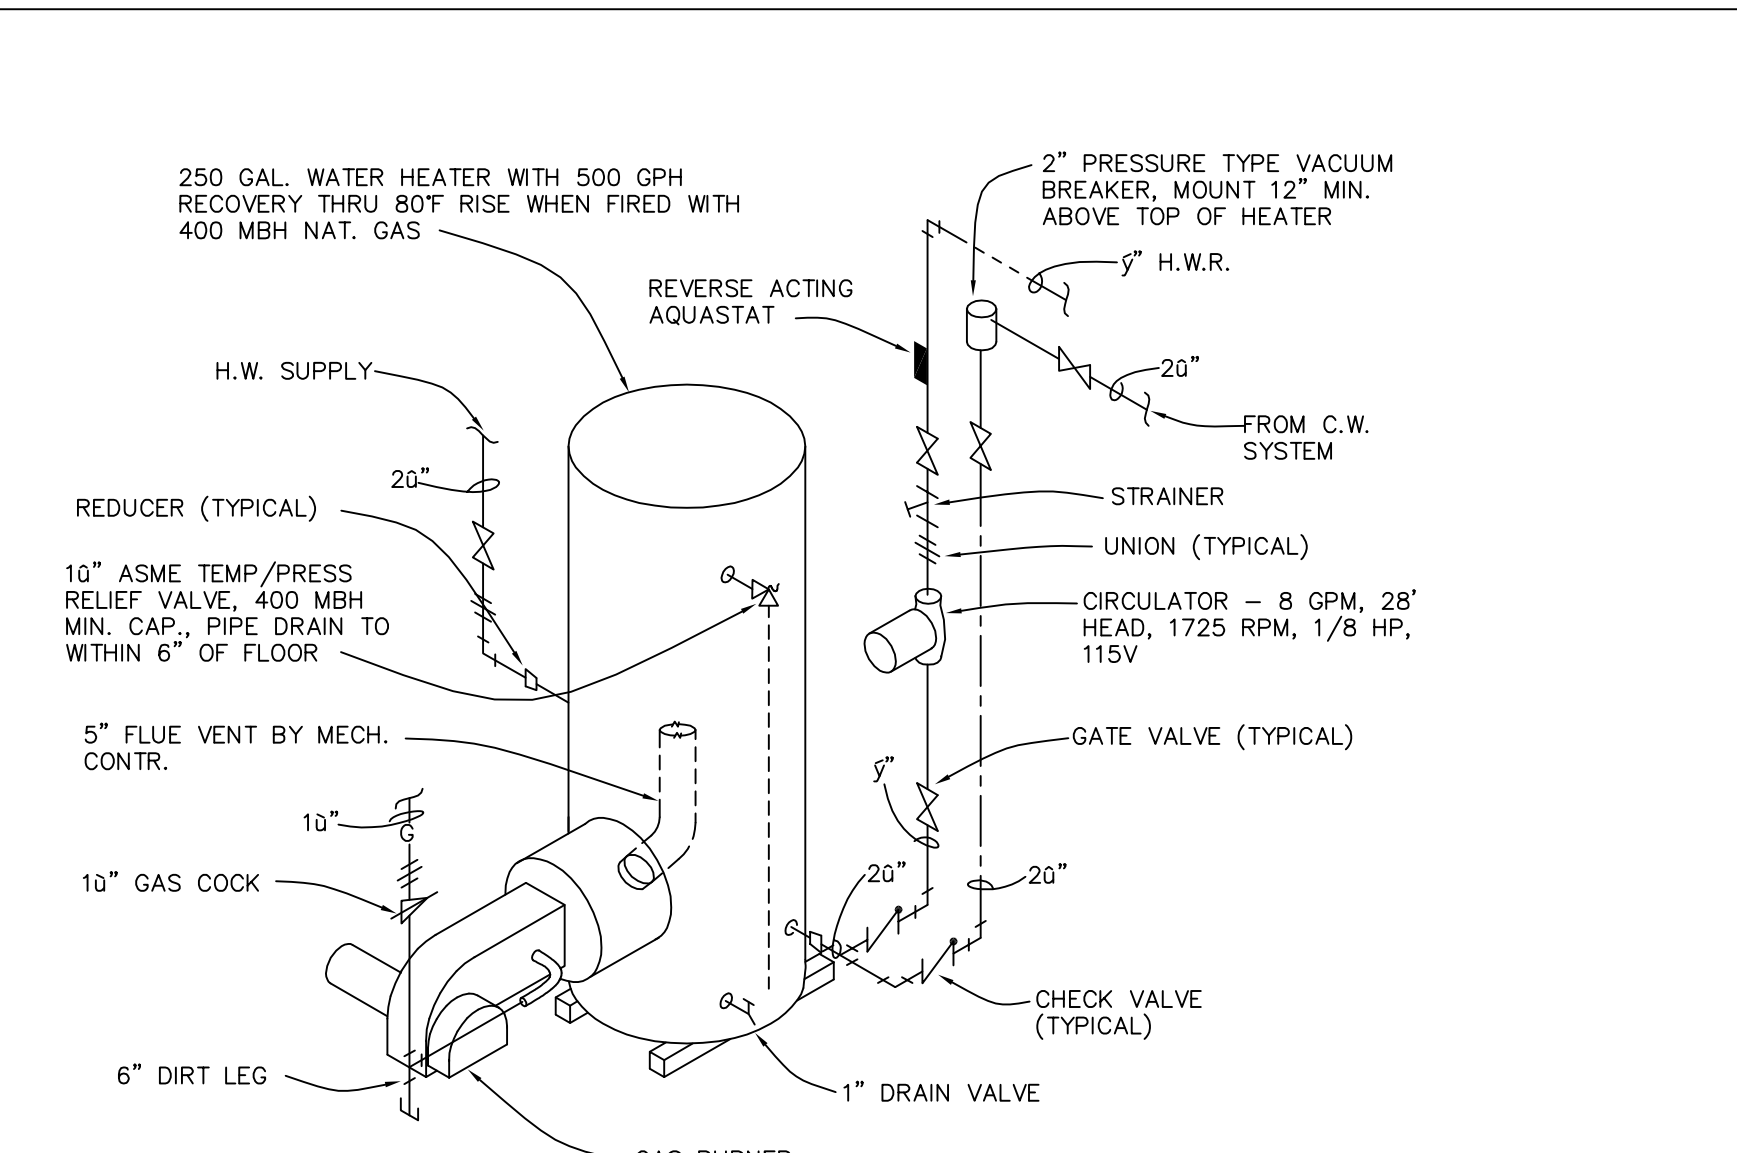


P4
03
WATER HEATER
DETAIL
NO SCALE

KEY PLAN

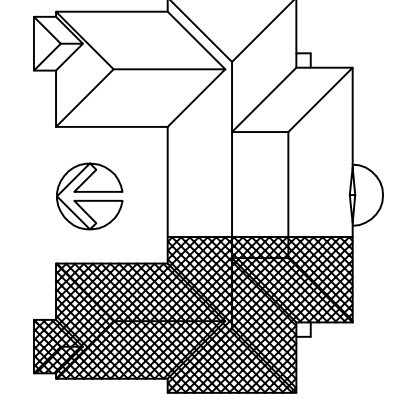

P4
01
SECOND FLOOR WEST - PLUMBING
FLOOR PLAN
SCALE: 1/8" = 1'-0"

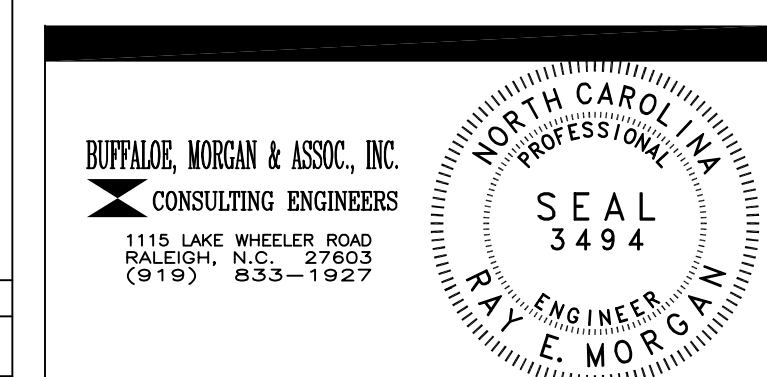

DRAWING REVISIONS:		
NO.	DATE:	REMARKS:

DATE:	16 MAY 1994
PROJECT#:	9305
DESIGNED BY:	CRR
DRAWN BY:	RDH II
CHECKED BY:	WMP
CHECKED BY:	REM

SHEET NO.:	P4
OF	7