

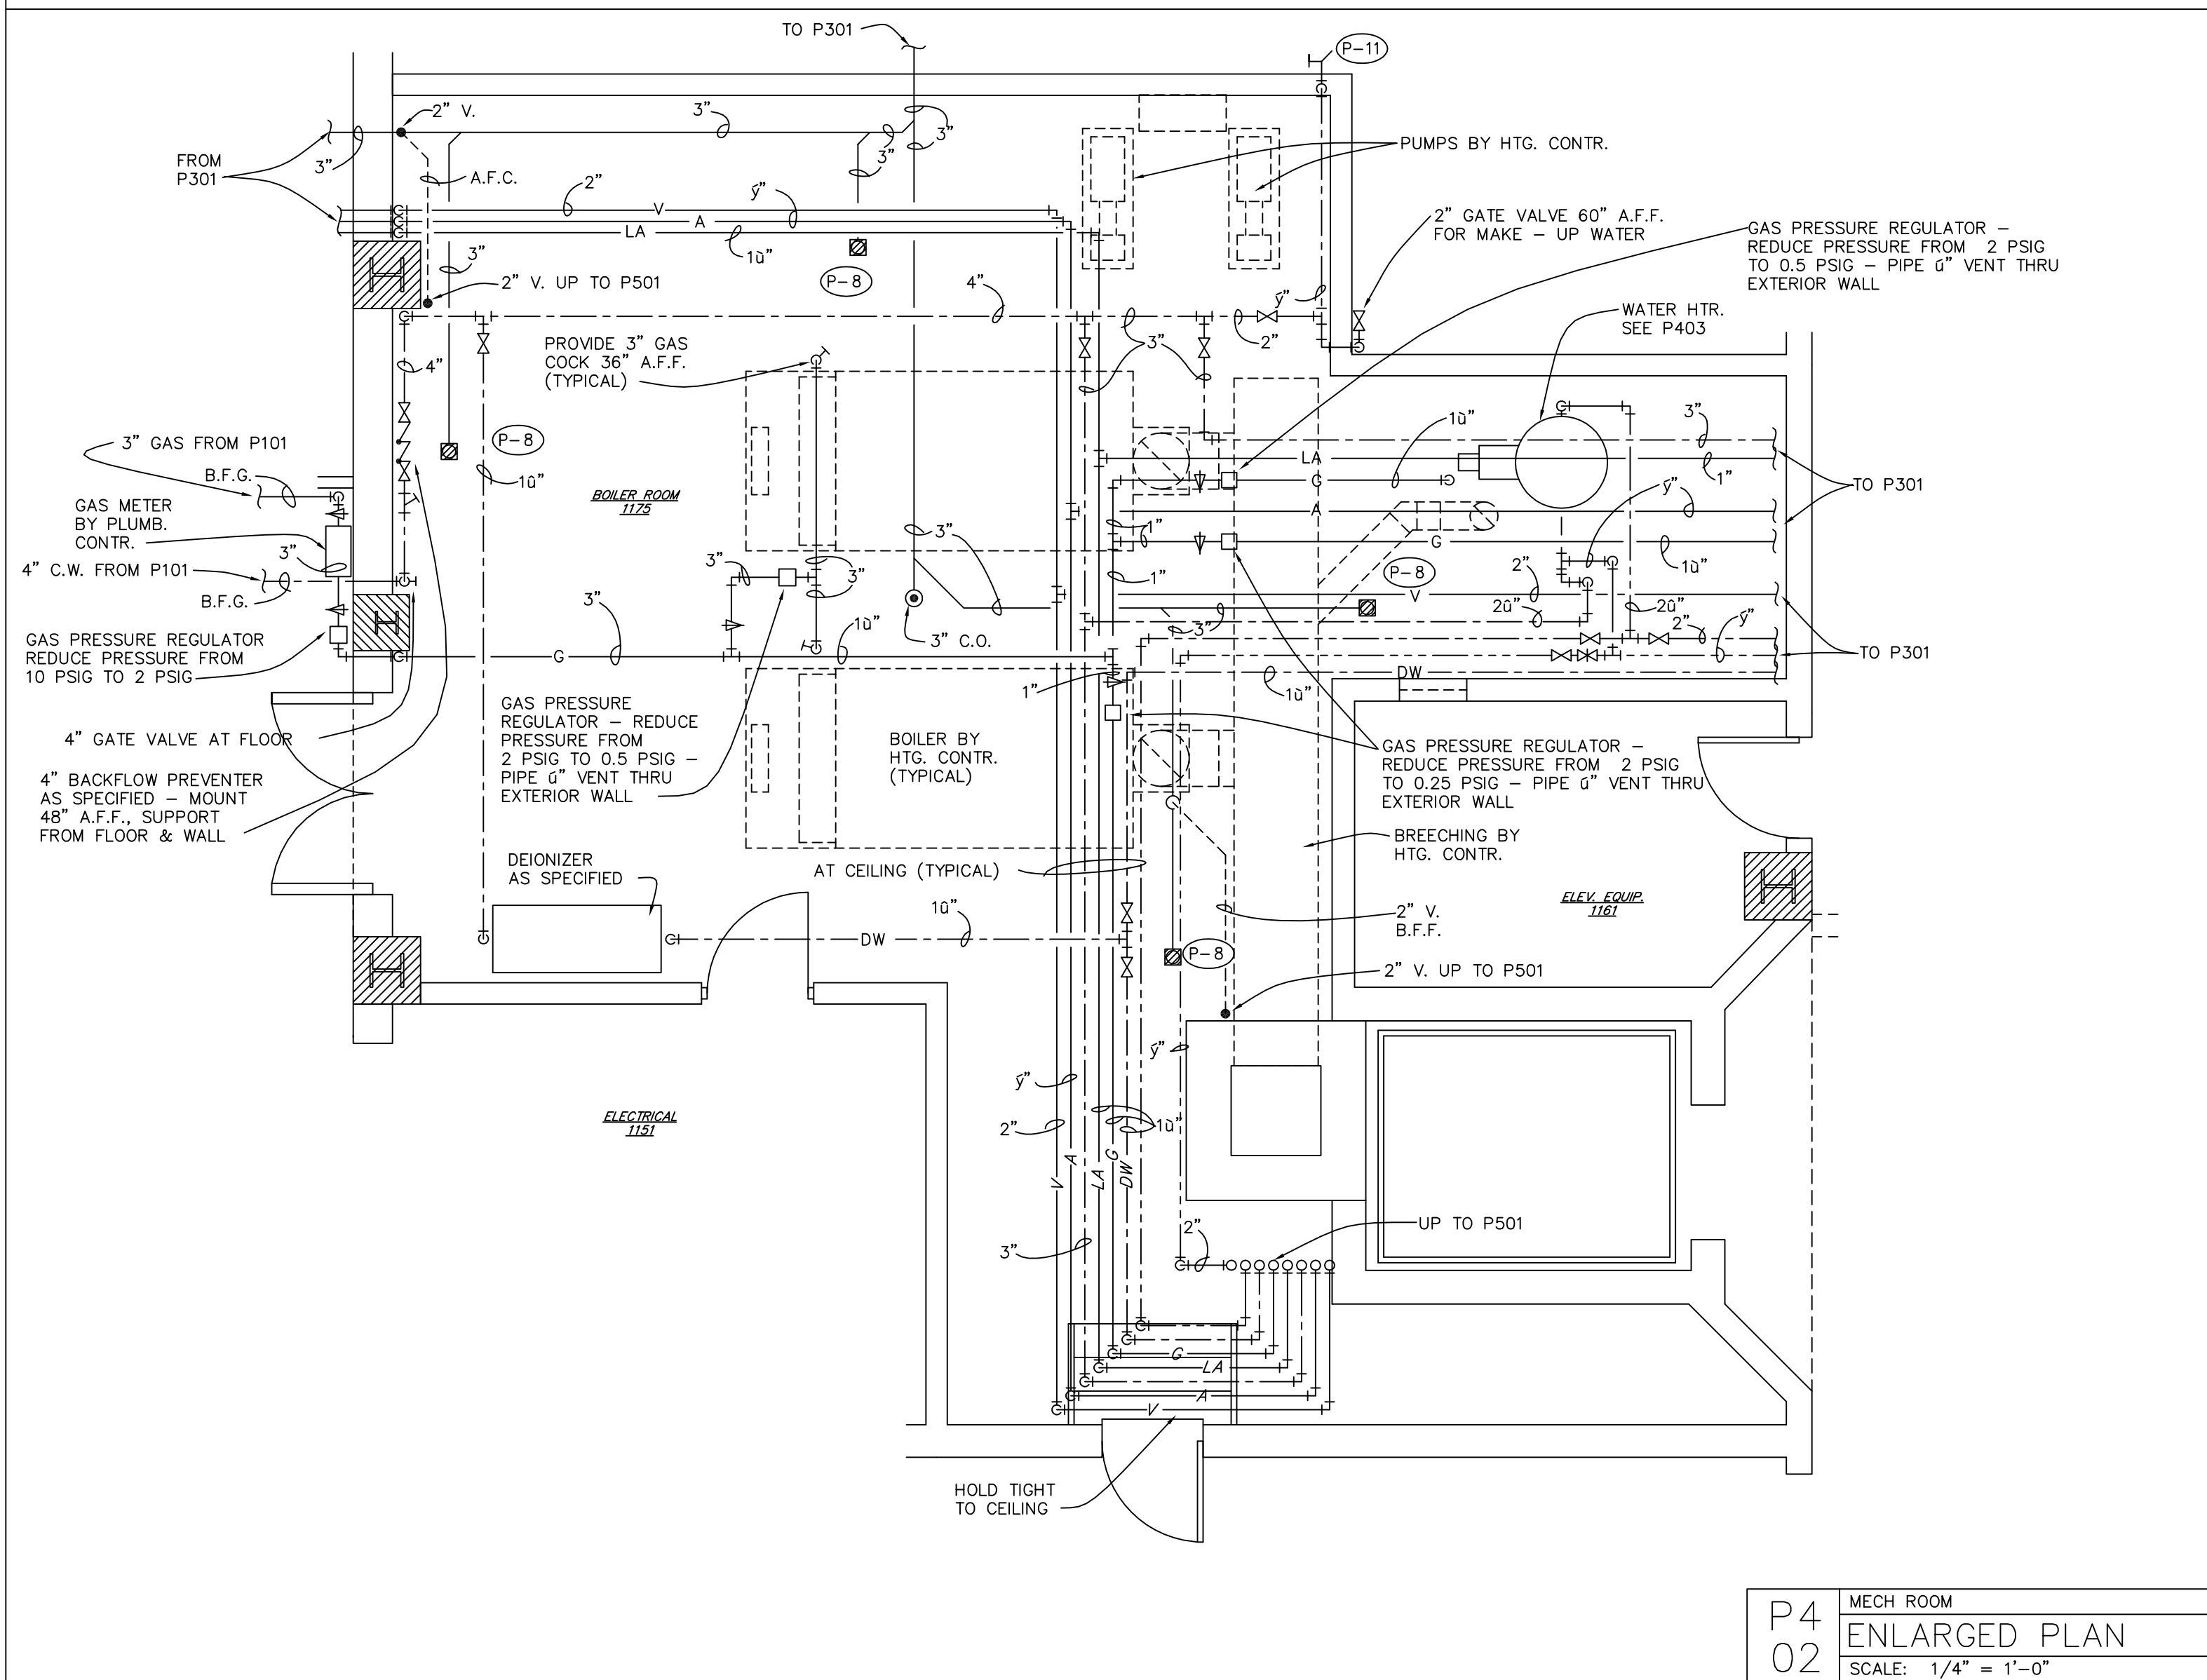


P5
01
P4
01

P5
01
P4
01

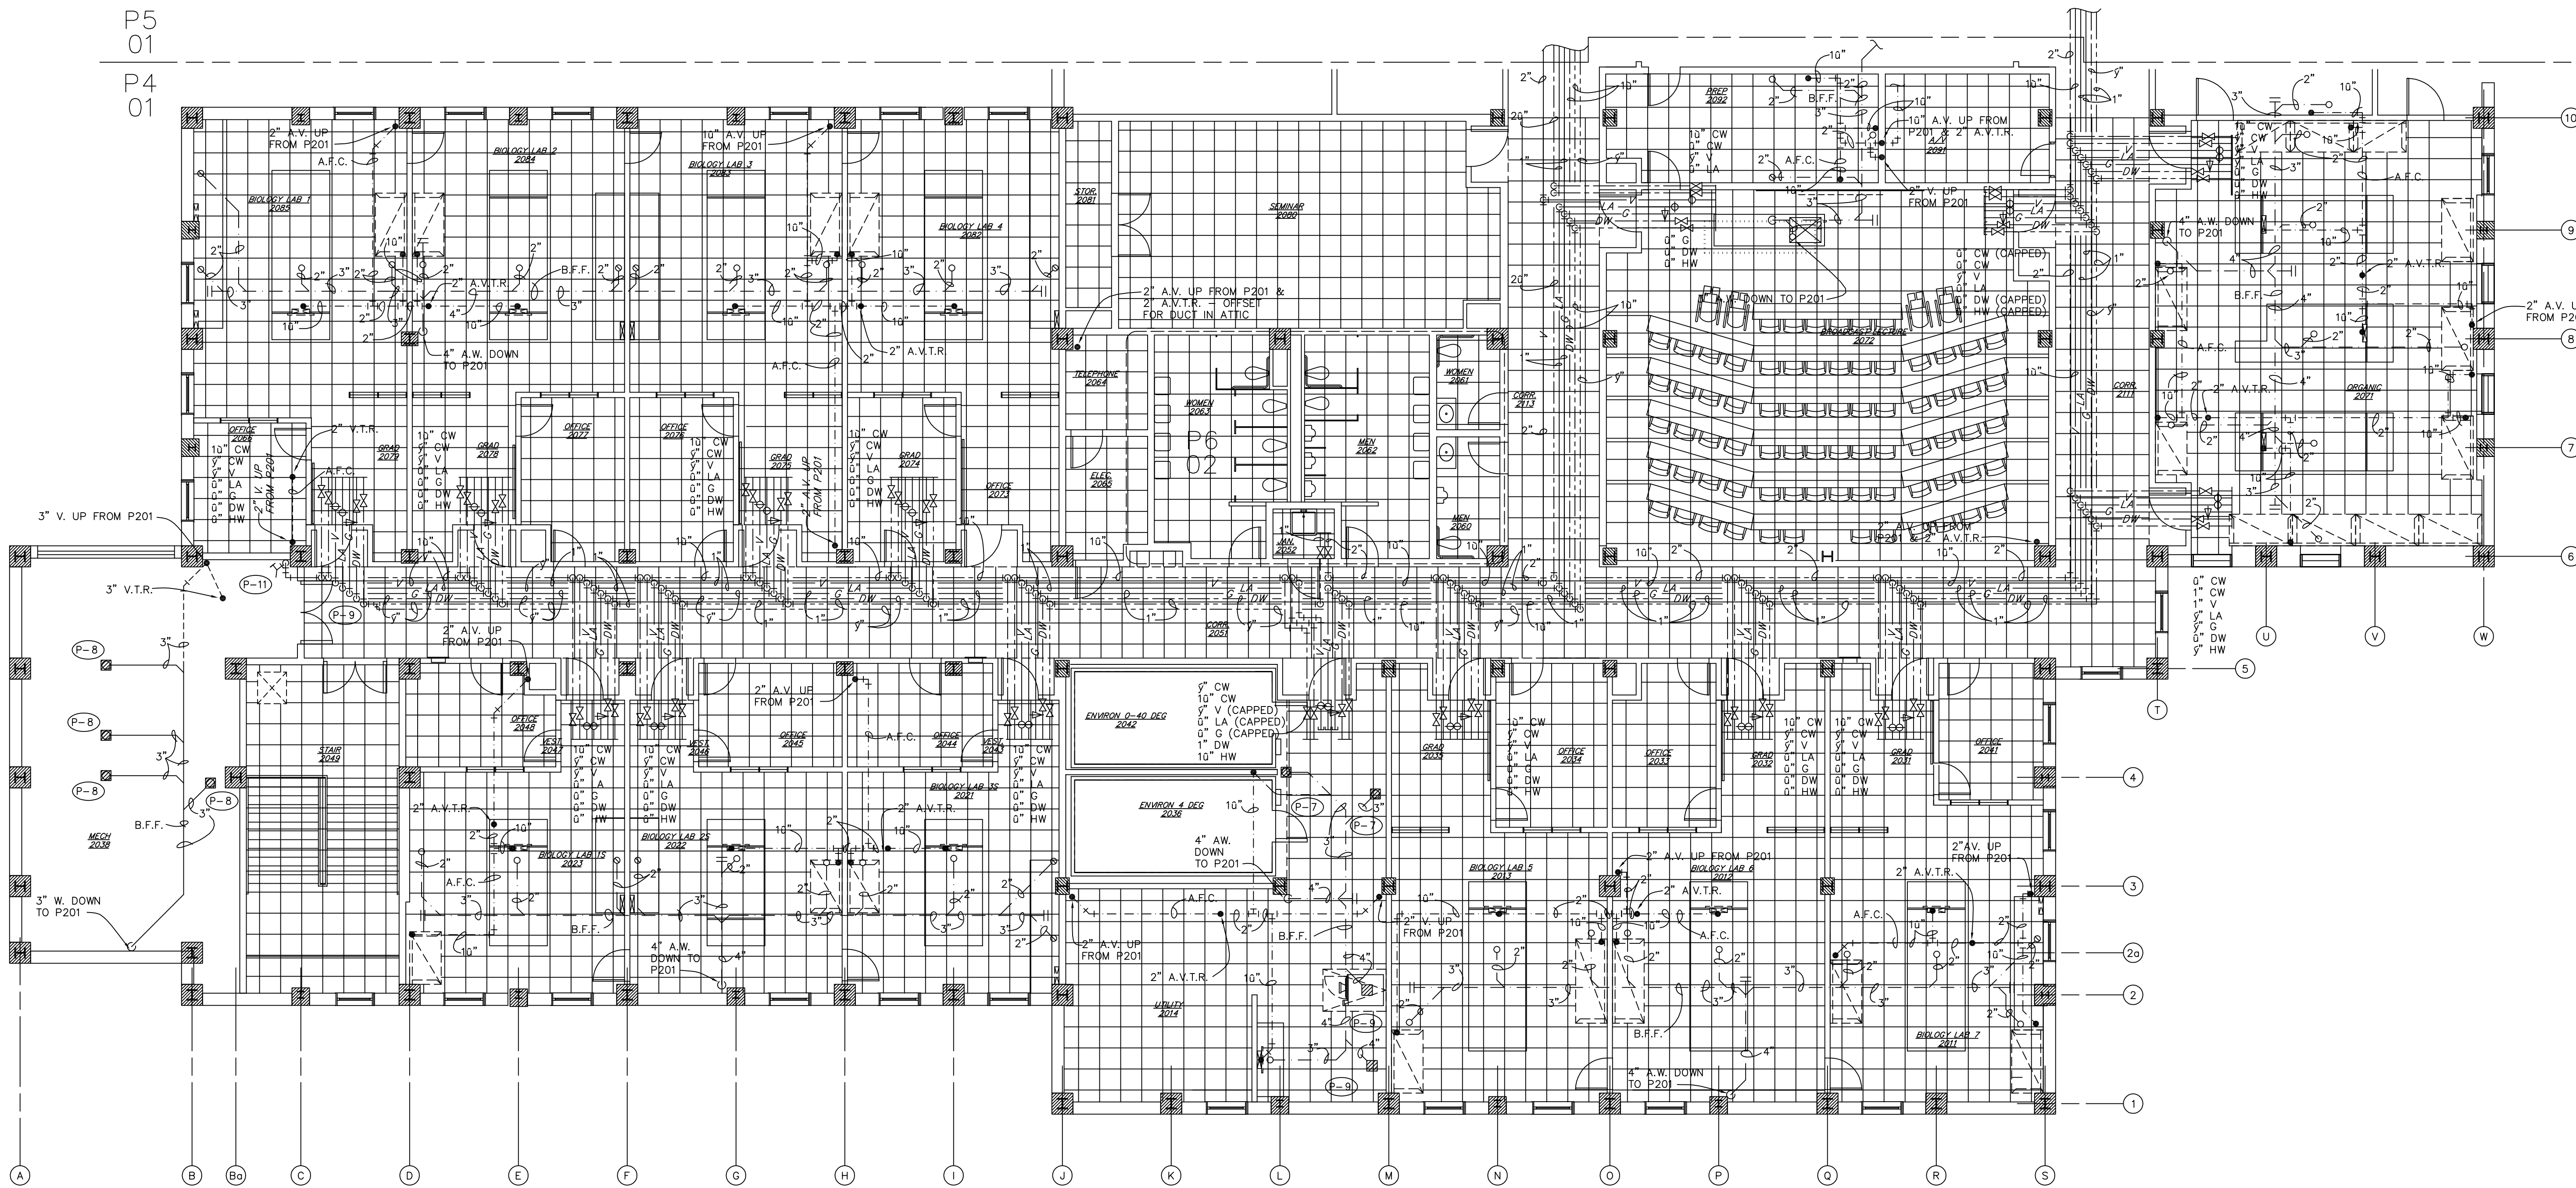


P4
02 MECH ROOM
ENLARGED PLAN
SCALE: 1/4" = 1'-0"

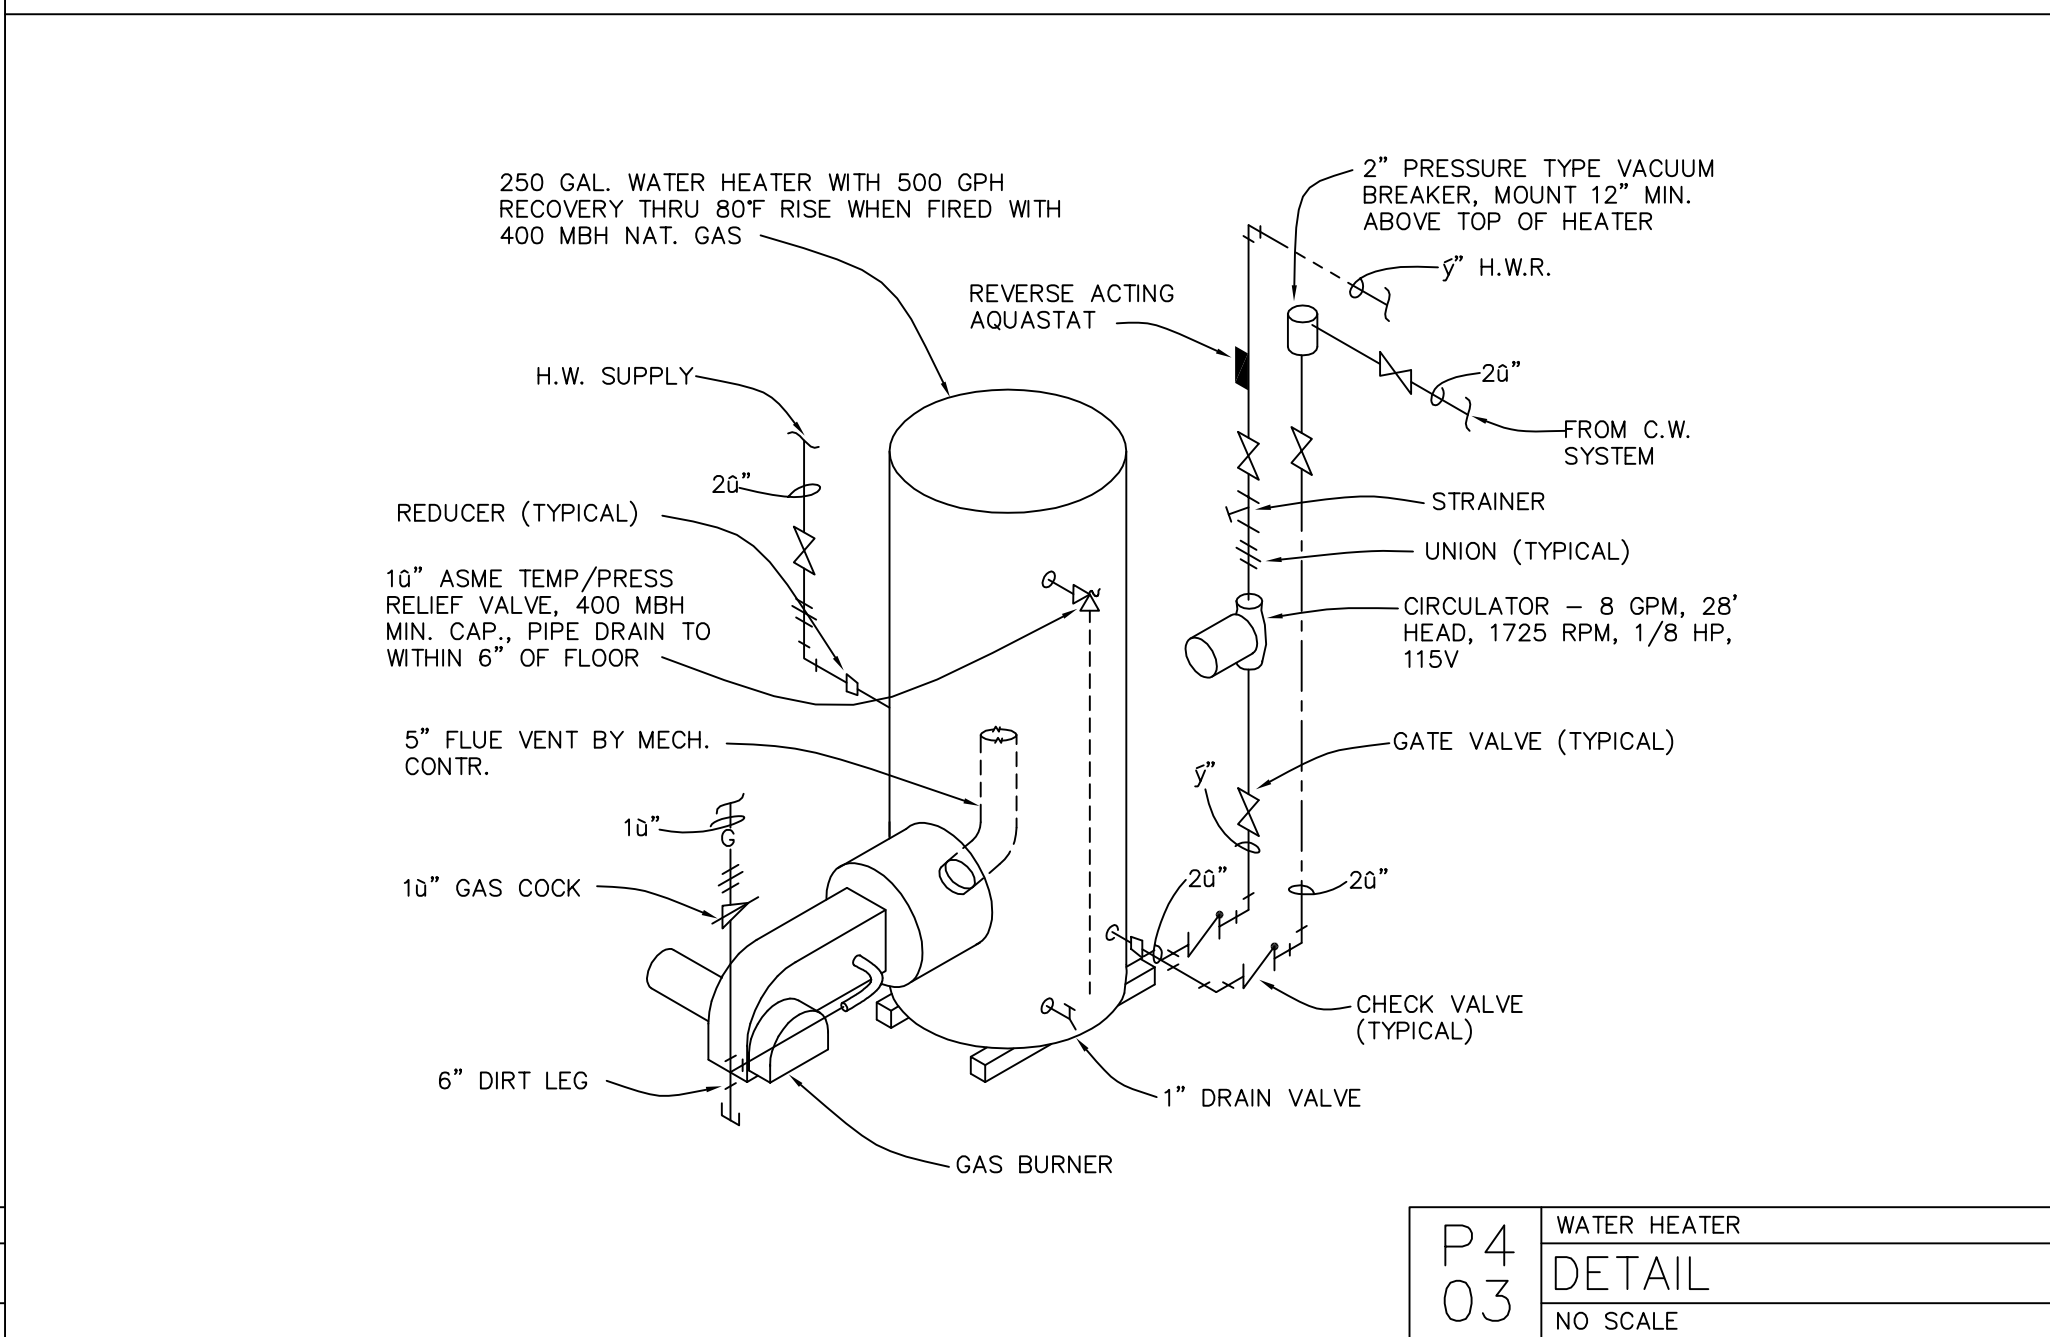


P4
03 WATER HEATER
DETAIL
NO SCALE

KEY PLAN

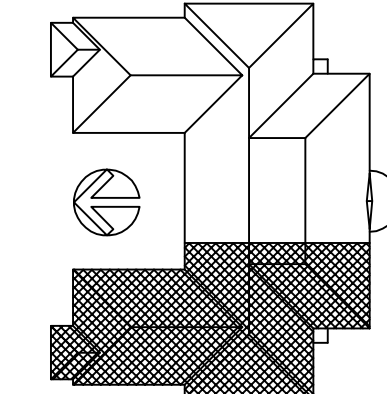

P4
01

SECOND FLOOR - WEST - PLUMBING
FLOOR PLAN
SCALE: 1/8" = 1'-0"

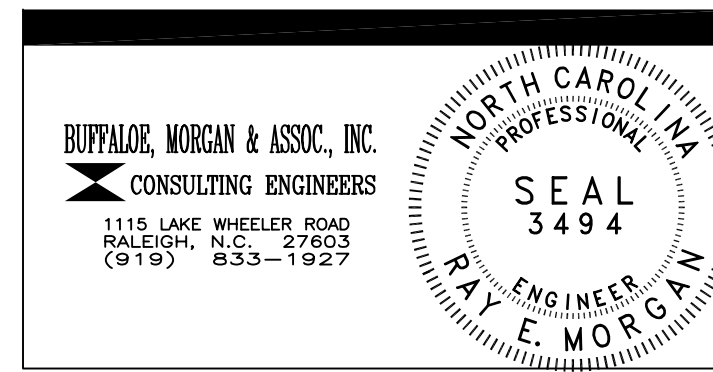

DRAWING REVISIONS:		
NO.	DATE:	REMARKS:

DATE: 16 MAY 1994
PROJECT#: 9305
DESIGNED BY: CRR
DRAWN BY: RDH II
CHECKED BY: WMP
CHECKED BY: REM

SHEET NO.:

P4

OF 7