




SCIENCE BUILDING
UNIVERSITY OF NORTH CAROLINA AT WILMINGTON
CODE 44888 ITEM 301 ID#009280801A

SHEET TITLE:


FIRST FLOOR PLAN - AREA ONE
WEST

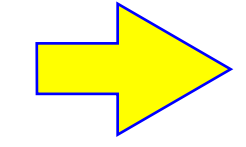

SHEET NO.:


LP1

BUILDING KEYMAP

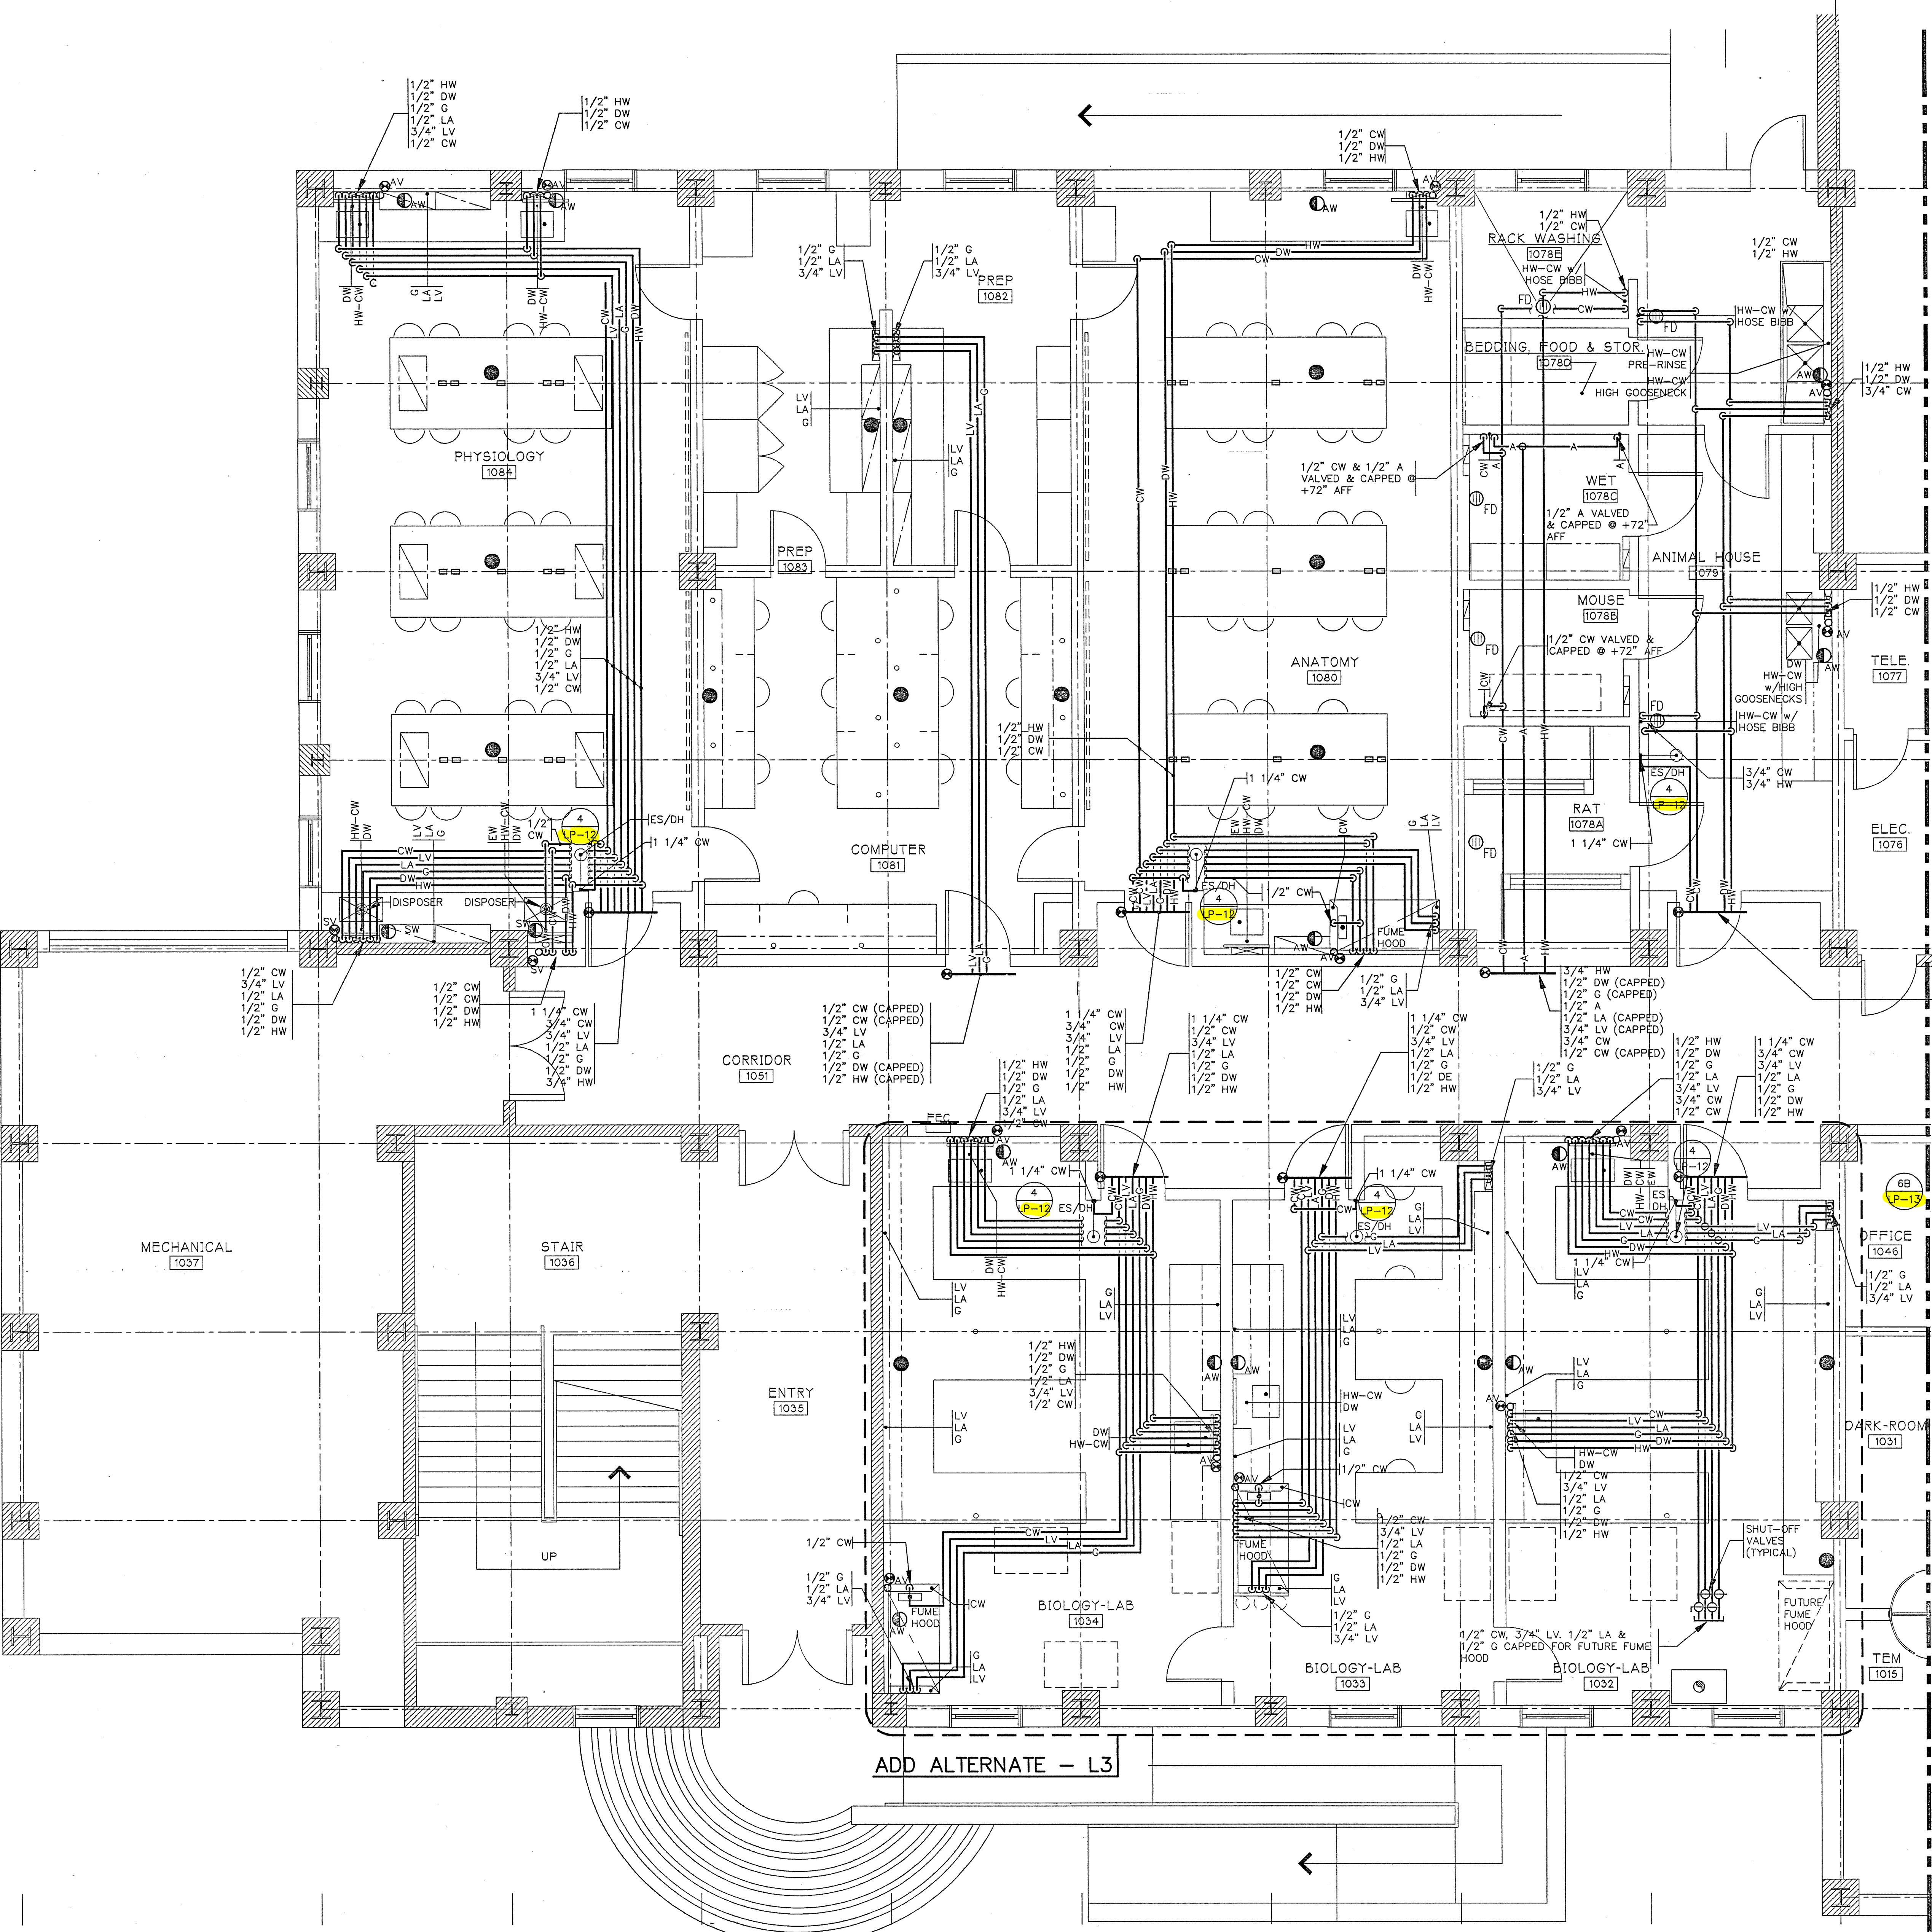

SERVICE FITTING SCHEDULE

EXAMPLE:
G-1A INDICATES TYPE OF FITTING ABBREVIATED INDIVIDUALLY ON FLOOR PLANS.
LA-10 NUMERICAL REFERENCE OF FITTING ELEV. SEE DRAWING U-16.
FITTINGS MAY ALSO BE INDICATED INDIVIDUALLY ON FLOOR PLANS.
A = 7\"/>

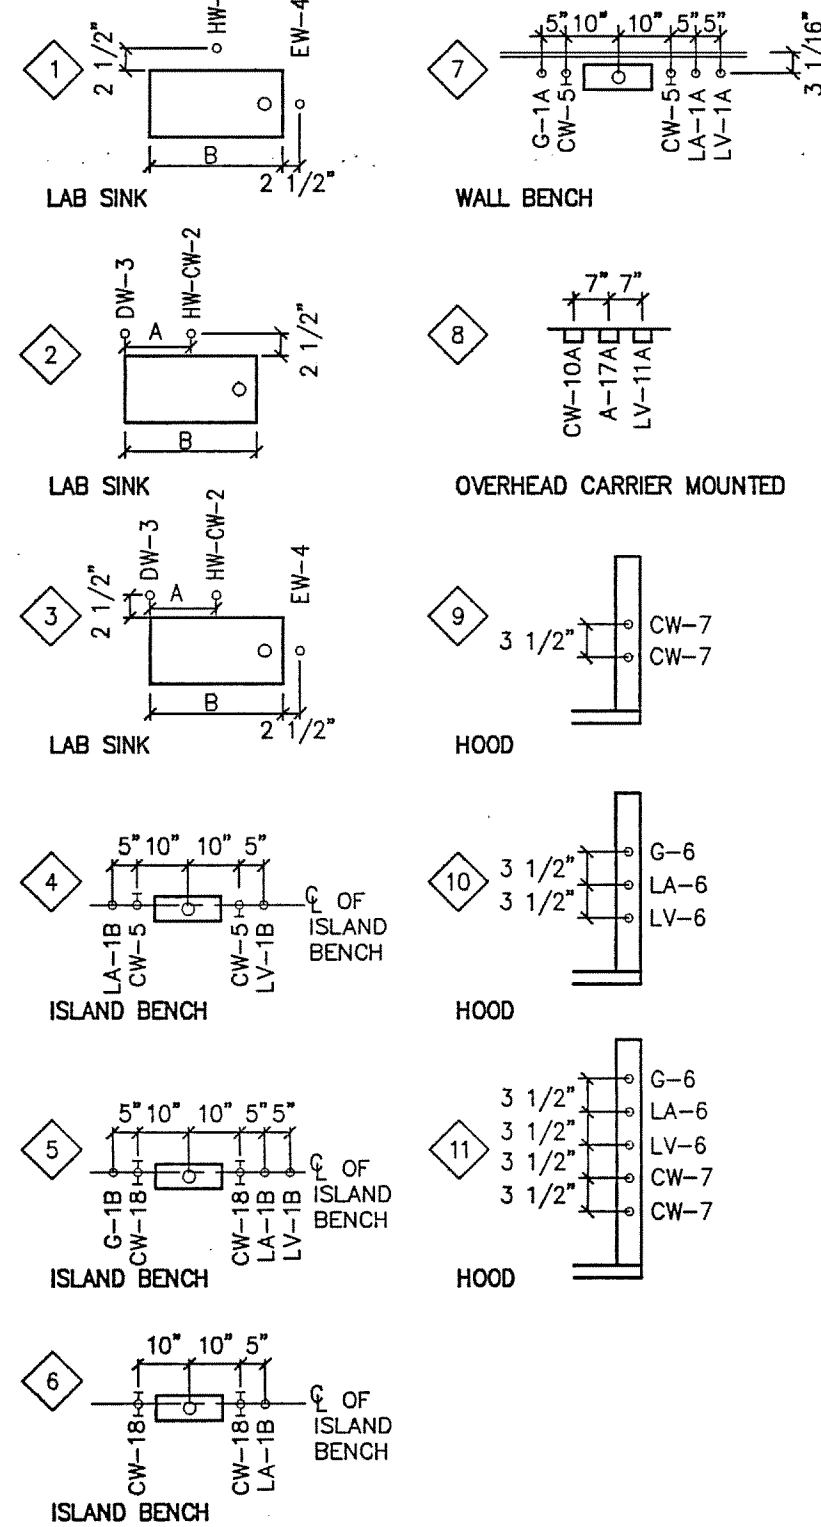

FIRST FLOOR
SCALE: 1/4\"/>

AREA ONE
AS BUILT

DRAWING REVISIONS:		
NO.	DATE	REMARKS

DATE: 5/16/94
PROJECT#: 8862
DESIGNED BY: AMA
DRAWN BY: AMA
CHECKED BY: ARW
CHECKED BY:

Earl Wells Associates
Laboratory Design Consultants
5348 Carroll Canyon Road
San Diego, California 92121
(619)457-2400