


SCIENCE BUILDING  
UNIVERSITY OF NORTH CAROLINA AT WILMINGTON  
CODE 49888 ITEM 301 ID#0089280301A



SHEET TITLE:

FIRST FLOOR PLAN - AREA TWO  
WEST

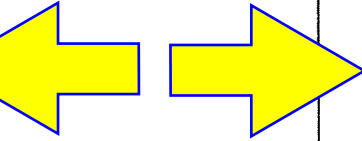


SHEET NO.:

LP2

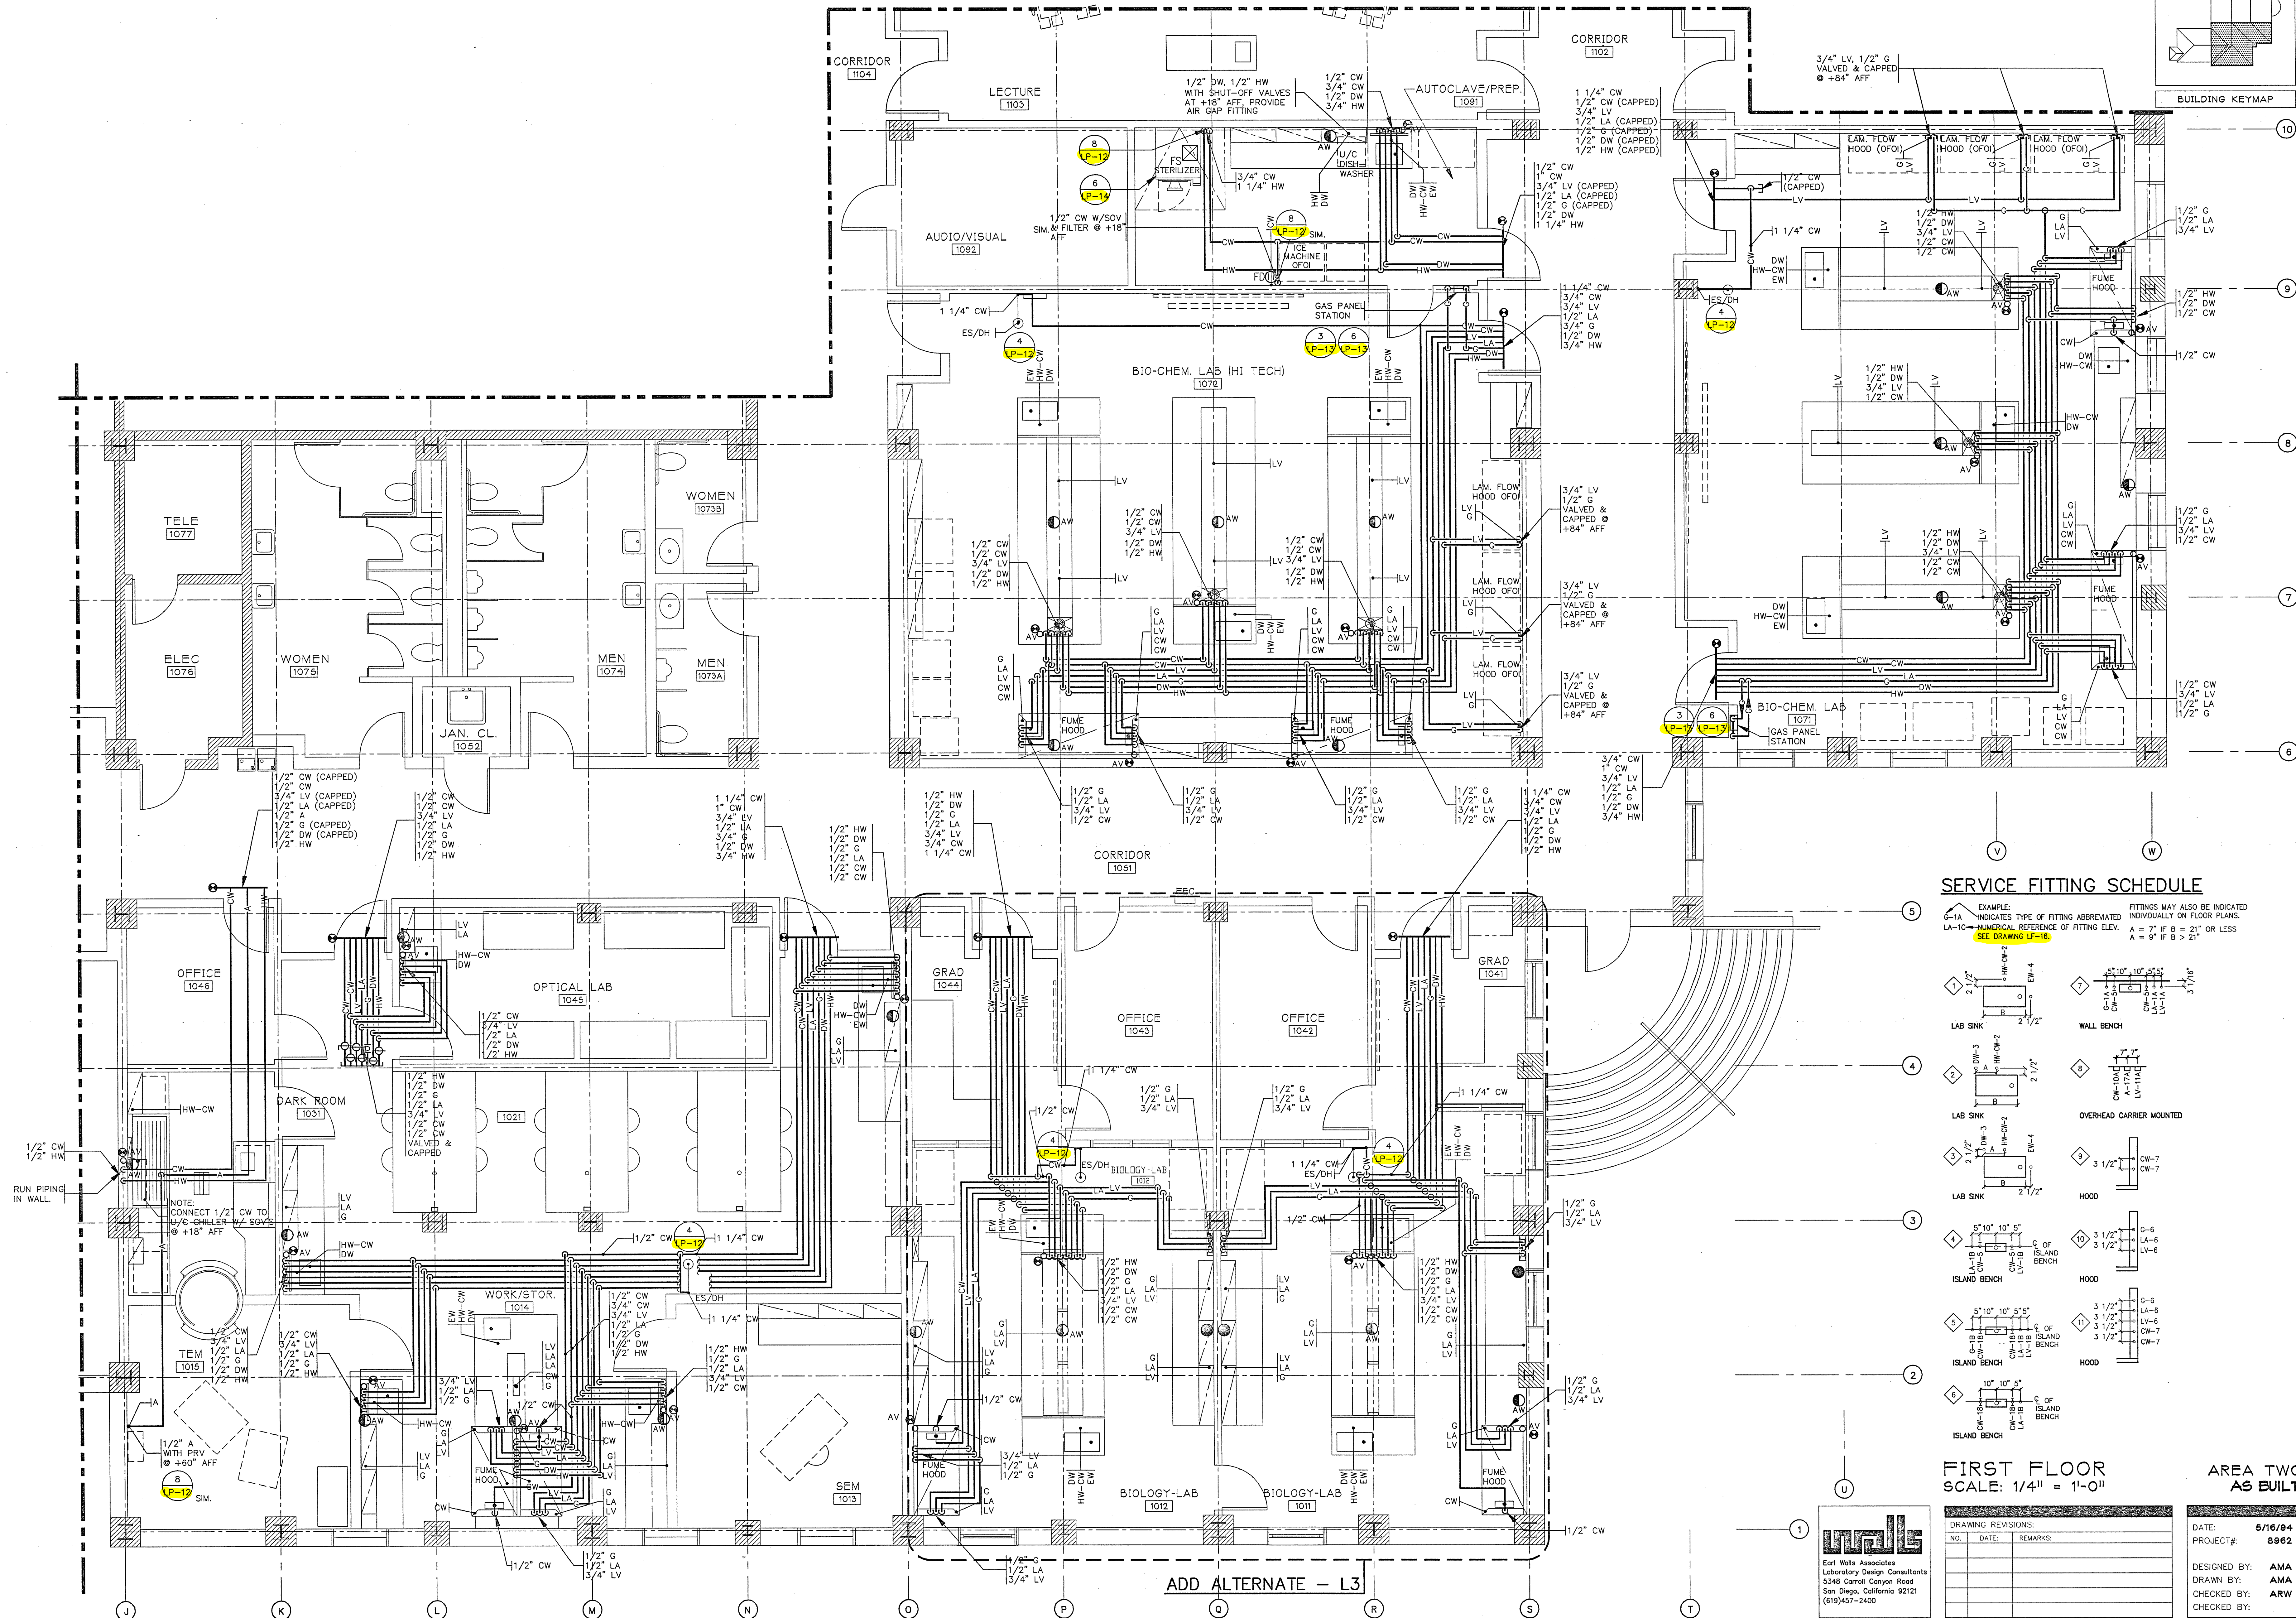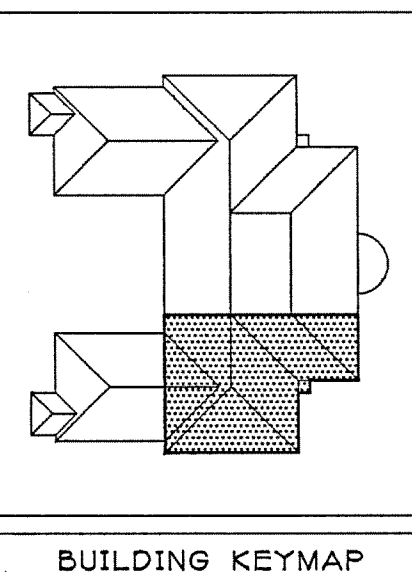

SERVICE FITTING SCHEDULE

EXAMPLE: INDICATES TYPE OF FITTING ABBREVIATED INDIVIDUALLY ON FLOOR PLANS.  
LA-10 = 10" ALUMINUM REFERENCE OF FITTING ELEV. A = 9" IF B > 21" OR LESS  
SEE DRAWING LF-16.

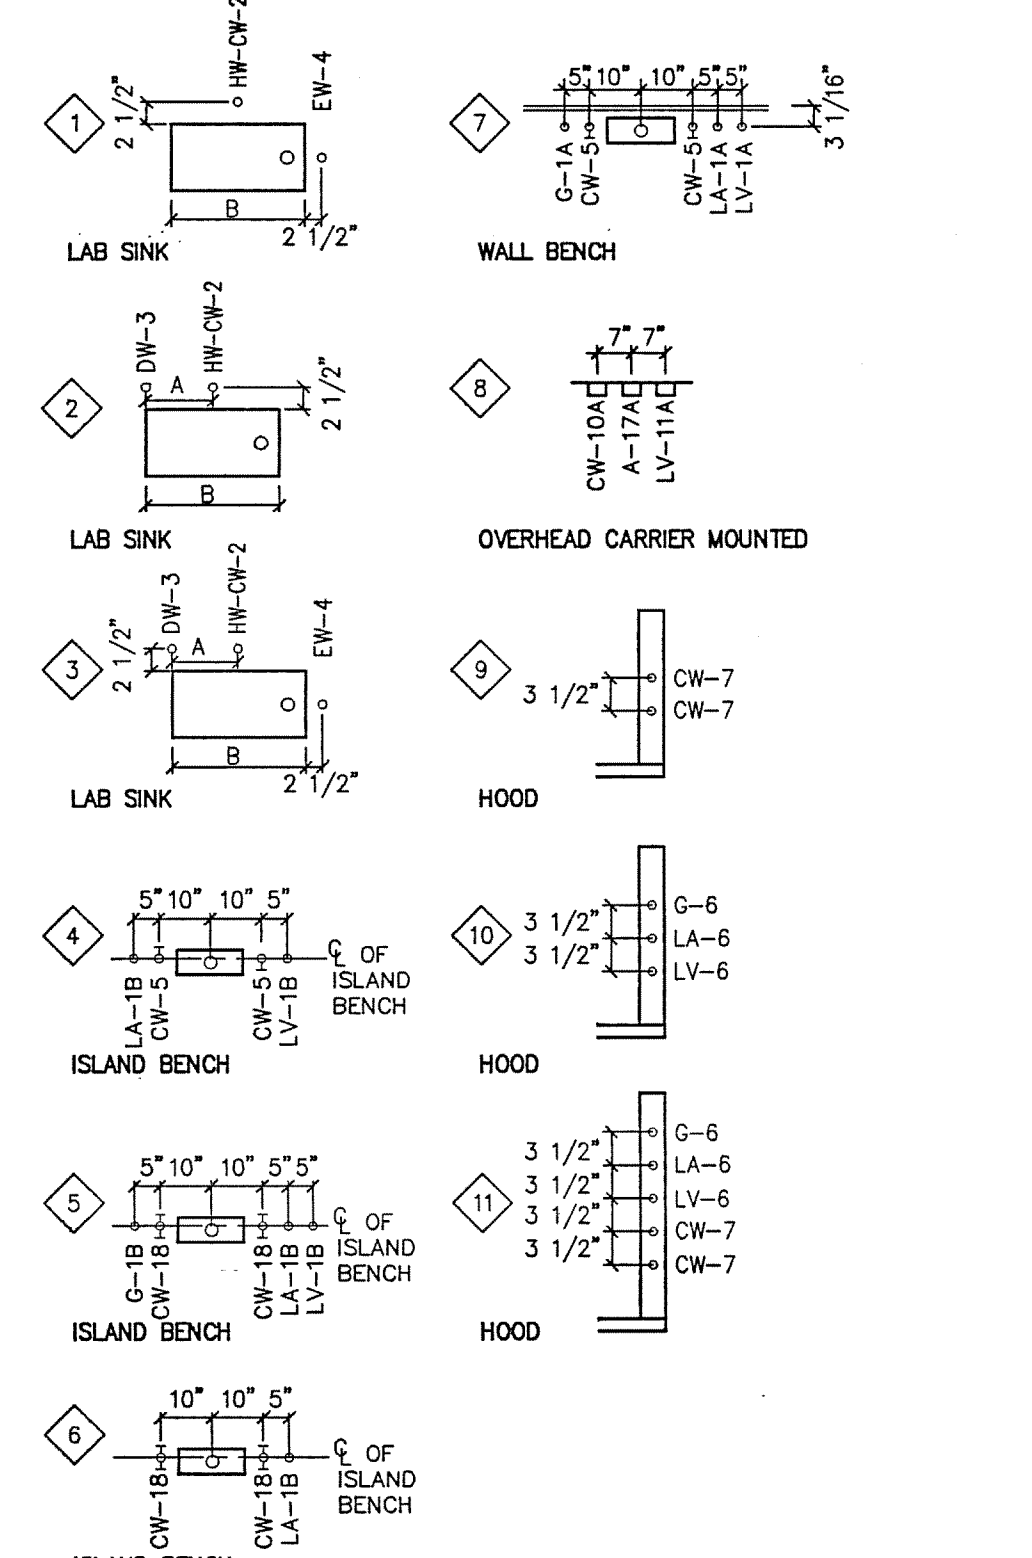

FIRST FLOOR  
SCALE: 1/4" = 1'-0"

AREA TWO  
AS BUILT

DRAWING REVISIONS:		
NO.	DATE	REMARKS

DATE: 5/16/94  
PROJECT#: 8862  
DESIGNED BY: AMA  
DRAWN BY: AMA  
CHECKED BY: ARW  
CHECKED BY:

Earl Walls Associates  
Laboratory Design Consultants  
5340 Cornell Canyon Road  
San Diego, California 92121  
(619)457-2400

ADD ALTERNATE - L3