


SERVICE FITTING SCHEDULE

EXAMPLE:
G-1A INDICATES TYPE OF FITTING ABBREVIATED
LA-1C NUMERICAL REFERENCE OF FITTING ELEV.
SEE DRAWING LP-10.

FITTINGS MAY ALSO BE INDICATED INDIVIDUALLY ON FLOOR PLANS.
A = 7" IF B = 21" OR LESS
A = 9" IF B > 21"

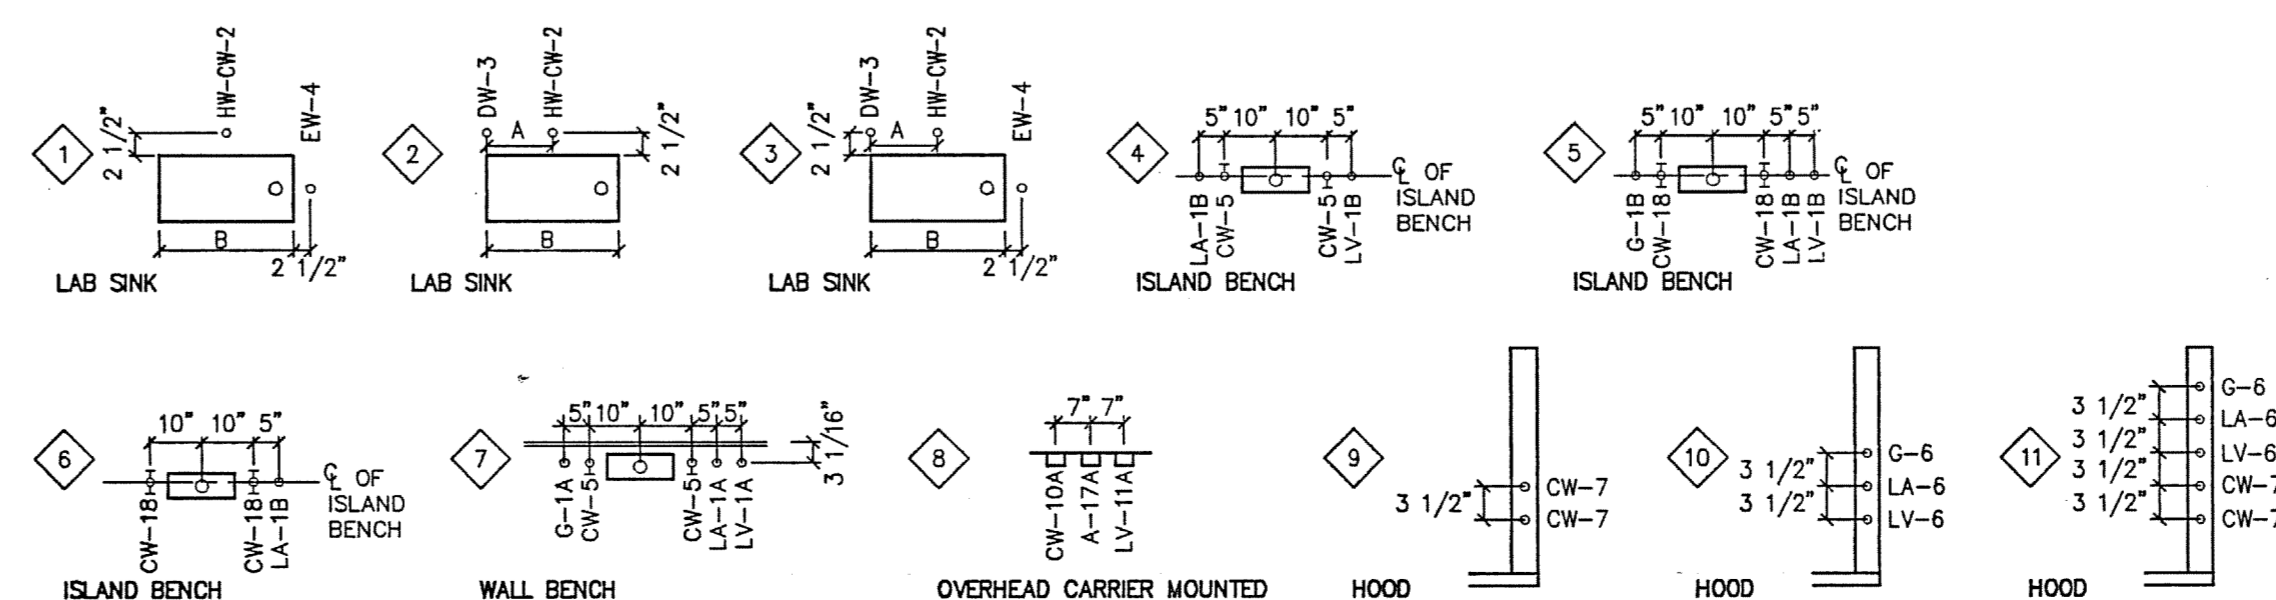


FIRST FLOOR
SCALE: 1/4" = 1'-0"

AREA THREE
AS BUILT


DRAWING REVISIONS:		
NO.	DATE	REMARKS

DATE: 5/16/94
PROJECT#: 8962
DESIGNED BY: AMA
DRAWN BY: AMA
CHECKED BY: ARW

SHEET NO.:
LP3

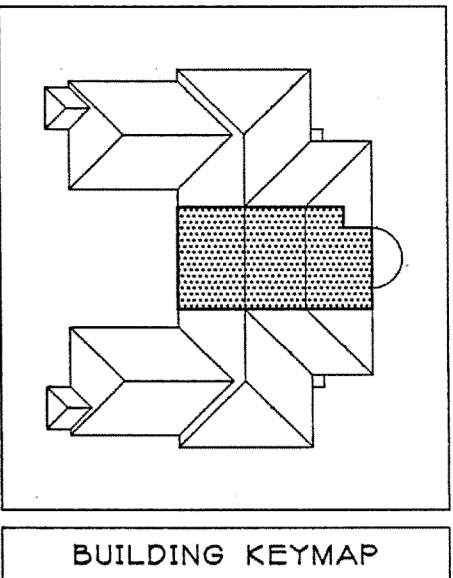

JEFFERIES AND FARIS
ASSOCIATES
ARCHITECTS • PLANNERS
SEA TOWERS, SUITE 201
2002 EASTWOOD ROAD
WILMINGTON, N.C. 28403
TEL: 910.256.6633
FAX: 910.256.9088

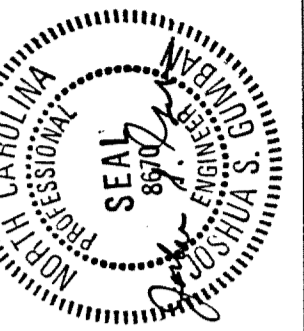

SCIENCE BUILDING
UNIVERSITY OF NORTH CAROLINA AT WILMINGTON
CODE 49308 ITEM 301 ID#6089280301A

SHEET TITLE:

FIRST FLOOR PLAN - AREA THREE
WEST

