


SCIENCE BUILDING
UNIVERSITY OF NORTH CAROLINA AT WILMINGTON
CODE 49308 ITEM 301 ID#6089290301A

SHEET TITLE:

FIRST FLOOR PLAN - AREA FOUR
EAST

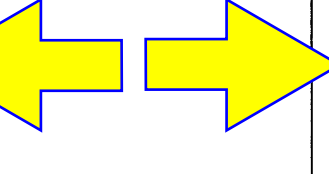


SHEET NO.:

LP4

SERVICE FITTING SCHEDULE

EXAMPLE:
G-1A - INDICATES TYPE OF FITTING ABBREVIATED INDIVIDUALLY ON FLOOR PLANS.
LA-10 - NUMERICAL REFERENCE OF FITTING ELEV. A = 7" IF B = 21" OR LESS
SEE DRAWING LF-16
FITTINGS MAY ALSO BE INDICATED
INDIVIDUALLY ON FLOOR PLANS.
A = 7" IF B = 21" OR LESS
A = 8" IF B > 21"

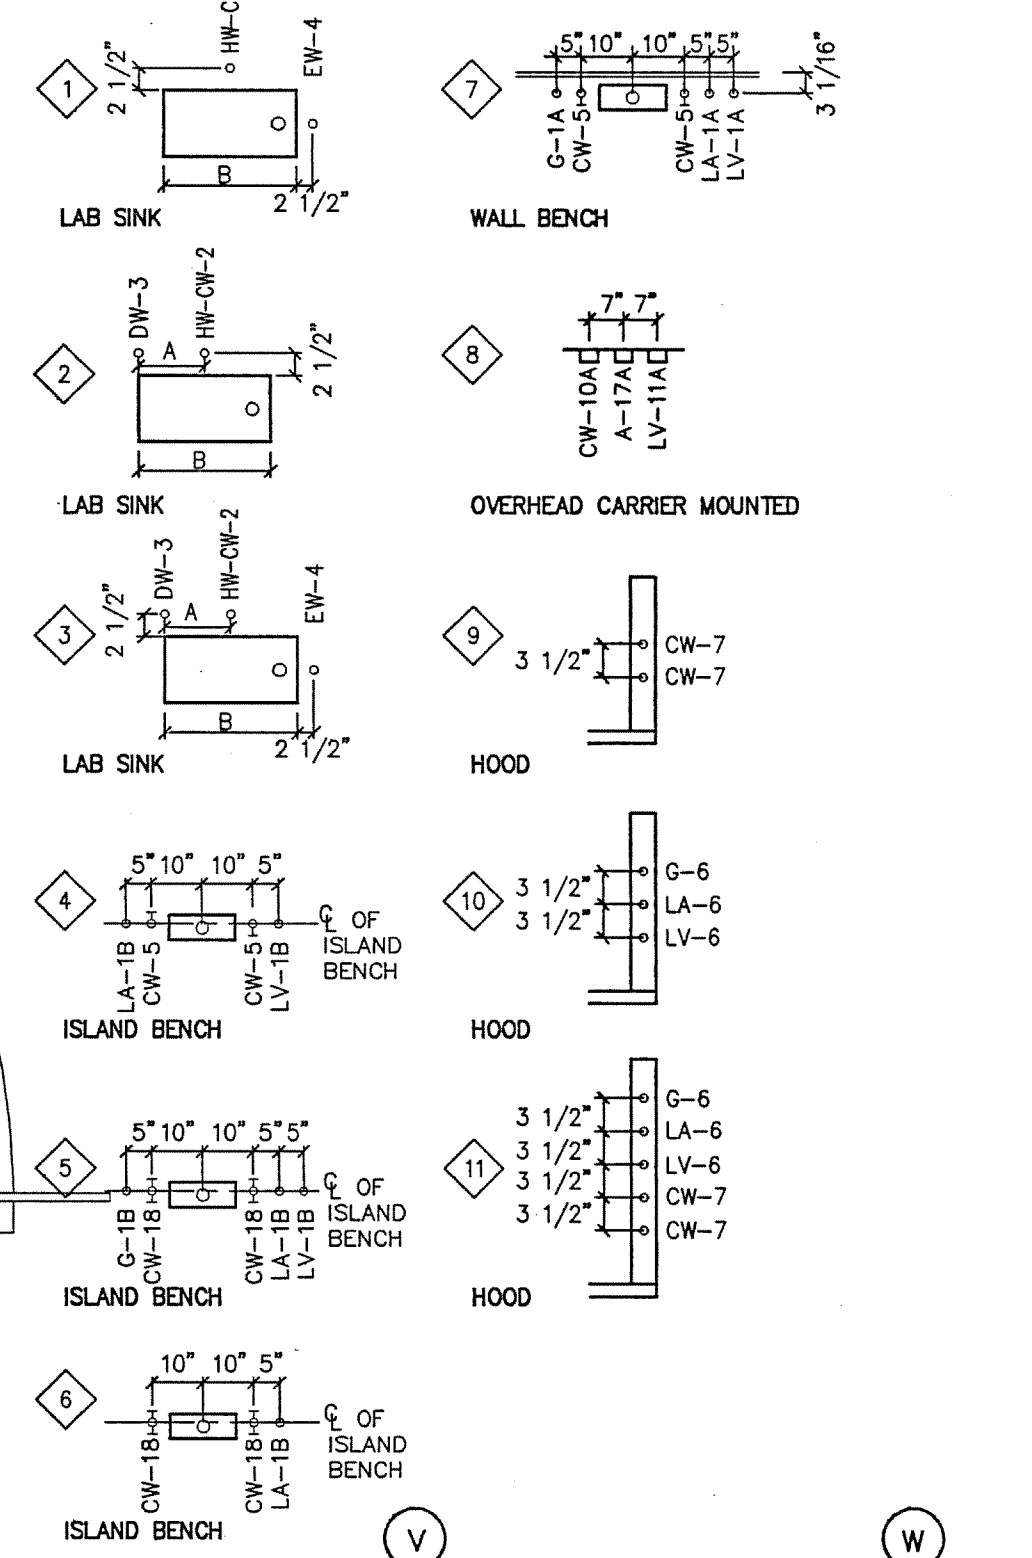

FIRST FLOOR
SCALE: 1/4" = 1'-0"

AREA FOUR
AS BUILT

DRAWING REVISIONS:		
NO.	DATE	REMARKS

DATE: 5/16/94
PROJECT#: 8962
DESIGNED BY: AMA
DRAWN BY: AMA
CHECKED BY: ARW

JEFFERIES AND FARIS ASSOCIATES
Laboratory Design Consultants
5348 Carroll Canyon Road
San Diego, California 92121
(619)457-2400

