

SCIENCE BUILDING
UNIVERSITY OF NORTH CAROLINA AT WILMINGTON
CODE 49388 ITEM 301 ID#60849280301A

SHEET TITLE:


SECOND FLOOR PLAN - AREA ONE
WEST

AREA ONE
AS BUILT

SHEET NO.:
LP6

ADD ALTERNATE - L5


ADD ALTERNATE - L7

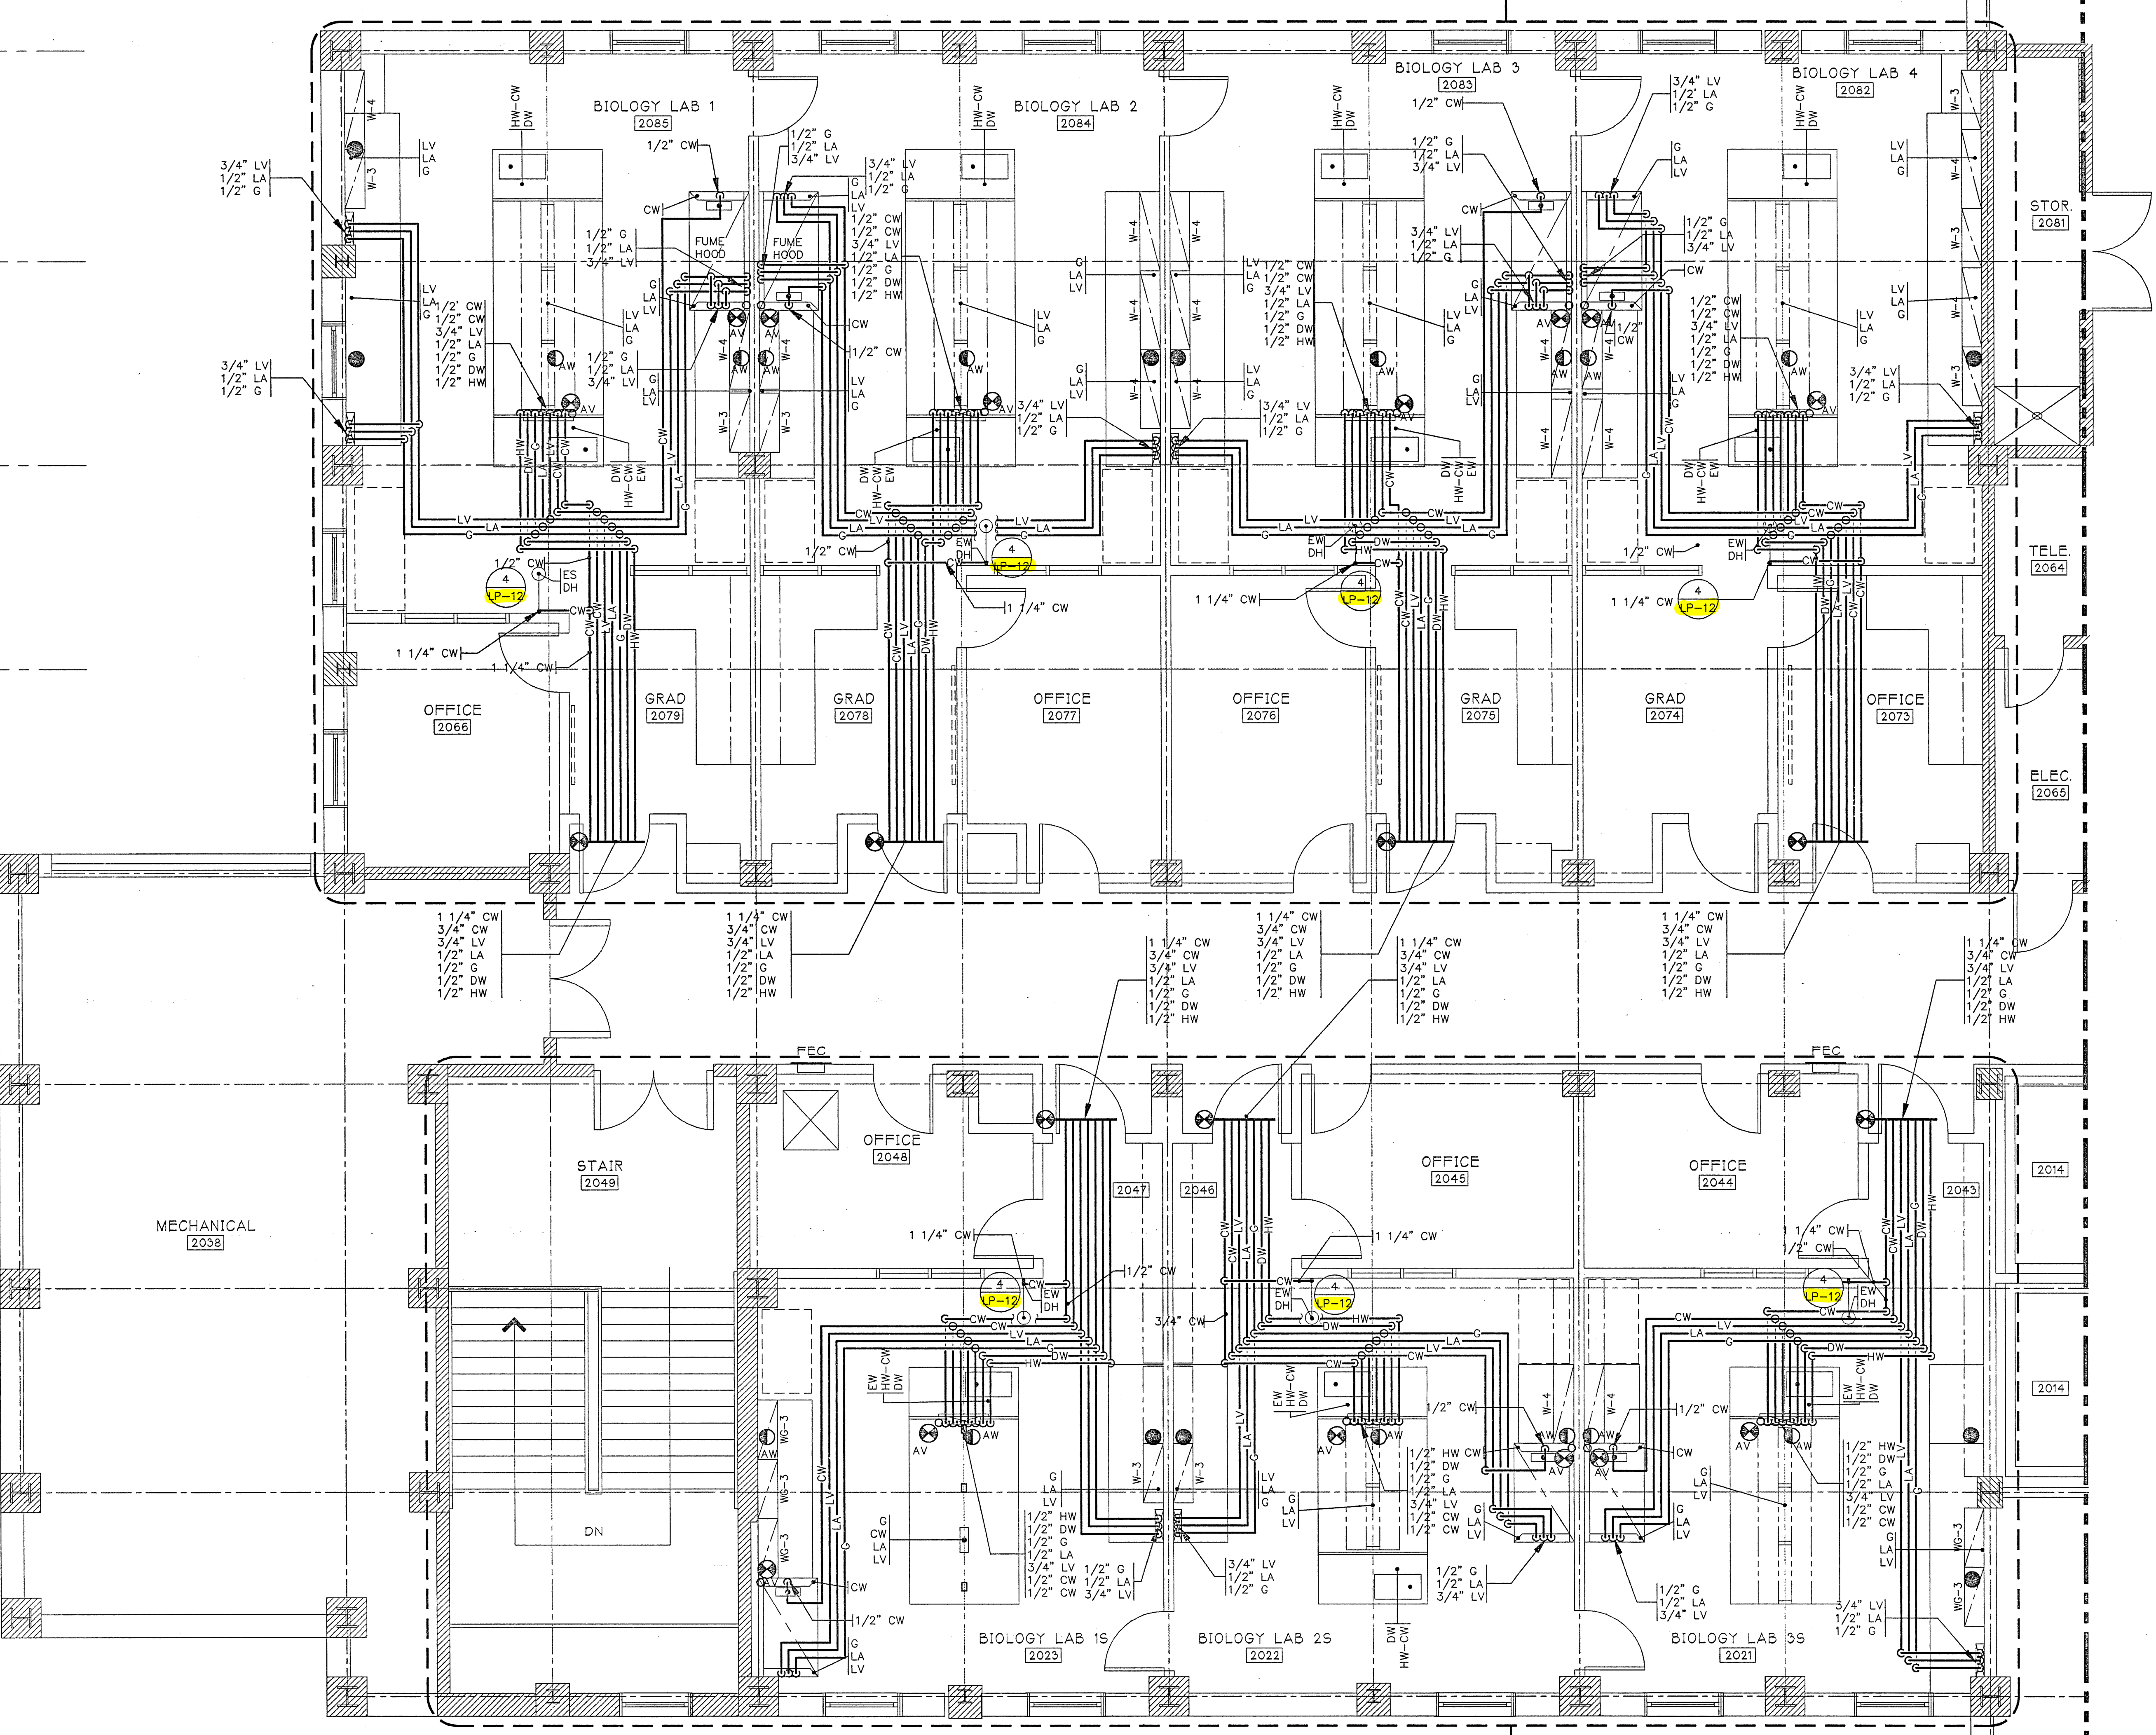

SERVICE FITTING SCHEDULE

EXAMPLES:
G-1A INDICATES TYPE OF FITTING ABBREVIATED INDIVIDUALLY ON FLOOR PLANS.
LA-10C NUMERICAL REFERENCE OF FITTING ELEV. SEE DRAWING LF-16.

FITTINGS MAY ALSO BE INDICATED
A = 7" IF B = 21" OR LESS
A = 9" IF B > 21"

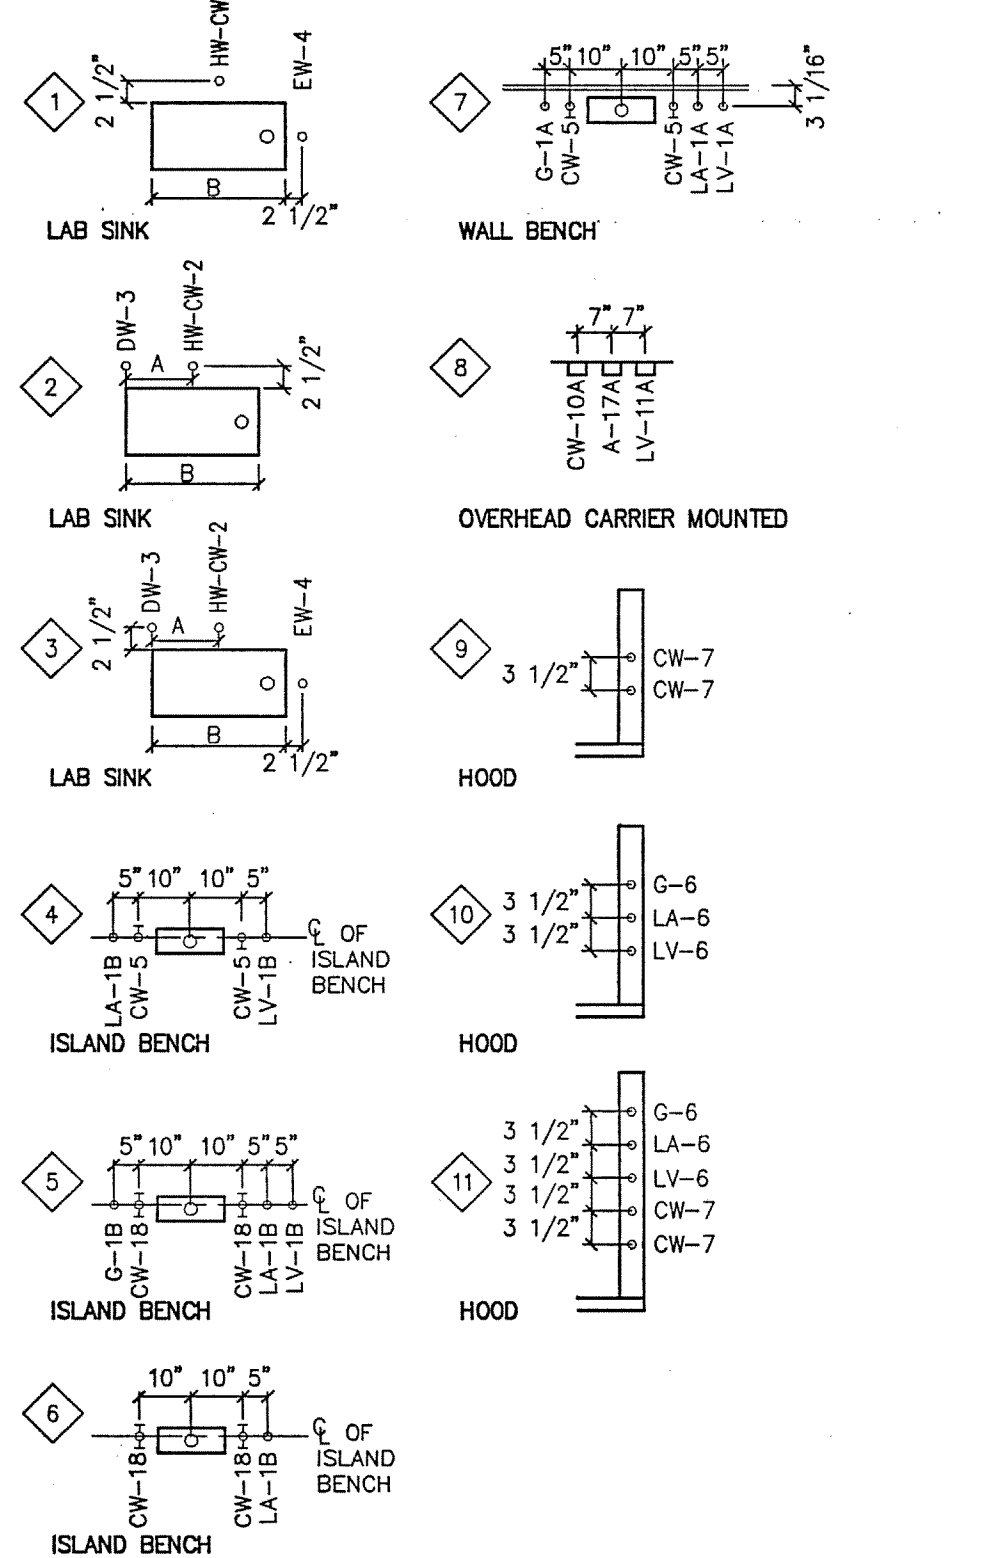

SECOND FLOOR
SCALE: 1/4" = 1'-0"

DRAWING REVISIONS:		
NO.	DATE	REMARKS

DATE: 5/16/94
PROJECT#: 8962
DESIGNED BY: AMA
DRAWN BY: AMA
CHECKED BY: ARW

mw
Earl Wells Associates
Laboratory Design Consultants
5348 Carroll Canyon Road
San Diego, California 92121
(619)457-2400