


	H4 01	SECOND FLOOR - WEST - HVAC
		FLOOR PLAN
		SCALE: 1/8" = 1'-0"

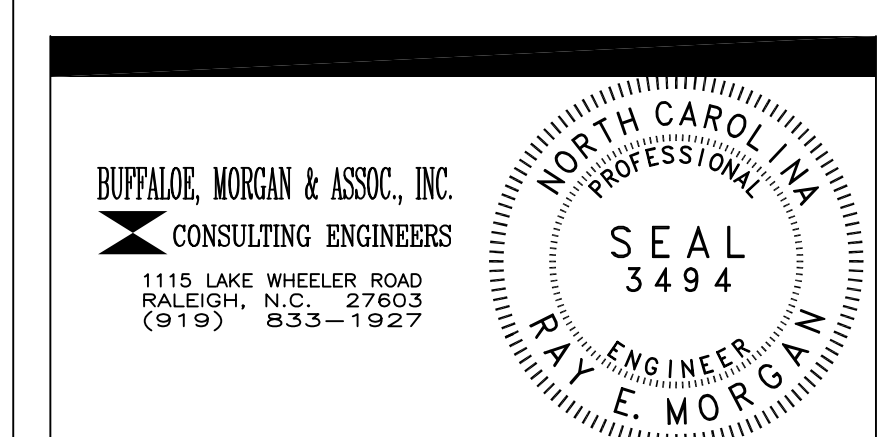

DRAWING REVISIONS:		
NO.	DATE:	REMARKS:

DATE: 16 MAY, 1994
PROJECT#: 9305
DESIGNED BY: .
DRAWN BY: DRD
CHECKED BY: REM
CHECKED BY: .