


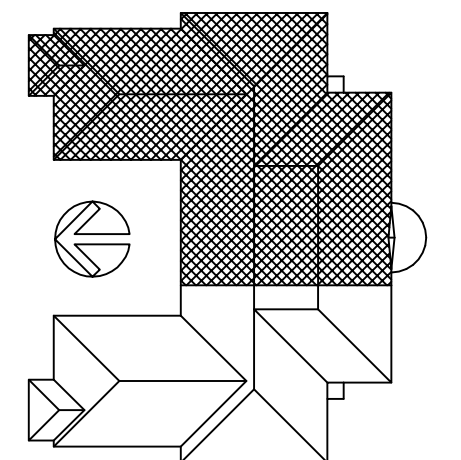


KEY PLAN



H5
01

SECOND FLOOR - EAST - HVAC
FLOOR PLAN
SCALE: 1/8" = 1'-0"

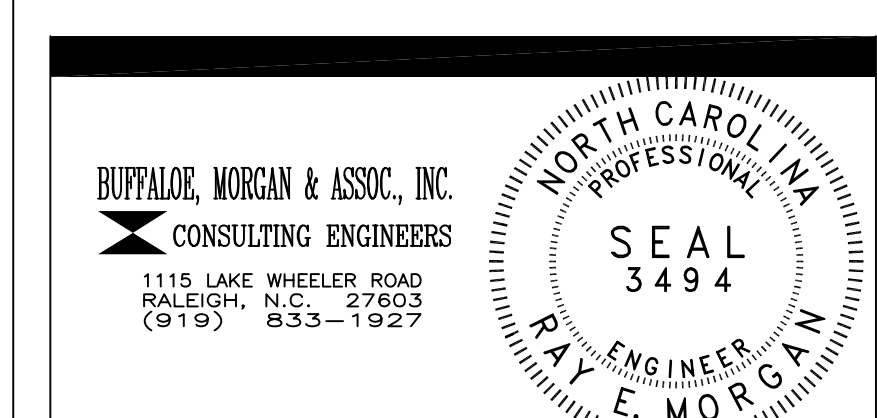

DRAWING REVISIONS:		
NO.	DATE	REMARKS

DATE: 16 MAY, 1994
PROJECT#: 9305
DESIGNED BY: WMP/NDM
DRAWN BY: NJC
CHECKED BY: REM