


**JEFFERIES AND FARIS
ASSOCIATES**
ARCHITECTS ■ PLANNERS

SEA TOWERS, SUITE 201
2002 EASTWOOD ROAD
WILMINGTON, N.C. 28403


TEL: 910.256.6633
FAX: 910.256.9088

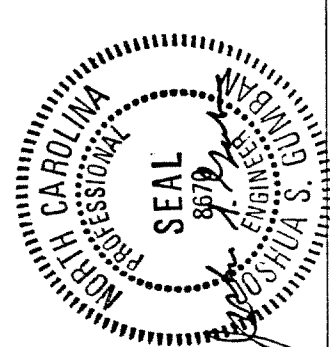

SCIENCE BUILDING
UNIVERSITY OF NORTH CAROLINA AT WILMINGTON
CODE 49388 ITEM 301 ID#6089290301A

SHEET TITLE:

FIRST FLOOR PLAN - AREA TWO
WEST

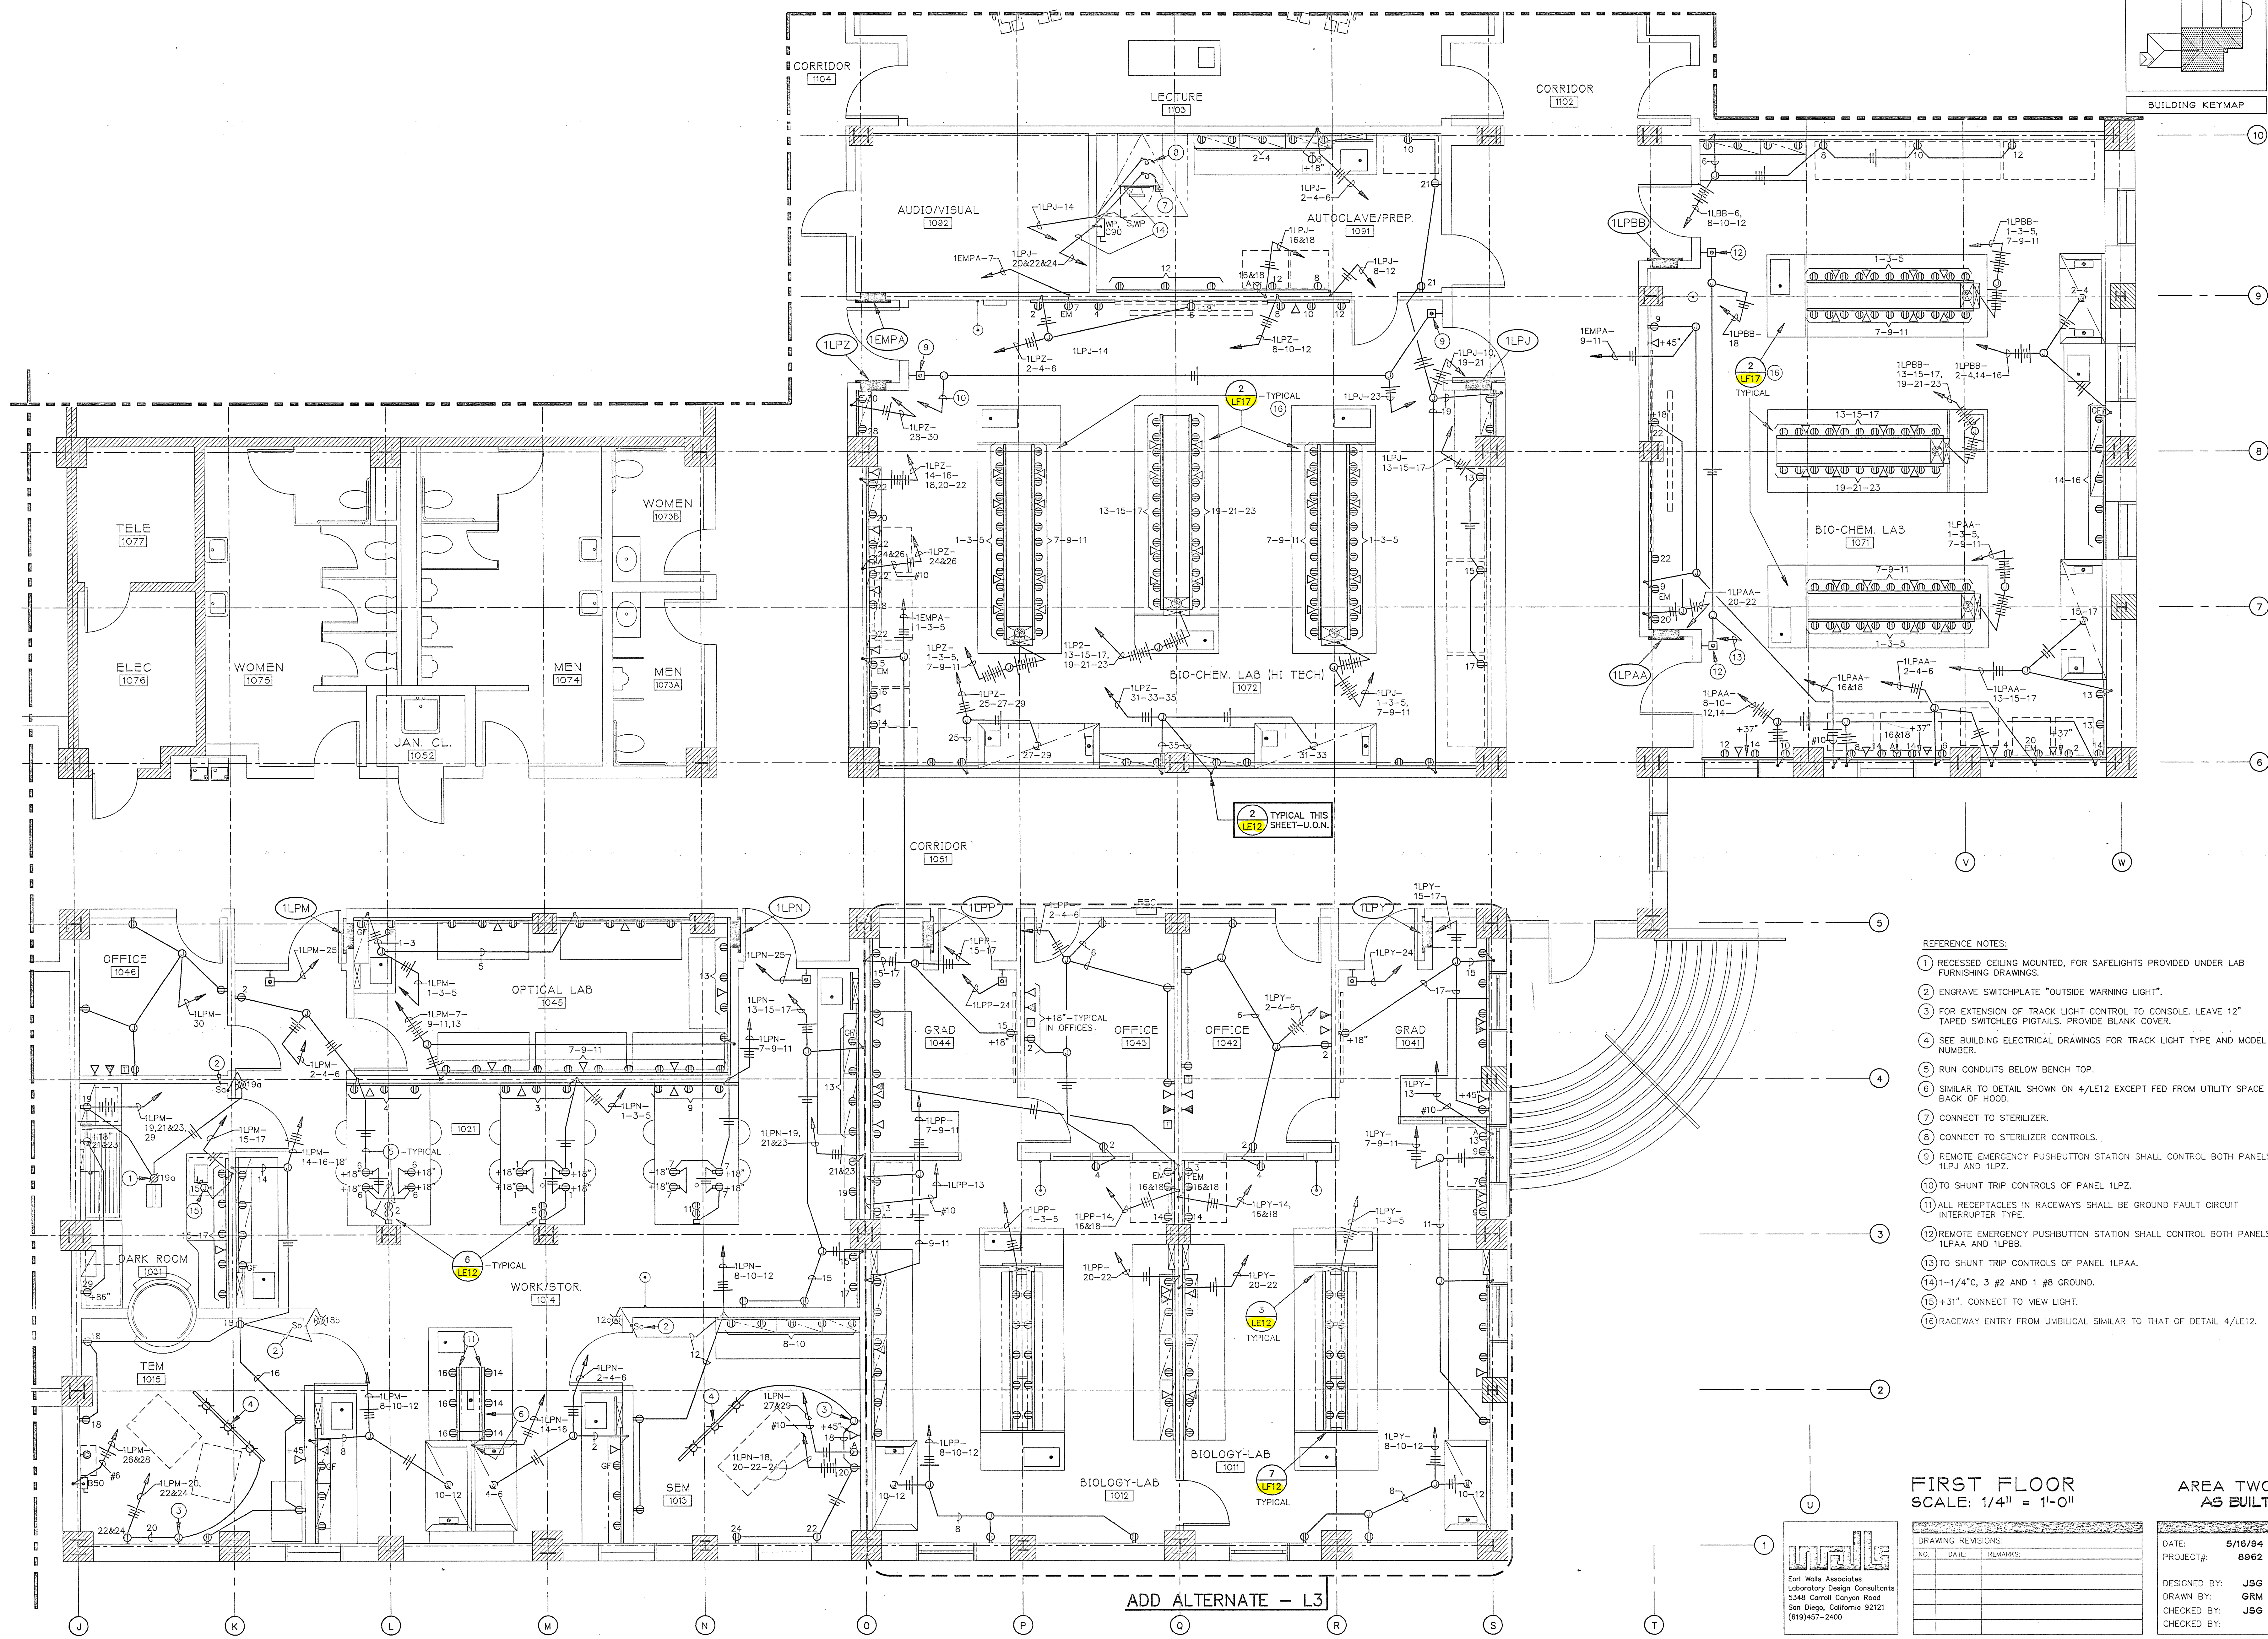

- ① RECESSED CEILING MOUNTED, FOR SAFELIGHTS PROVIDED UNDER LAB FURNISHING DRAWINGS.
- ② ENGRAVE SWITCHPLATE "OUTSIDE WARNING LIGHT".
- ③ FOR EXTENSION OF TRACK LIGHT CONTROL TO CONSOLE. LEAVE 12" TAPED SWITCHLEG PIGTAILS. PROVIDE BLANK COVER.
- ④ SEE BUILDING ELECTRICAL DRAWINGS FOR TRACK LIGHT TYPE AND MODEL NUMBER.
- ⑤ RUN CONDUITS UNDER BENCH TOP.
- ⑥ SIMILAR TO DETAIL SHOWN ON 4/LE12 EXCEPT FED FROM UTILITY SPACE BACK OF HOOD.
- ⑦ CONNECT TO STERILIZER.
- ⑧ CONNECT TO STERILIZER CONTROLS.
- ⑨ REMOTE EMERGENCY PUSHBUTTON STATION SHALL CONTROL BOTH PANELS 1LPJ AND 1LPZ.
- ⑩ TO SHUNT TRIP CONTROLS OF PANEL 1LPZ.
- ⑪ ALL RECEPTACLES IN RACEWAYS SHALL BE GROUND FAULT CIRCUIT INTERRUPTER TYPE.
- ⑫ REMOTE EMERGENCY PUSHBUTTON STATION SHALL CONTROL BOTH PANELS 1LPA4 AND 1LPB4.
- ⑬ TO SHUNT TRIP CONTROLS OF PANEL 1LPA4.
- ⑭ 1-1/4" C. 3 #2 AND 1 #8 GROUND.
- ⑮ +31". CONNECT TO VENT LIGHT.
- ⑯ RACEWAY ENTRY FROM UMBILICAL SIMILAR TO THAT OF DETAIL 4/LE12.

FIRST FLOOR
SCALE: 1/4" = 1'-0"

DRAWING REVISIONS:		
NO.	DATE:	REMARKS:

AREA TWO
AS BUILT

DATE:	5/16/94
PROJECT#:	8962
DESIGNED BY:	JSG
DRAWN BY:	GRM
CHECKED BY:	JSG
CHECKED BY:	

SHEET NO.:

LE2