



- REFERENCE NOTES:
- 1 ALL RECEPTACLES IN PEDESTALS ABOVE TABLES SHALL BE GROUND FAULT CIRCUIT INTERRUPTER (GFCI) TYPE.
 - 2 RUN CONDUITS BELOW BENCH TOP.
 - 3 CONNECT TO GLASSWARE WASHER.
 - 4 TO PANEL 1EMPA LOCATED IN CORRIDOR 1104, SEE SHEET LE02.
 - 5 J-BOX AT +6" TO TOP.
 - 6 UNDER BENCH TOP.
 - 7 1/4" C.O. TO NEARBY TELCO/DATA CLOSET.
 - 8 ENGRAVE SWITCHPLATE "DISPOSER".
 - 9 +24". CONNECT TO 1/2" HP, 120V DISPOSER.

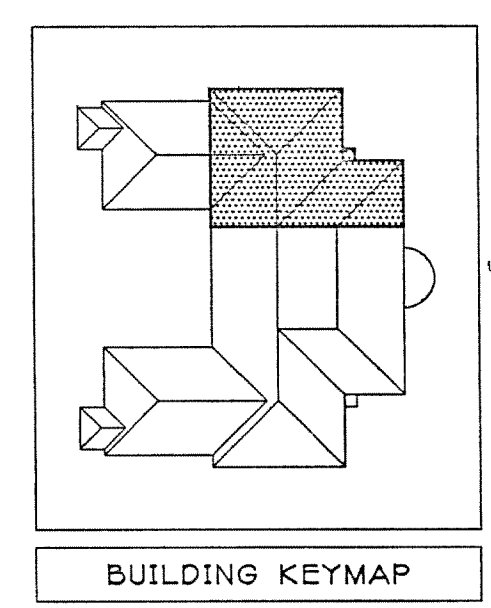

JEFFERIES AND FARIS
ASSOCIATES
ARCHITECTS • PLANNERS
SEA TOWERS, SUITE 201
2002 EASTWOOD ROAD
WILMINGTON, N.C. 28403
TEL: 910.256.6633
FAX: 910.256.9088

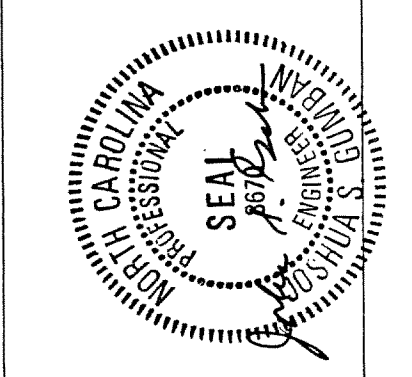

SCIENCE BUILDING
UNIVERSITY OF NORTH CAROLINA AT WILMINGTON
CODE 44388 ITEM 301 ID#60812B0301A

SHEET TITLE:

FIRST FLOOR PLAN - AREA FOUR
WEST EAST

FIRST FLOOR
SCALE: 1/4" = 1'-0"

AREA FOUR
AS BUILT

inall
Earl Walls Associates
Laboratory Design Consultants
5348 Carroll Canyon Road
San Diego, California 92121
(619)457-2400

DRAWING REVISIONS:	
NO.	REMARKS

DATE: 5/16/94
PROJECT#: 8962
DESIGNED BY: JSG
DRAWN BY: GRM
CHECKED BY: JSG

SHEET NO.:
LE4