


SCIENCE BUILDING
UNIVERSITY OF NORTH CAROLINA AT WILMINGTON
CODE 44300 ITEM 301 ID#6089280301A

SHEET TITLE:

FIRST FLOOR PLAN - AREA FIVE
EAST

SHEET NO.:

LE5

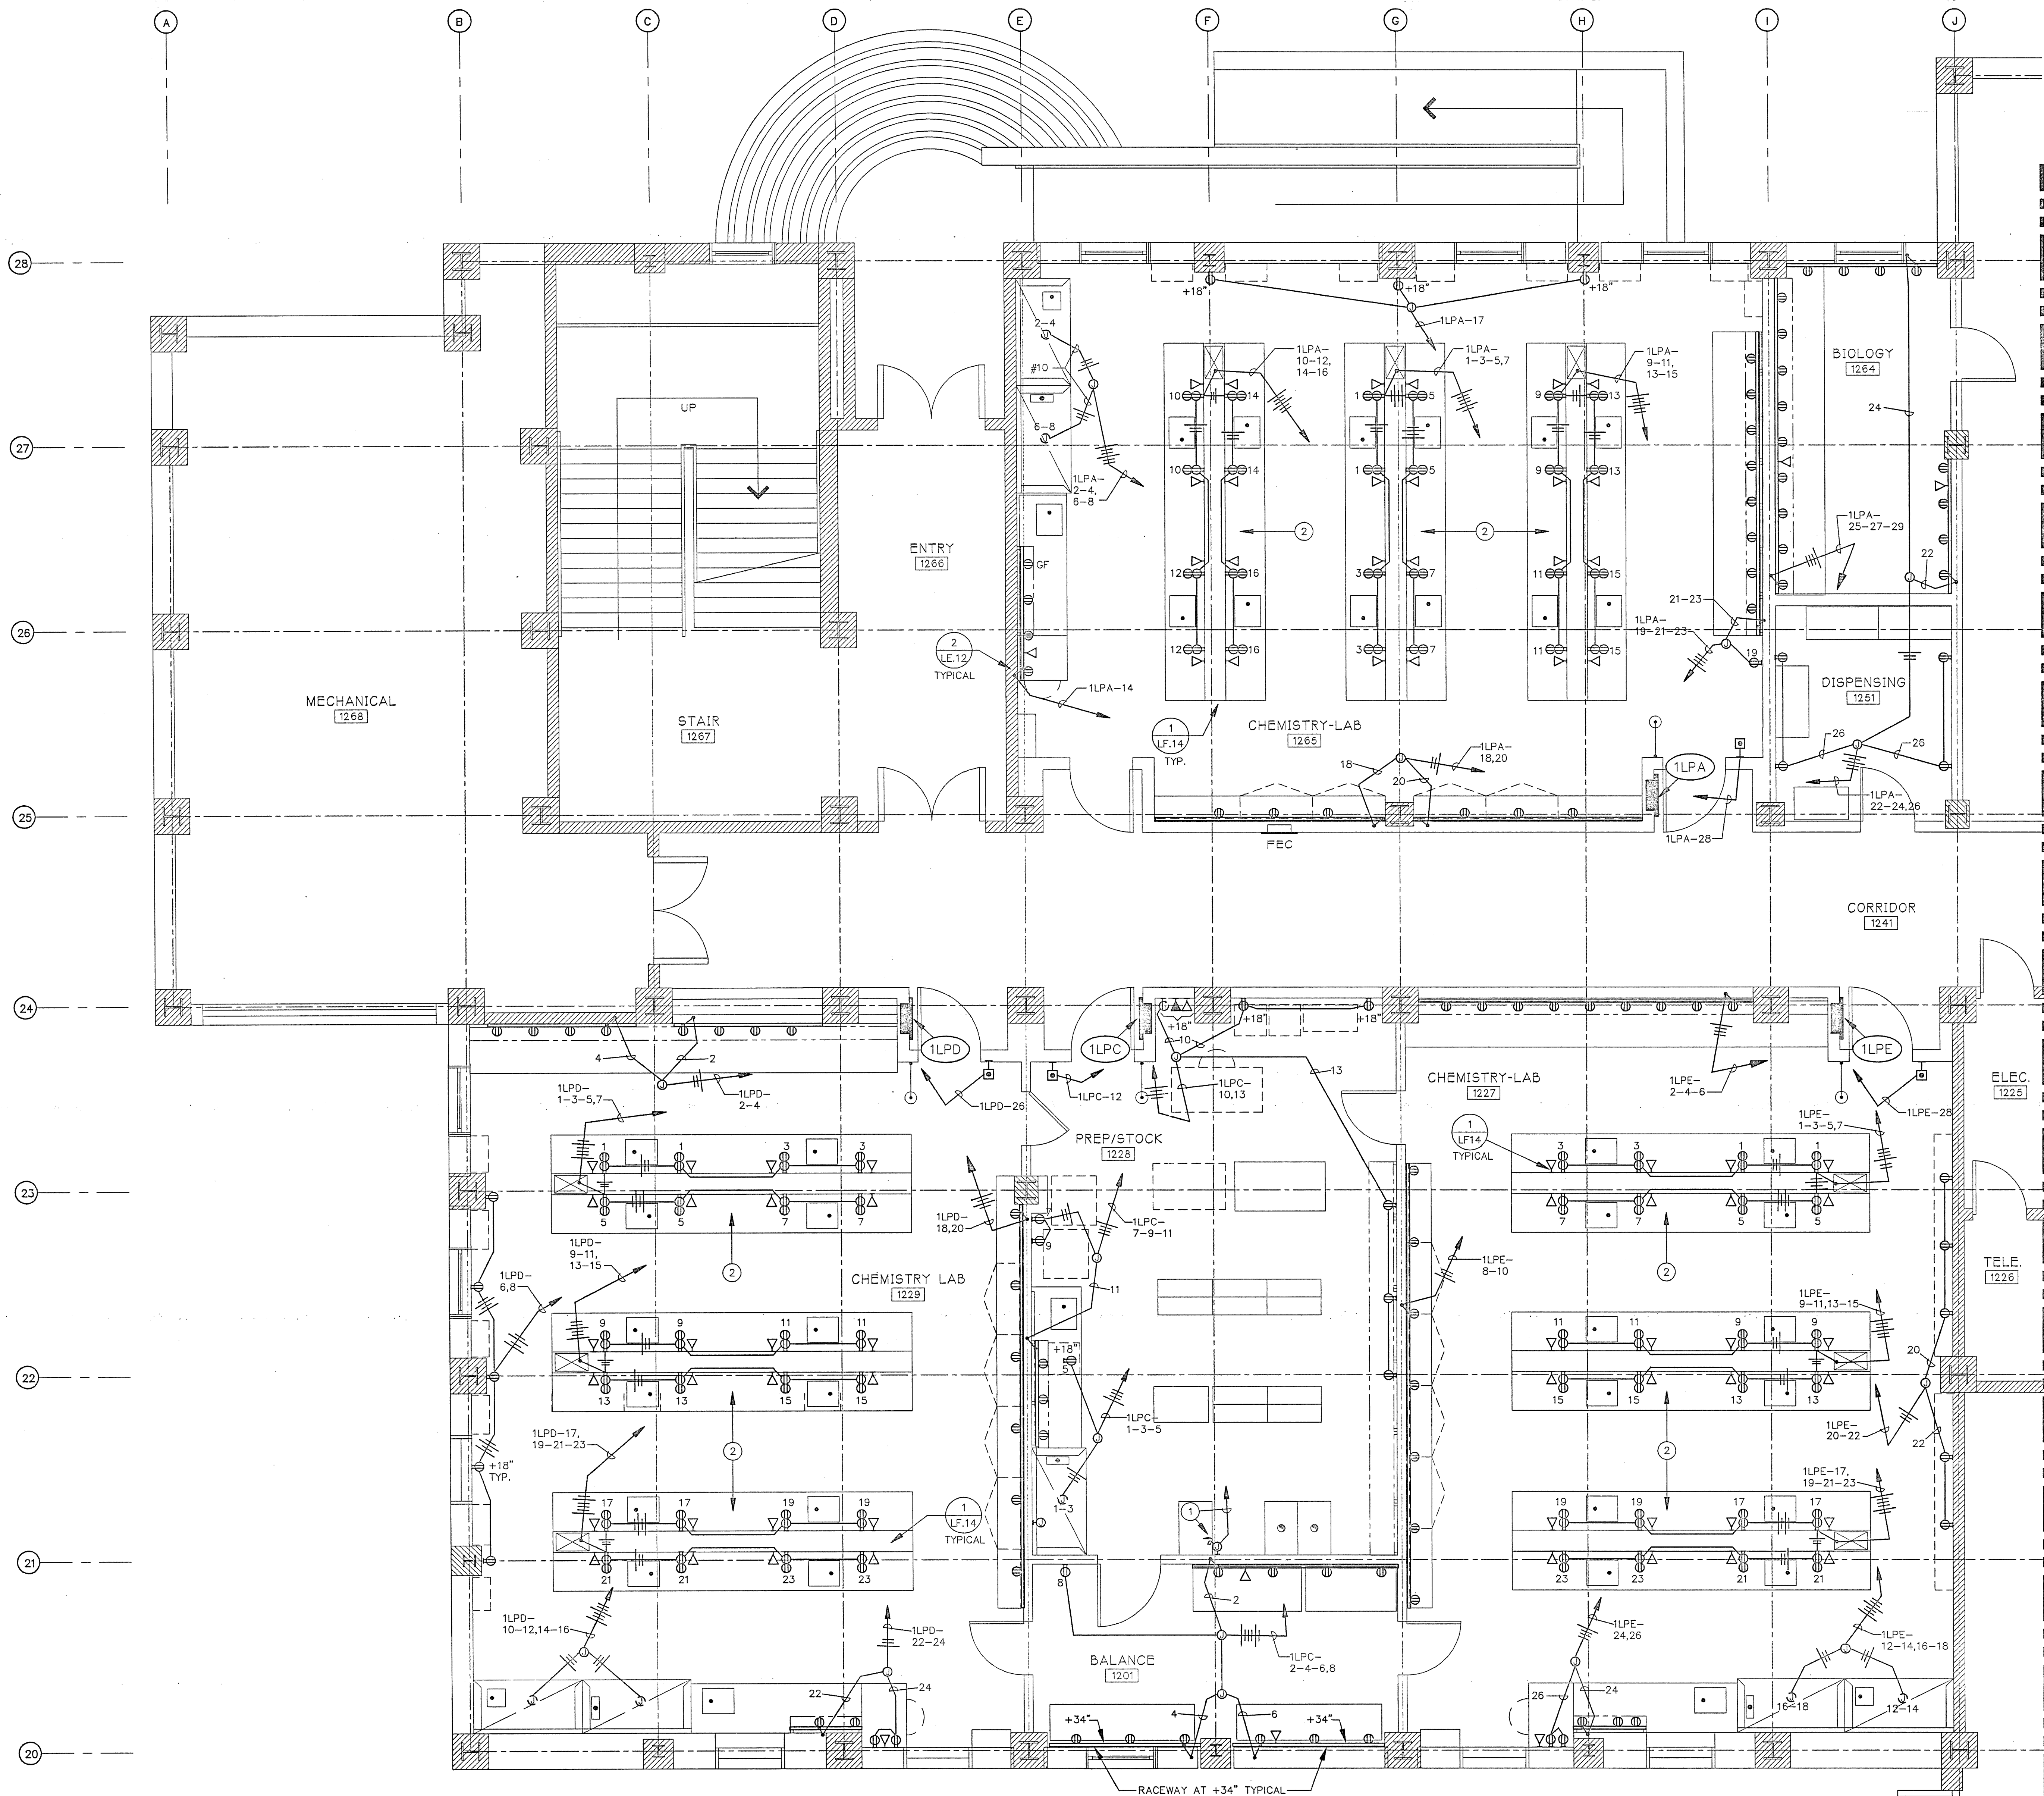

- REFERENCE NOTES:
- 3/4" C. 1 #10 TO GROUND BUS OF PANEL 1LPC. GROUND OSHA CABINET.
 - ALL DUPLEX RECEPTACLES IN THESE ISLAND BENCHES SHALL BE GROUND FAULT CIRCUIT INTERRUPTER (GFCI) TYPE.

FIRST FLOOR
SCALE: 1/4" = 1'-0"

AREA FIVE
AS BUILT

Earl Walls Associates
Laboratory Design Consultants
5348 Carroll Canyon Road
San Diego, California 92121
(619)457-2400

DRAWING REVISIONS:		
NO.	DATE	REMARKS

DATE: 5/16/94
PROJECT#: 8962
DESIGNED BY: JSG
DRAWN BY: MS
CHECKED BY: JSG