


JEFFERIES AND FARIS
ASSOCIATES
ARCHITECTS ■ PLANNERS
SEA TOWERS, SUITE 201
2002 EASTWOOD ROAD
WILMINGTON, N.C. 28403
TEL: 910.256.6633
FAX: 910.256.9088

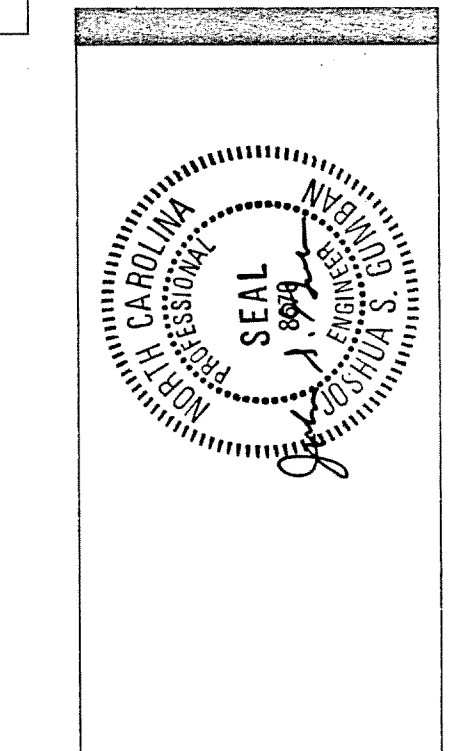

SCIENCE BUILDING
UNIVERSITY OF NORTH CAROLINA AT WILMINGTON
CODE 44988 ITEM 301 ID#6089280301A

SHEET TITLE:

SECOND FLOOR PLAN - AREA THREE
WEST

REFERENCE NOTES:

- (1) ALL RECEPTACLES, TELCO/DATA AND TV OUTLETS IN OFFICES SHALL BE AT +18".
- (2) 3/4" C, 3 #10, 2 #12 & 1 #10 GROUND.
- (3) TO SHUNT TRIP MAIN CIRCUIT BREAKER OF RESPECTIVE PANEL.
- (4) EITHER OF THE TWO EMERGENCY OFF PUSHBUTTONS SHALL DE-ENERGIZE BOTH RESPECTIVE POWER PANELS.
- (5) 1-1/2"C, 1 #10 TO GROUND BUS OF INDICATED PANEL.
- (6) CONNECT TO OSHA CABINET.
- (7) +18. MAKE CONNECTION TO VACUUM PUMP RECEPTACLE IN CABINET BELOW. SEE LAB FURNISHINGS DRAWING.
- (8) ALL RECEPTACLES IN THESE ISLAND BENCHES SHALL BE GROUND FAULT CIRCUIT INTERRUPTER (GFCI) TYPE.
- (9) EITHER OF THE 2 EMERGENCY OFF PUSHBUTTONS SHALL DE-ENERGIZE PANEL 2LPKK.
- (10) J.BOX AT +6" TO TOP.
- (11) UNDER BENCH TOP.
- (12) 1-1/4"C.O. TO NEARBY TELCO/DATA CLOSET. SEE CATEGORY "E" BUILDING ELECTRICAL DRAWINGS.

SECOND FLOOR
SCALE: 1/4" = 1'-0"

AREA THREE
AS BUILT

Earl Wells Associates
Laboratory Design Consultants
5348 Carroll Canyon Road
San Diego, California 92121
(619)457-2400

DRAWING REVISIONS:		
NO.	DATE	REMARKS

DATE: 5/16/94
PROJECT#: 8962
DESIGNED BY: JSG
DRAWN BY: GRM
CHECKED BY: JSG

SHEET NO.:
LE8