


Revisions	
No.	Date

Project Number	Date
0732.DOBO	Feb 08
Drawn	Checked
RSG	BBW

Scale
As Noted
Drawing Title
**EXISTING & NEW
FLOOR PLAN -
LIGHTING**


Sheet Number
9 of 10
Drawing Number

E-103

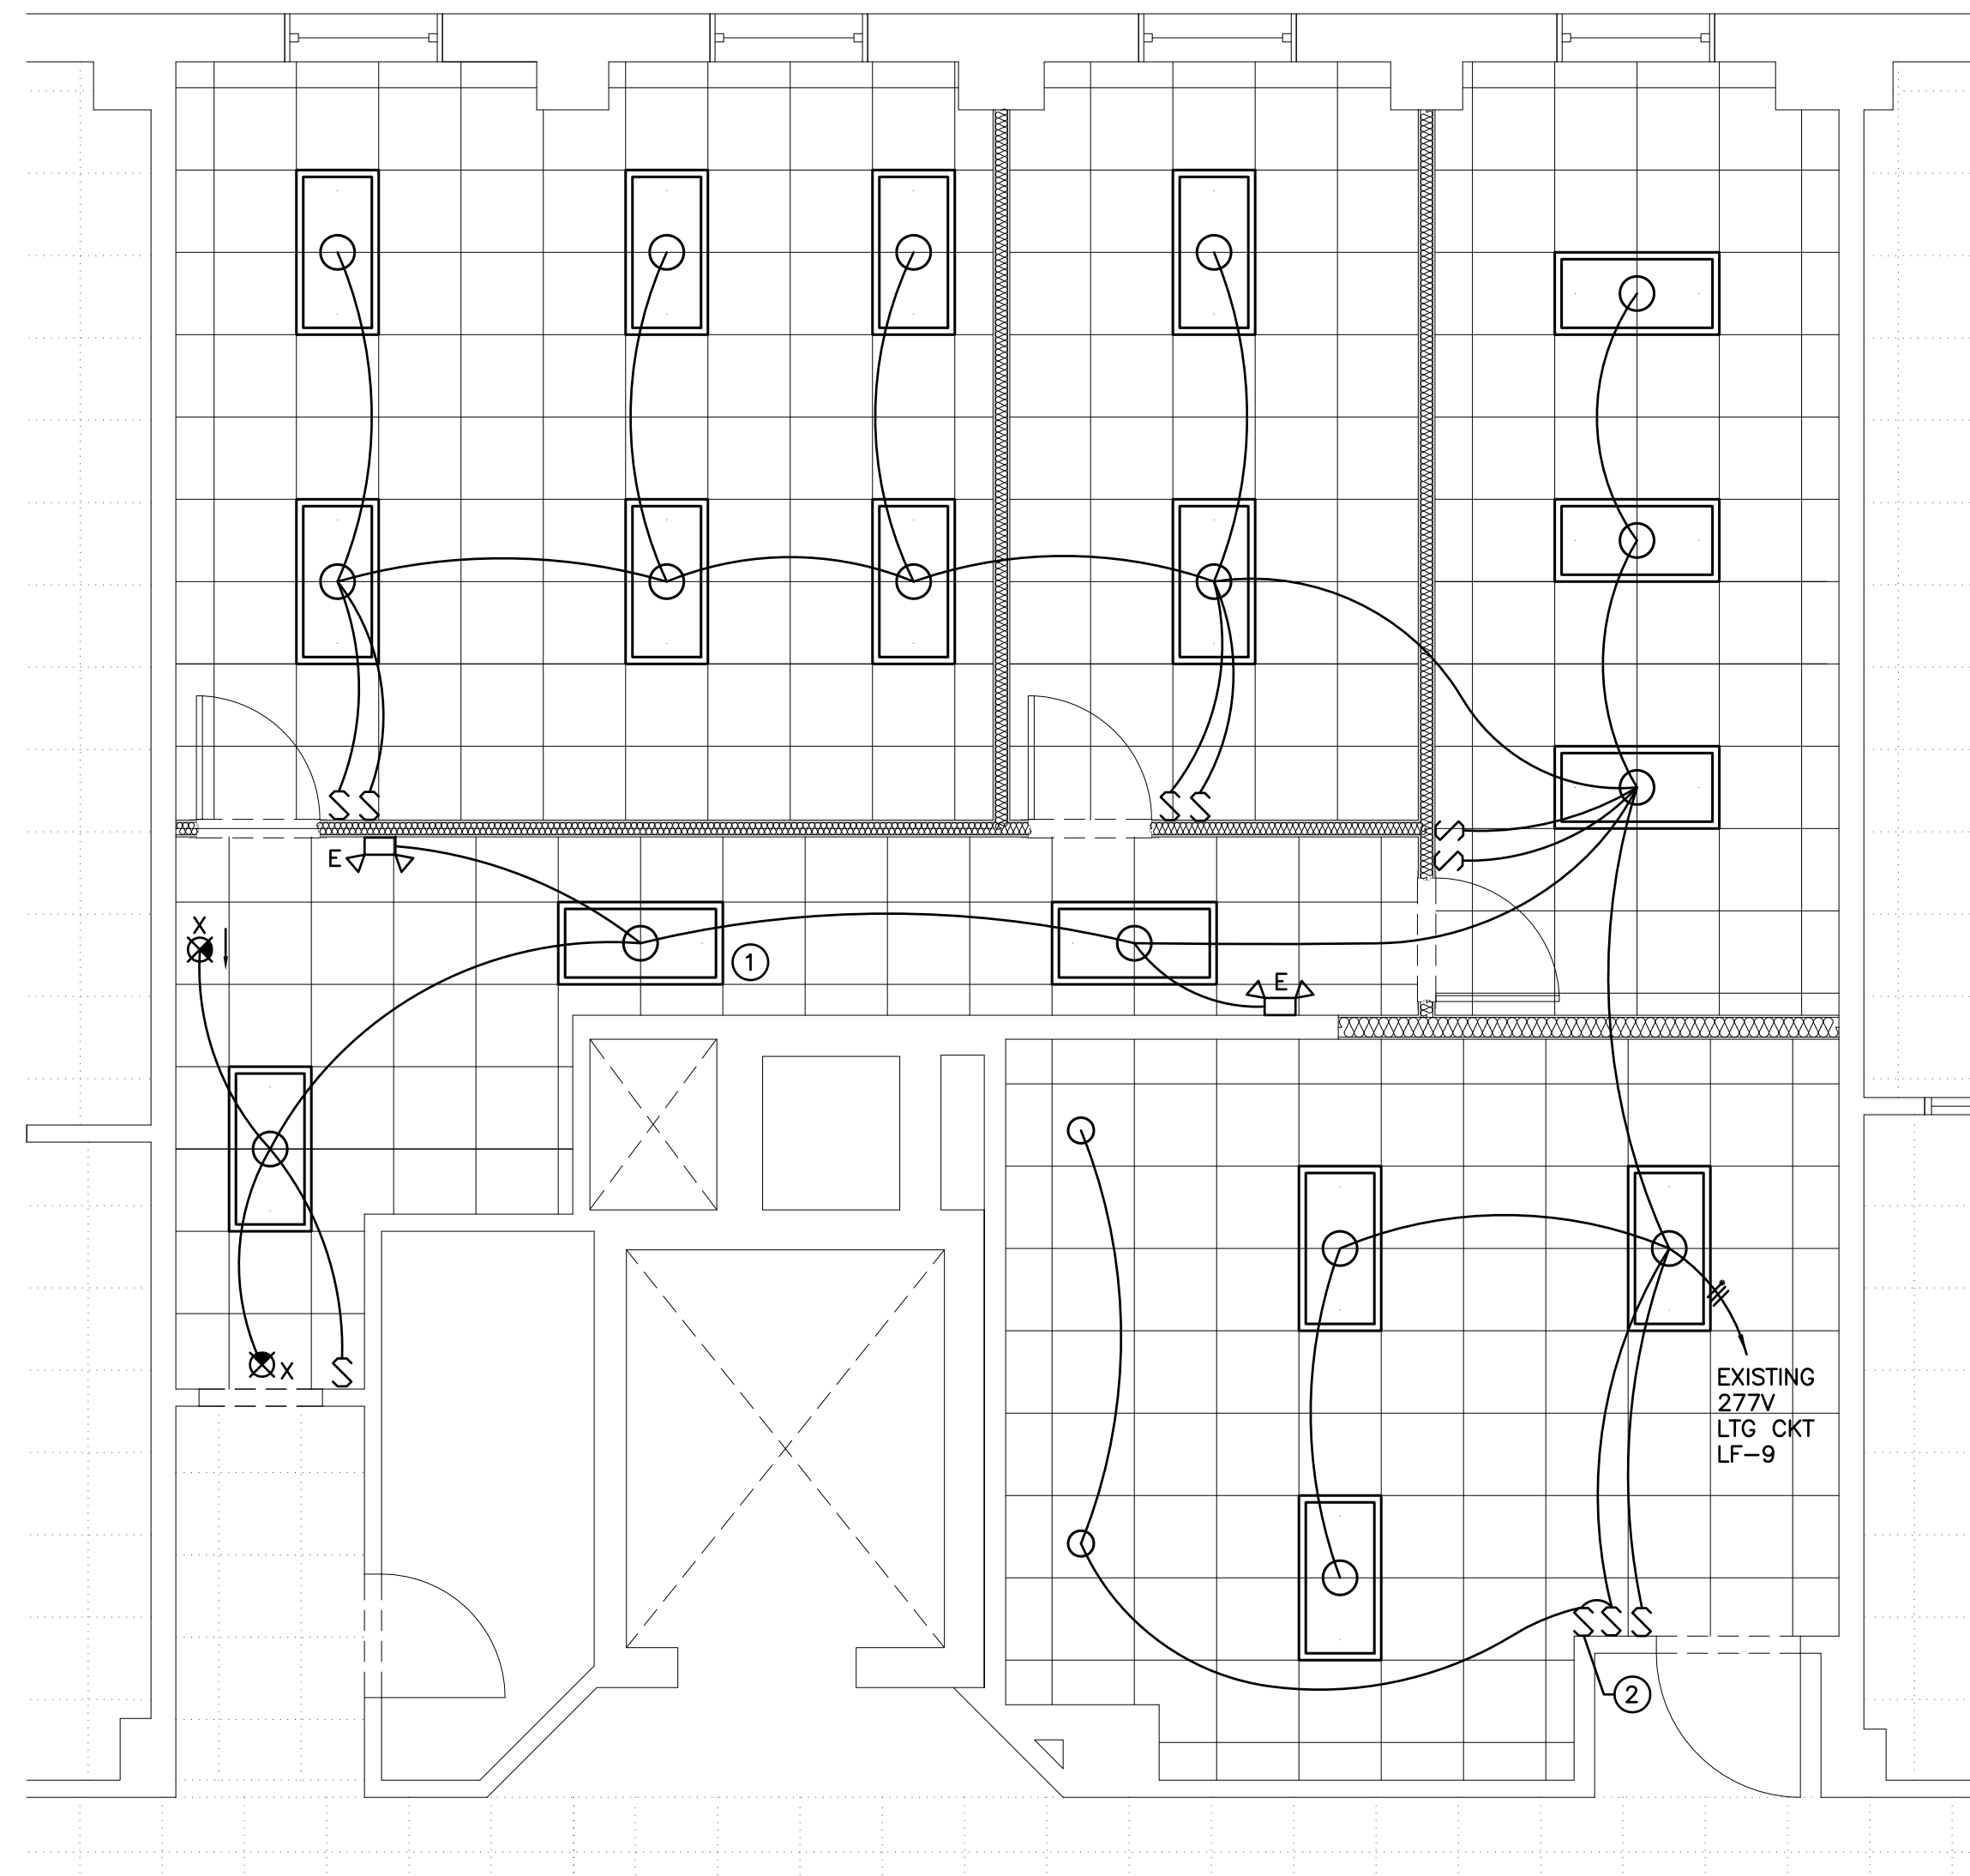

NEW FLOOR PLAN – LIGHTING
SCALE: 1/4"=1'-0"

- NEW WORK LIGHTING REFERENCE NOTES:**
- ① UNSWITCHED NIGHTLIGHT.
 - ② EXISTING SWITCH.

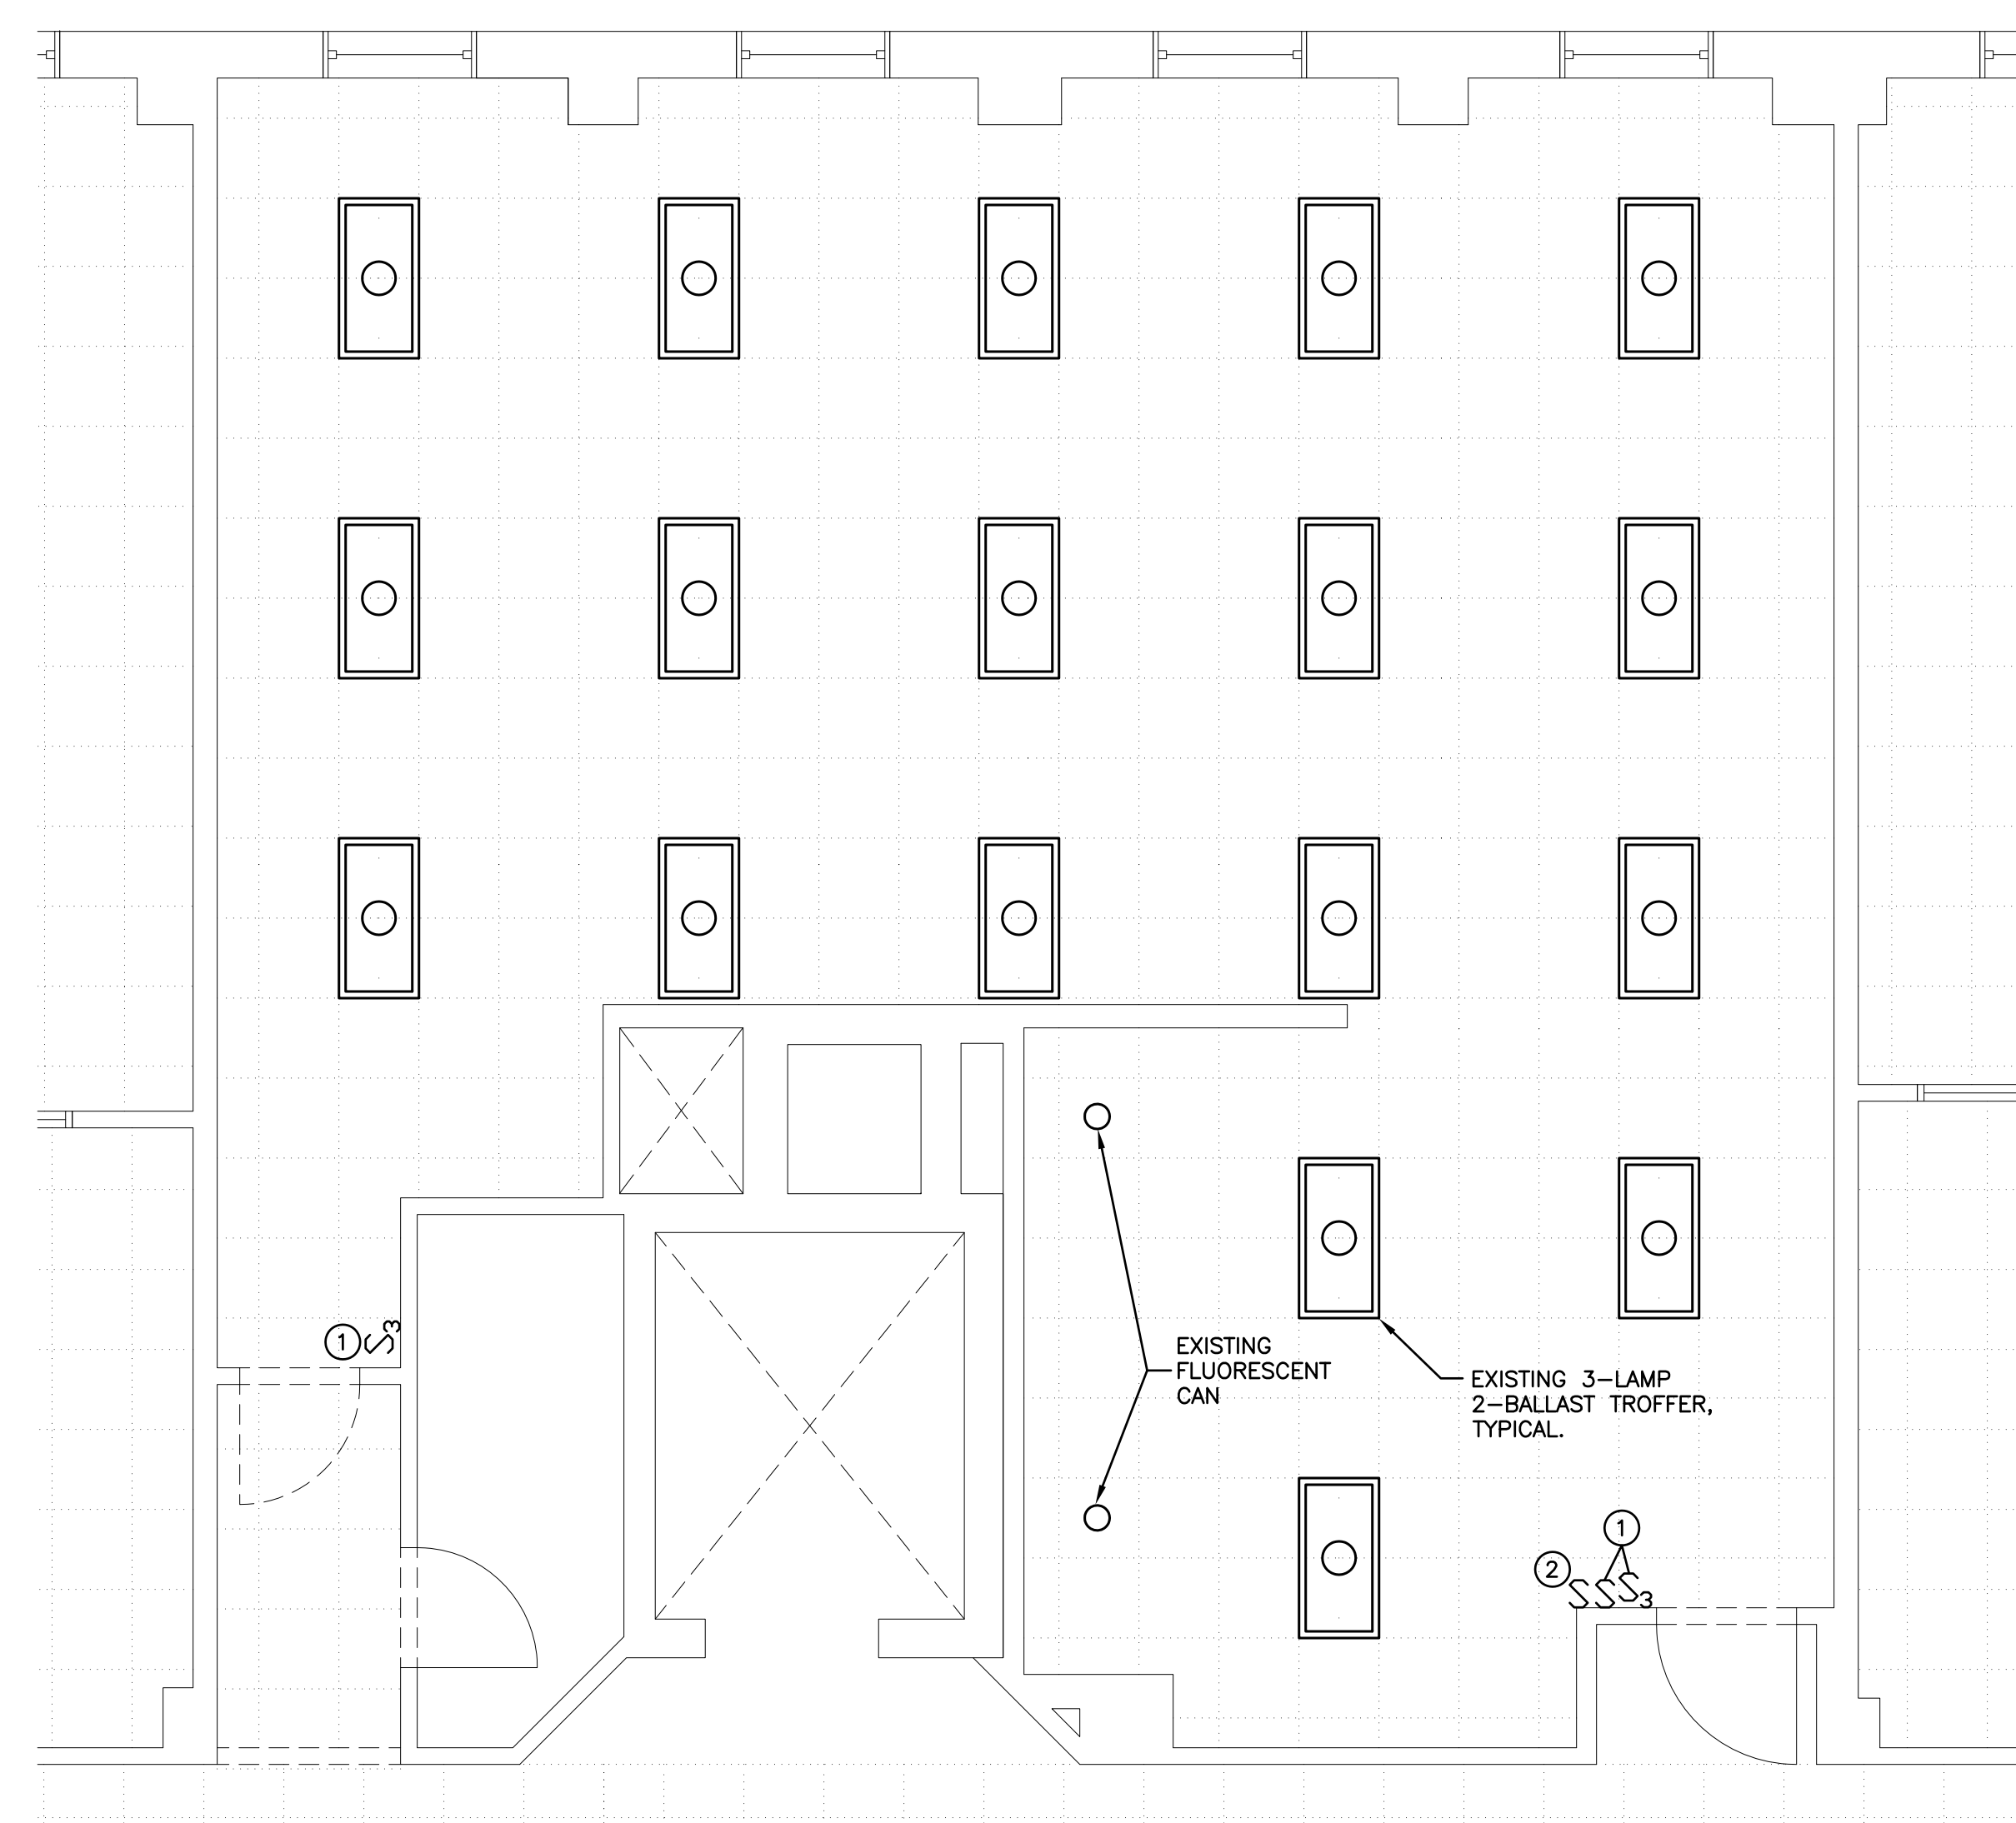

EXISTING FLOOR PLAN – LIGHTING
SCALE: 1/4"=1'-0"

NOTE: EXISTING CEILING GRID WILL BE REMOVED BY G.C. SUPPORT EXISTING FIXTURES DURING CONSTRUCTION. RE-INSTALL IN NEW GRID & REVISE SWITCHING ARRANGEMENTS AS SHOWN ON NEW LTG PLAN.

- DEMOLITION LIGHTING REFERENCE NOTES:**
- ① EXISTING SWITCH TO BE REMOVED.
 - ② EXISTING SWITCH TO REMAIN.
 - ③ EXISTING LIGHT FIXTURE TO REMAIN.