

NEW FLOOR PLAN – FIRE PROTECTION
SCALE: 1/4"=1'-0"

WALKER
the GROUP
ARCHITECTURE
incorporated
PO BOX 541, NEW BERN, NC 28563
252-636-8778 252-636-8992(fax)

RECORD DRAWINGS
2/05/09University of
North Carolina
at Wilmington

602 College Road
Wilmington, NC 28403

Dobo Hall
Computer Lab 230
Renovation

[illegible]


Project Number	Date
0732.DOBO	Feb 08
Drawn	Checked
KDS	BBW

Scale
As Noted

EXISTING & NEW FLOOR PLAN - FIRE PROTECTION

Sheet Number
10 of 10

10 5 10
+ Drawing Number

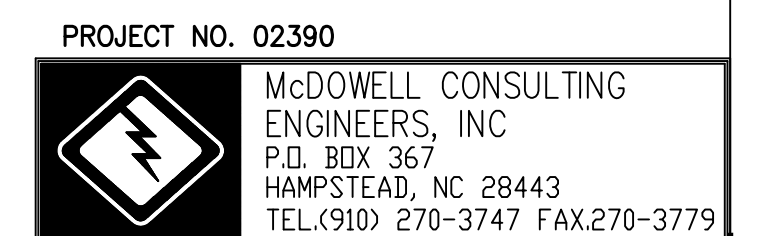

Drawing Number

FP-101