




1 -First Floor Mechanical Demolition Plan
1/4"=1'-0"

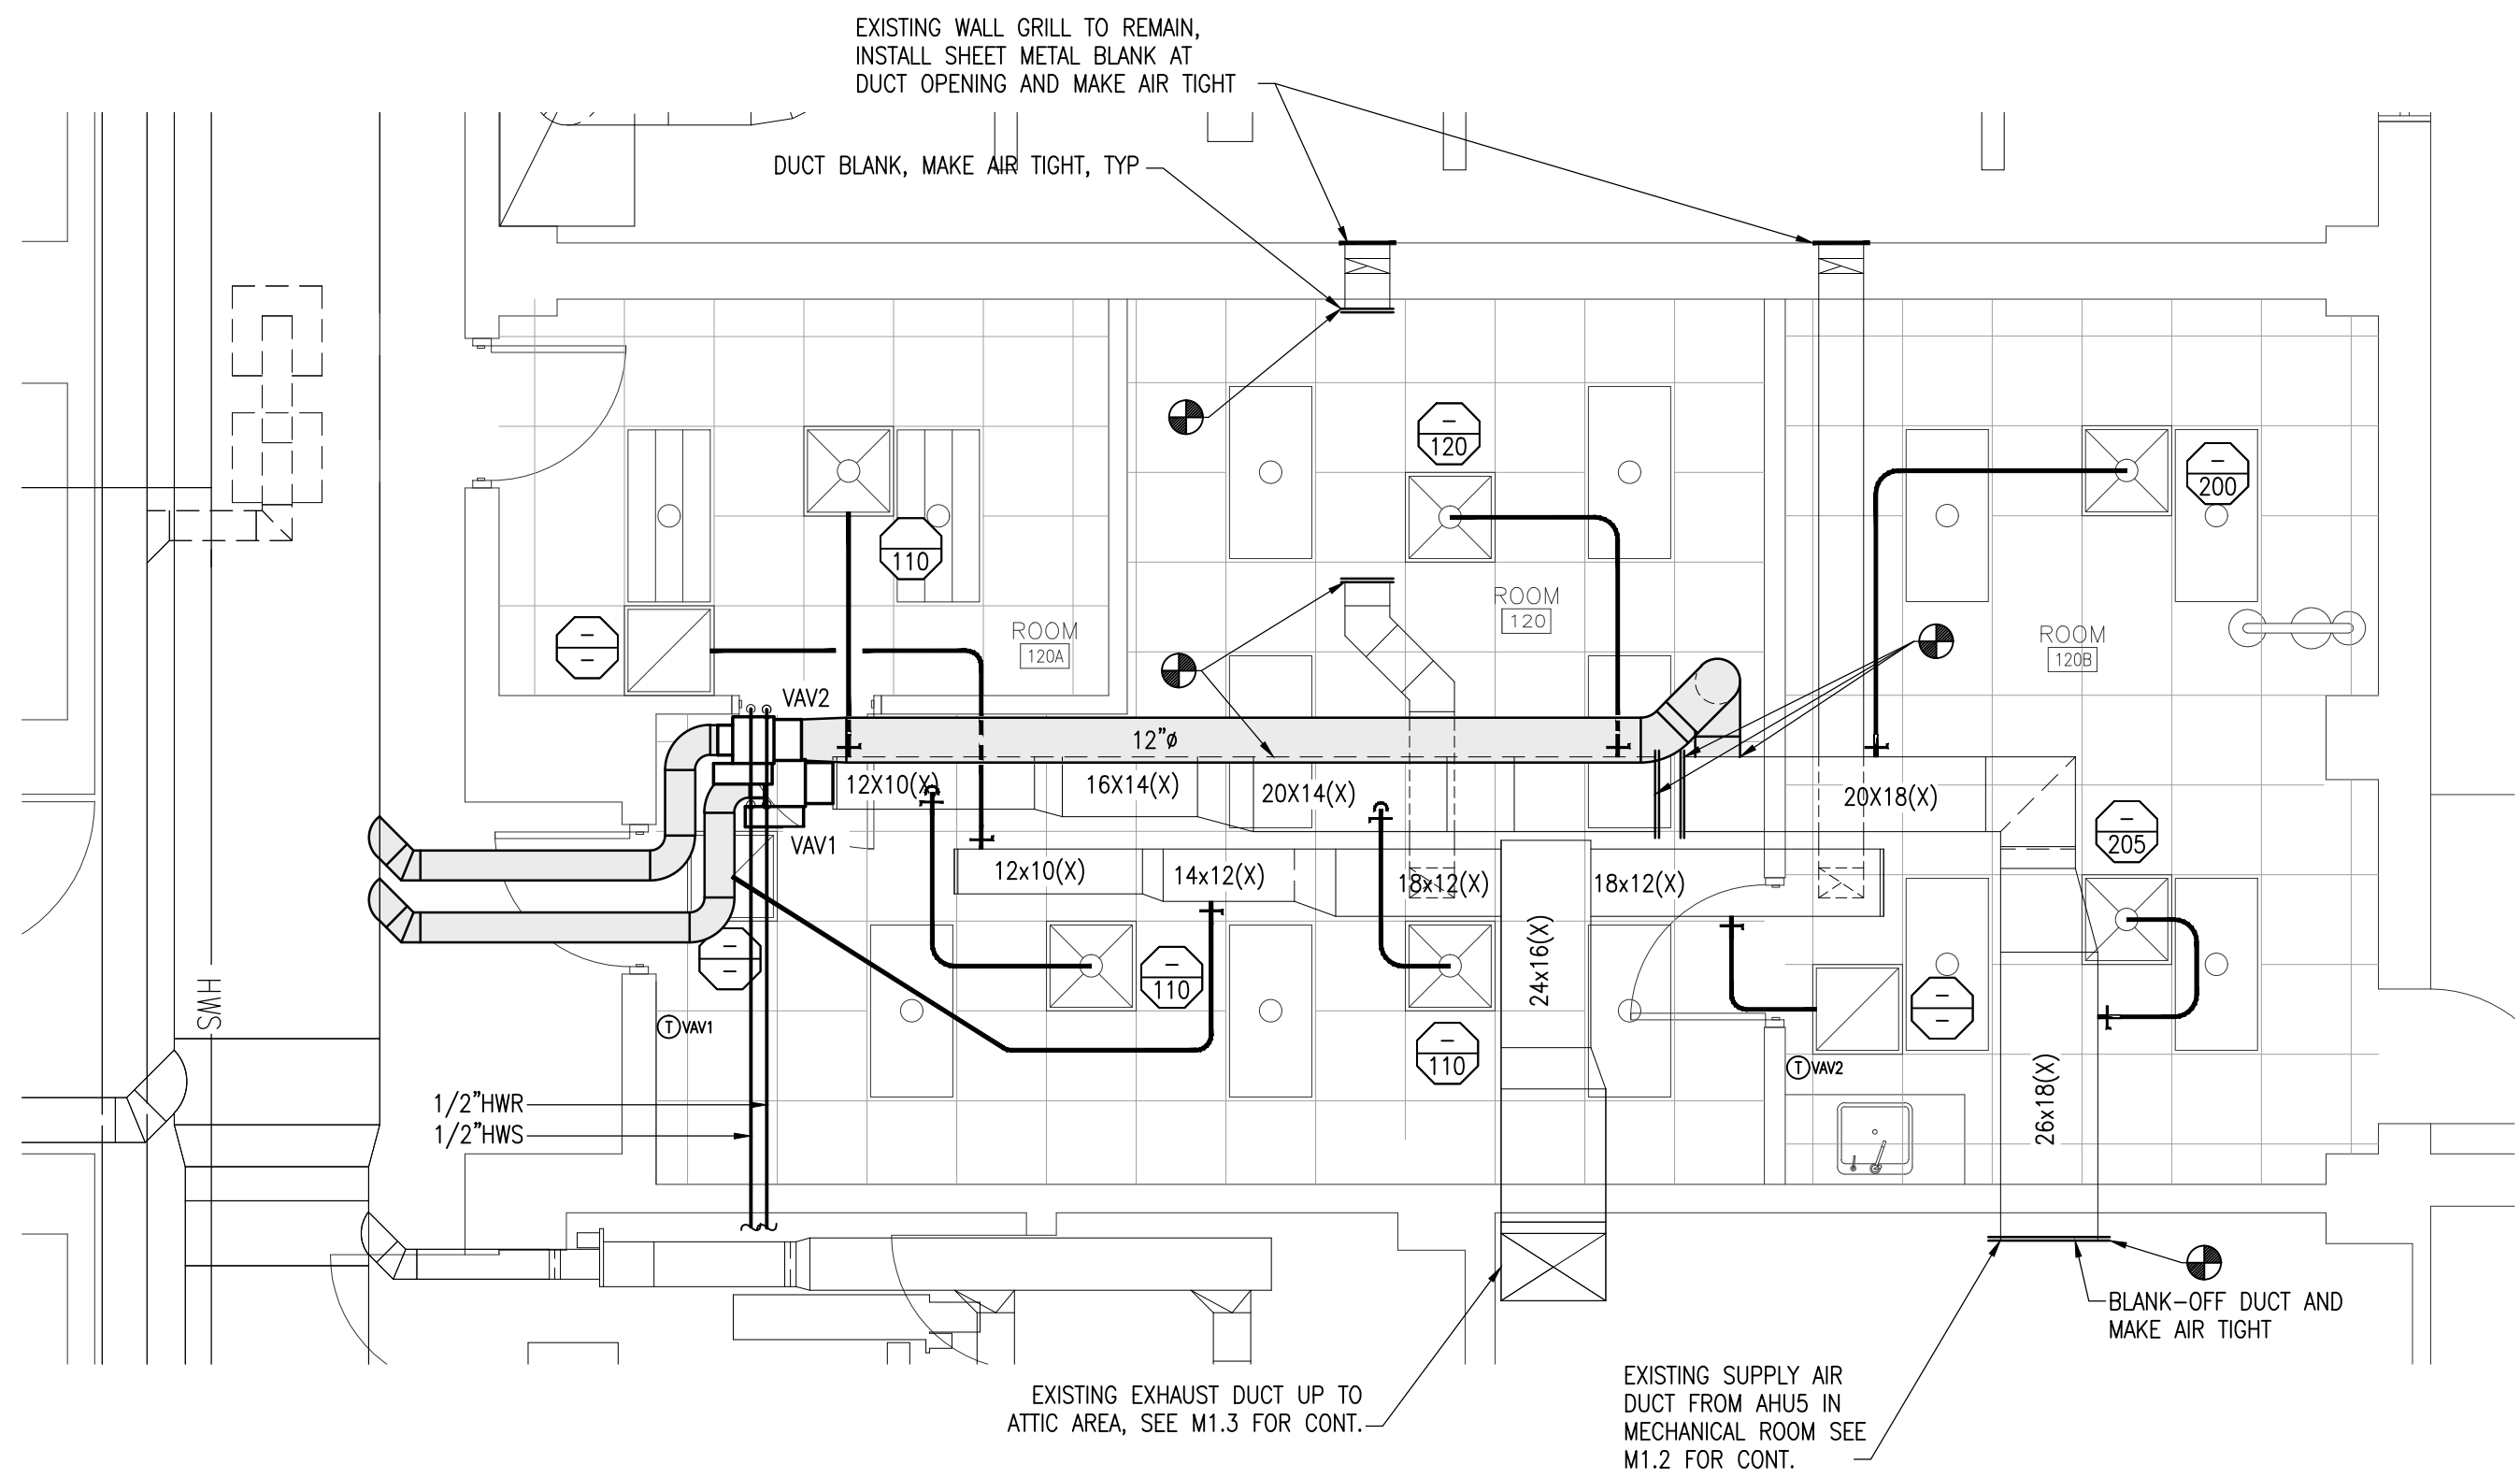

2 -First Floor Mechanical New Work Plan
1/4"=1'-0"

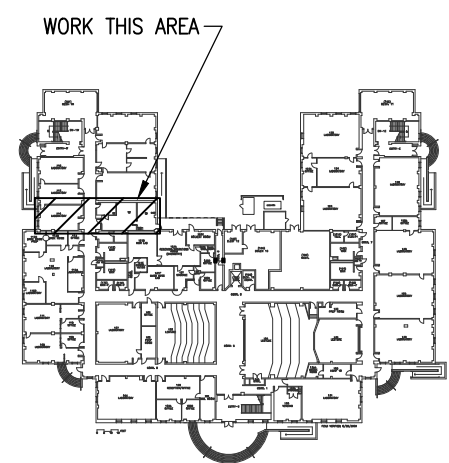

 Key Plan
Not To Scale



Revision No.	Description	Date
1	ISSUED FOR RECORD DRAWING	05.04.15
0	ISSUED FOR REVIEW	08.30.14

CBHF
Engineers, PLLC

3808 Park Avenue
Wilmington, NC 28403

Phone: 910.791.4000
Fax: 910.791.5266
www.cbhfeengineers.com

© Copyright 2013 CBHF Engineers, PLLC
NC# P-0506

THIS DOCUMENT, ORIGINALLY ISSUED AND SEALED, BY: JOHN H. McNALLY, P.E., NC 8737 ON 09/30/14. THIS MEDIA SHALL NOT BE CONSIDERED A CERTIFIED DOCUMENT.

UNC- Wilmington Dobo Hall Suite 120
601 S. College Road
Wilmington, NC

Mechanical
First Floor Demolition & HVAC Plans

Job No.:	14147
Drawn:	RWC
Designed:	RWC
Checked:	JHM

Drawing No:
M1.1

Revision:	1
-----------	---