

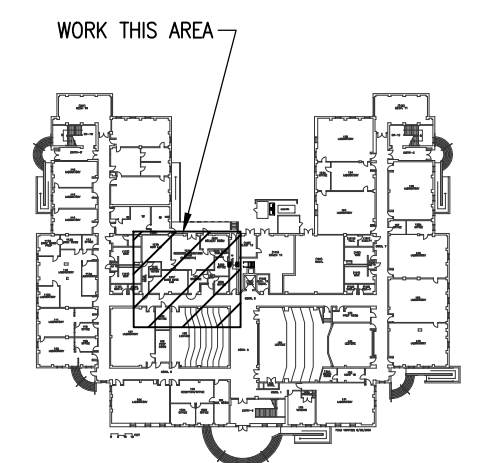
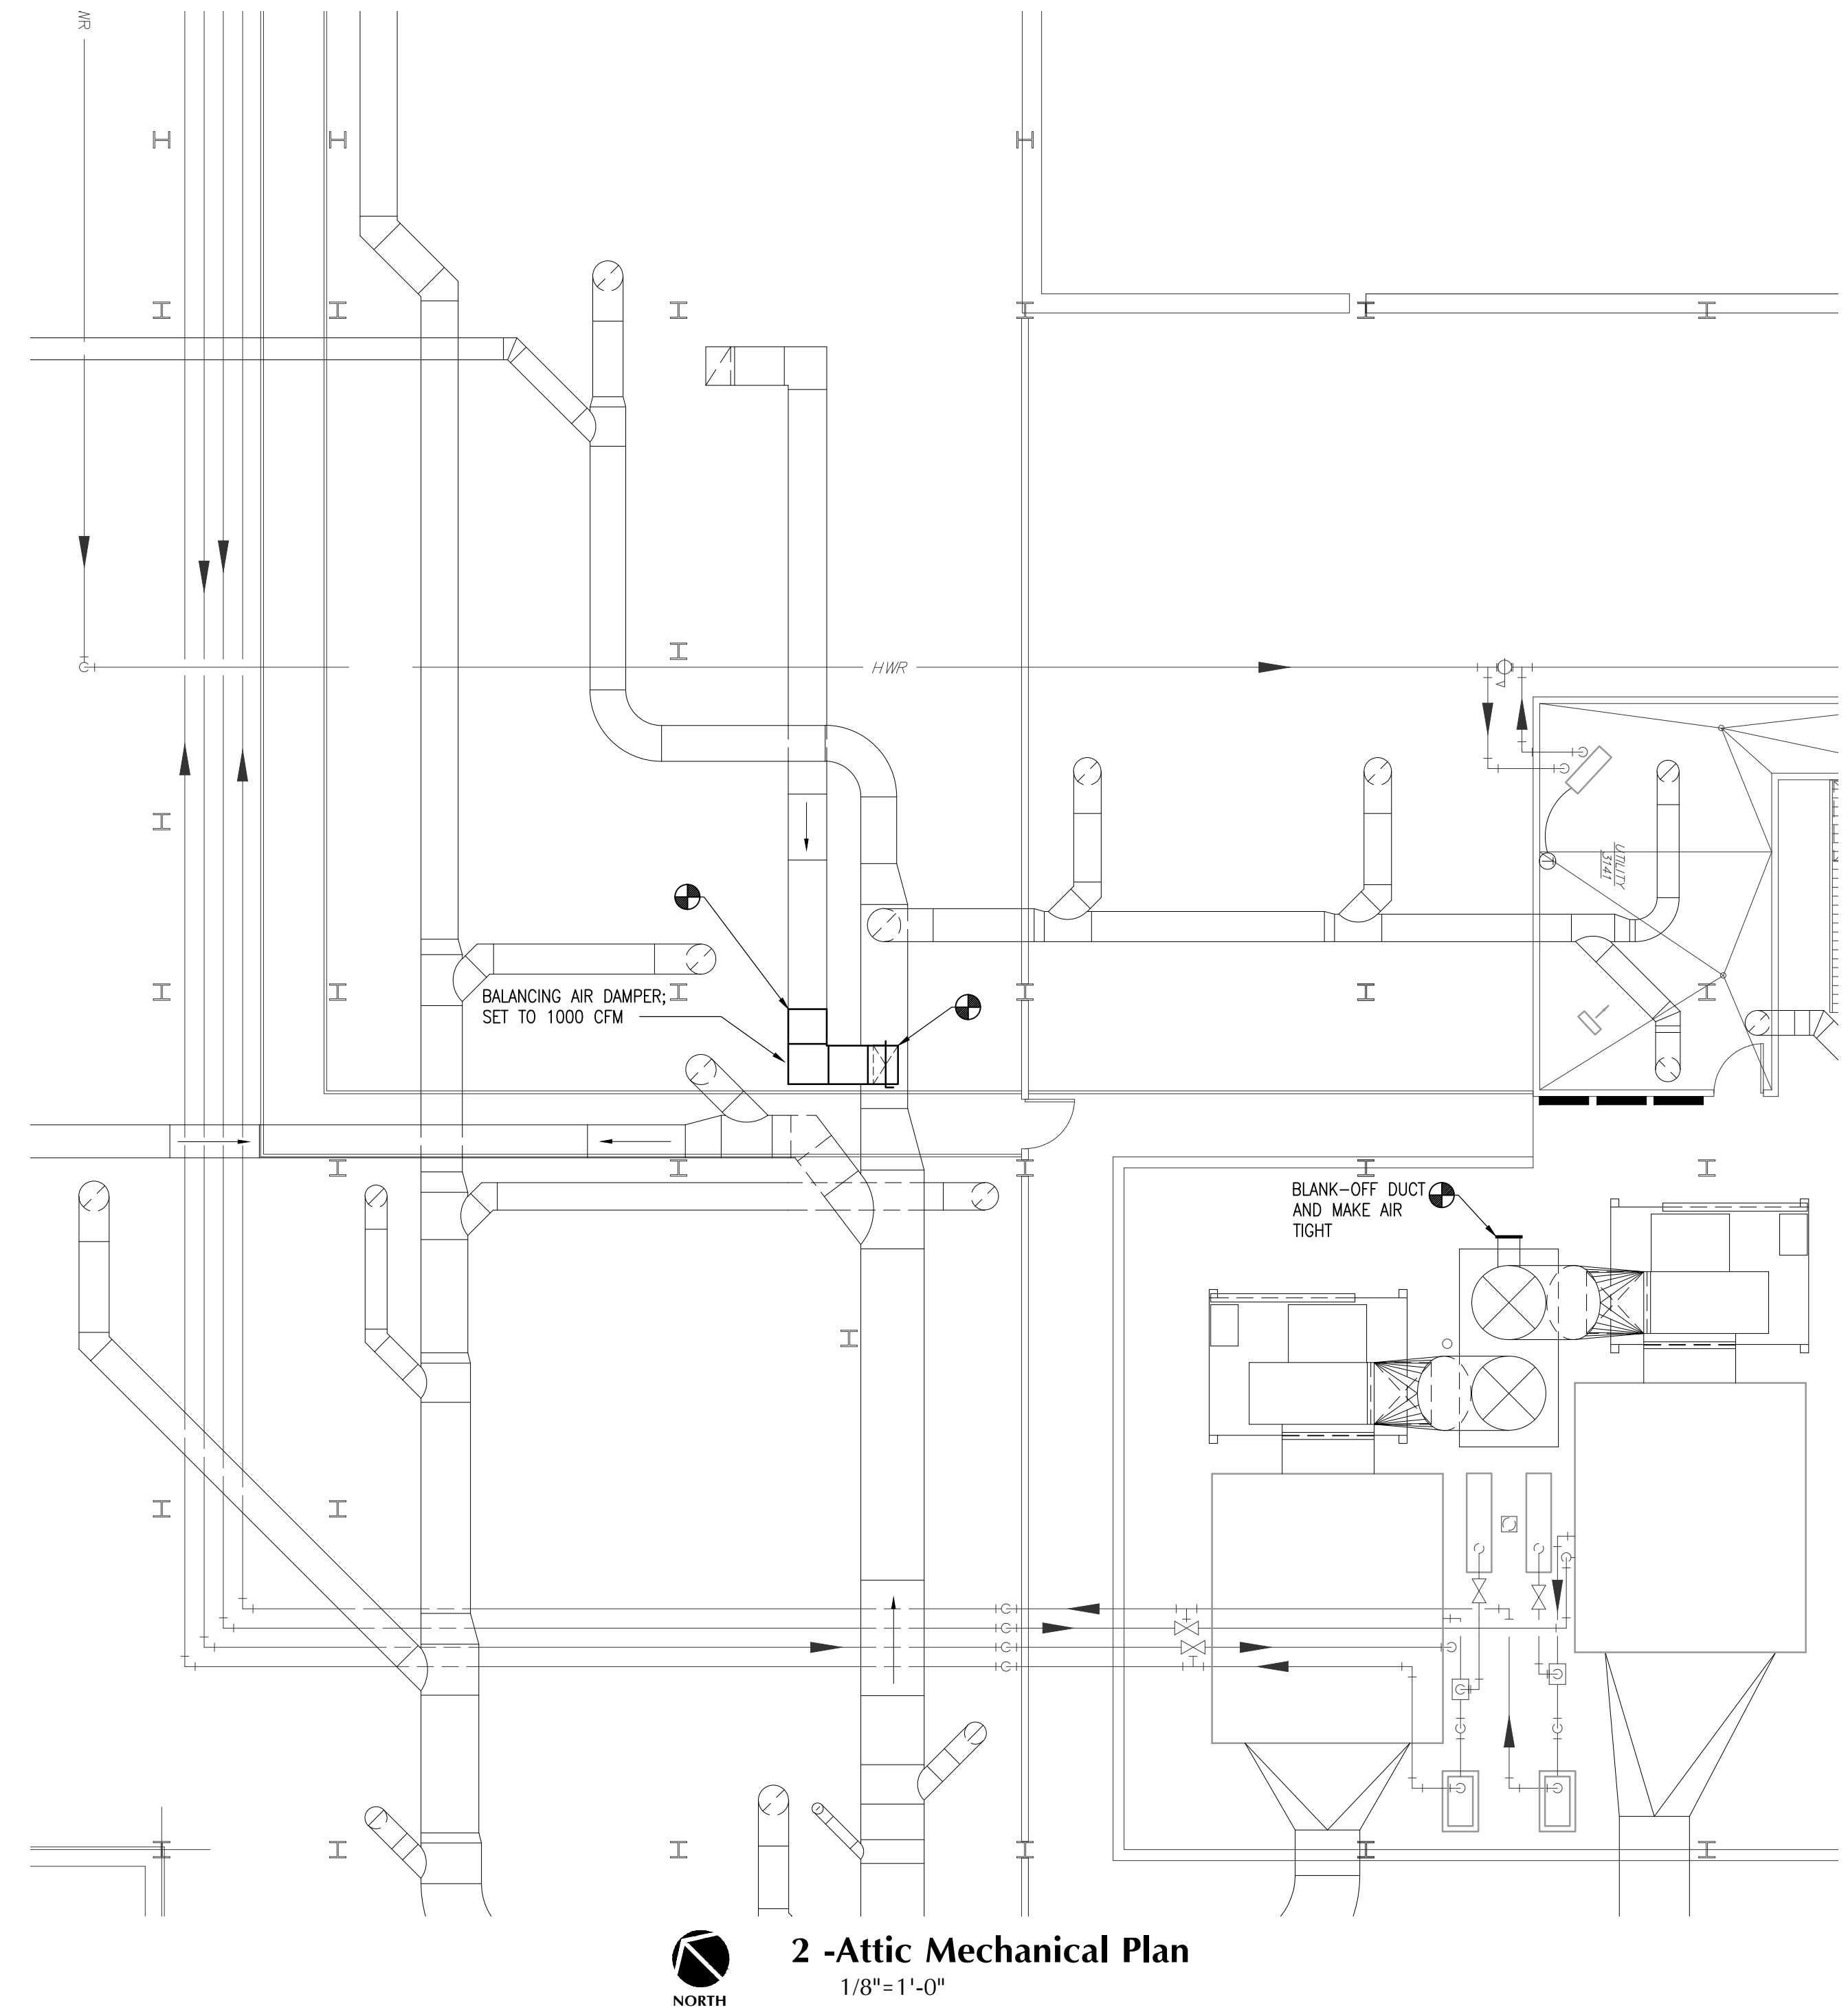


Drawing: K:\UNC\1147-Dobo Hall Suite 120\Outbox\2015-08-26 Rec Dwg-16 Rendons Mac\UNC\1147 Mac.dwg Pld Time: 6/26/2015 12:02 PM

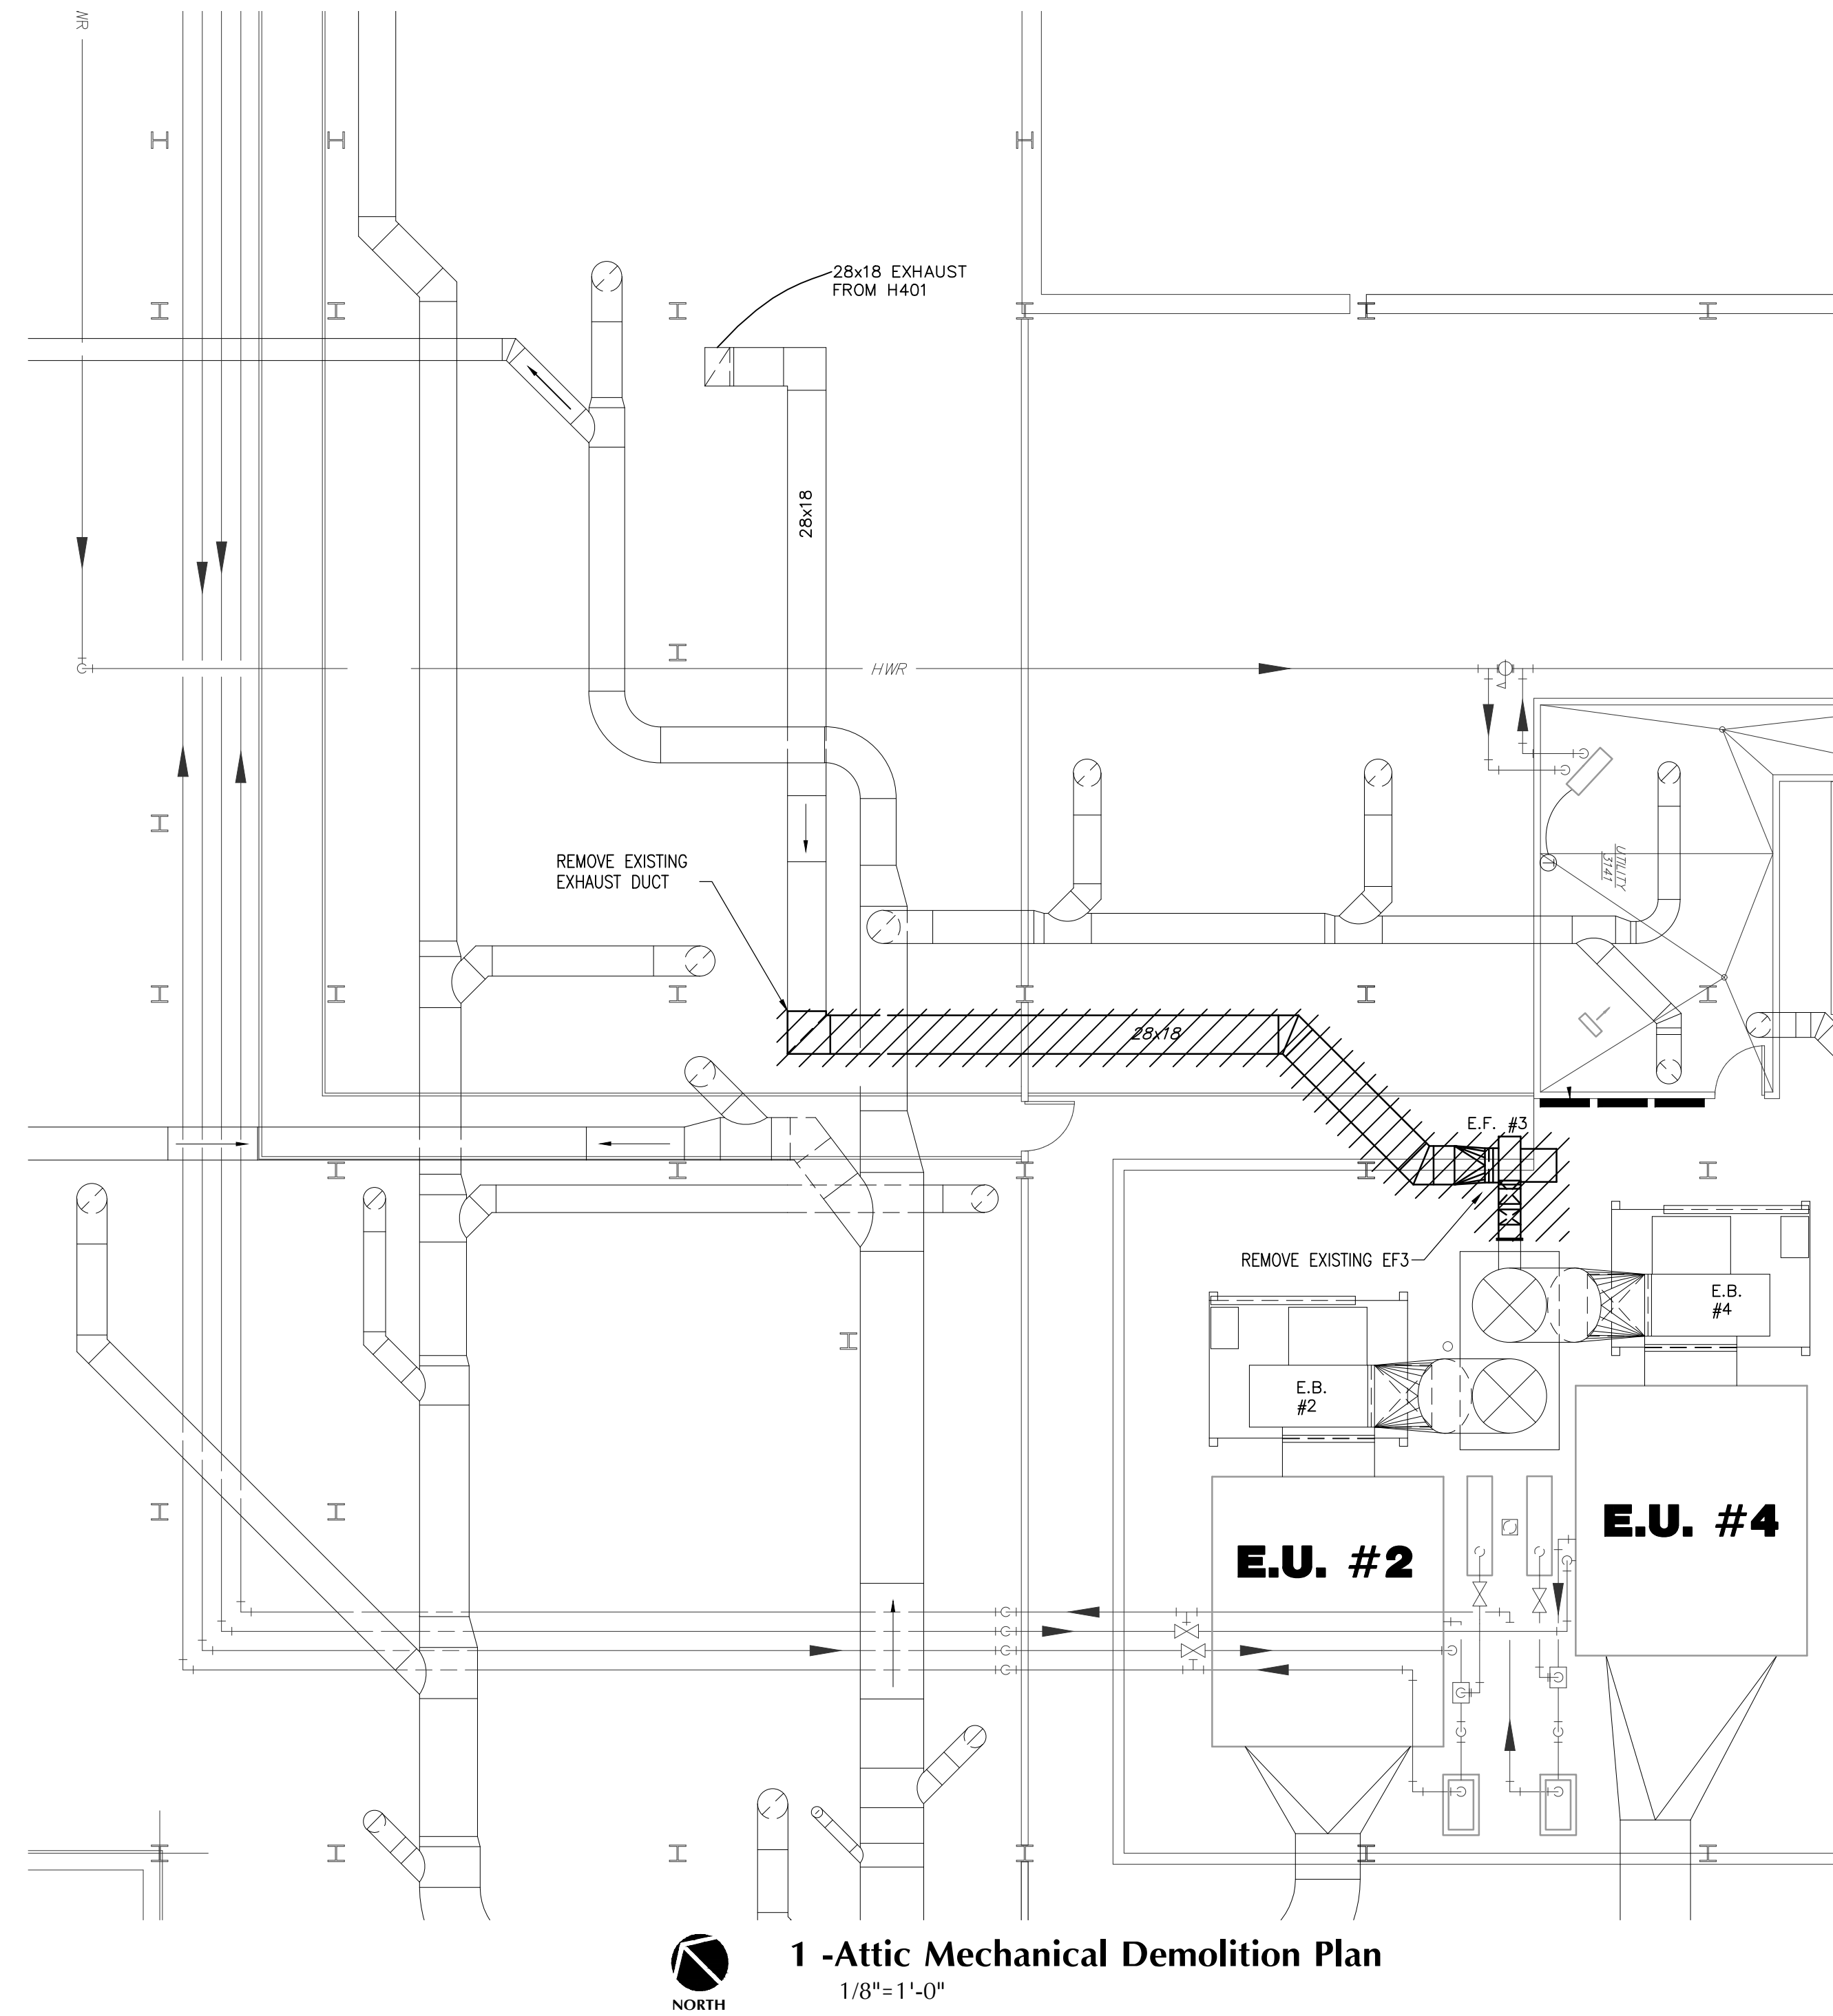

Key Plan
Not To Scale

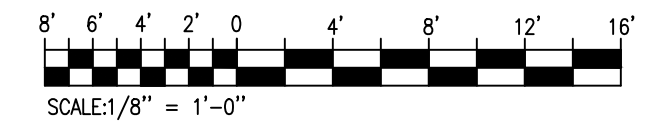

UNC- Wilmington Dobo Hall Suite 120
601 S. College Road
Wilmington, NC

Mechanical
Attic Demolition & HVAC Plans

Job No.: 14147
Drawn: RWC
Designed: RWC
Checked: JHM

Drawing No:

M1.3

Revision:
1

THIS DOCUMENT ORIGINALLY
ISSUED AND SEALED BY:
JOHN H. McNALLY PE,
NC 8737 ON 09/30/14
THIS MEDIA SHALL NOT BE
CONSIDERED A CERTIFIED
DOCUMENT.

CBHF
Engineers, PLLC
3808 Park Avenue
Wilmington, NC 28403
Phone: 910.791.4000
Fax: 910.791.5266
www.cbhfeengineers.com
© Copyright 2013 CBHF Engineers, PLLC
NC# P-0506

Revision No.	Description	Date
1	ISSUED FOR RECORD DRAWING	05.04.15
0	ISSUED FOR REVIEW	08.30.14