


- ### TELECOM/DATA GENERAL NOTES
- ALL VOICE/DATA CABLING SHALL BE HANDELED AND INSTALLED BY A CERTIFIED VOICE/DATA CONTRACTOR FOR THE COMMSCOPE SYSTEMAX SOLUTION. THE COMMSCOPE SYSTEMAX SOLUTION REQUIRES THE CONTRACTOR TO BE A CURRENT BUSINESS PARTNER.
  - ALL TELECOM SLEEVES AND RACEWAYS SHALL BE BUSHED, REAMED AND BE PROVIDED WITH INSULATED BONDING BUSHINGS. PROVIDE PULL STRING IN ALL SLEEVES AND RACEWAY.
  - ALL TERMINATIONS AND TESTING WILL BE DONE BY THE CERTIFIED VOICE/DATA INSTALLER PER SPECIFICATIONS.


**1 - POWER PLAN**  
1/4"=1'-0"

**RECORD DRAWING**  
These Record Documents have been prepared based on information provided by others. The Engineer has not verified the accuracy and/or completeness of this information and shall not be responsible for any errors or omissions which may be incorporated herein as a result.

FIRE RATING LEGEND	
1 HR	1 HOUR RATED FIRE PARTITION

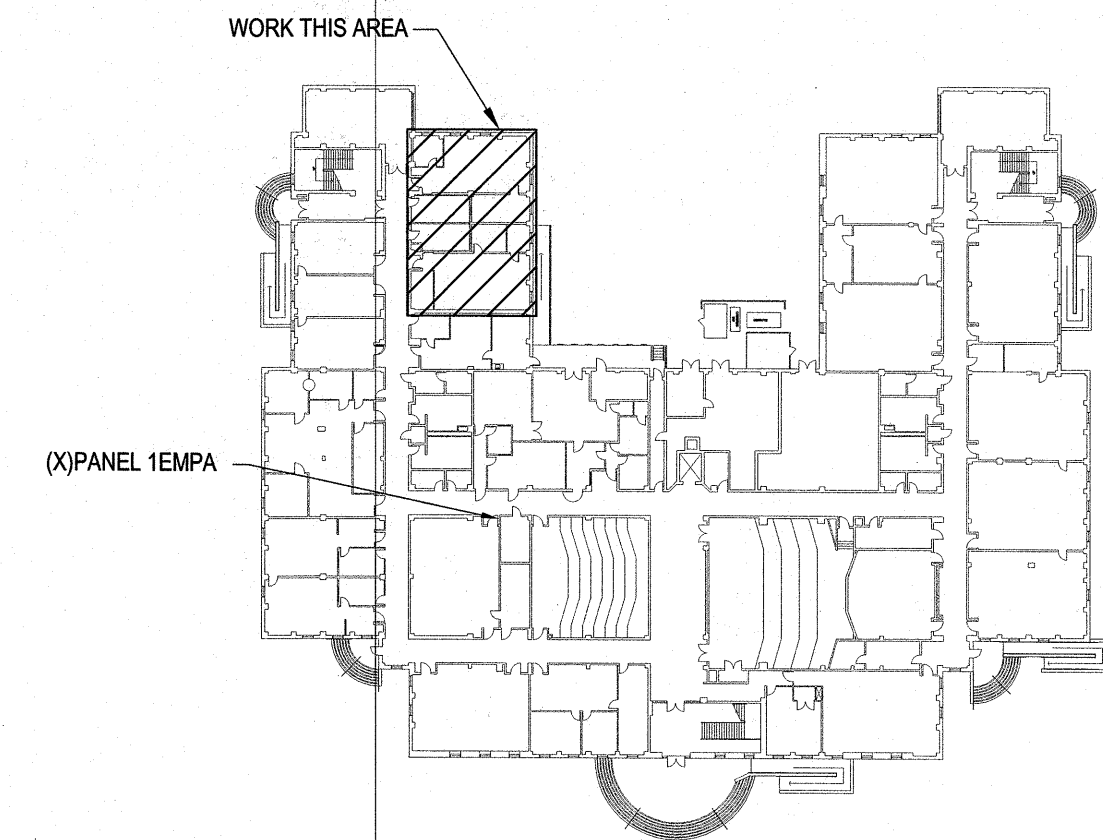


 **KEY PLAN**  
NOT TO SCALE



REVISIONS	10.13.17
REVISIONS	10.13.17

**CBHF**  
Engineers, PLLC  
2246 Yaupon Drive  
Wilmington, NC 28401  
Phone: 910.791.4000  
Fax: 910.791.5266  
www.cbhfenr.com  
© Copyright 2017 CBHF Engineers, PLLC  
NC# P-006

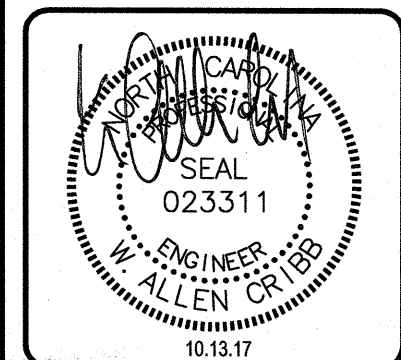

UNIVERSITY OF NORTH CAROLINA WILMINGTON  
DOB0 HALL LABS 117 AND 119 RENOVATIONS  
601 S. COLLEGE ROAD, WILMINGTON, NORTH CAROLINA 28403  
STATE ID# 17-1697501A  
**ELECTRICAL POWER PLAN**

Job No:	15250
Drawn:	HGH
Designed:	HGH
Checked:	WAC

Drawing No:  
**E1.1**  
Revision:  
0