


1 - HVAC PLAN  
1/4"=1'-0"

GENERAL MECHANICAL NOTES

1. THE MECHANICAL CONTRACTOR SHALL INSPECT AND TEST EXISTING FIRE DAMPERS AT THE PENETRATIONS OF FIRE RATED WALLS RELATED TO THE AREA OF WORK. CONTRACTOR SHALL SUBMIT REPORT DOCUMENTING FIRE DAMPER LOCATION, TYPE, DATE OF INSPECTION, NAME OF INSPECTOR, AND ANY DEFICIENCIES DISCOVERED. THE REPORT SHALL INDICATE WHEN AND HOW THE DEFICIENCIES WERE CORRECTED.

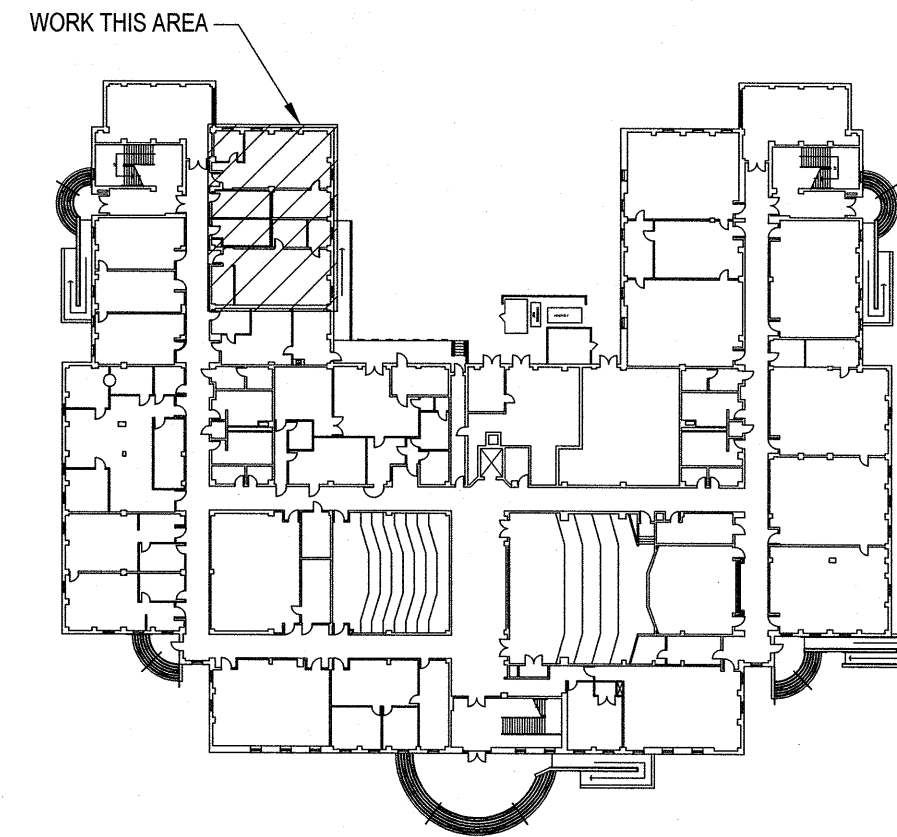


KEY PLAN  
NOT TO SCALE

RECORD DRAWING

These Record Documents have been prepared based on information provided by others. The Engineer has not verified the accuracy and/or completeness of this information and shall not be the responsible for any errors or omissions which may be incorporated herein as a result.

Dated: 2017-10-13  
By: [Signature]

FIRE RATING LEGEND	
1HR	1 HOUR RATED FIRE PARTITION

 

UNIVERSITY OF NORTH CAROLINA - WILMINGTON  
DOBO HALL LABS 117 AND 119 RENOVATIONS  
601 S. COLLEGE ROAD, WILMINGTON, NORTH CAROLINA 28403  
STATE ID# 17-16975-01A

MECHANICAL  
HVAC PLAN

Job No.:	15290
Drawn:	GRM
Designed:	GRM
Checked:	DMH

Drawing No:

M1.1

Revision:  
0



**CBHF**  
Engineers, PLLC

2246 Yaupon Drive  
Wilmington, NC 28401  
Phone: 910.791.4000  
Fax: 910.791.5266  
www.cbhfenr.com  
NC# P-0506