

PROJECT INFORMATION

NORTH WATERFRONT PARK

10 COWAN STREET
WILMINGTON, NORTH CAROLINA

CITY OF WILMINGTON
Community Services Department
PO Box 1810, Wilmington, North Carolina 28402
City of Wilmington Project Code 3CPRK1860

Landscape Architecture = L
HARGREAVES JONES
180 Varick Street, Suite 204, New York, NY 10014
www.hargreavesjonesla.com
NC License #C-513

Architecture = A
SAGE & COOMBE ARCHITECTS
12-16 Vestry Street, 5th Floor, New York, NY 10013
www.sageandcoombe.com

Acoustic/Theater/AV = AT
CAP.P.C.
77 Water Street, New York NY 10015
www.arup.com

Civil Engineering = C
Structural Engineering = S
Geotechnical Engineering = G
STEWART
223 S. West Street, Suite 1100, Raleigh, NC 27603
www.stewartinc.com
NC License #C-1051

Environmental Engineering = EE
SOIL & ENVIRONMENTAL CONSULTANTS, PA
8412 Falls of Neuse Road, Suite 104, Raleigh, NC 27615
www.sandec.com

EAGLE RESOURCES
215 West Moore Street, Southport, NC 28461
www.eagleresources.com

Irrigation = I
CLARK IRRIGATION DESIGN & CONSULTING, INC
P.O. Box 605, Lenoir, GA 30555
www.clarkirrigationdesign.com

Landscape Soil = LS
LANDIS, PLLC
5908 Bentley Brook Dr. Raleigh, NC 27612
www.landispllc.com

Mechanical Engineering = M
Electrical Engineering = E
Plumbing Engineering = P
Fire Protection = FP
CHEATHAM & ASSOCIATES, PA
3412 Enterprise Drive, Wilmington NC 28405
www.cheathampa.com
NC License #C-1073

Marine Structural Engineering = SM
ANDREW CONSULTING ENGINEERS
3811 Peachtree Avenue, Suite 300, Wilmington, NC 28403
www.andrewengineers.com

Water Fountain Design = WF
DELTA FOUNTAINS
11494 Columbia Park Dr. W., Suite 4, Jacksonville, FL 32258
www.deltafountains.com


Lighting Design = EL
TILLOTSON DESIGN ASSOCIATES
40 North Street, Room 703, New York NY 10013
www.tillotsondesign.com

SEAL/SIGNATURE

CAPA 17109

PROGRESS DRAWINGS
DO NOT USE FOR CONSTRUCTION

ISSUE/REVISIONS		
NO.	DESCRIPTION	DATE
1	30% CONSTRUCTION DOCUMENTS P3 & P4	06/07/2019
2	60% CONSTRUCTION DOCUMENTS P3	07/26/2019
3	95% CONSTRUCTION DOCUMENTS P3 & P4	12/04/2019

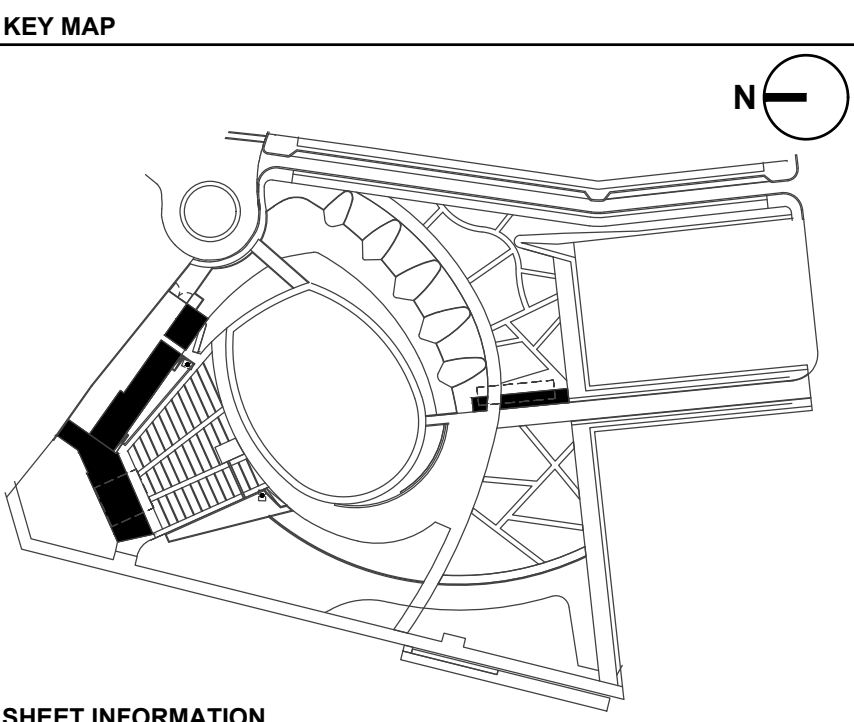

SHEET INFORMATION

Project No.: NWP 1701
Drawn By: CG, SL
Checked By: CG
Date: 12/04/2019
Scale: As indicated

SHEET TITLE


FIRE PROTECTION GENERAL NOTES AND DETAILS

SHEET NO.

FP-001-P4

N
M
L
K
J
I
H
G
F
E
D
C
B
A


1 2 3 4 5 6 7 8 9 10 11 12 13 14 15 16 17

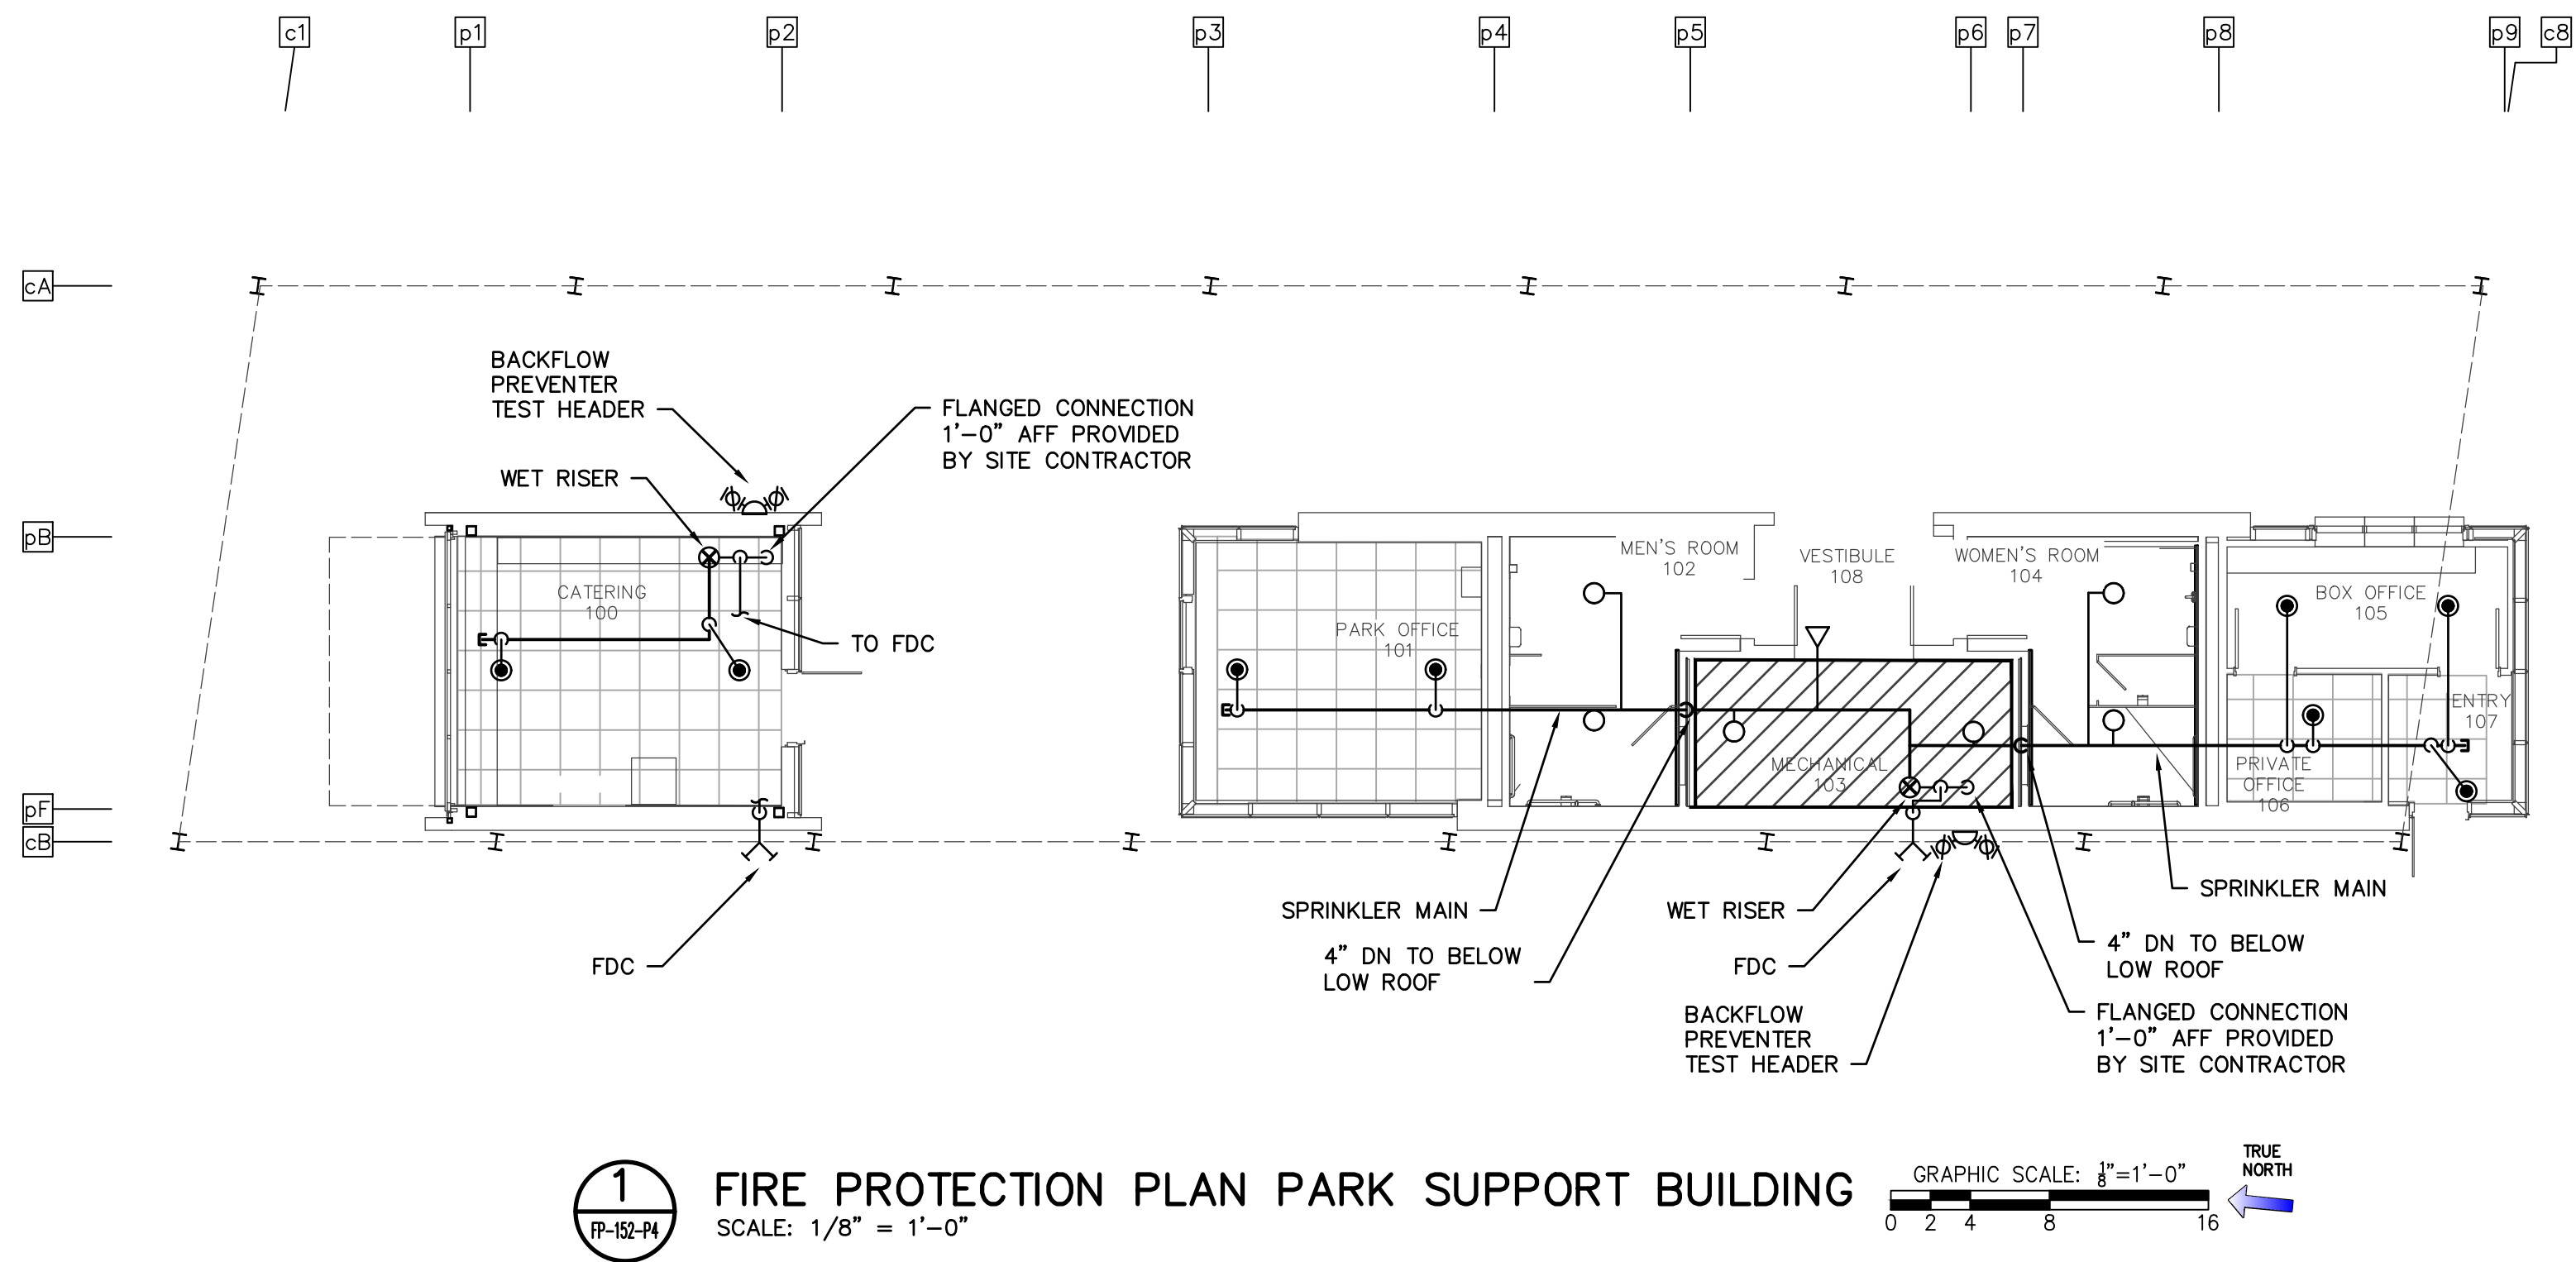

PIPING LEGEND	
	SPRINKLER MAIN
	SPRINKLER BRANCH
	CAP
	PIPE RISER DOWN
	PIPE RISER UP
	WET SPRINKLER RISER

SPRINKLER LEGEND	
	RECESSED PENDANT SPRINKLER HEAD
	CONCEALED PENDANT SPRINKLER HEAD
	UPRIGHT SPRINKLER HEAD
	DRY SIDEWALL SPRINKLER HEAD

HAZARD LEGEND	
	LIGHT HAZARD
	ORDINARY HAZARD I

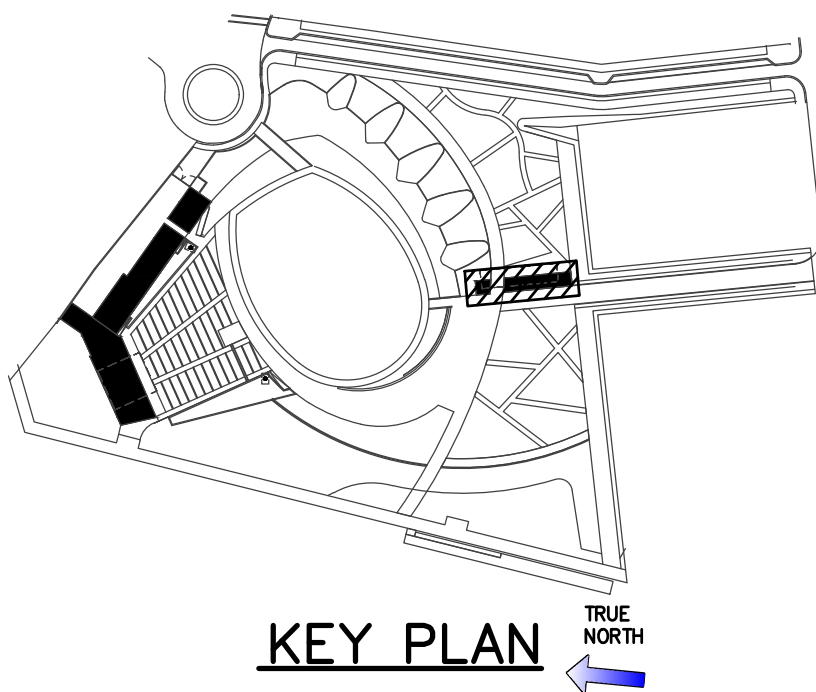

PROJECT INFORMATION

NORTH WATERFRONT PARK

10 COWAN STREET
WILMINGTON, NORTH CAROLINA

CITY OF WILMINGTON
Community Services Department
PO Box 1810, Wilmington, North Carolina 28402
City of Wilmington Project Code 3CPRK1860

Landscape Architecture = L
HARGREAVES JONES
180 Varick Street, Suite 204, New York, NY 10014
www.hargreavesjonesla.com
NC License #C-513

Architecture = A
SAGE & COOMBE ARCHITECTS
12-16 Vestry Street, 5th Floor, New York, NY 10013
www.sageandcoombe.com

Acoustic/Theater/AV = AT
CAP.P.C.
77 Water Street, New York NY 10015
www.arup.com

Civil Engineering = C
Structural Engineering = S
Geotechnical Engineering = G
STEWART
223 S. West Street, Suite 1100, Raleigh, NC 27603
www.stewartinc.com
NC License #C-1051

Environmental Engineering = EE
SOIL & ENVIRONMENTAL CONSULTANTS, PA
8412 Falls of Neuse Road, Suite 104, Raleigh, NC 27615
www.sandec.com

EAGLE RESOURCES
215 West Moore Street, Southport, NC 28461
www.eagleresources.com

Irrigation = I
CLARK IRRIGATION DESIGN & CONSULTING, INC
P.O. Box 695, Levonia, GA 30553
www.clarkirrigationdesign.com

Landscape Soil = LS
LANDIS, PLLC
5908 Bentley Brook Dr. Raleigh, NC 27612
www.landispllc.com

Mechanical Engineering = M
Electrical Engineering = E
Plumbing Engineering = P
Fire Protection = FP
CHEATHAM & ASSOCIATES, PA
3412 Enterprise Drive, Wilmington NC 28405
www.cheathamco.com
NC License #C-1073

Marine Structural Engineering = SM
ANDREW CONSULTING ENGINEERS
3811 Peachtree Avenue, Suite 300, Wilmington, NC 28403
www.andrewengineers.com

Water Fountain Design = WF
DELTA FOUNTAINS
11494 Columbia Park Dr. W., Suite 4, Jacksonville, FL 32258
www.deltafountains.com


Lighting Design = EL
TILLOTSON DESIGN ASSOCIATES
40 Worth Street, Room 703, New York NY 10013
www.tillotsondesign.com

SEAL/SIGNATURE

CAPA 17109

PROGRESS DRAWINGS
DO NOT USE FOR CONSTRUCTION

ISSUE/REVISIONS		
NO.	DESCRIPTION	DATE
1	30% CONSTRUCTION DOCUMENTS P3 & P4	06/07/2019
2	60% CONSTRUCTION DOCUMENTS P3	07/26/2019
3	95% CONSTRUCTION DOCUMENTS P3 & P4	12/04/2019

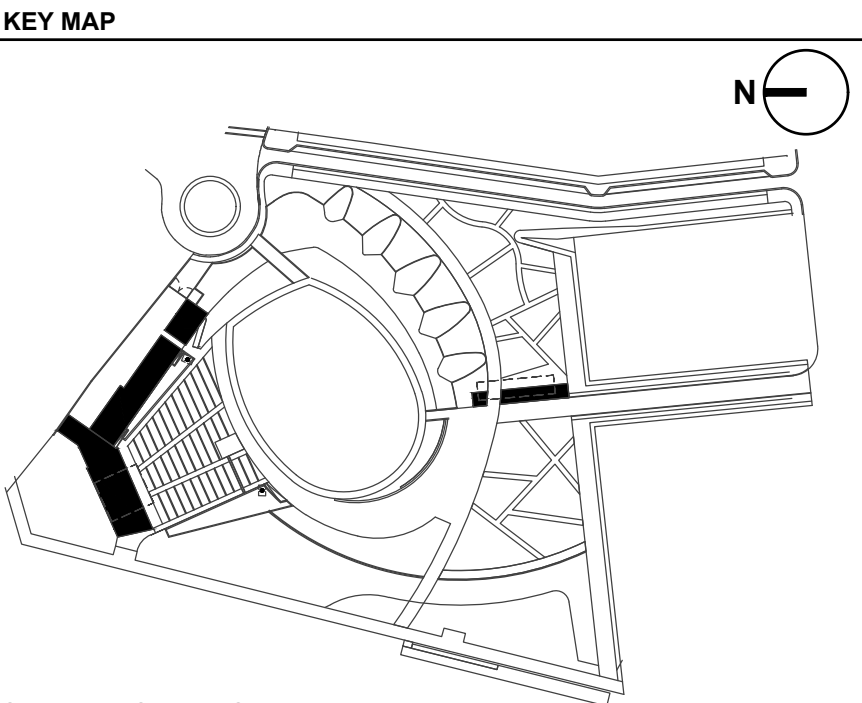

SHEET INFORMATION

Project No.: NWP 1701
Drawn By: CG, SL
Checked By: CG
Date: 12/04/2019
Scale: As indicated

SHEET TITLE

FIRE PROTECTION FLOOR PLANS PARK SUPPORT

SHEET NO.

FP-152-P4