

PROJECT INFORMATION

NORTH WATERFRONT PARK

10 COWAN STREET
WILMINGTON, NORTH CAROLINA

CITY OF WILMINGTON
Community Services Department
P.O. Box 1810, Wilmington, North Carolina 28402
City of Wilmington Project Code 3CPRK1860

Landscape Architecture = L
HARGREAVES JONES
180 Varick Street, Suite 204, New York, NY 10014
www.hargreavesjonesla.com
NC License #C-513

Architecture = A
SAGE & COOMBE ARCHITECTS
1215 Vestry Street, 5th Floor, New York, NY 10013
www.sageandcoombe.com

Acoustic/Theater/AV = AT
OAP.P.C.
77 Water Street, New York NY 10015
www.arup.com

Civil Engineering = C
Structural Engineering = S
Geotechnical Engineering = G
STEWART
223 S. West Street, Suite 1100, Raleigh, NC 27603
www.stewartinc.com
NC License #C-1051

Environmental Engineering = EE
SOIL & ENVIRONMENTAL CONSULTANTS, PA
8412 Falls of Neuse Road, Suite 104, Raleigh, NC 27615
www.sandec.com
EAGLE RESOURCES
215 West Moore Street, Southport, NC 28461
www.eagleresources.com

Irrigation = I
CLARK IRRIGATION DESIGN & CONSULTING, INC
P.O. Box 693, Lenoir, NC 28553
www.clarkirrigationdesign.com

Landscape Soil = LS
LANDIS, PLLC
3808 Bentley Brook Dr. Raleigh, NC 27612
www.landispllc.com

Mechanical Engineering = M
Electrical Engineering = E
Plumbing Engineering = P
Fire Protection = FP
CHEATHAM & ASSOCIATES, PA
3412 Enterprise Drive, Wilmington NC 28405
www.cheathamco.com
NC License #C-1073

Marine Structural Engineering = SM
ANDREW CONSULTING ENGINEERS
3811 Peachtree Avenue, Suite 300, Wilmington, NC 28403
www.andrewengineers.com

Water Fountain Design = WFF
DELTA FOUNTAINS
11494 Columbia Park Dr. W., Suite 4, Jacksonville, FL 32258
www.deltafountains.com

Lighting Design = EL
ILLIOTSON DESIGN ASSOCIATES
40 Worth Street, Room 703, New York NY 10013
www.illiotsondesign.com

KEYED NOTES:


CAPA 17109

PROGRESS DRAWINGS
DO NOT USE FOR CONSTRUCTION

ISSUE/REVISIONS

NO.	DESCRIPTION	DATE
1	30% CONSTRUCTION DOCUMENTS P3 & P4	06/07/2019
2	60% CONSTRUCTION DOCUMENTS P3	07/26/2019
3	95% CONSTRUCTION DOCUMENTS P3 & P4	12/04/2019

KEY MAP

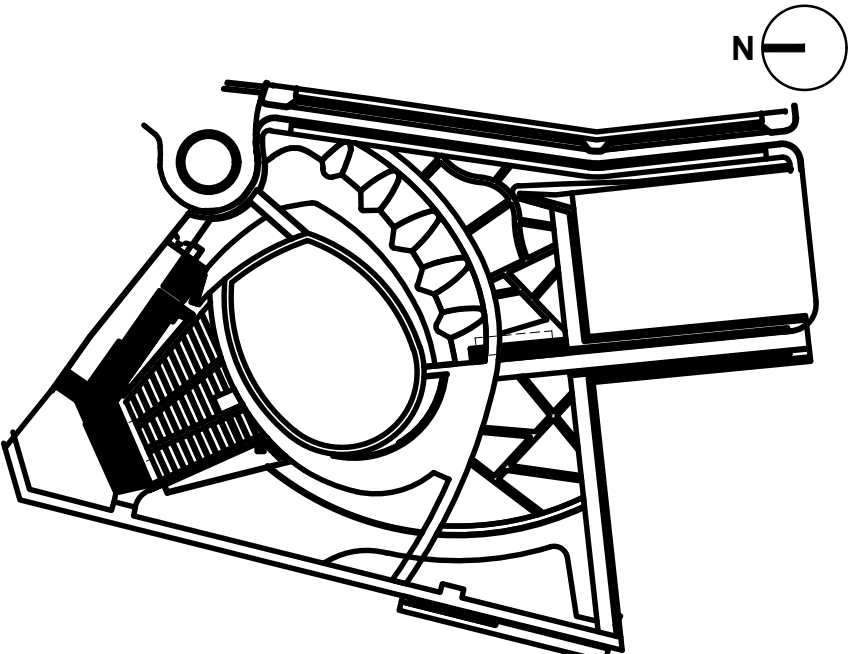

SHEET INFORMATION

Project No.: NWP 1701
Drawn By: KCL, TWT
Checked By: KL
Date: 07/26/2019
Scale: As indicated

SHEET TITLE


MECHANICAL PLANS - STAGE BUILDING

SHEET NO.

M-132-P3


3 MECHANICAL PLAN - STAGE BUILDING - ROOF

SCALE: 1/8" = 1'-0"

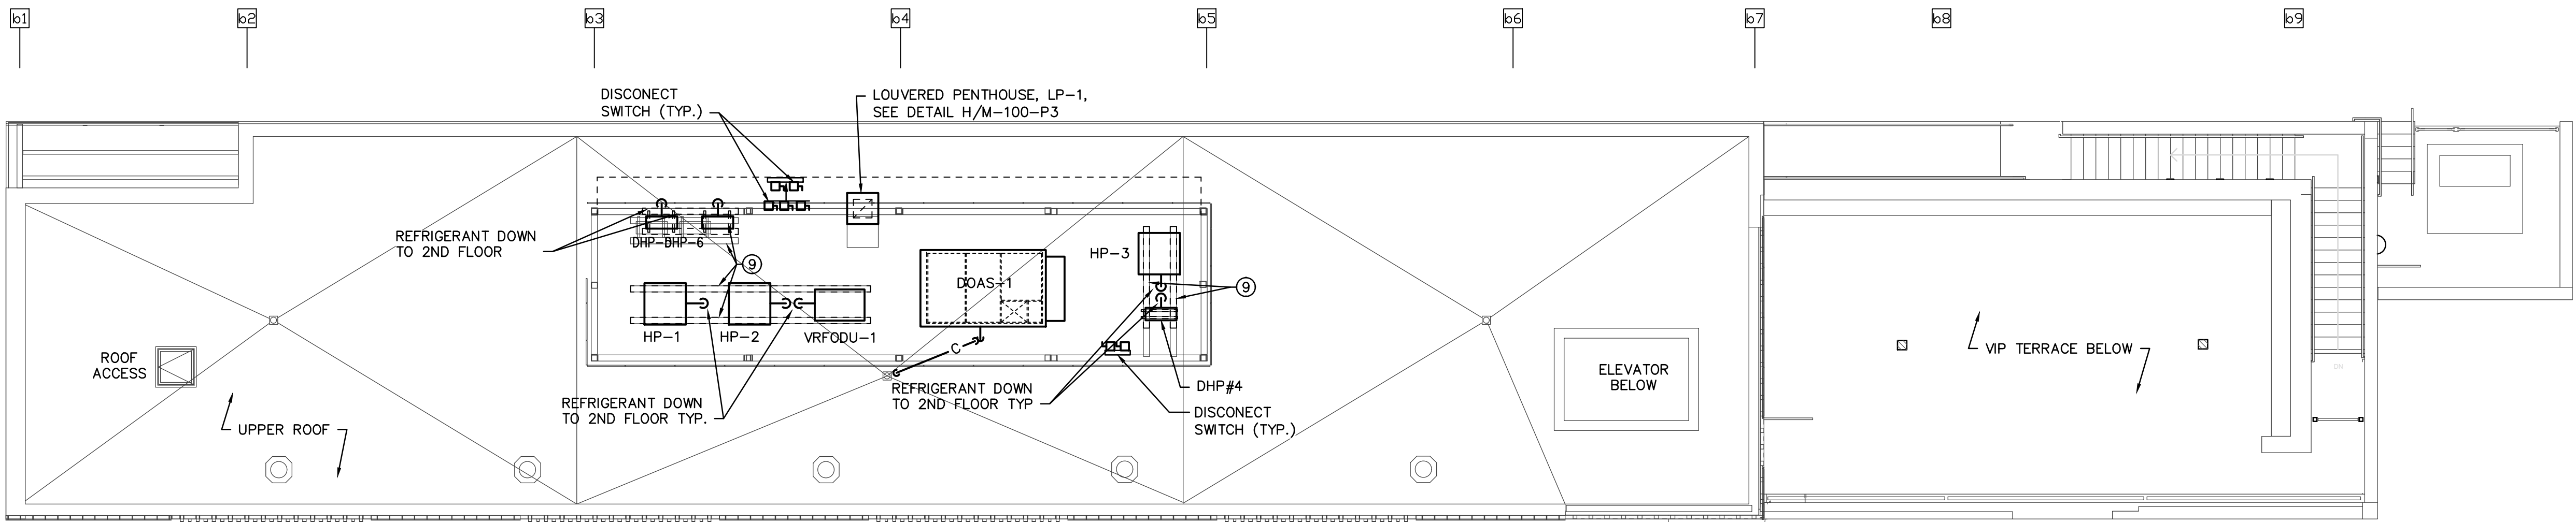

2 MECHANICAL PLAN - STAGE BUILDING - SECOND FLOOR

SCALE: 1/8" = 1'-0"

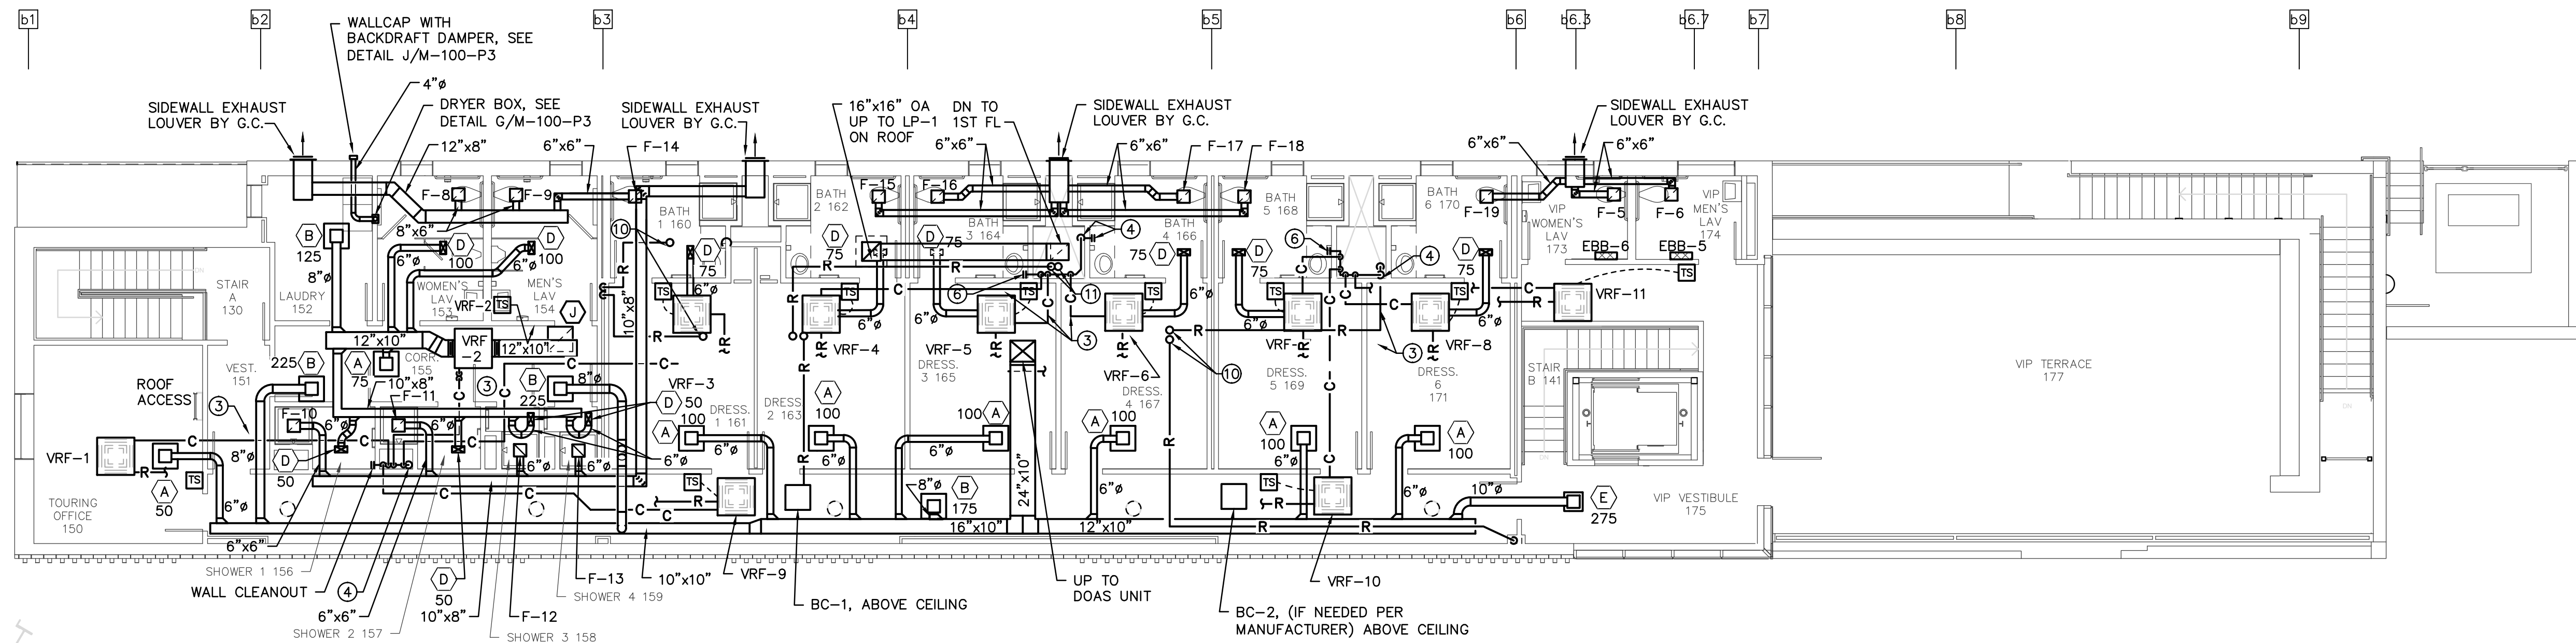

1 MECHANICAL PLAN - STAGE BUILDING - FIRST FLOOR

SCALE: 1/8" = 1'-0"

