

KEYED NOTES: (THIS SHEET ONLY)

- 6" RDL UP, SEE 3/P-132-P3 FOR CONTINUATION. PROVIDE CLEAN OUT AT BASE OF RISE.
- 6" RDL SLOPED AT 1/8"/FT.
- 2-1/2" CW, 3" V, 1/2" HWR, 1" HW, 4" W AND 1" G.
- 1/2" CW, 2" V, 1/2" HW AND 2" GW TO SK-2. INSTALL BALL VALVE ON CW & HW PIPING @ MAIN.
- 1/2" CW, 2" V, 1/2" HW AND 2" GW TO SK-1. INSTALL BALL VALVE ON CW & HW PIPING @ MAIN.
- RAISE SUMP DISCHARGE TO 1'-0" BFF.
- 3" CW MAIN BFF
- SUMP PUMP ALARM PANEL.
- 3" RDL UP TO 3" TERRACE DRAIN (520FT², 23 GPM).
- 3" RDL UP TO 3" TERRACE DRAIN (430FT², 20 GPM).
- 3" RDL SLOPED AT 1/4"/FT.
- INSTALL 1/2"G TO REG#3. INSTALL 1/2"G FROM REG#3 TO GAS DRYER. PIPE GAS FULL SIZE TO EQUIPMENT BEFORE REDUCING TO EQUIPMENT CONNECTION SIZE.
- 1"G UP, SEE 2/P-132-P3 FOR CONTINUATION.
- 1"G DN, SEE 1/P-132-P3 FOR CONTINUATION.

GENERAL NOTES:
1. INVERT ELEVATIONS ARE WITH RESPECT TO THE LOWER (NORTH SIDE) FLOOR ELEVATION.
2. SEE ARCHITECTURAL FIXTURE SCHEDULE

PROJECT INFORMATION
NORTH WATERFRONT PARK
10 COWAN STREET
WILMINGTON, NORTH CAROLINA

CITY OF WILMINGTON
Community Services Department
PO Box 1810, Wilmington, North Carolina 28402
City of Wilmington Project Code 3CPRK1860

Landscape Architecture = L
HARGREAVES JONES
180 Varick Street, Suite 204, New York, NY 10014
www.hargreavesjonesla.com
NC License #C-513

Architecture = A
SAGE & COOMBE ARCHITECTS
12-16 Vestry Street, 5th Floor, New York, NY 10013
www.sageandcoombe.com

Acoustic/Theater/AV = AT
OAP.P.C.
77 Water Street, New York NY 10015
www.arup.com

Civil Engineering = C
Structural Engineering = S
Geotechnical Engineering = G
STEWART
223 S. West Street, Suite 1100, Raleigh, NC 27603
www.stewartinc.com
NC License #C-1051

Environmental Engineering = EE
SOIL & ENVIRONMENTAL CONSULTANTS, PA
8412 Falls of Neuse Road, Suite 104, Raleigh, NC 27615
www.sandec.com
EAGLE RESOURCES
215 West Moore Street, Southport, NC 28461
www.eagleresources.com

Irrigation = I
CLARK IRRIGATION DESIGN & CONSULTING, INC
P.O. Box 605, Lenoir, GA 30553
www.clarkirrigationdesign.com

Landscape Soil = LS
LANDIS, PLLC
5906 Bentley Brook Dr. Raleigh, NC 27612
www.landispllc.com

Mechanical Engineering = M
Electrical Engineering = E
Plumbing Engineering = P
Fire Protection = FP
CHEATHAM & ASSOCIATES, PA
3412 Enterprise Drive, Wilmington NC 28405
www.cheathamco.com
NC License #C-1073

Marine Structural Engineering = SM
ANDREW CONSULTING ENGINEERS
3811 Peachtree Avenue, Suite 300, Wilmington, NC 28403
www.andrewengineers.com

Water Fountain Design = WF
DELTA FOUNTAINS
11454 Columbia Park Dr. W., Suite 4, Jacksonville, FL 32258
www.deltafountains.com

Lighting Design = EL
TILLOTSON DESIGN ASSOCIATES
40 North Street, Room 703, New York NY 10013
www.tillotsondesign.com

SEAL/SIGNATURE


CAPA 17109

PROGRESS DRAWINGS
DO NOT USE FOR CONSTRUCTION

ISSUE/REVISIONS

NO.	DESCRIPTION	DATE
1	30% CONSTRUCTION DOCUMENTS P3 & P4	06/07/2019
2	60% CONSTRUCTION DOCUMENTS P3	07/26/2019
3	95% CONSTRUCTION DOCUMENTS P3 & P4	12/04/2019

KEY MAP

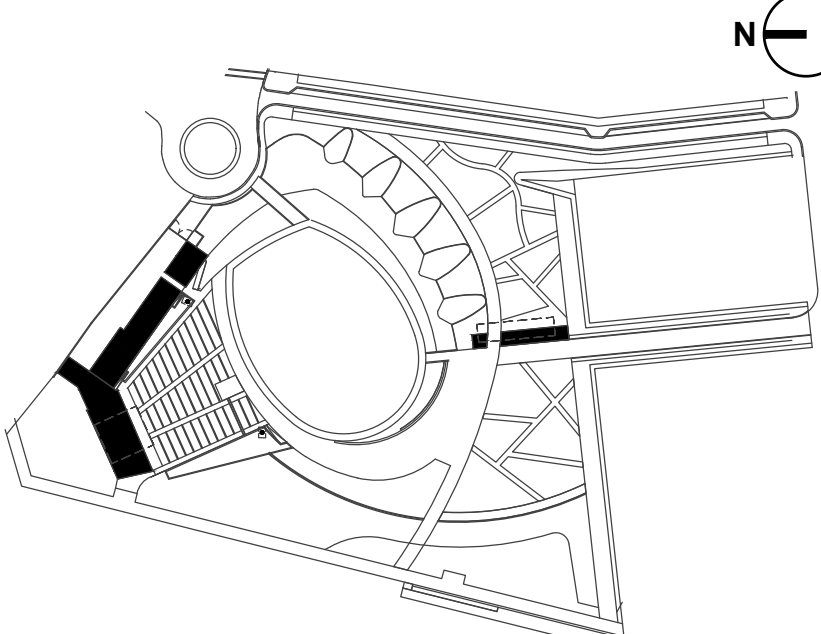

SHEET INFORMATION


Project No.: NWP 1701
Drawn By: MBSL
Checked By: MBSL
Date: 12/04/2019
Scale: As indicated

SHEET TITLE


PLUMBING FLOOR PLANS
STAGE BUILDING

SHEET NO.


P-132-P3

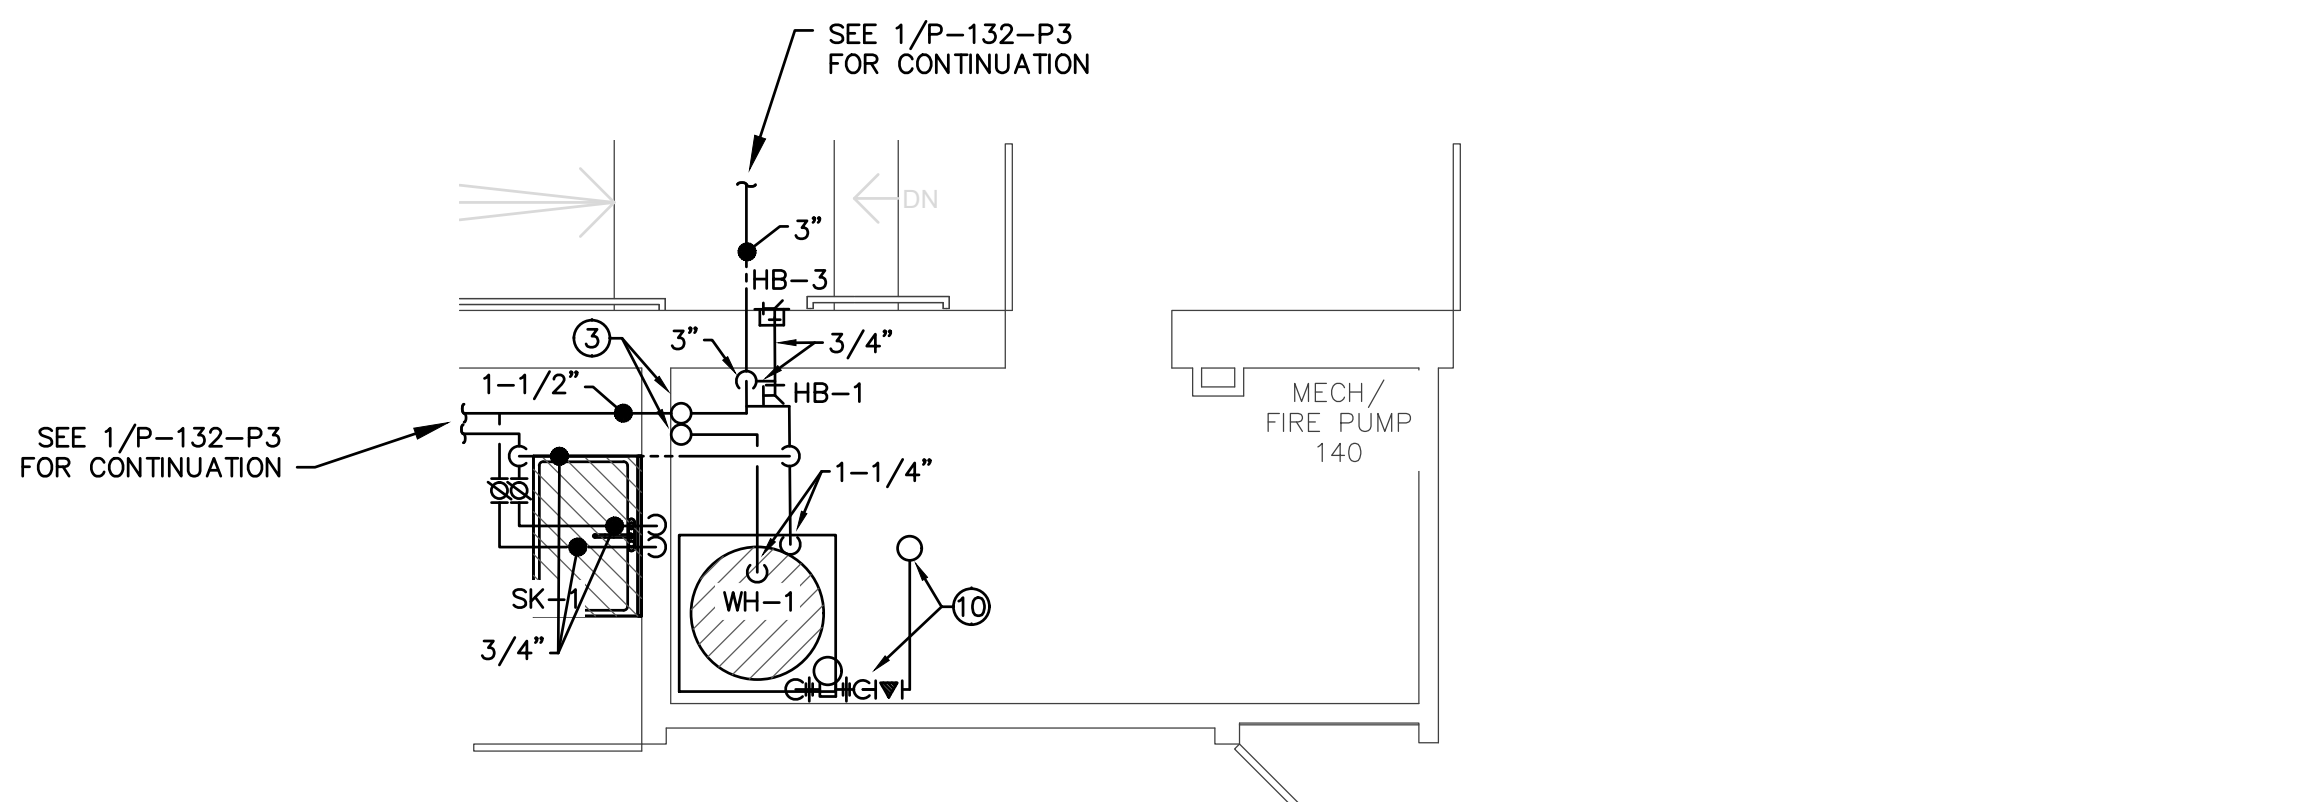


6 ENLARGED MECH FIRE PUMP DOMESTIC WATER & GAS
SCALE: 1/4" = 1'-0"
GRAPHIC SCALE: 1/4" = 1'-0" TRUE NORTH

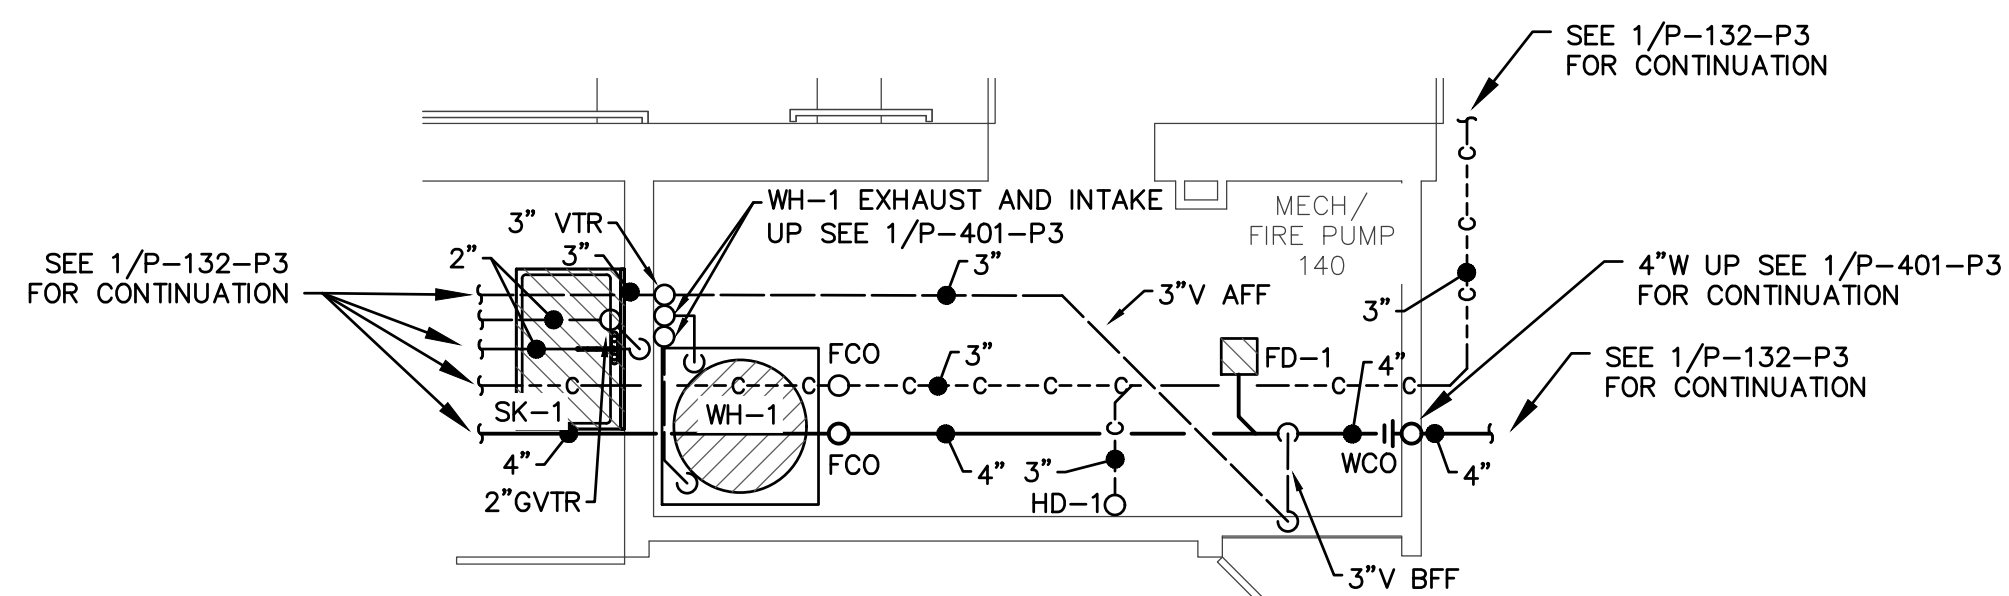

5 ENLARGED MECH FIRE PUMP WASTE & VENT
SCALE: 1/4" = 1'-0"
GRAPHIC SCALE: 1/4" = 1'-0" TRUE NORTH

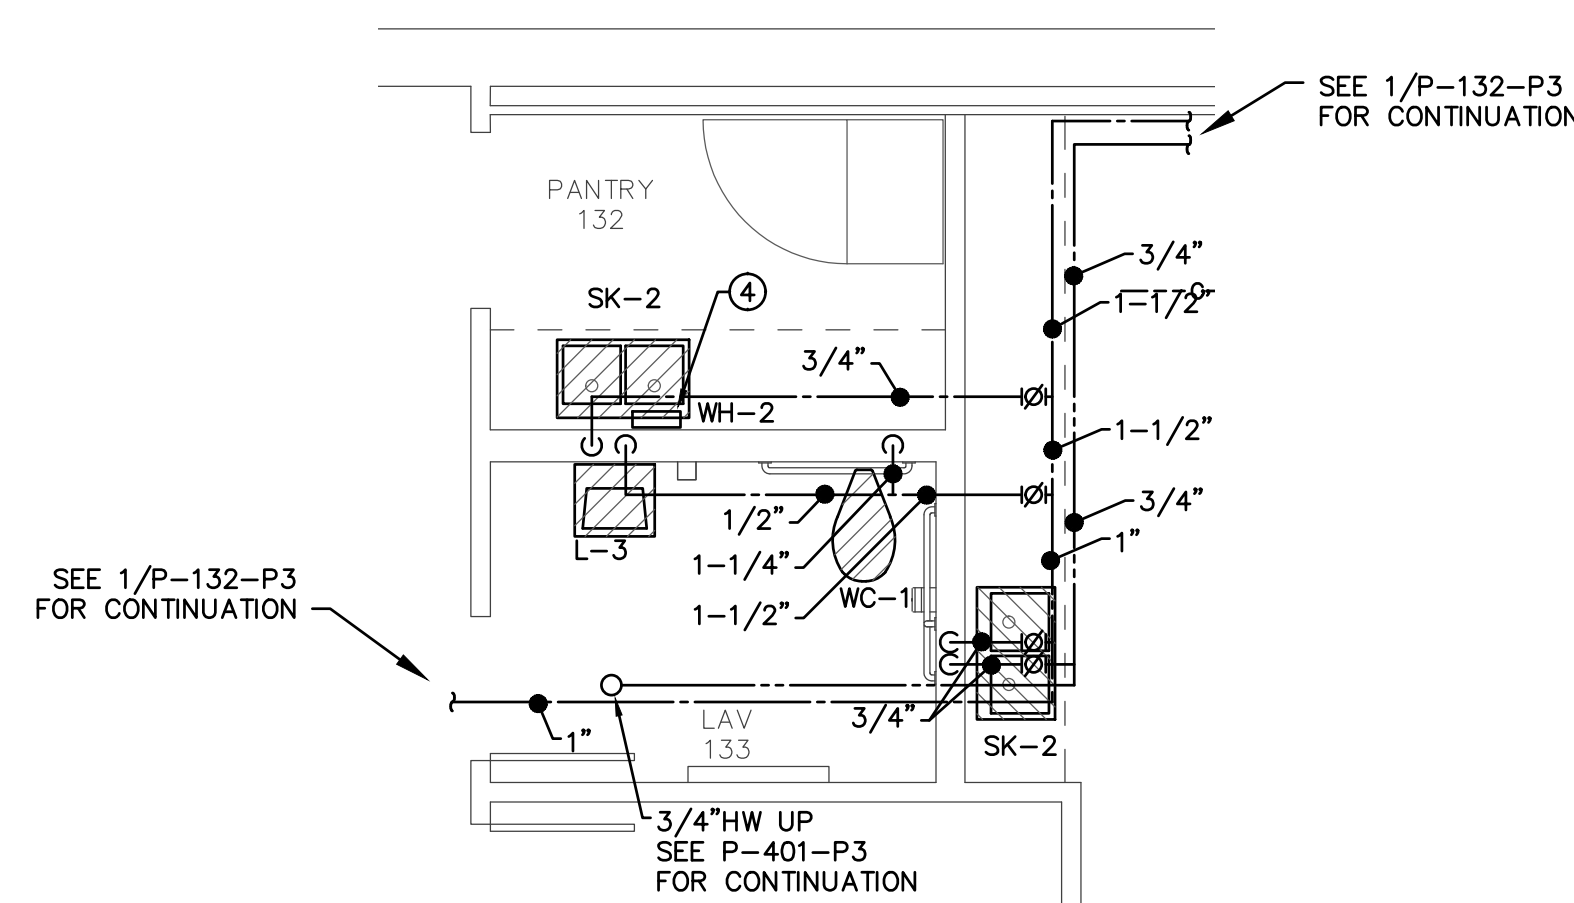

4 ENLARGED PANTRY DOMESTIC WATER
SCALE: 1/4" = 1'-0"
GRAPHIC SCALE: 1/4" = 1'-0" TRUE NORTH

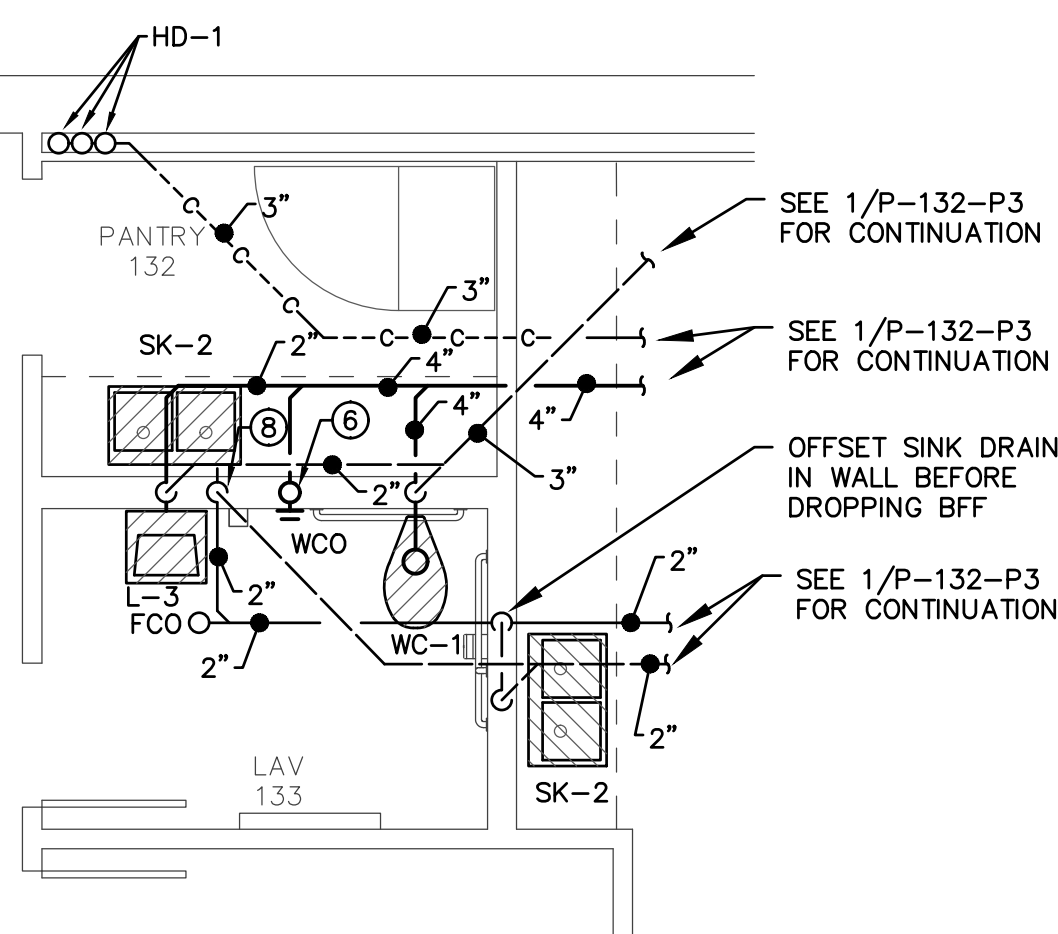


3 ENLARGED PANTRY WASTE & VENT
SCALE: 1/4" = 1'-0"
GRAPHIC SCALE: 1/4" = 1'-0" TRUE NORTH


KEYED NOTES: (THIS SHEET ONLY)

- CIRCUIT VENT OR COMMON VENT SERVING MULTIPLE FIXTURES.
- 2"W AFF DN TO BFF. 2" COMMON VENT UP.
- 2-1/2" CW, 1-1/4" HW UP, SEE 2/P-401-P3
- INSTALL WH-2 WITHIN CASEWORK BELOW SK-2. WH-2 SHALL SERVE SK-2 IN PANTRY 132 AS WELL AS L-3 IN LAV 133.
- 2-1/2" CW, 3/4" HWR AND 1" HW.
- 4" W UP, SEE 1/P-401-P3.
- PROVIDE WCO ON WASTE RISER BELOW LAVATORY OR SINK.
- OFFSET GREASE WASTE WITHIN CASEWORK TO AVOID INTERFERENCE WITH DOMESTIC WATER AND WASTE SERVING ADJACENT LAVATORY. PROVIDE WCO BELOW SINK.
- 3"V & 2-1/2" CW UP IN CHASE, SEE P-401-P3 FOR CONTINUATION. SUPPORT PIPING IN CHASE ON INTERIOR SIDE OF CHASE WITH UNISTRUT. INSULATION AND VAPOR BARRIER SHALL NOT BE PENETRATED BY HANGER OR SUPPORTS.
- INSTALL 3/4"G FROM 2ND FL TO REG#1. SEE 1/P-401-P3 FOR CONTINUATION. INSTALL 2"G FROM REG#1 TO WH-1. PIPE GAS FULL SIZE TO EQUIPMENT BEFORE REDUCING TO EQUIPMENT CONNECTION SIZE.
- 3/4" CW UP TO HB-3. SEE 2/P-132-P3 FOR CONTINUATION.

GENERAL NOTES:
1. SEE ARCHITECTURAL FIXTURE SCHEDULE

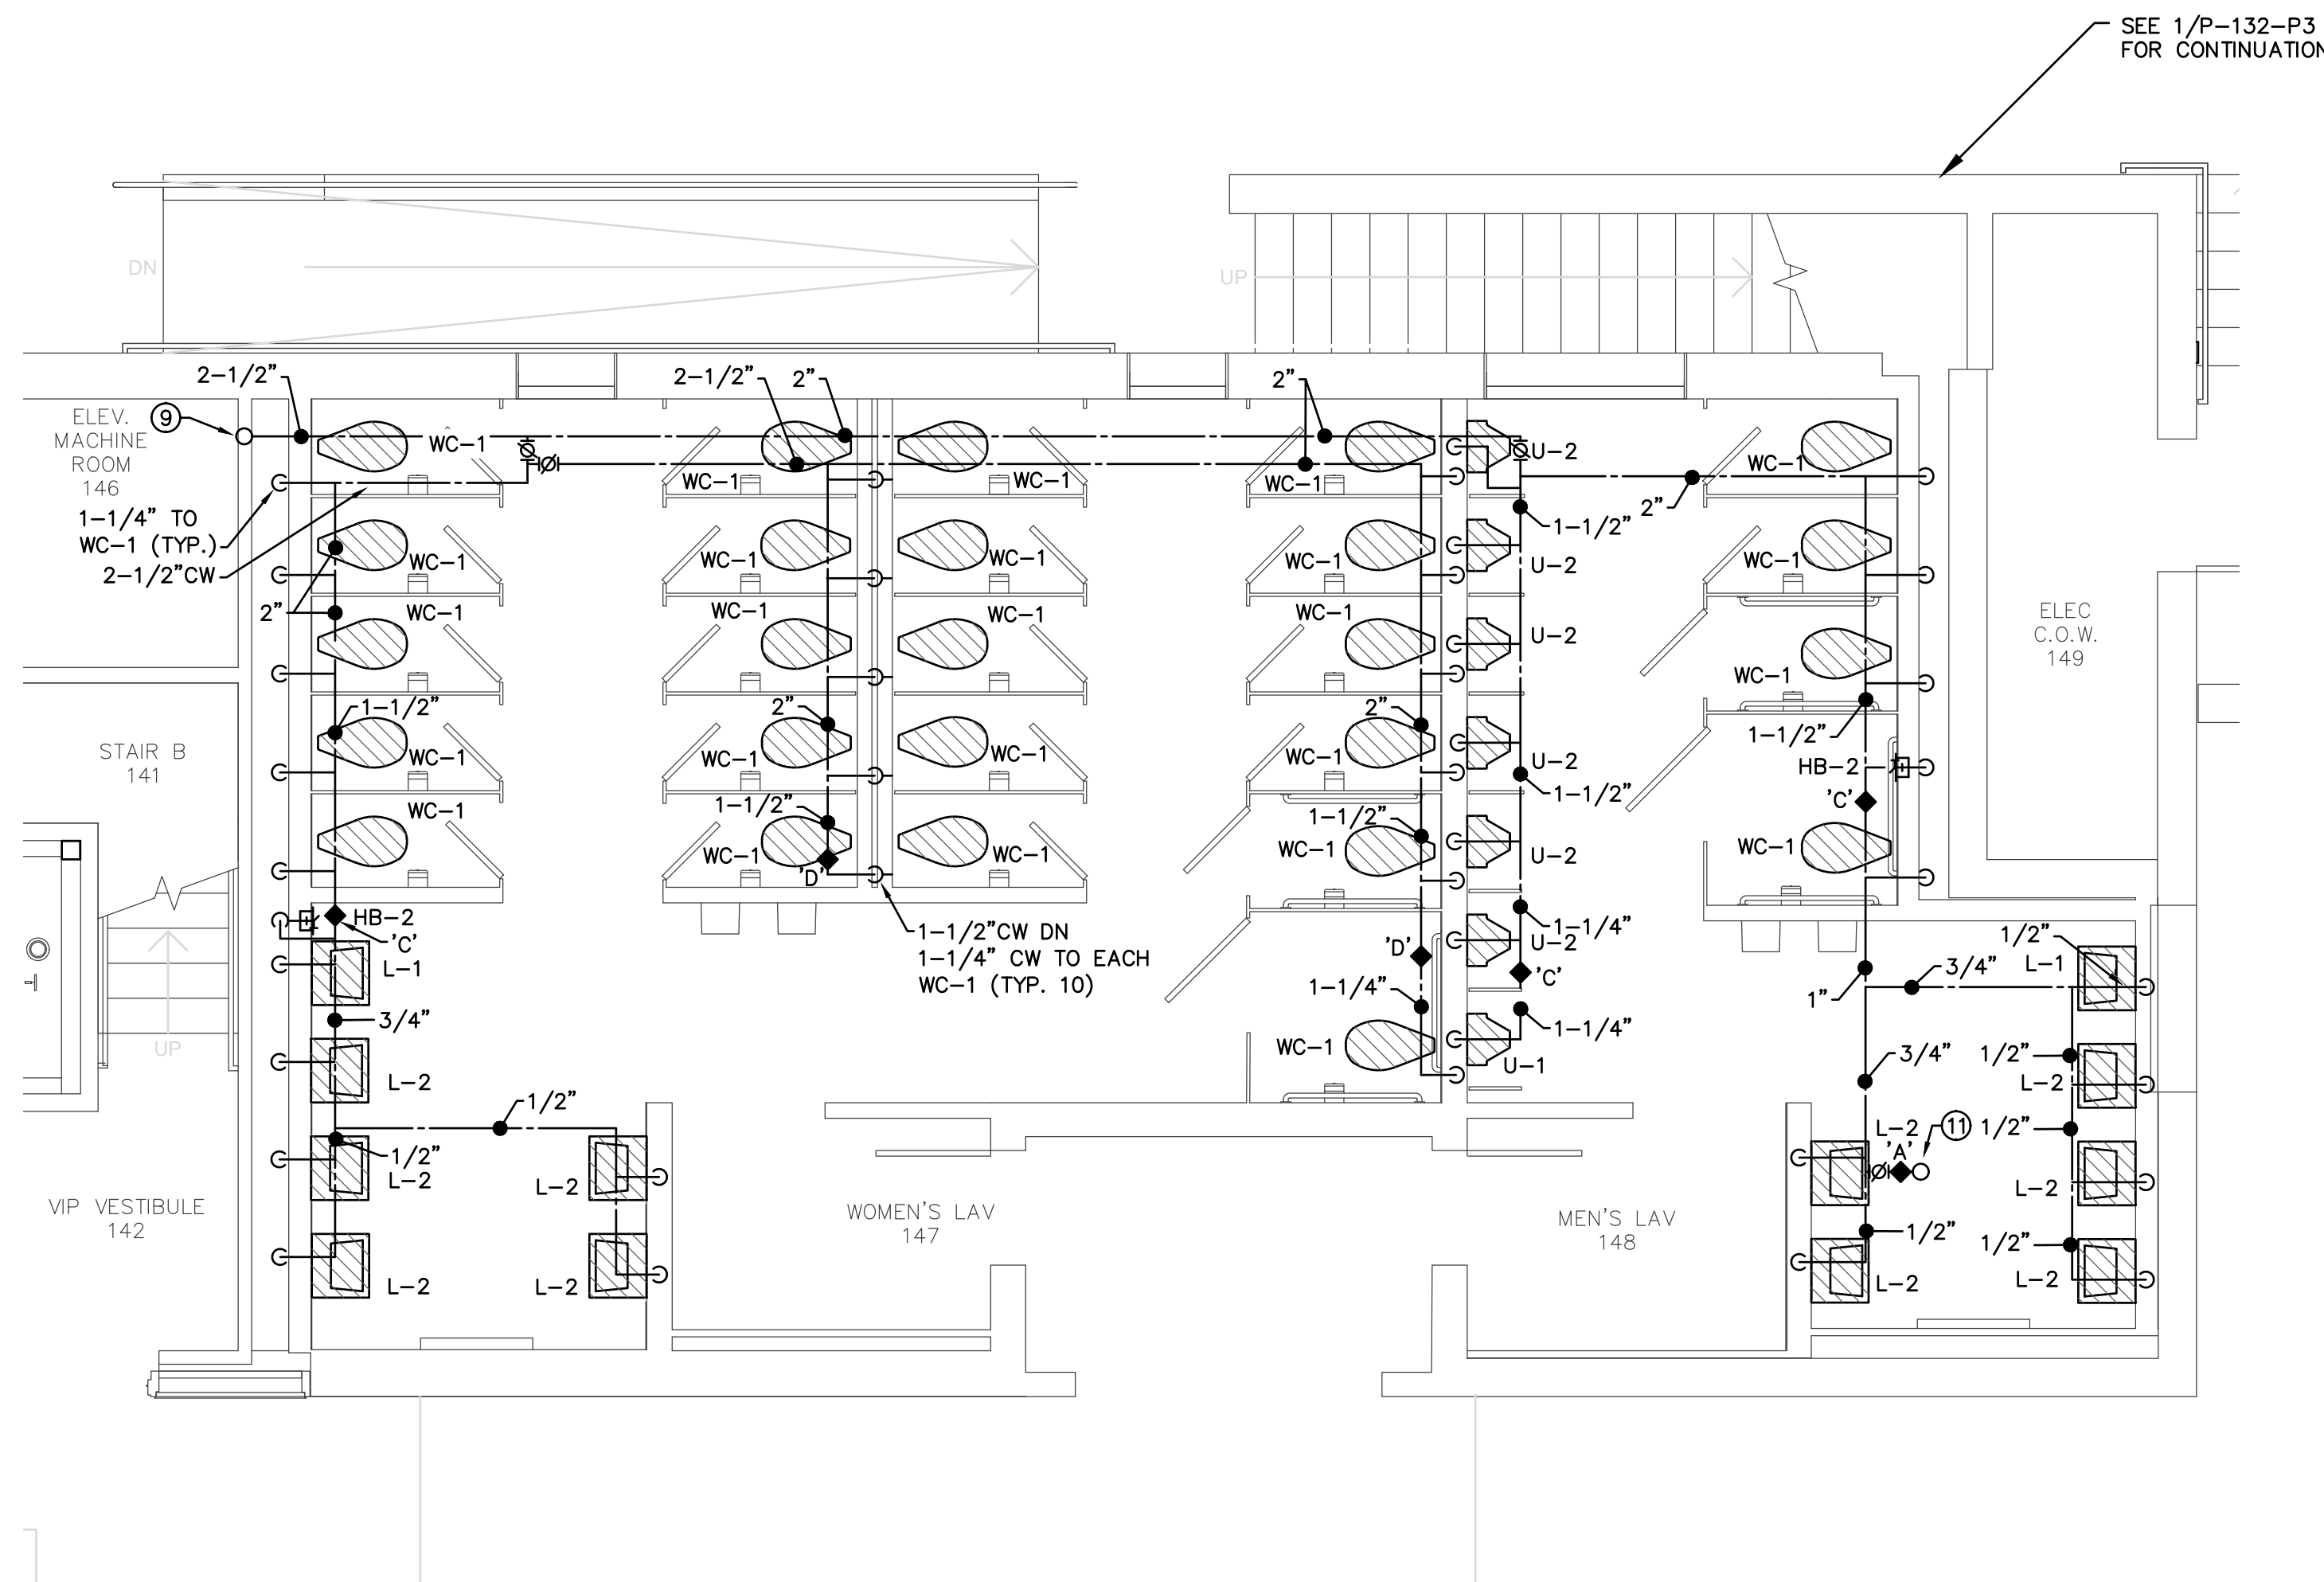

2 ENLARGED RESTROOMS DOMESTIC WATER & GAS
SCALE: 1/4" = 1'-0"
GRAPHIC SCALE: 1/4" = 1'-0" TRUE NORTH

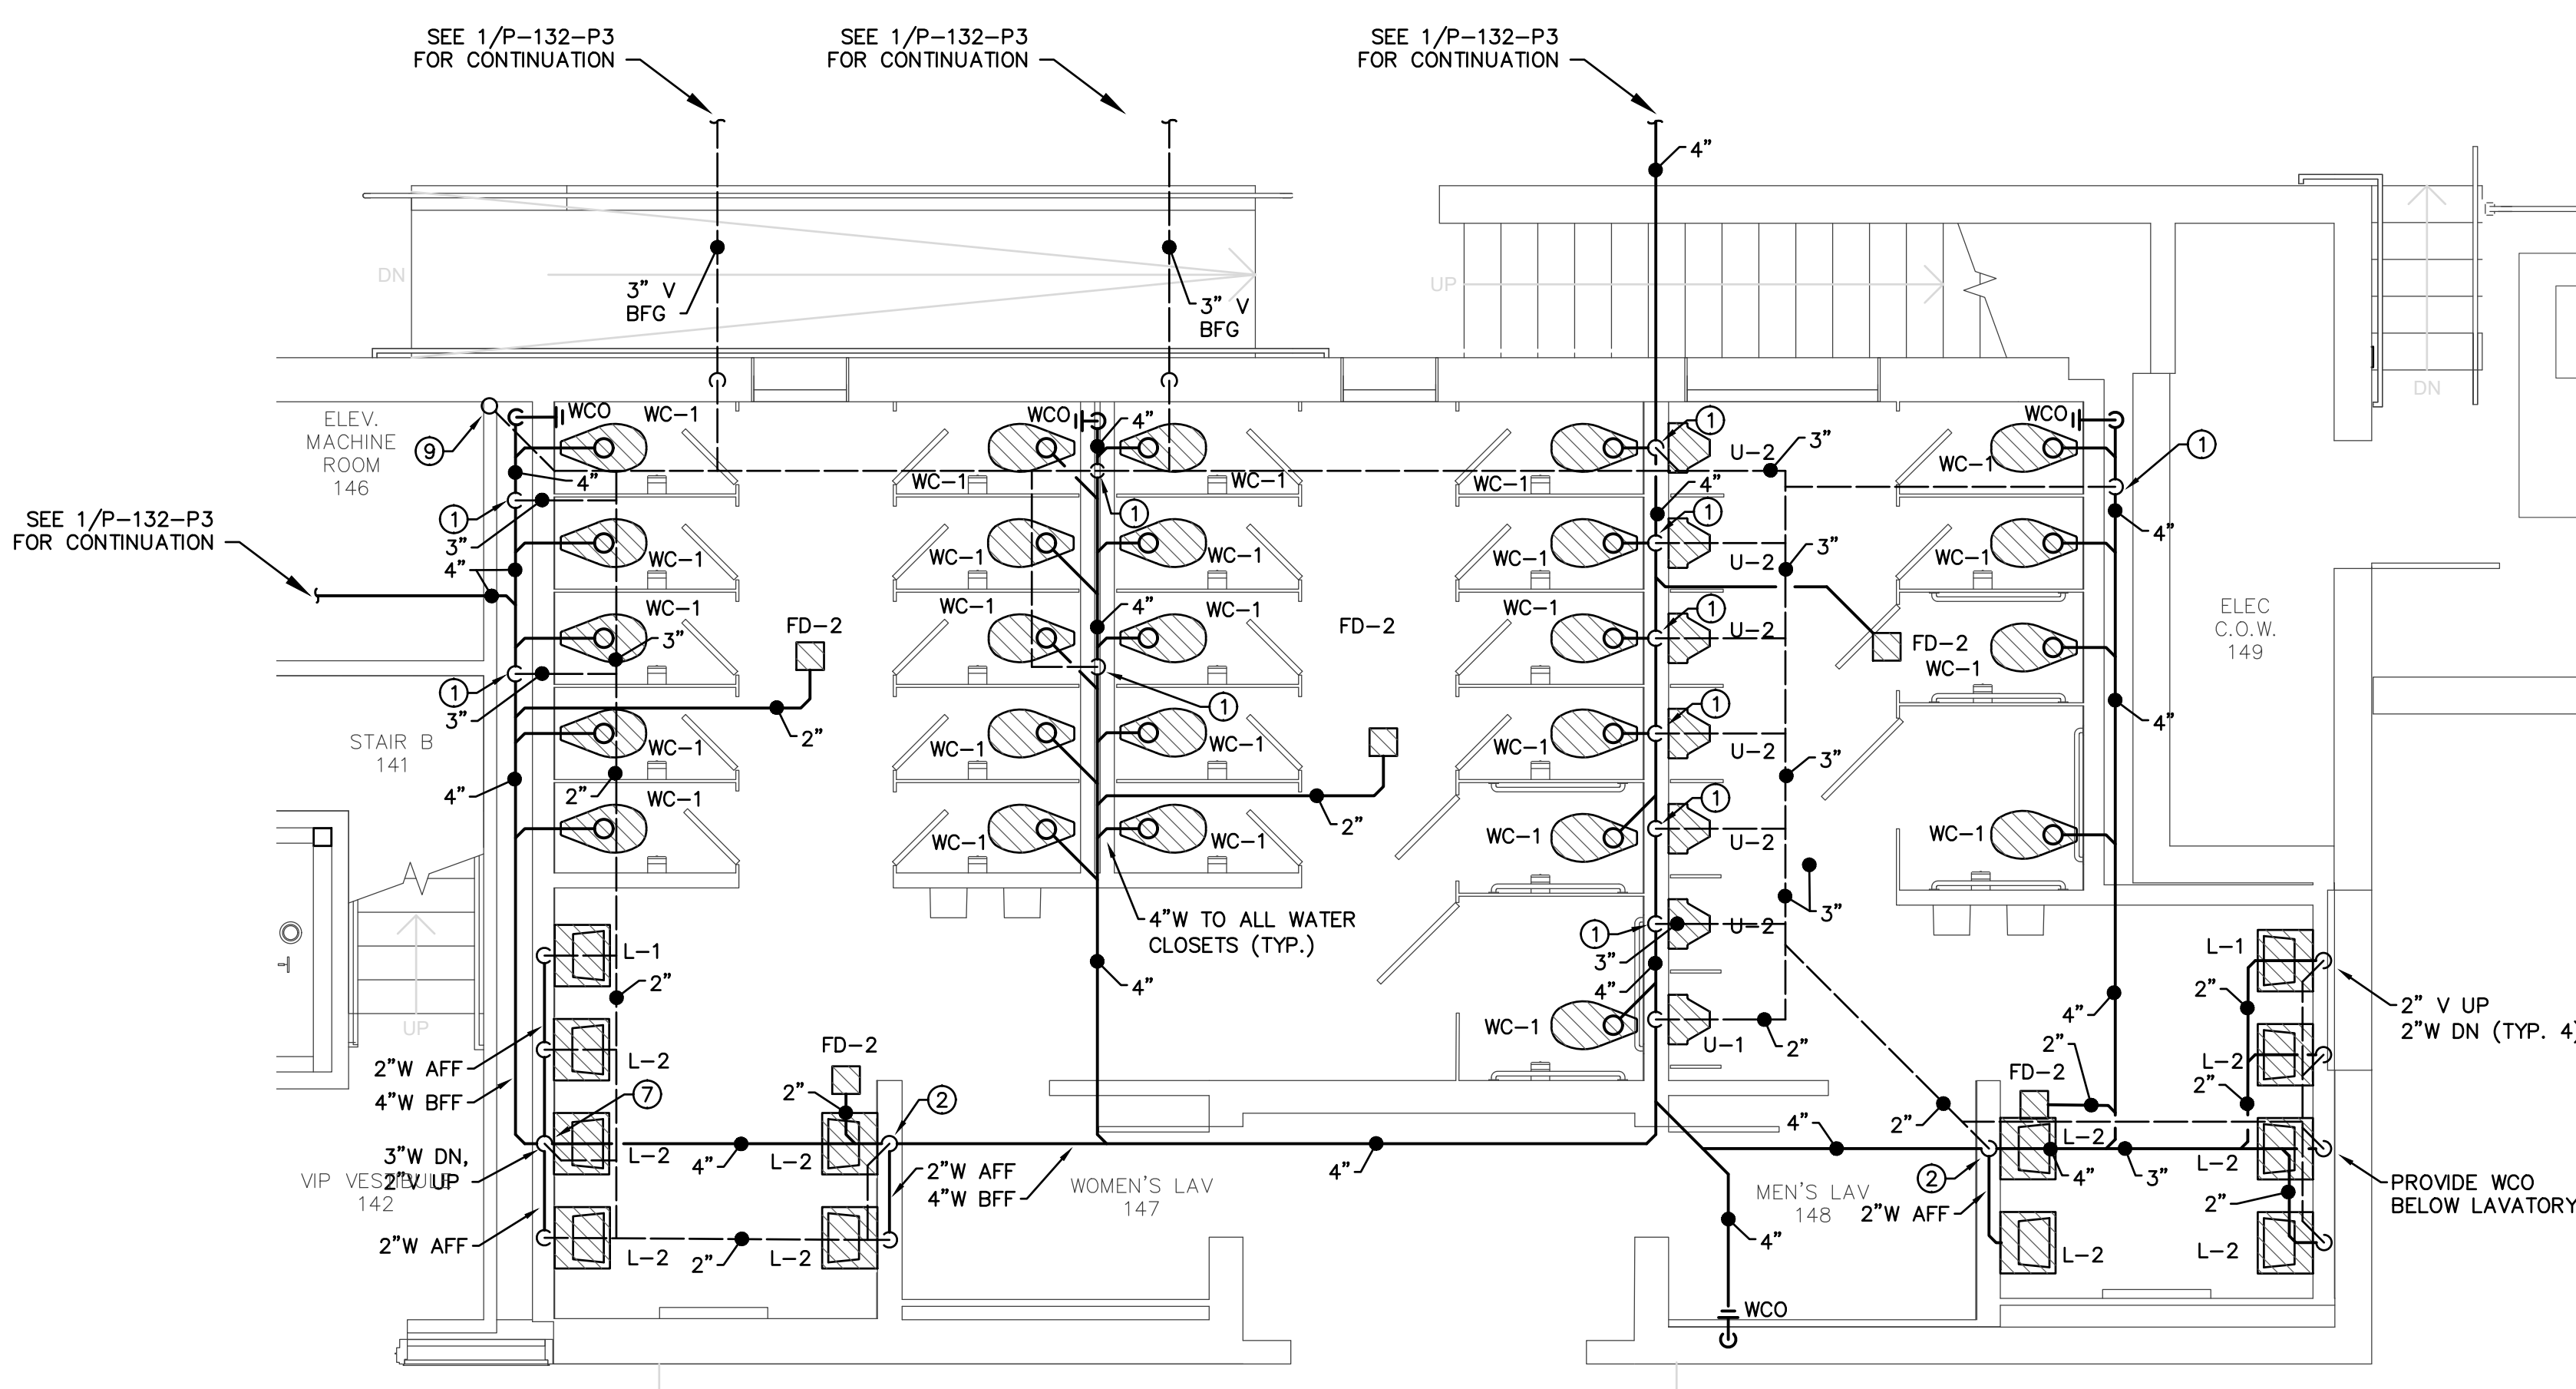

1 ENLARGED RESTROOMS WASTE & VENT
SCALE: 1/4" = 1'-0"
GRAPHIC SCALE: 1/4" = 1'-0" TRUE NORTH

PROJECT INFORMATION

NORTH WATERFRONT PARK

10 COWAN STREET
WILMINGTON, NORTH CAROLINA

CITY OF WILMINGTON
Community Services Department
PO Box 1810, Wilmington, North Carolina 28402
City of Wilmington Project Code 3CPRK1860

Landscape Architecture = L
HARGREAVES JONES
180 Varick Street, Suite 204, New York, NY 10014
www.hargreavesjonesla.com
NC License #C-513

Architecture = A
SAGE & COOMBE ARCHITECTS
12-16 Vestry Street, 5th Floor, New York, NY 10013
www.sageandcoombe.com

Acoustic/Theater/AV = AT
OAP.P.C.
77 Water Street, New York NY 10015
www.arup.com

Civil Engineering = C
Structural Engineering = S
Geotechnical Engineering = G
STEWART
223 S. West Street, Suite 1100, Raleigh, NC 27603
www.stewartinc.com
NC License #C-1051

Environmental Engineering = EE
SOIL & ENVIRONMENTAL CONSULTANTS, PA
8412 Falls of Neuse Road, Suite 104, Raleigh, NC 27615
www.sandec.com
EAGLE RESOURCES
215 West Moore Street, Southport, NC 28461
www.eagleresources.com

Irrigation = I
CLARK IRRIGATION DESIGN & CONSULTING, INC
P.O. Box 695, Lenoir, GA 30553
www.clarkirrigationdesign.com

Landscape Soil = LS
LANDIS, PLLC
5908 Bentley Brook Dr. Raleigh, NC 27612
www.landispllc.com

Mechanical Engineering = M
Electrical Engineering = E
Plumbing Engineering = P
Fire Protection = FP
CHEATHAM & ASSOCIATES, PA
3112 Enterprise Drive, Wilmington, NC 28405
www.chealthampa.com
NC License #C-1073

Marine Structural Engineering = SM
ANDREW CONSULTING ENGINEERS
3811 Piedmont Avenue, Suite 300, Wilmington, NC 28403
www.andrewengineers.com

Water Fountain Design = WF
DELTA FOUNTAINS
11494 Columbia Park Dr. W., Suite 4, Jacksonville, FL 32258
www.deltafountains.com

Lighting Design = EL
TILLOTSON DESIGN ASSOCIATES
40 North Street, Room 703, New York NY 10013
www.tillotsondesign.com

SEAL/SIGNATURE


CAPA 17109

PROGRESS DRAWINGS
DO NOT USE FOR CONSTRUCTION

ISSUE/REVISIONS

NO.	DESCRIPTION	DATE
1	30% CONSTRUCTION DOCUMENTS P3 & P4	06/07/2019
2	60% CONSTRUCTION DOCUMENTS P3	07/26/2019
3	95% CONSTRUCTION DOCUMENTS P3 & P4	12/04/2019

KEY MAP

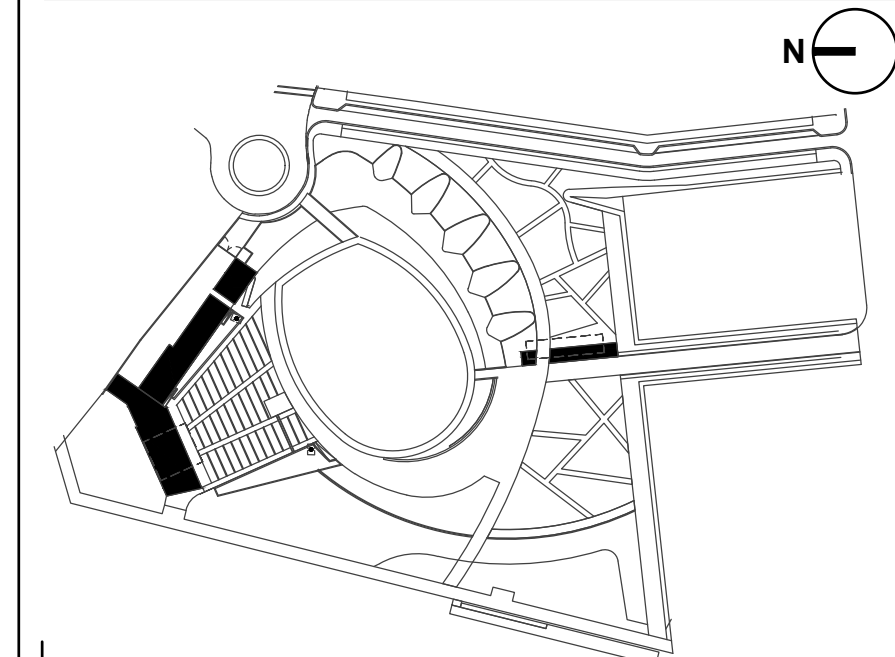

SHEET INFORMATION

Project No.: NWP 1701
Drawn By: CG, SL
Checked By: CG
Date: 12/04/2019
Scale: As indicated


SHEET TITLE

**ENLARGED FIRST FLOOR
PLUMBING PLANS STAGE
BUILDING**


SHEET NO.

P-400-P3

N
M
L
K
J
I
H
G
F
E
D
C
B
A

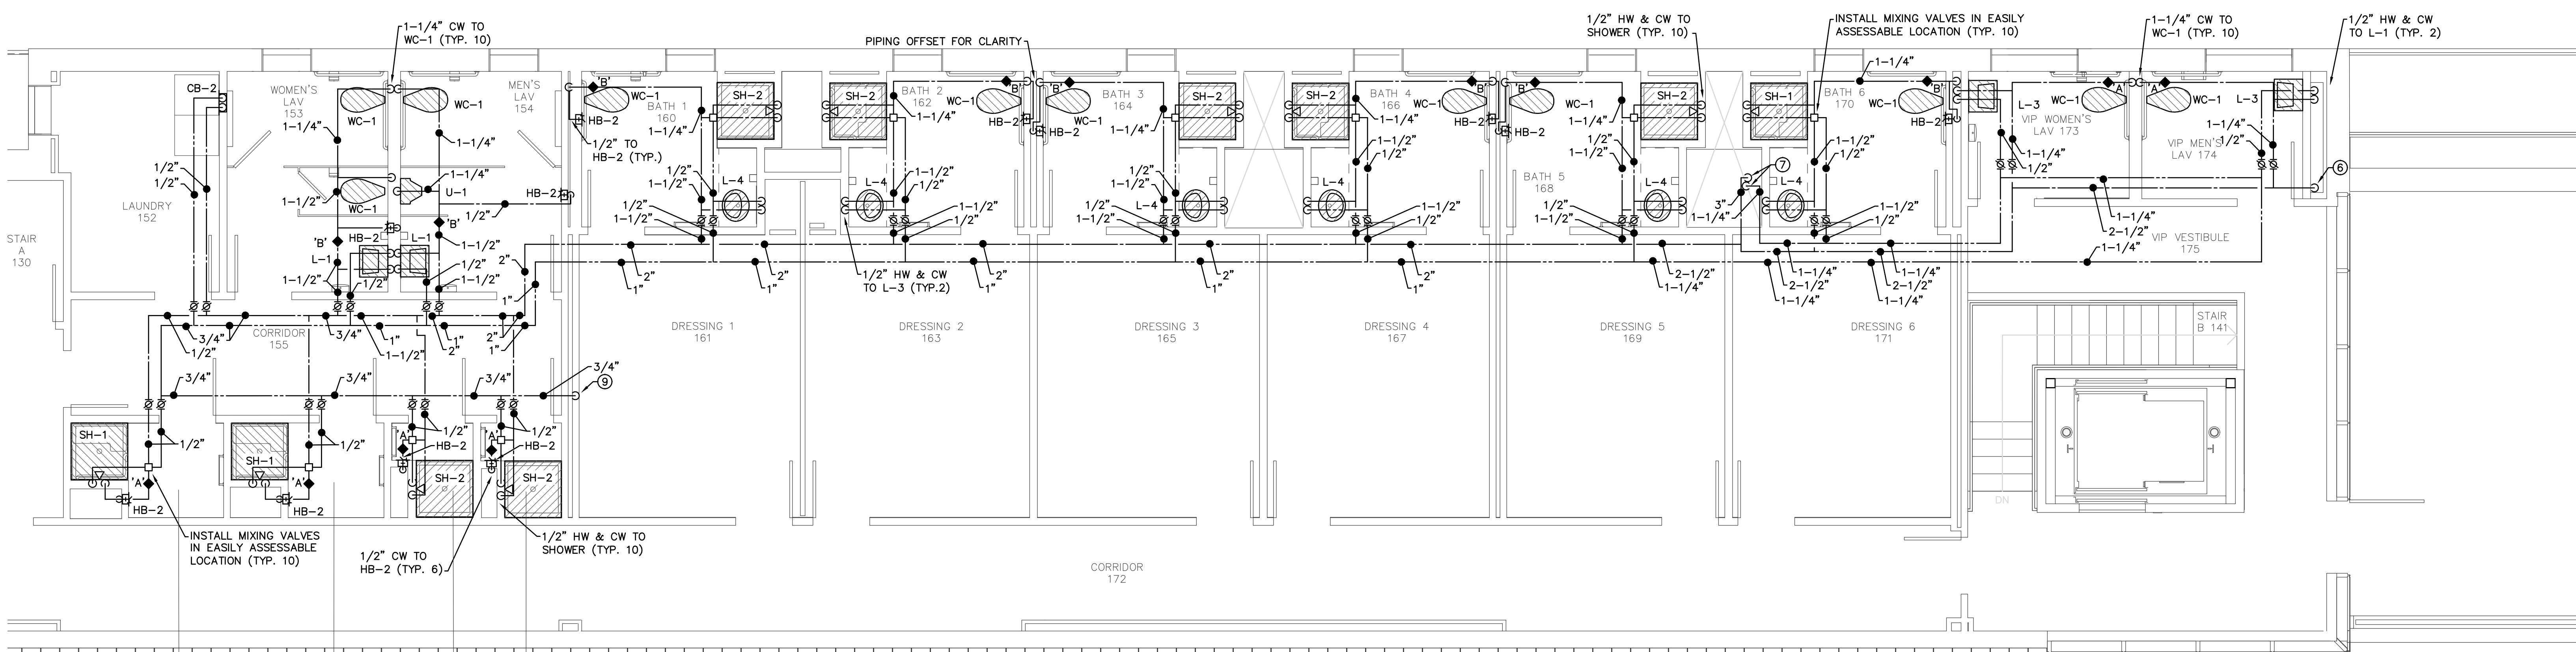

2 ENLARGED SECOND FLOOR DOMESTIC WATER & GAS
SCALE: 1/4" = 1'-0"
GRAPHIC SCALE: 1/4" = 1'-0" TRUE NORTH

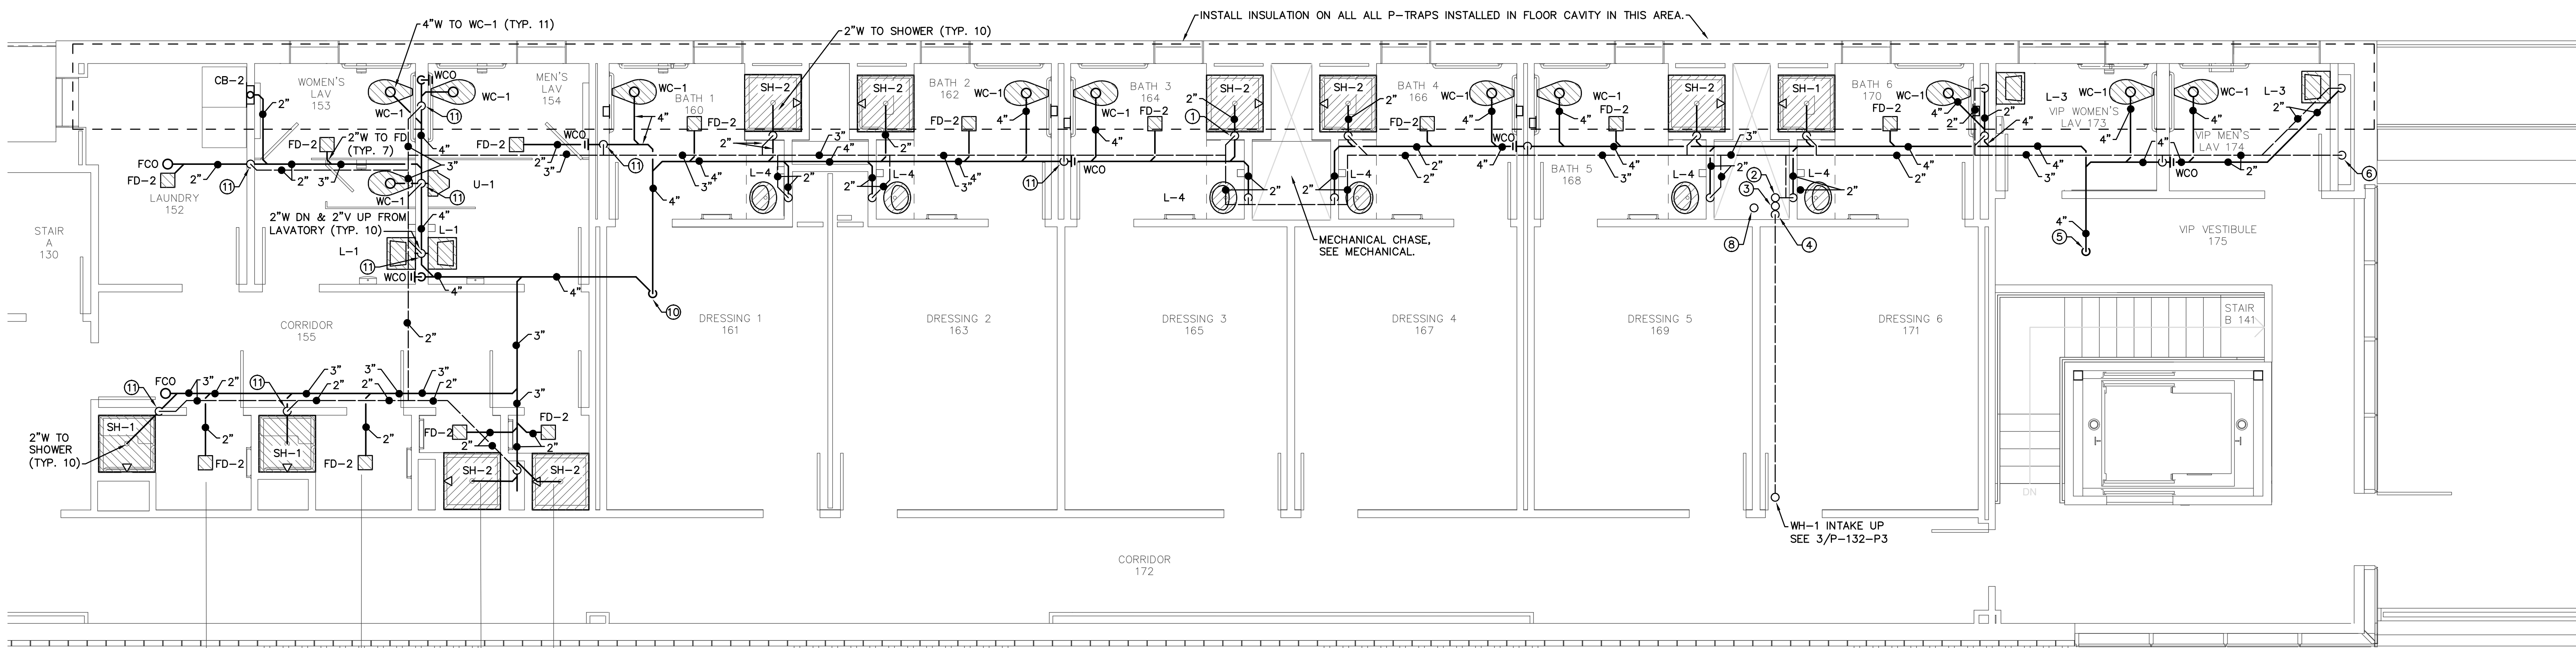

1 ENLARGED SECOND PLAN WASTE & VENT
SCALE: 1/4" = 1'-0"
GRAPHIC SCALE: 1/4" = 1'-0" TRUE NORTH

KEYED NOTES: (THIS SHEET ONLY)

1. INSTALL WCO BELOW LAVATORY COUNTER ON VENT RISE.
2. 3" V UP AND DOWN, SEE 5/P-400-P3 & 3/P-132-P3.
3. WH-1 EXHAUST UP AND DOWN, SEE 5/P-400-P3 & 3/P-132-P3.
4. WH-1 INTAKE DOWN, SEE 5/P-400-P3.
5. 4" WASTE DOWN, SEE 5/P-400-P3.
6. 2-1/2" CW & 3" V DN, SEE 1&2/P-400-P3 FOR CONTINUATION. SUPPORT PIPING IN CHASE ON INTERIOR SIDE OF CHASE WITH UNISTRUT. INSULATION AND VAPOR BARRIER SHALL NOT BE PENETRATED BY HANGER OR SUPPORTS.
7. 1-1/4" HW & 3" CW DOWN, SEE 6/P-400-P3.
8. 2" GREASE WASTE VENT UP AND DOWN, SEE 1&3/P-132-P3.
9. 3/4" HOT WATER DOWN TO , SEE 1/P-132-P3.
10. 4" W DOWN, SEE 3/P-400-P3.
11. COMMON VENT OR CIRCUIT VENT SERVING MULTIPLE FIXTURES.

GENERAL NOTES:
1. SEE ARCHITECTURAL FIXTURE SCHEDULE

PROJECT INFORMATION

NORTH WATERFRONT PARK

10 COWAN STREET
WILMINGTON, NORTH CAROLINA

CITY OF WILMINGTON
Community Services Department
PO Box 1810, Wilmington, North Carolina 28402
City of Wilmington Project Code 3CPK1860

Landscape Architecture = L
HARGREAVES JONES
180 Varick Street, Suite 204, New York, NY 10014
www.hargreavesjonesla.com
NC License #C-513

Architecture =
SAGE & COOMBE ARCHITECTS
12-16 Vestry Street, 5th Floor, New York, NY 10013
www.sageandcoombe.com

Acoustic/Theater/AV = AT
CAP.P.C.
77 Water Street, New York NY 10015
www.arup.com

Civil Engineering = C
Structural Engineering = S
Geotechnical Engineering = G
STEWART
223 S. West Street, Suite 1100, Raleigh, NC 27603
www.stewartinc.com
NC License #C-1051

Environmental Engineering = EE
SOIL & ENVIRONMENTAL CONSULTANTS, PA
8412 Falls of Neuse Road, Suite 104, Raleigh, NC 27615
www.sandec.com
EAGLE RESOURCES
215 West Moore Street, Southport, NC 28461
www.eagleresources.com

Irrigation = I
CLARK IRRIGATION DESIGN & CONSULTING, INC
P.O. Box 695, Lenoir, GA 30553
www.clarkirrigationdesign.com

Landscape Soil = LS
LANDIS, PLLC
5908 Bentley Brook Dr. Raleigh, NC 27612
www.landispllc.com

Mechanical Engineering = M
Electrical Engineering = E
Plumbing Engineering = P
Fire Protection = FP
CHEATHAM & ASSOCIATES, PA
3412 Enterprise Drive, Wilmington NC 28405
www.cheathamco.com
NC License #C-1073

Marine Structural Engineering = SM
ANDREW CONSULTING ENGINEERS
3811 Piedmont Avenue, Suite 300, Wilmington, NC 28403
www.andrewengineers.com

Water Fountain Design = WF
DELTA FOUNTAINS
11494 Columbia Park Dr. W., Suite 4, Jacksonville, FL 32258
www.deltafountains.com

Lighting Design = EL
TILLOTSON DESIGN ASSOCIATES
40 North Street, Room 703, New York NY 10013
www.tillotsondesign.com

SEAL/SIGNATURE


CAPA 17109

PROGRESS DRAWINGS
DO NOT USE FOR CONSTRUCTION

ISSUE/REVISIONS

NO.	DESCRIPTION	DATE
1	30% CONSTRUCTION DOCUMENTS P3 & P4	06/07/2019
2	60% CONSTRUCTION DOCUMENTS P3	07/26/2019
3	95% CONSTRUCTION DOCUMENTS P3 & P4	12/04/2019

KEY MAP

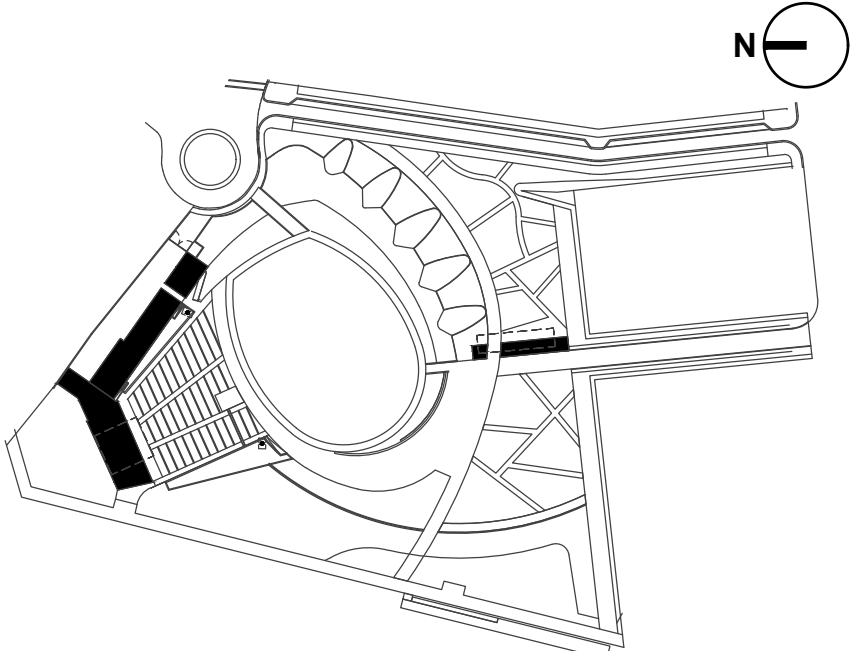

SHEET INFORMATION

Project No.: NWP 1701
Drawn By: CG, SL
Checked By: CG
Date: 12/04/2019
Scale: As indicated

SHEET TITLE

**ENLARGED SECOND FLOOR PLUMBING PLANS
STAGE BUILDING**

SHEET NO.

P-401-P3

1 2 3 4 5 6 7 8 9 10 11 12 13 14 15 16 17