

PROJECT INFORMATION

# NORTH WATERFRONT PARK

10 COWAN STREET  
WILMINGTON, NORTH CAROLINA

CITY OF WILMINGTON  
Community Services Department  
PO Box 1810, Wilmington, North Carolina 28402  
City of Wilmington Project Code 3CPRK1860

Landscape Architecture = L  
HARGREAVES JONES  
180 Varick Street, Suite 204, New York, NY 10014  
www.hargreavesjonesla.com  
NC License #C-513

Architecture = A  
SAGE & COOMBE ARCHITECTS  
12-16 Vestry Street, 5th Floor, New York, NY 10013  
www.sageandcoombe.com

Acoustic/Theater/AV = AT  
CARP.C.  
77 Water Street, New York NY 10015  
www.arup.com

Civil Engineering = C  
Structural Engineering = S  
Geotechnical Engineering = G  
STEWART  
223 S. West Street, Suite 1100, Raleigh, NC 27603  
www.stewartinc.com  
NC License #C-1051

Environmental Engineering = EE  
SOIL & ENVIRONMENTAL CONSULTANTS, PA  
8412 Falls of Neuse Road, Suite 104, Raleigh, NC 27615  
www.sandec.com

EAGLE RESOURCES  
215 West Moore Street, Southport, NC 28461  
www.eagleresources.com

Irrigation = I  
CLARK IRRIGATION DESIGN & CONSULTING, INC  
P.O. Box 693, Levonia, GA 30553  
www.clarkirrigationdesign.com

Landscape Soil = LS  
LANDIS, PLLC  
5906 Bentley Brook Dr. Raleigh, NC 27612  
www.landispllc.com

Mechanical Engineering = M  
Electrical Engineering = E  
Plumbing Engineering = P  
Fire Protection = FP  
CHEATHAM & ASSOCIATES, PA  
3412 Enterprise Drive, Wilmington, NC 28405  
www.cheathampa.com  
NC License #C-1073


Marine Structural Engineering = SM  
ANDREW CONSULTING ENGINEERS  
3811 Piedmont Avenue, Suite 300, Wilmington, NC 28403  
www.andrewengineers.com

Water Fountain Design = WF  
DELTA FOUNTAINS  
11494 Columbia Park Dr. W., Suite 4, Jacksonville, FL 32258  
www.deltafountains.com

Lighting Design = EL  
TILLOTSON DESIGN ASSOCIATES  
40 North Street, Room 703, New York NY 10013  
www.tillotsondesign.com

PROGRESS DRAWINGS  
DO NOT USE FOR CONSTRUCTION

ISSUE/REVISIONS		
NO.	DESCRIPTION	DATE
1	30% CONSTRUCTION DOCUMENTS P3 & P4	06/07/2019
2	60% CONSTRUCTION DOCUMENTS P3	07/26/2019
3	95% CONSTRUCTION DOCUMENTS P3 & P4	12/04/2019

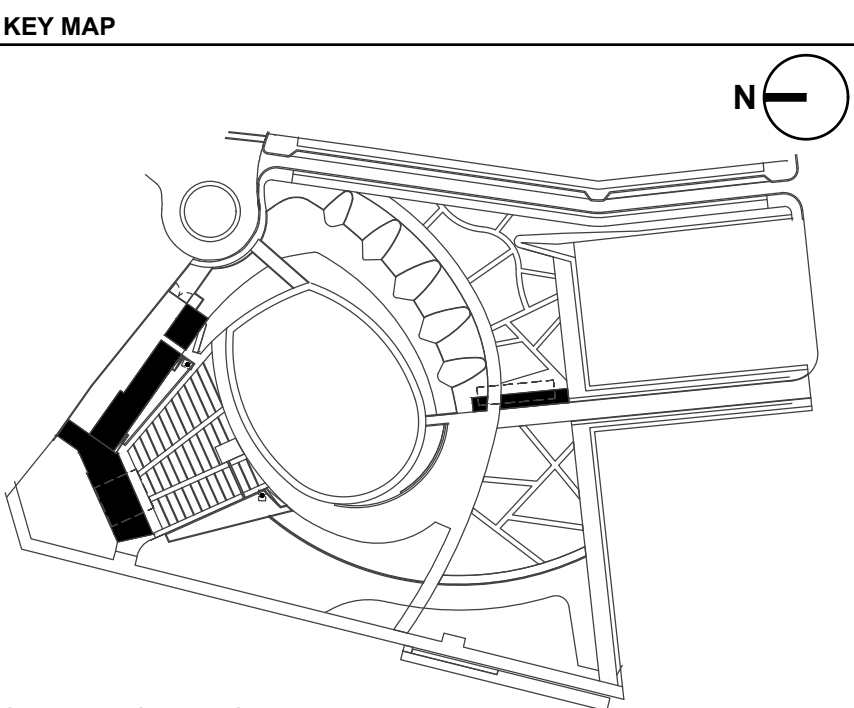

**SHEET INFORMATION**


Project No.: NWP 1701  
Drawn By: CG, SL  
Checked By: CG  
Date: 12/04/2019  
Scale: As indicated

**SHEET TITLE**

**PLUMBING LEGEND, SCHEDULES, AND DETAILS**

SHEET NO.

# P-001-P4

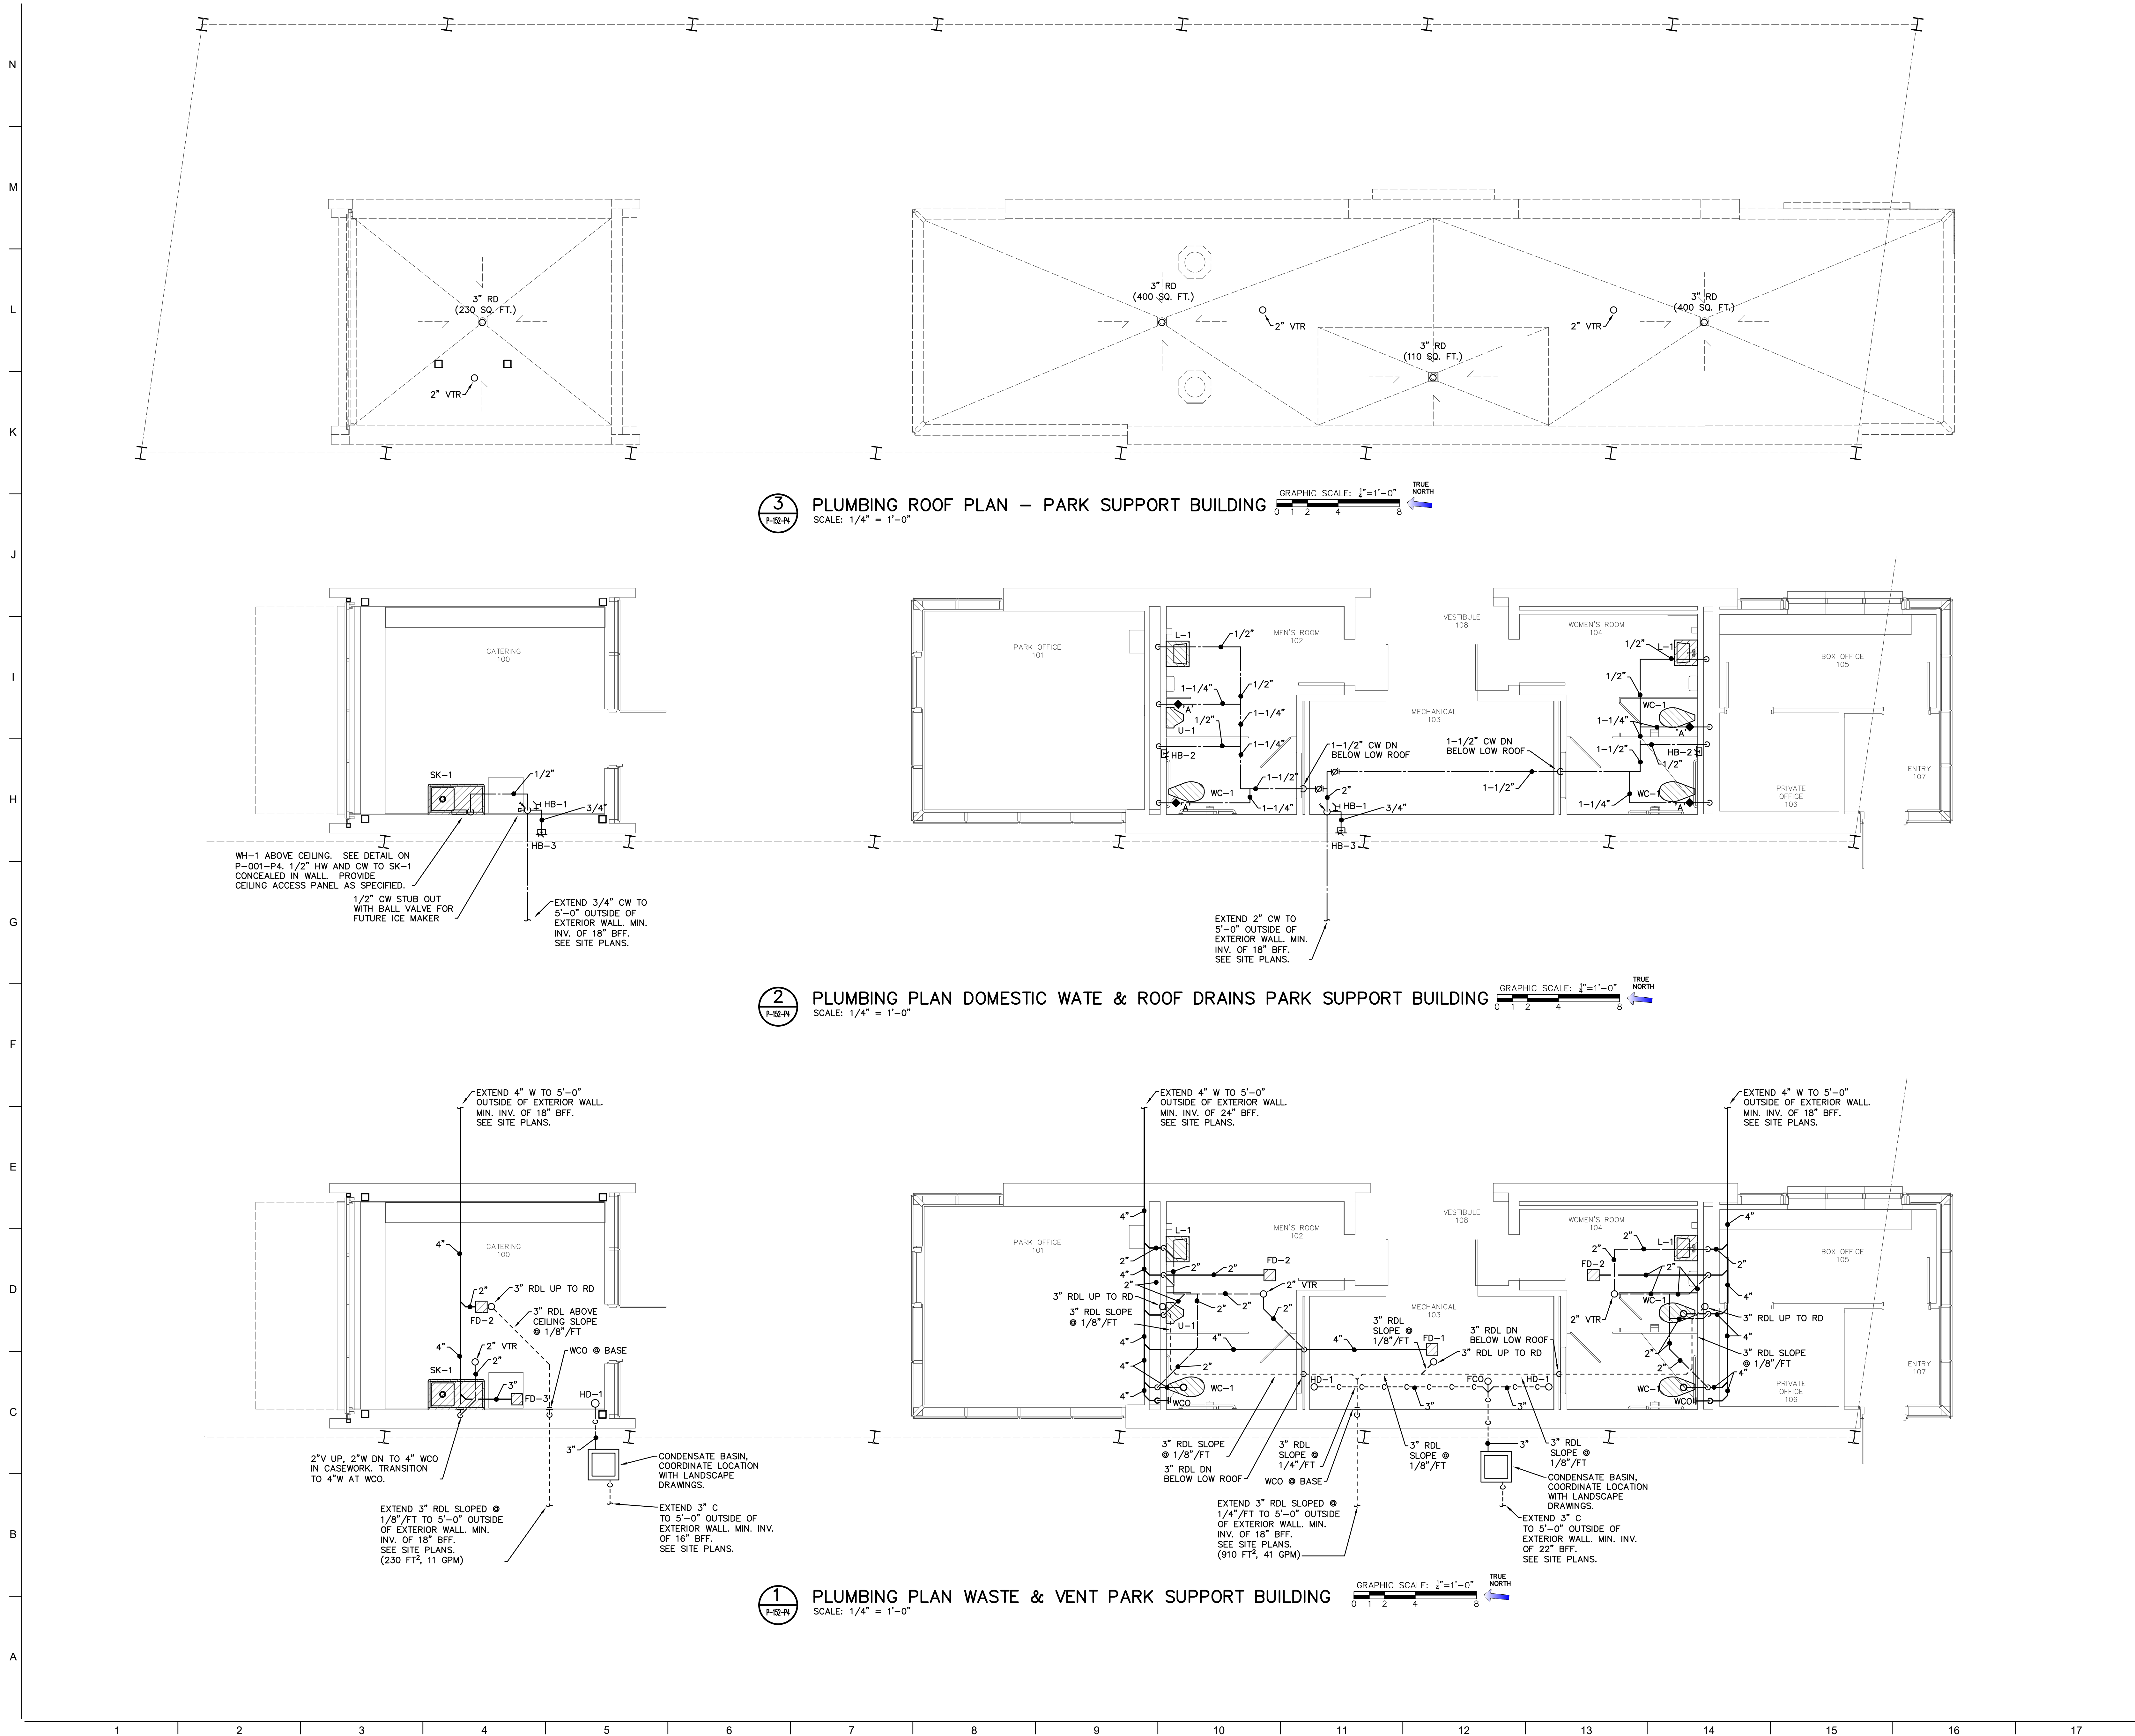

PROJECT INFORMATION

# NORTH WATERFRONT PARK

10 COWAN STREET  
WILMINGTON, NORTH CAROLINA

CITY OF WILMINGTON  
Community Services Department  
PO Box 1810, Wilmington, North Carolina 28402  
City of Wilmington Project Code 3CPRK1860

Landscape Architecture = L  
**HARGREAVES JONES**  
180 Varick Street, Suite 204, New York, NY 10014  
www.hargreavesjonesla.com  
NC License #C-513

Architecture = A  
**SAGE & COOMBE ARCHITECTS**  
12-16 Vestry Street, 5th Floor, New York, NY 10013  
www.sageandcoombe.com

Acoustic/Theater/AV = AT  
**OAP.P.C.**  
77 Water Street, New York NY 10015  
www.arup.com

Civil Engineering = C  
Structural Engineering = S  
Geotechnical Engineering = G  
**STEWART**  
223 S. West Street, Suite 1100, Raleigh, NC 27603  
www.stewartinc.com  
NC License #C-1051

Environmental Engineering = EE  
**SOIL & ENVIRONMENTAL CONSULTANTS, PA**  
3412 Falls of Neuse Road, Suite 104, Raleigh, NC 27615  
www.sandec.com  
**EAGLE RESOURCES**  
215 West Moore Street, Southport, NC 28461  
www.eagleresources.com

Irrigation = I  
**CLARK IRRIGATION DESIGN & CONSULTING, INC**  
P.O. Box 695, Lenoir, GA 30553  
www.clarkirrigationdesign.com

Landscape Soil = LS  
**LANDIS, PLLC**  
5906 Bentley Brook Dr. Raleigh, NC 27612  
www.landispllc.com

Mechanical Engineering = M  
Electrical Engineering = E  
Plumbing Engineering = P  
Fire Protection = FP  
**CHEATHAM & ASSOCIATES, PA**  
3412 Enterprise Drive, Wilmington NC 28405  
www.cheathamco.com  
NC License #C-1073

Marine Structural Engineering = SM  
**ANDREW CONSULTING ENGINEERS**  
3811 Peachtree Avenue, Suite 300, Wilmington, NC 28403  
www.andrewengineers.com


Water Fountain Design = WF  
**DELTA FOUNTAINS**  
11494 Columbia Park Dr. W., Suite 4, Jacksonville, FL 32258  
www.deltafountains.com

Lighting Design = EL  
**TILLOTSON DESIGN ASSOCIATES**  
40 North Street, Room 703, New York NY 10013  
www.tillotsondesign.com

SEAL/SIGNATURE  
CAPA 17109

PROGRESS DRAWINGS  
DO NOT USE FOR CONSTRUCTION

ISSUE/REVISIONS		
NO.	DESCRIPTION	DATE
1	30% CONSTRUCTION DOCUMENTS P3 & P4	06/07/2019
2	60% CONSTRUCTION DOCUMENTS P3	07/26/2019
3	95% CONSTRUCTION DOCUMENTS P3 & P4	12/04/2019

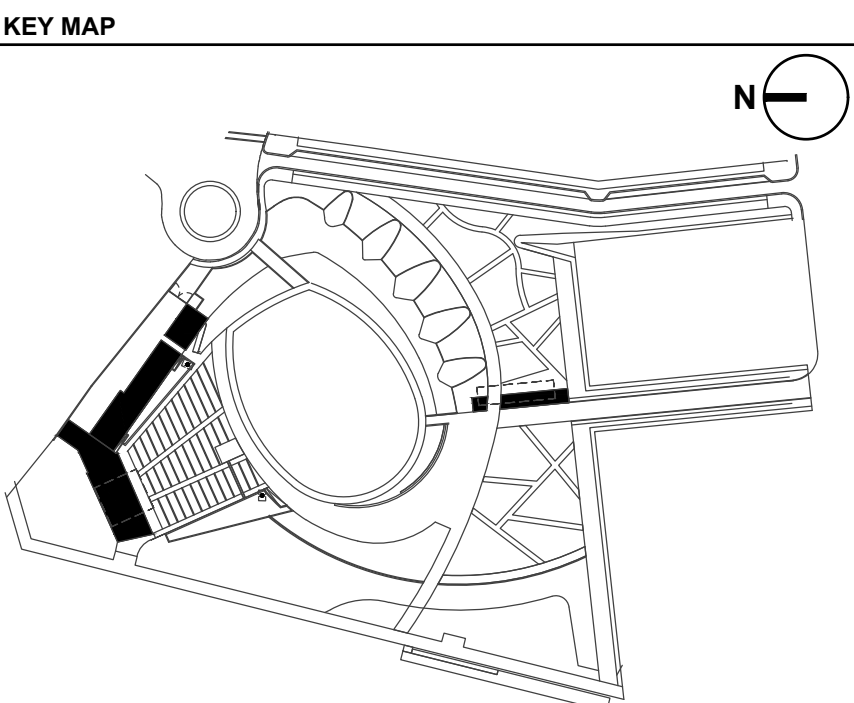

SHEET INFORMATION  
Project No.: NWP 1701  
Drawn By: CG, SL  
Checked By: CG  
Date: 12/04/2019  
Scale: As indicated

SHEET TITLE  
**PLUMBING FLOOR PLANS  
PARK SUPPORT**

SHEET NO.  
**P-152-P4**