

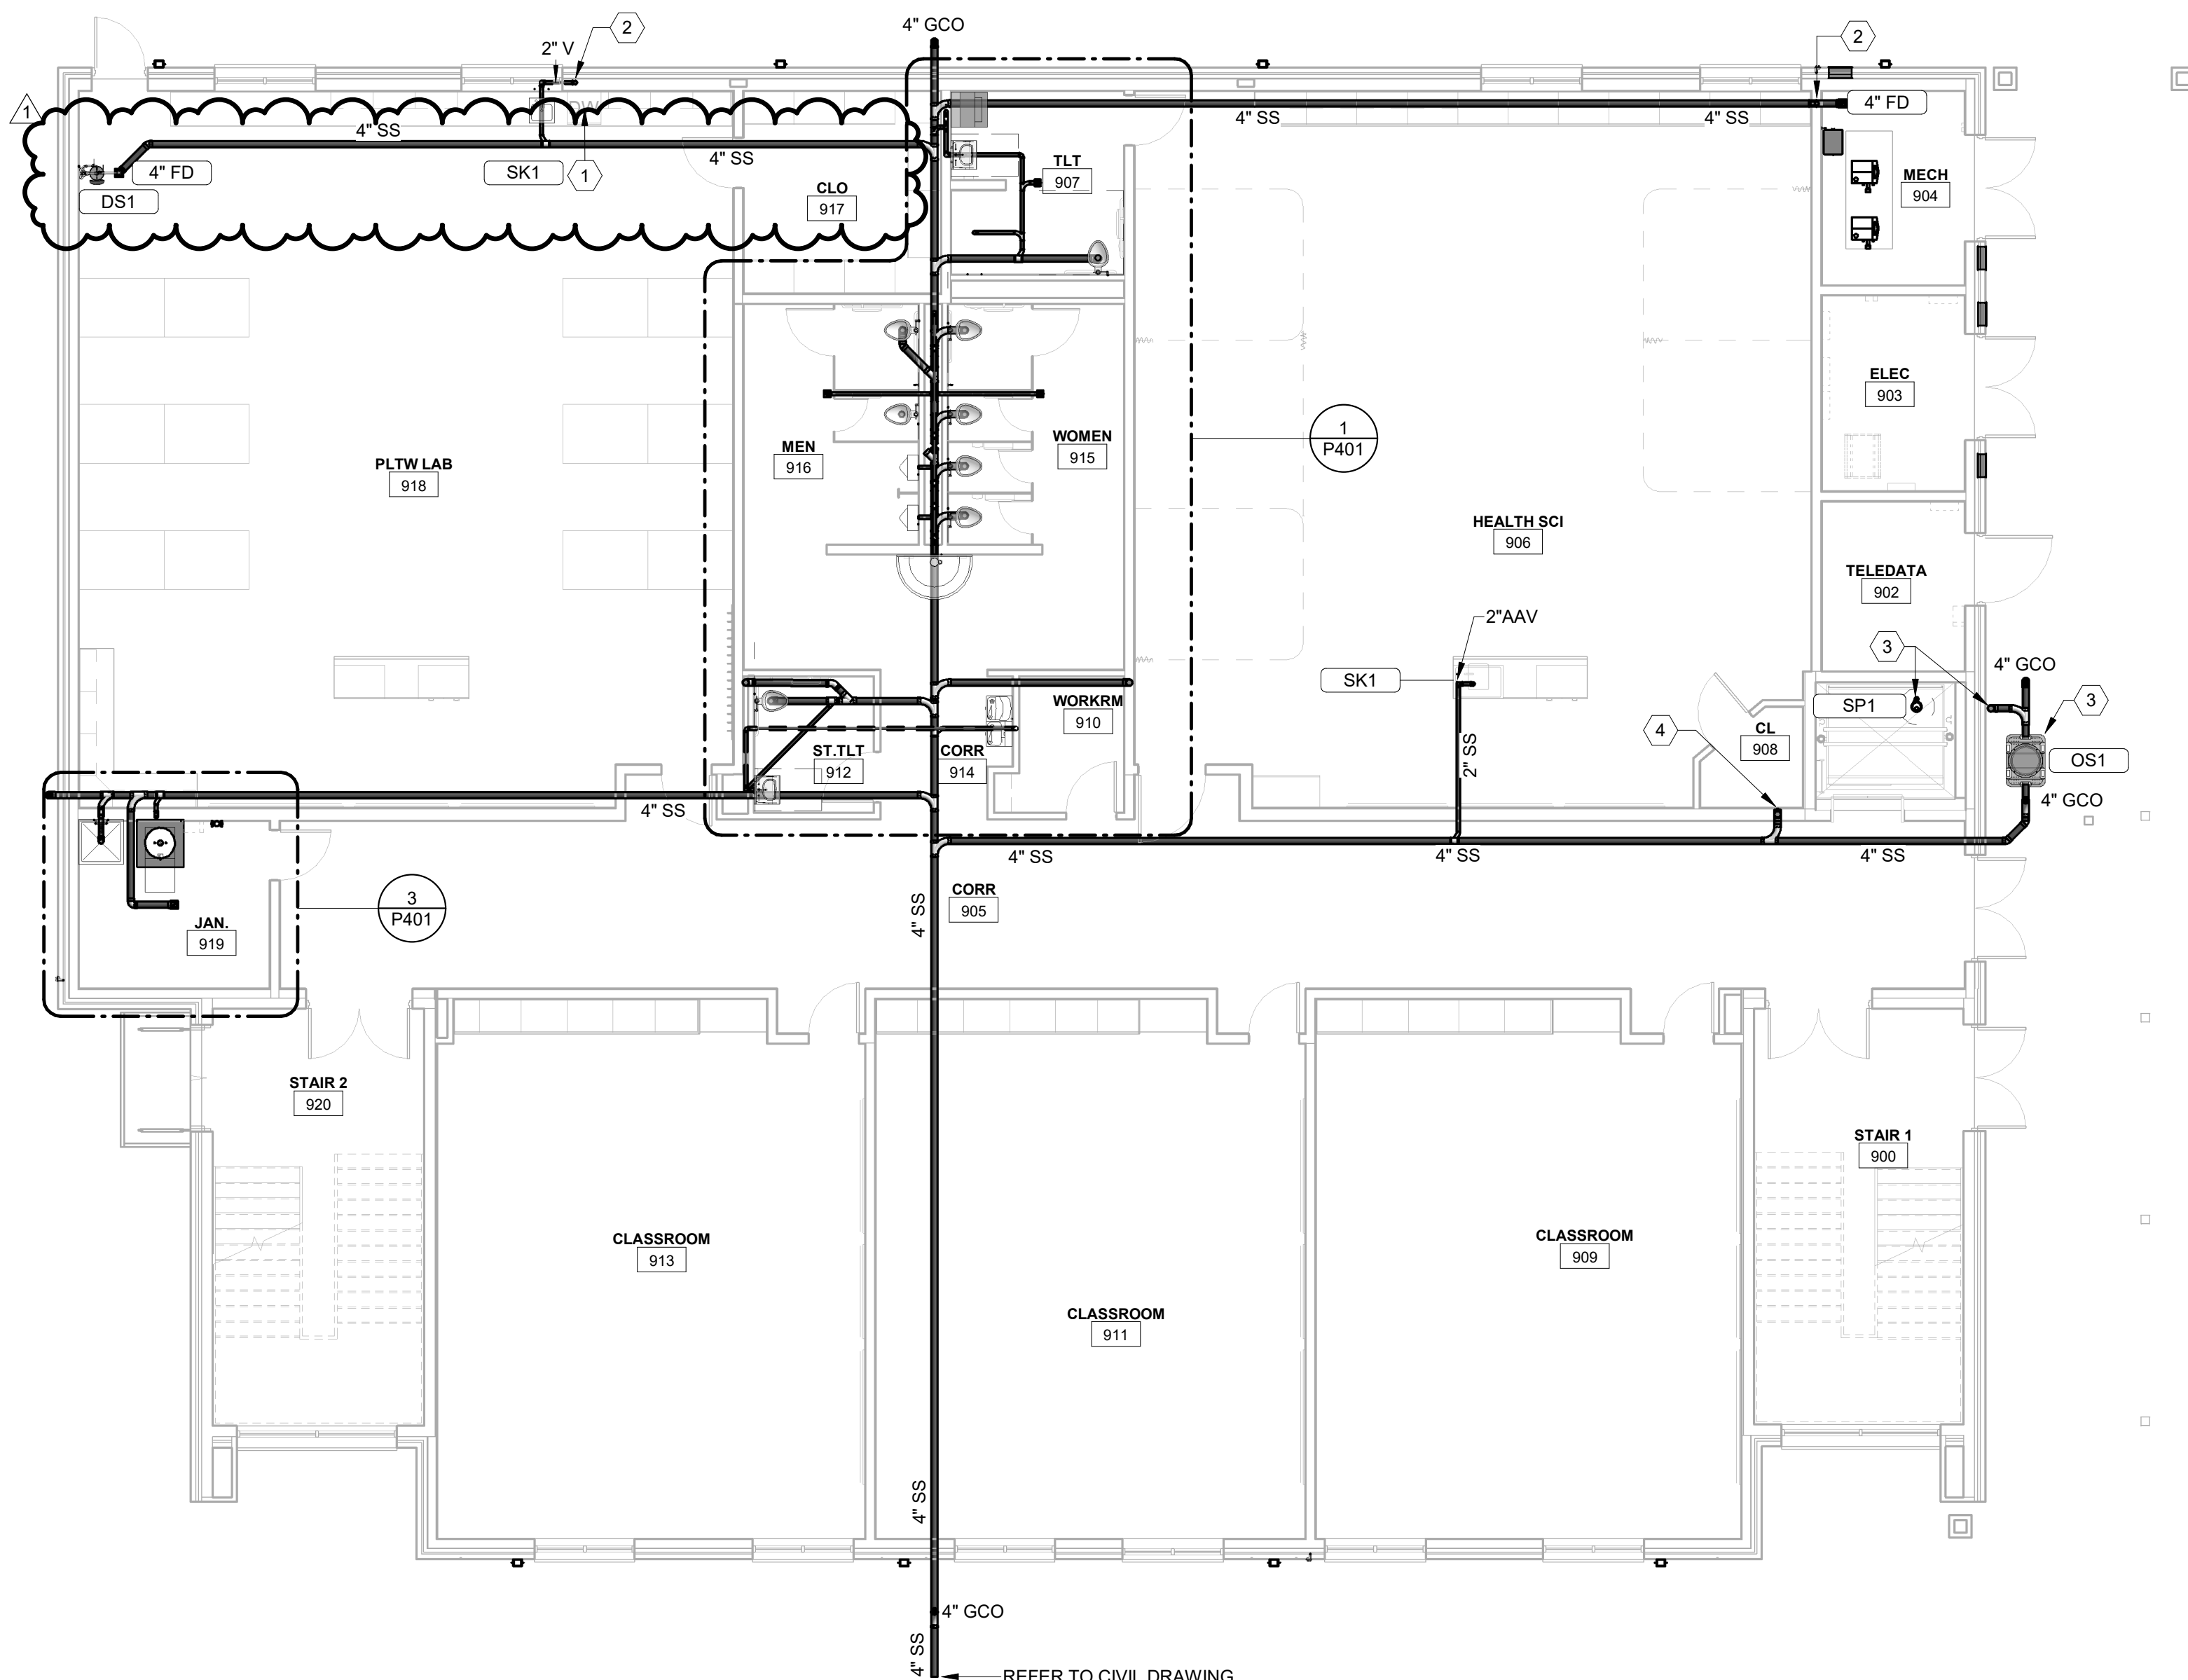


2 SECOND FLOOR PLAN - WASTE-VENT
SCALE: 1/8" = 1'-0"

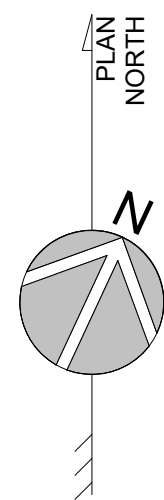

1 FIRST FLOOR PLAN - WASTE-VENT
SCALE: 1/8" = 1'-0"

KEYNOTES THIS SHEET		
1	PC SHALL PROVIDE AND INSTALL DISHWASHER CONNECTION KIT.	
2	PC SHALL INSTALL IN ACCORDANCE WITH SECTION 802.1.6 OF THE 2018 NC PLUMBING CODE	
3	REFER TO ELEVATOR SUMP PUMP DETAIL SHEET P501 FOR FURTHER INFORMATION	
4	4"W STACK; WGO	
5	2"VTR	
6	2"W STACK; 2"STACK VENT	

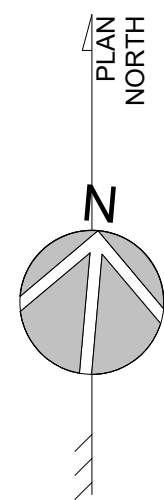

8' 4' 0' 8'
SCALE : 1/8" = 1'-0"

BECKER
MORGAN
GROUP

ARCHITECTURE
PLANNING

North Carolina
3333 Jaecle Drive, Suite 120
Wilmington, NC 28403
910.341.7600

Maryland
312 West Main St, Suite 300
Salisbury, MD 21801
410.546.9100

Delaware
309 S Governors Ave
Dover, DE 19904
302.734.7950

Rittenhouse Station
250 South Main Street, Suite 109
Newark, DE 19711
302.369.3700
www.beckermorgan.com

ISSUED
FOR BIDDING
NOT FOR CONSTRUCTION
ISSUED: 04.16.20

CBHF
Engineers, PLLC

2246 Yaupon Drive
Wilmington, NC 28401
Phone: 910.791.4000
Fax: 910.791.5266
www.cbhfenr.com
© Copyright 2020 CBHF Engineers, PLLC NCA P-0506

FINAL DRAWING
DO NOT USE FOR
CONSTRUCTION

PROJECT TITLE

WEST
BRUNSWICK
HIGH SCHOOL
NEW BUILDING

550 WHITEVILLE ROAD N.W.
SHALLOTTE, NC 28470

DSP # : 100
DPI SCHOOL # : 1167

SHEET TITLE

CLASSROOM
BUILDING PLANS-
WASTE-VENT

Mark	Date	Description
1	05.04.20	ADDENDUM 1
	04.16.20	ISSUED FOR BIDDING
	03.20.20	100% REV. SUBMISSION
	10.14.19	NCDPI DD SUBMISSION
	07.30.19	SD PROGRESS DWGS
	07.11.19	NCDPI SD SUBMISSION

PROJECT NO: 2019082.00
DATE: 01.20.2020
SCALE: 1/8" = 1'-0"
DRAWN BY: JBS PROJ MGR: DMH

P101
COPYRIGHT © 2020