


2 SECOND FLOOR PLAN - DOMESTIC WATER  
SCALE: 1/8" = 1'-0"

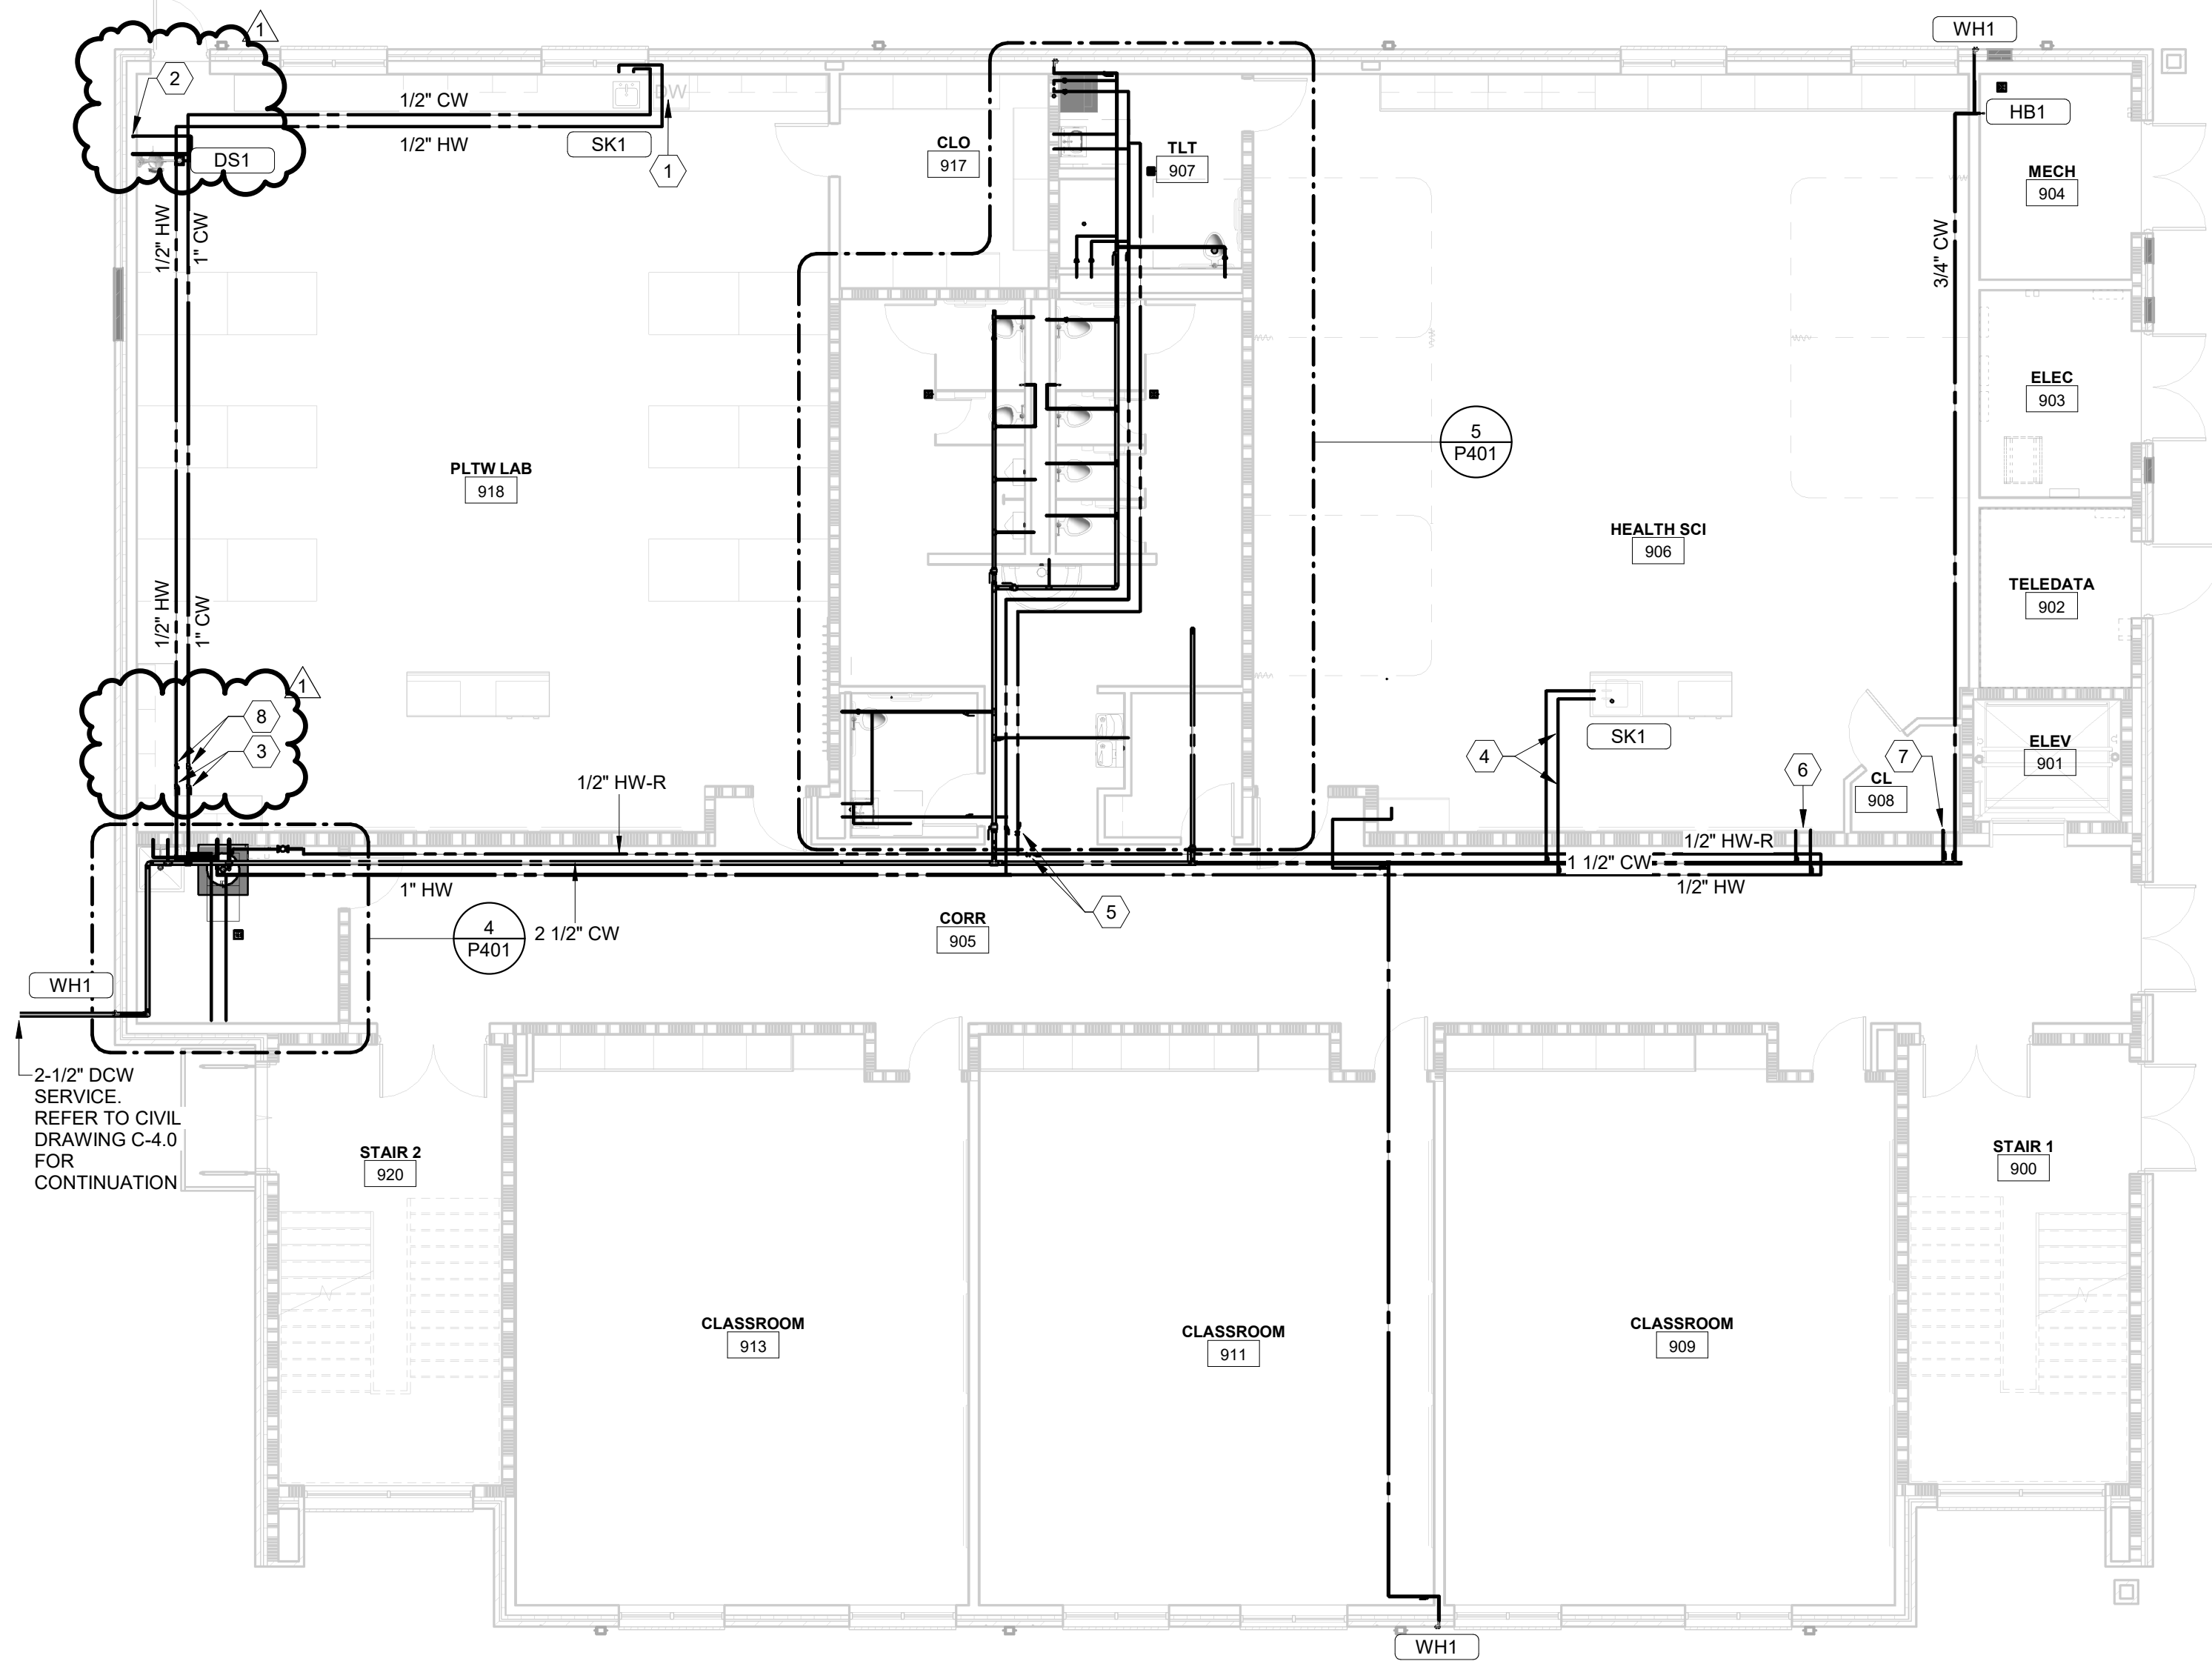

1 FIRST FLOOR PLAN - DOMESTIC WATER  
SCALE: 1/8" = 1'-0"

KEYNOTES THIS SHEET		
1	PC SHALL PROVIDE AND INSTALL DISHWASHER CONNECTION KIT. PC SHALL INSTALL IN ACCORDANCE WITH SECTION 608.15.1 OF THE 2018 NC PLUMBING CODE	
2	INSTALL TRAP PRIMER ABOVE LAY-IN CEILING AND ROUTE TO FLOOR DRAIN UNDER DRENCH SHOWER	
3	PC SHALL PROVIDE AND INSTALL SHUT OFF VALVES	
4	ROUTE 1/2" DCW & DHW UNDER SLAB TO ISLAND SINK	
5	PC SHALL PROVIDE AND INSTALL SHUTOFF VALVE AND CIRCUIT SETTER BALANCING VALVE.	
6	1/2" DCW & DHW UP TO LAV ABOVE	
7	1" DCW UP TO WATER CLOSET ABOVE	
8	PC SHALL PROVIDE AND INSTALL EMERGENCY SHUTOFF VALVES. COORDINATE WITH ELECTRICAL CONTRACTOR FOR LOCATION OF EMERGENCY STOP BUTTON. EMERGENCY STOP BUTTON SUPPLIED AND INSTALLED BY ELECTRICAL CONTRACTOR.	



ARCHITECTURE  
PLANNING

North Carolina  
3333 Jaecle Drive, Suite 120  
Wilmington, NC 28403  
910.341.7600

Maryland  
312 West Main St, Suite 300  
Salisbury, MD 21801  
410.546.9100


Delaware  
309 S Governors Ave  
Dover, DE 19904  
302.734.7950

Rittenhouse Station  
250 South Main Street, Suite 109  
Newark, DE 19711  
302.369.3700  
www.beckermorgan.com

ISSUED  
FOR BIDDING  
NOT FOR CONSTRUCTION  
ISSUED: 04.16.20

**CBHF**  
Engineers, PLLC

2246 Yaupon Drive  
Wilmington, NC 28401  
Phone: 910.791.4000  
Fax: 910.791.5266  
www.cbhfenrners.com  
© Copyright 2020 CBHF Engineers, PLLC NCA P-0506

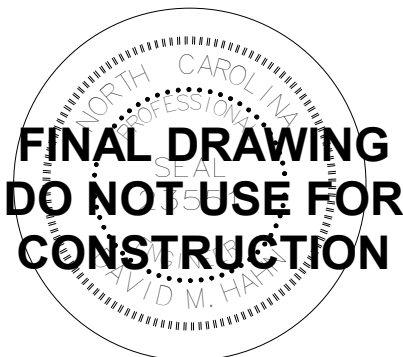

PROJECT TITLE

WEST  
BRUNSWICK  
HIGH SCHOOL  
NEW BUILDING

550 WHITEVILLE ROAD N.W.  
SHALLOTTE, NC 28470

DSP # : 100  
DPI SCHOOL # : 1167

SHEET TITLE

CLASSROOM  
ADDITION PLANS -  
DOMESTIC WATER

Mark	Date	Description
1	05.04.20	ADDENDUM 1
	04.16.20	ISSUED FOR BIDDING
	03.20.20	100% REV. SUBMISSION
	10.14.19	NCDPI DD SUBMISSION
	07.30.19	SD PROGRESS DWGS
	07.11.19	NCDPI SD SUBMISSION

PROJECT NO: 2019082.00  
DATE: 01.20.2020  
SCALE: 1/8" = 1'-0"  
DRAWN BY: JBS PROJ MGR: DMH

**P201**  
COPYRIGHT © 2020

