




1 ENLARGED FIRST FLOOR GANG TOILET - WASTE-VENT
SCALE: 1/4" = 1'-0"

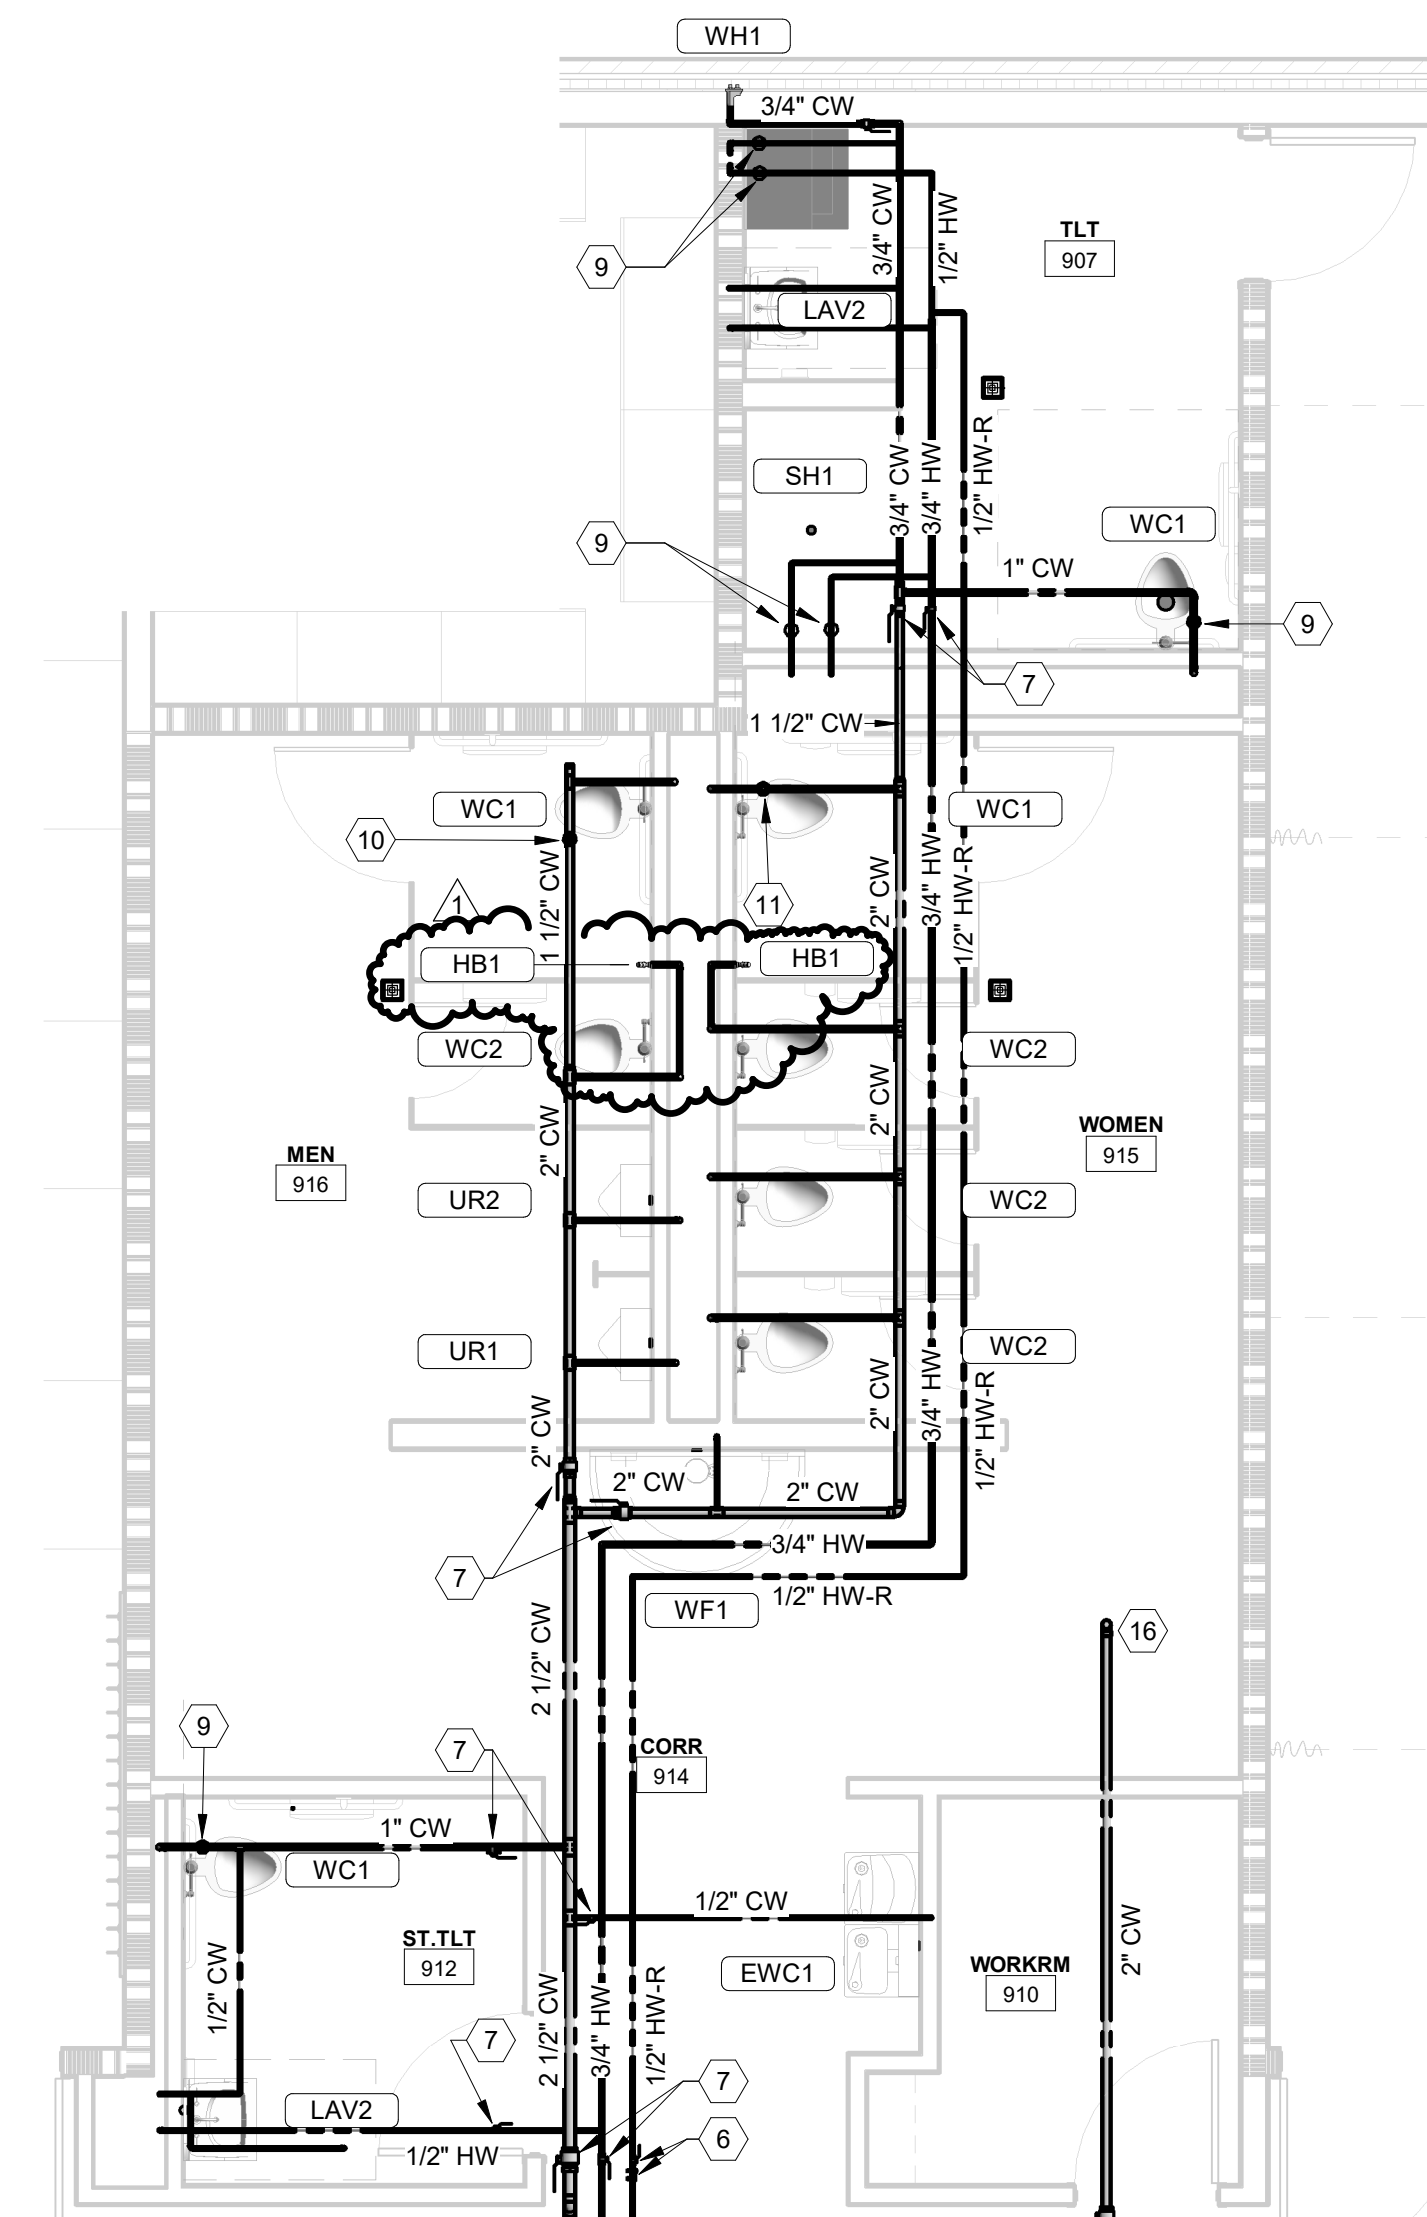


5 ENLARGED FIRST FLOOR GANG TOILET - DOMESTIC WATER
SCALE: 1/4" = 1'-0"

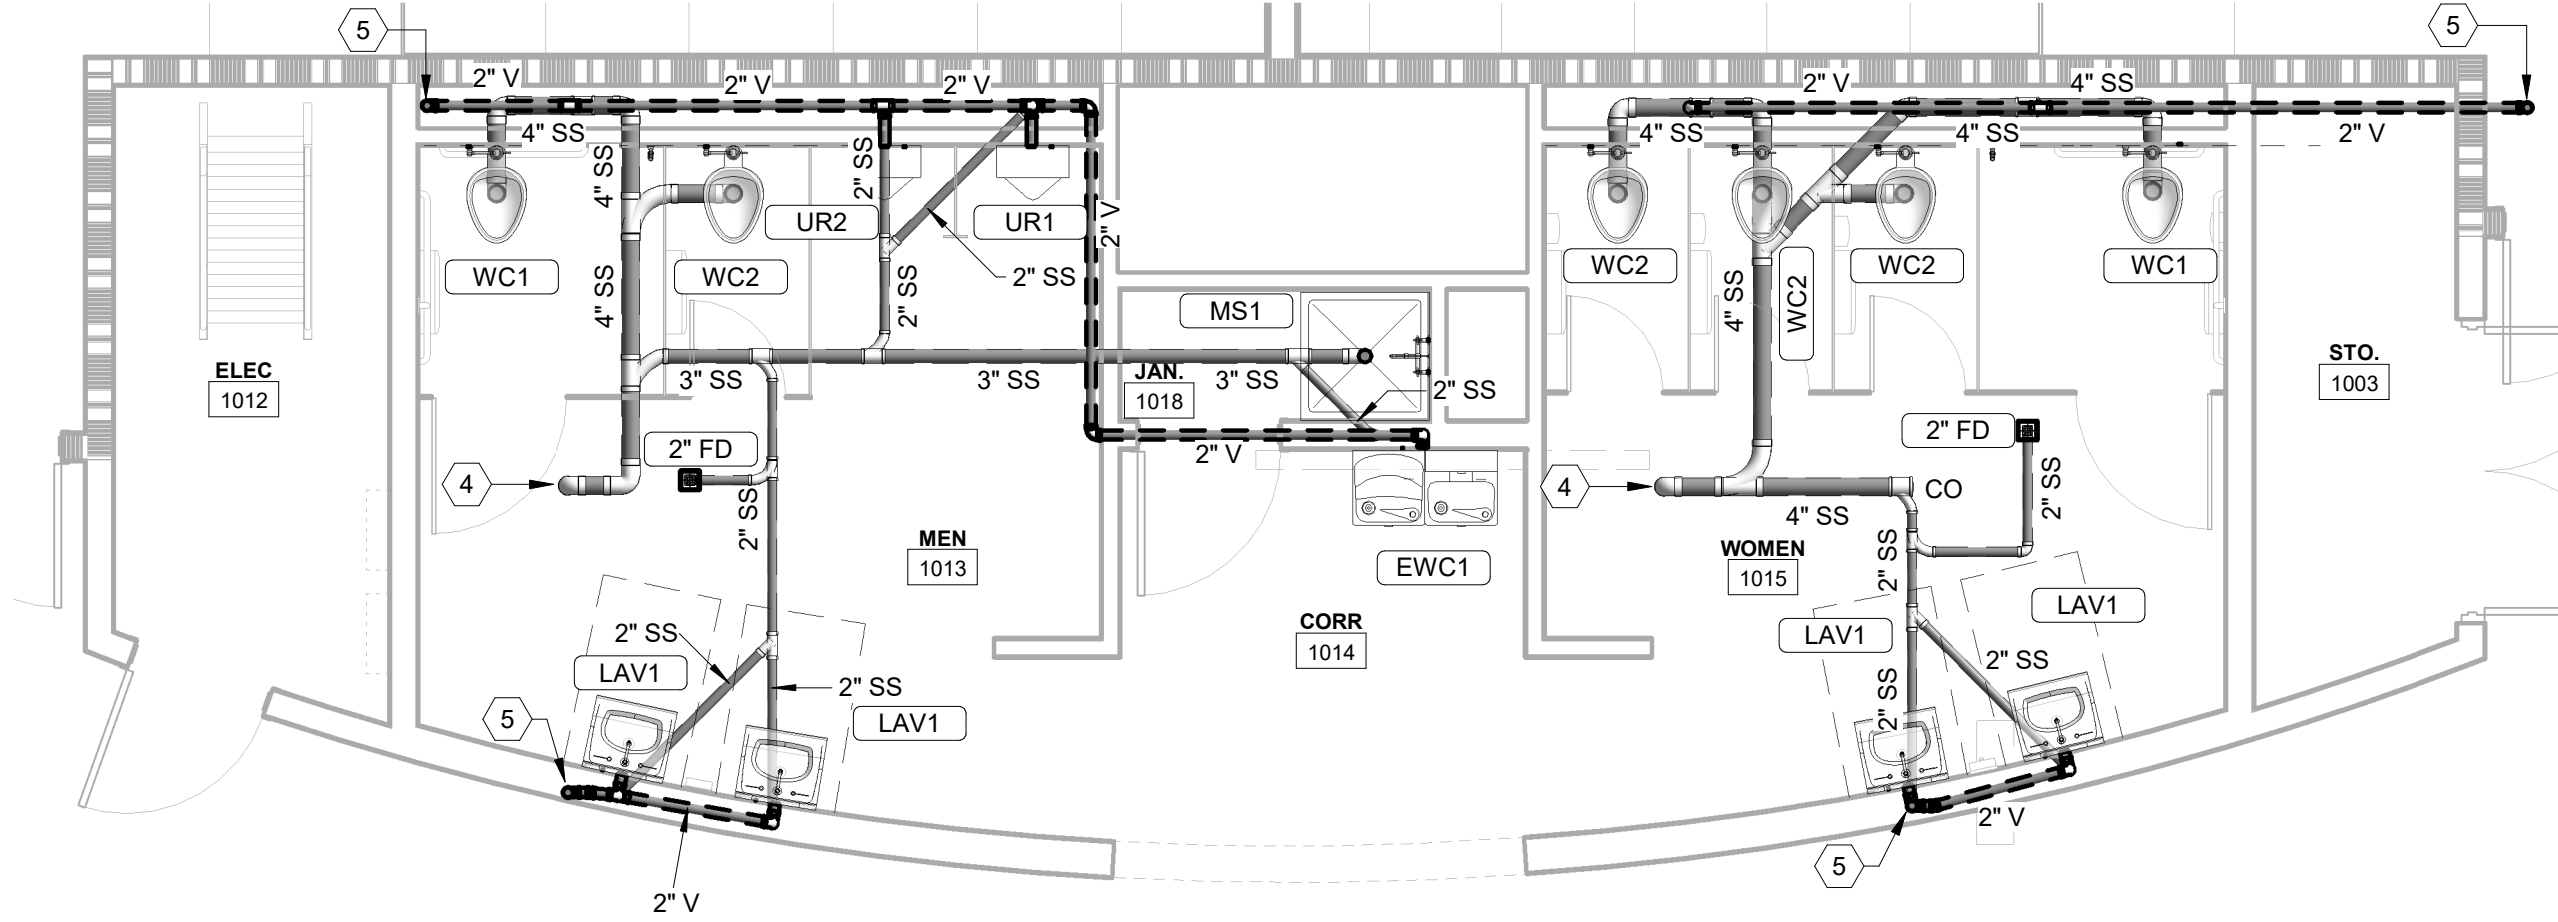


2 ENLARGED SECOND FLOOR GANG TOILETS - WASTE-VENT
SCALE: 1/4" = 1'-0"

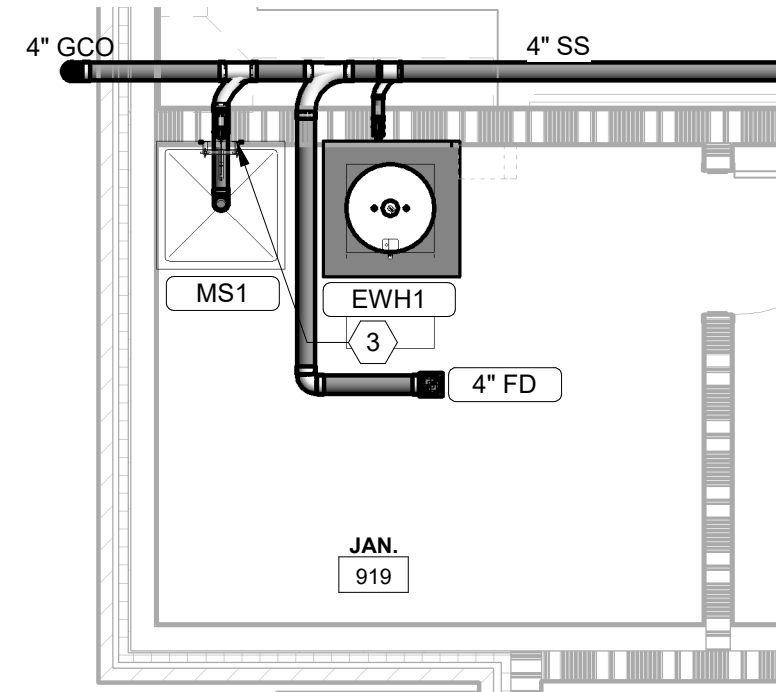

3 ENLARGED FIRST FLOOR JANITORS CLOSET - WASTE-VENT
SCALE: 1/4" = 1'-0"

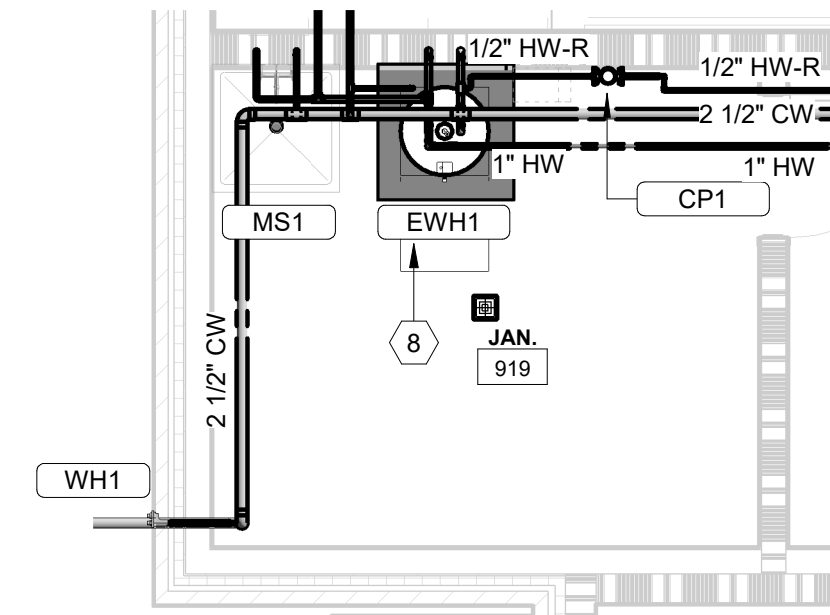


4 ENLARGED FIRST FLOOR JANITORS CLOSET - DOMESTIC WATER
SCALE: 1/4" = 1'-0"

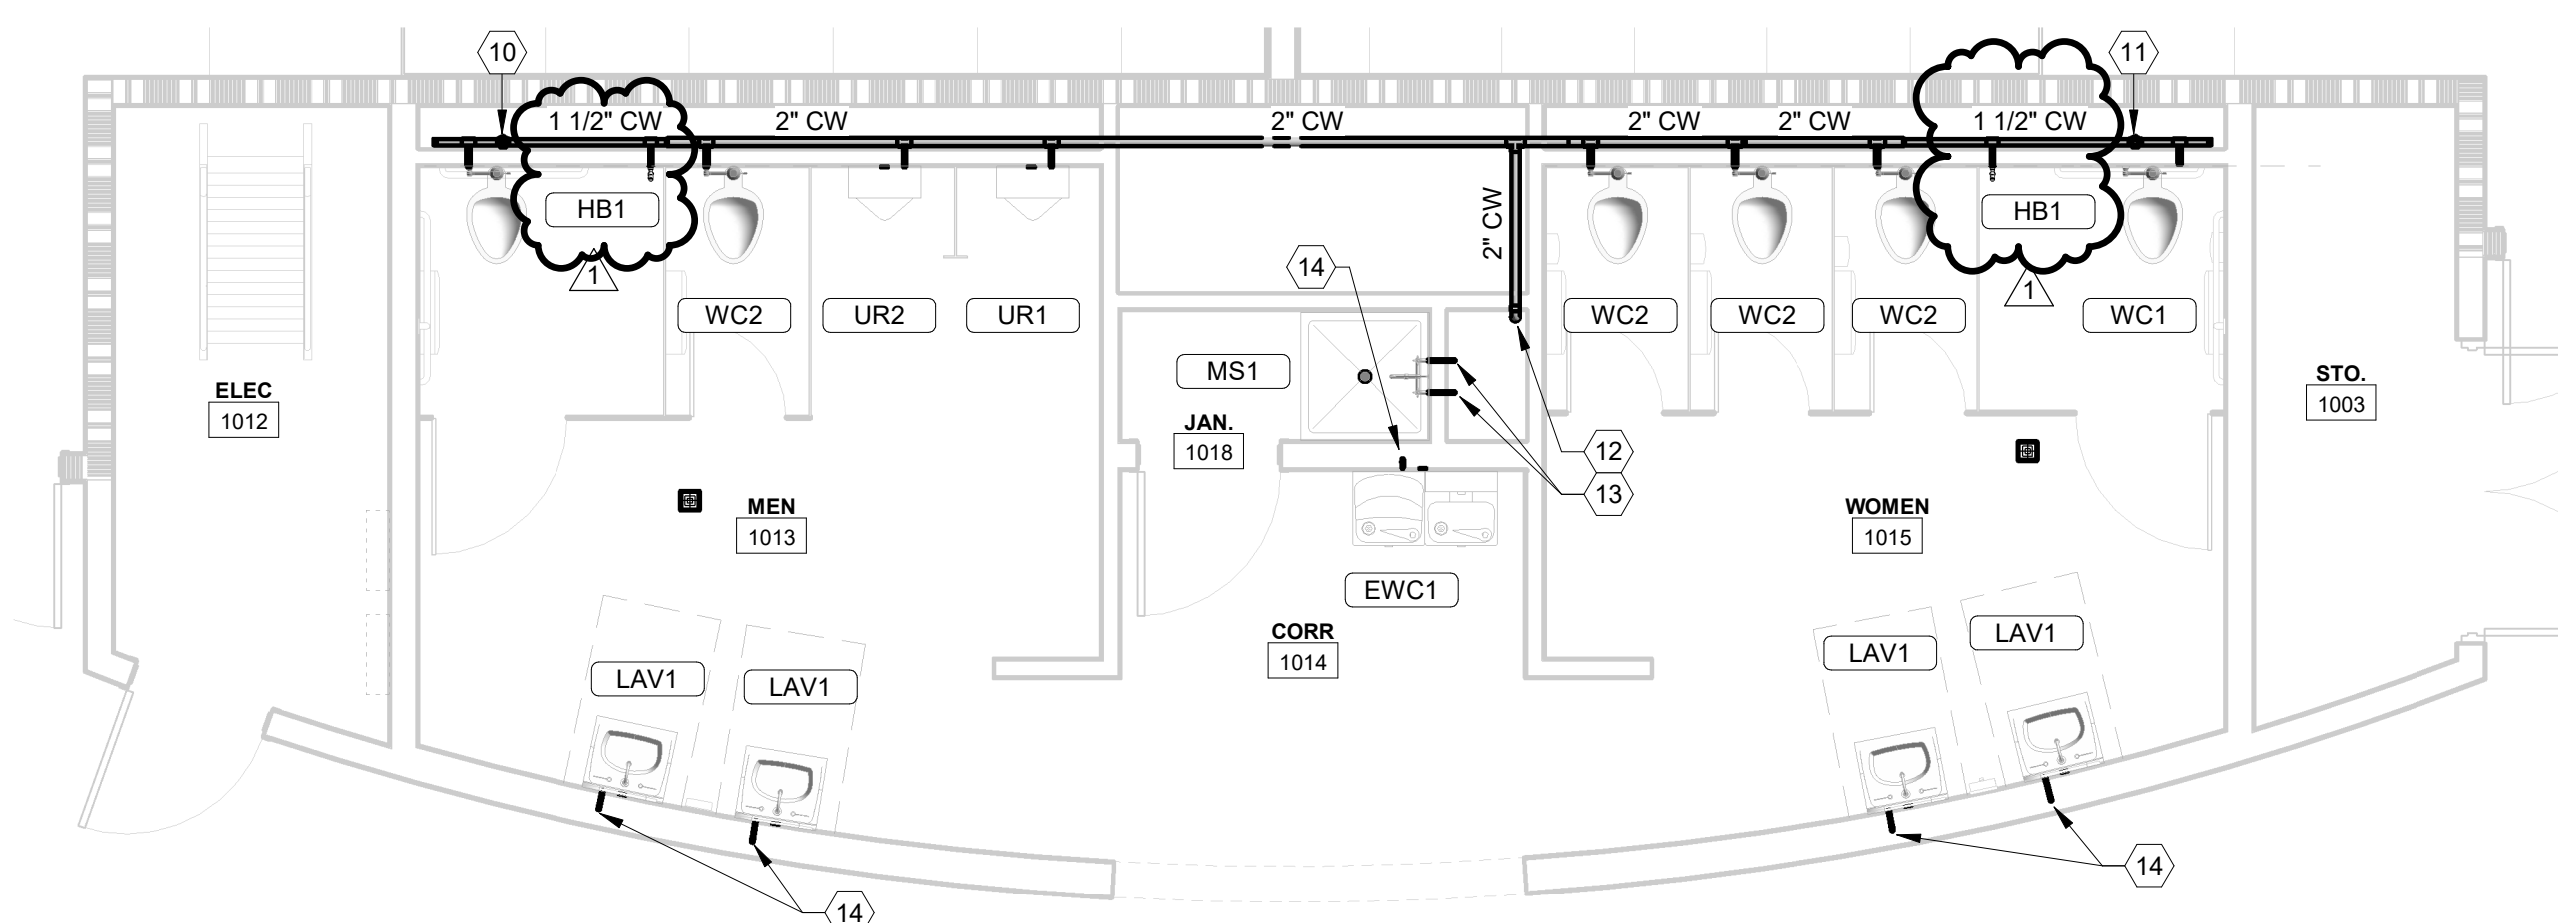


6 ENLARGED SECOND FLOOR GANG TOILETS - DOMESTIC WATER
SCALE: 1/4" = 1'-0"

KEYNOTES THIS SHEET		
1		
2	2"W-DOWN. WCO. 2"V-STACK	
3	2" V-STACK	
4	4"W-STACK	
5	2"V-STACK; 2"VTR	
6	PC SHALL PROVIDE AND INSTALL SHUTOFF VALVE AND CIRCUIT SETTER BALANCING VALVE.	
7	BRANCH VALVE: TYPICAL	
8	REFER TO WATER HEATER DETAIL SHEET P501 FOR FURTHER INFORMATION	
9	1/2" SHOCK ARRESTOR	
10	3/4" SHOCK ARRESTOR	
11	1" SHOCK ARRESTOR	
12	2" DCW FROM BELOW	
13	1/2" DCW & DHW FROM BELOW	
14	1/2" DCW FROM BELOW	
15	1" DCW FROM BELOW	
16		

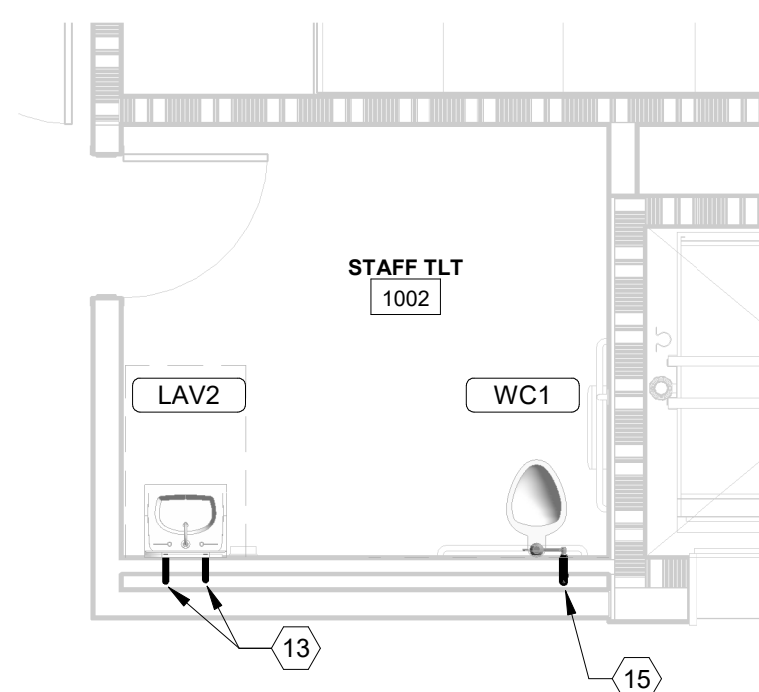

7 ENLARGED SECOND FLOOR STAFF TOILET - DOMESTIC WATER
SCALE: 1/4" = 1'-0"

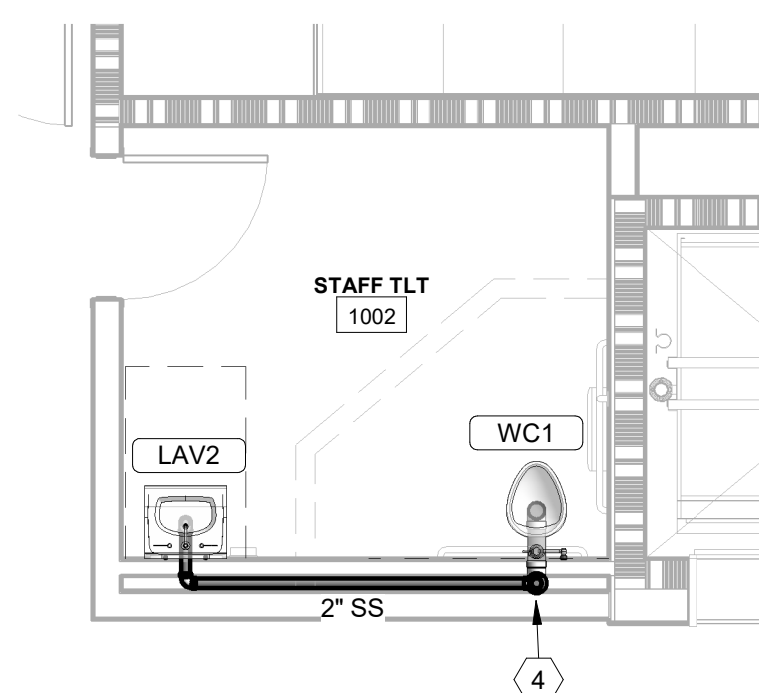

8 ENLARGED SECOND FLOOR STAFF TOILET - WASTE-VENT
SCALE: 1/4" = 1'-0"



ARCHITECTURE PLANNING

North Carolina
3333 Jaecle Drive, Suite 120
Wilmington, NC 28403
910.341.7600

Maryland
312 West Main St, Suite 300
Salisbury, MD 21801
410.546.9100

Delaware
309 S Governors Ave
Dover, DE 19904
302.734.7950

Rittenhouse Station
250 South Main Street, Suite 109
Newark, DE 19711
302.369.3700
www.beckermorgan.com

ISSUED
FOR BIDDING
NOT FOR CONSTRUCTION
ISSUED: 04.16.20

CBHF
Engineers, PLLC

2246 Yaupon Drive
Wilmington, NC 28401
Phone: 910.791.4000
Fax: 910.791.5266
www.cbhfenrines.com

© Copyright 2020 CBHF Engineers, PLLC NCA P-0506

FINAL DRAWING
DO NOT USE FOR
CONSTRUCTION

PROJECT TITLE
**WEST
BRUNSWICK
HIGH SCHOOL
NEW BUILDING**

550 WHITEVILLE ROAD N.W.
SHALLOTTE, NC 28470

DSP #: 100
DPI SCHOOL #: 1167

SHEET TITLE
**ENLARGED
PLUMBING PLANS**

Mark	Date	Description
1	05.04.20	ADDENDUM 1
2	04.16.20	ISSUED FOR BIDDING
3	03.20.20	100% REV. SUBMISSION
4	10.14.19	NCDPI DD SUBMISSION
5	07.30.19	SD PROGRESS DWGS
6	07.11.19	NCDPI SD SUBMISSION

PROJECT NO: 2019082.00
DATE: 01.20.2020
SCALE: 1/4" = 1'-0"
DRAWN BY: JBS PROJ MGR: DMH

P401
COPYRIGHT © 2020