



2 ROTC HVAC SECTION NORTH
SCALE: 1/4" = 1'-0"

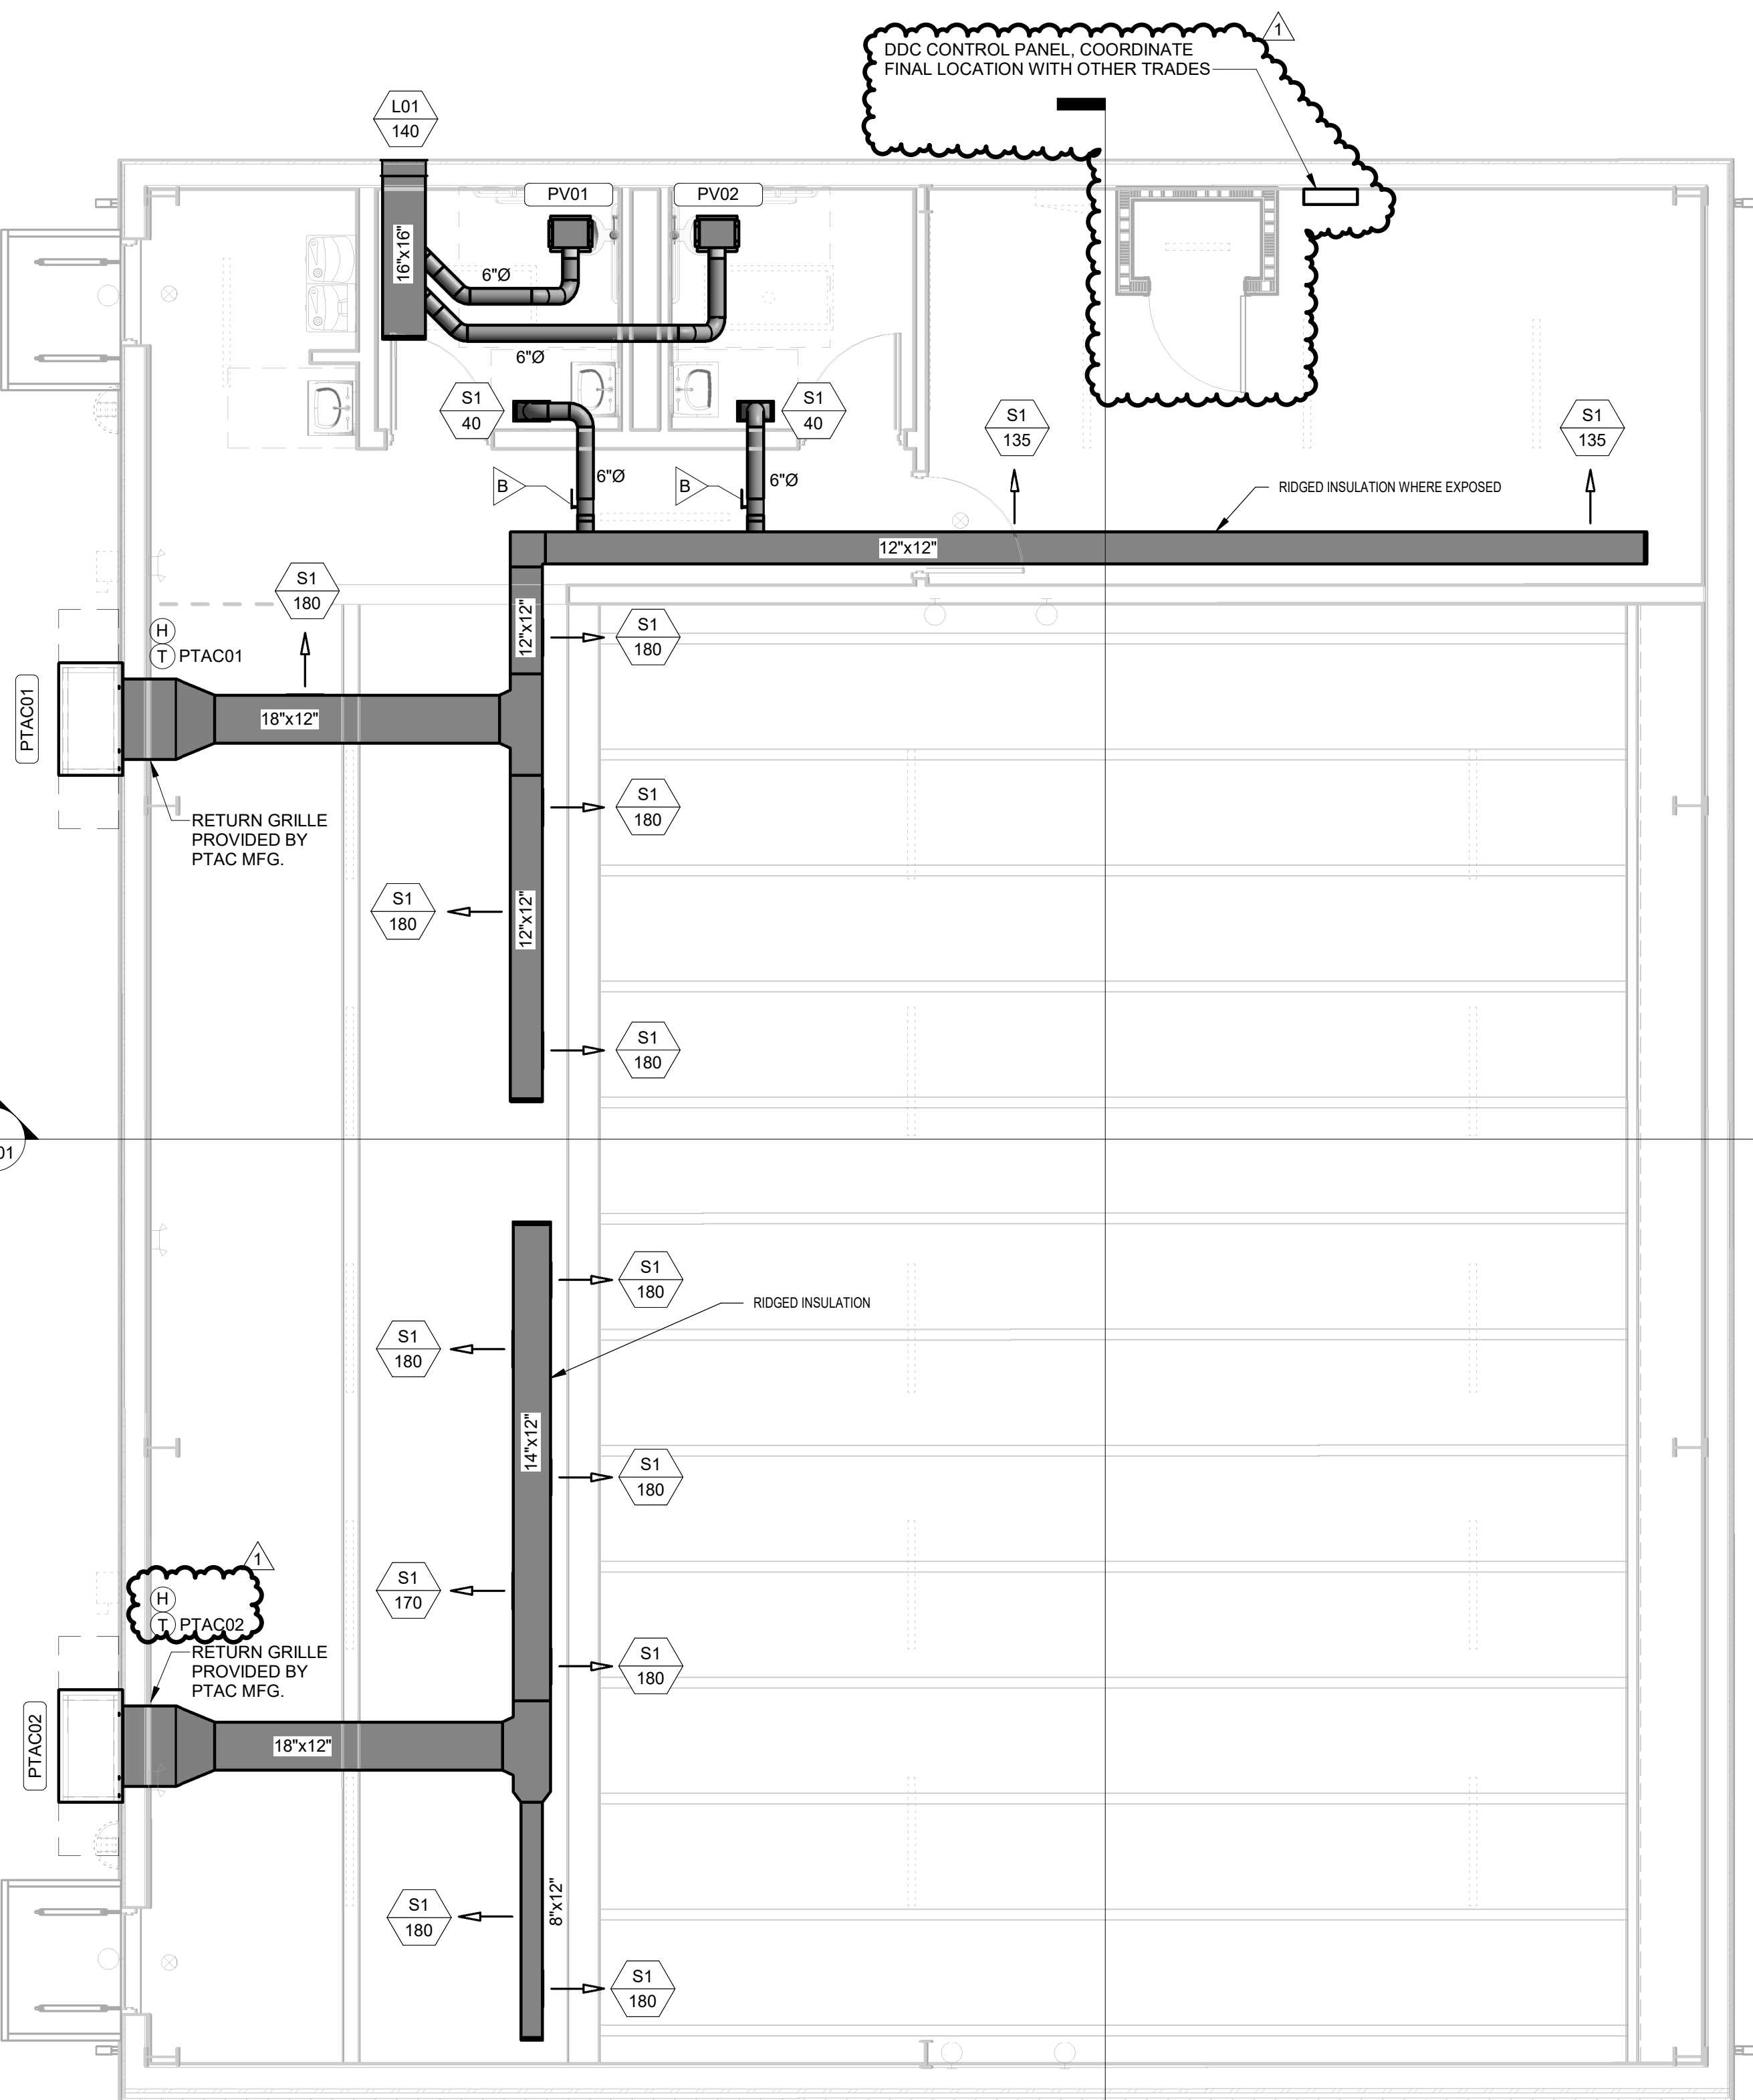

1 ROTC FLOOR PLAN - HVAC
SCALE: 1/4" = 1'-0"

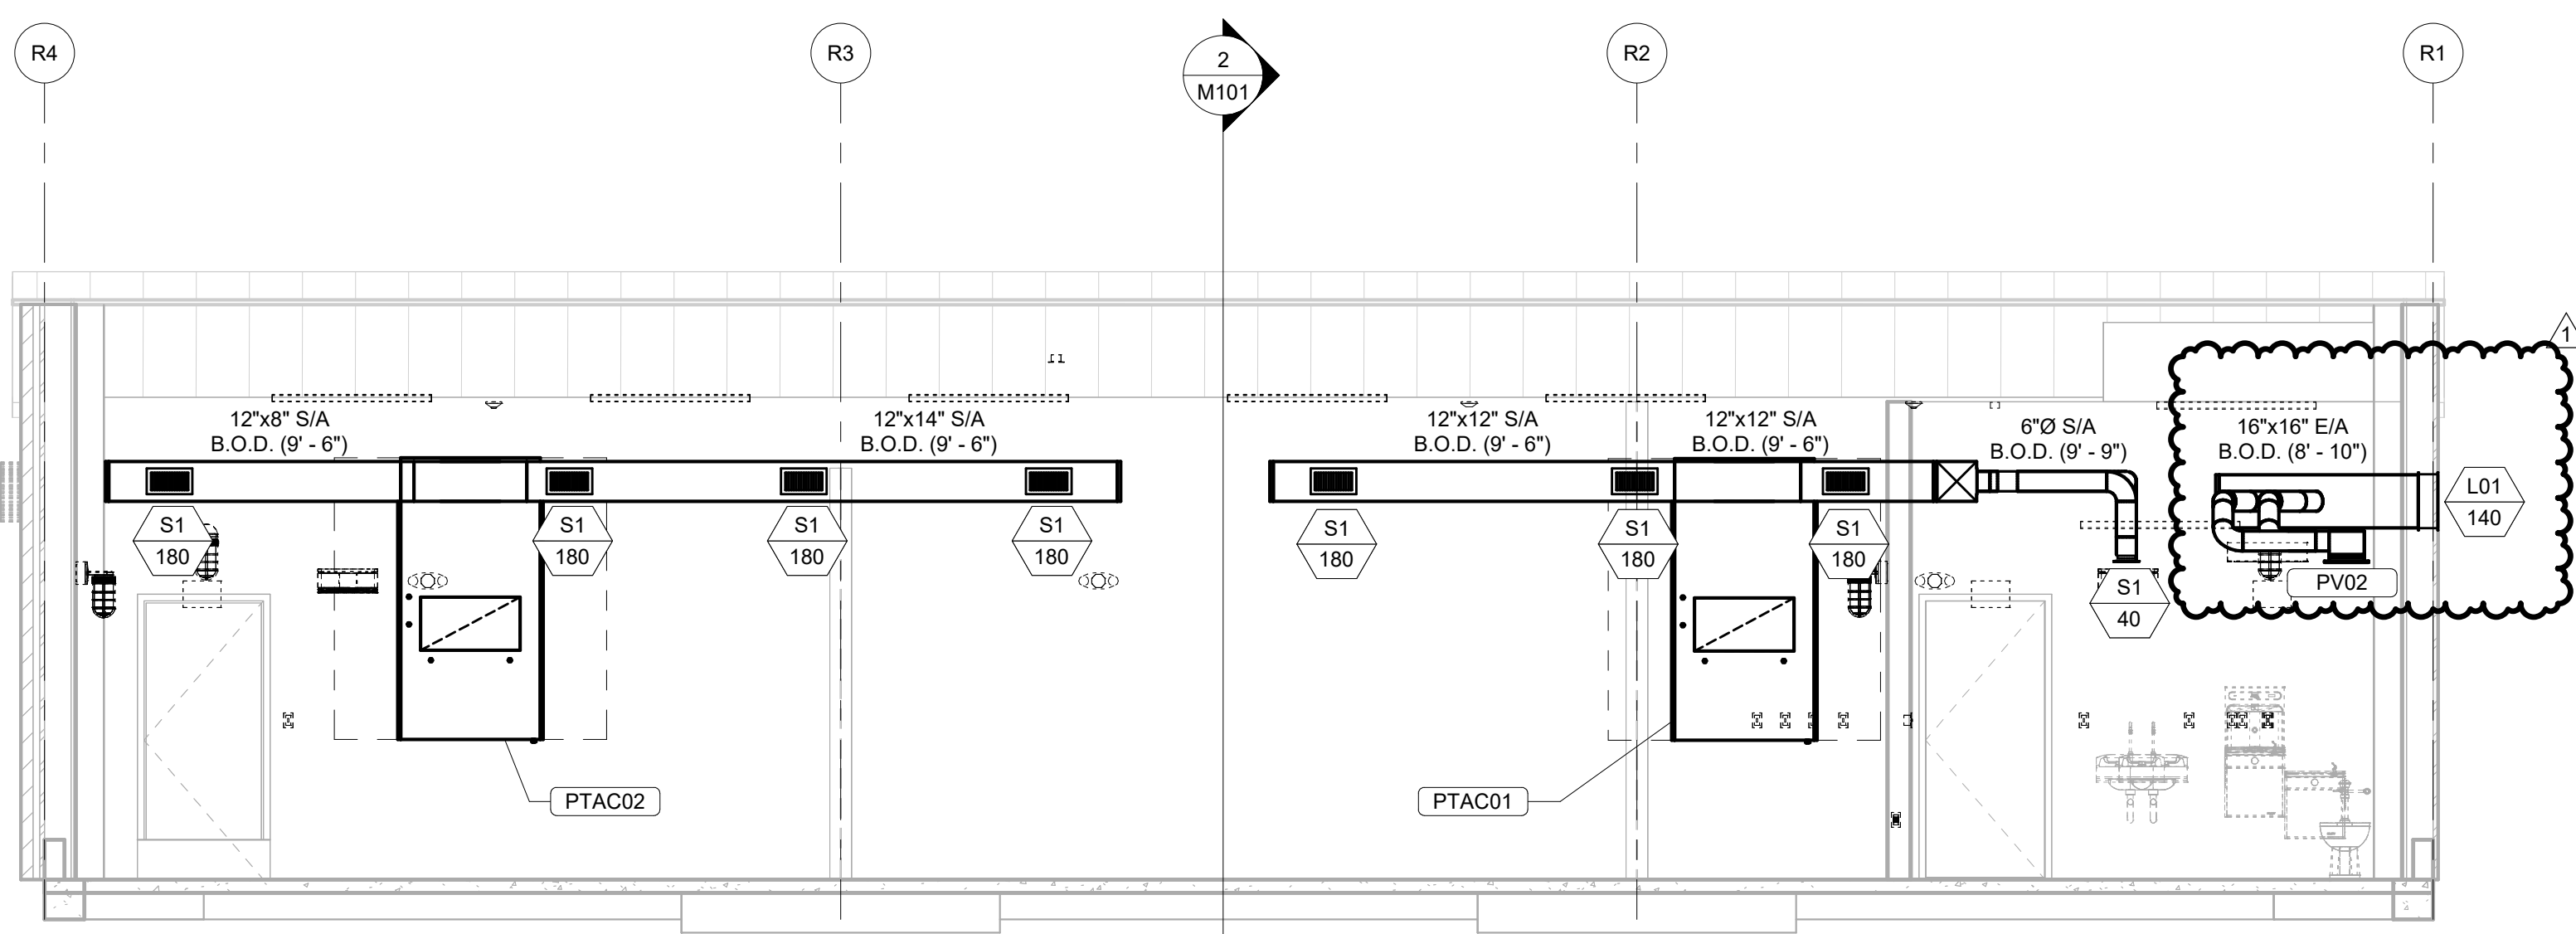

3 ROTC HVAC SECTION - WEST
SCALE: 1/4" = 1'-0"