


VICINITY MAP

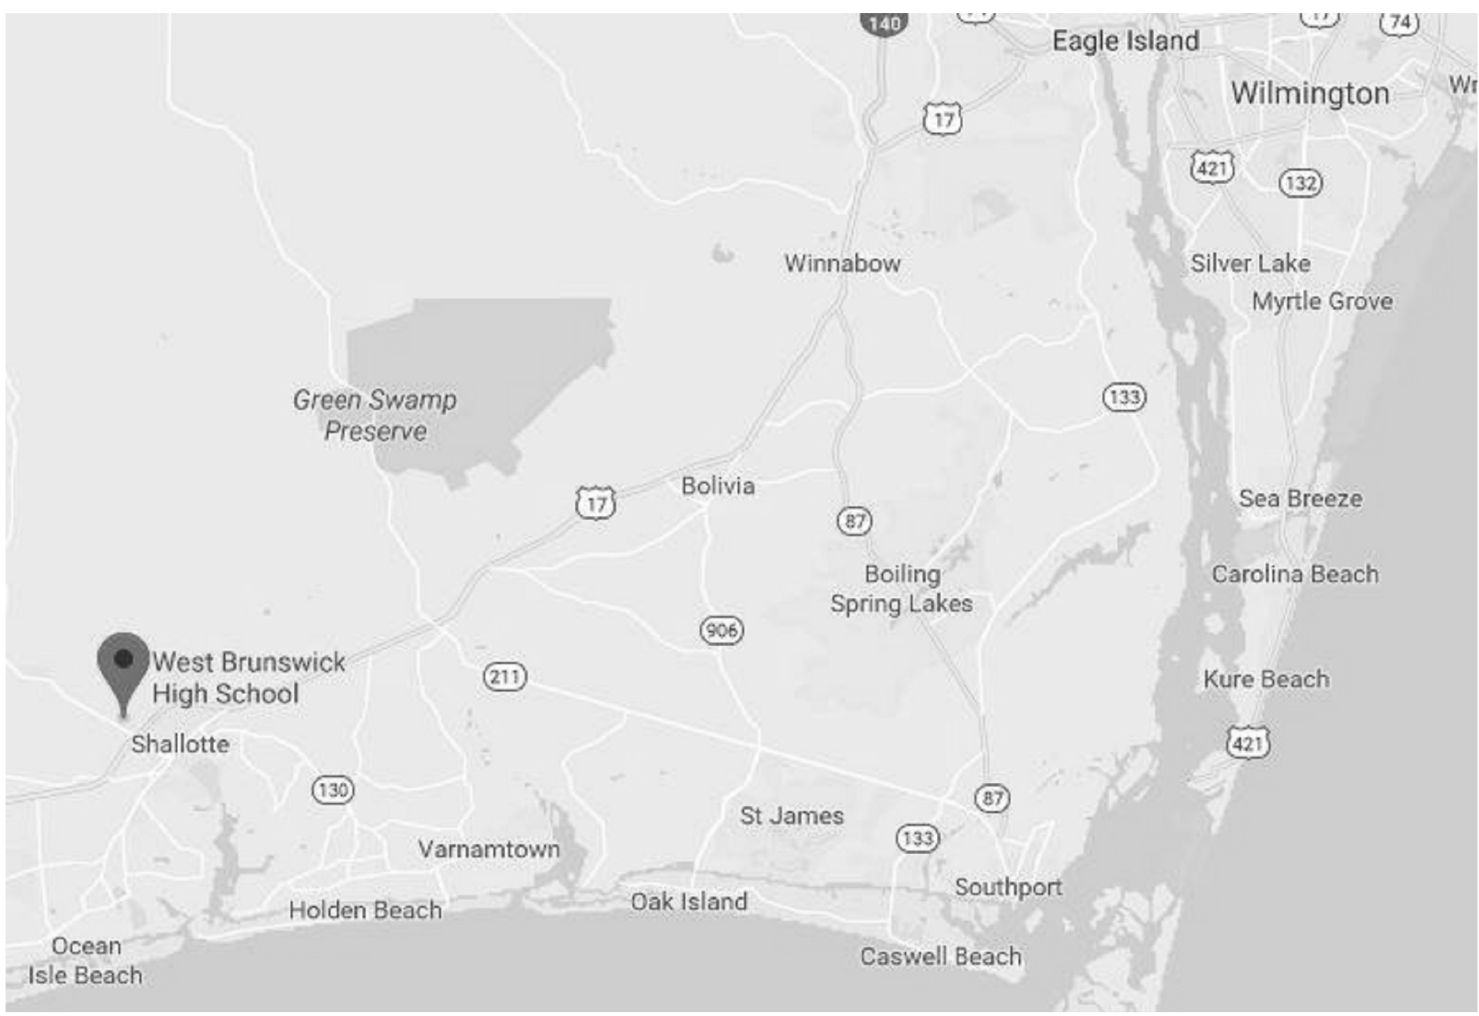

ABBREVIATIONS

ACT	ACOUSTIC CEILING	F.E.C.	FIRE EXTINGUISHER	PT., PTD.	PAINTED
AC.	TILE	FIN.F.F.F.	CABINET	P.R.V.	POWER ROOF VENTILATOR
AL.	ALUM.	F.O.F.S.	FACE OF STUD	R.P.	ROOF DRAIN
A.F.	ACCESS PANEL	FRP	FIREGLASS	REC.	RECESSED
A.R.GWB	ABUSE RESISTANT	REF.	REINFORCED PLASTIC	RECPT.	RECEPTIONIST
	GWB	F.R.T.	FIRE RETARDANT	REQD.	REQUIRED
A.F.F.	ABOVE FINISHED FLOOR	FTG.	FOOTING	R.L.	RAIN LEADER
		FURR.	FURRING	RM.	ROOM
BD.	BOARD	F.V.	FIELD VERIFY	R.O.	ROUGH OPENING
B.L.M.	BENCH MARK	F.V.C.	FIRE VALVE CABINET	RUB.	RUBBER (WALL BASE)
BRG.	BEARING	GA.	GAUGE	S.D.	SOAP DISPENSER
CAB.	CABINET	G.B.	GRAB BAR	SECT.	SECTION
CB, C.B.	CHALKBOARD	G.W.B, GWB	GYP.SUM WALL BOARD	S.G.F.T.	STRUCT. GLAZED FACING TILE
C.T.	CERAMIC TILE	GYP.BD.	GYP.SUM BOARD	S.H.	SHOWER HEAD
C.H.	CEILING HEIGHT	H., HT.	HEIGHT	SHT.	SHEET
C.J, C.J.	CONTROL JOINT	H.C.	HANDICAPPED	SIM.	SIMILAR
C.L.	CENTER LINE	HDW.	HARDWARE	S.M.	SURFACE MOUNTED
CLO.	CEILING	H.M.	HOLLOW METAL	S.P.	STAND PIPE
CLO, C.	CLOSET	H.R.	HOUR	S.S.	SERVICE SINK
CLR.	CLEAR	H.P.	HIGH POINT	S/S	STAINLESS STEEL
C.M.U., CMU	CONCRETE	I.D.	INSIDE DIAMETER	STL.	STEEL
	MASONRY UNIT	INSUL.	INSULATION	STOR.	STORAGE
COL.	COLUMN	J. JAN.	JANITOR	STRUCT.	STRUCTURAL
CONC.	CONCRETE	JST.	JOIST	SUSP.	SUSPENDED
CONST.	CONSTRUCTION	JOINT.	JOINT	SYN.FL.	SYNTHETIC FLOOR
CONT.	CONTINUOUS	LAM.	LAMINATE	TB, T.B.	TACKBOARD
CORR.	CORRIDOR	LAV.	LOW POINT	TEL.	TELEPHONE
CPT.	CARPET	L.P.	LAVATORY SINK	T & G.	TONGUE AND GROOVE
C.R.	COLD ROLLED	M.	MEN	THRESH.	THRESHOLD
D.A.	DISTURBED AREA	MACH.	MACHINE	T.O.B.	TOP OF BEARING
DET.	DETAIL	MAINT.	MAINTENANCE	T.O.M.	TOP OF MASONRY PARAPET
D.F.	DRINKING FOUNTAIN	MAS.	MASONRY	T.P.	TOILET PAPER HOLDER
DBL	DOUBLE	MAT.	MATERIALS	T.S.	TACK STRIP
DA.	DIAMETER	MAX.	MAXIMUM	TYP.	TEACHING STATION
DIM.	DIMENSION	MB, M.B.	MARKER BOARD	T.W.	TEACHING WALL
DISP.	DISPENSER	M.C.	MEDICINE CABINET	TYP.	TYPICAL
DR.	DOOR	MECH.	MECHANICAL	U.L.	UNDERWRITERS
DW	DRYWALL	MET., MTL.	METAL	U.O.N.	UNLESS OTHERWISE NOTED
DS	DOWNSPOUT	MFR.	MANUFACTURER	U.S.G.	U.S. GYPSUM COMPANY
DWG.	DRAWING	MIN.	MINIMUM	V.A.T.	VINYL ASBESTOS TILE
EA.	EACH	M.O.	MASONRY OPENING	V.C.T.	VINYL COMPOSITION TILE
EJ, EJ	EXPANSION JOINT	M.S.	METAL SHELVING	VERT.	VERTICAL
ELEC.	ELECTRIC(IAL)	MTD.	MOUNTED	VEST., V.	VESTIBULE
EP	EPOXY PAINT	N.C., NONCOM.	NON COMBUSTIBLE	V.R.G.	VINYL REDUCER STRIP
EQ.	EQUAL	NOT IN CONTRACT		V.T.R.	VENT THROUGH ROOF
EQUIP, EQPT	EQUIPMENT	NO., #	NUMBER	W.	WOMEN
E.W.C.	ELECTRIC WATER COOLER	N.T.S.	NOT TO SCALE	W.	WITH
		ON CENTER		W.	WAINSCOT
EXG.	EXISTING	O.D.	OUTSIDE DIAMETER	WARD.	WARDROBE
EXP.	EXPANSION	OFF.	OFFICE	W.C.	WATER CLOSET
EXT.	EXTERIOR	O.H.	OPPOSITE HAND	WD.	WOOD
F.C.	FIRE CODE	OPNG.	OPENING	WDR.	WARDROBE
F.C.U.	FAN COIL UNIT	PART.	PARTITION	WL.	WALL
F.D.	FLOOR DRAIN	PLAM., P-LAM	PLASTIC LAMINATE	W.M.	WALL-MOUNTED
FON.	FOUNDATION	PLY., PWD	PLYWOOD	W.W.W.	WELDED WIRE MESH
F.E.	FIRE EXTINGUISHER	P.N.L.	PANEL		
		PS., P.S.	PROJECTOR SCREEN		

SYMBOLS OF MATERIALS

ALL METALS-SMALL SCALE	GLAZED C.M.U.
ACOUSTIC C.M.U. SMALL SCALE	PARTICLE BOARD
ACOUSTIC C.M.U. LARGE SCALE	RIGID INSULATION
BATT INSULATION	SHINGLES
BRICK	SOLID CONCRETE MASONRY UNITS
CAST STONE	STEEL-LARGE SCALE
CONCRETE	STUD PARTITION
CONCRETE MASONRY UNITS	WOOD-FINISH
EARTH	WOOD BLOCKING
GLASS-LARGE SCALE	


DRAWING KEYS

0	STRUCTURAL GRID LINES
1 A101	SECTION
1 A101	ELEVATION
1 A101	DETAILS IN PLAN, SECTION
11	WALL TYPE, SEE A501
Name 101	ROOM NAME AND NUMBER
11	WINDOW TAG
101	DOOR TAG
	NEW WALL
	EXISTING WALL TO REMAIN
	EXISTING WALL TO BE REMOVED

NEW CONSTRUCTION OF

WEST BRUNSWICK HIGH SCHOOL NEW ROTC BUILDING

550 WHITEVILLE ROAD N.W.
SHALLOTTE, NC 28470

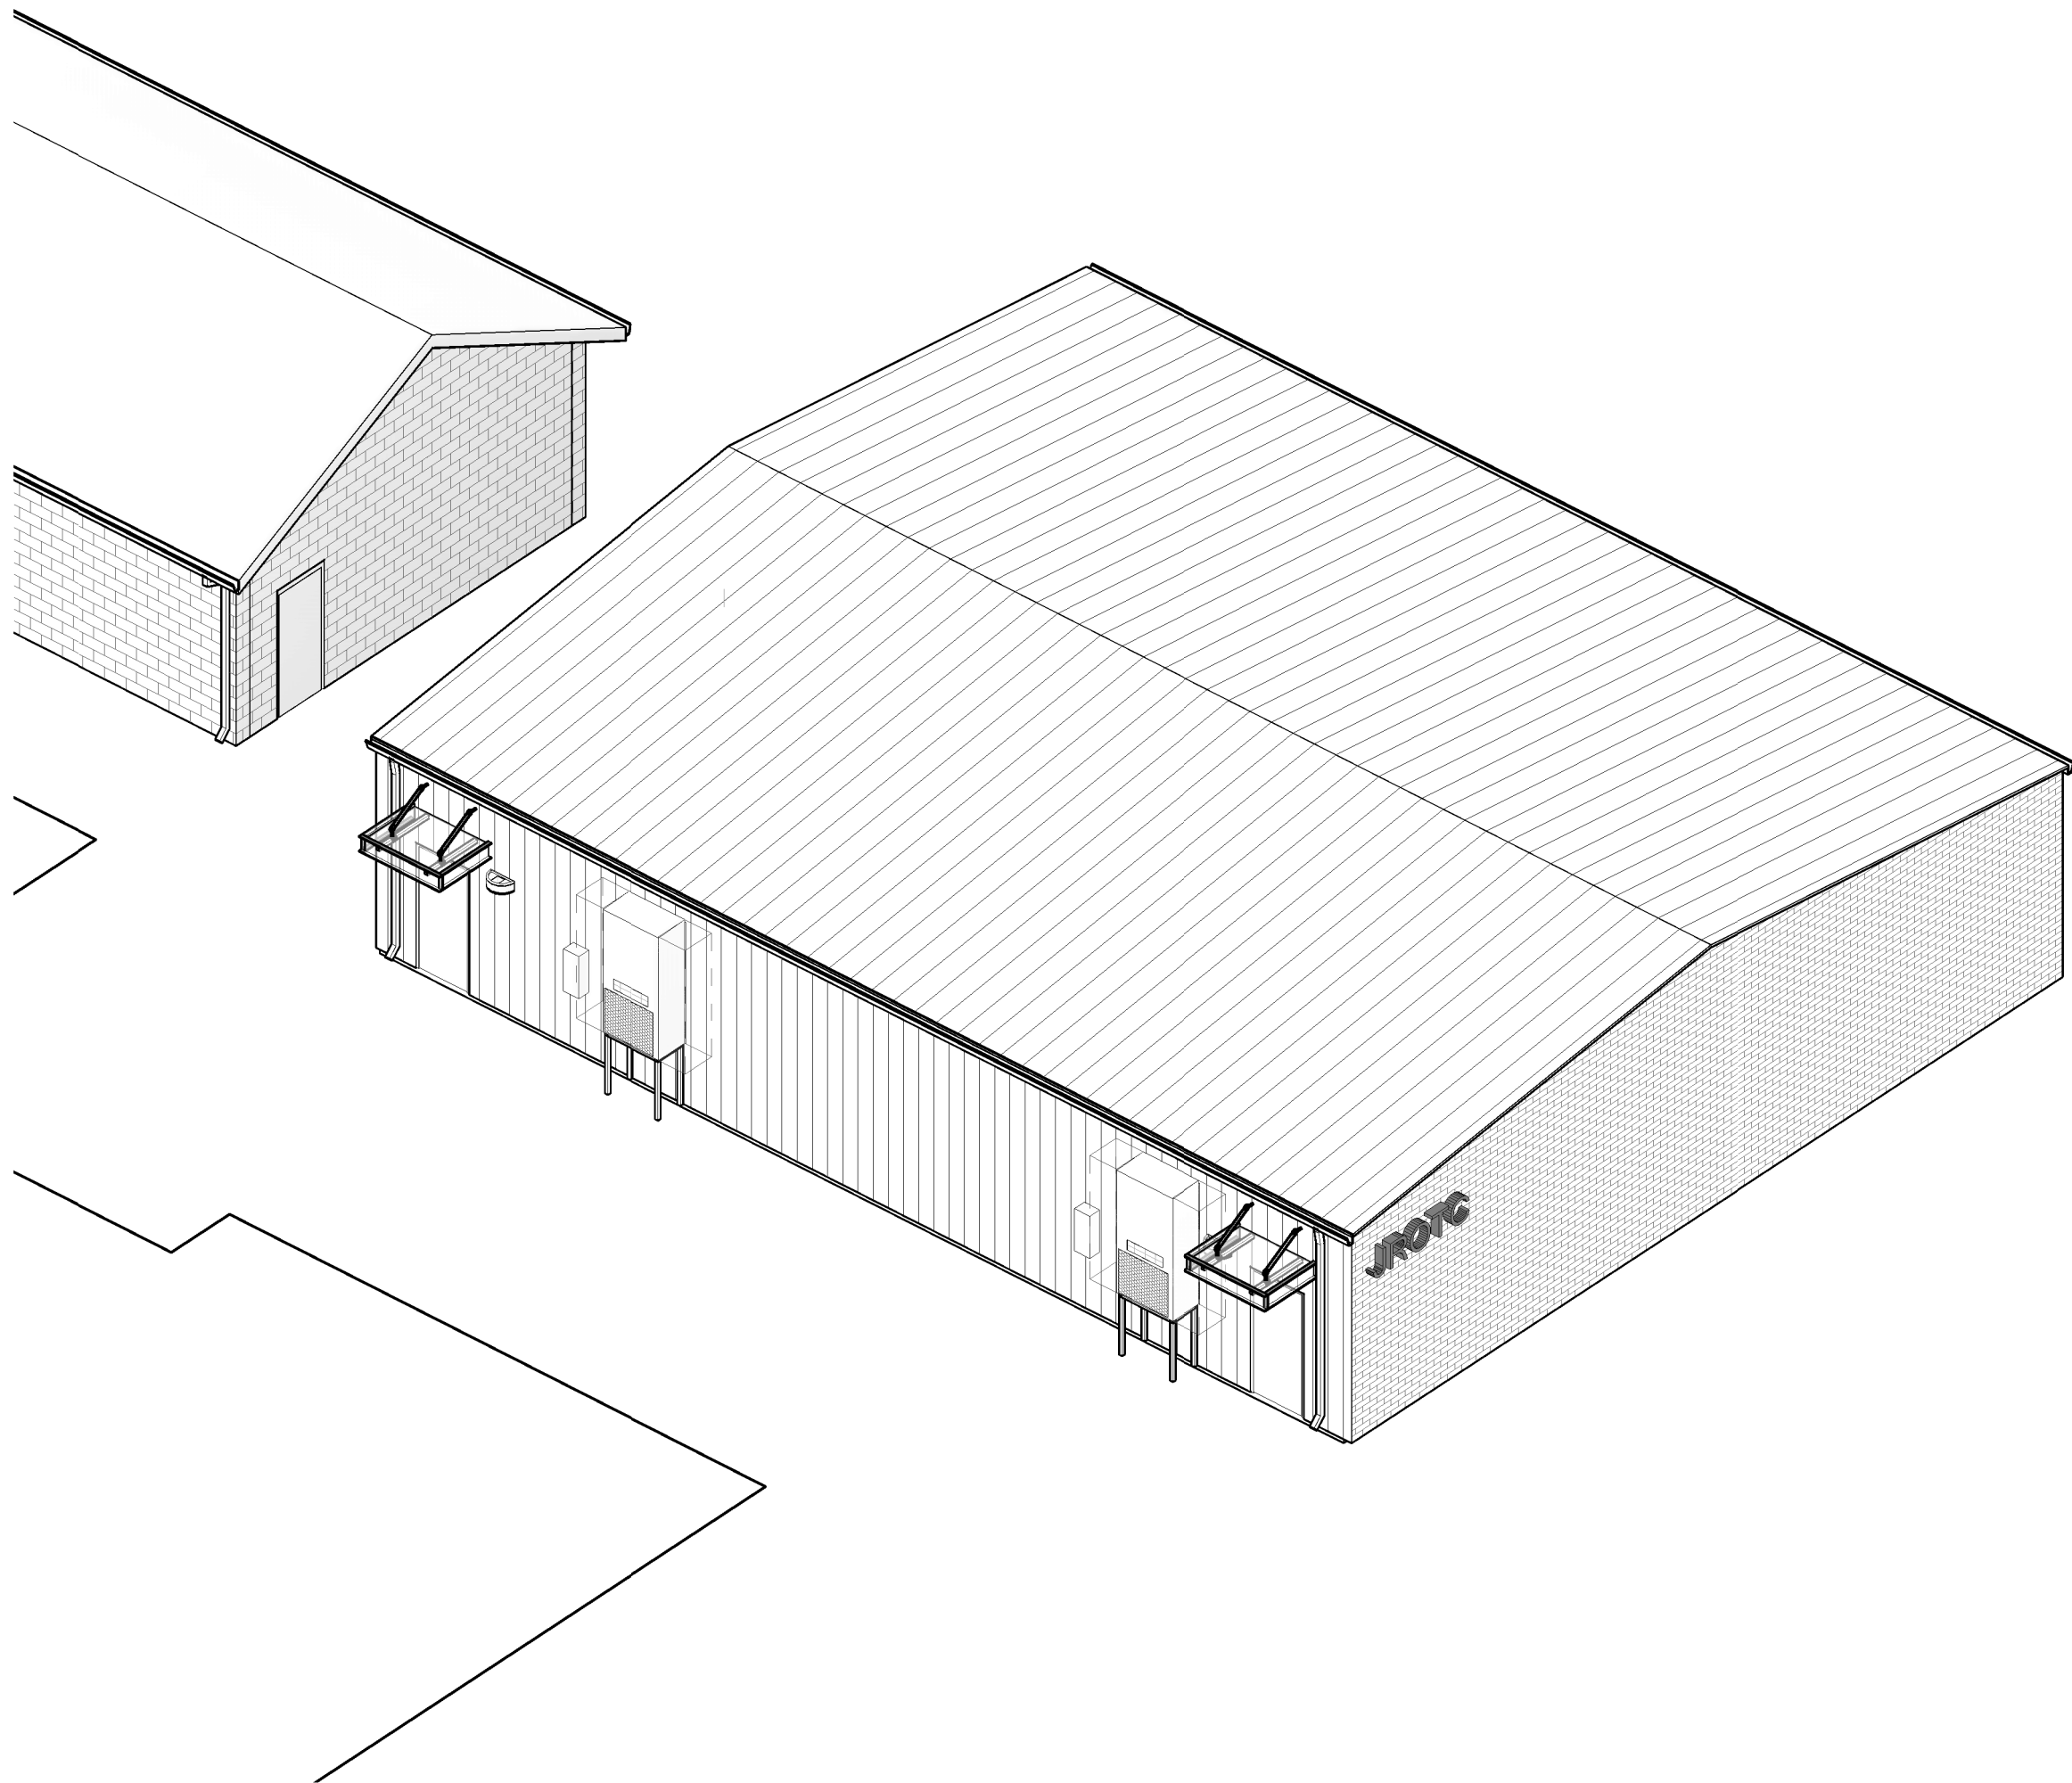

ISSUED FOR BIDDING
NOT FOR CONSTRUCTION

04.16.2020

DESIGN TEAM

BECKER MORGAN GROUP, INC.
WOODS ENGINEERING, P.A.
CBHF ENGINEERS, PLLC
PARAMOUNTE ENGINEERING, INC.
W.M. JORDAN COMPANY

ARCHITECTS
STRUCTURAL ENGINEERS
MECHANICAL, PLUMBING AND ELECTRICAL ENGINEERS
CIVIL ENGINEERS
CONSTRUCTION MANAGERS

DRAWING LIST

SHEET No.	SHEET TITLE
GENERAL	
G001	COVER SHEET
G101	ROTC BUILDING CODE SUMMARY
G201	CAMPUS LIFE SAFETY PLAN
G202	ROTC LIFE SAFETY PLAN
G301	ComCHECK
CIVIL	
C-0.0	COVER SHEET
C-1.0	GENERAL NOTES
C-1.1	GENERAL NOTES
C-2.0	DEMOLITION PLAN
C-2.1	DEMOLITION PLAN
C-2.2	DEMOLITION PLAN
C-2.3	OVERALL SITE PLAN
C-2.4	SITE PLAN
C-2.5	SITE PLAN
C-2.6	SITE PLAN
C-3.0	GRADING - DRAINAGE - EC PLAN
C-3.1	GRADING - DRAINAGE - EC PLAN
C-4.0	UTILITY PLAN
C-4.1	UTILITY PLAN
C-5.0	DETAILS
C-5.1	DETAILS
C-5.2	DETAILS
C-5.3	DETAILS
C-5.4	DETAILS
LANDSCAPING	
L-1.0	LANDSCAPE PLAN
STRUCTURAL	
S101	GENERAL NOTES
S102	TYPICAL DETAILS
S201	ROTC BUILDING FOUNDATION PLAN
S301	FOUNDATION SECTIONS AND DETAILS
ARCHITECTURAL	
A001	CONSTRUCTION TYPES
A101	ROTC PLANS
A201	ROTC EXTERIOR ELEVATIONS
A301	ROTC BUILDING SECTION AND WALL SECTIONS
A302	DETAILS
A401	ROTC ENLARGED PLANS AND DETAILS
A501	SCHEDULES AND DETAILS
PLUMBING	
P101	ROTC BUILDING - PLUMBING
MECHANICAL	
M001	MECHANICAL ABBREVIATIONS, LEGEND, ENERGY & MECH SUMMARIES
M101	ROTC FLOOR PLAN
M501	HVAC DETAILS
M502	HVAC DETAILS
M601	MECHANICAL SCHEDULES
ELECTRICAL	
E001	ELECTRICAL SYMBOLS AND ABBREVIATIONS
E100	ELECTRICAL SITE PLAN
E101	ROTC FLOOR PLANS - POWER, HVAC POWER AND SYSTEMS
E201	ROTC FLOOR PLAN - LIGHTING
E501	ELECTRICAL DETAILS
E502	ELECTRICAL DETAILS
E601	ELECTRICAL RISER DIAGRAM AND SCHEDULES
E602	ELECTRICAL SYSTEMS RISER DIAGRAMS
FIRE PROTECTION	
F101	ROTC FLOOR PLAN - FIRE ALARM
F601	FIRE ALARM RISER DIAGRAM, LEGEND AND NOTES




ARCHITECTURE
PLANNING

North Carolina
3333 Jackle Drive, Suite 120
Wilmington, NC 28403
910.341.7600

Maryland
312 West Main St, Suite 300
Salisbury, MD 21801
410.546.9100

Delaware
309 S Governors Ave
Dover, DE 19904
302.734.7950
Rittenhouse Station
250 South Main Street, Suite 109
Newark, DE 19711
302.369.3700
www.beckermorgan.com

ISSUED
FOR BIDDING
NOT FOR CONSTRUCTION
ISSUED: 04/16/20

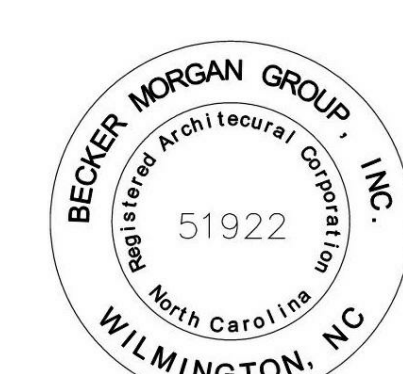

PROJECT TITLE

WEST
BRUNSWICK
HIGH SCHOOL
NEW ROTC
BUILDING

550 WHITEVILLE ROAD N.W.
SHALLOTTE, NC 28470

DSP #: 100
DPI SCHOOL #: 1167

SHEET TITLE

COVER SHEET

Mark	Date	Description
1	05.04.20	ADDENDUM 1
	04.16.20	ISSUED FOR BIDDING
	03.20.20	100% REV. SUBMISSION
	10.14.19	NCDPI DD SUBMISSION
	07.30.19	SD PROGRESS DWGS
	07.11.19	NCDPI SD SUBMISSION

PROJECT NO: 2019083.01
DATE: 04.16.2020
SCALE: 1" = 1'-0"
DRAWN BY: LJR PROJ MGR: RMC

G001
COPYRIGHT © 2020