



U. S. COAST GUARD
CIVIL ENGINEERING UNIT
CLEVELAND



USCG. CEU CLEVELAND
1240 EAST 9TH STREET
CLEVELAND, OH 44199-2060

MARK	DATE	DESCRIPTION
04	01/21/20	FINAL SUBMITTAL
03	01/07/20	100% SUBMITTAL
02	12/05/19	95% SUBMITTAL
01	10/29/19	35% SUBMITTAL

A/E PROJECT NO:	
CAD FILE NAME: C8560M105.dwg	
DESIGNED BY:	S. HOUSTON
DRAWN BY:	S. HOUSTON
EDITED BY:	S. HOUSTON
CHECKED BY:	J. NADER

SCALE: AS SHOWN PLOT SCALE: 1:1


SHEET TITLE
**REPAIR HVAC SYSTEM
CG STATION OAK ISLAND
OAK ISLAND NC
MULTI-PURPOSE BUILDING
MECHANICAL
SECOND FLOOR PIPING PLAN**

REVIEWED BY: <i>[Signature]</i>	REVIEWED BY: <i>[Signature]</i>	REVIEWED BY: <i>[Signature]</i>
PROJECT ENG.	BRANCH CHIEF	TECH. DIRECTOR

J. M. HALL, CDR
APPROVING OFFICER
DATE: 01/21/20

PROJECT NUMBER 12190963	DRAWING NUMBER 8560-D
-----------------------------------	---------------------------------

DISCIPLINE/SHT NO M-105	SHEET 20 OF 29
-----------------------------------	------------------------------

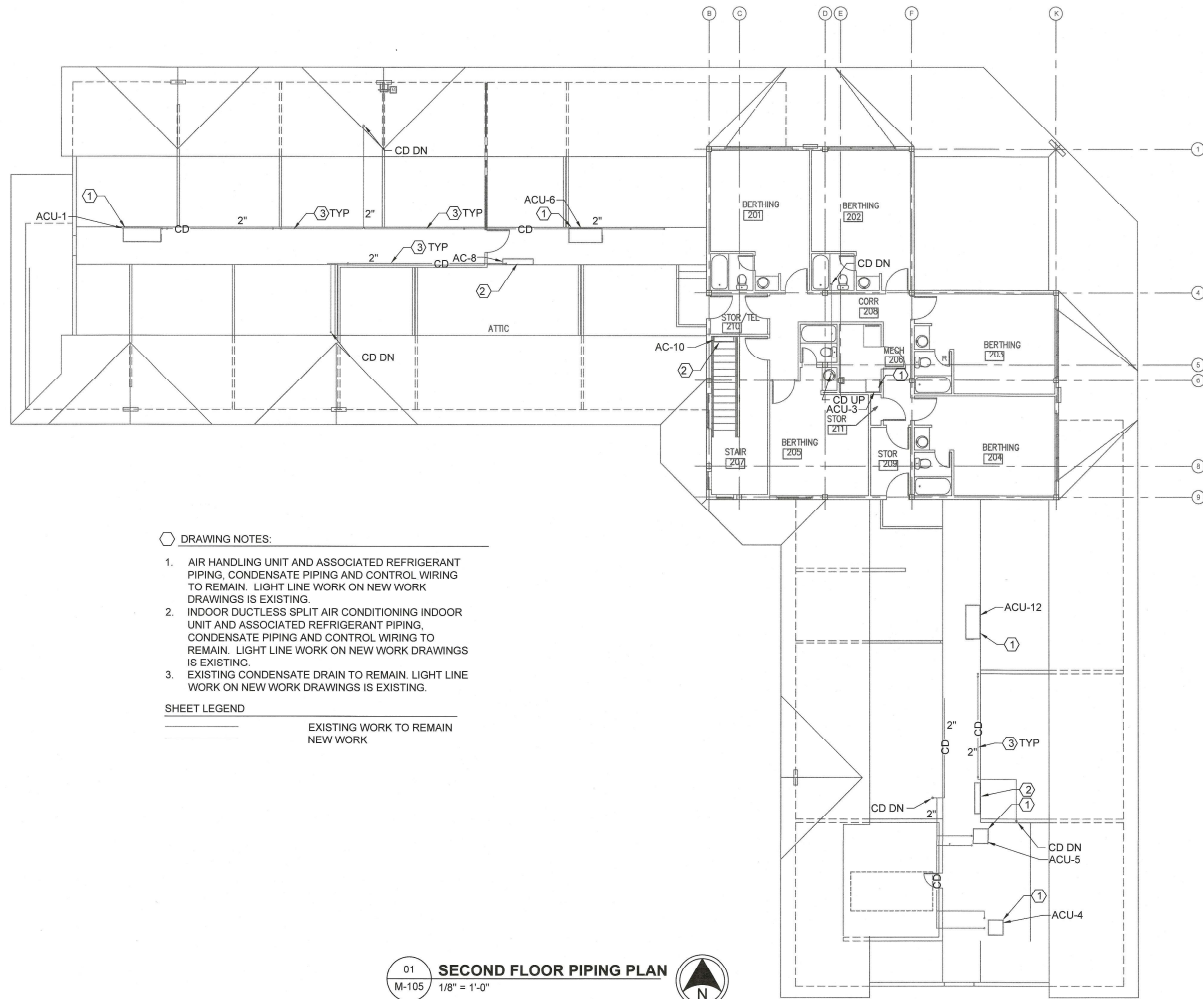

DRAWING NOTES:

- AIR HANDLING UNIT AND ASSOCIATED REFRIGERANT PIPING, CONDENSATE PIPING AND CONTROL WIRING TO REMAIN. LIGHT LINE WORK ON NEW WORK DRAWINGS IS EXISTING.
- INDOOR DUCTLESS SPLIT AIR CONDITIONING INDOOR UNIT AND ASSOCIATED REFRIGERANT PIPING, CONDENSATE PIPING AND CONTROL WIRING TO REMAIN. LIGHT LINE WORK ON NEW WORK DRAWINGS IS EXISTING.
- EXISTING CONDENSATE DRAIN TO REMAIN. LIGHT LINE WORK ON NEW WORK DRAWINGS IS EXISTING.

SHEET LEGEND

EXISTING WORK TO REMAIN
NEW WORK

01
M-105
SECOND FLOOR PIPING PLAN
1/8" = 1'-0"

