

WESCP, LLC
WILMINGTON EYE SURGERY CENTER

1915 & 1919 S. 16th STREET, WILMINGTON, NC 28403

DESIGNER



8208 Brownleigh Drive, Suite 200
Raleigh, NC 27617
Tel: 919-460-6700 Fax: 919-460-6733

CONSULTANTS



2246 Yaupon Drive Phone: 910.791.4000
Wilmington, NC 28401 Fax: 910.791.5266
www.cbhfhengineers.com
© Copyright 2020 CBHF Engineers, PLLC



PRINCIPAL: DMH
PROJECT MANAGER: DMH

REVISIONS

NO.	BY	DESCRIPTION	DATE
1		ISSUE FOR REVIEW	07.10.20
		KEY PLAN	

DATE: 07-10-2020 DRAWN BY: GRM
PROJECT NO.: 20190431 SCALE: AS NOTED
DHSR NO.: AS-422 FID NO.:



DRAWING NAME: FLOOR PLAN - HVAC
FLOOR/SECTION PHASE: CD
DRAWING NO.: M1.2

GENERAL NOTES

- COORDINATE DUCT ELEVATIONS AND ROUTING WITH OTHER TRADES PRIOR TO INSTALLATION.
- MAINTAIN MANUFACTURER'S CLEARANCE REQUIREMENTS FOR INDOOR AND OUTDOOR EQUIPMENT.
- REFER TO ARCHITECTURAL DRAWINGS FOR RATED UL NUMBERS (WALLS, FLOOR / CEILINGS, ETC.).
- FIELD ROUTE REFRIGERANT PIPING IN A PROFESSIONAL MANNER FOLLOWING THE MANUFACTURER'S INSTALLATION INSTRUCTIONS.
- COORDINATE CONDENSATE PIPE ROUTING WITH GENERAL CONTRACTOR AND OWNER, TYPICAL.
- CONCERNING DIFFUSER LAYOUT AND CEILING TYPE, REFER TO ARCHITECTURAL PLANS FOR FURTHER INFORMATION.


KEYED NOTES

- PROVIDE DOUBLE THICKNESS TURNING VANES IN ALL NON-RADIUS ELBOWS.

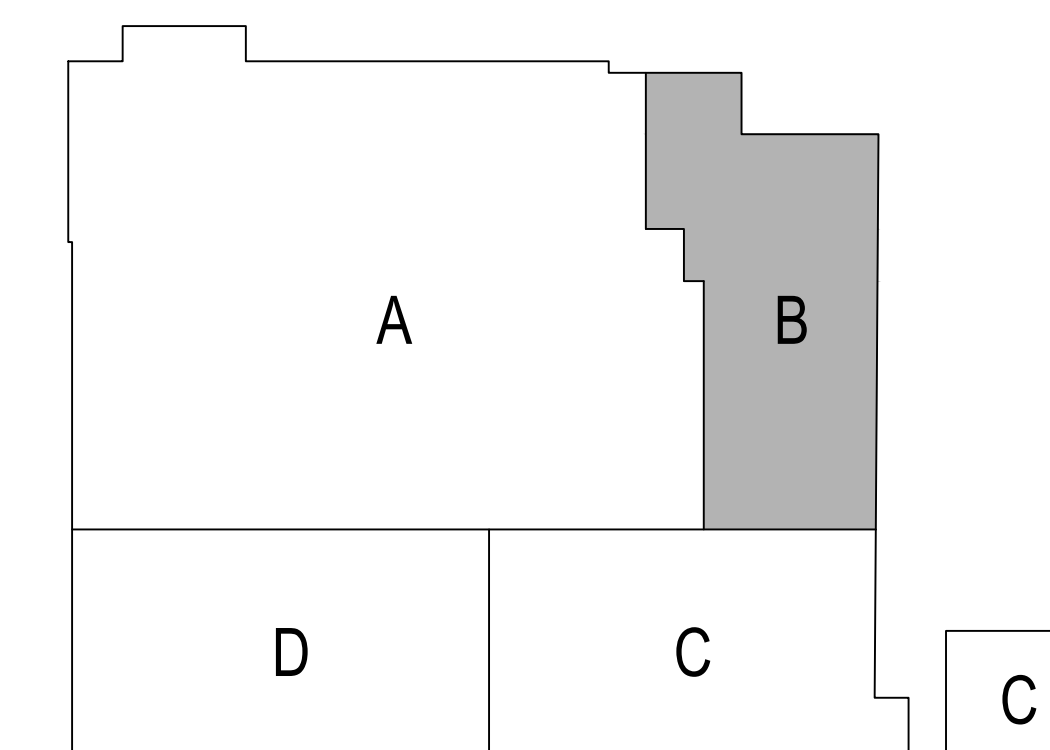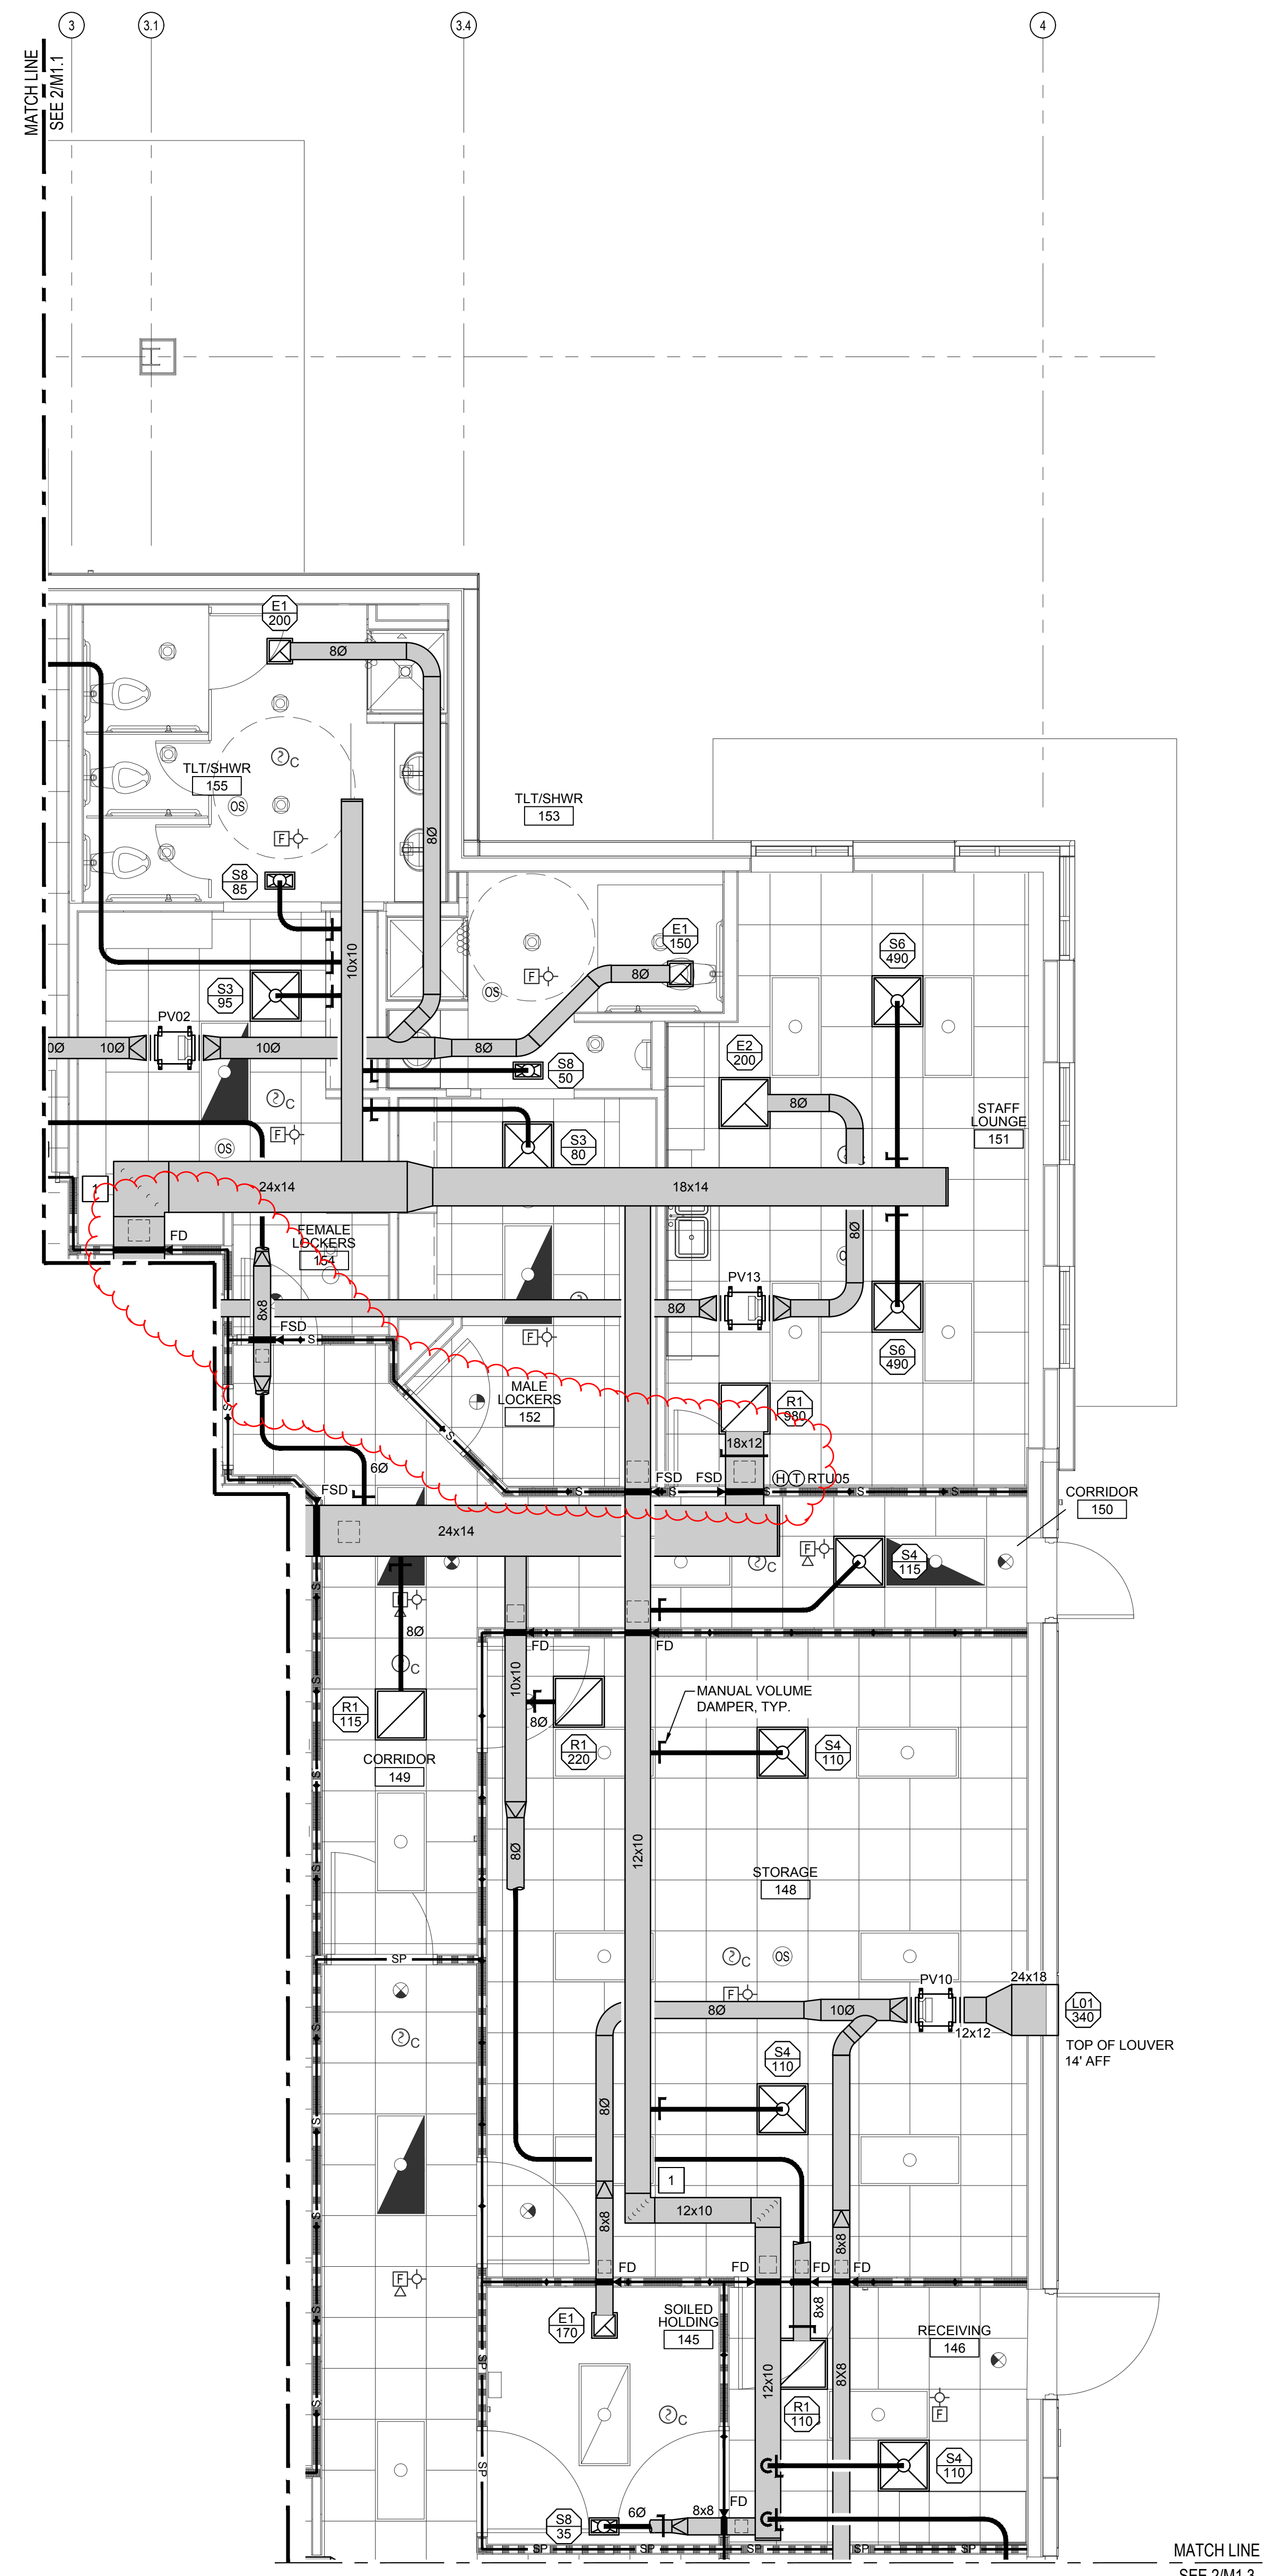

FIRE WALL LEGEND

1-HOUR RATED FIRE BARRIER	—
1-HOUR RATED SMOKE BARRIER	—S
1-HOUR RATED SMOKE PARTITION	—SP

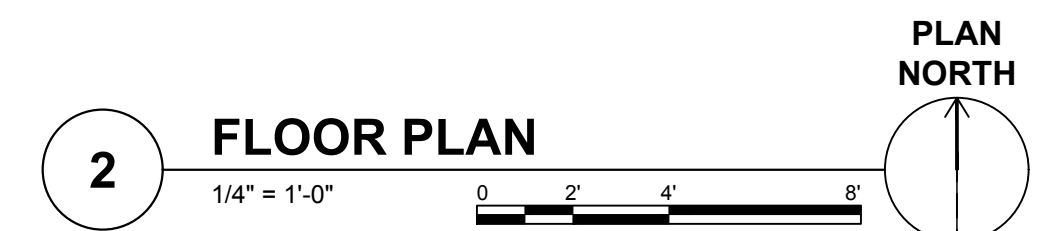

MATCH LINE
SEE 2/M1.3