



**Country Club of Landfall – Dye Club House Renovation
Addendum 3 – 9/4/2020**

Prebid Walk-Through

The building will be open to all for an optional walk-through on September 10 between the hours of 11:00 and 1:00. This site is actively under construction. Hard hats and a face mask are required when entering the building.

Revised Drawings issued


CS-1 Accessible Walkway Modifications Site Plan – 8/20/20

CS-2 Site Detail – 8/20/20

ASI 4 Drawings – Low Voltage Revisions:

- E0.1 – Electrical Legend and Detail
- E0.7 – Electrical Panel Schedules
- E0.8 – Electrical Panel Schedules
- ED1.1 – Electrical First Floor Demo Plan
- EL1.1 – Electrical First Floor Lighting Plan
- EP1.1 – Electrical First Floor Power Plan
- EP1.2 – Electrical Second Floor Power Plan
- EP1.3 – Electrical Attic Power Plan
- EP4.1 – Electrical Enlarged Power Plan
- EP4.2 – Electrical Enlarged Power Plans

The bid date remains September 4 by 3:00.

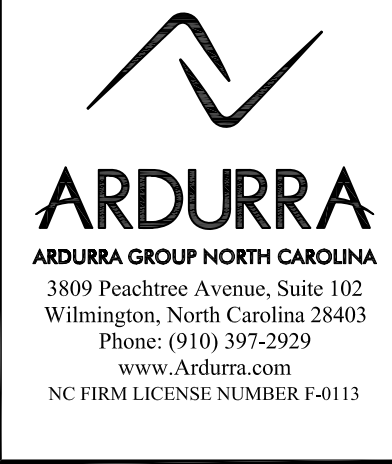

--

[illegible]


LANDFALL DYE CLUBHOUSE 1550 LANDFALL DRIVE, WILMINGTON, N.C.	ACCESSIBLE WALKWAY MODIFICATIONS SITE PLAN
---	---





JOB NO:	2020-0154-00
DATE:	AUG. 20, 2020

CS-1

FOR REVIEW
8/20/20

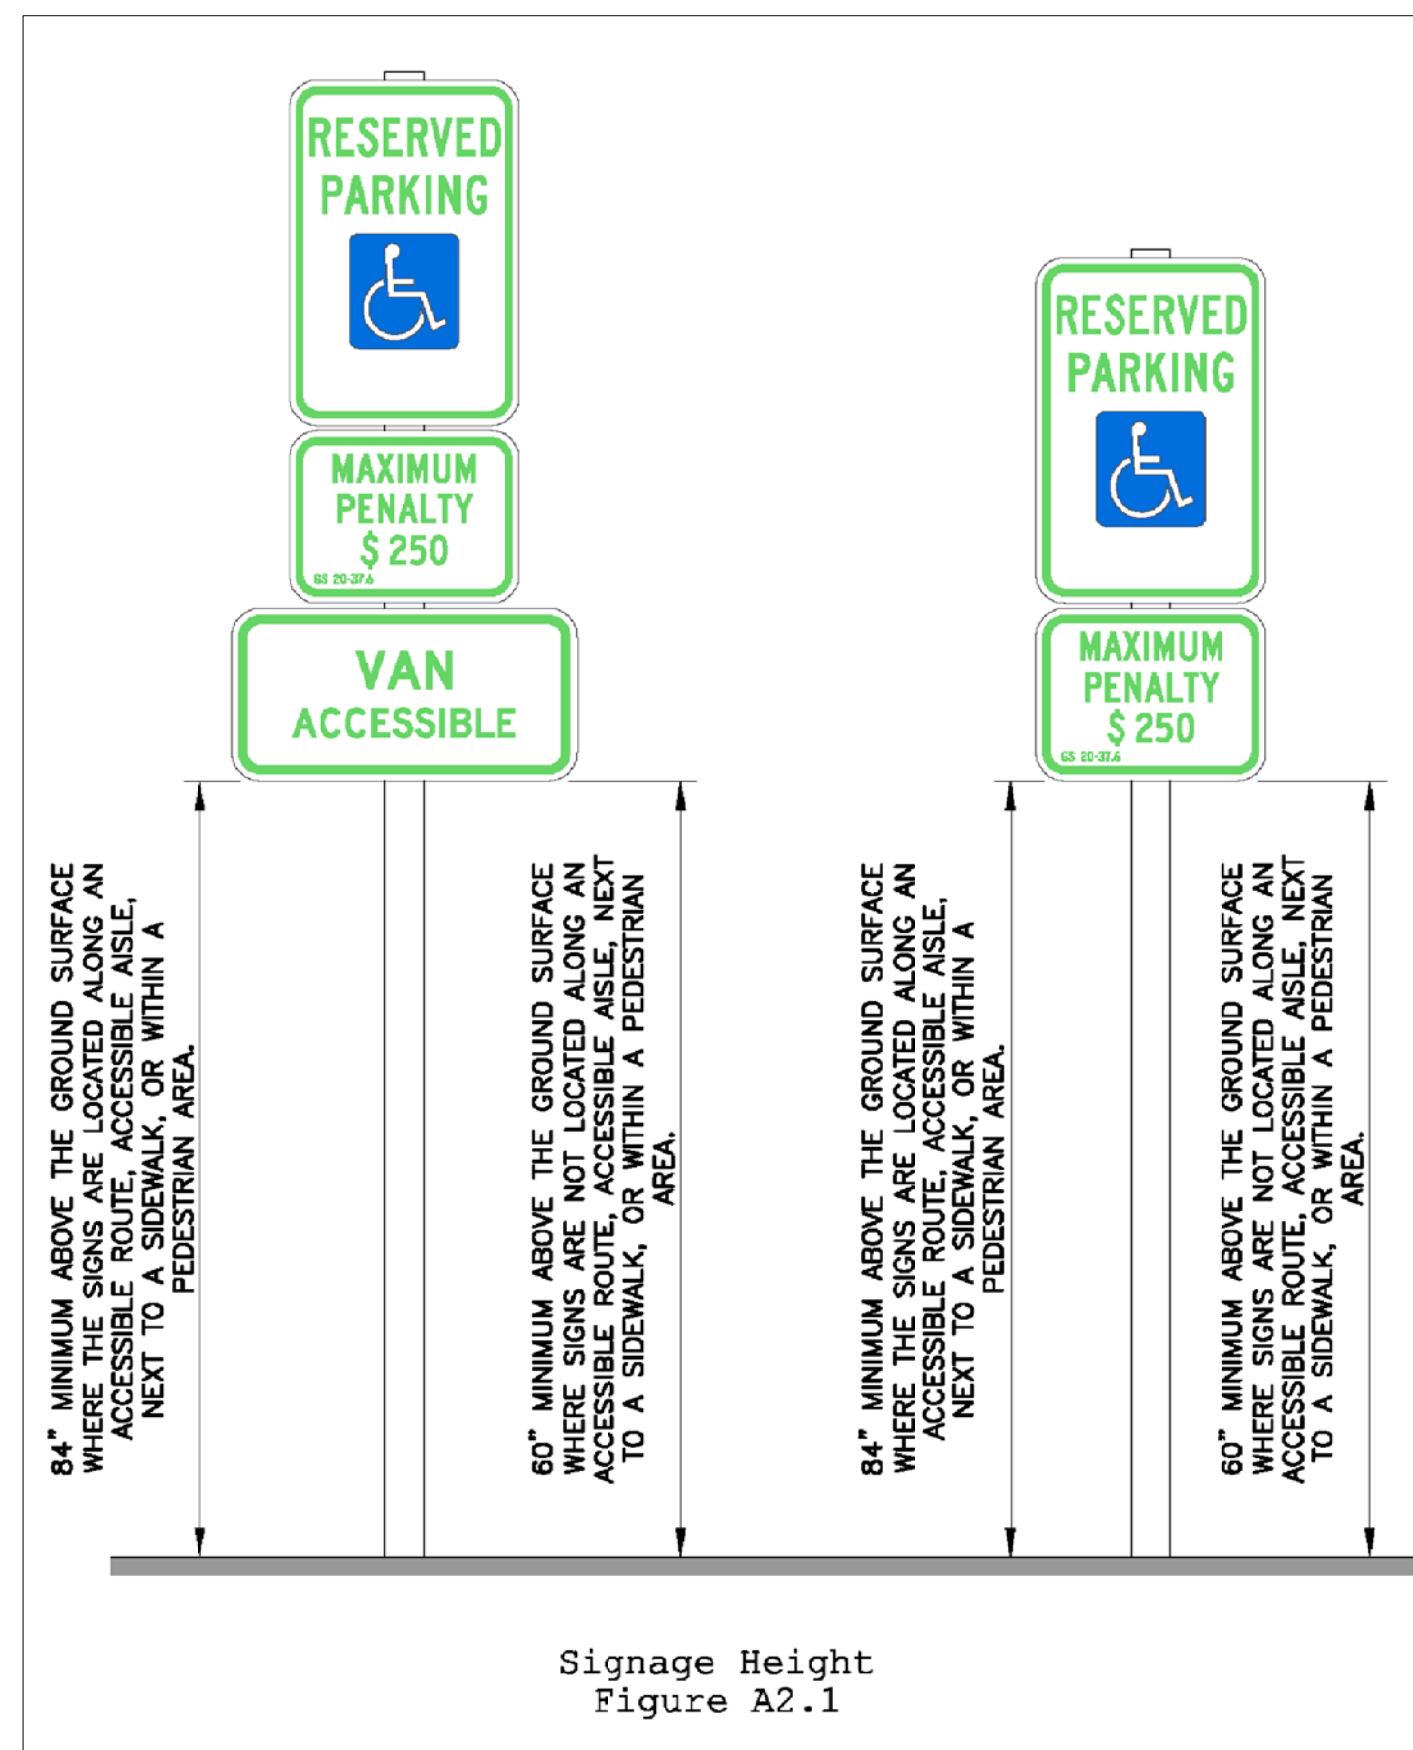


ACCESSIBLE PARKING SIGN DETAILS

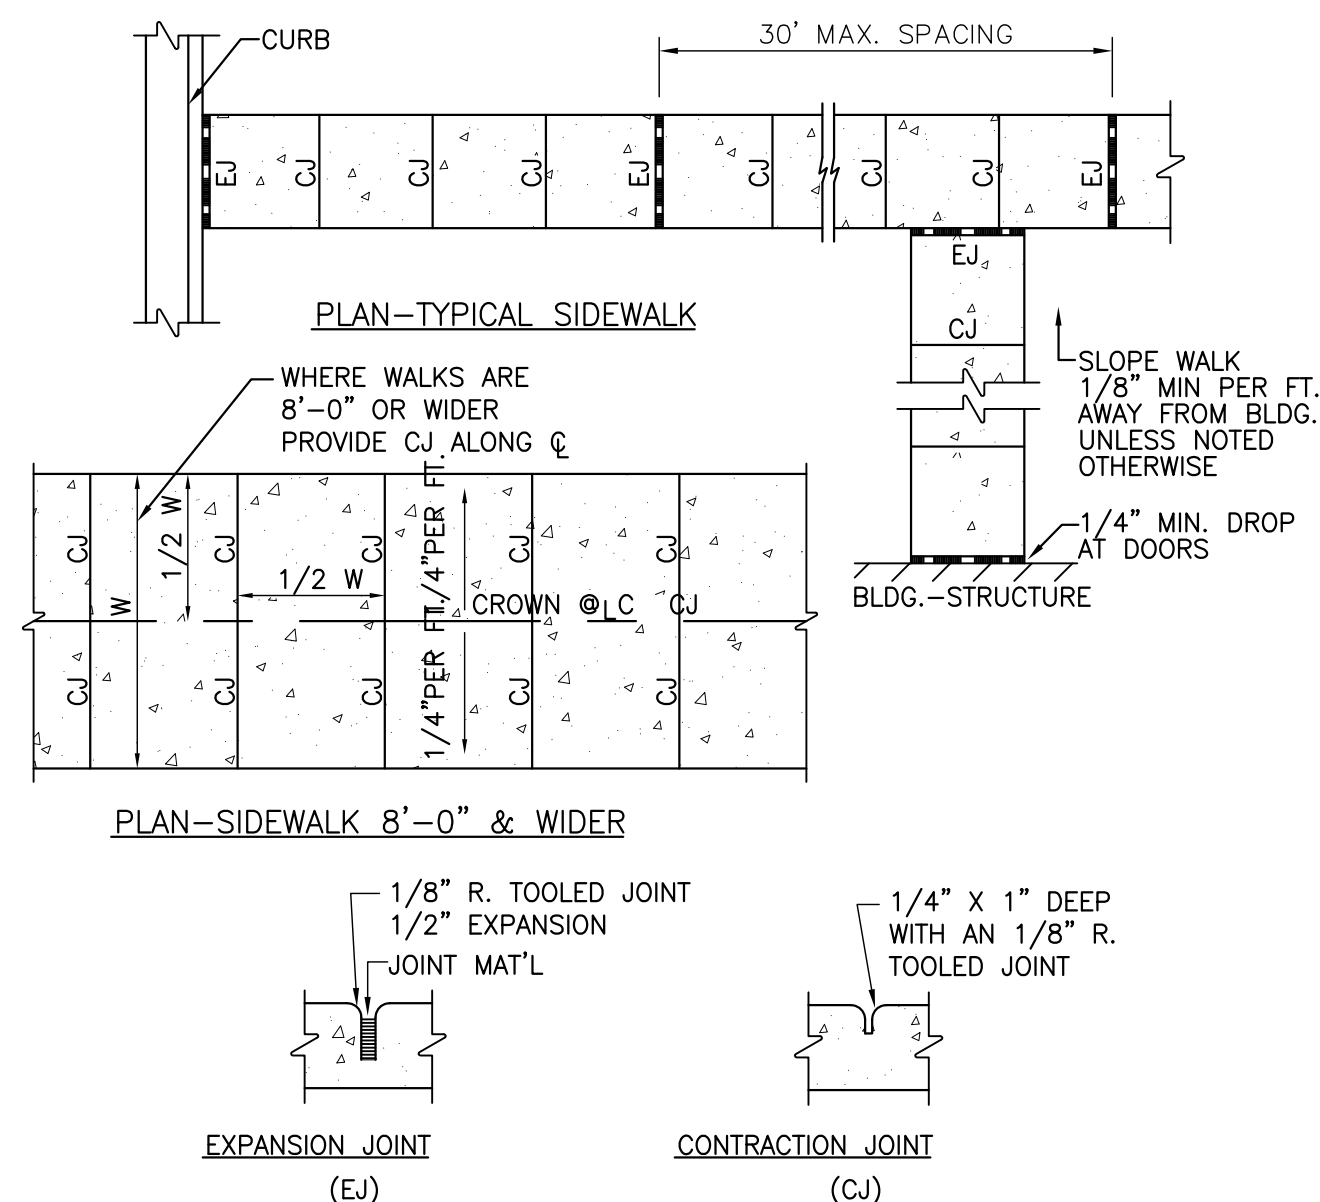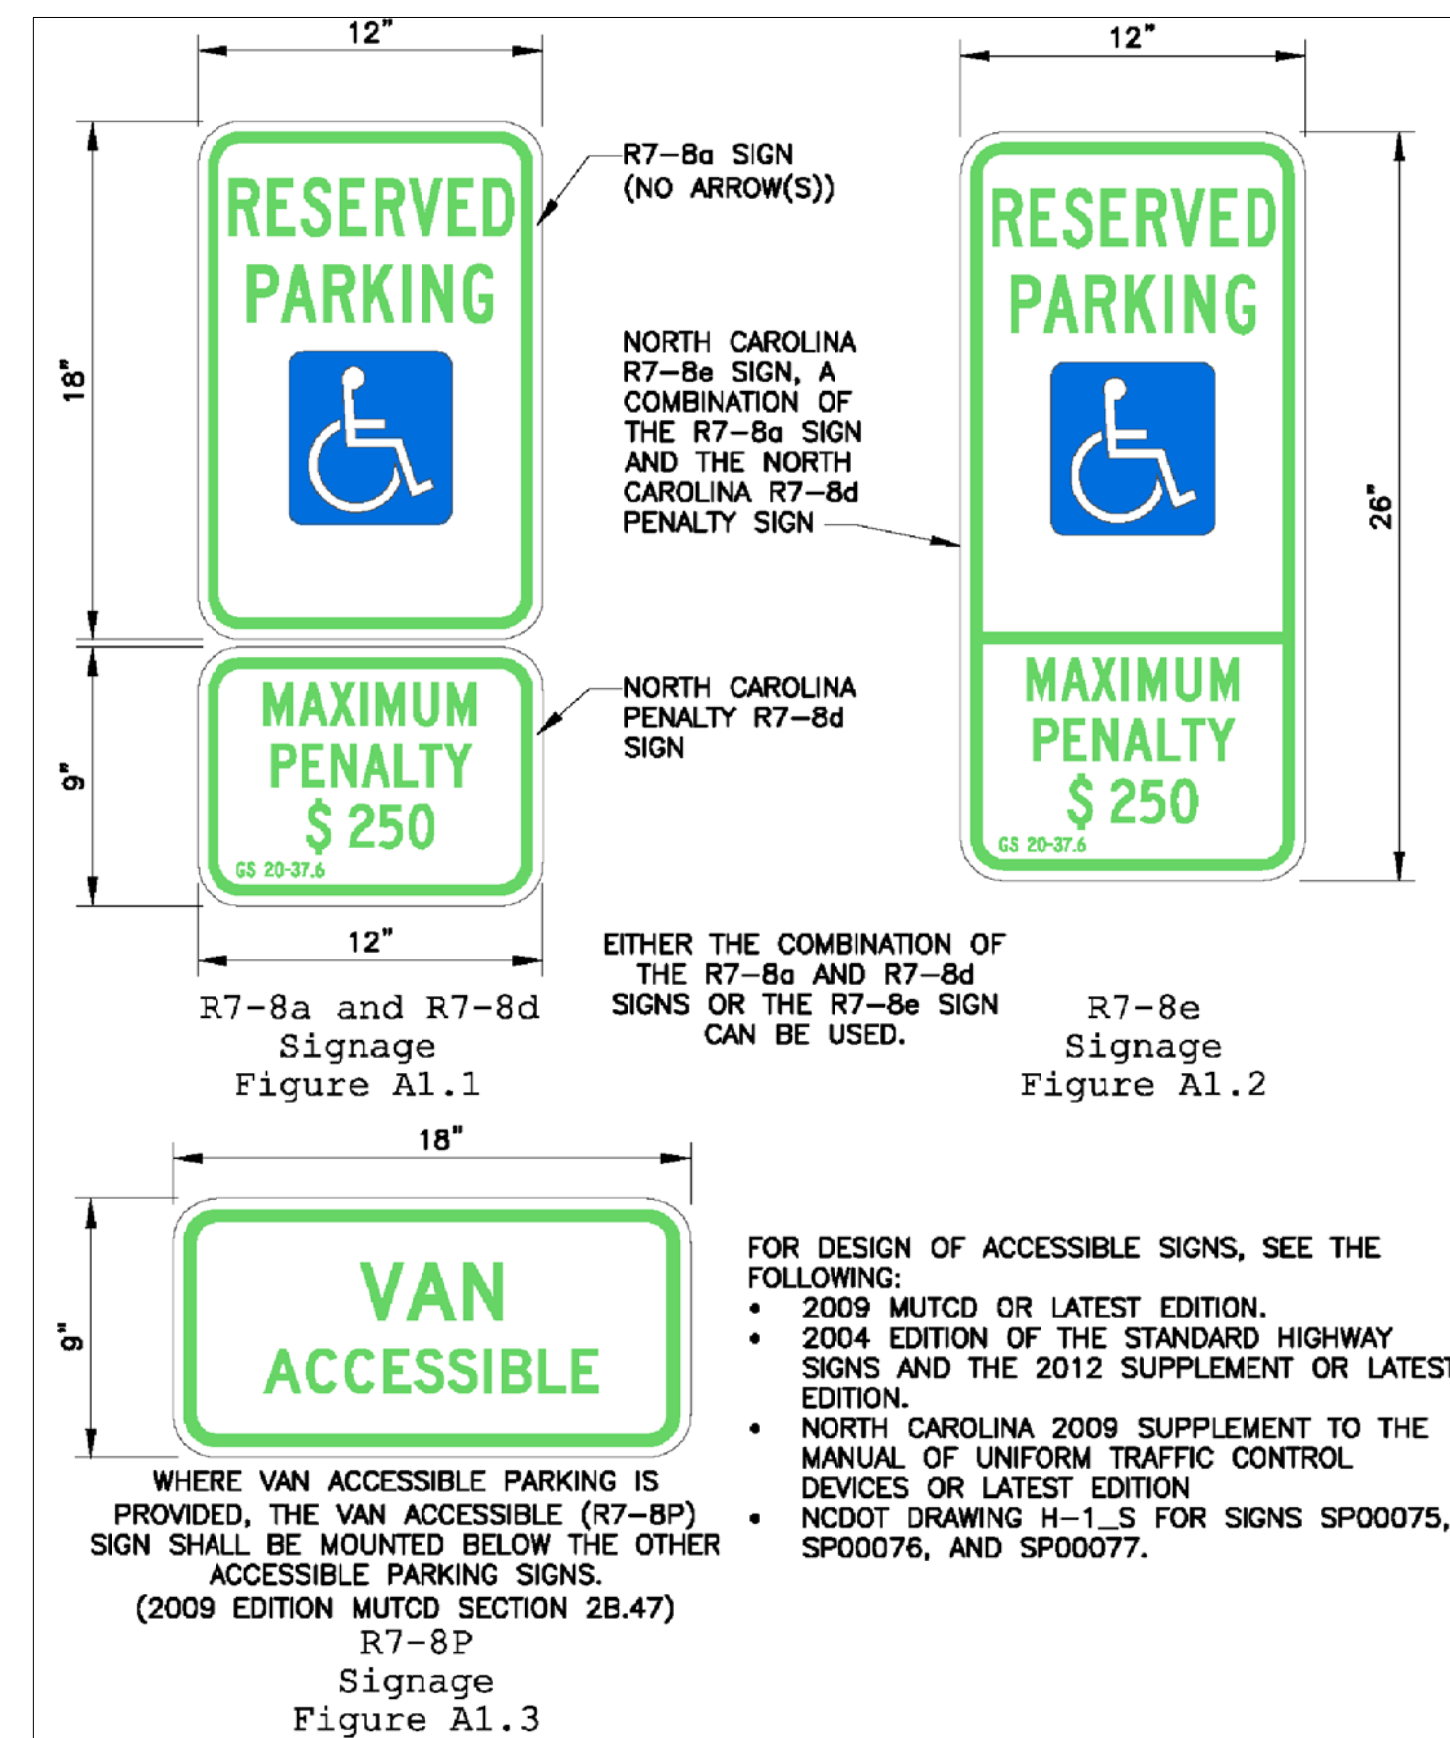

- NOTES:**
1. SIDEWALK THICKNESS SHALL BE 4" UNLESS NOTED OTHERWISE.
 2. CONTRACTION JOINTS (CJ), SPACE SAME AS SIDEWALK WIDTH.
 3. THICKEN SIDEWALK TO 6" AT DRIVEWAYS.
 4. THICKEN SIDEWALK TO 6" IN LAST 3' WHERE IT ABUTS PAVEMENT WITH NO CURB.
 5. 1/2" EXPANSION JOINT (EJ) REQ'D AT 30' MAX., AT SIDEWALK JUNCTIONS, AT STRUCTURES AND AS NOTED ON SITE PLAN.


STANDARD SIDEWALK DETAIL

SCALE: N.T.S.

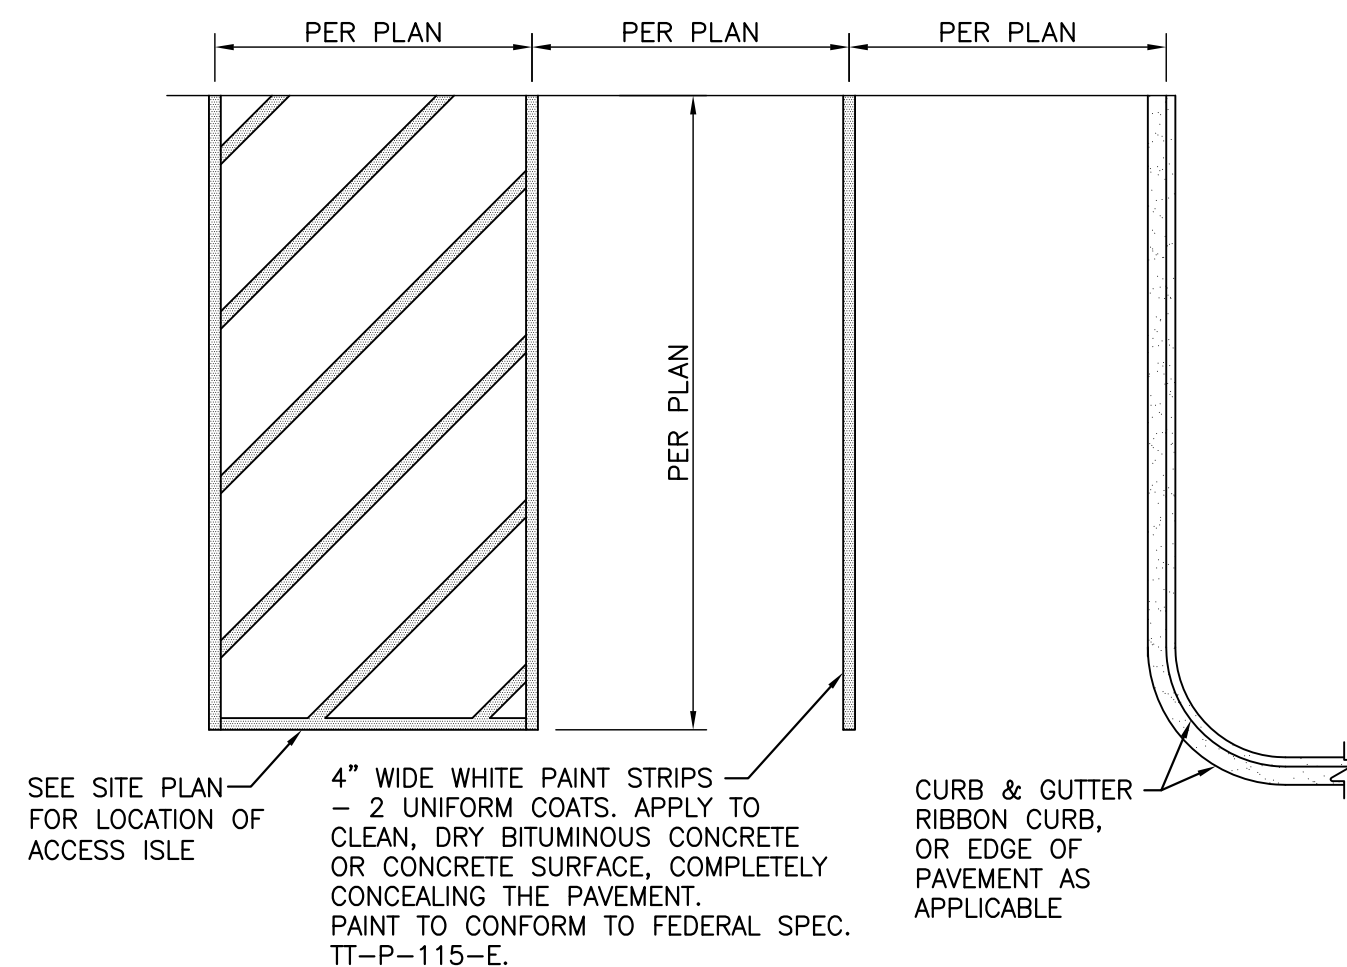

PAINT STRIPE DETAIL

SCALE: N.T.S.

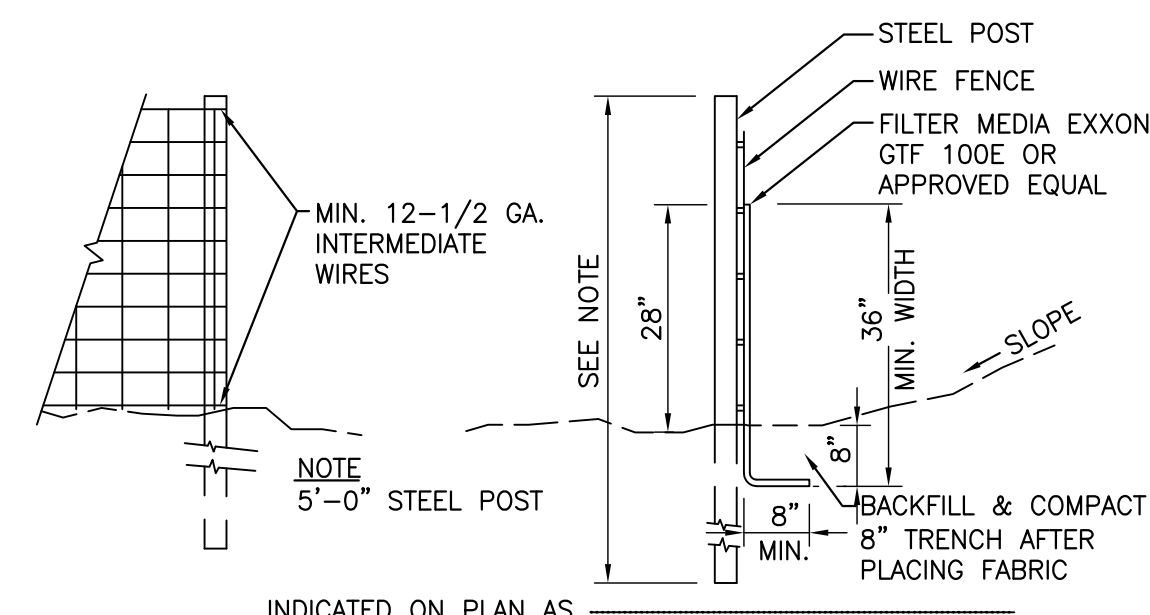


INDICATED ON PLAN AS

NOTES:

- 1.) WIRE FENCE SHALL BE A MIN. OF 32" IN WIDTH AND SHALL HAVE A MIN. OF SIX LINE WIRES WITH 12" STAY SPACING.
- 2.) FILTER FABRIC SHALL MEET OR EXCEED 150 LBS. GRAB TENSILE (ASTM-D-1682), 180 PSI. BURST (ASTM-D-2263) AND 70 ON COE E.O.S. TEST.
- 3.) STEEL POST SHALL BE 5'-0" IN HEIGHT AND BE OF THE SELF-FASTENER TYPE.
- 4.) STEEL POSTS FOR SILT FENCE SHALL BE NO WIDER THAN 8' APART O.C. WITH WIRE BACKING.
- 5.) CONTRACTOR TO FIELD LOCATE AS NECESSARY TO CONTROL SURFACE EROSION.

TEMPORARY SILT FENCE/INLET PROTECTION

SCALE: N.T.S.

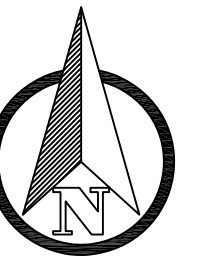

ARDURRA

ARDURRA GROUP NORTH CAROLINA
3809 Peachtree Avenue, Suite 102
Wilmington, North Carolina 28403
Phone: (910) 397-2929
www.Ardurra.com
NC FIRM LICENSE NUMBER F-0113

[illegible]

LANDFALL DYE CLUBHOUSE
1550 LANDFALL DRIVE, WILMINGTON, N.C.

SITE DETAILS

ISSUED FOR REVIEW



NOT FOR CONSTRUCTION

JOB NO:	2020-0154-00
---------	--------------

CS-2

FOR REVIEW
8/20/20



514 Market Street
Wilmington, NC 28401
phone 910.762.2621
www.bmharch.com

ARCHITECTURAL SUPPLEMENTAL INSTRUCTION

Do Not Proceed

with any action requiring an adjustment to the contract sum
or schedule without a signed change order.

To:

John Muter
Muter Construction
111 East Vance Street
Zebulon, NC 27597
Phone: 919-749-9340

Date:

ASI No.:
Project No.:

09.02.2020

4

From:

John D. Murray, AIA

Project: Renovations to the Country Club of Landfall Dye Club House

Origin: CBHF Consulting Engineers

Sent Via: Email

 
 
 
 
 

 
 
 
Spec Section/Drawing: E0.1, E0.7, E0.8, ED1.1, EL1.1, EP1.1 EP1.2, EP1.3, EP4.1, EP4.2

ASI Subject: Owner low voltage revisions

Description:

The attached reissued drawings reflect owner requested revisions from the low voltage meeting held August 25th, 2020.

By: John D. Murray, AIA

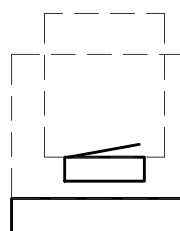ELECTRICAL LEGEND		ELECTRICAL LEGEND	
SYMBOL	DESCRIPTION	SYMBOL	DESCRIPTION
	2x4 LIGHT FIXTURE, RECESSED OR SURFACE MOUNTED LETTER INDICATES FIXTURE TYPE (SEE FIXTURE SCHEDULE)		RECESSED SINGLE/DOUBLE GANG BOX WITH BLANK COVER PLATE, MOUNTED 16" AFF, UNLESS OTHERWISE NOTED
	4FT OR 8FT LIGHT FIXTURE, RECESSED OR SURFACE MOUNTED LETTER INDICATES FIXTURE TYPE (SEE FIXTURE SCHEDULE)		RECESSED DEDICATED/PICTURE/CLOCK SINGLE OUTLET, 120VAC, 20A, MOUNTED AS INDICATED ON DRAWING.
	4FT OR 8FT CHANNEL LIGHT FIXTURE, SUSPENDED OR SURFACE MOUNTED LETTER INDICATES FIXTURE TYPE (SEE FIXTURE SCHEDULE)		RECEPTACLE, DUPLEX, 120VAC, 20A, MOUNTED 16" AFF, UNLESS OTHERWISE NOTED. (SEE ELECTRICAL MOUNTING HEIGHT DETAIL) WP - LISTED WEATHER-RESISTANT TYPE DEVICE WITH WEATHERPROOF IN USE COVER GFI - GROUND FAULT CIRCUIT INTERRUPTER TYPE, 120VAC, 20A, MOUNTED 24" AFF LOCATE GFI TEST SWITCH IN A READILY ACCESSIBLE LOCATION TR - TAMPER RESISTANT
	WALL MOUNTED LIGHT FIXTURE LETTER INDICATES FIXTURE TYPE (SEE FIXTURE SCHEDULE)		RECEPTACLE, DUPLEX, 120VAC, 20A, MOUNTED 6" ABOVE COUNTER TOP OR BACK SPLASH. +##" - INDICATES MOUNTING HEIGHT OF DEVICE IN INCHES AFF (IF GIVEN) (SEE ELECTRICAL MOUNTING HEIGHT DETAIL)
	RECESSED LIGHT FIXTURE LETTER INDICATES FIXTURE TYPE (SEE FIXTURE SCHEDULE)		RECEPTACLE, QUADPLEX, 120VAC, 20A MOUNTED 16" AFF UNLESS OTHERWISE NOTED (SEE ELECTRICAL MOUNTING HEIGHT DETAIL) WP - LISTED WEATHER-RESISTANT TYPE DEVICE WITH WEATHERPROOF, EXTRA DUTY, WHILE IN USE COVER GFI - GROUND FAULT CIRCUIT INTERRUPTER TYPE, 120VAC, 20A, MOUNTED 24" AFF LOCATE GFI TEST SWITCH IN A READILY ACCESSIBLE LOCATION TR - TAMPER RESISTANT
	SURFACE LIGHT FIXTURE LETTER INDICATES FIXTURE TYPE (SEE FIXTURE SCHEDULE)		RECEPTACLE, QUADPLEX, 120VAC, 20A, MOUNTED 6" ABOVE COUNTER TOP OR BACK SPLASH. +##" - INDICATES MOUNTING HEIGHT OF DEVICE IN INCHES AFF (IF GIVEN) (SEE ELECTRICAL MOUNTING HEIGHT DETAIL)
	RECESSED WALL WASH LIGHT FIXTURE LETTER INDICATES FIXTURE TYPE (SEE FIXTURE SCHEDULE)		RECEPTACLE, 208VAC, 2 POLE, 3 WIRE, WALL MOUNTED, SIZE AS INDICATED ON DRAWING
	WALL MOUNTED LIGHT FIXTURE LETTER INDICATES FIXTURE TYPE (SEE FIXTURE SCHEDULE)		RECEPTACLE, DUPLEX, 120VAC, 30A, MOUNTED 16" AFF, UNLESS OTHERWISE NOTED.
	POWER & SWITCH LEG		RECEPTACLE, DUPLEX, 120VAC, 20A RECESSED FLOOR MOUNTED.
	UNSWITCHED LEG		DISCONNECT SWITCH, FUSED, HEAVY (GENERAL) DUTY, SIZE AS INDICATED ON DRAWINGS (SIZE AS INDICATED IN THE EQUIPMENT CONNECTION SCHEDULE) ##A = DISCONNECT SIZE / # = NUMBER OF POLES / # = NEMA RATING, /###AF = FUSE SIZE
	EXIT SIGN, SINGLE FACE, CEILING, ARROW INDICATES DIRECTION. LETTER INDICATES FIXTURE TYPE (SEE FIXTURE SCHEDULE)		MANUAL MOTOR STARTER, ELECTRICAL CONTRACTOR SHALL COORDINATE POLES AND SIZE WITH EQUIPMENT ## = AMPERAGE RATING WHEN INDICATED ON DRAWING
	EXIT SIGN, DOUBLE FACE, CEILING MOUNTED, ARROW INDICATES DIRECTION. LETTER INDICATES FIXTURE TYPE (SEE FIXTURE SCHEDULE)		PANELBOARD, SURFACE OR RECESSED MOUNTED AS SHOWN. SIZE, RATINGS, AND MOUNTING AS INDICATED ON PANEL SCHEDULE. CONTRACTOR IS RESPONSIBLE FOR REQUIRED CLEARANCE IN FRONT OF ELECTRICAL PANEL. SEE NEC TABLE 110.26 WORKING SPACES FOR ADDITIONAL CLEARANCE CONDITIONS.
	EXIT SIGN W/EMERGENCY LIGHTING UNIT, CEILING MOUNTED, ARROW INDICATES DIRECTION. LETTER INDICATES FIXTURE TYPE (SEE FIXTURE SCHEDULE)		ELECTRICAL MOTOR
	EXIT SIGN, SINGLE FACE, WALL/END MOUNTED, ARROW INDICATES DIRECTION. LETTER INDICATES FIXTURE TYPE (SEE FIXTURE SCHEDULE)		METER
	EXIT SIGN, DOUBLE FACE, WALL/END MOUNTED, ARROW INDICATES DIRECTION. INDICATES FIXTURE TYPE (SEE FIXTURE SCHEDULE)		CONDUIT, HOME RUN TO PANEL BOARD
	EMERGENCY LIGHTING UNIT, 2-HEAD WITH BATTERY BACK-UP, WALL MOUNTED, "NOT SWITCHED" LETTER INDICATES FIXTURE TYPE (SEE FIXTURE SCHEDULE)		WIRELESS ACCESS POINT, 1 DATA IN A DUAL GANG BOX WITH A SINGLE GANG PLASTER RING. OWNER SHALL PROVIDE SURGE PROTECTOR AND WAP DEVICE. THE ELECTRICAL CONTRACTOR SHALL INSTALL. CONTRACTOR MUST COORDINATE FINAL LOCATION WITH OWNER BEFORE ROUGH-IN.
	EMERGENCY LIGHTING UNIT, 2-HEAD WITH BATTERY BACK-UP, CEILING MOUNTED, "NOT SWITCHED" LETTER INDICATES FIXTURE TYPE (SEE FIXTURE SCHEDULE)		WP - LISTED WEATHER-RESISTANT TYPE DEVICE
	PHOTOCELL, REMOTE MOUNTED, 120V, 10 SECOND TIME DELAY, UL WET LOCATION, RATED FOR 1500 W @ 120 VAC AND 4000 W @ 277 VAC (FOR USE WITH LAMP SOURCE(S) SHOWN		COMBINATION DATA/TELEPHONE OUTLET, MOUNTED 18" AFF UNLESS OTHERWISE NOTED. PROVIDE 1-1/4" CONDUIT TO ABOVE GRID CEILING W/PULL STRING. OUTLETS LOCATED BELOW HARD(GYPBOARD) CEILINGS, ROUTE 1-1/4" CONDUIT BACK TO TELEPHONE/DATA ROOM. COORDINATE NUMBER OF VOICE AND DATA CONNECTIONS WITH OWNER AND OWNER'S DATA CONTRACTOR.
	SWITCH, SINGLE POLE, 120/277VAC, 20A, MOUNTED AT 46" AFF UNLESS OTHERWISE NOTED (SEE ELECTRICAL MOUNTING HEIGHT DETAIL). LOWER CASE LETTER INDICATES FIXTURE SWITCHING (WHEN INDICATED)		COMBINATION DATA/COAX OUTLET, MOUNTED 18" AFF UNLESS OTHERWISE NOTED. PROVIDE 1-1/4" CONDUIT TO ABOVE GRID CEILING W/PULL STRING. OUTLETS LOCATED BELOW HARD(GYPBOARD) CEILINGS, ROUTE 1-1/4" CONDUIT BACK TO TELEPHONE/DATA ROOM. COORDINATE NUMBER OF VOICE AND DATA CONNECTIONS WITH OWNER AND OWNER'S DATA CONTRACTOR.
	3-WAY SWITCH, SINGLE POLE 120/277 VAC, 20A, MOUNTED AT 46" AFF UNLESS OTHERWISE NOTED		FLOOR MOUNTED DATA RACK
	4-WAY SWITCH 120/277 VAC, 20A, MOUNTED AT 46" AFF UNLESS OTHERWISE NOTED		JUNCTION BOX - WALL MOUNTED +##" - INDICATES MOUNTING HEIGHT OF DEVICE IN INCHES AFF (If given)
	INDICATES BILEVEL SWITCHING, 1 SWITCH SWITCHES OUTSIDE LAMPS, 1 SWITCH SWITCHES INSIDE LAMPS.		JUNCTION BOX - CEILING/ABOVE CEILING MOUNTED
	WEATHERPROOF SWITCH, SINGLE POLE 120/277 VAC, 20A, MOUNTED AT 46" AFF UNLESS OTHERWISE NOTED		JUNCTION BOX - FLOOR MOUNTED
	DIMMER, 0-10V OR LED RATED LINE DIMMER, PER APPLICATION		HATCHING INDICATES ITEMS TO BE DEMOLISHED. REMOVE DEVICE, EQUIPMENT, FIXTURE INDICATED, CIRCUIT, AND CONDUIT BACK TO SOURCE UNLESS OTHERWISE NOTED.
	ADJUSTABLE FAN CONTROL		DETAIL, SECTION OR PLAN NUMBER
	CEILING MOUNTED DUAL TECHNOLOGY OCCUPANCY SENSOR, 360° COVERAGE 2 = SECOND CONTACT TO BE PROVIDED FOR CONNECTION TO BUILDING MANAGEMENT		DRAWING SHEET PLAN, DETAIL OR SECTION APPEARS ON
	WALL MOUNTED OCCUPANCY SENSOR, SINGLE BUTTON ON/OFF CONTROL, 180° COVERAGE, MOUNTED AT 46" AFF UNLESS OTHERWISE NOTED.		ENLARGED PLAN
	WALL MOUNTED OCCUPANCY SENSOR, DUAL BUTTON ON/OFF CONTROL, 180° COVERAGE, MOUNTED AT 46" AFF UNLESS OTHERWISE NOTED.		ELEVATION
	WALL MOUNTED DIGITAL TIMED SWITCH (5 MIN'S TO 12 HR'S), SINGLE BUTTON ON/OFF CONTROL, MOUNTED AT 46" AFF UNLESS OTHERWISE NOTED.		
	WALL MOUNTED DUAL TECHNOLOGY OCCUPANCY SENSOR, DUAL BUTTON ON/OFF CONTROL, 180° COVERAGE, ADDITIONAL POWER SUPPLY FOR FAN OPERATION, MOUNTED AT 46" AFF UNLESS OTHERWISE NOTED.		



614 Market Street
Wilmington, NC 28401
Tel - (910) 762-2621
Fax - (910) 762-8506



08-28-2020

The Country Club of Landfall
Dye Club House
Wilmington, North Carolina

	08.28.20	ADDENDUM #3: OWNER LOW VOLTAGE COMMENTS
REV.	DATE	DESCRIPTION


NO.	DATE	ISSUE NOTE
Project Manager		Drawn By MDM
Date 07.29.2020		Reviewed By WAC
Project ID		

Sheet Title

ELECTRICAL
LEGEND AND
DETAIL

Sheet No. _____

E0.1

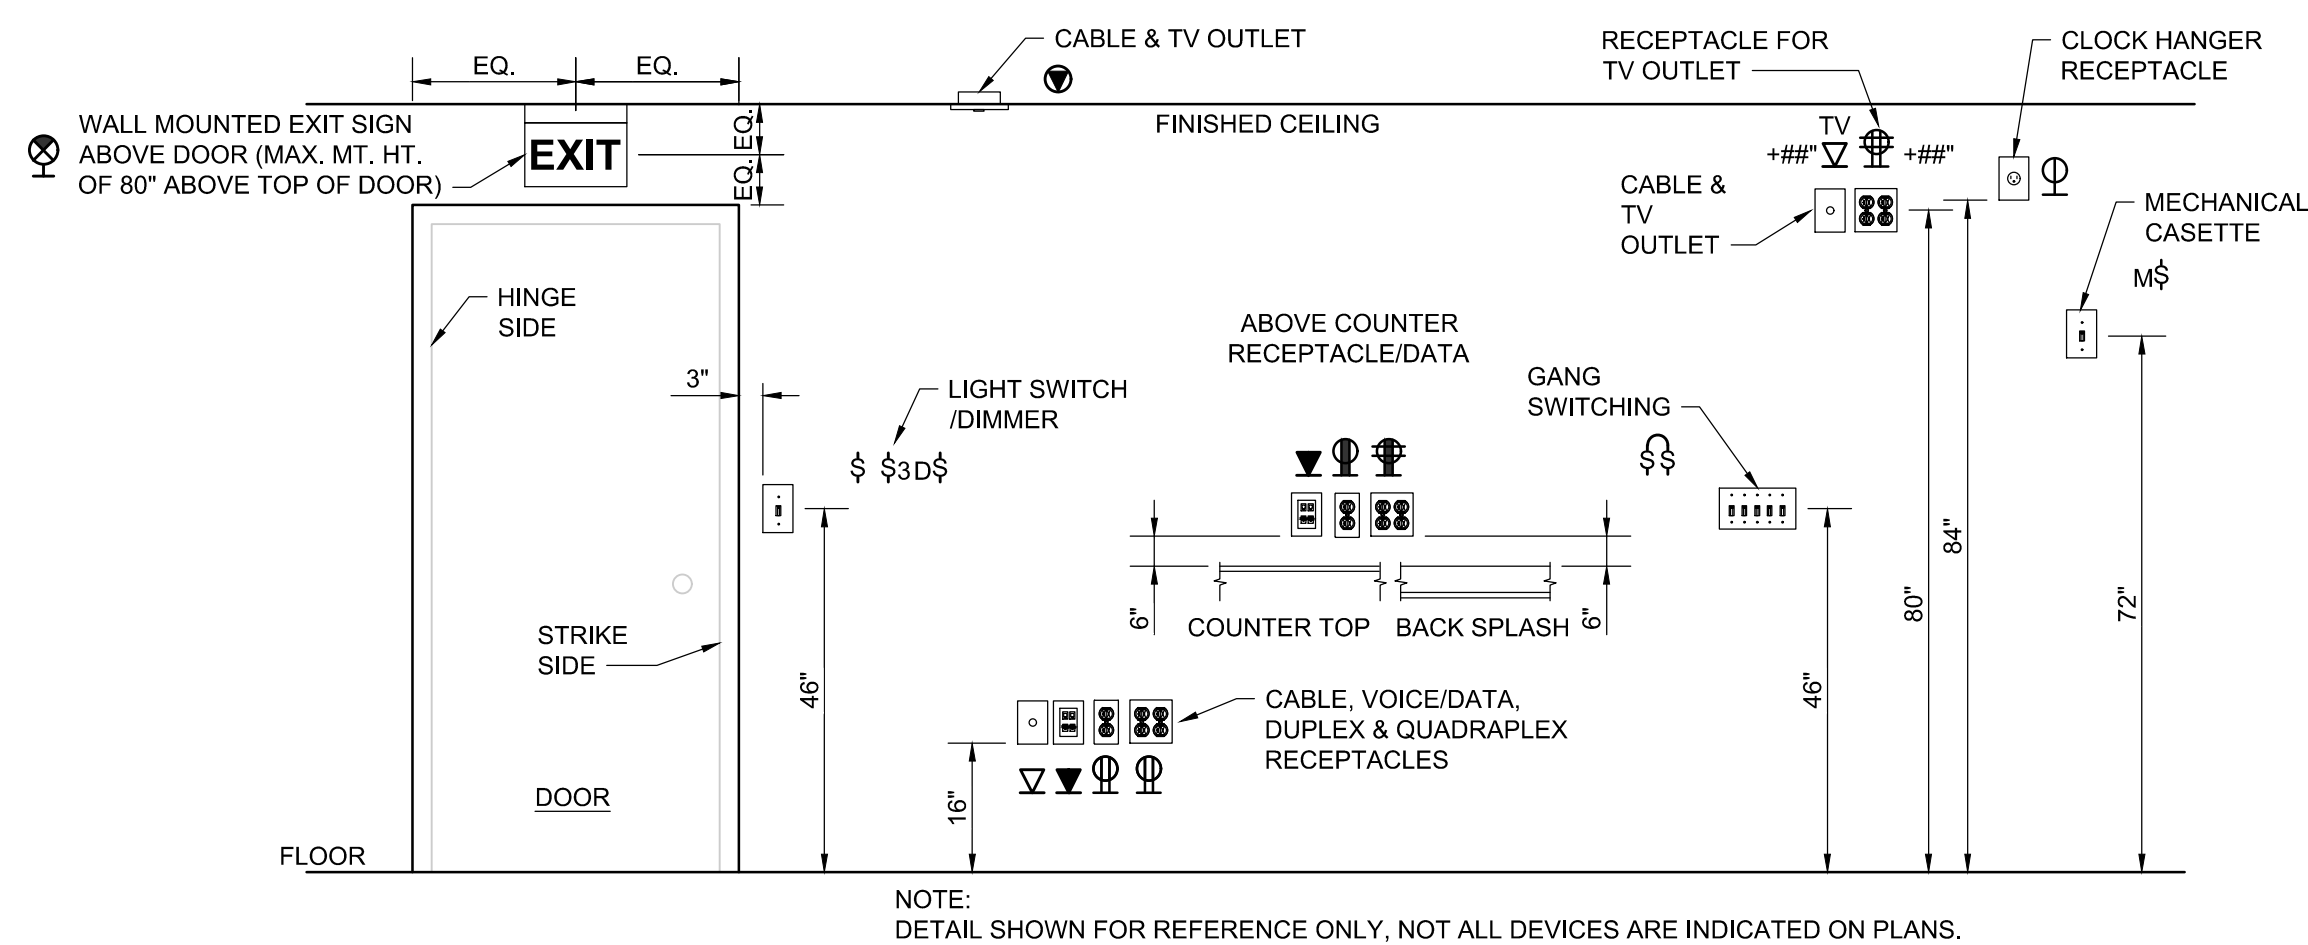

NOTE:
DETAIL SHOWN FOR REFERENCE ONLY, NOT ALL DEVICES ARE INDICATED ON PLANS.

1

ELECTRICAL DEVICES - MOUNTING HEIGHT DETAIL

NOT TO SCALE

PANEL MDP														
TYPE: NEMA 1 BOLT-ON		208 MOUNT: FEED:	120 WALL BOTTOM	V.	3	PH.	4	WIRE	PROVIDE IF CHECKED:		XX XX	EQUIP. GND BUS NEUTRAL BUS GUTTER TAPS SUB-FEED LUGS		
LOAD SERVED	LOAD VA	CKT BKR	CKT #	LOAD VA			CKT #	CKT BKR	LOAD VA	LOAD SERVED				
				A	B	C								
PANEL A1	40,335 39,502 42,733 20,084	400/3	1	52,576	51,199		2	200/3	12,241 11,697 8,398 8,651	PANEL A2				
PANEL H1	22,553 22,220 8,863 6,172 5,508	225/3	3	28,735	31,314	51,130	4	200/3	8,761 7,556 8,470 12,406 12,471	PANEL H2				
PANEL K1		200/3	5	17,333	18,578		6	200/3	5,967 9,865 8,643	PANEL LP3				
EXISTING 1200A PANEL		600/3	7	5,967	9,865	17,979	8	200/3	5,967 9,865 8,643	PANEL B				
SPARE		225/3	9				10	225/3		PREPARED SPACE				
PREPARED SPACE			11				12	30/3		SPD				
NOTE:				104,612	110,956	107,528	TOTAL V. AMPS		1,200	A. BUS (COPPER)				
1. HVAC EQUIPMENT SHALL USE TYPE HACR BREAKERS.				872	925	896	CONN. AMPS		1,200	A. MAIN CIRCUIT BREAKER				
2. ARC ENERGY REDUCTION REQUIRED AT ALL BREAKERS THAT CAN BE ADJUSTED TO 1200AMPS OR MORE PER NEC 240.87.										**ARC ENERGY REDUCTION REQUIRED AT ALL BREAKERS 1200AMPS OR MORE. 22 KAIC MIN.				

PANEL A1																
TYPE: NEMA 1 BOLT-ON DOOR-IN-DOOR, HINGED TRIM FRONT COVER		208	120	V.	3	PH.	4	WIRE	PROVIDE IF CHECKED:	XX XX	EQUIP. GND BUS NEUTRAL BUS GUTTER TAPS SUB-FEED LUGS					
		MOUNT: FEED:	SURFACE BOTTOM													
LOAD SERVED	LOAD VA	CKT BKR	CKT #	LOAD VA			CKT #	CKT BKR	LOAD VA	LOAD SERVED						
AH1-01	3,245	40/2	1	3,785			2	20/1	540	RCP: RM 201						
	3,245		3		3,545		4	20/1	300	GW11						
SPARE		30/2	5				6	20/1	300	GW12						
			7	701			8	20/1	701	RCP: DO2						
AH2-01	7,013	80/3	9		7,013		10	20/1		SPARE						
	7,013		11			7,714	12	20/1	701	RCP: D05						
	7,013		13	7,013			14	20/1		SPARE						
AH2-02	2,163	30/2	15		2,763		16	20/1	600	FACP (SEE NOTE 2)						
	2,163		17			2,413	18	20/1	250	PV2-02						
AH2-09	1,153	20/3	19	1,288			20	20/1	135	LTG: ATTIC						
	1,153		21		1,153		22	20/1	6,485	SPARE						
	1,153		23			7,638	24	45/2	6,485	AH2-06						
SPARE		20/1	25	6,485			26		6,485							
AH2-07	3,245	40/2	27		3,605		28	20/1	360	RCP: DATA BACKBOARD						
	3,245		29			3,245	30	20/1		SPARE						
AH2-08	7,013	80/3	31	8,237			32	15/3	1,224	PV2-03						
	7,013		33		8,237		34		1,224							
	7,013		35			8,237	36		1,224							
AH2-09	1,153	20/3	37	12,826			38	150/3	11,673	EDH02						
	1,153		39		12,826		40		11,673							
	1,153		41			12,826	42		11,673							
NOTES:		1. HVAC & REFRIG. EQUIP. SHALL USE TYPE HACR BREAKERS.														
2. PROVIDE CIRCUIT BREAKER LOCKING DEVICE FOR FACU ALONG WITH IDENTIFYING CIRCUIT BREAKER IN ACCORDANCE WITH NEC 780.41		40,335			39,142	42,373	TOTAL V. AMPS		400	A. BUS (COPPER)						
		336			326	353	CONN. AMPS		400	A. MAIN CIRCUIT BREAKER						
22 KAIC MIN.																

PANEL A2														
TYPE: NEMA 1 BOLT-ON DOOR-IN-DOOR, HINGED TRIM FRONT COVER		208	120	V.	3	PH.	4	WIRE	PROVIDE IF CHECKED:	XX XX	EQUIP. GND BUS NEUTRAL BUS GUTTER TAPS SUB-FEED LUGS			
		MOUNT: FEED:	SURFACE BOTTOM											
LOAD SERVED	LOAD VA	CKT BKR	CKT #	LOAD VA			CKT #	CKT BKR	LOAD VA	LOAD SERVED				
AH1-02	3,578	45/2	1	4,118			2	20/1	540	RCP: MECHANICAL ATTIC				
	3,578		3		4,279		4	15/1	701	RCP: D01				
AH2-03	3,578	45/2	5		4,279	4,279	6	15/1	701	RCP: D03				
	3,578		7	4,279			8	15/1	701	RCP: D04				
AH2-04	3,744	45/2	9		3,994		10	15/1	250	PV2-01				
	3,744		11			3,879	12	20/1	135	LTG: ATTIC				
AH2-05	3,245	40/2	13	3,845			14	20/1	600	RCP: XIRRAGATION CONTROL PANEL				
	3,245		15		3,425		16	20/1	180	LTG: EXTERIOR FLOODS				
SPARE		20/1	17				18	20/1		SPARE				
SPARE		20/1	19				20	20/1		SPARE				
SPARE		20/1	21				22	20/1		SPARE				
PV2-04	240	15/1	23			240	24	20/1		SPARE				
SPARE		20/1	25				26	20/1		SPARE				
SPARE		20/1	27				28	20/1		SPARE				
SPARE		20/1	29				30	20/1		SPARE				
NOTES:				12,241	11,697	8,398	TOTAL V. AMPS			200	A. BUS (COPPER)			
1. HVAC & REFRIG. EQUIP. SHALL USE TYPE HACR BREAKERS.				102	97	70	CONN. AMPS			200	A. MAIN CIRCUIT BREAKER			
22 KAIC MIN.														

PANEL H1														
TYPE: NEMA 3R BOLT-ON		208	120	V.	3	PH.	4	WIRE	PROVIDE IF CHECKED:		XX XX	EQUIP. GND BUS NEUTRAL BUS GUTTER TAPS SUB-FEED LUGS		
		MOUNT: FEED:	SURFACE BOTTOM											
LOAD SERVED	LOAD VA	CKT BKR	CKT #	LOAD VA			CKT #	CKT BKR	LOAD VA	LOAD SERVED				
				A	B	C								
CUT-04	2,018	35/3	1	2,378			2	20/1	360	RCP: MECHANICAL YARD				
	2,018		3		4,035		4	35/3	2,018	HP2-06				
	2,018		5			4,035	6		2,018					
AH1-04	832	20/2	7	2,850			8		2,018					
	832		9		2,246		10	25/2	1,414	HP2-07				
DHP1-01	915	15/2	11			2,330	12		1,414					
	915		13	4,086			14	45/3	3,170	HP2-08				
DHP3-02	915	15/2	15		4,086		16		3,170					
	915		17			4,086	18		3,170					
HP1-01	1,414	25/2	19	1,414			20	20/1		SPARE				
	1,414		21		5,353		22	50/3	3,939	CUT-09				
HP1-03	1,249	20/3	23			5,188	24		3,939					
	1,249		25	5,188			26		3,939					
	1,249		27		3,662		28	30/2	2,413	AH1-03				
HP2-01	3,170	45/3	29			5,583	30		2,413					
	3,170		31	3,170			32	20/1		SPARE				
	3,170		33		3,170		34	20/1		SPARE				
HP2-02	998	20/2	35			998	36	20/1		SPARE				
	998		37	998			38	20/1		SPARE				
SPARE		20/1	39				40	20/1		SPARE				
SPARE		20/1	41				42	20/1		SPARE				
NOTES:				20,084	22,553	22,220	TOTAL V. AMPS			225	A. BUS (COPPER)			
1. HVAC & REFRIG. EQUIP. SHALL USE TYPE HACR BREAKERS.				167	188	185	CONN. AMPS			225	A. MAIN CIRCUIT BREAKER			
22 KAIC MIN.														

PANEL H2														
TYPE: NEMA 3R BOLT-ON		208 MOUNT: FEED:	120 SURFACE BOTTOM	V.	3	PH.	4	WIRE	PROVIDE IF CHECKED:	XX XX	EQUIP. GND BUS NEUTRAL BUS GUTTER TAPS SUB-FEED LUGS			
LOAD SERVED	LOAD VA	CKT BKR	CKT #	LOAD VA			CKT #	CKT BKR	LOAD VA	LOAD SERVED				
HP1-02	1,729	3/03	1	1,909				2	2/01	180	RCP: MECHANICAL YARD			
	1,729		3		2,894			4	15/2	1,165	DHP1-02			
	1,729		5			2,894		6		1,165				
HP2-03	1,729	3/03	7	2,645				8	15/2	915	DHP1-03			
	1,729		9		2,645			10		915				
	1,729		11			2,645		12		915	DHP3-01			
HP2-04	2,018	35/3	13	2,933				14		915				
	2,018		15		2,098			16	20/1	80	LTG: MECHANICAL YARD			
	2,018		17			2,018		18	20/1		SPARE			
HP2-05	1,165	25/2	19	1,165				20	20/1		SPARE			
	1,165		21		1,165			22	20/1		SPARE			
		20/1	23					24	20/1		SPARE			
SPARE		20/1	25					26	20/1		SPARE			
SPARE		20/1	27					28	20/1		SPARE			
SPARE		20/1	29					30	20/1		SPARE			
NOTES:				8,651	8,801	7,555	TOTAL VA AMPS			200	A. BUS (COPPER)			
1. HVAC & REFRIG. EQUIP. SHALL USE TYPE HACR BREAKERS.				72	73	63	CONN. AMPS			200	A. MAIN CIRCUIT BREAKER			
22. K41C MIN.														

(X)PANEL K2

TYPE: NEMA 1 BOLT-ON DOOR-IN-DOOR, HINGED TRIM FRONT COVER	208 MOUNT: FEED:	120 V. SURFACE BOTTOM	3 PH.	4 WIRE	PROVIDE IF CHECKED:	XX XX	EQUIP. GND BUS NEUTRAL BUS GUTTER TAPS SUB-FEED LUGS	
	LOAD VA	CKT BKR	CKT #	LOAD VA A B C	CKT #	CKT BKR	LOAD VA	LOAD SERVED
(X)HOOD LIGHT/EXISTING CKT		20/20	1		2	30/2		(X)ICE MAKER
(X)COFFEE BREWER		20/2	3		4	1		
		1	5		6	30/2		(X)EXPRESSO
(X)WALK IN FREEZER		20/2	7		8			
(SHUNT)		1	9		10	30/2		(X)EXHAUST FAN
(X)CONVECTION OVEN		1	11		12	1		
		1	13		14	20/1		(X)TOASTER
(X)REFRIGERATOR		20/1	15		16	20/20		(X)MICROWAVE / TOASTER
(X)HEAT LAMP		20/1	17		18	40/3		(X)BOOSTER HEATER
(X)EXISTING CIRCUIT		40/2	19		20			
		1	21		22	1		
(X)RCPP: BEVERAGE COUNTER		20/1	23		24	40/3		(X)DISHWASHER
(X)WUG DEFROSTER		30/1	25		26	1		
(X)BEER COOLER		20/1	27		28	1		
(X)RCPP: BK KITCHEN		20/1	28		30	20/2		(X)FREEZER
(X)RCPP: DINING RM		20/1	31		32	1		
(X)RCPP: DINING RM (X)CIRCUIT		20/20	33		34	20/1		(X)COOLER
(X)STEAMER		30/3	35		36	20/1		(X)LIGHT IN COOLER
		1	37		38	20/3		(X)HOOD FAN
			39		40	1		
			41					
NOTES:					TOTAL V. AMPS		225 A. BUS (COPPER)	
1. HVAC & REFRIG. EQUIP. SHALL USE TYPE HACR BREAKERS.					CONN. AMPS		225 A. MAIN CIRCUIT BREAKER	

(X)PANEL LP1

TYPE: NEMA 1 BOLT-ON DOOR-IN-DOOR, HINGED TRIM FRONT COVER	208 MOUNT: FEED:	120 V. SURFACE BOTTOM	3 PH.	4 WIRE	PROVIDE IF CHECKED:	XX XX	EQUIP. GND BUS NEUTRAL BUS GUTTER TAPS SUB-FEED LUGS	
	LOAD VA	CKT BKR	#	LOAD VA A B C	CKT #	CKT BKR	LOAD VA	LOAD SERVED
(X)NL BACK STAIRS		20/1	1		2	20/1		(X)NL GARAGE
(X)TIME CLOCK		20/1	3		4	20/1		(X)RCPP: DOOR
(X)RECEPTACLE BACK AREA		20/1	5		6	20/2		(X)EXHAUST FAN
(X)NL BAGI		20/1	7		8			(X)NL SIDE
(X)LTG: FREEZER ROOM		20/1	9		10	20/1		SPARE
(X)LTG: GARAGE		20/1	11		12	20/1		(X)PANEL LP2
(X)LTG: GARAGE		20/1	13		14	100/3		
(X)LTG: FRONT STAIRS		20/1	15		16			
(X)LTG: PARKING LOT		20/2	17		18			
(X)LTG: PARKING LOT			19		20	100/3		(X)PANEL LP3
			21		22			
			23		24			
(X)RCPP: EXTERIOR		20/1	25		26			SPACE
SPACE			27		28			SPACE
SPACE			29		30			SPACE
(X)LTG: SHRUBBRY		20/1	31		32			SPACE
(X)GREEN FAN AND GRILL OUTLETS		20/1	33		34			SPACE
(X)TEMPORARY POWER		50/2	35		36			SPACE
			37		38			SPACE
SPACE			39		40			SPACE
SPACE			41		42			SPACE
NOTES:					TOTAL V. AMPS	225 A. BUS (COPPER)		
1. HVAC & REFRIG. EQUIP. SHALL USE TYPE HACR BREAKERS.					CONN. AMPS	225 A. MAIN CIRCUIT BREAKER		

(X)PANEL LP2

TYPE: NEMA 1 BOLT-ON DOOR-IN-DOOR, HINGED TRIM FRONT COVER	208 MOUNT: FEED:	120 V. SURFACE BOTTOM	3 PH.	4 WIRE	PROVIDE IF CHECKED:	XX XX	EQUIP. GND BUS NEUTRAL BUS GUTTER TAPS SUB-FEED LUGS	
LOAD SERVED	LOAD VA	CKT BKR	CKT #	LOAD VA A B C	CKT #	CKT BKR	LOAD VA	LOAD SERVED
(X)LTG: DINING ROOM		20/1	1		2	20/1		(X)LTG: KITCHEN BATH
(X)WOMEN'S SITTING ROOM FAN		20/1	3		4	20/1		(X)LTG: UPSTAIRS
(X)LTG: DINING ROOM		20/1	5		6	20/1		(X)LTG: HALL AND BACKSTAIRS
WOMEN'S BATH LIGHT		20/1	7		8	20/1		(X)LTG: UPSTAIRS OFFICE
(X)LTG: WOMEN'S SITTING ROOM		20/1	9		10	20/1		(X)LTG: KITCHEN
(X)LTG: UPSTAIRS OFFICE		20/1	11		12	20/1		RCP: UPSTAIRS
(X)LTG: UPSTAIRS OFFICE		20/1	13		14	20/1		RCP: WOMEN'S DRESSING ROOM
(X)LTG: WOMEN'S DRESSING ROOM		20/1	15		16	20/1		(X)LTG: UPSTAIRS OFFICE
(X)LTG: WOMEN'S SITTING ROOM		20/1	17		18	20/1		(X)LTG: WOMEN'S DRESSING ROOM
(X)LTG: WOMEN'S BATH		20/1	19		20	20/1		(X)LTG: STAIR & HALL NEARS WOMEN'S ROOM
RCP: WOMEN'S SITTING ROOM		20/1	21		22	20/1		(X)LTG: OUTSIDE NL
CASH REGISTER		20/1	23		24	20/1		(X)LTG: SUNPORCH SCONCES & CEILING FAN
(X) CIRCUIT		20/1	25		26	20/1		(X)COOLER
(X) CIRCUIT		20/1	27		28	20/1		(X)COOLER
(X) CIRCUIT		20/1	29		30	20/1		(X)CIRCUIT
(X) CIRCUIT		20/1	31		32	20/1		(X)CIRCUIT
SPACE			33		34			SPACE
SPACE			35		36			SPACE
SPACE			37		38			SPACE
SPACE			39		40			SPACE
SPACE			41		42			SPACE
NOTES:					TOTAL V. AMPS	100 A. BUS (COPPER)		
1. HVAC & REFRIG. EQUIP. SHALL USE TYPE HACR BREAKERS.					CONN. AMPS	100 A. MAIN CIRCUIT BREAKER		

(X)PANEL 9

TYPE: NEMA 1 BOLT-ON DOOR-IN-DOOR, HINGED TRIM FRONT COVER	208 MOUNT: FEED:	120 V. SURFACE BOTTOM	3 PH.	4 WIRE	PROVIDE IF CHECKED:	XX XX	EQUIP. GND BUS NEUTRAL BUS GUTTER TAPS SUB-FEED LUGS	
LOAD SERVED	LOAD VA	CKT BKR	CKT #	LOAD VA A B C	CKT #	CKT BKR	LOAD VA	LOAD SERVED
(X)HEAT		40/3	1	A B C	2	20/1		(X)LTG:
			3		4	20/1		(X)RCP:
			5		6	20/2		(X)WATER HEATER
SPACE			7		8	1		(X)WATER HEATER
SPACE			9		10	20/2		
SPACE			11		12			
NOTES:					TOTAL V. AMPS	225 A. BUS (COPPER)		
1. HVAC & REFRIG. EQUIP. SHALL USE TYPE HACR BREAKERS.					CONN. AMPS	225 A. MAIN CIRCUIT BREAKER		

PANEL K2 REPLACEMENT

TYPE: NEMA 1 BOLT-ON DOOR-IN-DOOR, HINGED TRIM FRONT COVER	208 MOUNT: FEED:	120 V. SURFACE BOTTOM	3 PH.	4 WIRE	PROVIDE IF CHECKED:	XX XX	EQUIP. GND BUS NEUTRAL BUS GUTTER TAPS SUB-FEED LUGS	
LOAD SERVED	LOAD VA	CKT BKR	CKT #	LOAD VA A B C	CKT #	CKT BKR	LOAD VA	LOAD SERVED (X)ICE MAKER
(X)HOOD LIGHT		20/1	1		2	30/2		
(X)COFFEE BREWER		20/2	3		4			
			5		6	30/2		(X)EXPRESSO
(X)WALK IN FREEZER		20/2	7		8			
			9	360	10	20/1	360	RCP: RM 221(SEE NOTE 2)
RCP: RM 221 (1) (SEE NOTE 2)	400	15/2	11		12	20/1		(X)TOASTER (SEE NOTE 3)
(SHUNT)	400		13	400	14	20/1		(X)TOASTER
(X)REFRIGERATOR		20/1	15		16	20/1		(X)MICROWAVE
HEAT LAMPS (9)	1,500	20/1	17	1,500	18	40/3		(X)BOOSTER HEATER
(X)EXISTING CIRCUIT		40/2	19		20			
			21		22			
			23		24	40/3		(X)DISHWASHER
(X)RCP: BEVERAGE COUNTER		30/1	25		25			
(X)CIRCUIT (SEE NOTE 3)		20/1	27		28			
(X)CIRCUIT (SEE NOTE 3)		20/1	29		30	20/2		(X)FREEZER
(X)RCP: GFI KITCHEN		20/1	31		32			
(X)RCP: DINING RM		20/1	33		34	20/1		(X)COOLER
(X)RCP: DINING ROOM		20/1	35		36	20/1		(X)LIGHT IN COOLER
(X)STEAMER		30/3	37	1,273	38	20/3	1,273	PV2-03 VIA PRIMARY CONTROL CABINET
			39	1,273	40		1,273	
			41		42		1,273	
(X)CIRCUIT (SEE NOTE 3)		20/1	43	564	44	20/1	564	RCP: RM 219 UNDR CNTR REFRIG (16)
RCP: RM 221 (2)(SEE NOTE 2)	708	20/1	45	1,308	46	20/1	600	HO2 PRIMARY CONTROL PANEL
(SHUNT)			47		48	20/1		SPARE
RCP: RM 221 (7)(SEE NOTE 2)	420	20/1	49	1,920	50	20/2	1,500	RMP 221 (11) (SEE NOTE 2)
(SHUNT)			51	1,500	52		1,500	
RCP: RM 223 (X) REFRIG. WORK TOP	1,488	20/1	53		54	20/1	1,272	RCP: RM 223 (X) REACH IN
NOTES:				5,657	4,441	4,433	TOTAL V. AMPS	
1. HVAC & REFRIG. EQUIP. SHALL USE TYPE HACR BREAKERS.				47	37	37	CONN. AMPS	225 A. MAIN CIRCUIT BREAKER
2. ALL BREAKERS IN KITCHEN (ROOM 221) MUST BE GFI.								
3. CIRCUIT MOVED FROM TANDUM BREAKER.								
4. PROVIDE SHUNT TRIP BREAKERS WHERE SPECIFIED.								22 KAIC MIN.

(X)PANEL LP1 REVISED

TYPE: NEMA 1 BOLT-ON DOOR-IN-DOOR, HINGED TRIM FRONT COVER	208 MOUNT: FEED:	120 V. SURFACE BOTTOM	3 PH.	4 WIRE	PROVIDE IF CHECKED:	XX XX	EQUIP. GND BUS NEUTRAL BUS GUTTER TAPS SUB-FEED LUGS	
LOAD SERVED	LOAD VA	CKT BKR	CKT #	LOAD VA A B C	CKT #	CKT BKR	LOAD VA	LOAD SERVED
(X)NL BACK STAIRS		20/1	1		2	20/1		(X)NL GARAGE
(X)TIME CLOCK		20/1	3		4	20/1		(X)RCPP: DOOR
(X)RECEPTACLE BACK AREA		20/1	5		6	20/2		(X)EXHAUST FAN
(X)NL BAGI		20/1	7		8			(X)NL SIDE
(X)LTG: FREEZER ROOM		20/1	9		10	20/1		SPARE
(X)LTG: GARAGE		20/1	11		12	20/1		(X)NL GARAGE
(X)LTG: GARAGE		20/1	13		14	100/3		(X)PANEL LP2
(X)LTG: FRONT STAIRS		20/1	15		16			
(X)LTG: PARKING LOT		20/2	17		18			
			19		20	100/3		SPARE (SEE NOTE 2)
(X)LTG: PARKING LOT		20/2	21		22			
			23		24			
(X)RCPP: EXTERIOR		20/1	25	180	26	20/1	180	RCP: EXT. PATIO (SEE NOTE 3)
SPACE			27	180	28	20/1	180	RCP: EXT. PATIO (SEE NOTE 3)
SPACE			29		30	20/1	360	RCP: EXTERIOR (SEE NOTE 3)
(X)LTG: SHRUBBRY		20/1	31	360	32	20/1	360	RCP: RM113 (SEE NOTE 3)
(X)GREEN FAN AND GRILL OUTLETS		20/1	33	222	34	20/1	222	PV1-03 (SEE NOTE 3)
(X)TEMPORARY POWER		50/2	35		36	20/1	360	RCP: EXTERIOR (SEE NOTE 3)
			37		38			SPACE
SPACE			39		40			SPACE
SPACE			41		42			SPACE
NOTES:				540	402	720	TOTAL V. AMPS	225 A. BUS (COPPER)
1. HVAC & REFRIG. EQUIP. SHALL USE TYPE HACR BREAKERS.				5	3	6	CONN. AMPS	225 A. MAIN CIRCUIT BREAKER
2. BREAKER MADE SPARE DURING DEMOLITION.								
3. PROVIDE BREAKER MATCHING KAIC RATING OF PANEL.								

(X)PANEL LP2 REVISED

TYPE: NEMA 1 BOLT-ON DOOR-IN-DOOR, HINGED TRIM FRONT COVER	208 MOUNT: FEED:	120 V. SURFACE BOTTOM	3 PH.	4 WIRE	PROVIDE IF CHECKED:	XX XX	EQUIP. GND BUS NEUTRAL BUS GUTTER TAPS SUB-FEED LUGS	
LOAD SERVED	LOAD VA	CKT BKR	CKT #	LOAD VA A B C	CKT #	CKT BKR	LOAD VA	LOAD SERVED
(X)LTG: DINING ROOM		20/1	1		2	20/1		(X)LTG: KITCHEN BATH
(X)WOMEN'S SITTING ROOM FAN		20/1	3	360	4	20/1	360	RCP: RM 223
(X)LTG: DINING ROOM		20/1	5		6	20/1		(X)LTG: HALL AND BACKSTAIRS
WOMEN'S BATH LIGHT		20/1	7	720	8	20/1	720	RCP: RM 223
(X)LTG: WOMEN'S SITTING ROOM		20/1	9		10	20/1		(X)LTG: KITCHEN
RCP: RM 221	360	20/1	11		12	20/1	1,080	RCP: RM 223 (X) REACH IN
RCP: RM 221	360	20/1	13	360	14	20/1		RCP: WOMEN'S DRESSING ROOM
(X)LTG: WOMEN'S DRESSING ROOM		20/1	15	1,080	16	20/1	1,080	RCP: RM 223 (X) REACH IN
(X)LTG: WOMEN'S SITTING ROOM		20/1	17		18	20/1		(X)LTG: WOMEN'S DRESSING ROOM
(X)LTG: WOMEN'S BATH		20/1	19		20	20/1		(X)LTG: STAIR & HALL NEARS WOMEN'S ROOM
RCP: WOMEN'S SITTING ROOM		20/1	21		22	20/1		(X)LTG: OUTSIDE NL
CASH REGISTER		20/1	23		24	20/1		(X)LTG: SUNPORCH SCONCES & CEILING FAN
(X) CIRCUIT		20/1	25		26	20/1		(X)COOLER
(X) CIRCUIT		20/1	27		28	20/1		(X)COOLER
(X) CIRCUIT		20/1	29		30	20/1		(X)CIRCUIT
(X) CIRCUIT		20/1	31		32	20/1		(X)CIRCUIT
LTG: RM 212, 213, 214, 215 & 217 (SEE NOTE 4)	1,138	20/1	33	1,318	34	20/1	180	RCP: RM 223
LTG: RM 216 & 219 (SEE NOTE 4)	485	20/1	35		36	20/1	540	RCP: RM 217 (SEE NOTE 4)
LTG: RM 203 (SEE NOTE 4)	690	20/1	37	1,050	38	20/1	360	RCP: RM 218 (SEE NOTE 4)
R66: RM 223	360	20/1	39	924	40	20/1	564	RCP: RM 223 (16)
RCP: RM 223	360	20/1	41		42	20/1	180	RCP: RM 223
NOTES				2,130 3,682	540 420	3,005 TOTAL V. AMPS	100 A. BUS (COPPER)	
1. HVAC & REFRIG. EQUIP. SHALL USE TYPE HACR BREAKERS.				18 31	25	CONN. AMPS	100 A. MAIN CIRCUIT BREAKER	
2. BREAKER MADE SPARE DURING DEMOLITION.								
3. PROVIDE CIRCUIT BREAKER LOCKING DEVICE FOR FACU ALONG WITH IDENTIFYING CIRCUIT BREAKER IN ACCORDANCE WITH NEC 760.41								
4. PROVIDE BREAKER MATCHING KAIC RATING OF PANEL.								

DEMOLITION KEYED NOTES

- 1 MAIN DISTRIBUTION PANEL: CONTRACTOR MUST PROTECT PANEL AND DISTRIBUTION TO SUB-PANELS DURING DEMOLITION AND CONSTRUCTION FOR RE-USE.
- 2 PANELBOARD: CONTRACTOR MUST REMOVE PANEL, CONDUIT, CONDUCTORS, SUPPORTS ETC. IN ENTIRETY.
- 3 HVAC EQUIPMENT: CONTRACTOR MUST DISCONNECT EQUIPMENT, DISCONNECTS, CONDUIT, CONDUCTORS, FITTINGS, ETC. IN ENTIRETY TO SOURCE.
- 4 RECEPTACLES: CONTRACTOR MUST REMOVE DEVICE, BOX, CONDUIT, CONDUCTORS, FITTINGS ETC. IN ENTIRETY TO SOURCE.
- 5 RECEPTACLES: CONTRACTOR MUST REMOVE DEVICE AND PROTECT BOX, CONDUIT AND CONDUCTORS DURING DEMOLITION AND CONSTRUCTION FOR RE-USE.
- 6 LIGHTING: CONTRACTOR MUST REMOVE FIXTURE AND/OR SWITCH, BOXES, CONDUITS, CONDUCTORS, FITTINGS, SWITCHES, ETC. IN ENTIRETY TO SOURCE.
- 7 LIGHTING: CONTRACTOR MUST REMOVE FIXTURE AND/OR DEVICE, PROTECT BOX, CONDUIT AND CONDUCTORS DURING DEMOLITION AND CONSTRUCTION FOR RE-USE.
- 8 DATA: CONTRACTOR MUST REMOVE ALL DEVICES, CONDUIT AND CONDUCTORS TO SOURCE IN ENTIRETY.
- 9 CEILING FAN: CONTRACTOR MUST REMOVE FAN, BOX, CONDUIT, CONDUCTORS, FITTINGS, SWITCHES, ETC. IN ENTIRETY TO SOURCE.
- 10 RECEPTACLE: PROTECT EXISTING BOX AND CONDUIT DURING DEMOLITION AND CONSTRUCTION FOR RE-USE. REMOVE CONDUCTORS TO SOURCE IN ENTIRETY.
- 11 PANELBOARD: REMOVE PANEL, CONDUCTORS AND ALL UNUSED CONDUIT. ABANDON UNDERGROUND CONDUIT IN PLACE. CONTRACTOR MAY DETERMINE THAT SOME EXISTING CONDUIT MAY BE PROTECTED FOR REUSE AND EXTENDED TO NEW PANEL.

- 12 POWER VENTILATOR: CONTRACTOR MUST PROTECT DISCONNECT, BOXES, CONDUIT AND CONDUCTORS DURING DEMOLITION AND CONSTRUCTION.
- 13 WATER HEATER: CONTRACTOR MUST DISCONNECT DEVICES, REMOVE DISCONNECTS, CONDUIT, CONDUCTORS, FITTINGS, ECT. IN ENTIRETY TO SOURCE.
- 14 NOT IN SCOPE, EXISTING DEVICE TO REMAIN.
- 15 JB: CONTRACTOR MUST REMOVE BOX, CONDUIT, CONDUCTORS, FITTINGS ETC. IN ENTIRETY TO SOURCE.

GENERAL NOTES

- ATTEMPT HAS BEEN MADE TO LOCATE AND SHOW ALL DATA, ELECTRICAL EQUIPMENT AND DEVICES INCLUDING LIGHTING. ALL LOCATIONS ON THESE PLANS ARE BELIEVED TO BE CORRECT. NOTWITHSTANDING, THE CONTRACTOR SHALL VERIFY ALL DATA, ELECTRICAL EQUIPMENT AND DEVICES INCLUDING LIGHTING LOCATIONS. THE CONTRACTOR MUST DO THE FOLLOWING:
- ALL EXISTING LIGHTING FIXTURES AND SWITCHES MUST BE REMOVED EVEN IF NOT INDICATED ON PLANS.
 - ALL EXISTING RECEPTACLES AND FACEPLATES MUST BE REMOVED EVEN IF NOT INDICATED ON PLANS.
 - ALL DATA BOXES AND FACEPLATES MUST BE REMOVED EVEN IF NOT INDICATED ON PLANS.

CBHF
Engineers, PLLC

2246 Yaupon Drive
Wilmington, NC 28401
Phone: 910.791.4000
Fax: 910.791.5266
www.cbhfindengineers.com
NC# P-0506

bmh
BOWMAN
MURRAY
HEMINGWAY
ARCHITECTS

514 Market Street
Wilmington, NC 28401
Tel - (910) 762-2621
Fax - (910) 762-8506

08-28-2020

The Country Club of Landfall
Dye Club House
Wilmington, North Carolina

REV.	DATE	DESCRIPTION
1	08.28.20	ADDENDUM #3: OWNER LOW VOLTAGE COMMENTS


NO.	DATE	ISSUE NOTE
-----	------	------------

Project Manager	Drawn By MDM
Date	Reviewed By WAC
Project ID	

Sheet Title
**ELECTRICAL
FIRST FLOOR
DEMO PLAN**

Sheet No.

ED1.1

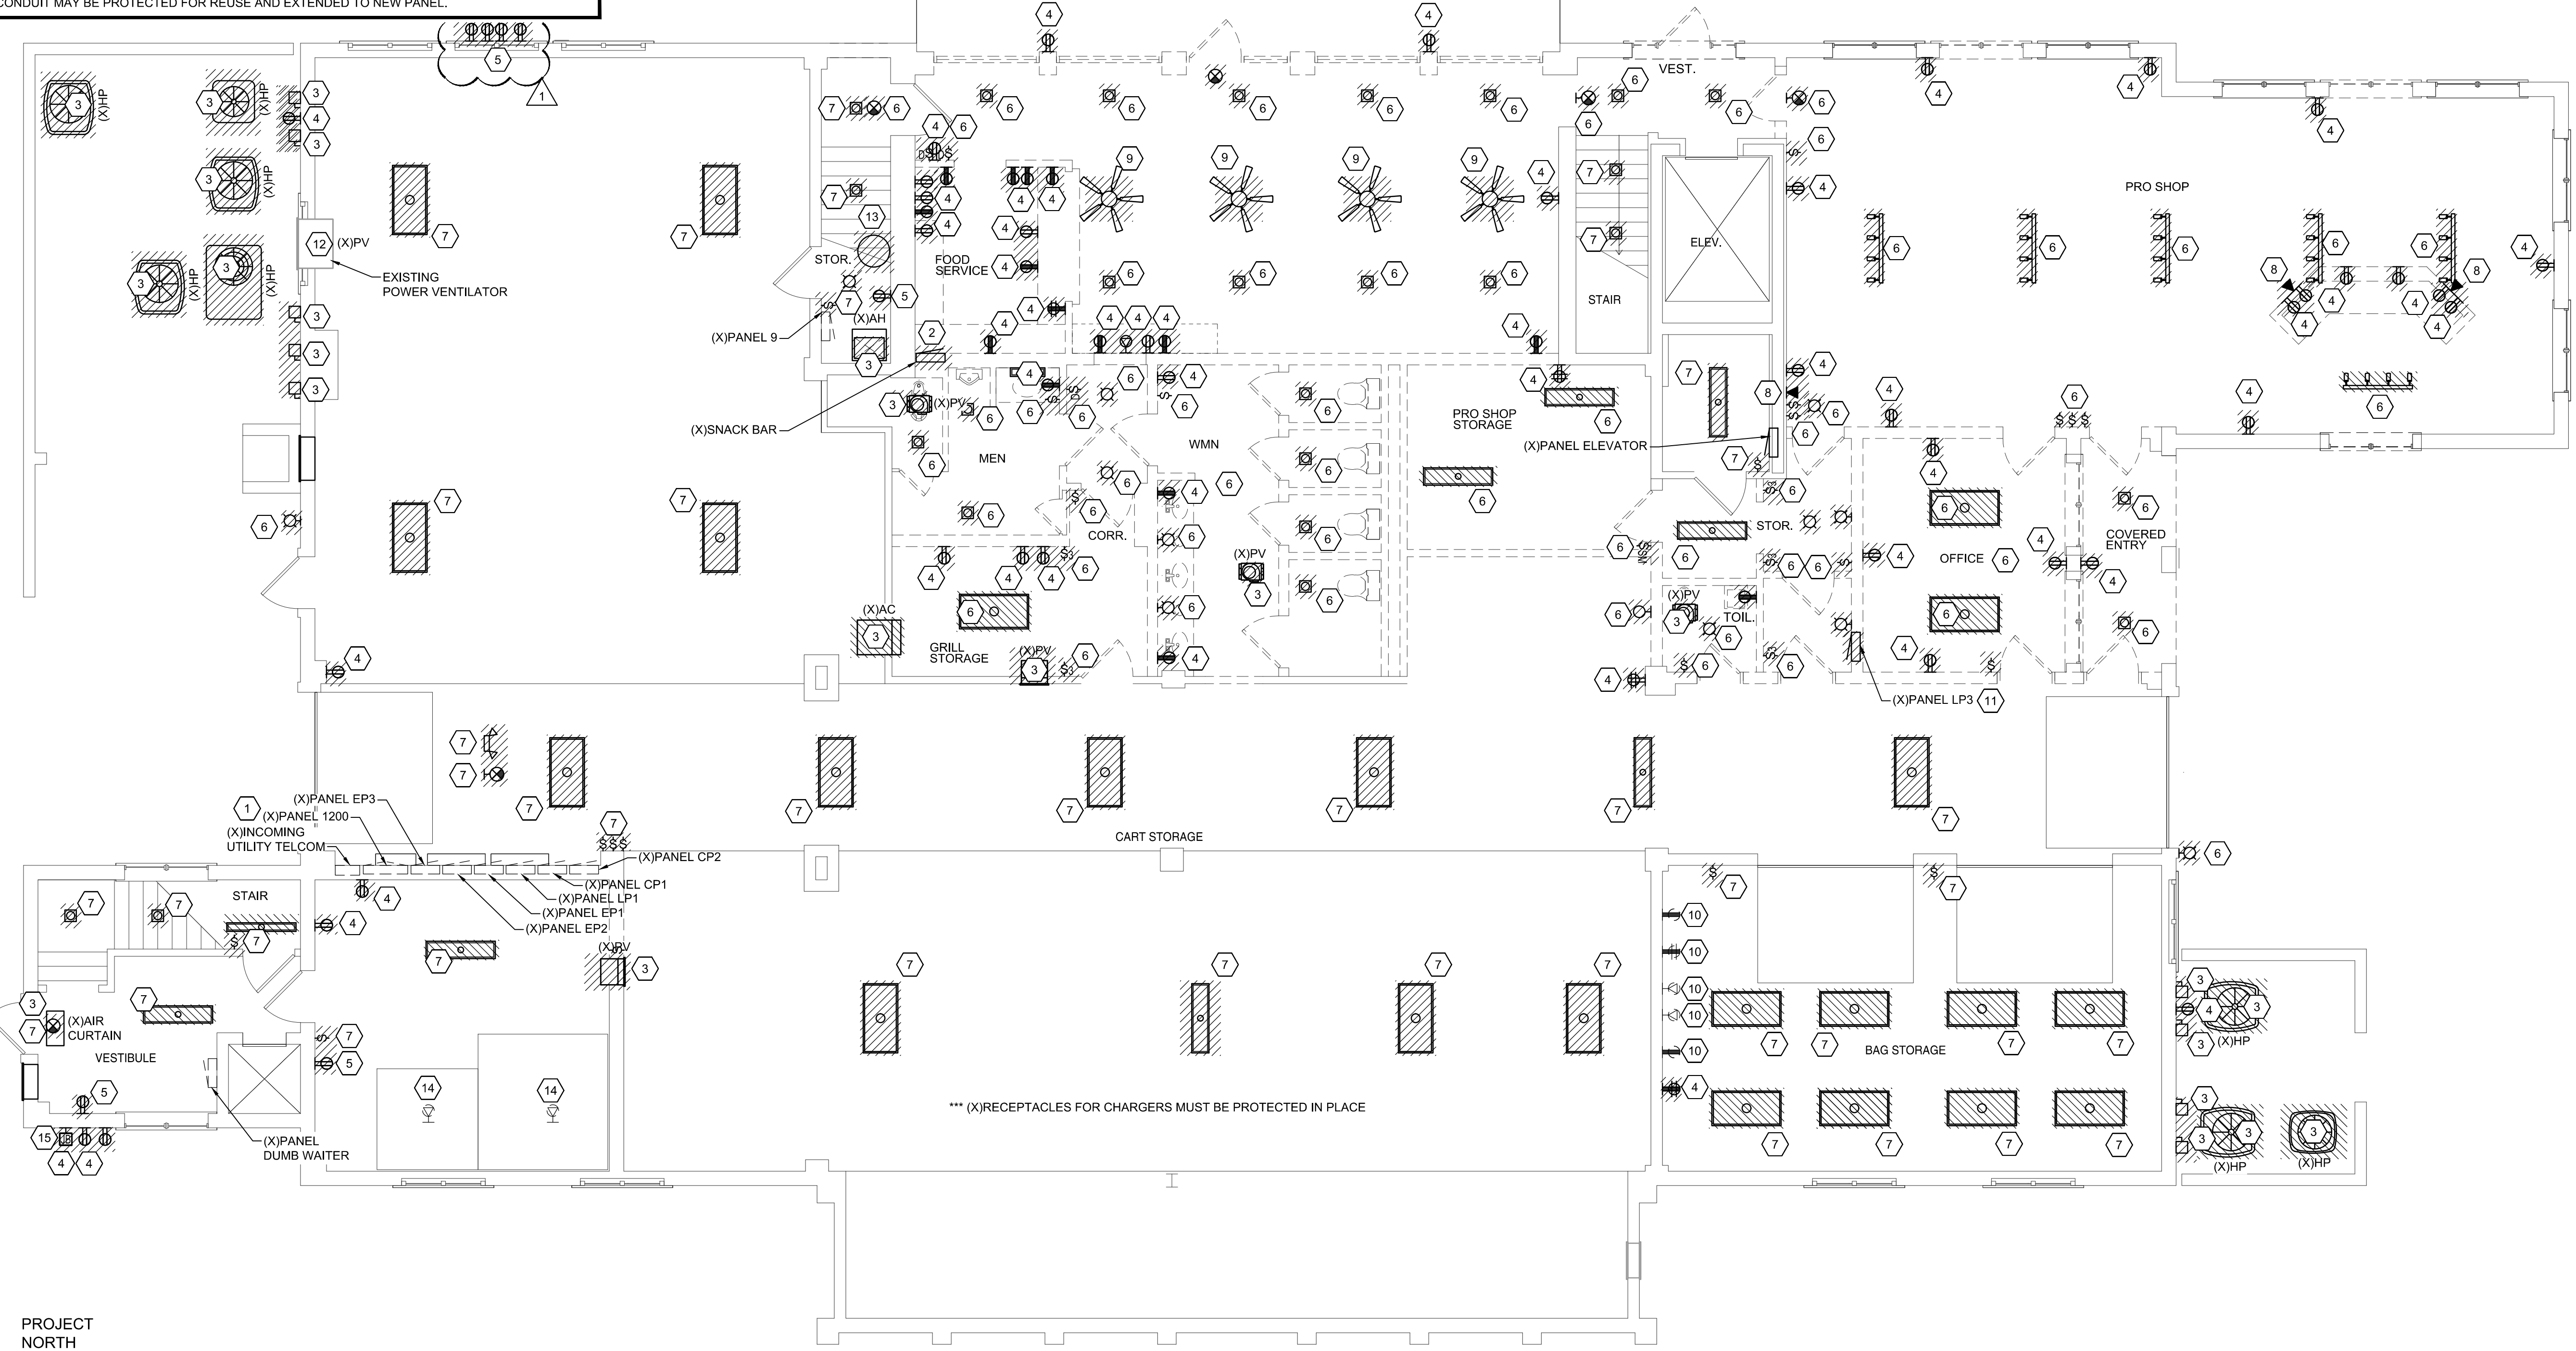

PROJECT
NORTH
1
ED1.1
scale: 3/16"=1'-0"

*** (X)RECEPTACLES FOR CHARGERS MUST BE PROTECTED IN PLACE

KEYED NOTES


- 1 CONTRACTOR PROVIDED FIXTURE CONNECTED TO EXISTING CIRCUIT.
2 THIS FIXTURE FED VIA INVERTER UPON LOSS OF NORMAL POWER.

GENERAL NOTE:

INTERIOR DESIGNER MUST APPROVE ALL SCONCE LOCATIONS.
CONTRACTOR MUST COORDINATE SITE VISIT WITH INTERIOR DESIGNER
BEFORE ANY ELECTRICAL ROUGH-IN WORK.

CBHF
Engineers, PLLC
2246 Yaupon Drive
Wilmington, NC 28401
Phone: 910.791.4000
Fax: 910.791.5266
www.cbhfenr.com
NC# P-0506
© Copyright 2020 CBHF Engineers, PLLC

bmh
BOWMAN
MURRAY
HEMINGWAY
ARCHITECTS
514 Market Street
Wilmington, NC 28401
Tel - (910) 762-2621
Fax - (910) 762-8506

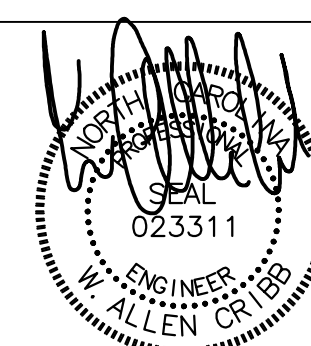

08-28-2020

The Country Club of Landfall
Dye Club House
Wilmington, North Carolina


REV.	DATE	DESCRIPTION
2	08.28.20	ADDENDUM #3: OWNER LOW VOLTAGE COMMENTS
1	08.10.20	ADDENDUM #1: CEILING LIGHTING REVISED

NO.	DATE	ISSUE NOTE
Project Manager	MDM	Drawn By
Date	07.29.2020	Reviewed By
Project ID	WAC	

Sheet Title
**ELECTRICAL
FIRST FLOOR
LIGHTING PLAN**

Sheet No.

EL1.1

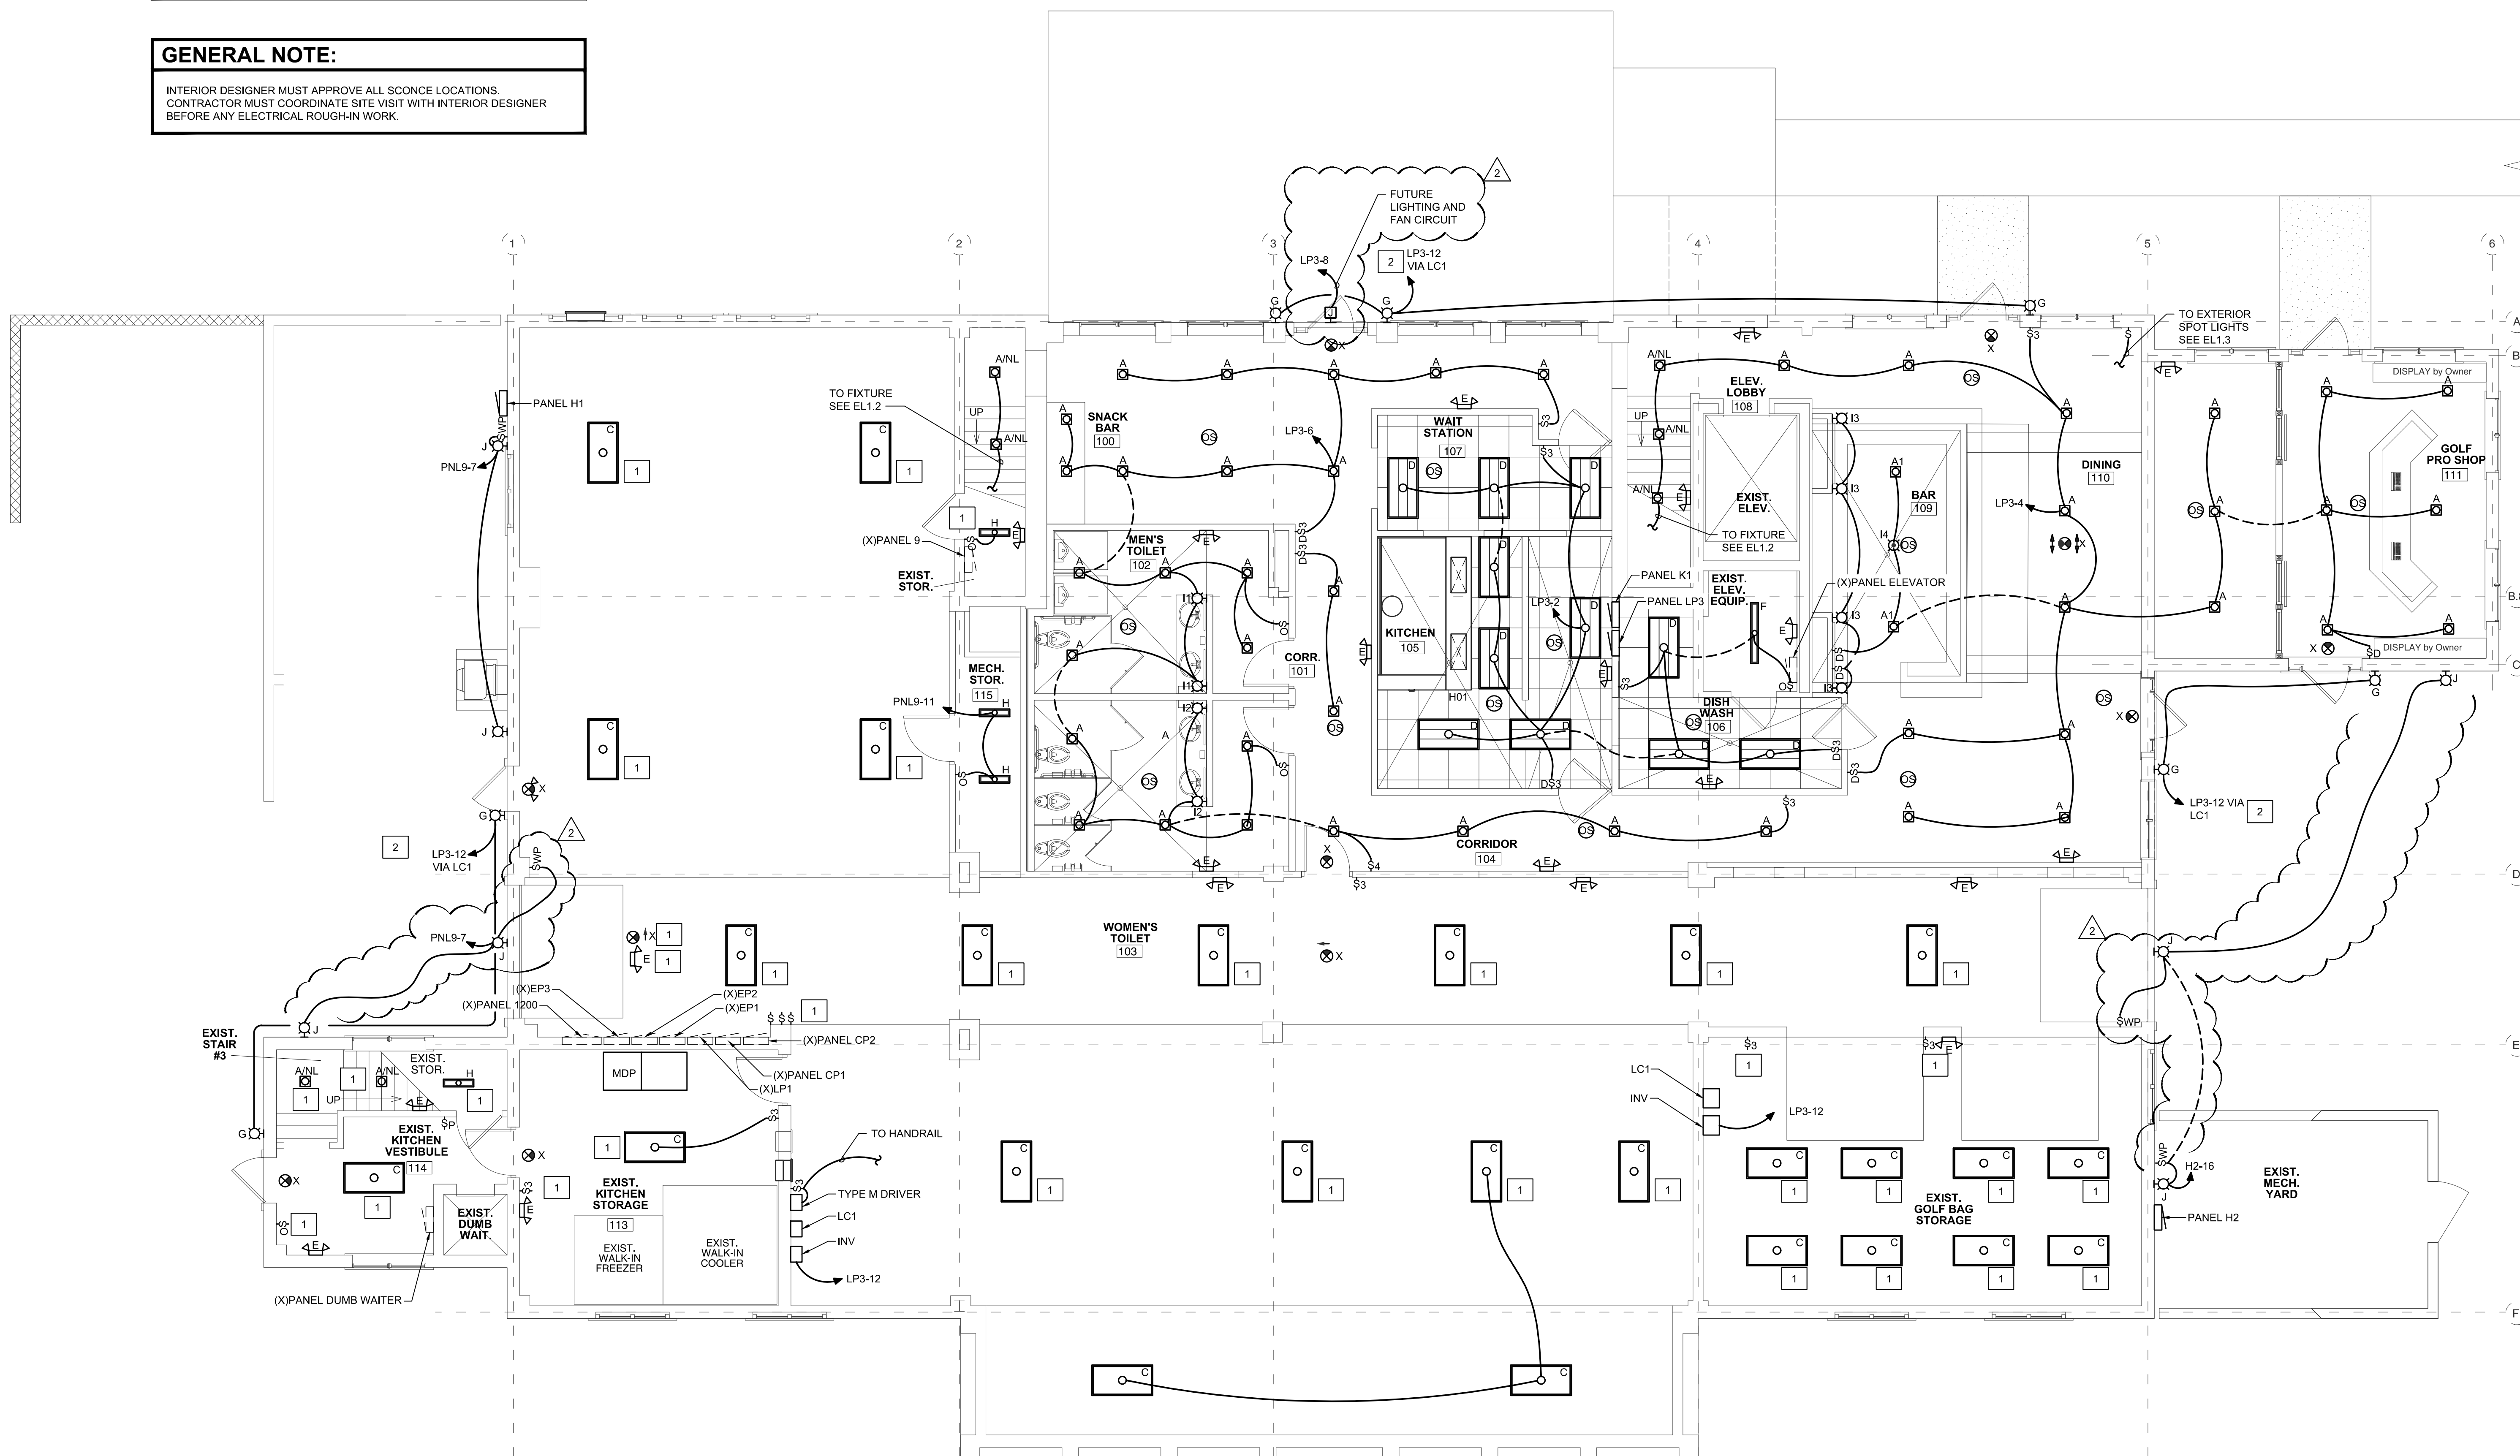

PROJECT
NORTH
1
EL1.1
FIRST FLOOR PLAN
scale: 3/16"=1'-0"

KEYED NOTES	
1	CONTRACTOR PROVIDED DEVICE CONNECTED TO EXISTING CIRCUIT.
2	COORDINATE RECEPTACLE CONFIGURATION AND WIRING WITH OWNER SUPPED EQUIPMENT.
3	EXISTING DEVICE AND CIRCUIT NOT IN SCOPE.

CBHF
Engineers, PLLC

2246 Yaupon Drive
Wilmington, NC 28401

Phone: 910.791.4000
Fax: 910.791.5266
www.cbhfenr.com
NC# P-0506

bmm
BOWMAN
MURRAY
HEMINGWAY
ARCHITECTS


514 Market Street
Wilmington, NC 28401
Tel - (910) 762-2621
Fax - (910) 762-8506

08-28-2020

The Country Club of Landfall
Dye Club House
Wilmington, North Carolina

ADDENDUM #3: OWNER LOW VOLTAGE COMMENTS	
REV.	DATE
1	08-28-20
NO.	
DATE	
ISSUE NOTE	
Project Manager	
Drawn By	
Date	
Reviewed By	
Project ID	
Sheet Title	
ELECTRICAL FIRST FLOOR POWER PLAN	
Sheet No.	

EP1.1

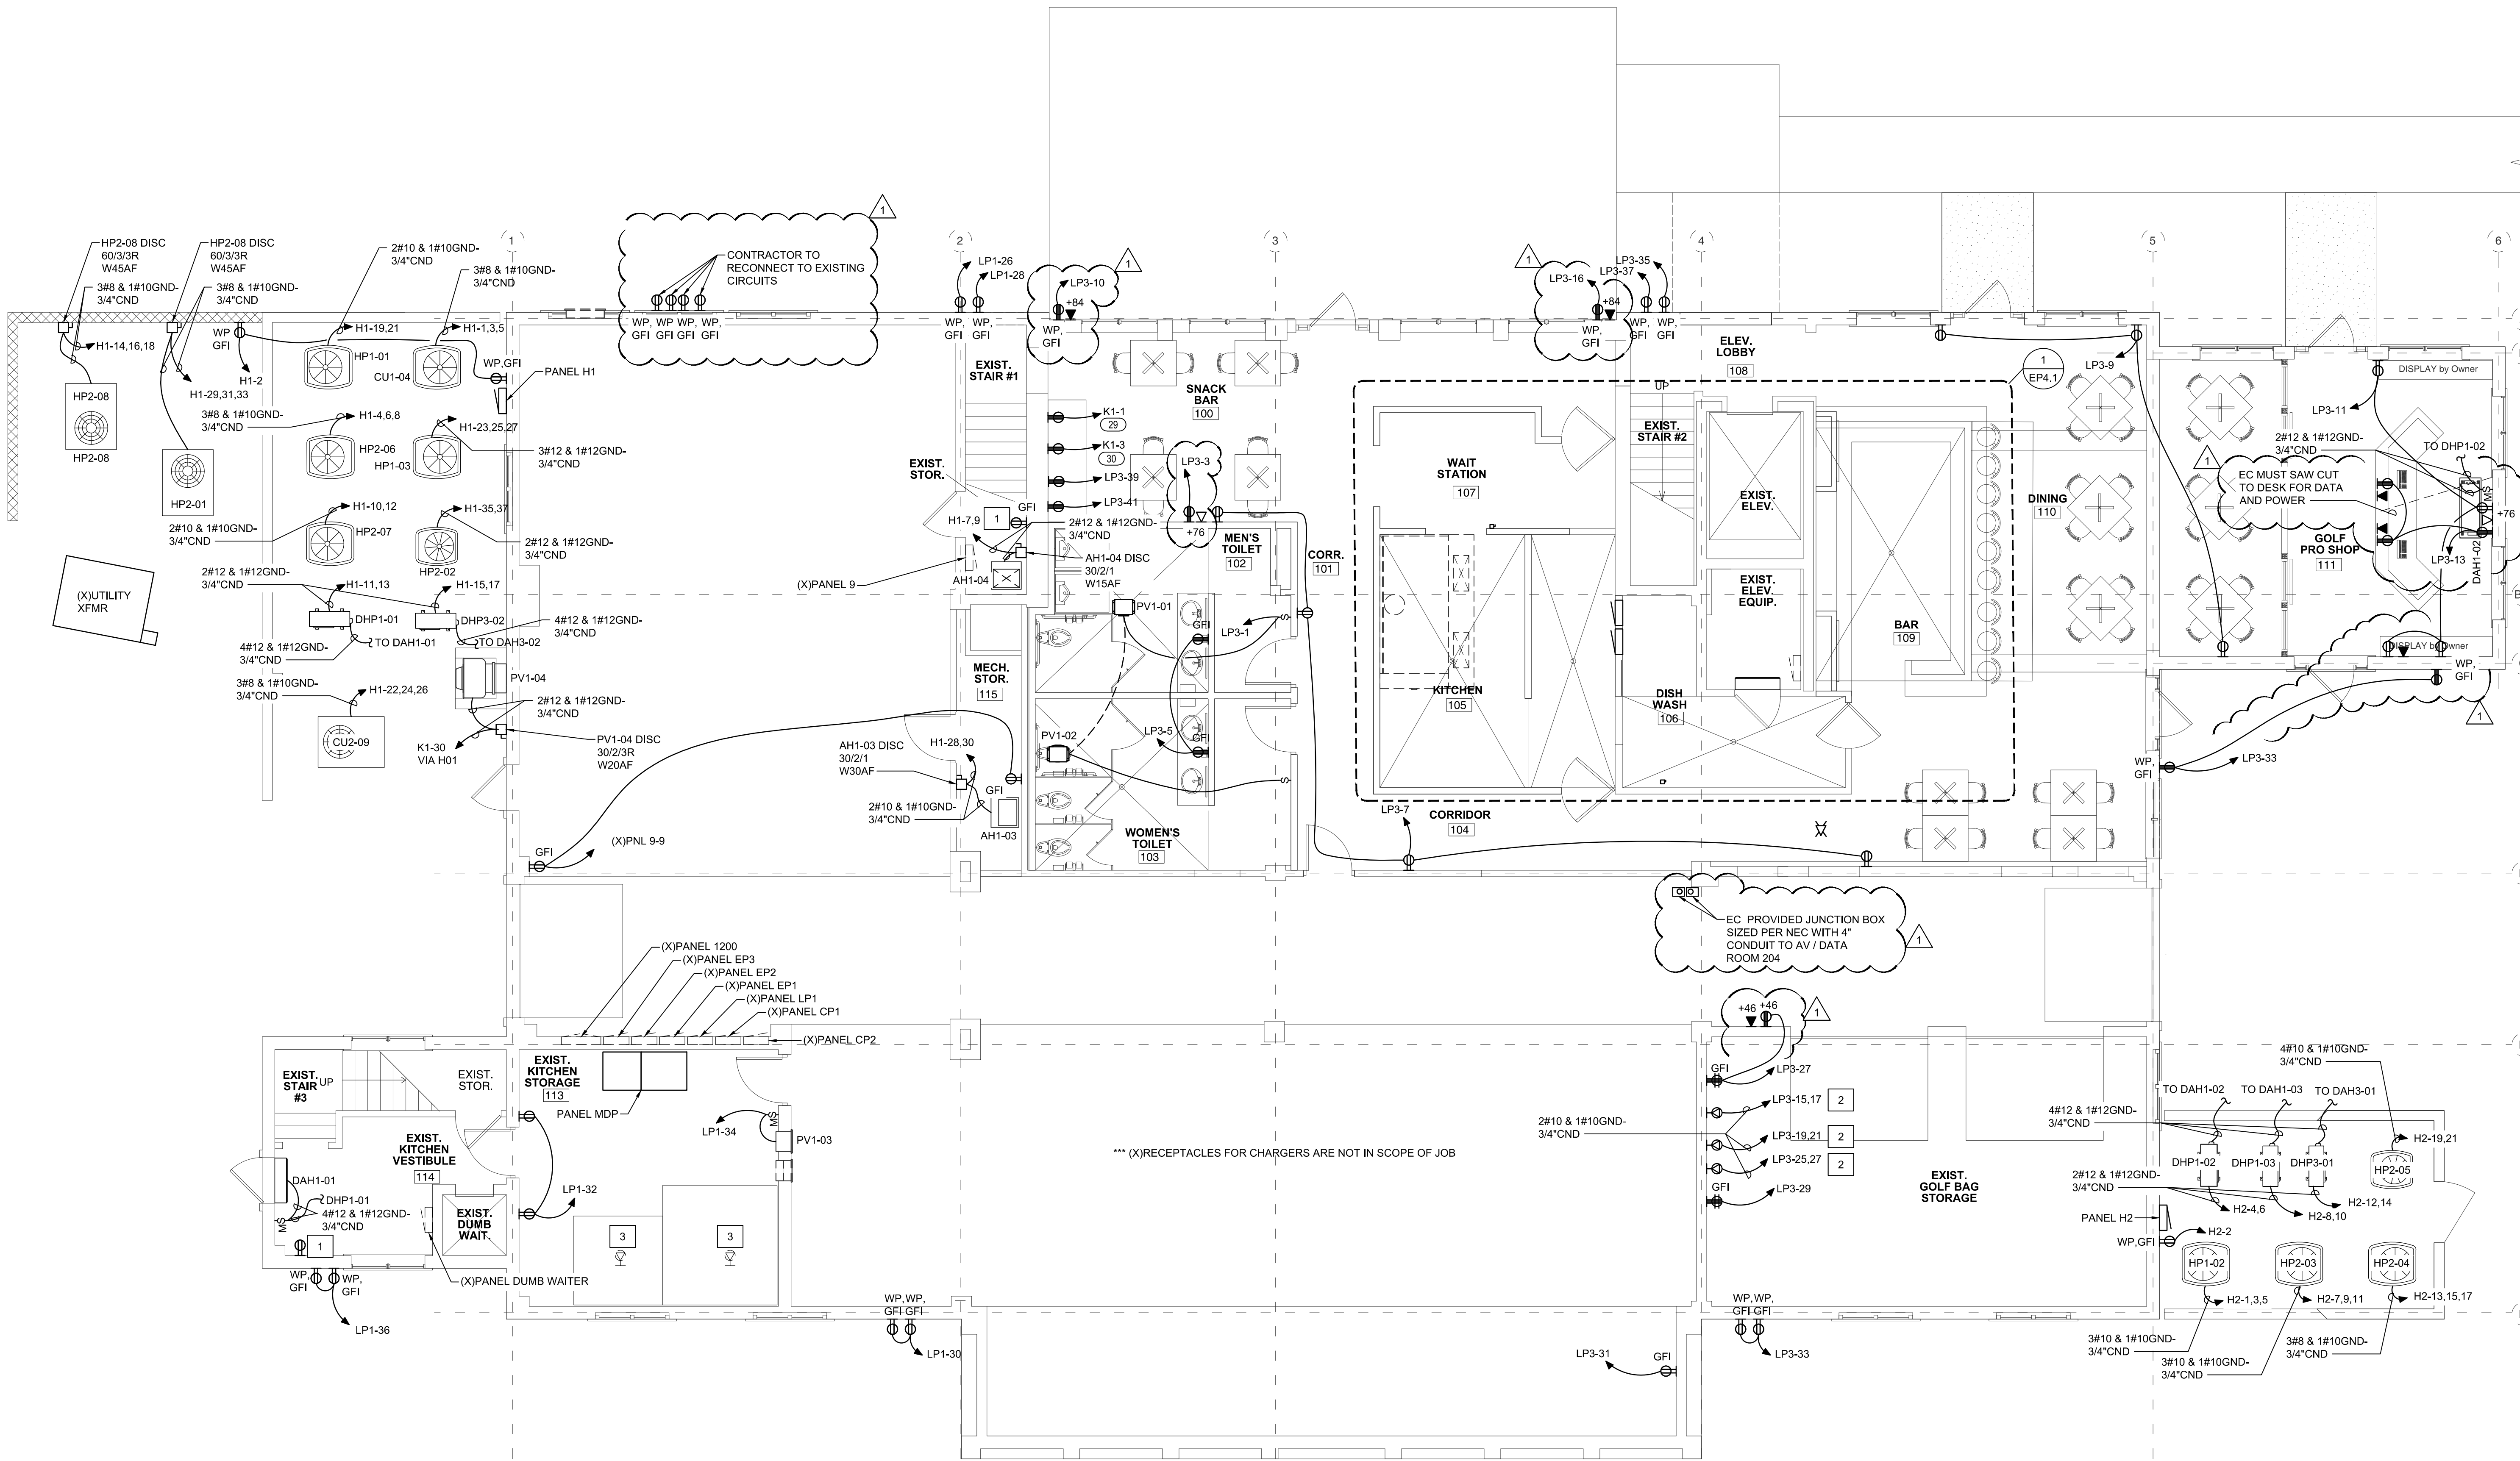

PROJECT
NORTH

1
EP1.1

scale: 3/16"=1'-0"

KEYED NOTES	
1	CONTRACTOR PROVIDED DEVICE CONNECTED TO EXISTING CIRCUIT.
2	PROVIDE COVERPLATE, COORDIANTE COLOR WITH ARCHTIECT.

CBHF
Engineers, PLLC

2246 Yaupon Drive
Wilmington, NC 28401

Phone: 910.791.4000
Fax: 910.791.5266
www.cbhfindengineers.com
NC# P-0506

© Copyright 2020 CBHF Engineers, PLLC

bmm

**BOWMAN
MURRAY
HEMINGWAY**

ARCHITECTS

514 Market Street
Wilmington, NC 28401
Tel - (910) 762-2621
Fax - (910) 762-8506

08-28-2020

The Country Club of Landfall
Dye Club House
Wilmington, North Carolina

REV.	DATE	DESCRIPTION
1	08.28.20	ADDENDUM #3: OWNER LOW VOLTAGE COMMENTS


NO.	DATE	ISSUE NOTE

Project Manager	Drawn By MDM
Date 07.29.2020	Reviewed By WAC
Project ID	

Sheet Title
**ELECTRICAL
SECOND FLOOR
POWER PLAN**

Sheet No.

EP1.2

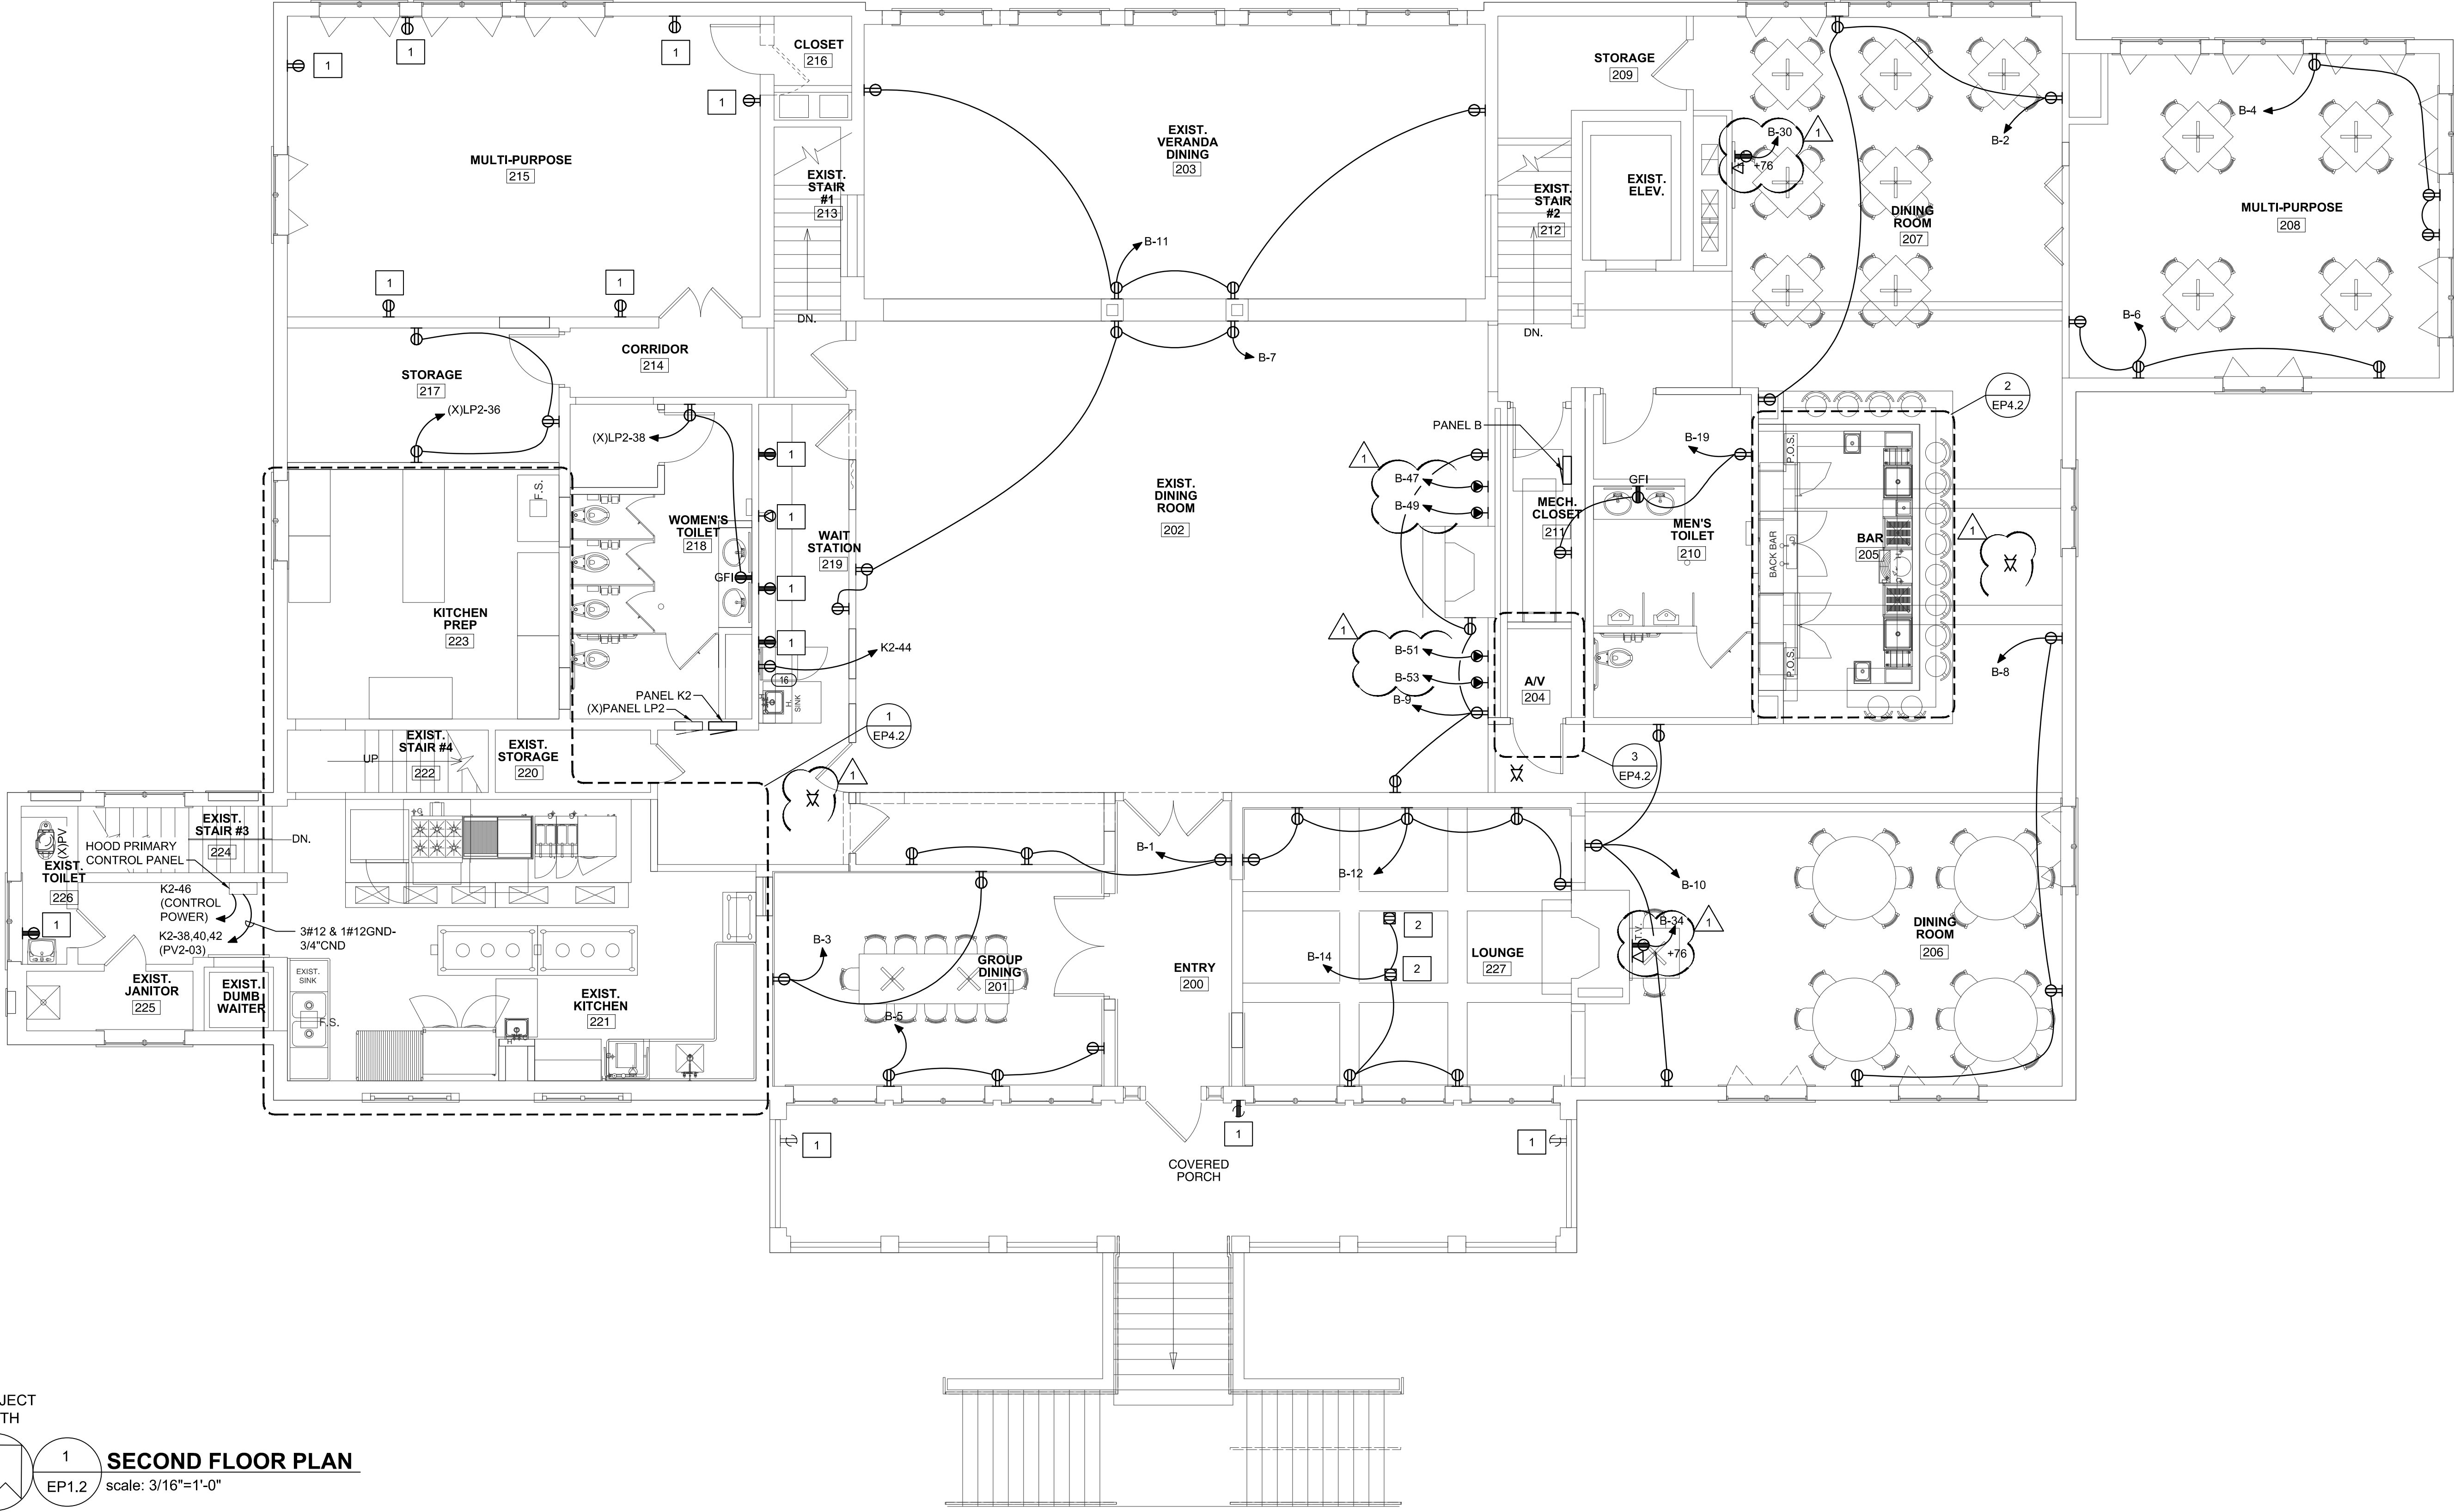

PROJECT
NORTH

1
EP1.2

SECOND FLOOR PLAN

scale: 3/16"=1'-0"


CBHF
Engineers, PLLC

2246 Yaupon Drive
Wilmington, NC 28401

Phone: 910.791.4000
Fax: 910.791.5266
www.cbhfenrines.com
NC# P-0506

bmm
BOWMAN
MURRAY
HEMINGWAY
ARCHITECTS


514 Market Street
Wilmington, NC 28401
Tel - (910) 762-2621
Fax - (910) 762-8506

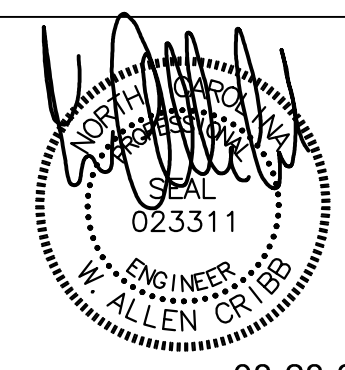
08-28-2020


The Country Club of Landfall
Dye Club House
Wilmington, North Carolina

1		08.28.20	ADDENDUM #3: OWNER LOW VOLTAGE COMMENTS
REV.	DATE	DESCRIPTION	
NO.	DATE	ISSUE NOTE	
Project Manager		Drawn By MDM	
Date 07.29.2020		Reviewed By WAC	
Project ID			
Sheet Title			
ELECTRICAL ATTIC POWER PLAN			
Sheet No.			

EP1.3

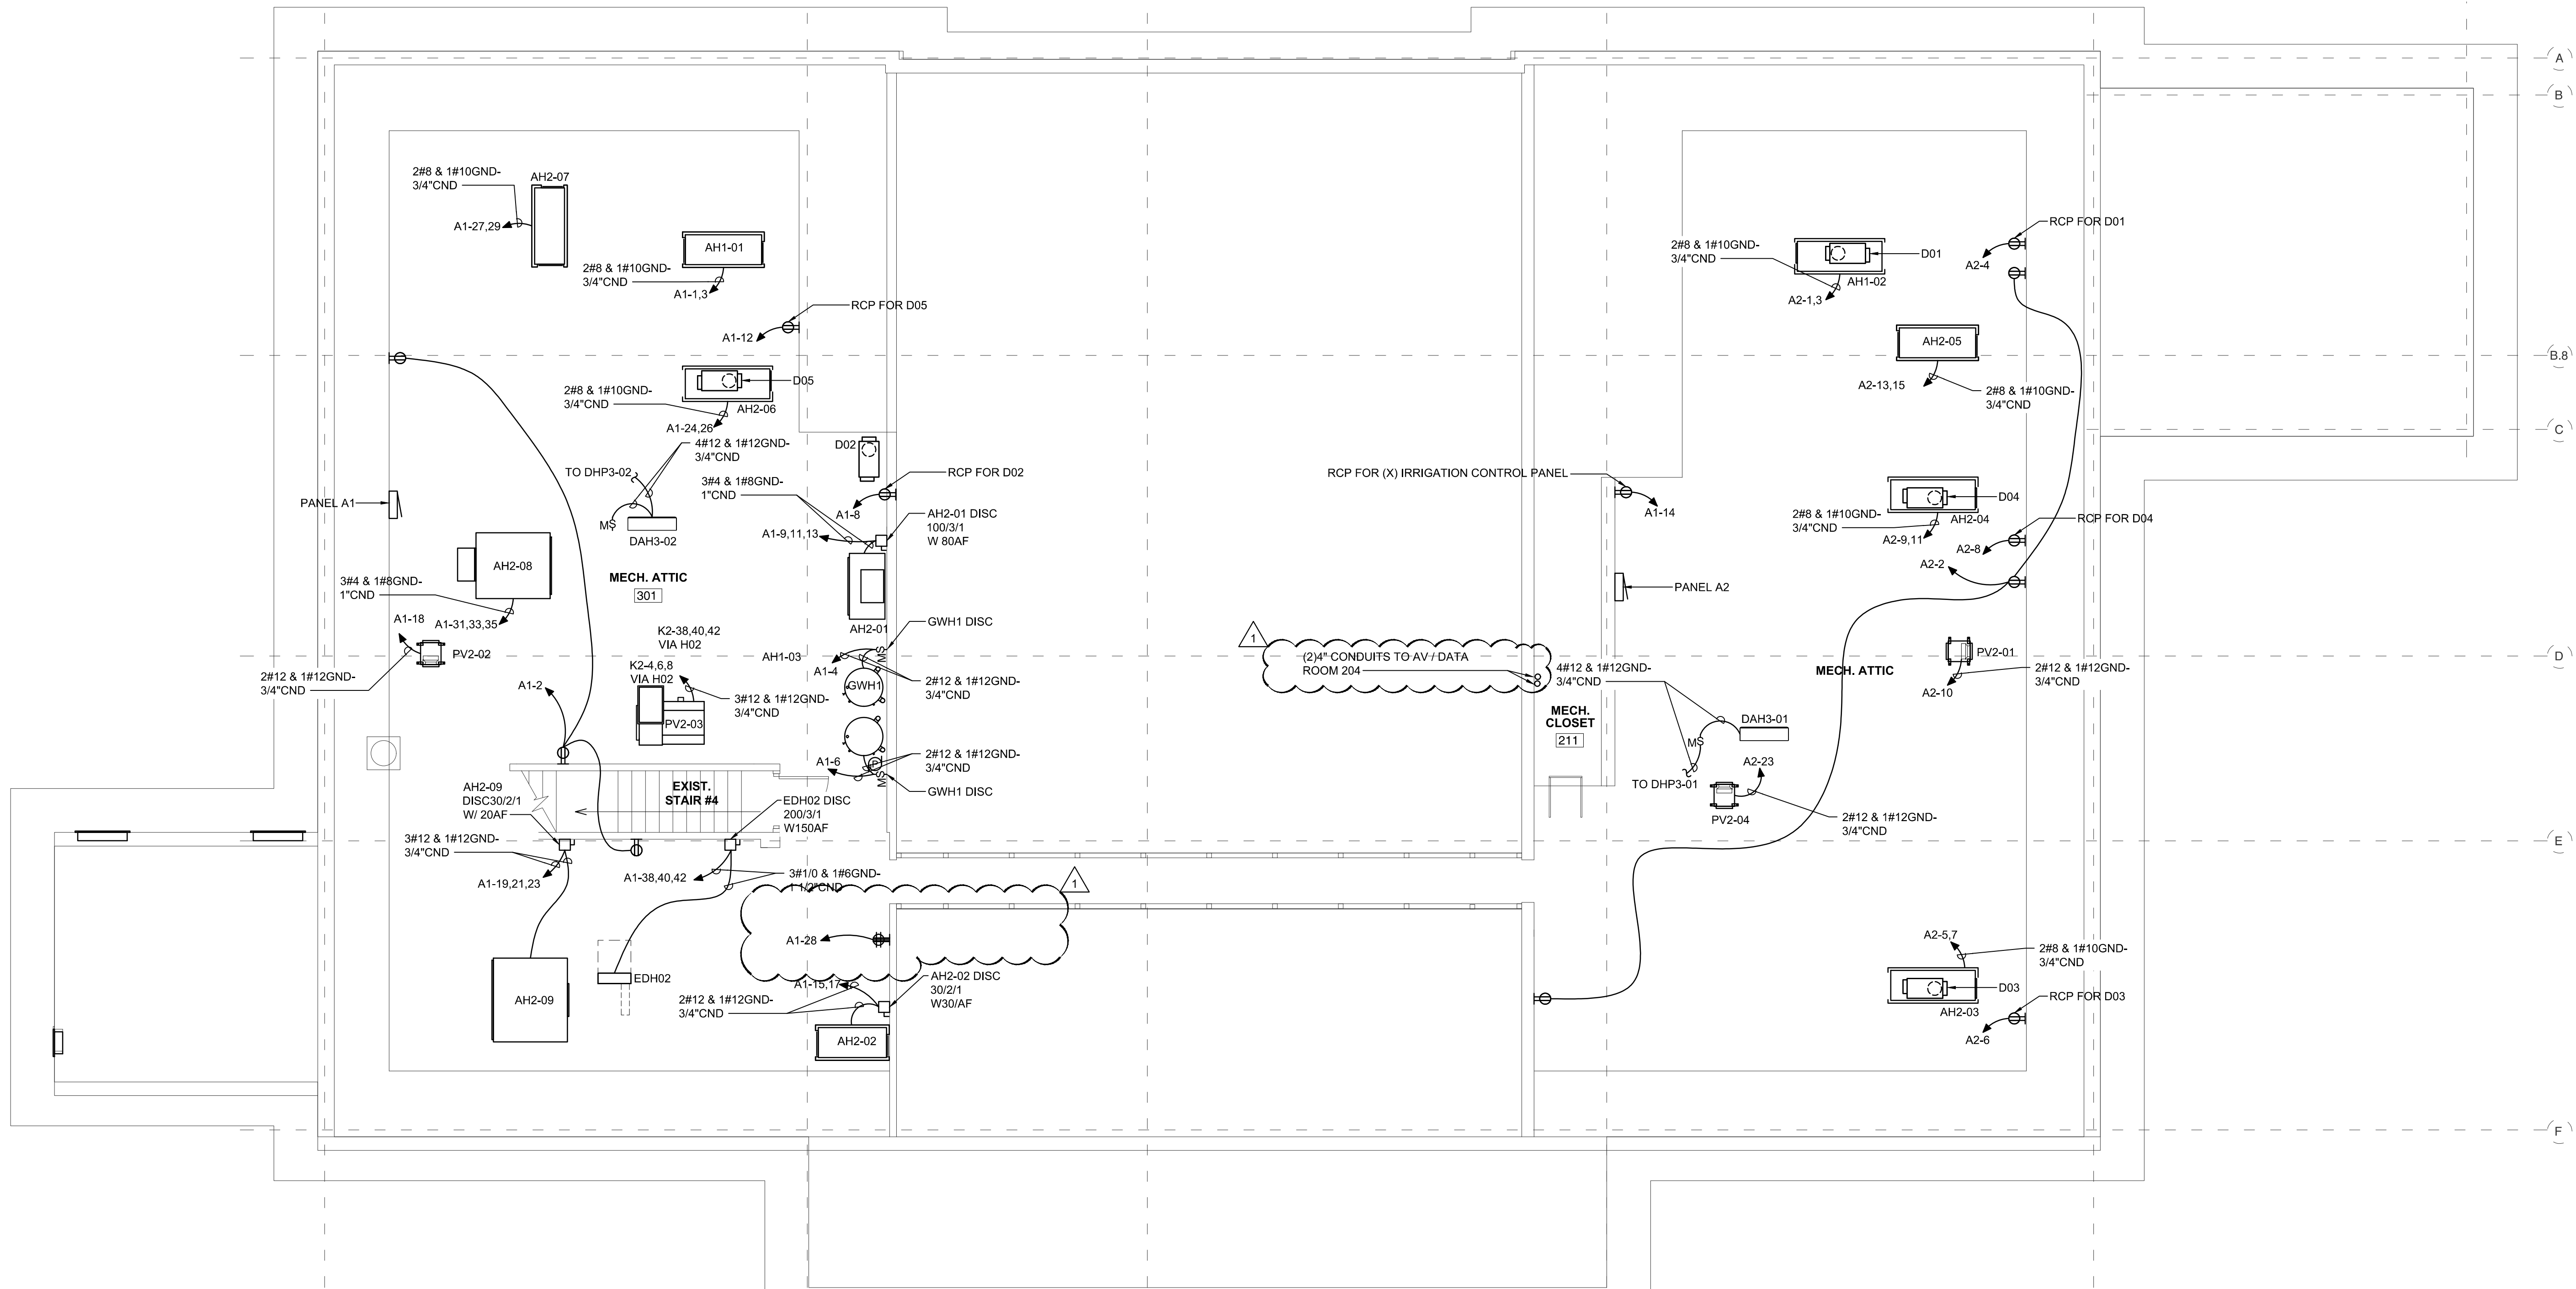

PROJECT
NORTH

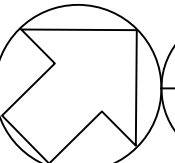

1
EP1.3
ATTIC PLAN
scale: 3/16"=1'-0"

1

2

3

4

5

6


A

B

C

D

E

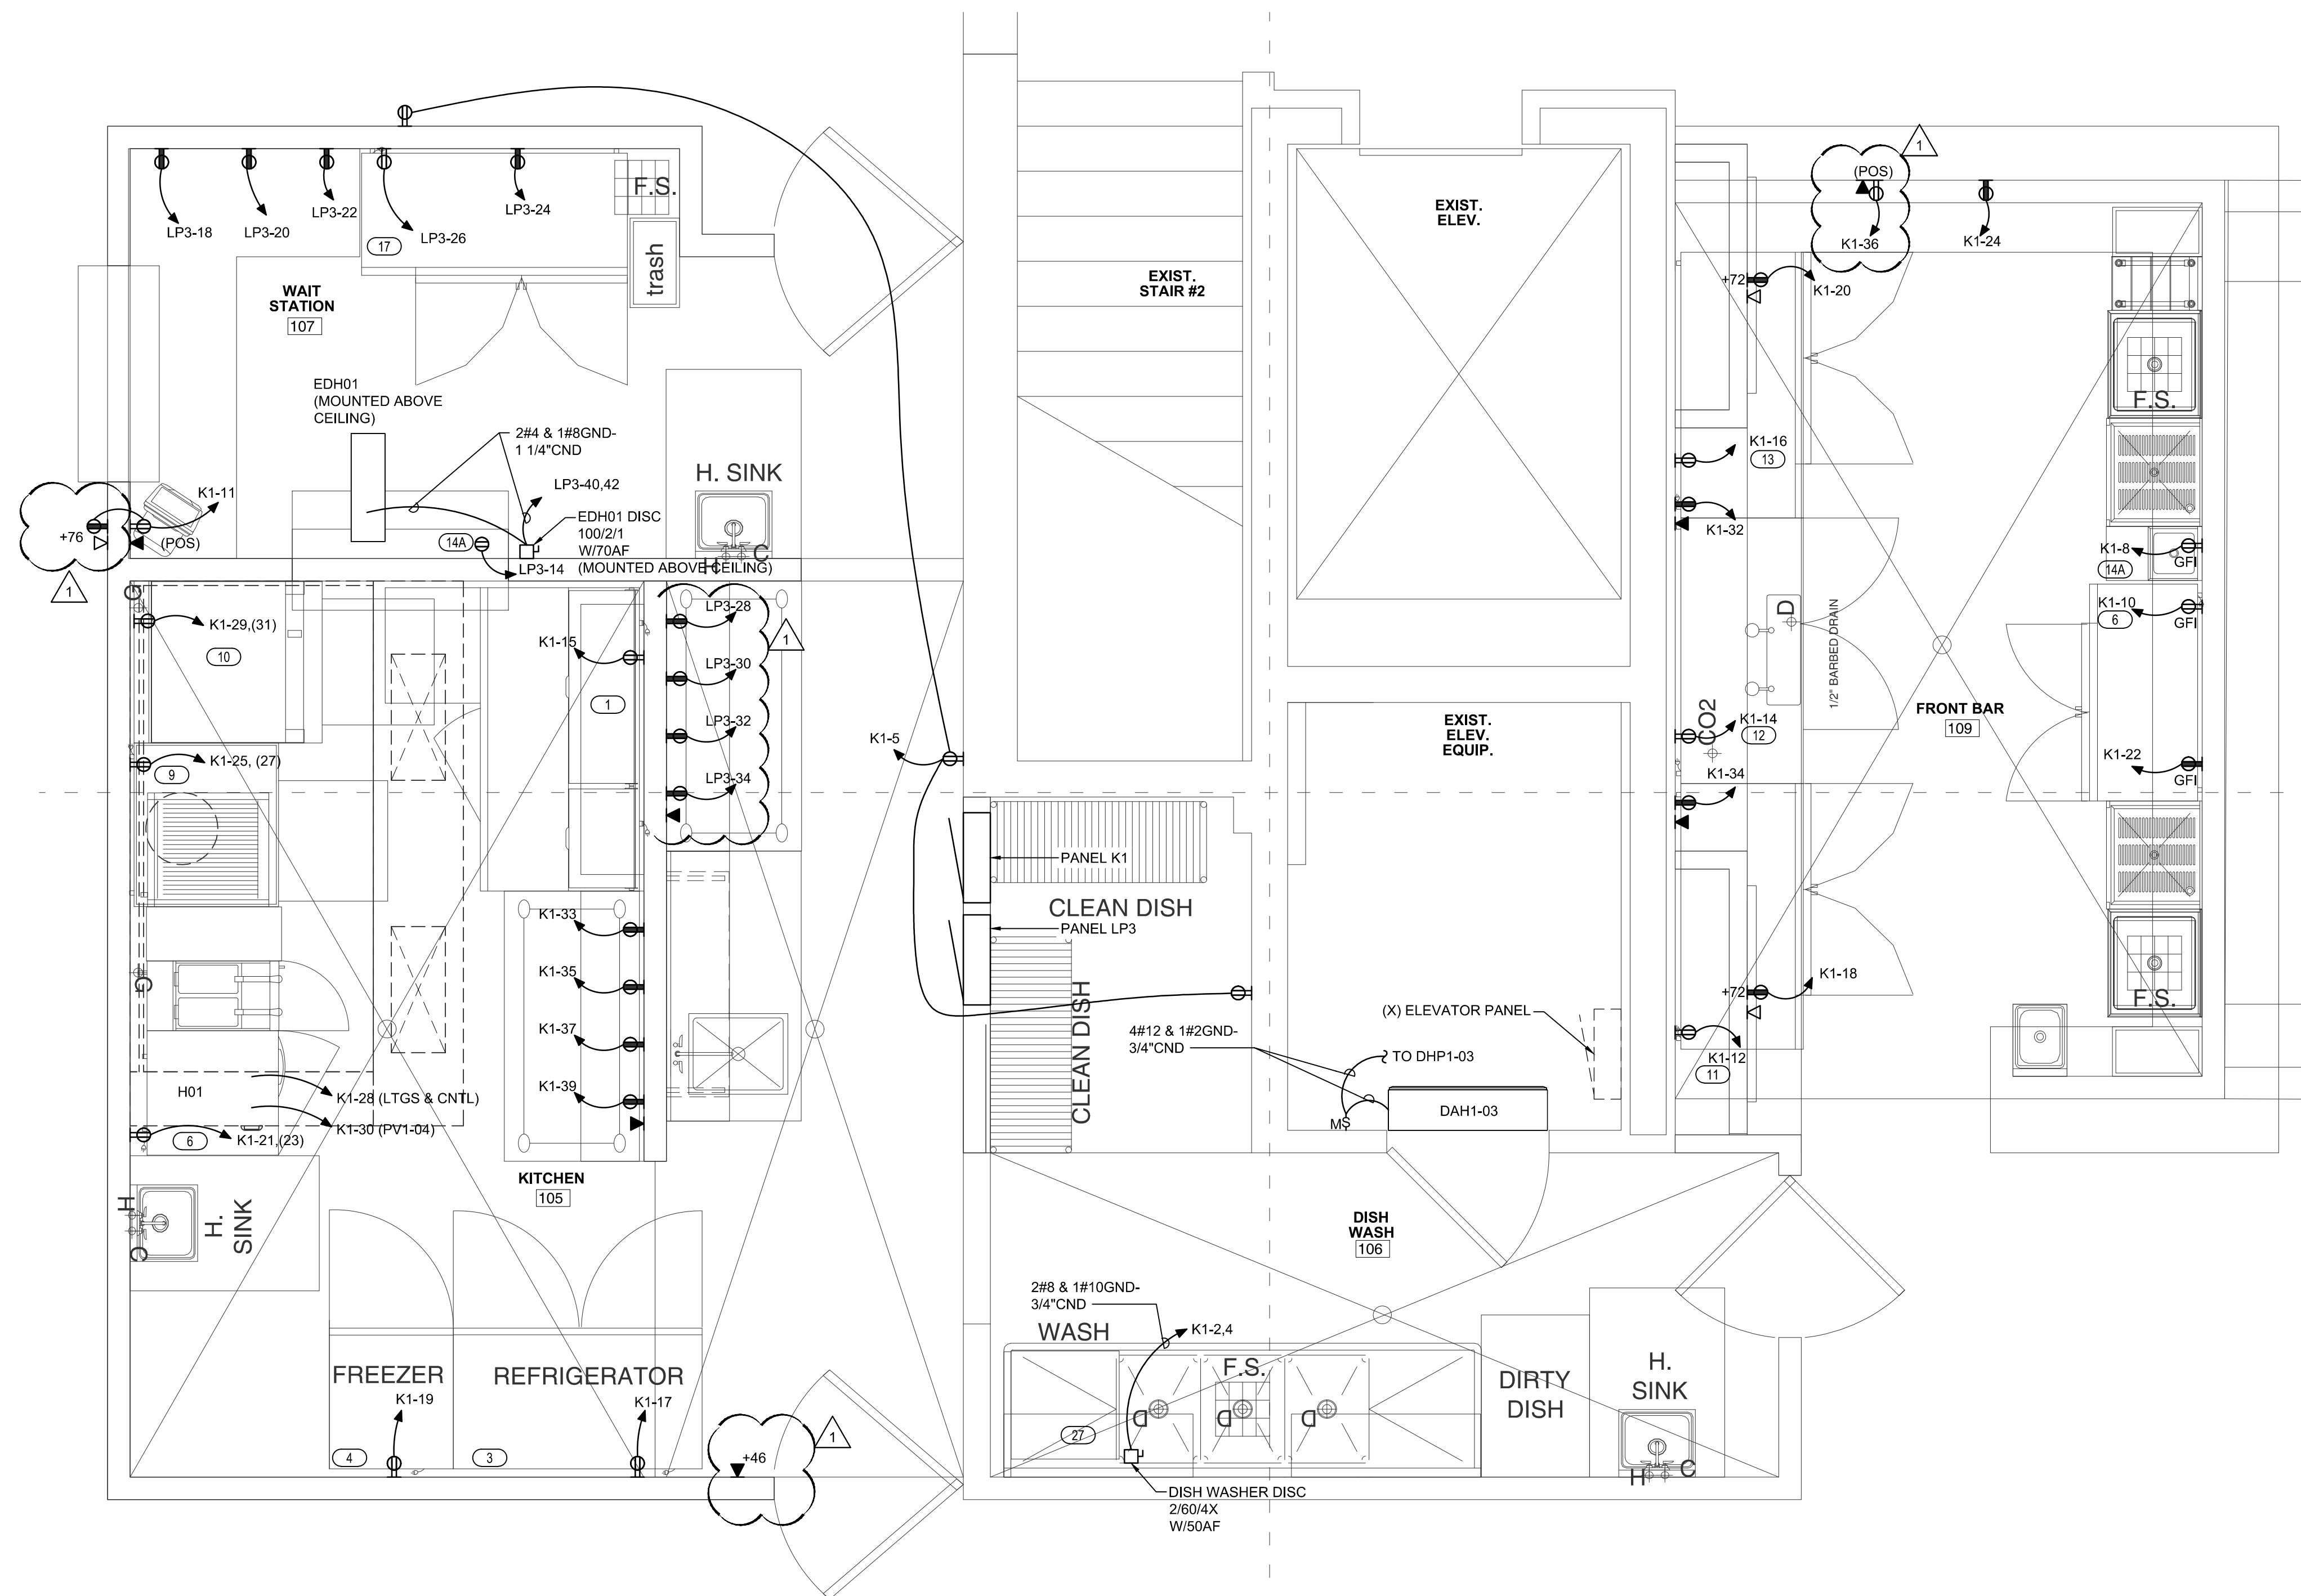

1 **ENLARGED BAR AND KITCHEN PLAN**
EP4.1 Scale: 1/2"=1'-0"

NOTE:
ALL BREAKER SUPPLYING KITCHEN LOADS MUST BE GFI.

CBHF
Engineers, PLLC
2246 Yaupon Drive
Wilmington, NC 28401
Phone: 910.791.4000
Fax: 910.791.5266
www.cbhfenr.com
NC# P-0506

bmm
BOWMAN
MURRAY
HEMINGWAY
ARCHITECTS

514 Market Street
Wilmington, NC 28401
Tel - (910) 762-2621
Fax - (910) 762-8506

08-28-2020

The Country Club of Landfall
Dye Club House
Wilmington, North Carolina

REV.	DATE	DESCRIPTION
1	08.28.20	ADDENDUM #3: OWNER LOW VOLTAGE COMMENTS

NO.	DATE	ISSUE NOTE

Project Manager	Drawn By MDM
Date 07.29.2020	Reviewed By WAC
Project ID	

Sheet Title
ELECTRICAL ENLARGED POWER PLAN
Sheet No.

EP4.1

1


2

3

4

5

6

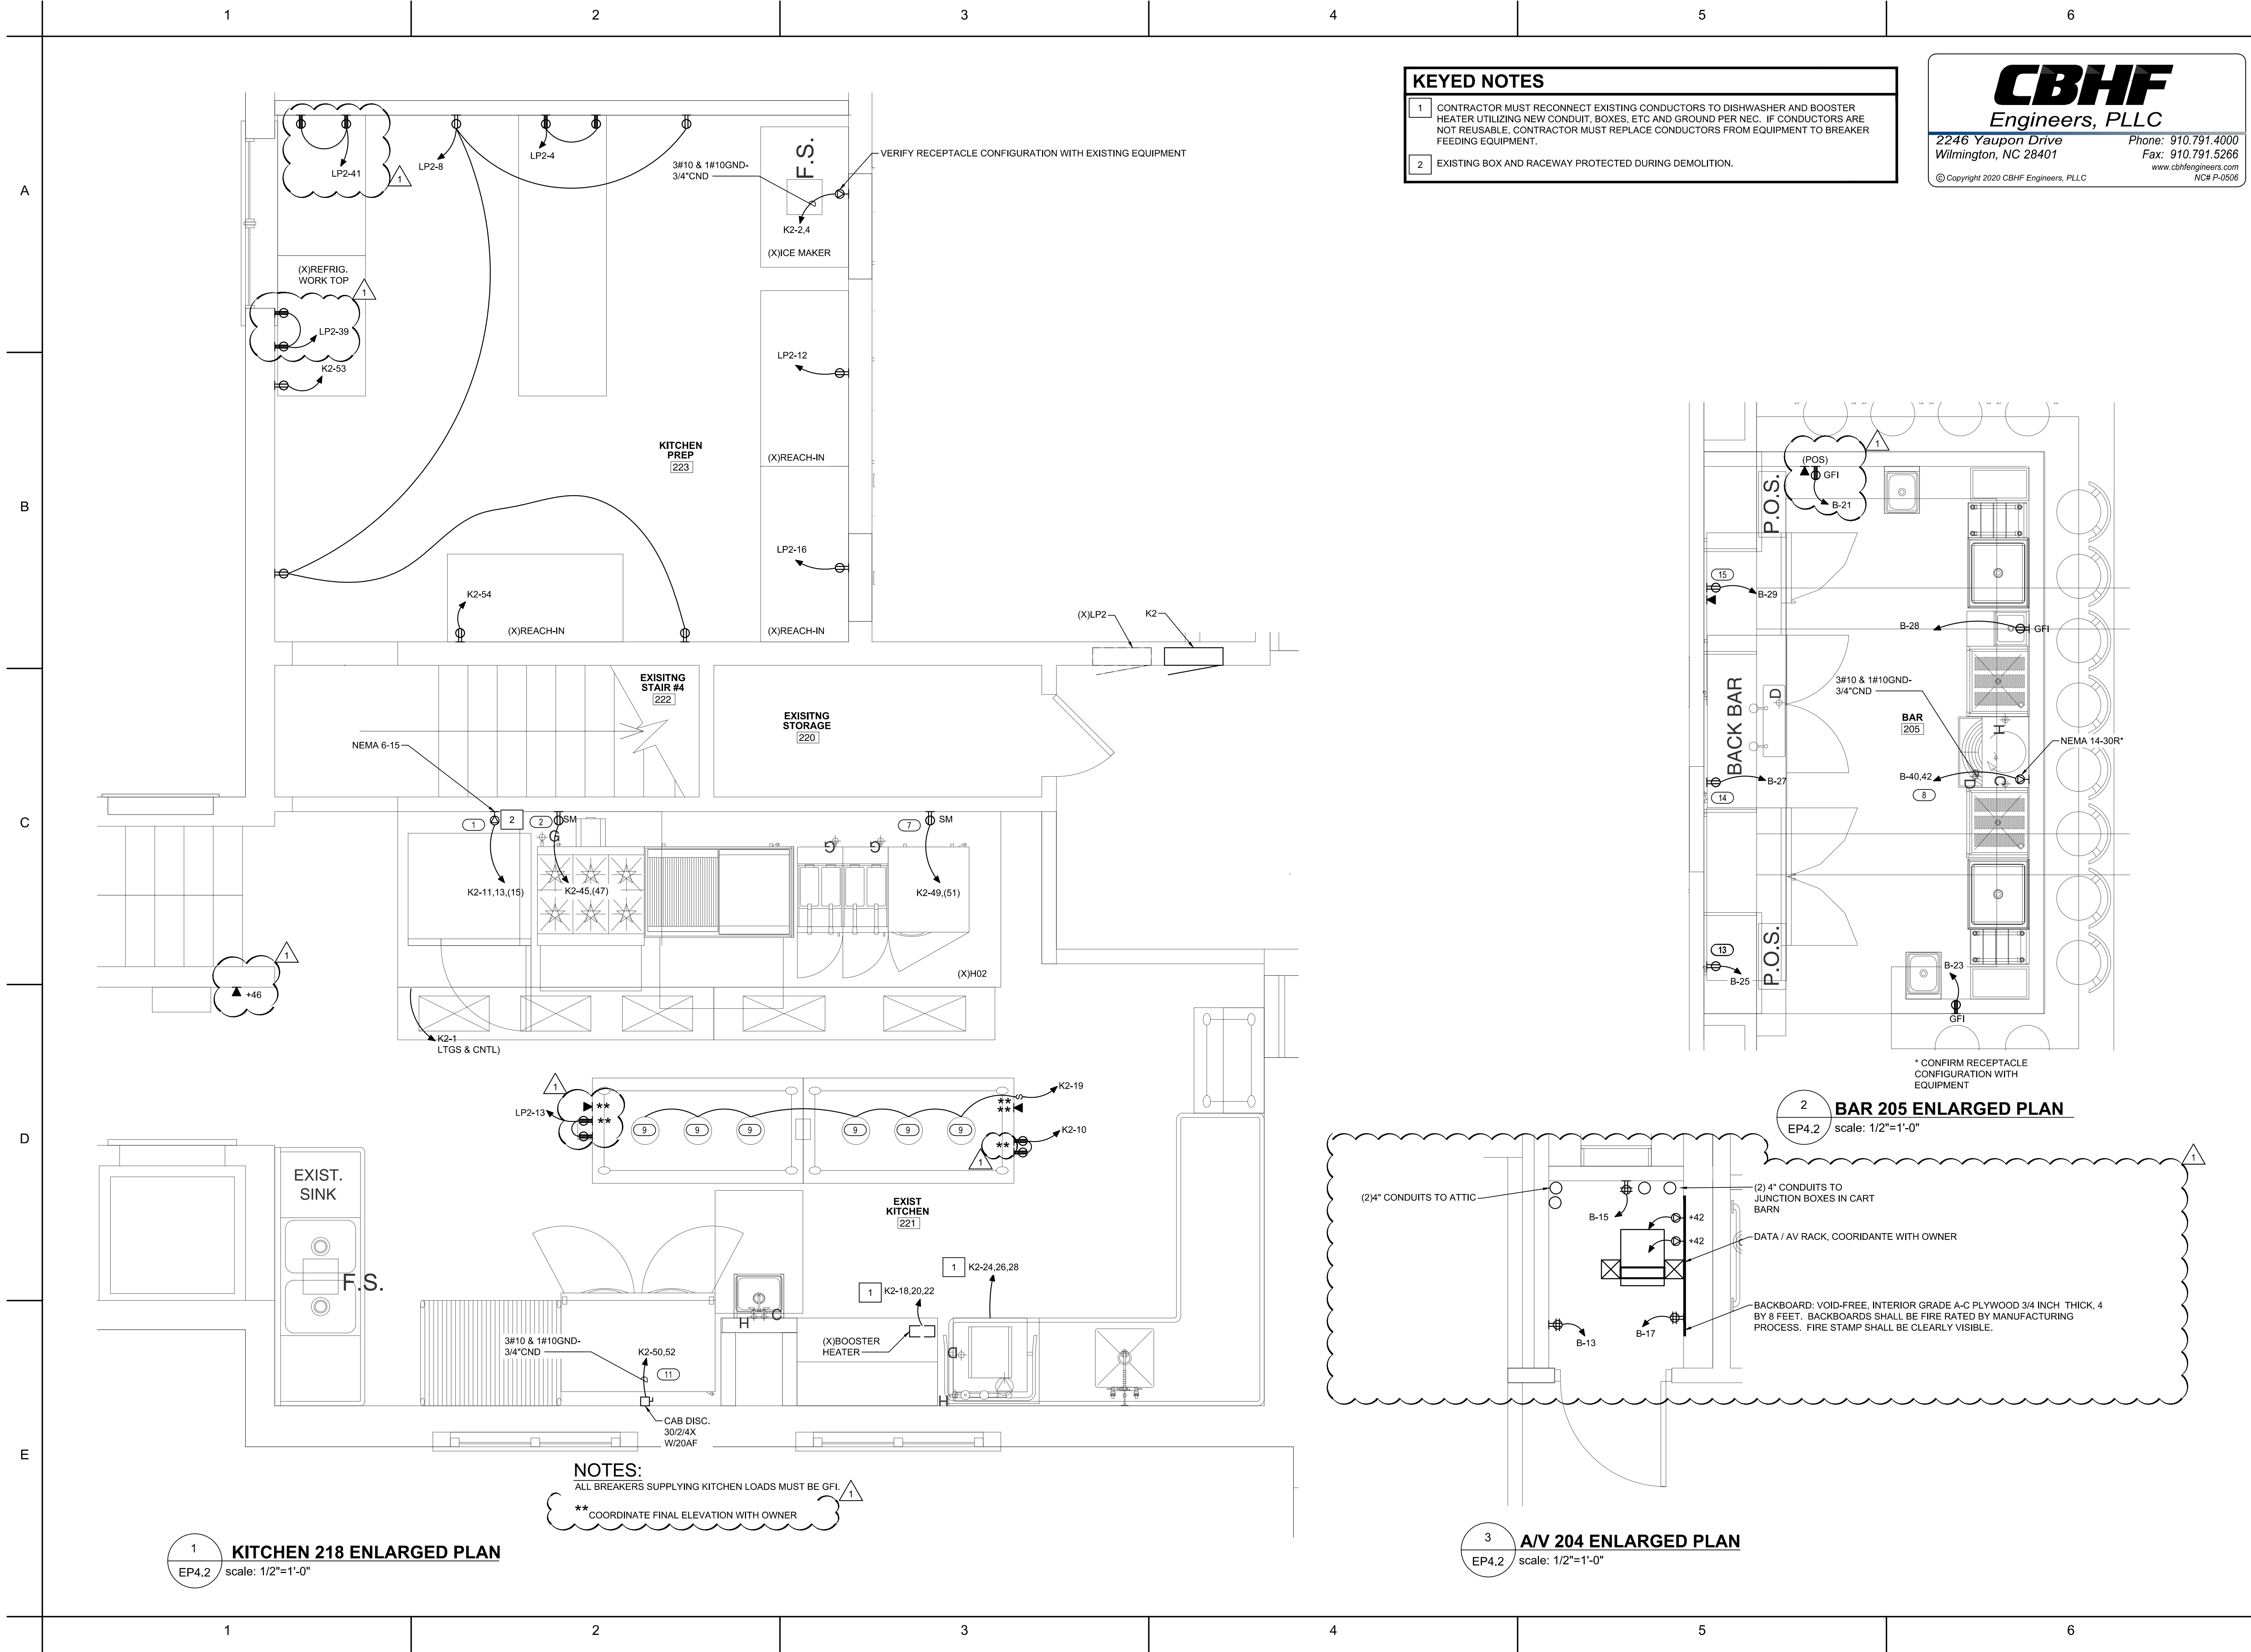

CBHF
Engineers, PLLC

2246 Yaupon Drive
Wilmington, NC 28401

Phone: 910.791.4000
Fax: 910.791.5266
www.cbhfenrigneers.com
NC# P-0506

bmm
BOWMAN
MURRAY
HEMINGWAY
ARCHITECTS

514 Market Street
Wilmington, NC 28401
Tel - (910) 762-2621
Fax - (910) 762-8506

[Signature]
025311
ENGINEER
ALLEN CRIBB
08-28-2020

The Country Club of Landfall
Dye Club House
Wilmington, North Carolina

1	08.28.20	ADDENDUM #3: OWNER LOW VOLTAGE COMMENTS
REV.	DATE	DESCRIPTION
NO.	DATE	ISSUE NOTE
Project Manager		Drawn By MDM
Date 07.29.2020		Reviewed By WAC
Project ID		

Sheet Title	
ELECTRICAL ENLARGED POWER PLANS	
Sheet No.	