 


By Others	By CSCO	Item
X		City Water Connection
X		Valve House or Pit
	N/A	Connection to Plant Air
	N/A	Air Compressor
	N/A	Air Maintenance Device
X		Electric Alarm
X		Electric Wire
X		Hose Cabinet and Equipment
X		Painting
X		Sleeves
	N/A	Cutting Hole and Patch
	N/A	Trench and Backfill
X		Repeating
		Underground Piping

This drawing and the information hereon is the property of Crawford Sprinkler Company of Raleigh, and may not be reproduced, altered or used in any form without consent from Crawford Sprinkler Company of Raleigh.



THE HEALING PLACE OF NEW HANOVER COUNTY
SITE UTILITY PLAN
1000 MEDICAL CENTER DRIVE
WILMINGTON, NORTH CAROLINA

UNDERWRITERS:

INDEX NO.

REVISIONS:

DESIGN CRITERIA

SYSTEM TYPE	Wd
SYSTEM DESIGN	Calculated
DESIGN DENSITY	VARIES
MAX HEAD CVRG	VARIES
HOSE ALLOWANCE	VARIES


DRAWN BY: DJM	DATE: 8/25/2020
CHECK BY:	DATE:
SCALE: AS NOTED	

CONTRACT NO: J181258


FILE NO:

DWG. NO: FP 2 OF 12

Furthered 8/25/2020

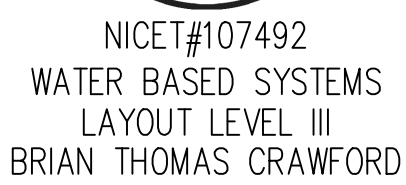

NICET#107492
WATER BASED SYSTEMS
LAYOUT LEVEL III
BRIAN THOMAS CRAWFORD

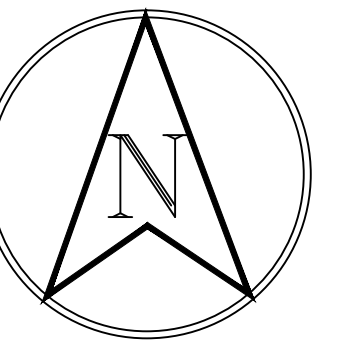

Important: In locations subject to freezing conditions, it is the owner's responsibility to provide adequate heat throughout wet pipe sprinkler system areas and enclosures for dry-pipe, deluge and other types of valves controlling water supplies to sprinkler systems

By Others	By CSCO	Item
X		City Water Connection
X		Valve House or Pit
N/A		Connection to Plant Air
N/A		Air Compressor
N/A		Air Maintenance Device
X		Electric Alarm
X		Electric Wire
X		Hose Cabinet and Equipment
X		Painting
X		Sleeves
X		Cutting Hole and Patch
N/A		Trench and Backfill
N/A		Repaving
X		Underground Piping

This drawing and the information hereon is the property of Crawford Sprinkler Company of Raleigh, and may not be reproduced, altered or used in any form without consent from Crawford Sprinkler Company of Raleigh.



2725 S. SAUNDERS STREET-RALEIGH, NC 27603 • PO BOX 28207-RALEIGH, NC 27611
PHONE 919-828-5346 • FAX 919-839-8164

THE HEALING PLACE OF NEW HANOVER COUNTY
ADMIN. BUILDING - PIPING PLAN
1000 MEDICAL CENTER DRIVE
WILMINGTON, NORTH CAROLINA

UNDERWRITERS:

INDEX NO.

REVISIONS:

DESIGN CRITERIA

SYSTEM TYPE	Wet
SYSTEM DESIGN	Calculated
DESIGN DENSITY	VARIABLE
MAX HEAD CVRG	VARIABLE
HOSE ALLOWANCE	VARIABLE

DRAWN BY: DJM
CHECK BY:
SCALE: AS NOTED

CONTRACT NO: JIB2028


FILE NO:

DWG. NO: FP 3 OF 12

NICET#107492
WATER BASED SYSTEMS
LAYOUT LEVEL III
BRIAN THOMAS CRAWFORD
N.C License No. 29772 FS-I




NICET#107492
WATER BASED SYSTEMS
LAYOUT LEVEL III
BRIAN THOMAS CRAWFORD

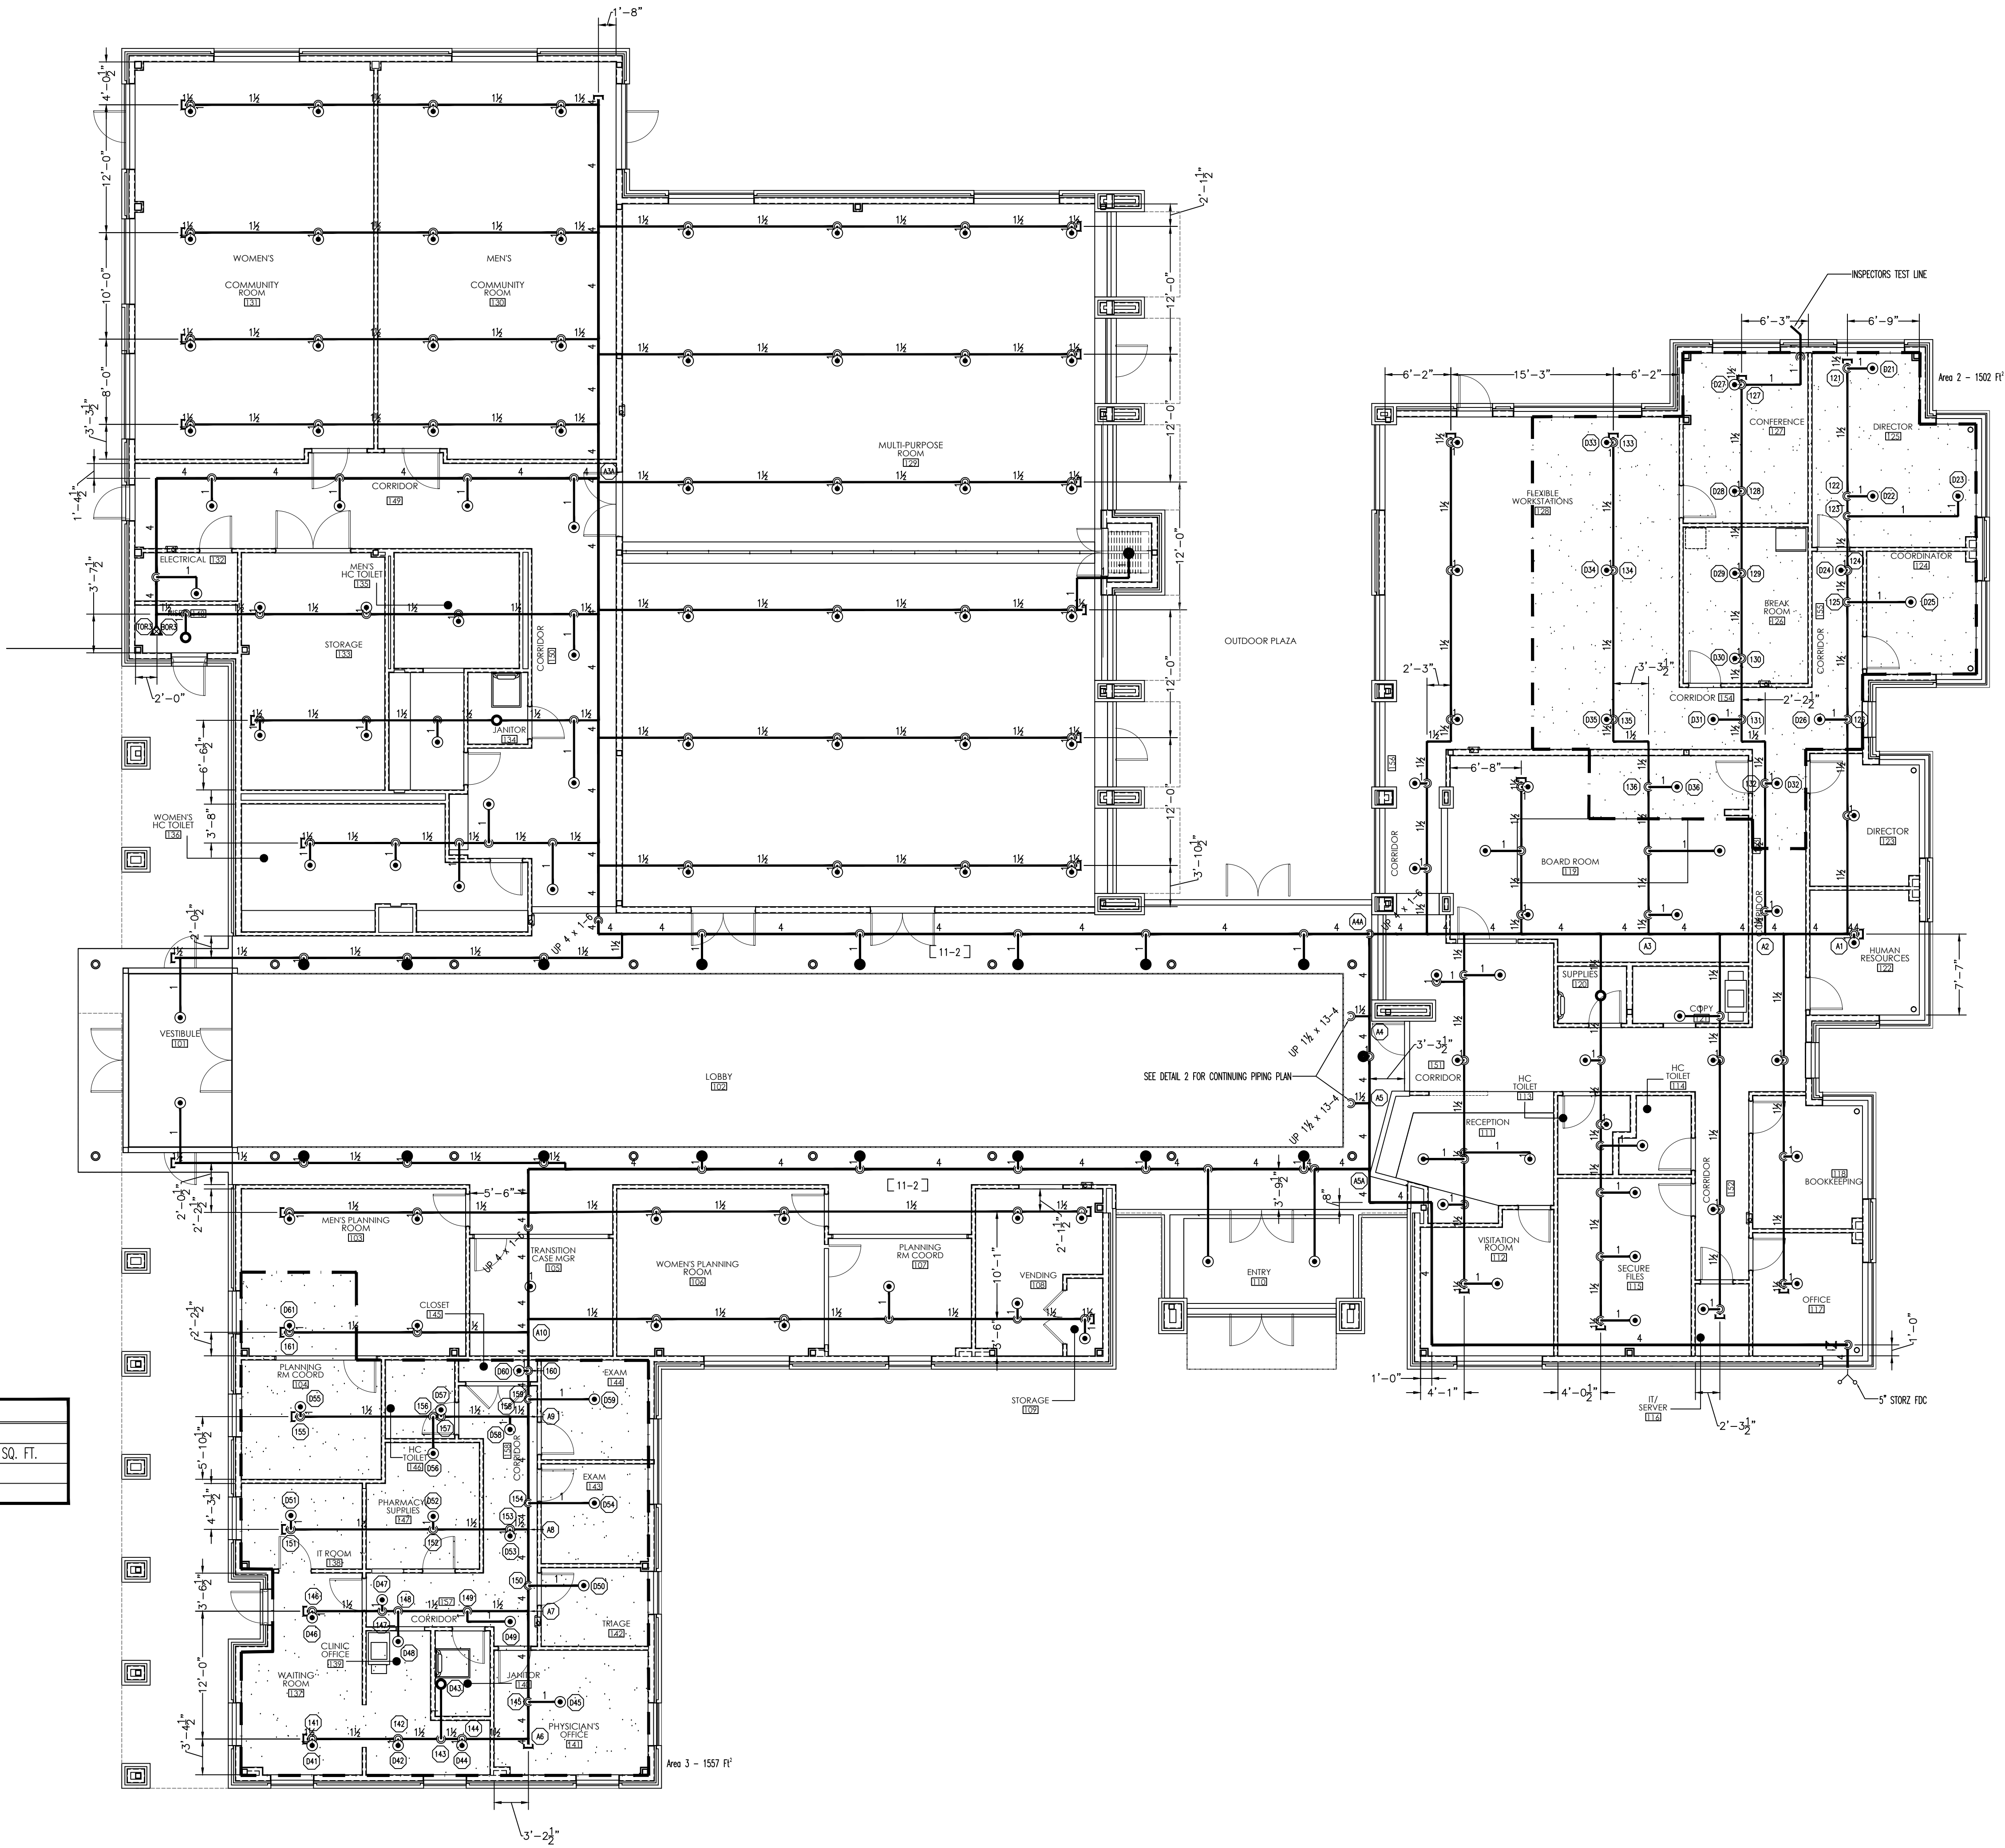

HYDRAULIC DESIGN CRITERIA		
AREA NUMBER: 2	CODE REF.: NFPA 13	HAZARD: LIGHT HAZARD
REMOTE AREA: 1500 SQFT	DENSITY: .10 GPM	AREA PER SPRINKLER: 225 SQ. FT.
SYSTEM TYPE: WET	INSIDE HOSE: 0	OUTSIDE HOSE: 100 GPM
TOTAL SYS. DEMAND: 408.191	PSI: 42.995	SAFETY MARGIN: 21.287

HYDRAULIC DESIGN CRITERIA		
AREA NUMBER: 3	CODE REF.: NFPA 13	HAZARD: LIGHT HAZARD
REMOTE AREA: 1500 SQFT	DENSITY: .10 GPM	AREA PER SPRINKLER: 225 SQ. FT.
SYSTEM TYPE: WET	INSIDE HOSE: 0	OUTSIDE HOSE: 100 GPM
TOTAL SYS. DEMAND: 548.240	PSI: 53.131	SAFETY MARGIN: 10.629

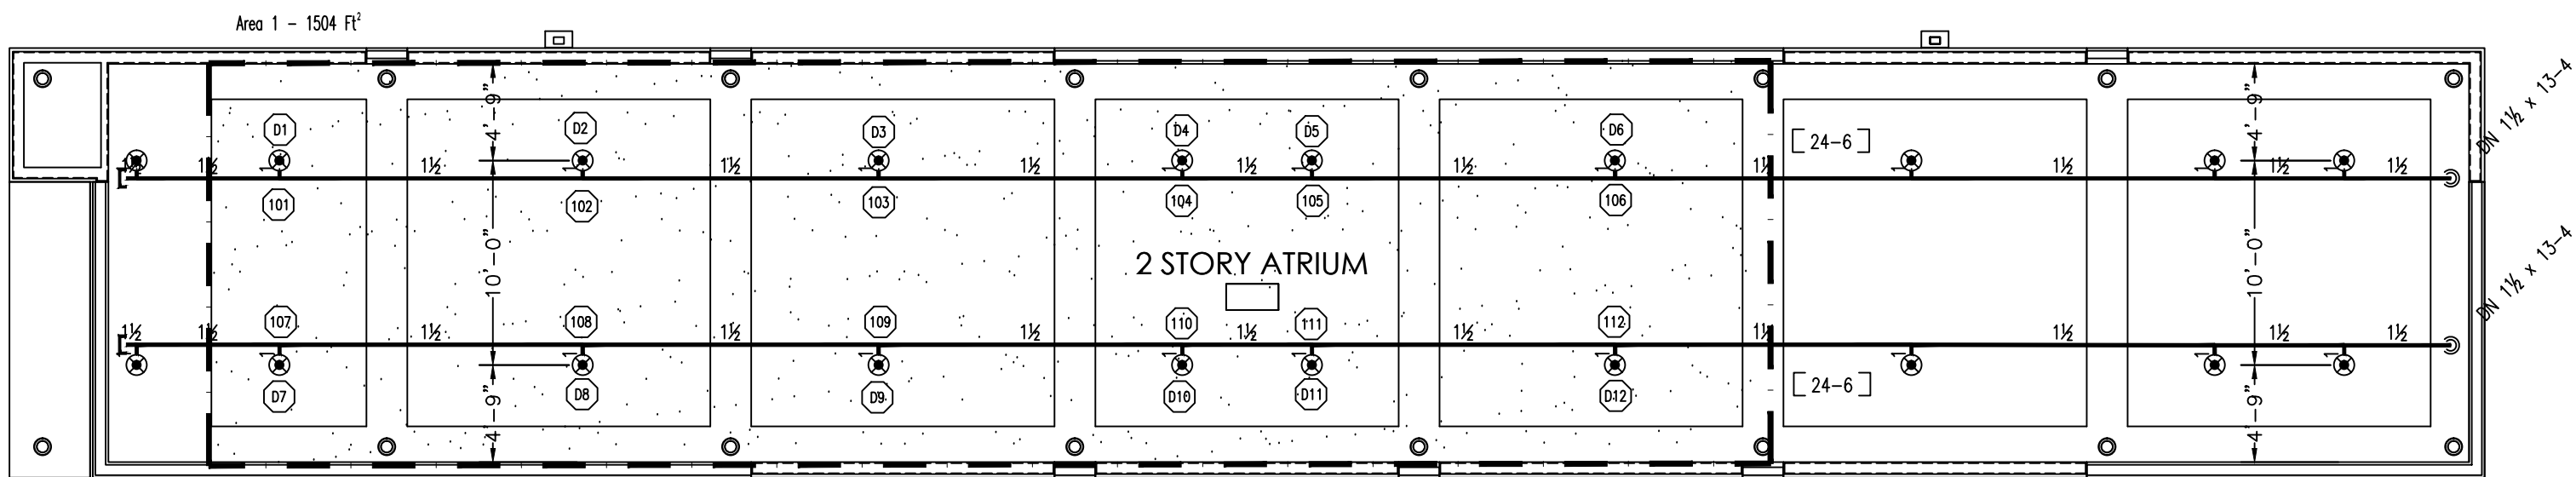

HYDRAULIC DESIGN CRITERIA		
AREA NUMBER: 1	CODE REF.: NFPA 13	HAZARD: LIGHT HAZARD
REMOTE AREA: 1500 SQFT	DENSITY: .10 GPM	AREA PER SPRINKLER: 225 SQ. FT.
SYSTEM TYPE: WET	INSIDE HOSE: 0	OUTSIDE HOSE: 100 GPM
TOTAL SYS. DEMAND: 292.855	PSI: 50.022	SAFETY MARGIN: 14.589

2 ADMIN. BUILDING - ATRIUM PIPING
1/8" = 1'-0"


1 ADMIN. BUILDING - PIPING PLAN
1/8" = 1'-0"

HEAD LEGEND

SYM	QTY	NAME	MATERIAL	NEW	K	NPT	ORF	WGL	MODEL#	APPROX	MIN SPACING	MAX SPACING	RESPONSE	ESQUIT	SNL
8	NEW DRY PENDENTS	METAL	200	5.60	1/2"	1/2	VIKING	M	UL/FM/ULC/NEA	6'-0"	15'-0"	15'-0"	QUICK RESPONSE	N/A	VK 178
23	NEW UPRIGHTS	BRASS	155	5.60	1/2"	1/2	VIKING	M	UL/FM/ULC/NEA	6'-0"	15'-0"	15'-0"	QUICK RESPONSE	N/A	VK 3001
58	NEW RESIDENTIAL PENDENTS	WHITE	155	5.8	1/2"	1/2	VIKING	VK472	UL/FM/ULC/NEA	8'-0"	18'X18'	15'-0"	QUICK RESPONSE	WHITE PLATE	VK 472
51	NEW CONCEALED PENDENTS	BRASS	155	5.60	1/2"	1/2	VIKING	M	UL/FM/ULC/NEA	6'-0"	15'-0"	15'-0"	QUICK RESPONSE	WHITE PLATE	VK 462
466	NEW PENDENTS	WHITE	155	5.60	1/2"	1/2	VIKING	M	UL/FM/ULC/NEA	6'-0"	15'-0"	15'-0"	QUICK RESPONSE	RECESSED	VK 3021
32	NEW PENDENTS	WHITE	200	5.60	1/2"	1/2	VIKING	M	UL/FM/ULC/NEA	6'-0"	15'-0"	15'-0"	QUICK RESPONSE	RECESSED	VK 3021
TOTAL		638													

NOTE

1. ALL PIPE ELEVATIONS ARE 9'-8" AFF UNLESS OTHERWISE SPECIFIED.

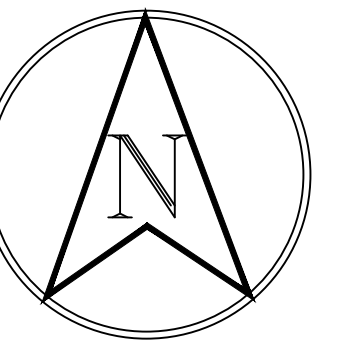

Important: In locations subject to freezing conditions, it is the owner's responsibility to provide adequate heat throughout wet pipe sprinkler system areas and enclosures for dry-pipe, deluge and other types of valves controlling water supplies to sprinkler systems

By Others	By CSCO	Item
X		City Water Connection
X		Valve House or Pit
N/A		Connection to Plant Air
N/A		Air Compressor
N/A		Air Maintenance Device
X		Electric Alarm
X		Electric Wire
X		Hose Cabinet and Equipment
X		Painting
X		Sleeves
X		Cutting Hole and Patch
N/A		Trench and Backfill
N/A		Repaving
X		Underground Piping

This drawing and the information hereon is the property of Crawford Sprinkler Company of Raleigh, and may not be reproduced, altered or used in any form without consent from Crawford Sprinkler Company of Raleigh.



2725 S. SAUNDERS STREET-RALEIGH, NC 27603 • PO. BOX 26207-RALEIGH, NC 27611
PHONE 919-828-5346 • FAX 919-839-8164

THE HEALING PLACE OF NEW HANOVER COUNTY
ADMIN. BUILDING - RCP
100 MEDICAL CENTER DRIVE
WILMINGTON, NORTH CAROLINA

UNDERWRITERS:

INDEX NO.

REVISIONS:

DESIGN CRITERIA

SYSTEM TYPE	Wet
SYSTEM DESIGN	Calculated
DESIGN DENSITY	VARIES
MAX HEAD CVRG	VARIES
HOSE ALLOWANCE	VARIES


DRAWN BY: DJM
CHECK BY:
SCALE: AS NOTED

DATE: 8/20/2020
DATE:
CONTRACT NO: JIB208
FILE NO:


DWG. NO: FP 4 OF 12
N.C. License No. 29772 FS-I



NICET#107492
WATER BASED SYSTEMS
LAYOUT LEVEL III
BRIAN THOMAS CRAWFORD

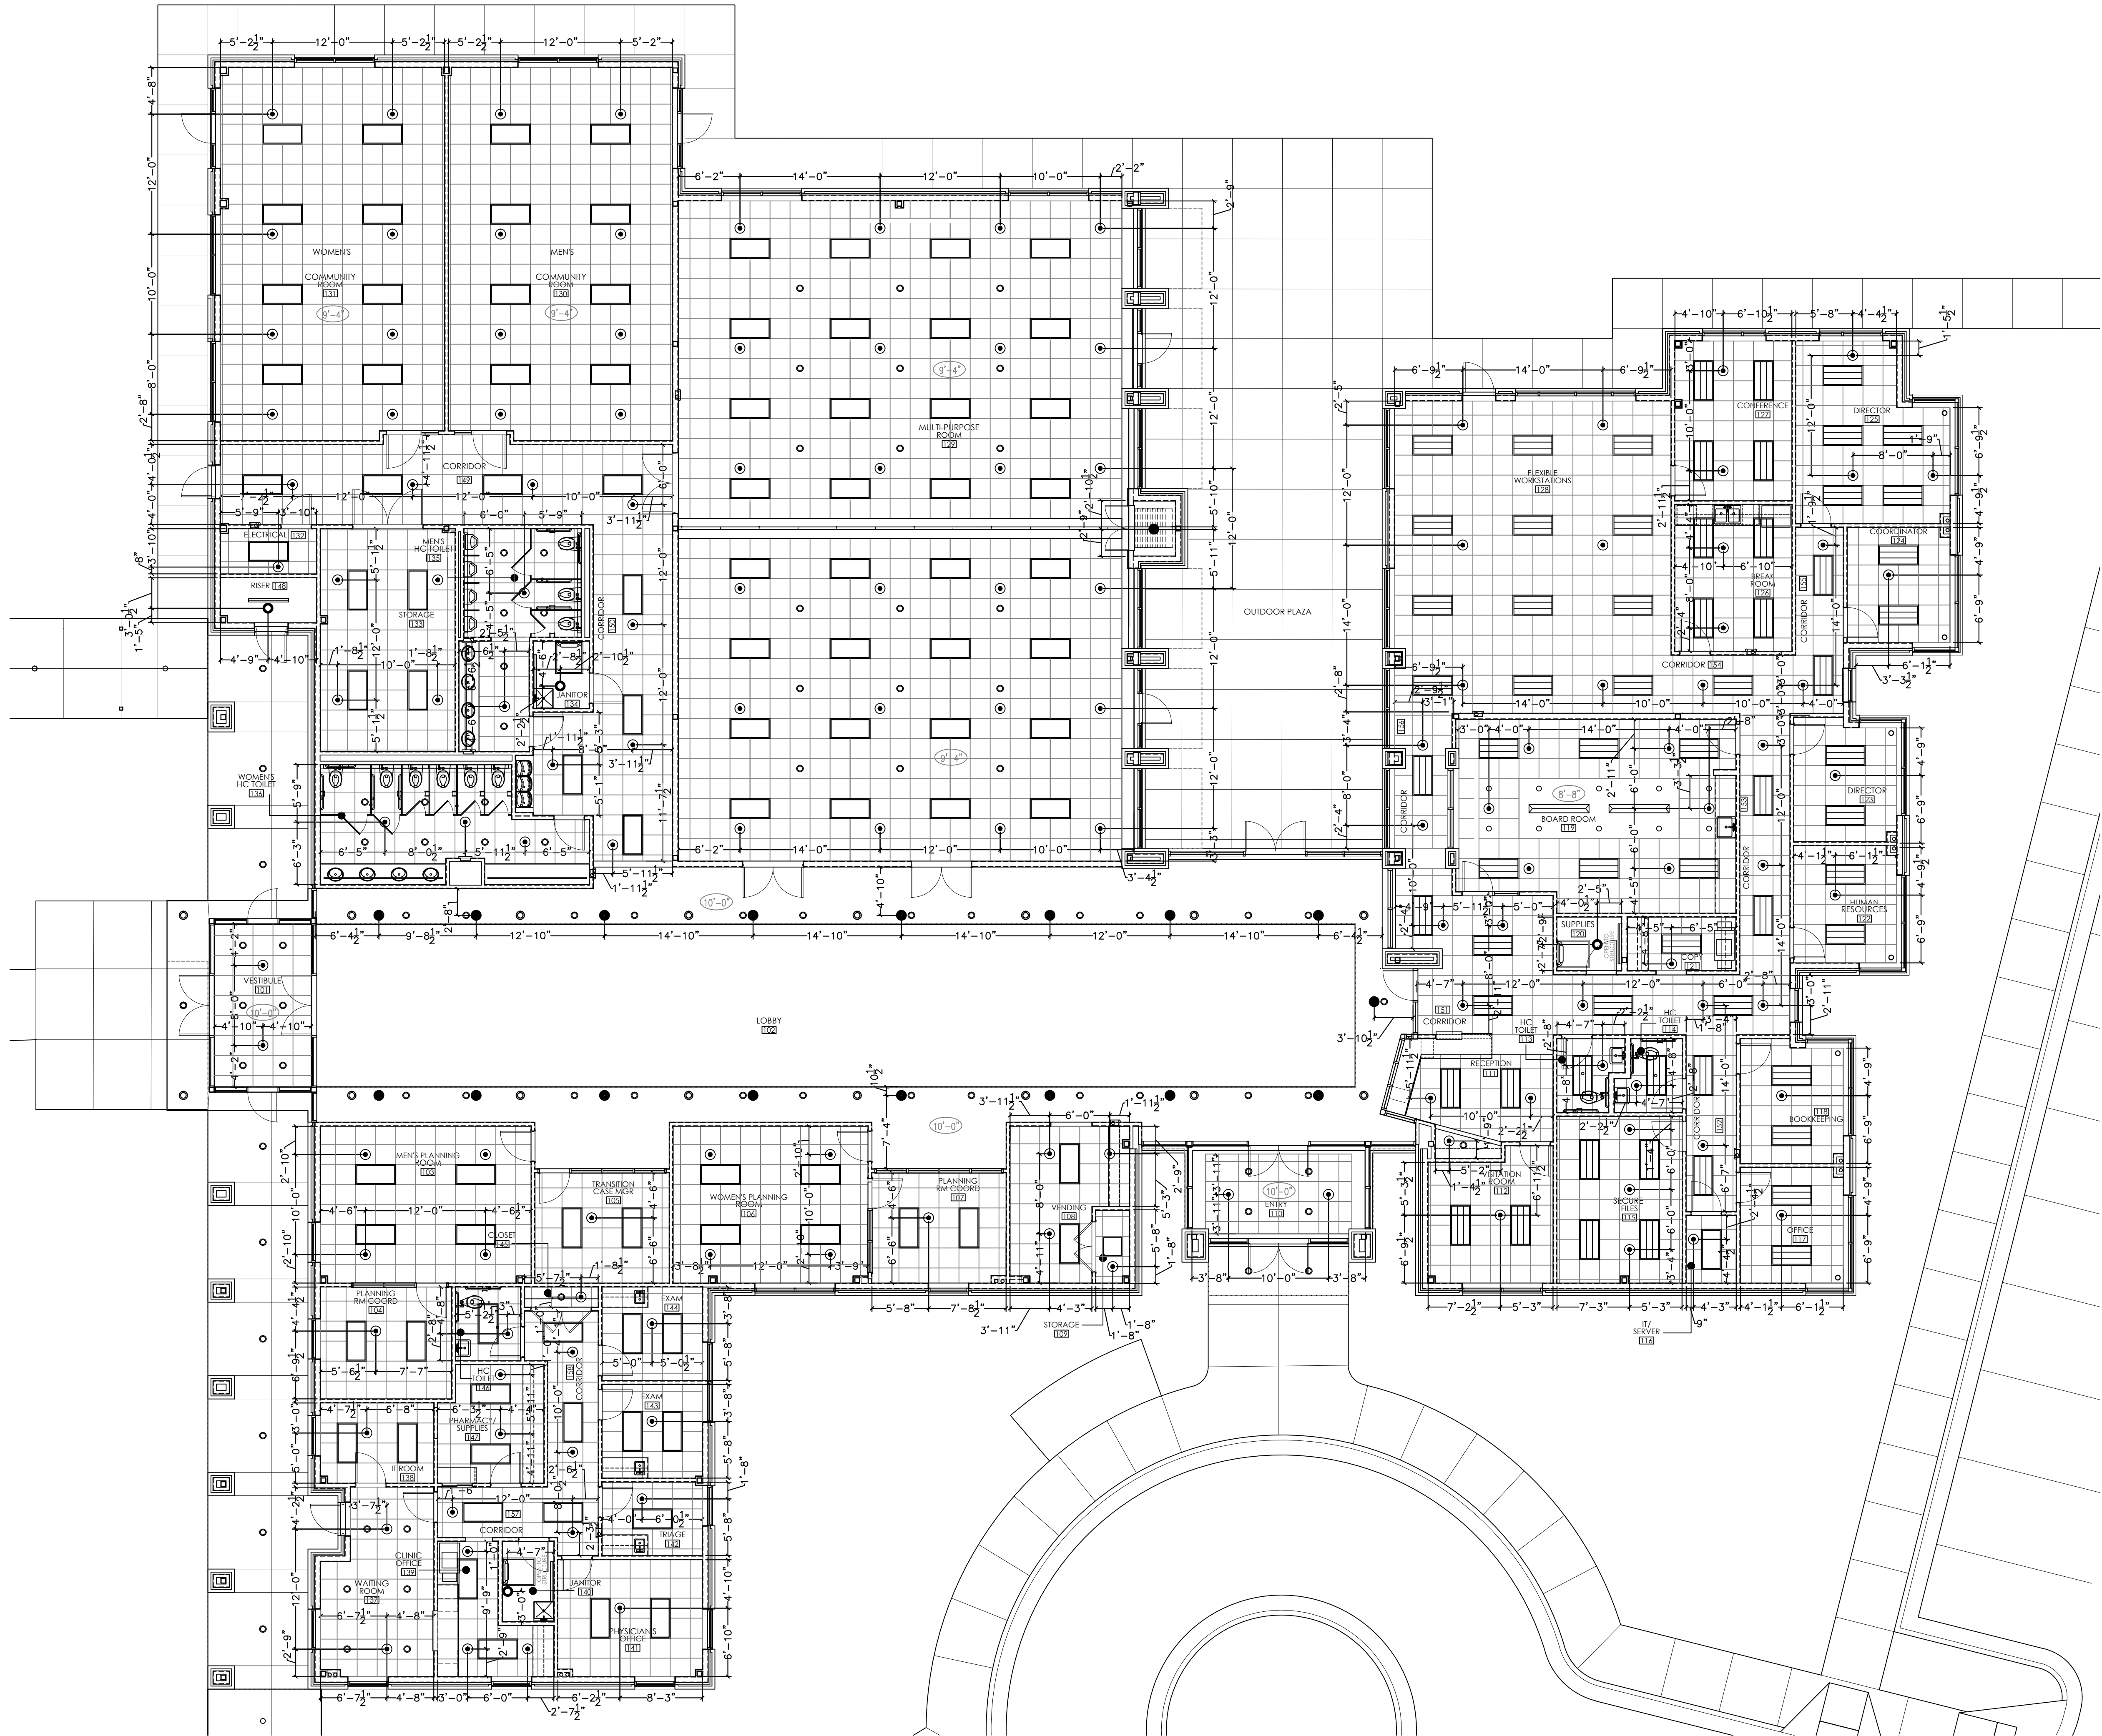

1 ADMIN. BUILDING - RCP
FP 4 1/8" = 1'-0"

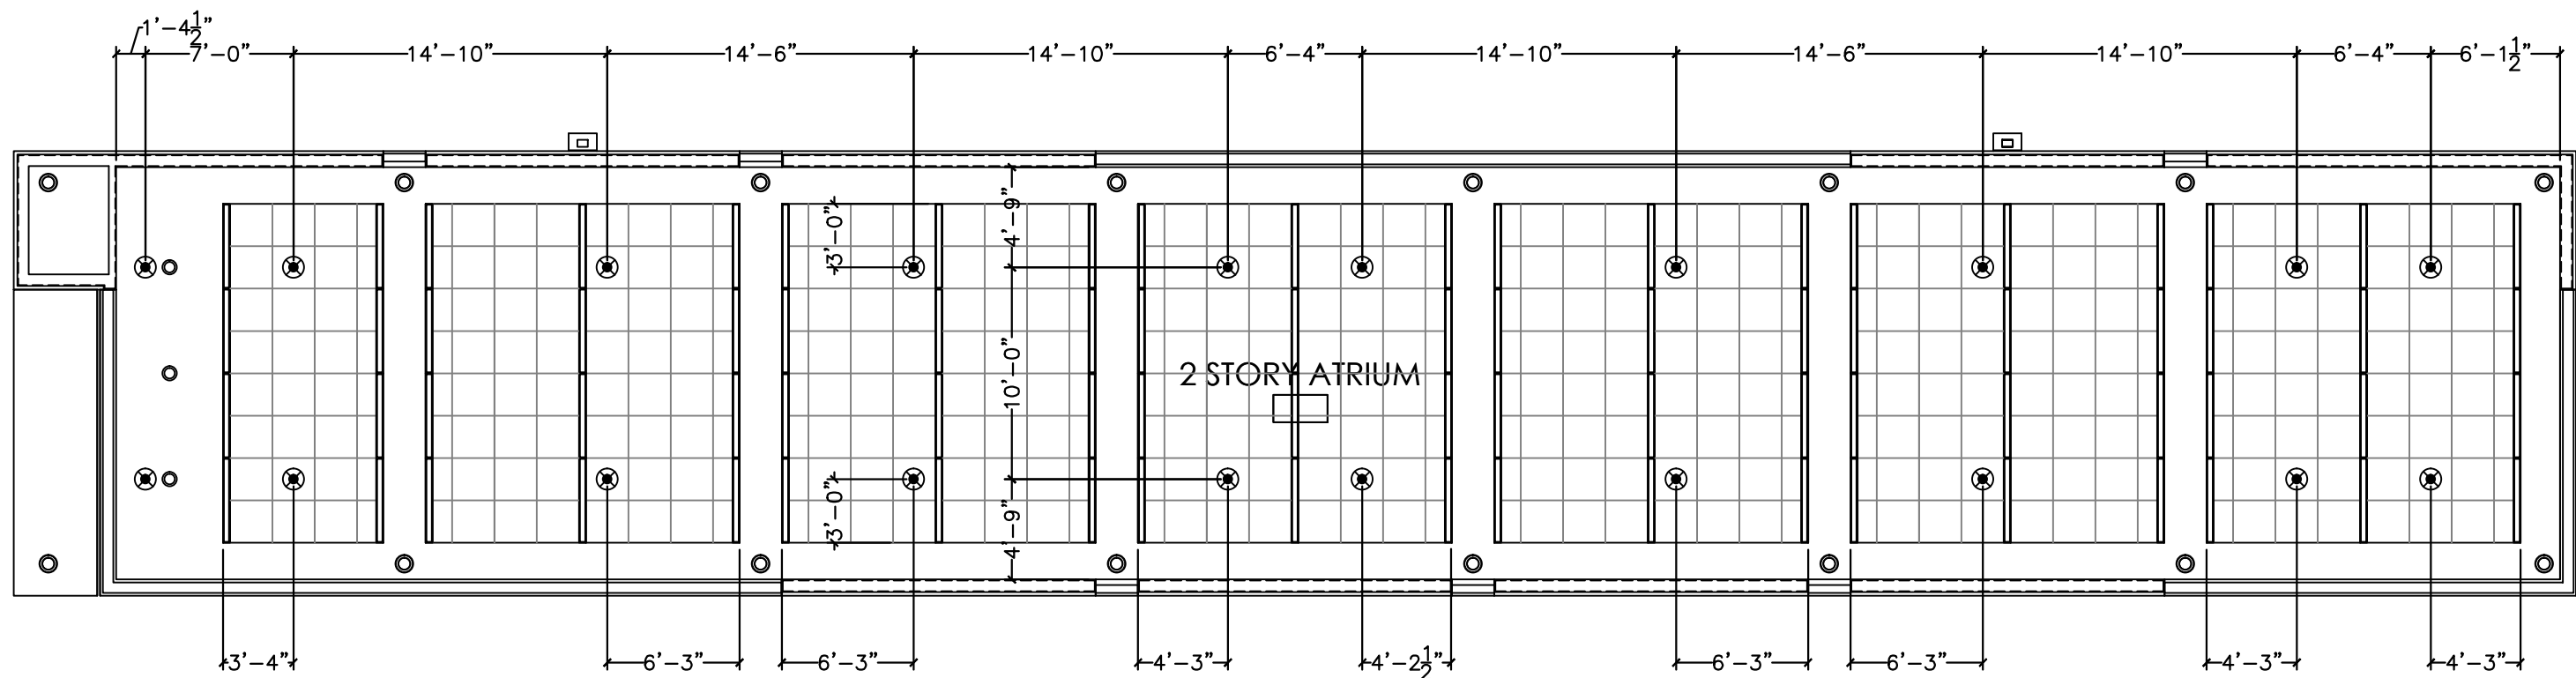


2 ADMIN. BUILDING - ATRIUM RCP
FP 4 1/8" = 1'-0"

HEAD LEGEND

SYM	CH	NAME	METAL	TEMP	T K	NPT	DRIF	INFS	MODEL	APPRAL	MIN SPACING	MAX SPACING	RESPONSE	ESCUIT	SIN
8		NEW DRY PENDENTS	CHROME	200	5.60	1/2"	1/2"	WIKING	M	UL/FM/ULC/NEA	6'-0"	15'-0"	QUICK RESPONSE	ADJ. STANDARD	WK 178
23		NEW UPRIGHTS	BRASS	155	5.60	1/2"	1/2"	WIKING	M	UL/FM/ULC/NEA	6'-0"	15'-0"	QUICK RESPONSE	N/A	WK 3001
59		NEW RESIDENTIAL PENDENTS	WHITE	155	5.8	1/2"	1/2"	WIKING	W472	UL/FM/ULC/NEA	6'-0"	18'X18'	QUICK RESPONSE	WHITE PLATE	WK 472
51		NEW CONCEALED PENDENTS	BRASS	155	5.60	1/2"	1/2"	WIKING	M	UL/FM/ULC/NEA	6'-0"	15'-0"	QUICK RESPONSE	WHITE PLATE	WK 465
466		NEW PENDENTS	WHITE	155	5.60	1/2"	1/2"	WIKING	M	UL/FM/ULC/NEA	6'-0"	15'-0"	QUICK RESPONSE	RECESSED	WK 3021
32		NEW PENDENTS	WHITE	200	5.60	1/2"	1/2"	WIKING	M	UL/FM/ULC/NEA	6'-0"	15'-0"	QUICK RESPONSE	RECESSED	WK 3021
TOTAL		638													

NOTE

1. ALL CEILING HEIGHTS ARE 9'-0" AFF UNLESS OTHERWISE SPECIFIED.

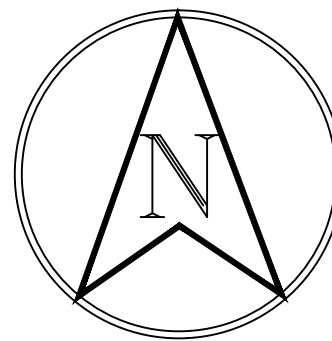

Important: In locations subject to freezing conditions, it is the owner's responsibility to provide adequate heat throughout wet pipe sprinkler system areas and enclosures for dry-pipe, deluge and other types of valves controlling water supplies to sprinkler systems

By Others	By CSCO	Item
X		City Water Connection
X		Valve House or Pit
N/A		Connection to Plant Air
N/A		Air Compressor
N/A		Air Maintenance Device
X		Electric Alarm
X		Electric Wire
X		Hose Cabinet and Equipment
X		Painting
X		Sleeves
X		Cutting Hole and Patch
N/A		Trench and Backfill
N/A		Re-paving
X		Underground Piping

This drawing and the information herein is the property of Crawford Sprinkler Company of Raleigh, and may not be reproduced, altered or used in any form without consent from Crawford Sprinkler Company of Raleigh.

Crawford
SPRINKLER CO.
OF RALEIGH, INC.
2725 S. SAUNDERS STREET - RALEIGH, NC 27603 • PO BOX 28207 - RALEIGH, NC 27611
PHONE 919-828-5346 • FAX 919-839-8164

THE HEALING PLACE OF NEW HANOVER COUNTY
DINING, SHELTER & STORAGE BUILDING - PIPING PLAN
1000 MEDICAL CENTER DRIVE
WILMINGTON, NORTH CAROLINA

UNDERWRITERS:

INDEX NO.

REVISIONS:

DESIGN CRITERIA

SYSTEM TYPE	Wet
SYSTEM DESIGN	Calculated
DESIGN DENSITY	VARIABLE
MAX HEAD CVRG	VARIABLE
HOSE ALLOWANCE	VARIABLE

DRAWN BY: DJM
CHECK BY:
SCALE: AS NOTED

CONTRACT NO: JIB1208

FILE NO:


DWG. NO: FP 5 OF 12



NICET#107492
WATER BASED SYSTEMS
LAYOUT LEVEL III
BRIAN THOMAS CRAWFORD

DATE: 8/20/2020
DATE: 8/20/2020
N.C. License No. 29772 FS-I

HYDRAULIC DESIGN CRITERIA		
AREA NUMBER: 1	CODE REF.: NFPA 13	HAZARD: ORDINARY HAZARD (GROUP 1)
REMOTE AREA: 1500 SQFT	DENSITY: 15 GPM	AREA PER SPRINKLER: 130 SQ. FT.
SYSTEM TYPE: WET	INSIDE HOSE: 0	OUTSIDE HOSE: 250 GPM
TOTAL SYS. DEMAND: 587.021	PSI: 37.043	SAFETY MARGIN: 26.550

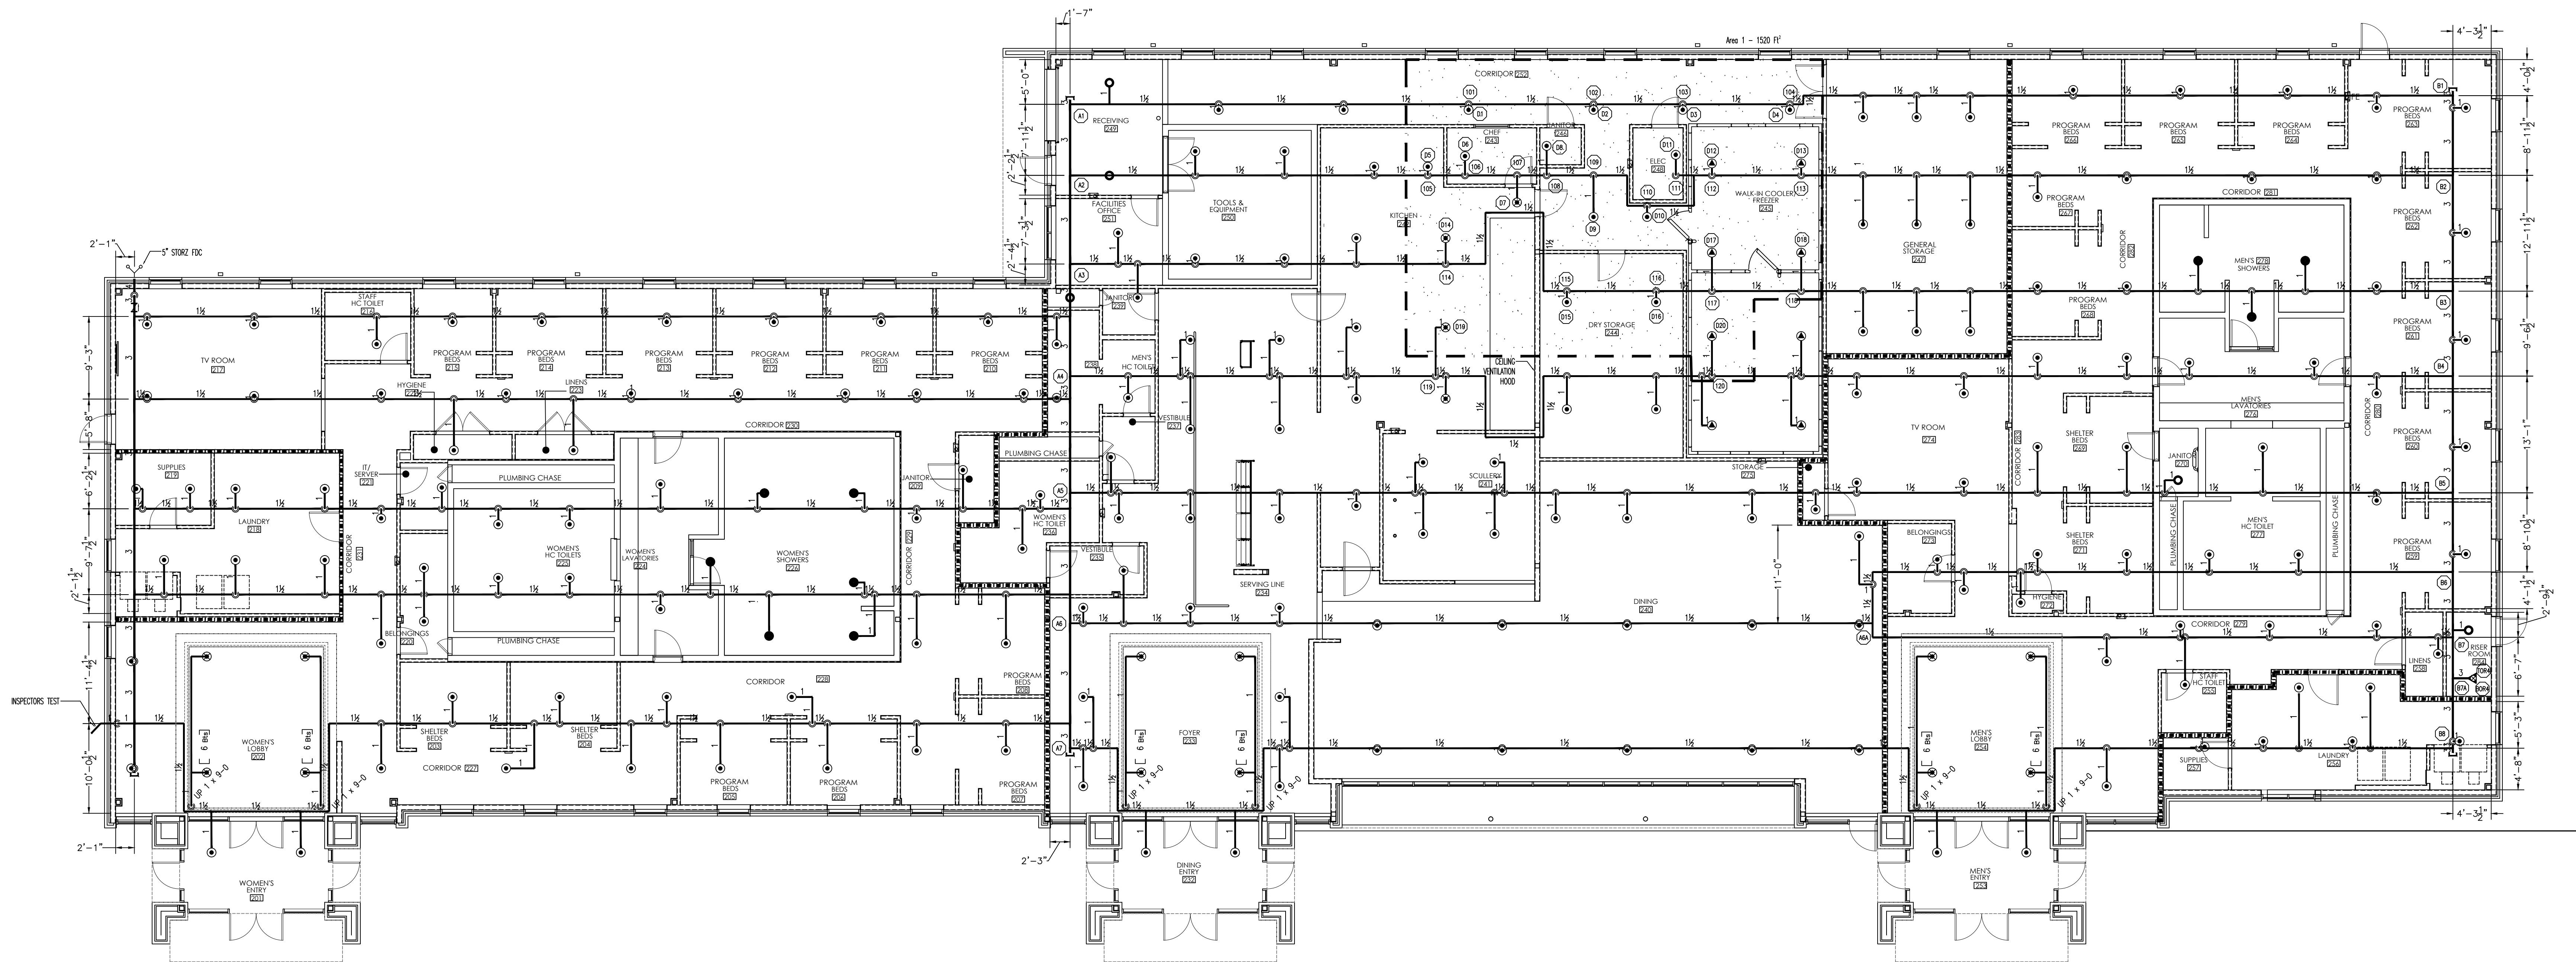


1 DINING, SHELTER & STORAGE BUILDING - PIPING PLAN
5 1/8" = 1'-0"

HEAD LEGEND

SYM	QTY	NAME	METAL	TEMP	K	NPT	ORF	MFG.	MODEL	APPROV.	MIN. SPACING	MAX. SPACING	RESPONSE	ESCUIT	SIN.
8	NEW DRY PENDENTS	CHROME	200	5.60	1/2"	1/2	Viking	M	UL/TM/ULC/MEA	6'-0"	15'-0"	15'-0"	QUICK RESPONSE	ADL. STANDARD	VK 178
23	NEW UPGRATS	BRASS	155	5.60	1/2"	1/2	Viking	M	UL/TM/ULC/MEA	6'-0"	15'-0"	15'-0"	QUICK RESPONSE	N/A	VK 3001
58	NEW RESIDENTIAL PENDENTS	WHITE	155	5.8	1/2"	1/2	Viking	M	UL/TM/ULC/MEA	6'-0"	15'-0"	15'-0"	QUICK RESPONSE	WHITE PLATE	VK 472
51	NEW CONCEALED PENDENTS	BRASS	155	5.60	1/2"	1/2	Viking	M	UL/TM/ULC/MEA	6'-0"	15'-0"	15'-0"	QUICK RESPONSE	WHITE PLATE	VK 462
466	NEW PENDENTS	WHITE	155	5.60	1/2"	1/2	Viking	M	UL/TM/ULC/MEA	6'-0"	15'-0"	15'-0"	QUICK RESPONSE	RECESSED	VK 3021
32	NEW PENDENTS	WHITE	200	5.60	1/2"	1/2	Viking	M	UL/TM/ULC/MEA	6'-0"	15'-0"	15'-0"	QUICK RESPONSE	RECESSED	VK 3021
TOTAL	638														

NOTE

1. ALL PIPE ELEVATIONS ARE 9'-8" AFF UNLESS OTHERWISE SPECIFIED.

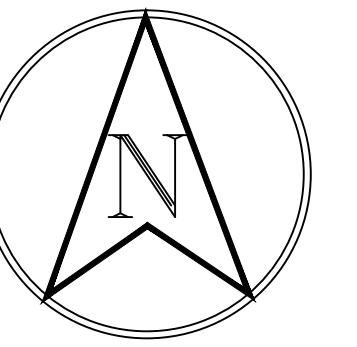

Important: In locations subject to freezing conditions, it is the owner's responsibility to provide adequate heat throughout wet pipe sprinkler system areas and enclosures for dry-pipe, deluge and other types of valves controlling water supplies to sprinkler systems

By Others	By CSCO	Item
X		City Water Connection
X		Valve House or Pit
N/A		Connection to Plant Air
N/A		Air Compressor
N/A		Air Maintenance Device
X		Electric Alarm
X		Electric Wire
X		Hose Cabinet and Equipment
X		Painting
X		Sleeves
X		Cutting Hole and Patch
N/A		Trench and Backfill
N/A		Repeating
X		Underground Piping

This drawing and the information hereon is the property of Crawford Sprinkler Company of Raleigh, and may not be reproduced, altered or used in any form without consent from Crawford Sprinkler Company of Raleigh.



2725 S. SAUNDERS STREET-RALEIGH, NC 27603 • PO BOX 28207-RALEIGH, NC 27611
PHONE 919-828-5346 • FAX 919-839-8164

THE HEALING PLACE OF NEW HANOVER COUNTY
DINING, SHELTER & STORAGE BUILDING - RCP
1000 MEDICAL CENTER DRIVE
WILMINGTON, NORTH CAROLINA

UNDERWRITERS:

INDEX NO.

REVISIONS:

DESIGN CRITERIA

SYSTEM TYPE	Wet
SYSTEM DESIGN	Calculated
DESIGN DENSITY	VARIES
MAX HEAD CVRG	VARIES
HOSE ALLOWANCE	VARIES

DRAWN BY: DJM
CHECK BY:
SCALE: AS NOTED

CONTRACT NO: JIB1208


FILE NO:

DWG. NO: FP 6 OF 12



NICET#107492
WATER BASED SYSTEMS
LAYOUT LEVEL III
BRIAN THOMAS CRAWFORD

N.C. License No. 29772 FS-I

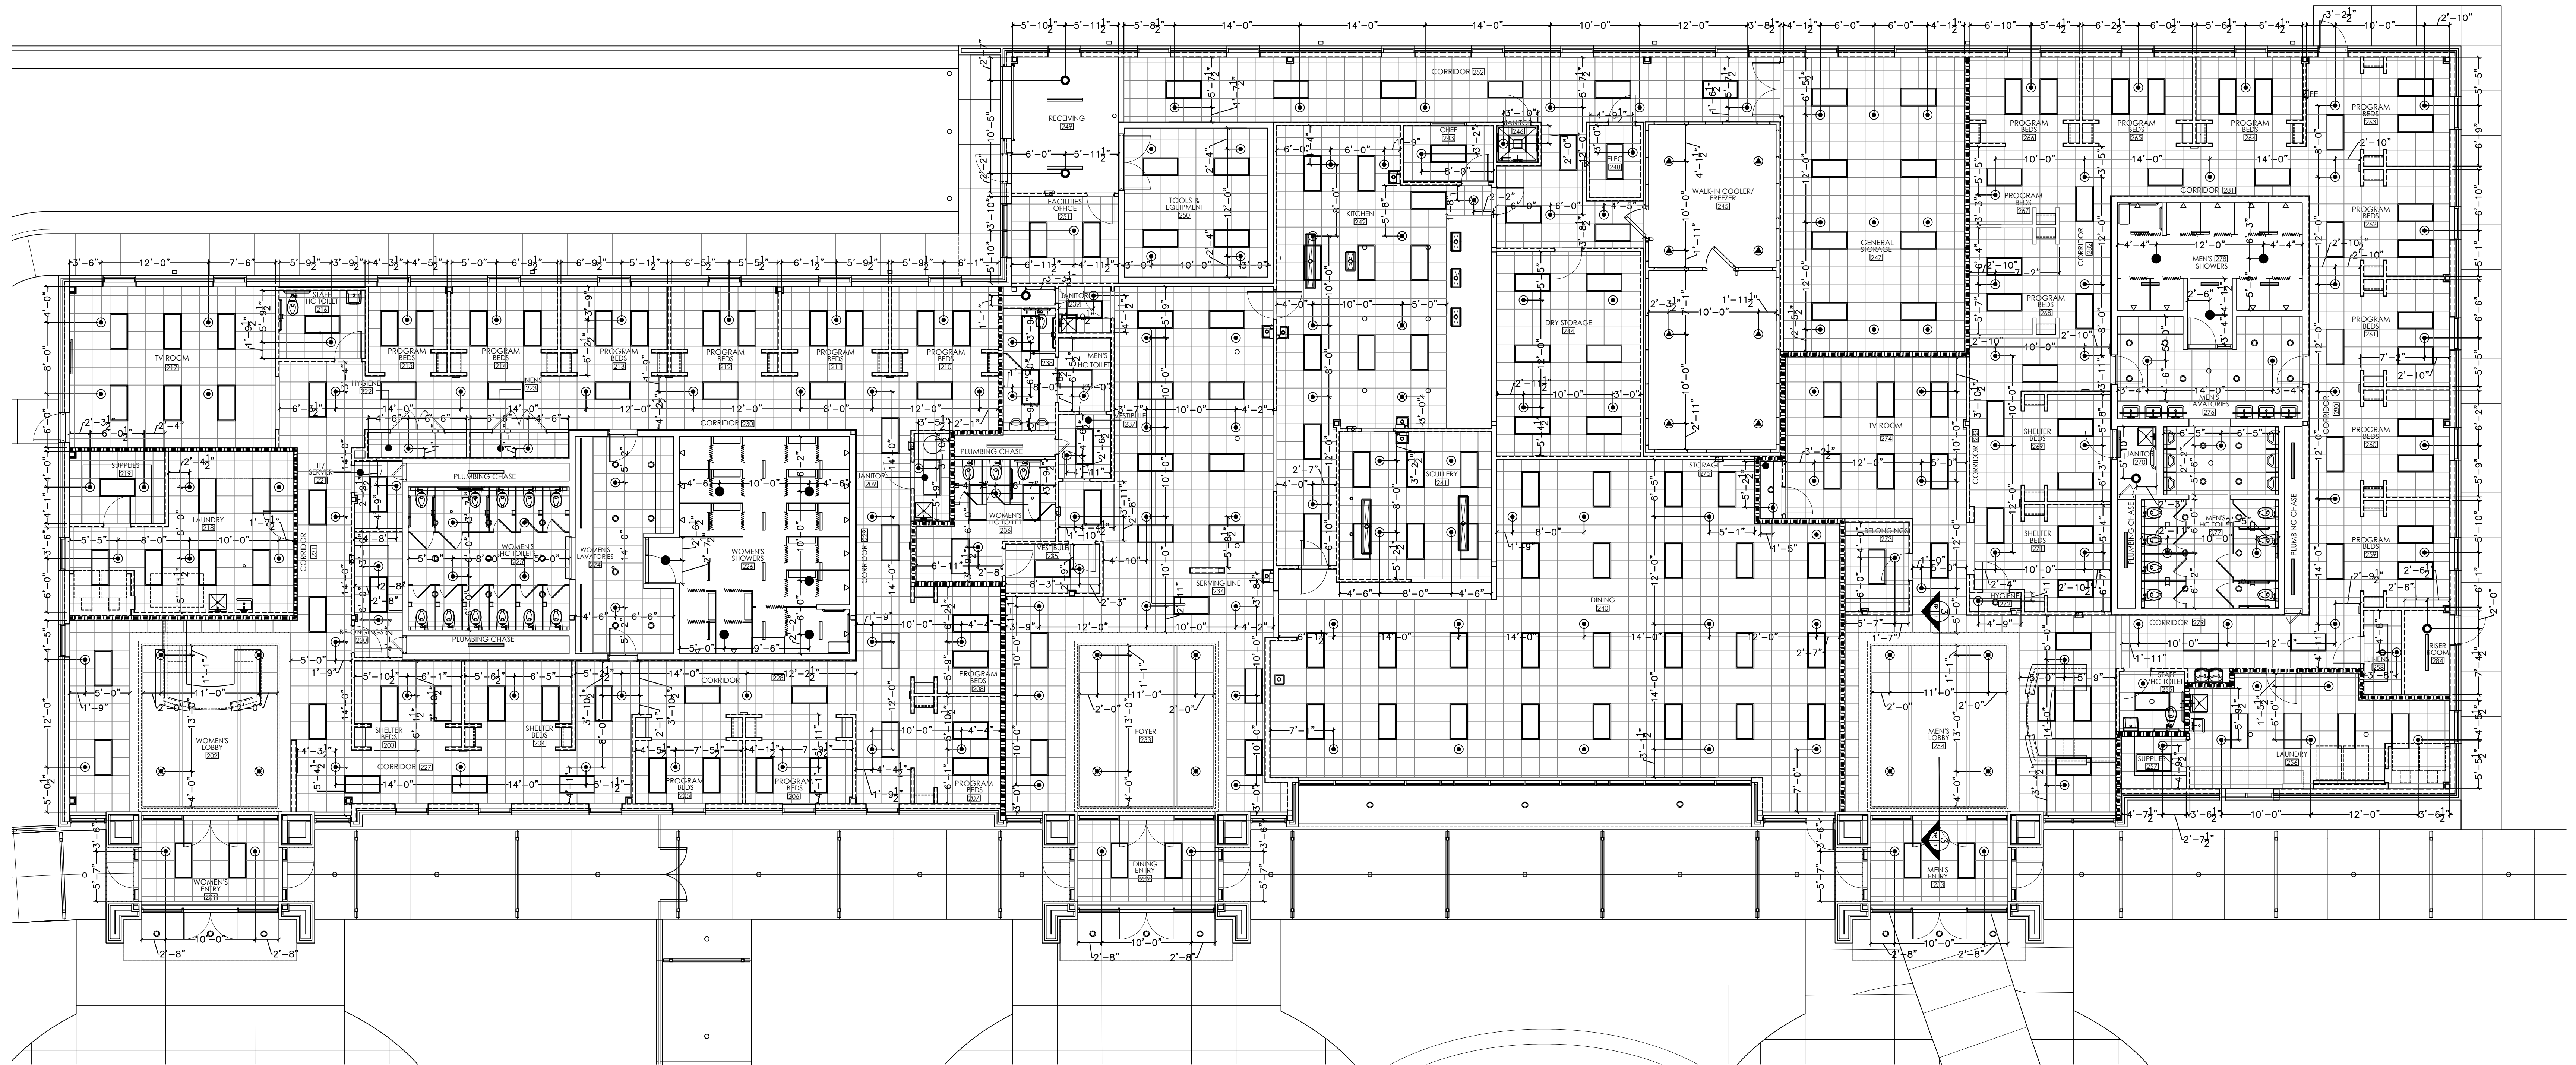


1 DINING, SHELTER & STORAGE BUILDING - RCP
FP 6 1/8" = 1'-0"

HEAD LEGEND

SYM.	QTY	NAME	METAL	TEMP	K	NPT	ORIF	MFG.	MODEL#	APPROV.	MIN SPACING	MAX SPACING	RESPONSE	ESCAP	SRL
●	8	NEW DRY PENDENTS	CHROME	200	5.60	1/2"	1/2	VIKING	M	UL/FM/ULC/NEA	6'-0"	15'-0"	QUICK RESPONSE	ADJ. STANDARD	VK 178
●	23	NEW UPRIGHTS	BRASS	155	5.60	1/2"	1/2	VIKING	M	UL/FM/ULC/NEA	6'-0"	15'-0"	QUICK RESPONSE	N/A	VK 3001
●	58	NEW RESIDENTIAL PENDENTS	WHITE	155	5.8	1/2"	1/2	VIKING	WK472	UL/FM/ULC/NEA	8'-0"	18'X18'	QUICK RESPONSE	WHITE PLATE	VK 472
●	51	NEW CONCEALED PENDENTS	BRASS	155	5.60	1/2"	1/2	VIKING	M	UL/FM/ULC/NEA	6'-0"	15'-0"	QUICK RESPONSE	WHITE PLATE	VK 462
●	466	NEW PENDENTS	WHITE	155	5.60	1/2"	1/2	VIKING	M	UL/FM/ULC/NEA	6'-0"	15'-0"	QUICK RESPONSE	RECESSED	VK 3021
●	32	NEW PENDENTS	WHITE	200	5.60	1/2"	1/2	VIKING	M	UL/FM/ULC/NEA	6'-0"	15'-0"	QUICK RESPONSE	RECESSED	VK 3021
TOTAL	638														

NOTE


1. ALL CEILING HEIGHTS ARE 9'-0" AFF UNLESS OTHERWISE SPECIFIED.

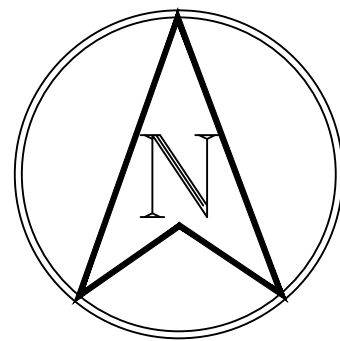

Important: In locations subject to freezing conditions, it is the owner's responsibility to provide adequate heat throughout wet pipe sprinkler system areas and enclosures for dry-pipe, deluge and other types of valves controlling water supplies to sprinkler systems

By Others	By CSCO	Item
X		City Water Connection
X		Valve House or Pit
N/A		Connection to Plant Air
N/A		Air Compressor
N/A		Air Maintenance Device
X		Electric Alarm
X		Electric Wire
X		Hose Cabinet and Equipment
X		Painting
X		Sleeves
X		Cutting Hole and Patch
N/A		Trench and Backfill
N/A		Repaving
X		Underground Piping

This drawing and the information hereon is the property of Crawford Sprinkler Company of Raleigh, and may not be reproduced, altered or used in any form without consent from Crawford Sprinkler Company of Raleigh.

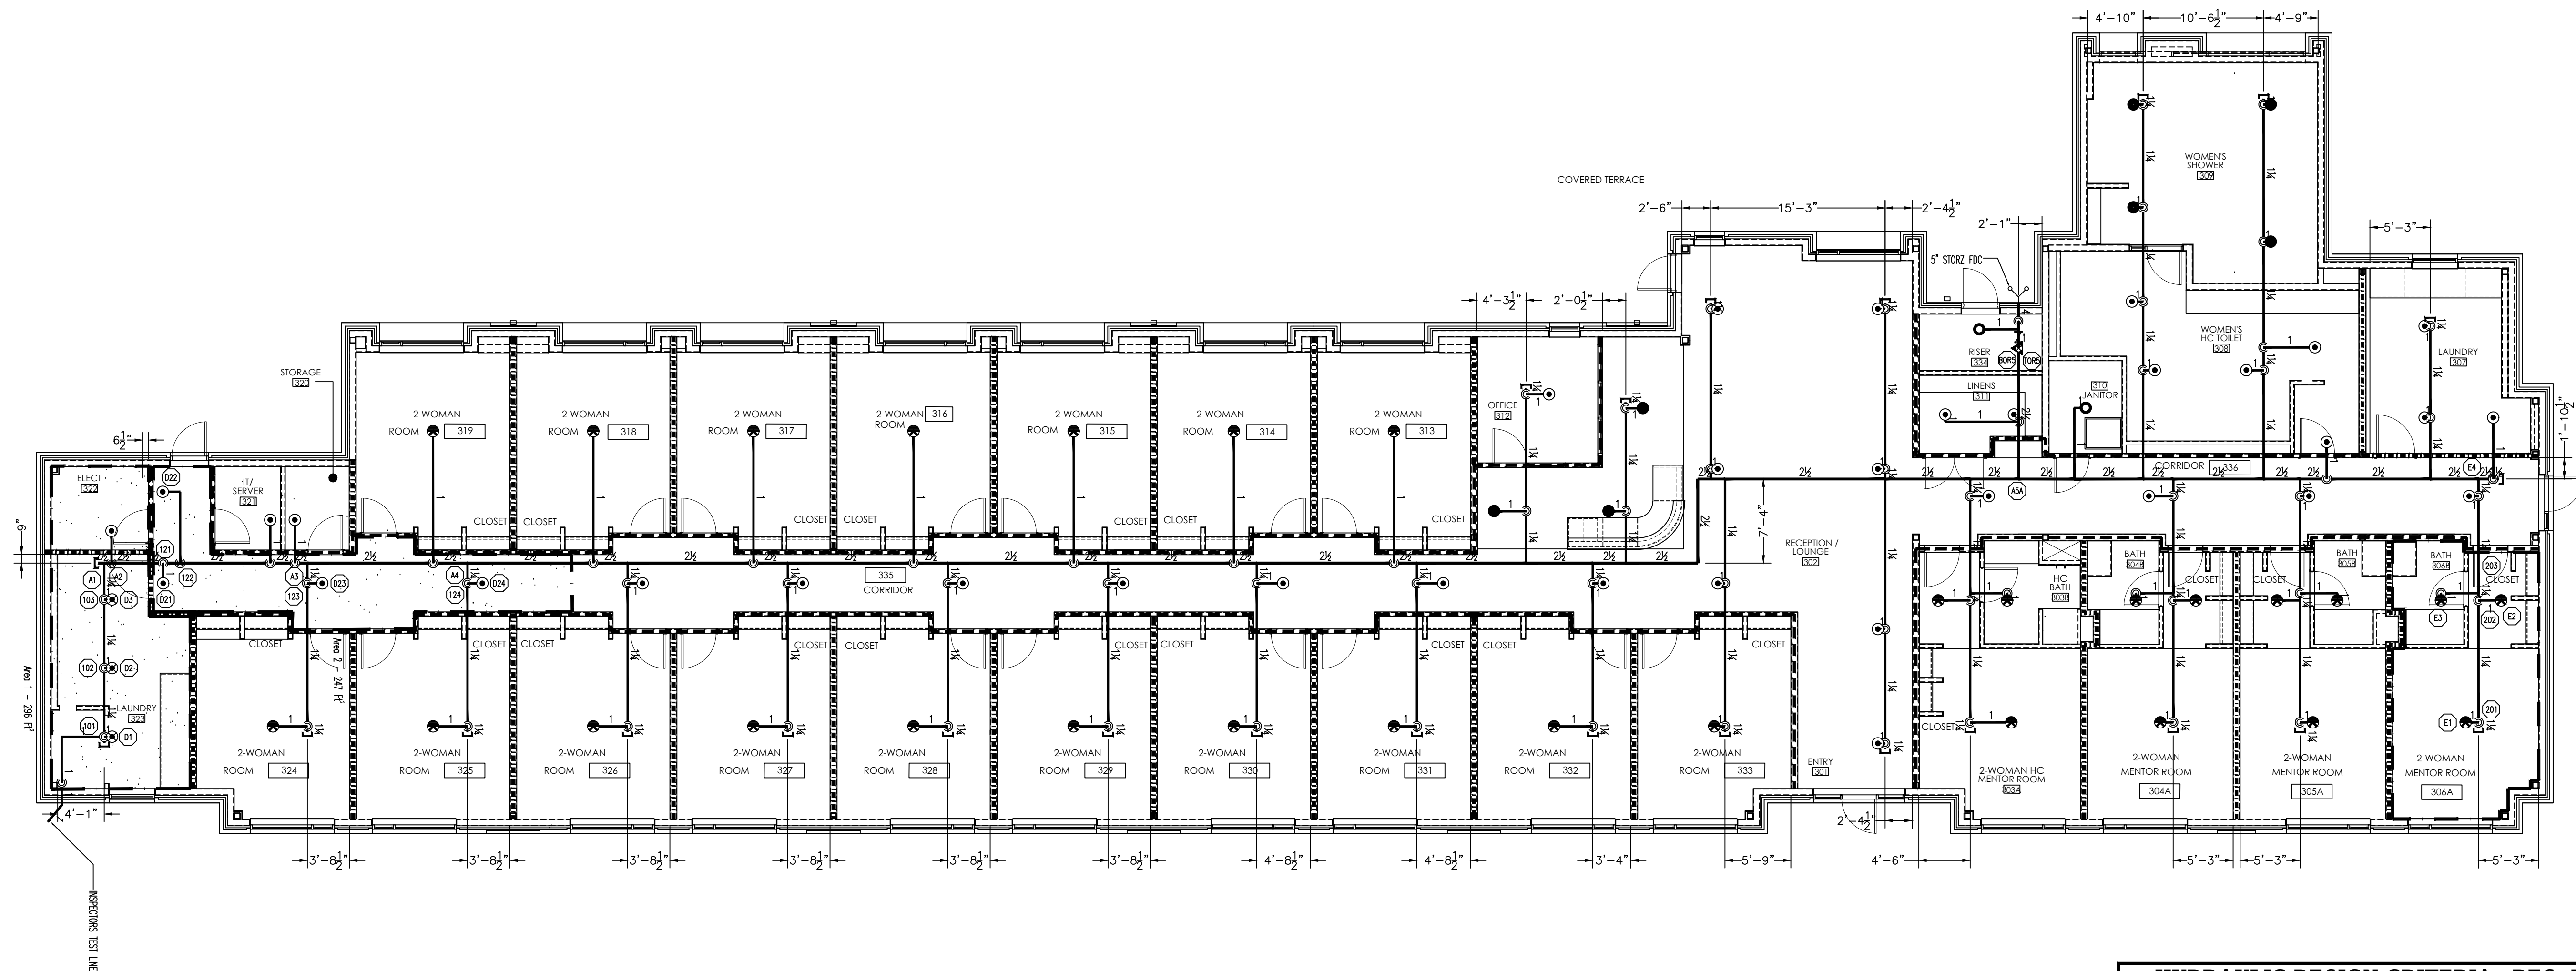

HYDRAULIC DESIGN CRITERIA - LAUNDRY			
AREA NUMBER: 1	CODE REF.: NFPA 13	HAZARD: ORDINARY HAZARD (GROUP 1)	
REMOTE AREA: 3-HEAD	DENSITY: .15 GPM	AREA PER SPRINKLER: 130 SQ. FT.	
SYSTEM TYPE: WET	INSIDE HOSE: 0	OUTSIDE HOSE: 250 GPM	
TOTAL SYS. DEMAND: 294.953	PSI: 21.584	SAFETY MARGIN: 43.022	

HYDRAULIC DESIGN CRITERIA - CORRIDOR			
AREA NUMBER: 2	CODE REF.: NFPA 13	HAZARD: LIGHT HAZARD	
REMOTE AREA: 4-HEAD CORR.	DENSITY: .10 GPM	AREA PER SPRINKLER: 225 SQ. FT.	
SYSTEM TYPE: WET	INSIDE HOSE: 0	OUTSIDE HOSE: 100 GPM	
TOTAL SYS. DEMAND: 190.925	PSI: 33.912	SAFETY MARGIN: 30.912	

1 WOMEN'S RESIDENTIAL BUILDING - PIPING PLAN
FP 7 1/8" = 1'-0"

HEAD LEGEND

SYM	QTY	NAME	MATL	TEMP	K	NPT	ORIF	MFG	MODEL#	APPROV	MIN SPACING	MAX SPACING	RESPONSE	ESCU	SRL
8	8	NEW DRY PENDENTS	CHROME	200	5.60	1/2"	1/2	WIKING	M	UL/FM/ULC/MEA	8'-0"	15'-0"	QUICK RESPONSE	ADJ. STANDARD	VK 178
23	23	NEW UPRIGHTS	BRASS	155	5.60	1/2"	1/2	WIKING	M	UL/FM/ULC/MEA	8'-0"	15'-0"	QUICK RESPONSE	N/A	VK 3001
58	58	NEW RESIDENTIAL PENDENTS	WHITE	155	5.8	1/2"	1/2	WIKING	WK472	UL/FM/ULC/MEA	8'-0"	18'x18'	QUICK RESPONSE	WHITE PLATE	VK 472
51	51	NEW CONCEALED PENDENTS	BRASS	155	5.60	1/2"	1/2	WIKING	M	UL/FM/ULC/MEA	8'-0"	15'-0"	QUICK RESPONSE	WHITE PLATE	VK 462
466	466	NEW PENDENTS	WHITE	155	5.60	1/2"	1/2	WIKING	M	UL/FM/ULC/MEA	8'-0"	15'-0"	QUICK RESPONSE	RECESSED	VK 3021
32	32	NEW PENDENTS	WHITE	200	5.60	1/2"	1/2	WIKING	M	UL/FM/ULC/MEA	8'-0"	15'-0"	QUICK RESPONSE	RECESSED	VK 3021
TOTAL	638														

HYDRAULIC DESIGN CRITERIA - RES. UNIT		
AREA NUMBER: 3	CODE REF.: NFPA 13	HAZARD: RESIDENTIAL
REMOTE AREA: 3 HEAD - UNIT	DENSITY: .05 GPM	AREA PER SPRINKLER: 324
SYSTEM TYPE: WET	INSIDE HOSE: 0	OUTSIDE HOSE: 100 GPM
TOTAL SYS. DEMAND: 151.487	PSI: 23.621	SAFETY MARGIN: 41.264

NOTE

1. ALL PIPE ELEVATIONS ARE 9'-8" AFF UNLESS OTHERWISE SPECIFIED.



Crawford
SPRINKLER CO.
OF RALEIGH, NC
2725 S. SAUNDERS STREET-RALEIGH, NC 27603 • PO BOX 28207-RALEIGH, NC 27611
PHONE 919-828-5346 • FAX 919-839-8164

THE HEALING PLACE OF NEW HANOVER COUNTY
WOMEN'S RESIDENTIAL BUILDING - PIPING PLAN
1000 MEDICAL CENTER DRIVE
WILMINGTON, NORTH CAROLINA

UNDERWRITERS:

INDEX NO.

REVISIONS:

DESIGN CRITERIA

SYSTEM TYPE	Wet
SYSTEM DESIGN	Calculated
DESIGN DENSITY	VARIABLE
MAX HEAD CVRG	VARIABLE
HOSE ALLOWANCE	VARIABLE

DRAWN BY: DJM	DATE: 8/20/2020
CHECK BY:	DATE:
SCALE: AS NOTED	

CONTRACT NO.: J181208


FILE NO.:

DWG. NO.: FP 7 OF 12



NICET#107492
WATER BASED SYSTEMS
LAYOUT LEVEL III
BRIAN THOMAS CRAWFORD


N.C. License No. 29772 FS-I

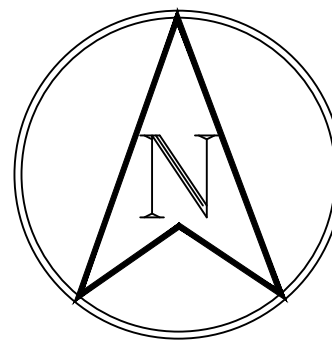

Important: In locations subject to freezing conditions, it is the owner's responsibility to provide adequate heat throughout wet pipe sprinkler system areas and enclosures for dry-pipe, deluge and other types of valves controlling water supplies to sprinkler systems

By Others	By CSCO	Item
X		City Water Connection
X		Valve House or Pit
	N/A	Connection to Plant Air
	N/A	Air Compressor
	N/A	Air Maintenance Device
X		Electric Alarm
X		Electric Wire
X		Hose Cabinet and Equipment
X		Painting
X		Sieves
X		Cutting Hole and Patch
N/A		Trench and Backfill
	N/A	Repaving
X		Underground Piping

This drawing and the information herein is the property of Crawford Sprinkler Company of Raleigh, and may not be reproduced, altered or used in any form without consent from Crawford Sprinkler Company of Raleigh.

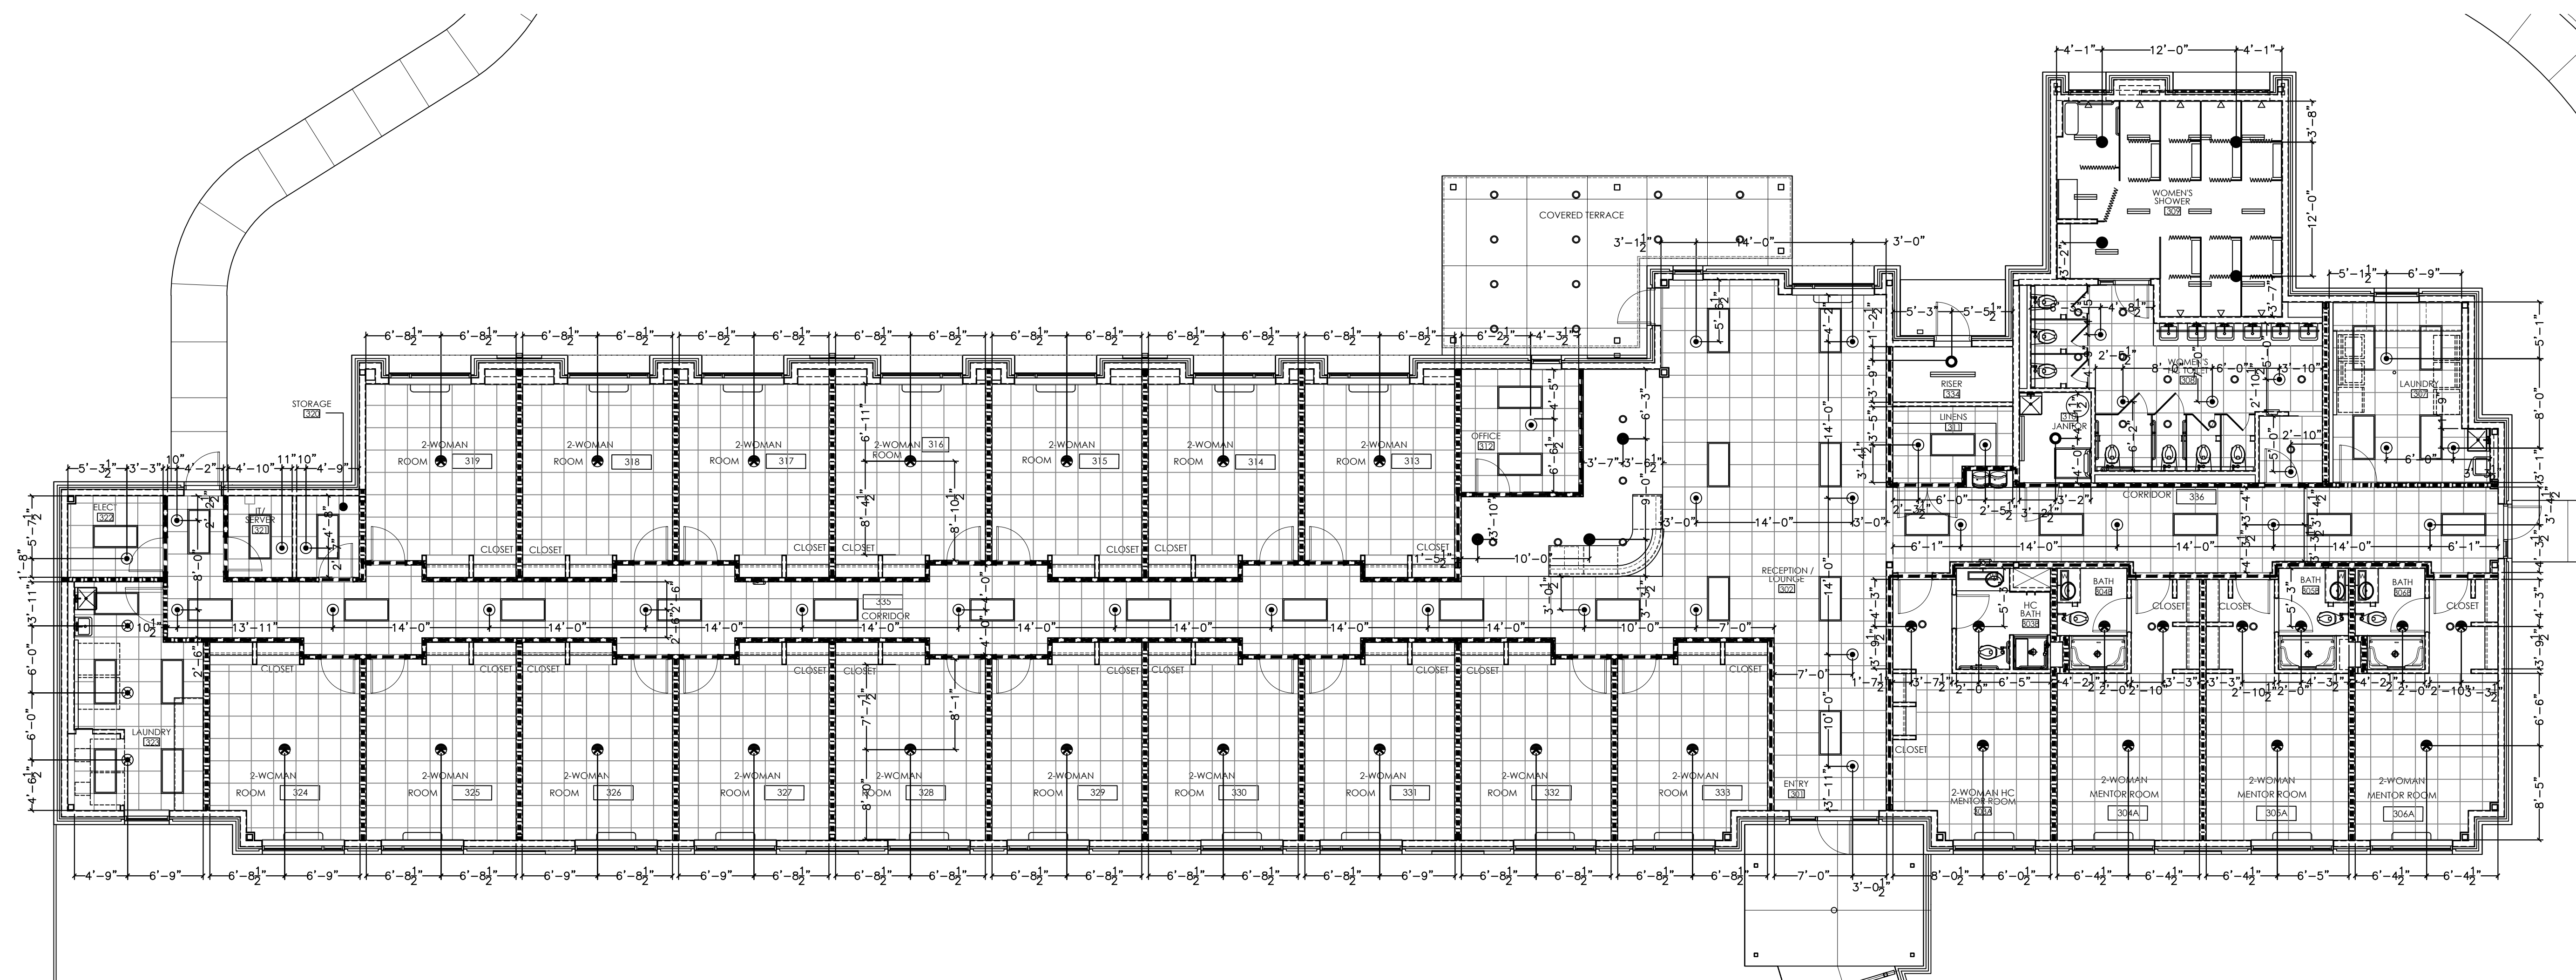

1 WOMEN'S RESIDENTIAL BUILDING - RCP
1/8" = 1'-0"

HEAD LEGEND

SYM	CON	NAME	METAL	TEMP	K	NPT	DRIP	MFG	MODEL	APPROV	MIN SPACING	MAX SPACING	RESPONSE	ESCUIT	SIN
▲	8	NEW DRY PENDENTS	CHROME	200	5.60	1/2"	1/2"	Viking	M	UL/FM/ULC/MEA	6'-0"	15'-0"	QUICK RESPONSE	AUL STANDARD	WK 178
●	23	NEW UPRIGHTS	BRASS	155	5.60	1/2"	1/2"	Viking	M	UL/FM/ULC/MEA	6'-0"	15'-0"	QUICK RESPONSE	N/A	WK 301
●	58	NEW RESIDENTIAL PENDENTS	WHITE	155	5.8	1/2"	1/2"	Viking	WK472	UL/FM/ULC/MEA	6'-0"	18'x18'	QUICK RESPONSE	WHITE PLATE	WK 472
●	51	NEW CONCEALED PENDENTS	BRASS	155	5.60	1/2"	1/2"	Viking	M	UL/FM/ULC/MEA	6'-0"	15'-0"	QUICK RESPONSE	WHITE PLATE	WK 462
●	466	NEW PENDENTS	WHITE	155	5.60	1/2"	1/2"	Viking	M	UL/FM/ULC/MEA	6'-0"	15'-0"	QUICK RESPONSE	RECESSED	WK 3021
●	32	NEW PENDENTS	WHITE	200	5.60	1/2"	1/2"	Viking	M	UL/FM/ULC/MEA	6'-0"	15'-0"	QUICK RESPONSE	RECESSED	WK 3021
TOTAL		638													

NOTE

- ALL CEILING HEIGHTS ARE 9'-0" AFF UNLESS OTHERWISE SPECIFIED.



2725 S. SAUNDERS STREET-RALEIGH, NC 27603 • PO. BOX 28207-RALEIGH, NC 27611
PHONE 919-828-5346 • FAX 919-839-8164

THE HEALING PLACE OF NEW HANOVER COUNTY
WOMEN'S RESIDENTIAL BUILDING - RCP
1000 MEDICAL CENTER DRIVE
WILMINGTON, NORTH CAROLINA

UNDERWRITERS:

INDEX NO.

REVISIONS:

DESIGN CRITERIA

SYSTEM TYPE	Wd
SYSTEM DESIGN	Calculated
DESIGN DENSITY	VARIES
MAX HEAD CVRG	VARIES
HOSE ALLOWANCE	VARIES

DRAWN BY: DJM
CHECK BY: DATE: 8/25/2020
SCALE: AS NOTED

CONTRACT NO: J181208


FILE NO:

DWG. NO: FP 8 OF 12



NICET#107492
WATER BASED SYSTEMS
LAYOUT LEVEL III
BRIAN THOMAS CRAWFORD


0/25/2020
N.C License No. 29772 FS-I

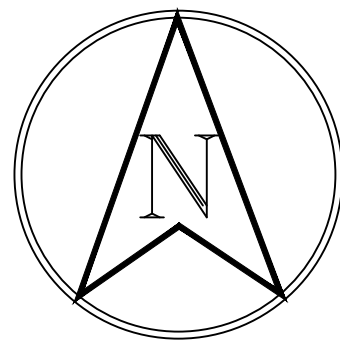

Important: In locations subject to freezing conditions, it is the owner's responsibility to provide adequate heat throughout wet pipe sprinkler system areas and enclosures for dry-pipe, deluge and other types of valves controlling water supplies to sprinkler systems

By Others	By CSCO	Item
X		City Water Connection
X		Valve House or Pit
N/A		Connection to Plant Air
N/A		Air Compressor
N/A		Air Maintenance Device
X		Electric Alarm
X		Electric Wire
X		Hose Cabinet and Equipment
X		Painting
X		Sleeves
X		Cutting Hole and Patch
N/A		Trench and Backfill
N/A		Repaving
X		Underground Piping

This drawing and the information hereon is the property of Crawford Sprinkler Company of Raleigh, and may not be reproduced, altered or used in any form without consent from Crawford Sprinkler Company of Raleigh.

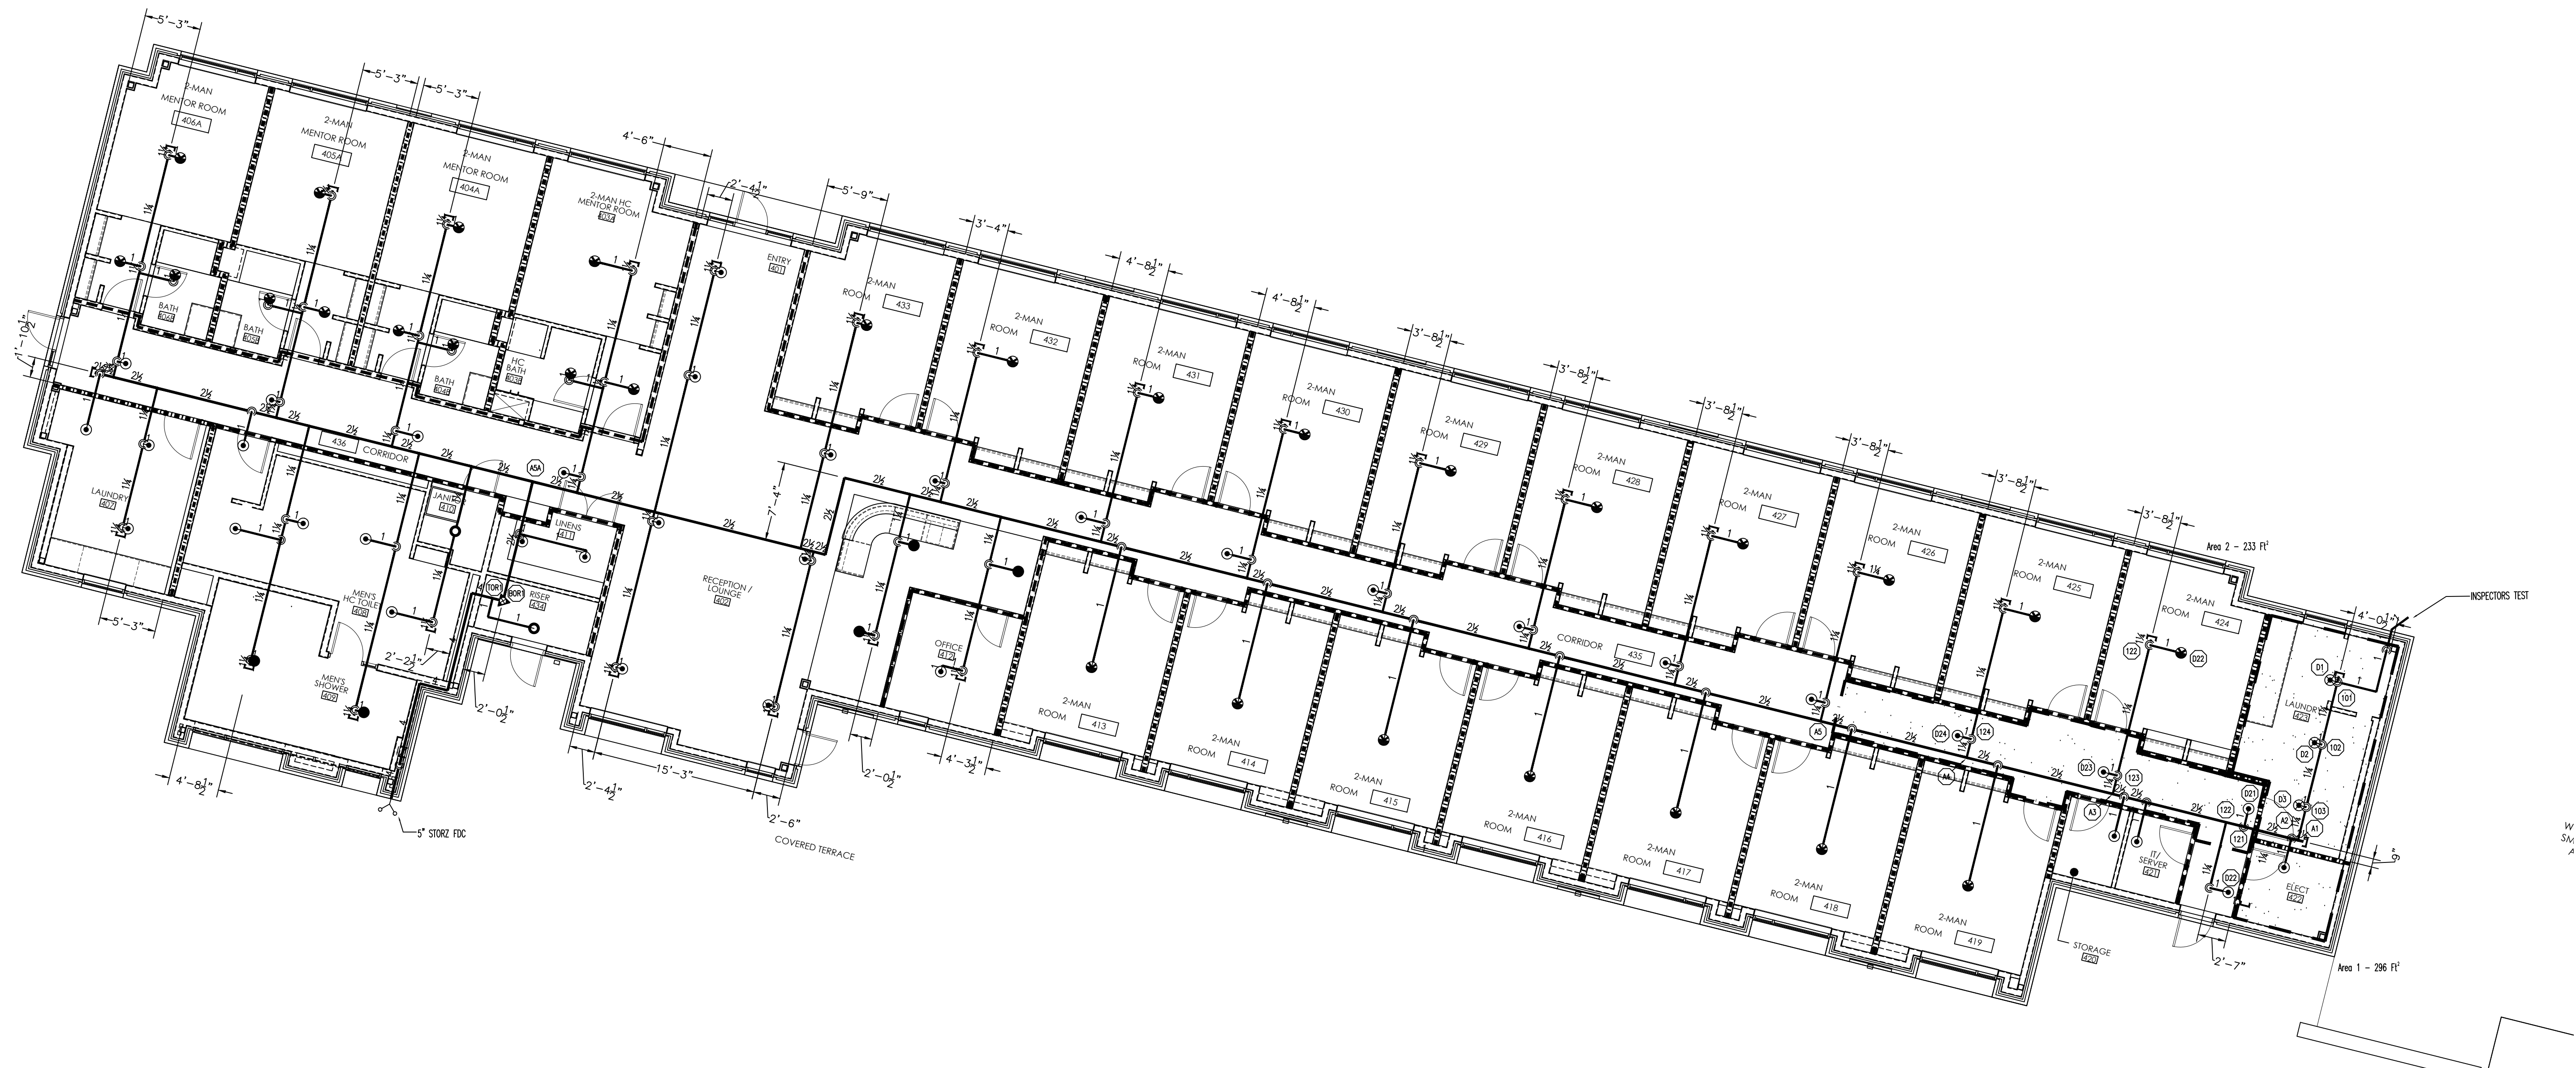

1 MEN'S RESIDENTIAL BUILDING - PIPING PLAN
FP 9 1/8" = 1'-0"

HEAD LEGEND

SYM	CONT	NAME	METAL	TEMP	K	INPT	ORF	MFG	MODEL#	APPROX	MIN SPACING	MAX SPACING	RESPONSE	ESQUT	SIN.
8	NEW DRY PENDENTS	CHROME	200	5.60	1/2"	1/2	WIKING	M	UL/FM/ULC/MEA	6'-0"	15'-0"	15'-0"	QUICK RESPONSE	ADJ. STANDARD	VK 178
23	NEW UPRIGHTS	BRASS	155	5.60	1/2"	1/2	WIKING	M	UL/FM/ULC/MEA	6'-0"	15'-0"	15'-0"	QUICK RESPONSE	N/A	VK 3001
58	NEW RESIDENTIAL PENDENTS	WHITE	155	5.6	1/2"	1/2	WIKING	M472	UL/FM/ULC/MEA	6'-0"	15'-0"	15'-0"	QUICK RESPONSE	WHITE PLATE	VK 472
51	NEW CONCEALED PENDENTS	BRASS	155	5.60	1/2"	1/2	WIKING	M	UL/FM/ULC/MEA	6'-0"	15'-0"	15'-0"	QUICK RESPONSE	WHITE PLATE	VK 462
466	NEW PENDENTS	WHITE	155	5.60	1/2"	1/2	WIKING	M	UL/FM/ULC/MEA	6'-0"	15'-0"	15'-0"	QUICK RESPONSE	RECESSED	VK 3021
32	NEW PENDENTS	WHITE	200	5.60	1/2"	1/2	WIKING	M	UL/FM/ULC/MEA	6'-0"	15'-0"	15'-0"	QUICK RESPONSE	RECESSED	VK 3021
TOTAL	638														

NOTE

1. ALL PIPE ELEVATIONS ARE 9'-8" AFF UNLESS OTHERWISE SPECIFIED.

HYDRAULIC DESIGN CRITERIA - LAUNDRY		
AREA NUMBER: 1	CODE REF.: NFPA 13	HAZARD: ORDINARY HAZARD (GROUP 1)
REMOTE AREA: 3-HEAD	DENSITY: .15 GPM	AREA PER SPRINKLER: 130 SQ. FT.
SYSTEM TYPE: WET	INSIDE HOSE: 0	OUTSIDE HOSE: 250 GPM
TOTAL SYS. DEMAND: 294.953	PSI: 21.584	SAFETY MARGIN: 43.022

HYDRAULIC DESIGN CRITERIA - CORRIDOR		
AREA NUMBER: 2	CODE REF.: NFPA 13	HAZARD: LIGHT HAZARD
REMOTE AREA: 4-HEAD CORR.	DENSITY: .10 GPM	AREA PER SPRINKLER: 225 SQ. FT.
SYSTEM TYPE: WET	INSIDE HOSE: 0	OUTSIDE HOSE: 100 GPM
TOTAL SYS. DEMAND: 190.925	PSI: 33.912	SAFETY MARGIN: 30.912

DESIGN CRITERIA


SYSTEM TYPE	Wet
SYSTEM DESIGN	Calculated
DESIGN DENSITY	VARIABLES
MAX HEAD CVRG	VARIABLES
HOSE ALLOWANCE	VARIABLES
DRAWN BY: DJM	DATE: 8/20/2022
CHECK BY:	DATE:
SCALE: AS NOTED	

CONTRACT NO.: JIB208	
FILE NO:	

DWG. NO: FP 9 OF 12
B. Thomas 8/25/2022
N.C. License No. 29772 FS-I



NICET#107492
WATER BASED SYSTEMS
LAYOUT LEVEL III
BRIAN THOMAS CRAWFORD

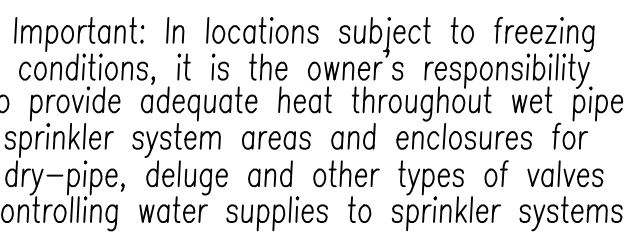

By Others	By CSCO	Item
X		City Water Connection
X		Valve House or Pit
	N/A	Connection to Plant Air
	N/A	Air Compressor
	N/A	Air Maintenance Device
X		Electric Alarm
X		Electric Wire
X		Hose Cabinet and Equipment
X		Painting
X		Sleeves
X		Cutting Hole and Patch
	N/A	Trench and Backfill
	N/A	Regrading
X		Underground Piping

This drawing and the information hereon is the property of Crawford Sprinkler Company of Raleigh, and may not be reproduced, altered or used in any form without consent from Crawford Sprinkler Company of Raleigh.



SYM	CNZ	NAME	METAL	TEMP	K	NPT	ORF	WFG	MODIFI	APPROX.	MIN SPACING	MAX SPACING	RESPONSE	ESCUIT	SIN.
(A)	8	NEW DRY PENDENTS	CHROME	200	5.60	1/2"	1/2	WING	M	UL/FM/ULC/NEA	6"-0"	15'-0"	QUICK RESPONSE	AJU - STANDARD	VK 178
(B)	23	NEW UPRIGHTS	BRASS	155	5.60	1/2"	1/2	WING	M	UL/FM/ULC/NEA	6'-0"	15'-0"	QUICK RESPONSE	N/A	VK 3001
(C)	58	NEW QUADRANTAL PENDENTS	WHITE	155	5.8	1/2"	1/2	WING	YK472	UL/FM/ULC/NEA	8'-0"	18'X18'	QUICK RESPONSE	WHITE PLATE	VK 472
(D)	51	NEW CONCEALED PENDENTS	BRASS	155	5.60	1/2"	1/2	WING	M	UL/FM/ULC/NEA	6'-0"	15'-0"	QUICK RESPONSE	WHITE PLATE	VK 462
(E)	466	NEW PENDENTS	WHITE	155	5.60	1/2"	1/2	WING	M	UL/FM/ULC/NEA	6'-0"	15'-0"	QUICK RESPONSE	RECESSED	VK 3201
(F)	32	NEW PENDENTS	WHITE	200	5.60	1/2"	1/2	WING	M	UL/FM/ULC/NEA	6'-0"	15'-0"	QUICK RESPONSE	RECESSED	VK 3021

1. ALL CEILING HEIGHTS ARE 9'-0" AFF UNLESS OTHERWISE SPECIFIED.


SYSTEM TYPE	Wd
SYSTEM DESIGN	Calculated
DESIGN DENSITY	VARIES
MAX HEAD CVRG	VARIES
HOSE ALLOWANCE	VARIES


DRAWN BY: DJM	DATE: 8/25/2020
CHECK BY:	DATE:
SCALE: AS NOTED	

CONTRACT NO: J181258

FILE NO:


DWG. NO: FP 10 OF 12
Ruthland 8/25/2020
 N.C License No. 29772 FS-I

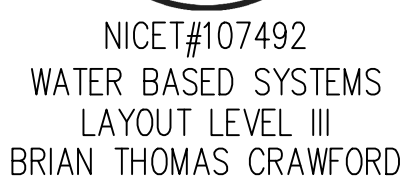

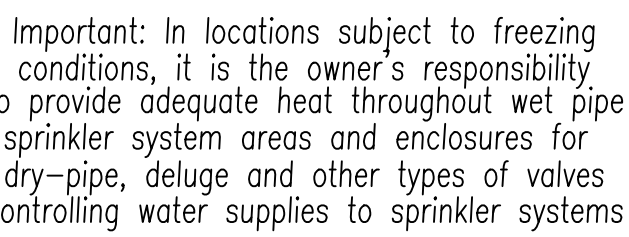

By Others	By CSCO	Item
X		City Water Connection
X		Valve House or Pit
	N/A	Connection to Plant Air
	N/A	Air Compressor
	N/A	Air Maintenance Device
X		Electric Alarm
X		Electric Wire
X		Hose Cabinet and Equipment
X		Painting
X		Sleeves
X		Cutting Hole and Patch
	N/A	Trench and Backfill
	N/A	Regrading
X		Underground Piping

This drawing and the information hereon is the property of Crawford Sprinkler Company of Raleigh, and may not be reproduced, altered or used in any form without consent from Crawford Sprinkler Company of Raleigh.

 

THE HEALING PLACE OF NEW HANOVER COUNTY
DETOX BUILDING - PIPING PLAN
1000 MEDICAL CENTER DRIVE
WILMINGTON, NORTH CAROLINA

UNDERWRITERS:

INDEX NO.

REVISIONS:

DESIGN CRITERIA

SYSTEM TYPE	Wd
SYSTEM DESIGN	Calculated
DESIGN DENSITY	VARIES
MAX HEAD CVRG	VARIES
HOSE ALLOWANCE	VARIES


DRAWN BY: DJM	DATE: 8/25/2020
CHECK BY:	DATE:
SCALE: AS NOTED	

CONTRACT NO: J181258


FILE NO:

DWG. NO: *FP 11 OF 12*

Ruthland 8/25/2020

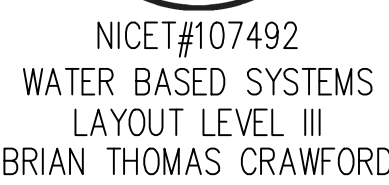

WATER BASED SYSTEMS
LAYOUT LEVEL III
BRIAN THOMAS CRAWFORD

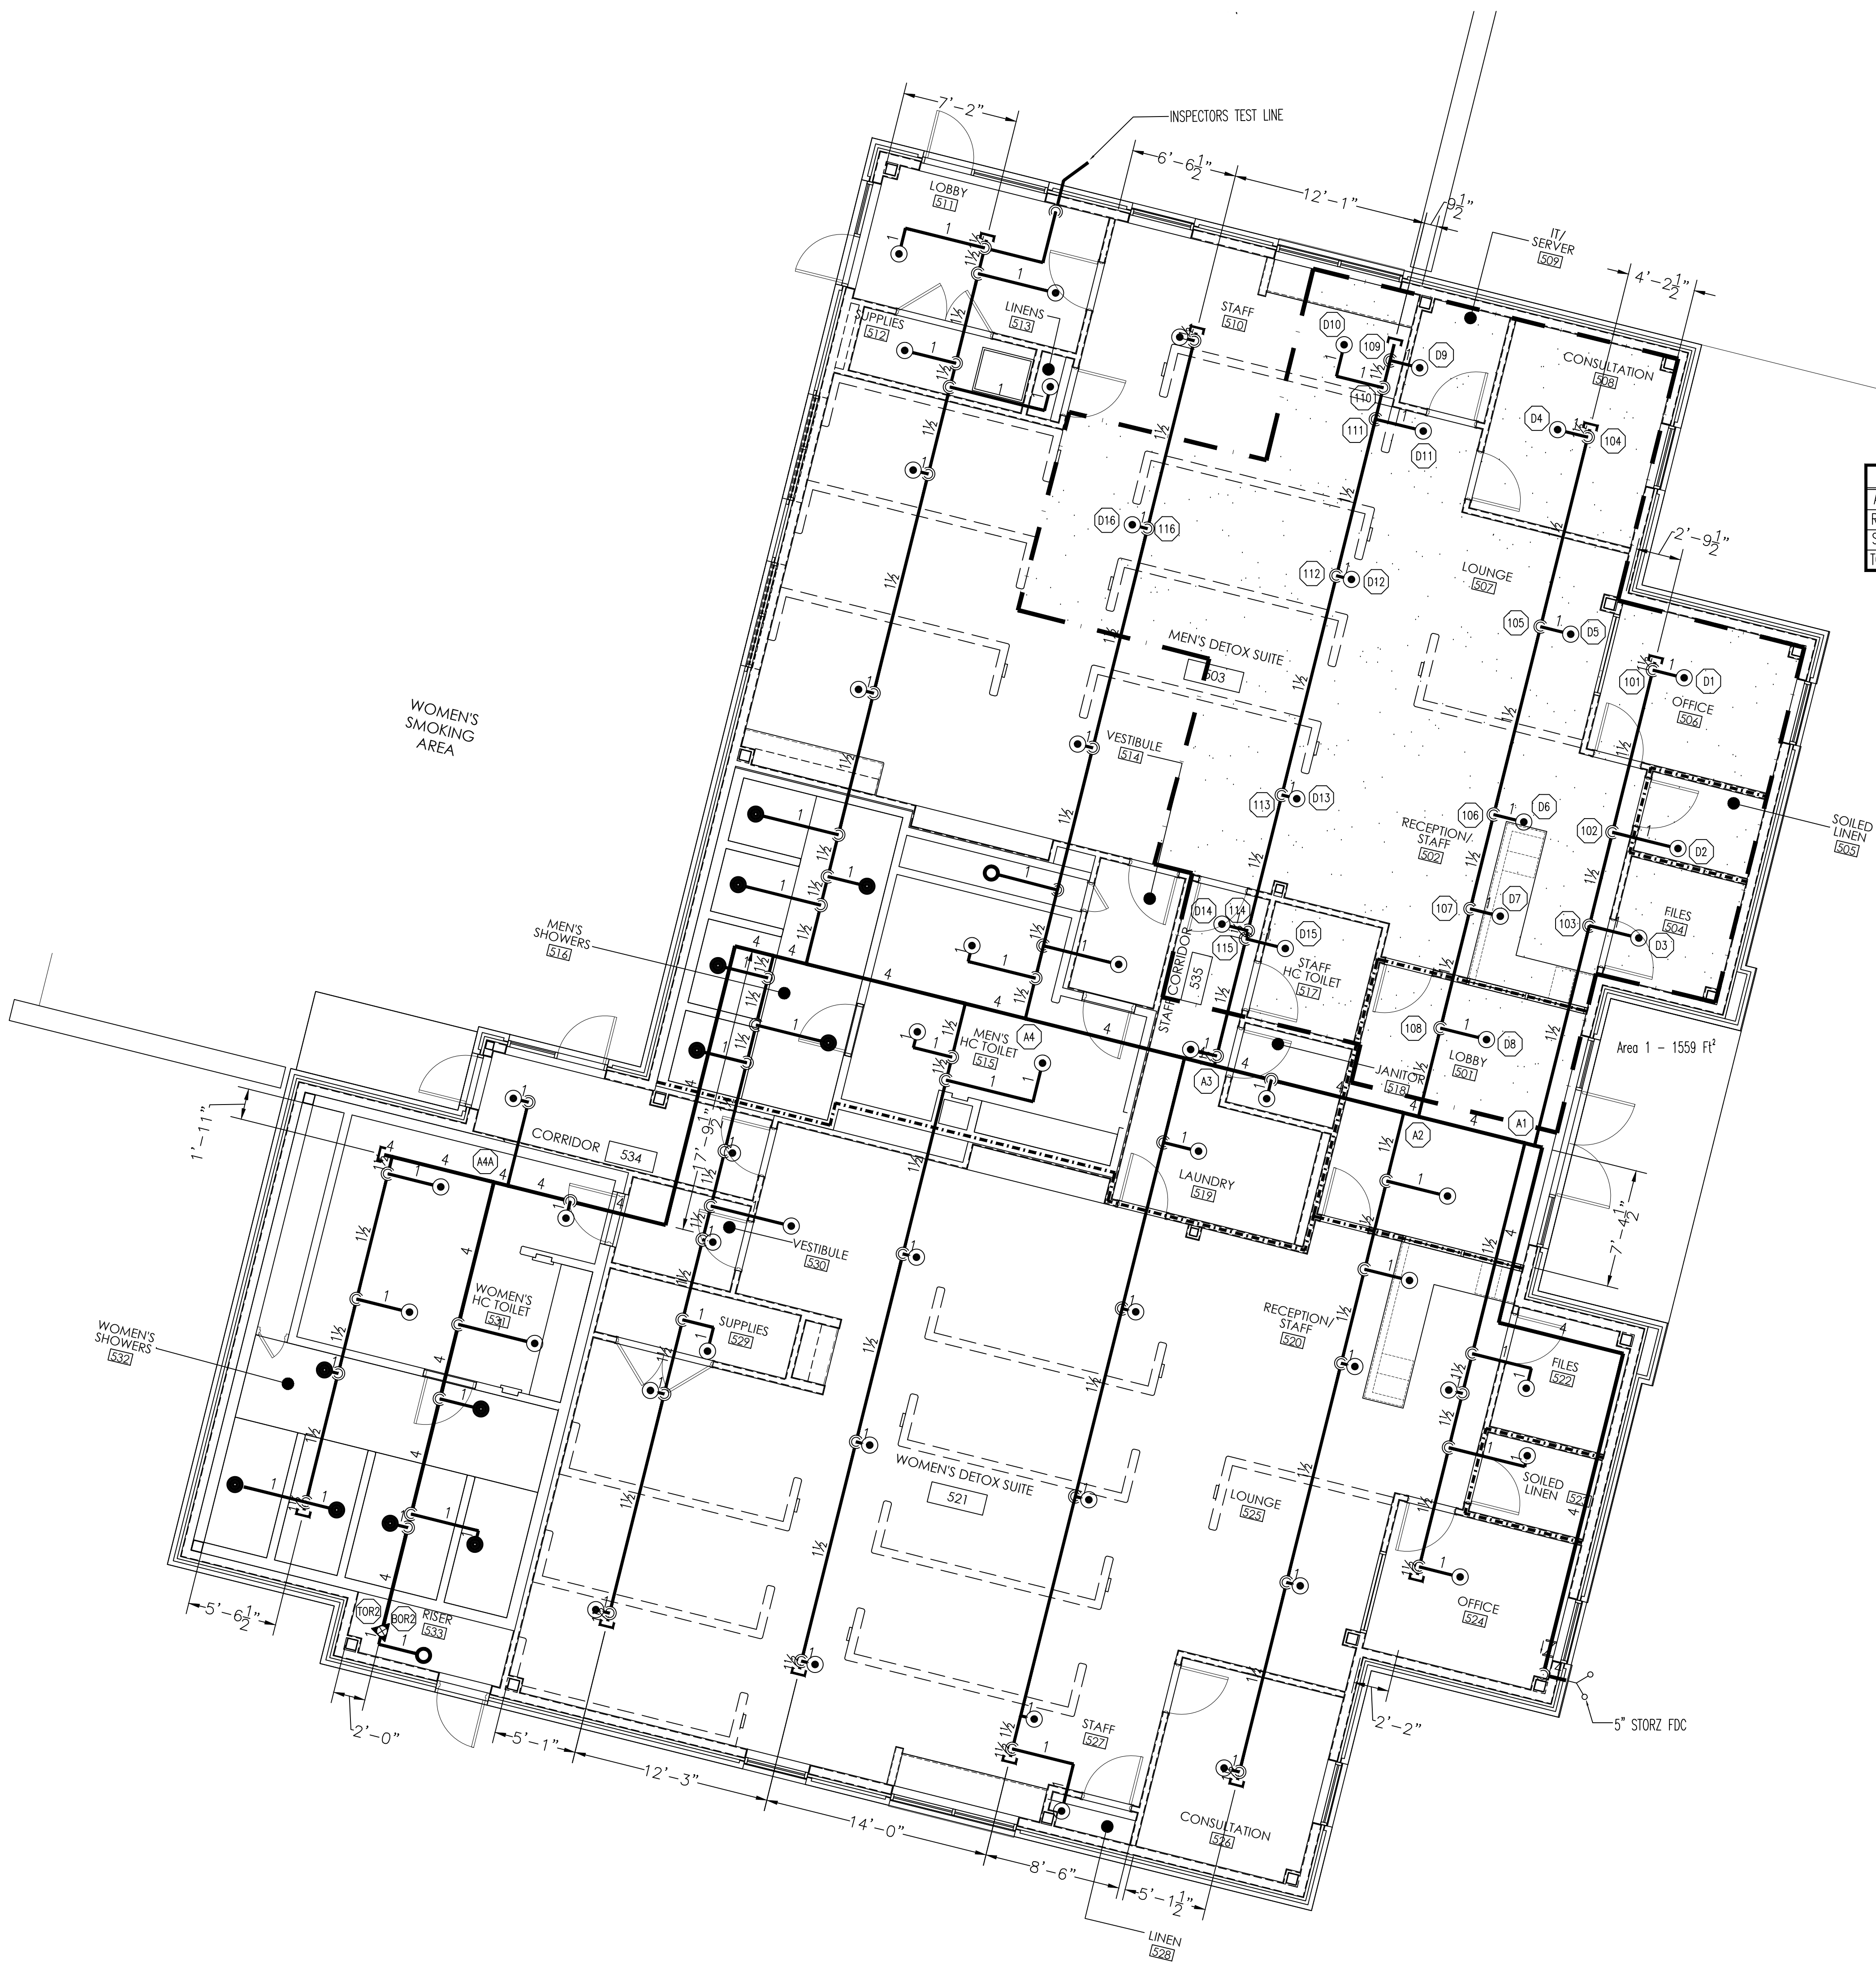


1 DETOX BUILDING - PIPING PLAN
FP 11 $\frac{3}{16}'' = 1'-0''$

HEAD LEGEND

[illegible]

NOTE

1. ALL PIPE ELEVATIONS ARE 9'-8" AFF UNLESS OTHERWISE SPECIFIED.

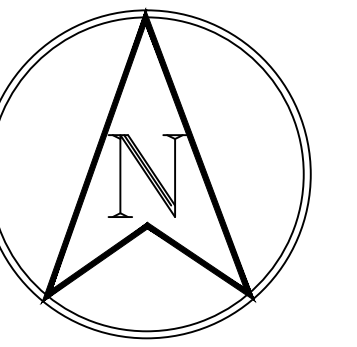

Important: In locations subject to freezing conditions, it is the owner's responsibility to provide adequate heat throughout wet pipe sprinkler system areas and enclosures for dry-pipe, deluge and other types of valves controlling water supplies to sprinkler systems

By Others	By CSCO	Item
X		City Water Connection
X		Valve House or Pit
N/A		Connection to Plant Air
N/A		Air Compressor
N/A		Air Maintenance Device
X		Electric Alarm
X		Electric Wire
X		Hose Cabinet and Equipment
X		Painting
X		Sleeves
X		Cutting Hole and Patch
N/A		Trench and Backfill
N/A		Re-paving
X		Underground Piping

This drawing and the information hereon is the property of Crawford Sprinkler Company of Raleigh, and may not be reproduced, altered or used in any form without consent from Crawford Sprinkler Company of Raleigh.



2725 S. SAUNDERS STREET-RALEIGH, NC 27603 • PO BOX 28207-RALEIGH, NC 27611
PHONE 919-828-5346 • FAX 919-839-8164

THE HEALING PLACE OF NEW HANOVER COUNTY
DETOX BUILDING - RCP
1000 MEDICAL CENTER DRIVE
WILMINGTON, NORTH CAROLINA

UNDERWRITERS:

INDEX NO.

REVISIONS:

DESIGN CRITERIA

SYSTEM TYPE	Wd
SYSTEM DESIGN	Calculated
DESIGN DENSITY	VARIES
MAX HEAD CVRG	VARIES
HOSE ALLOWANCE	VARIES

DRAWN BY: DJM
CHECK BY: DATE: 8/25/2020
SCALE: AS NOTED

CONTRACT NO.: JIB208
FILE NO:

DWG. NO.: FP 12 OF 12



NICET#107492
WATER BASED SYSTEMS
LAYOUT LEVEL III
BRIAN THOMAS CRAWFORD

N.C. License No. 29772 FS-I

