


ENLARGED FINISH FLOOR PLAN - DECON BATH 204 1/2" = 1'-0" 2

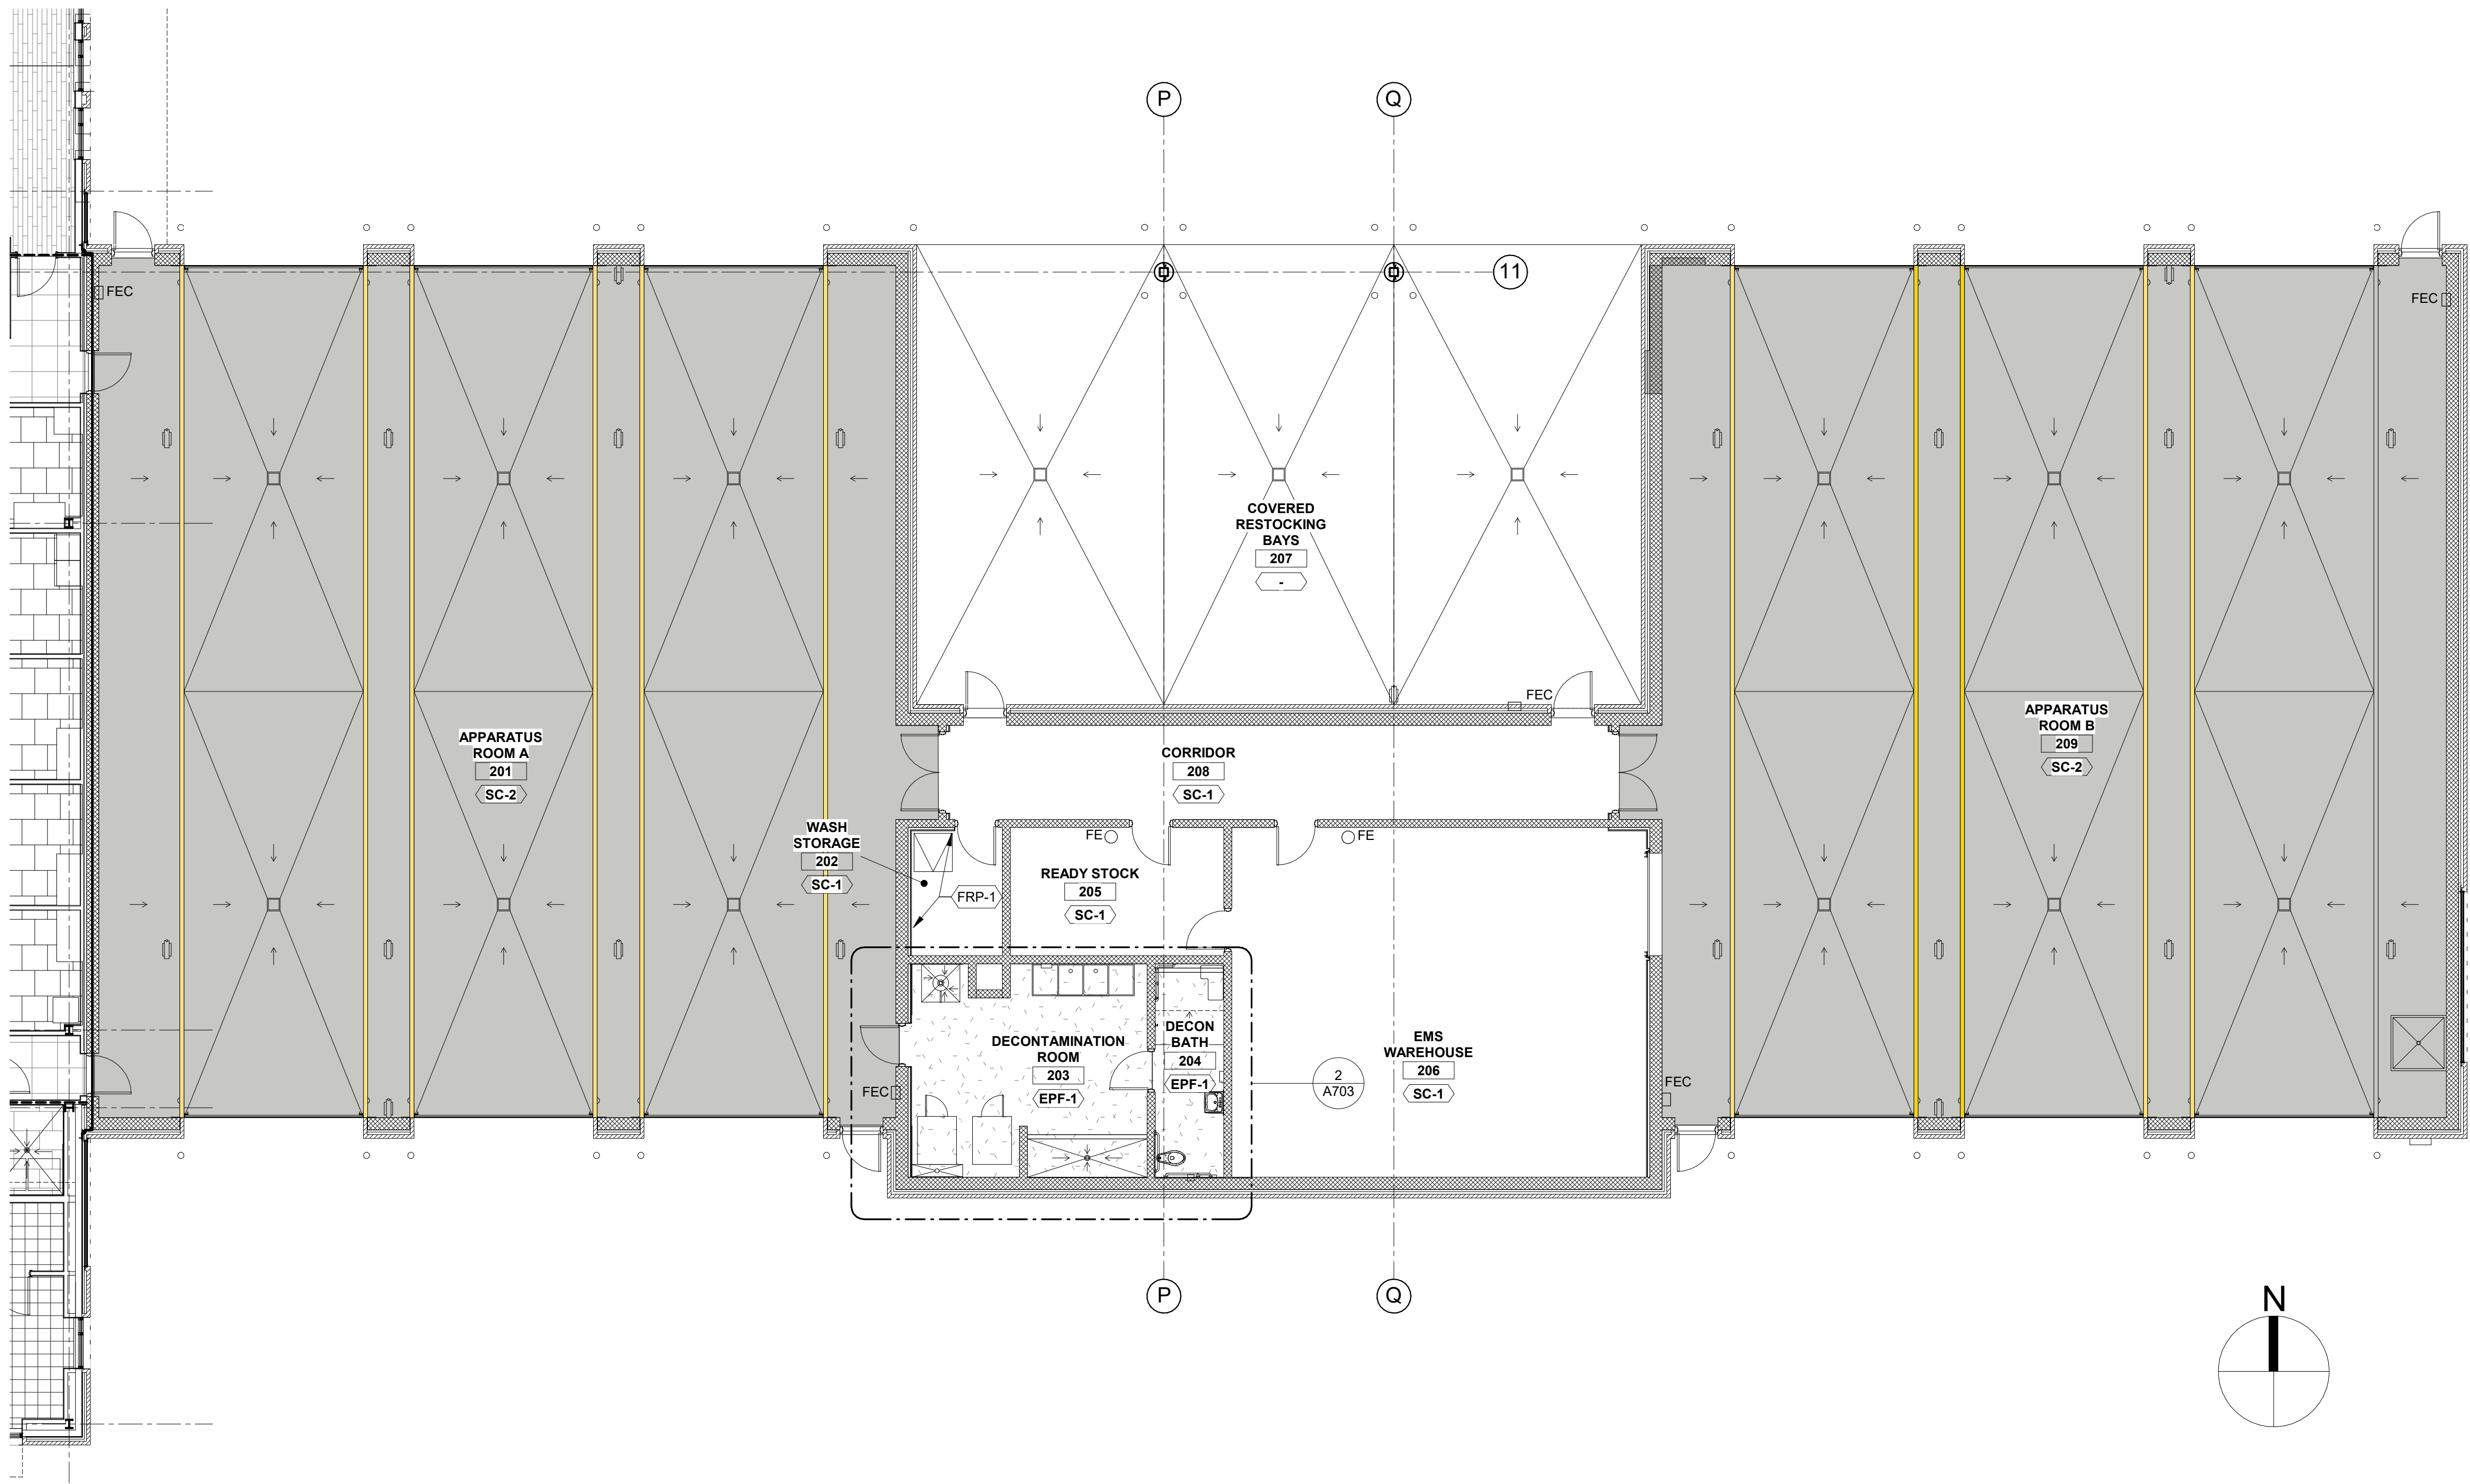

EMS FINISH FLOOR PLAN 1/8" = 1'-0" 1

SAMPSON
COUNTY 911 &
ES FACILITIES

CLINTON, NORTH
CAROLINA



EMS WING FINISH FLOOR
PLAN

DATE: 12.04.2020
PROJECT NO: 20003

REVISIONS
NO: DATE: DESCRIPTION:

THIS DRAWING IS THE PROPERTY OF ADW ARCHITECTS, P.A. AND SHALL NOT BE REPRODUCED OR COPIED IN WHOLE OR PART. IT SHALL NOT BE USED ON ANY OTHER PROJECT OR GIVEN TO ANY OTHER COMPANY OR AGENCY WITHOUT THE CONSENT OF ADW ARCHITECTS, P.A.

SHEET NUMBER

A703