



STEWART

101 N TRYON ST
SUITE 1400
CHARLOTTE, NC 28202
T 704 334 7925
FIRM LICENSE # C-1051
S19191

SAMPSON COUNTY 911 & ES FACILITIES

CLINTON,
NORTH CAROLINA

OVERALL FOUNDATION PLAN

DATE: 12.04.2020
PROJECT NO: 20003


REVISIONS
NO: DATE: DESCRIPTION:

THIS DRAWING IS THE PROPERTY OF ADW ARCHITECTS, P.A. AND
SHALL NOT BE REPRODUCED OR COPIED IN WHOLE OR PART. IT
SHALL NOT BE USED ON ANY OTHER PROJECT OR GIVEN TO ANY
OTHER COMPANY OR AGENCY WITHOUT THE CONSENT OF ADW
ARCHITECTS, P.A.



SHEET NUMBER

S101

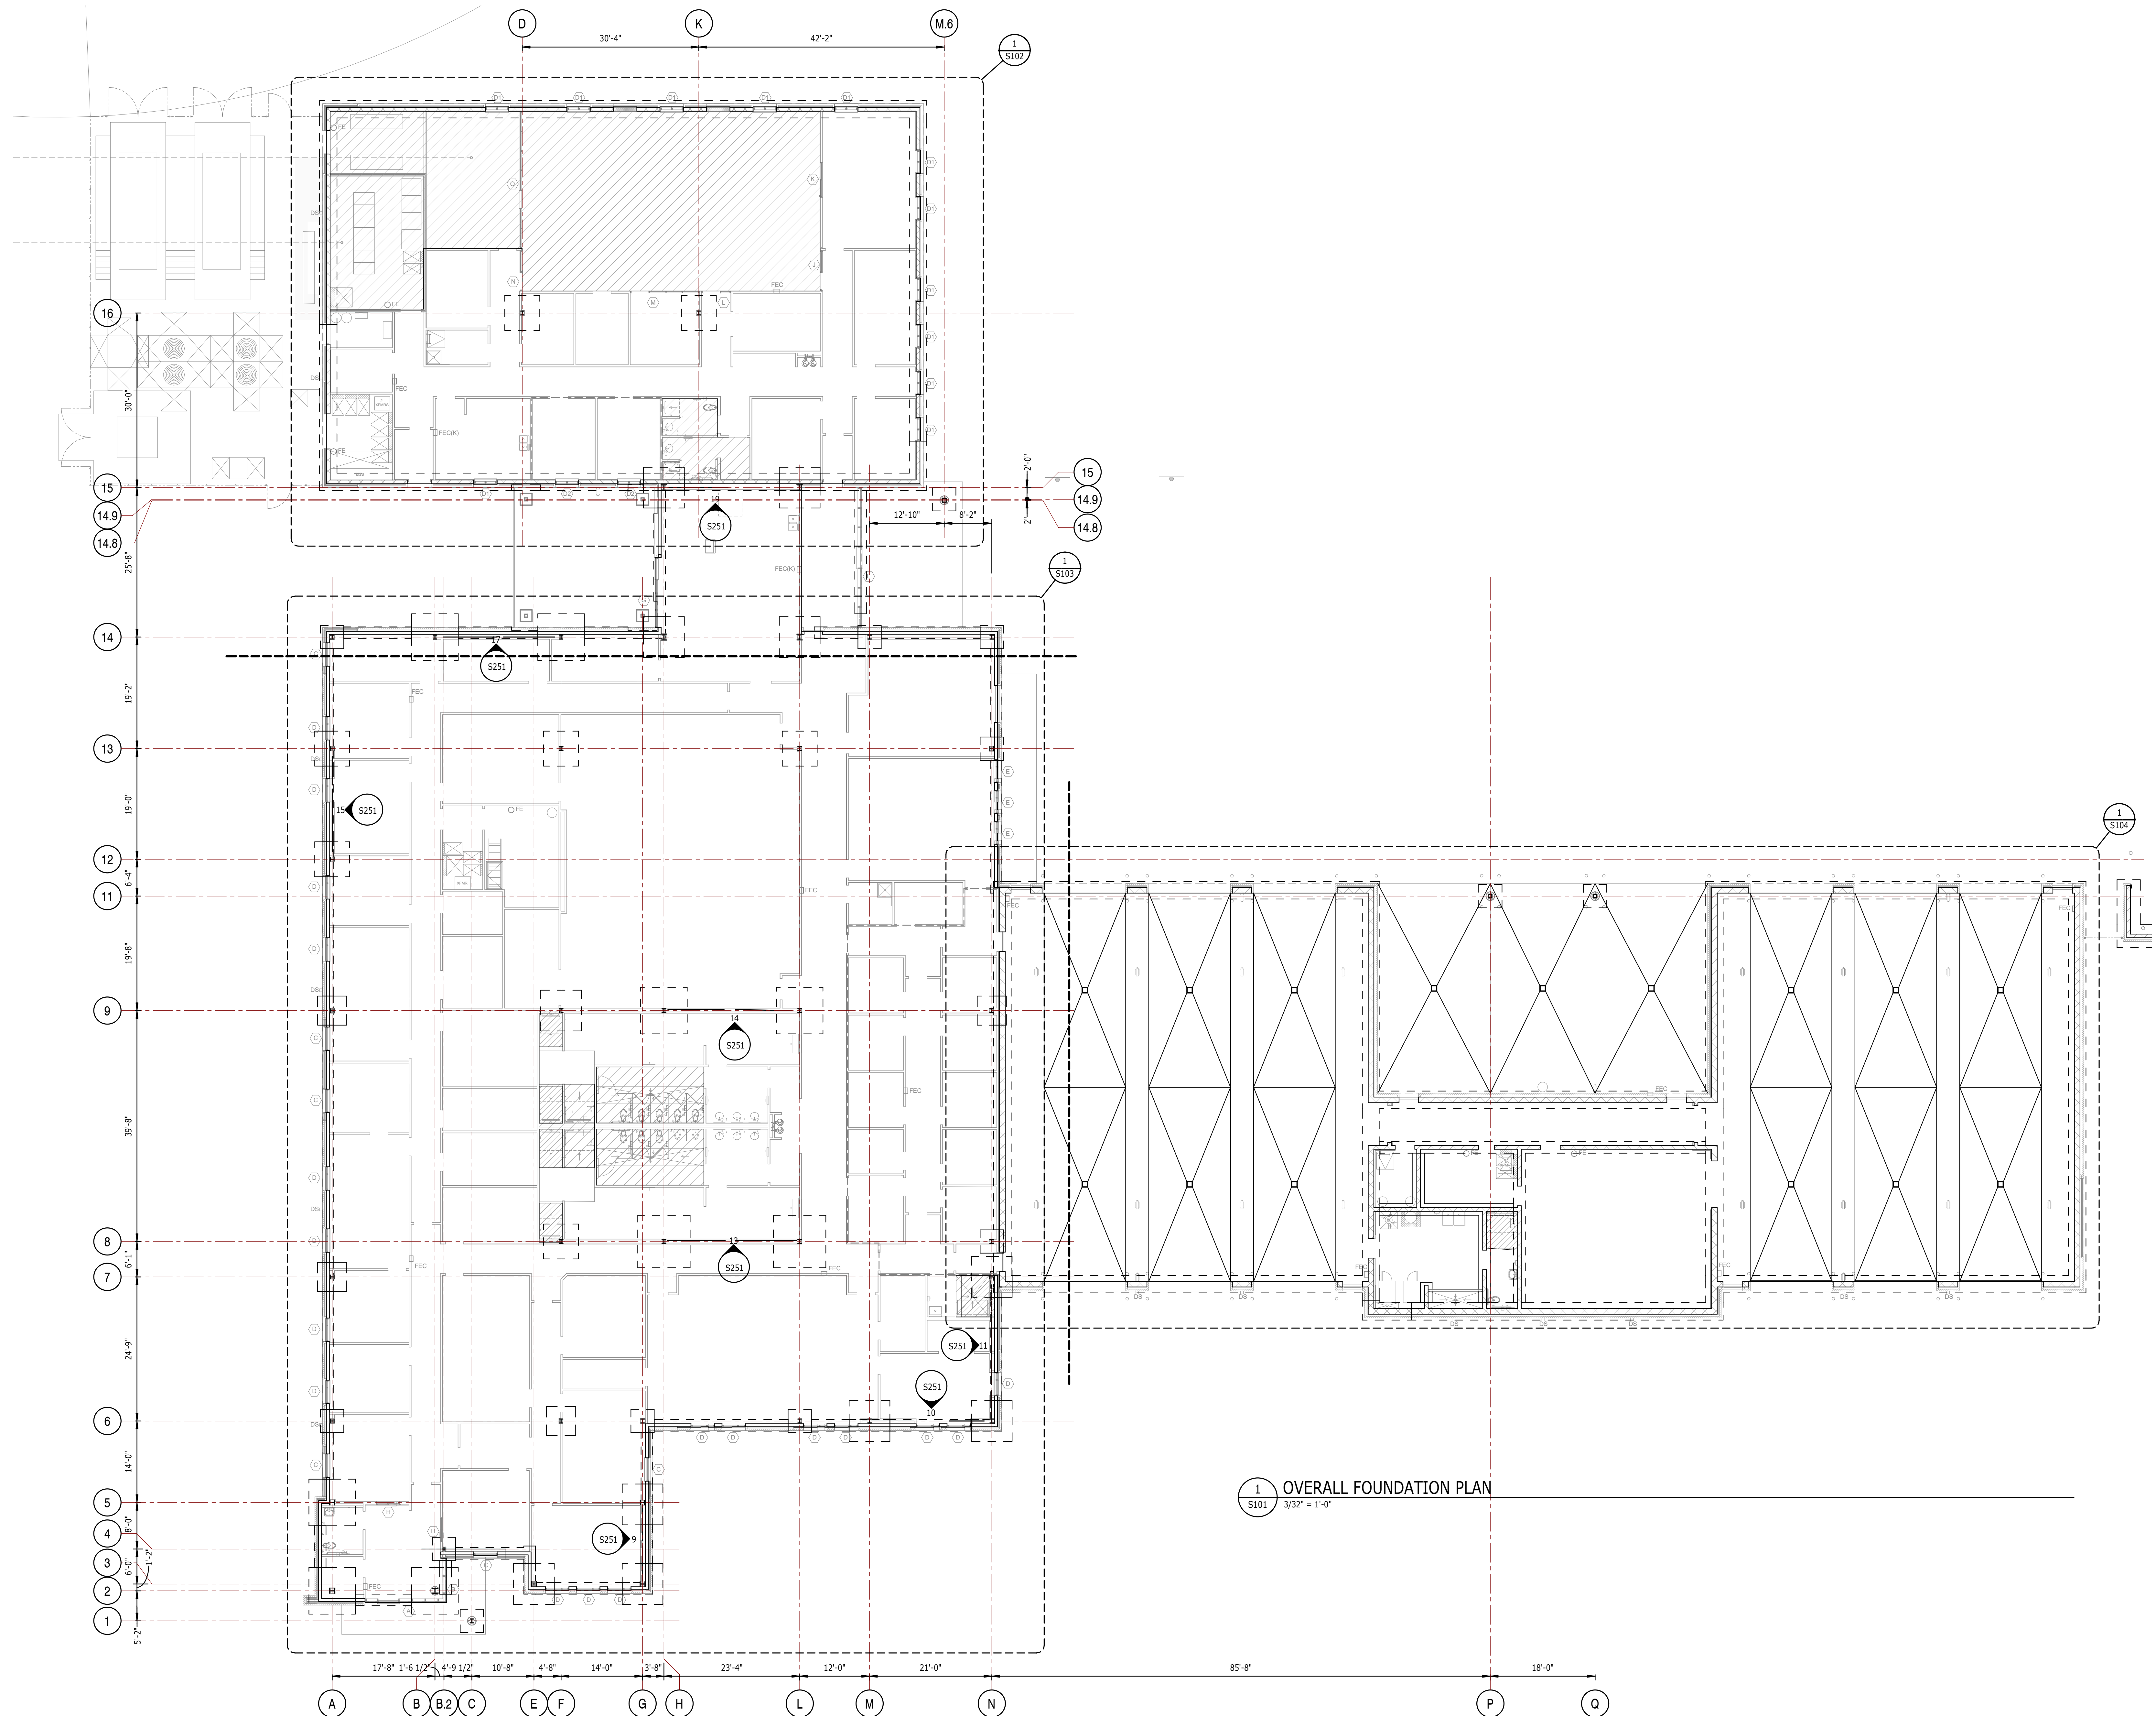

1 OVERALL FOUNDATION PLAN
S101 3/32" = 1'-0"