




SAMPSON COUNTY
911 & ES
FACILITIES


CLINTON,
NORTH CAROLINA

CONSTRUCTION
DOCUMENTS

AREA 1 AND AREA 2
FLOOR PLANS - FIRE
PROTECTION

| | | | |
|---|------------|--------------|--|
| DATE | 12.04.2020 | | |
| PROJECT NO | 20003 | | |
| REVISIONS | | | |
| NUM. | DATE | DESCRIPTION: | |
|  | 12-17-18 | REVISION #1 | |

THIS DRAWING IS THE PROPERTY OF ADW ARCHITECTS, P.A. AND SHALL NOT BE REPRODUCED OR COPIED IN WHOLE OR IN PART. IT SHALL NOT BE USED ON ANY OTHER PROJECT OR GIVEN TO ANY OTHER COMPANY OR AGENCY WITHOUT THE CONSENT OF ADW ARCHITECTS, P.A.

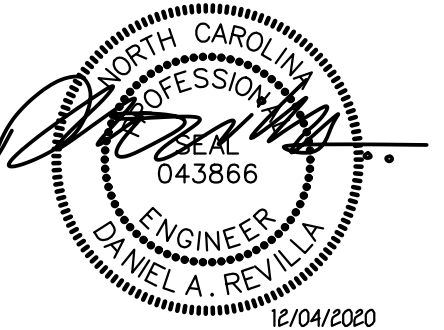

SEAL

SHEET NUMBER

FP101




② AREA 2 FLOOR PLAN - FIRE PROTECTION
1/8" = 1'-0"

① AREA 1 FLOOR PLAN - FIRE PROTECTION
1/8" = 1'-0"

KEYED NOTES

- CLEAN AGENT STORAGE CYLINDERS
- CLEAN AGENT CONTROL PANEL. INTERLOCKED WITH PRE-ACTION SYSTEM PANEL TO PERMIT CLEAN AGENT SYSTEM TO BE THE PRIMARY SOURCE OF FIRE SUPPRESSION
- CLEAN AGENT SYSTEM VISUAL AND AUDIBLE ALARM
- CLEAN AGENT SYSTEM MANUAL RELEASE
- CLEAN AGENT SYSTEM MANUAL ABORT
- PRE-ACTION SYSTEM ASSEMBLY IN CABINET. INTERLOCK BUILT-IN CONTROL PANEL TO CLEAN AGENT SYSTEM CONTROLS.

NOTES:
PRE-ACTION SPRINKLER SYSTEM CONTROL VALVE AND TRIM IN FACTORY PRE-ASSEMBLED CABINET. CONTROL PANEL SHALL PROVIDE CONNECTION POINTS TO BUILDING BAS. COORDINATE COMMUNICATION PROTOCOL WITH CONTROLS CONTRACTORS.
CLEAN AGENT SYSTEM STORAGE CYLINDER(S) AND CONTROL PANEL. CONTROL PANEL SHALL PROVIDE CONNECTION POINTS TO BUILDING BAS. COORDINATE COMMUNICATION PROTOCOL WITH CONTROLS CONTRACTORS.
CLEAN AGENT SYSTEM SHALL BE ONE OF THE FOLLOWING:
1. FK-5-1-12 (BOD: 3-M NOVEC 1230)
2. HFC 227EA (BOD: DUPONT FM-200)
OR APPROVED EQUALS FOR EACH TYPE.

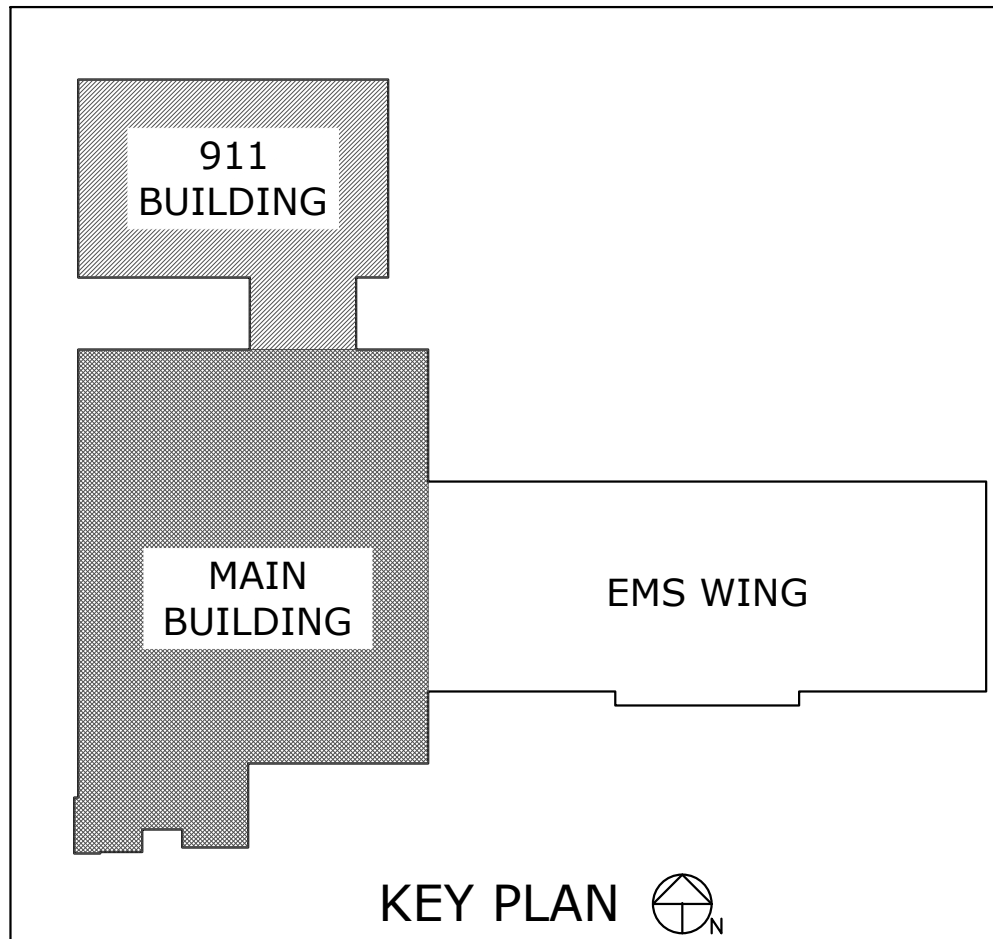

KEY PLAN