



## SAMPSON COUNTY 911 & ES FACILITIES


CLINTON,  
NORTH CAROLINA

CONSTRUCTION  
DOCUMENTS

AREA 1 AND AREA 2  
DRAINAGE PLANS -  
PLUMBING


DATE	12.04.2020	
PROJECT NO	20003	
REVISIONS		
NUM.	DATE	DESCRIPTION:
1	12-17-18	REVISION #1

THIS DRAWING IS THE PROPERTY OF ADW ARCHITECTS, P.A. AND  
SHALL NOT BE REPRODUCED OR COPIED IN WHOLE OR IN PART. IT  
SHALL NOT BE USED ON ANY OTHER PROJECT OR GIVEN TO ANY  
OTHER COMPANY OR AGENCY WITHOUT THE CONSENT OF ADW  
ARCHITECTS, P.A.

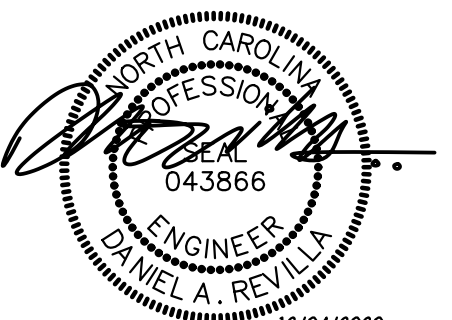


SEAL

SHEET NUMBER  
**P101**

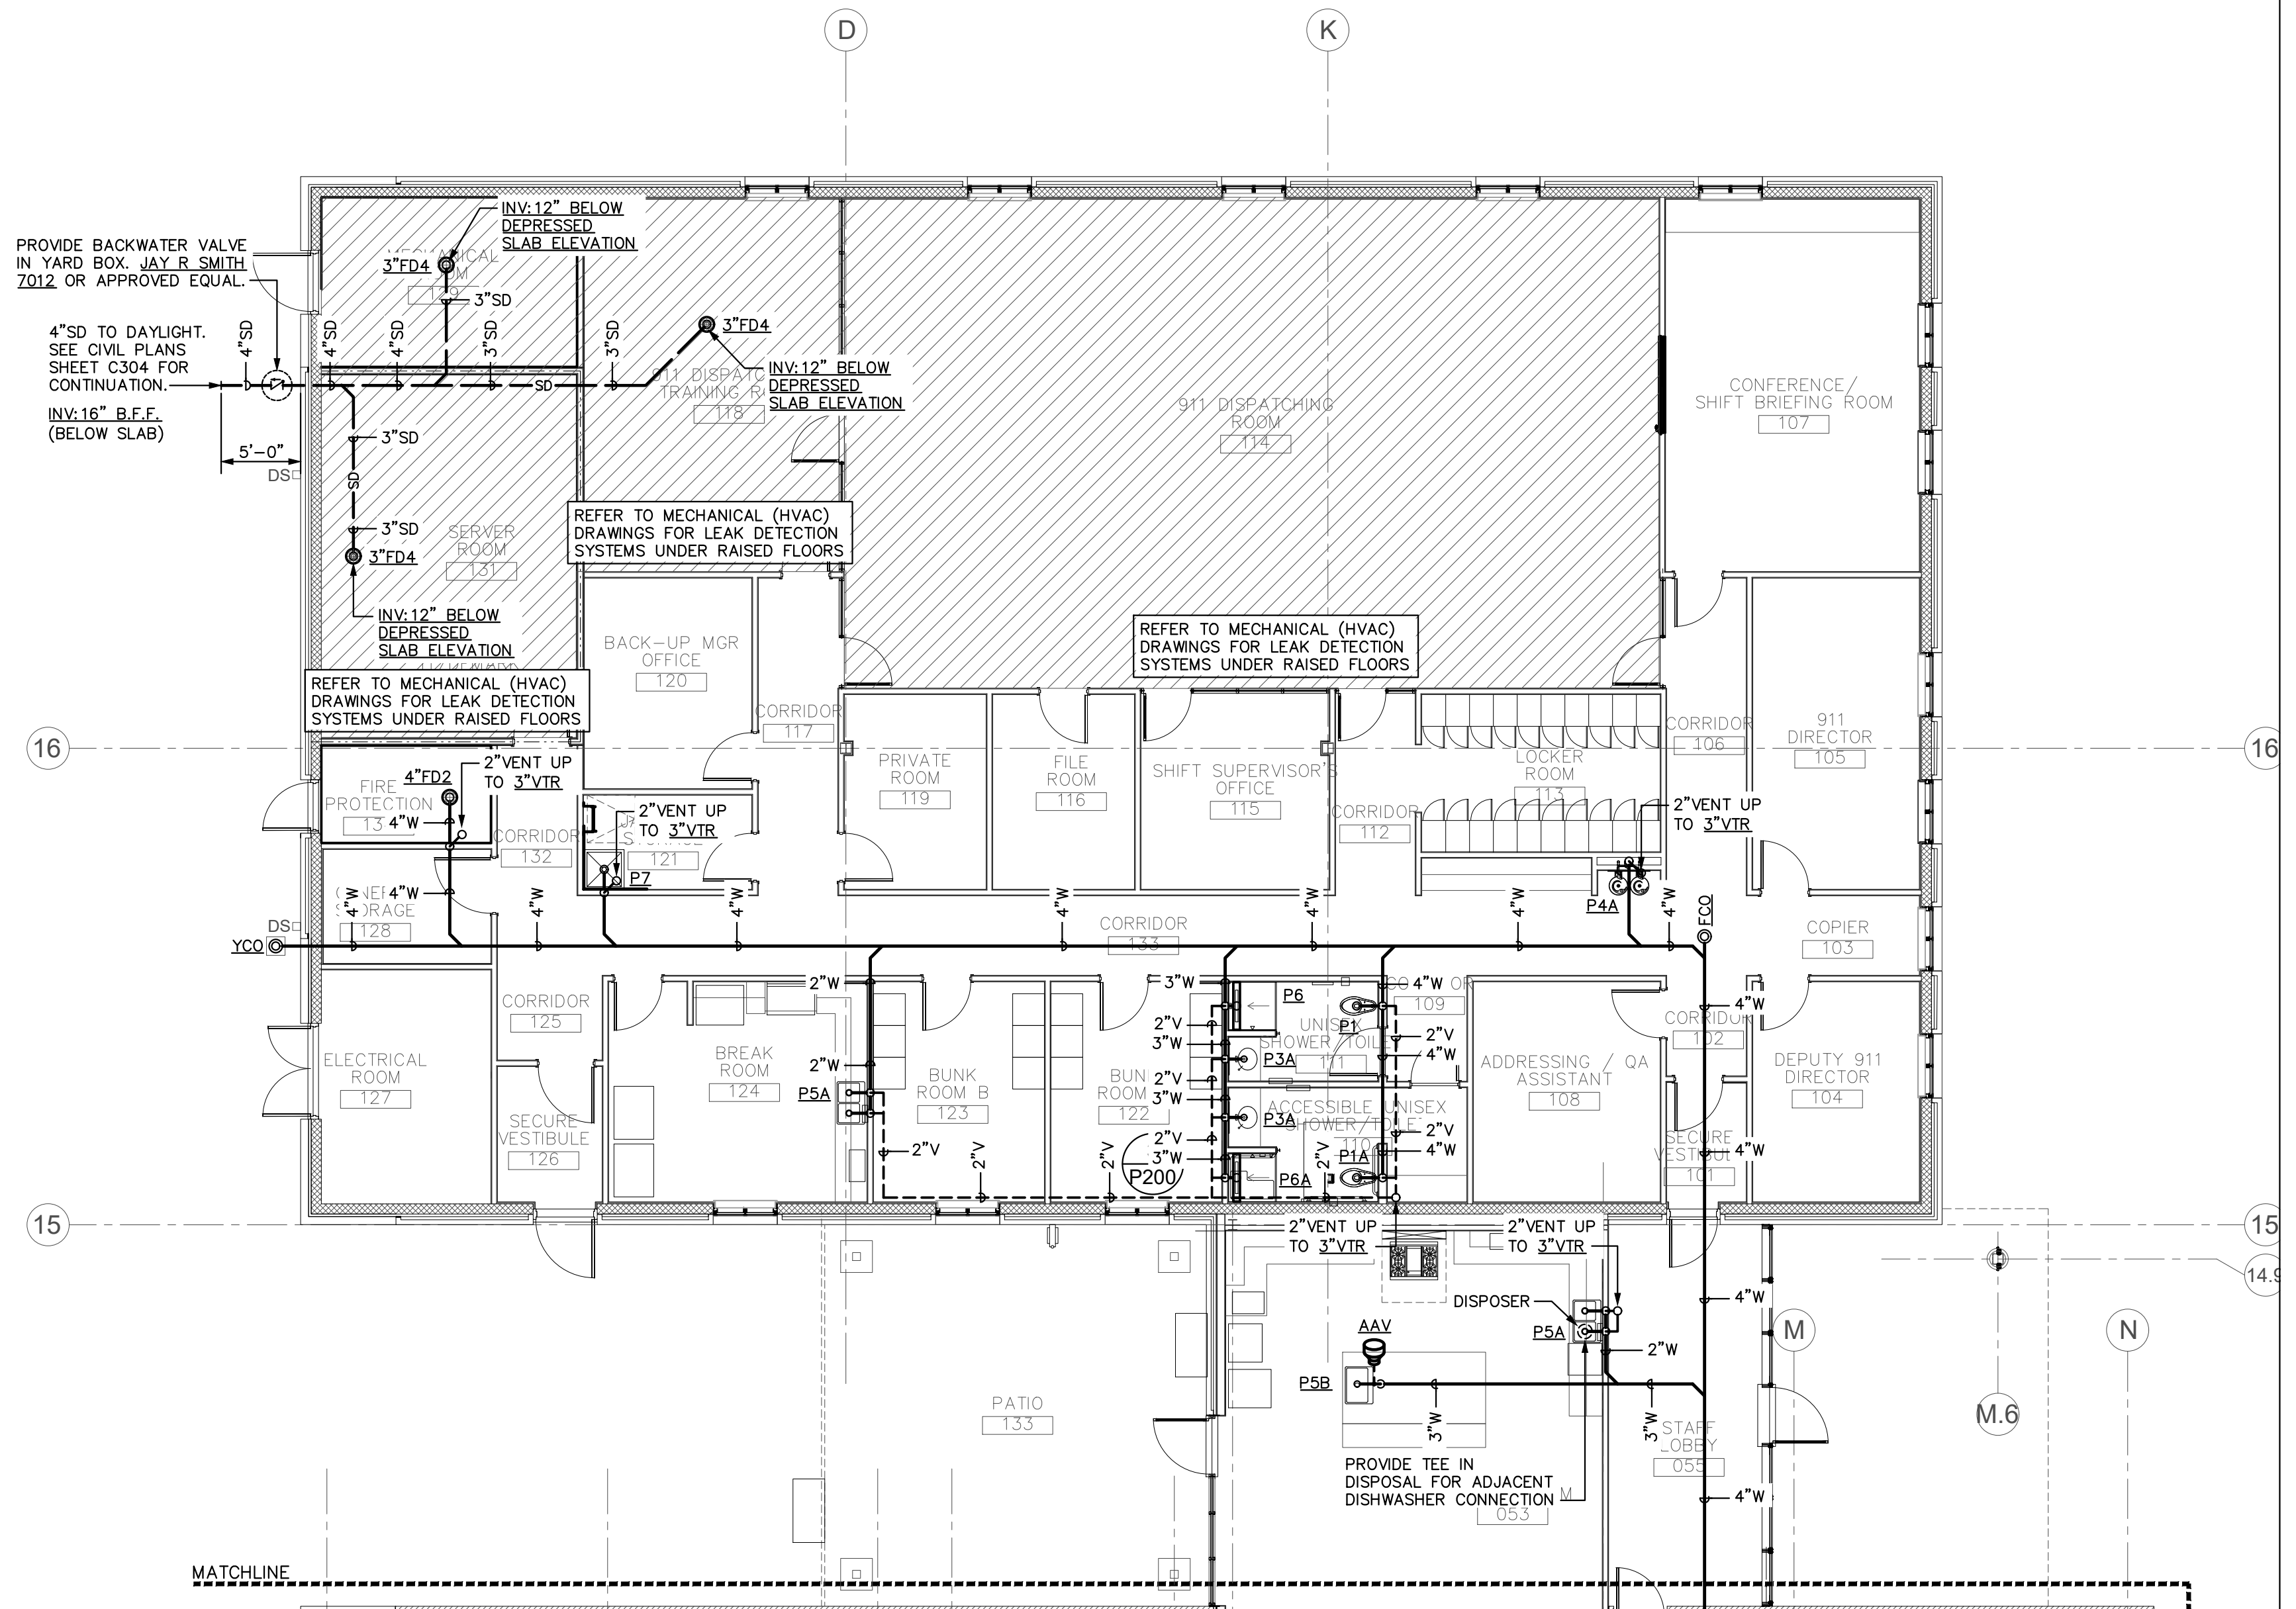

① AREA 1 DRAINAGE FLOOR PLAN - PLUMBING  
1/8" = 1'-0"

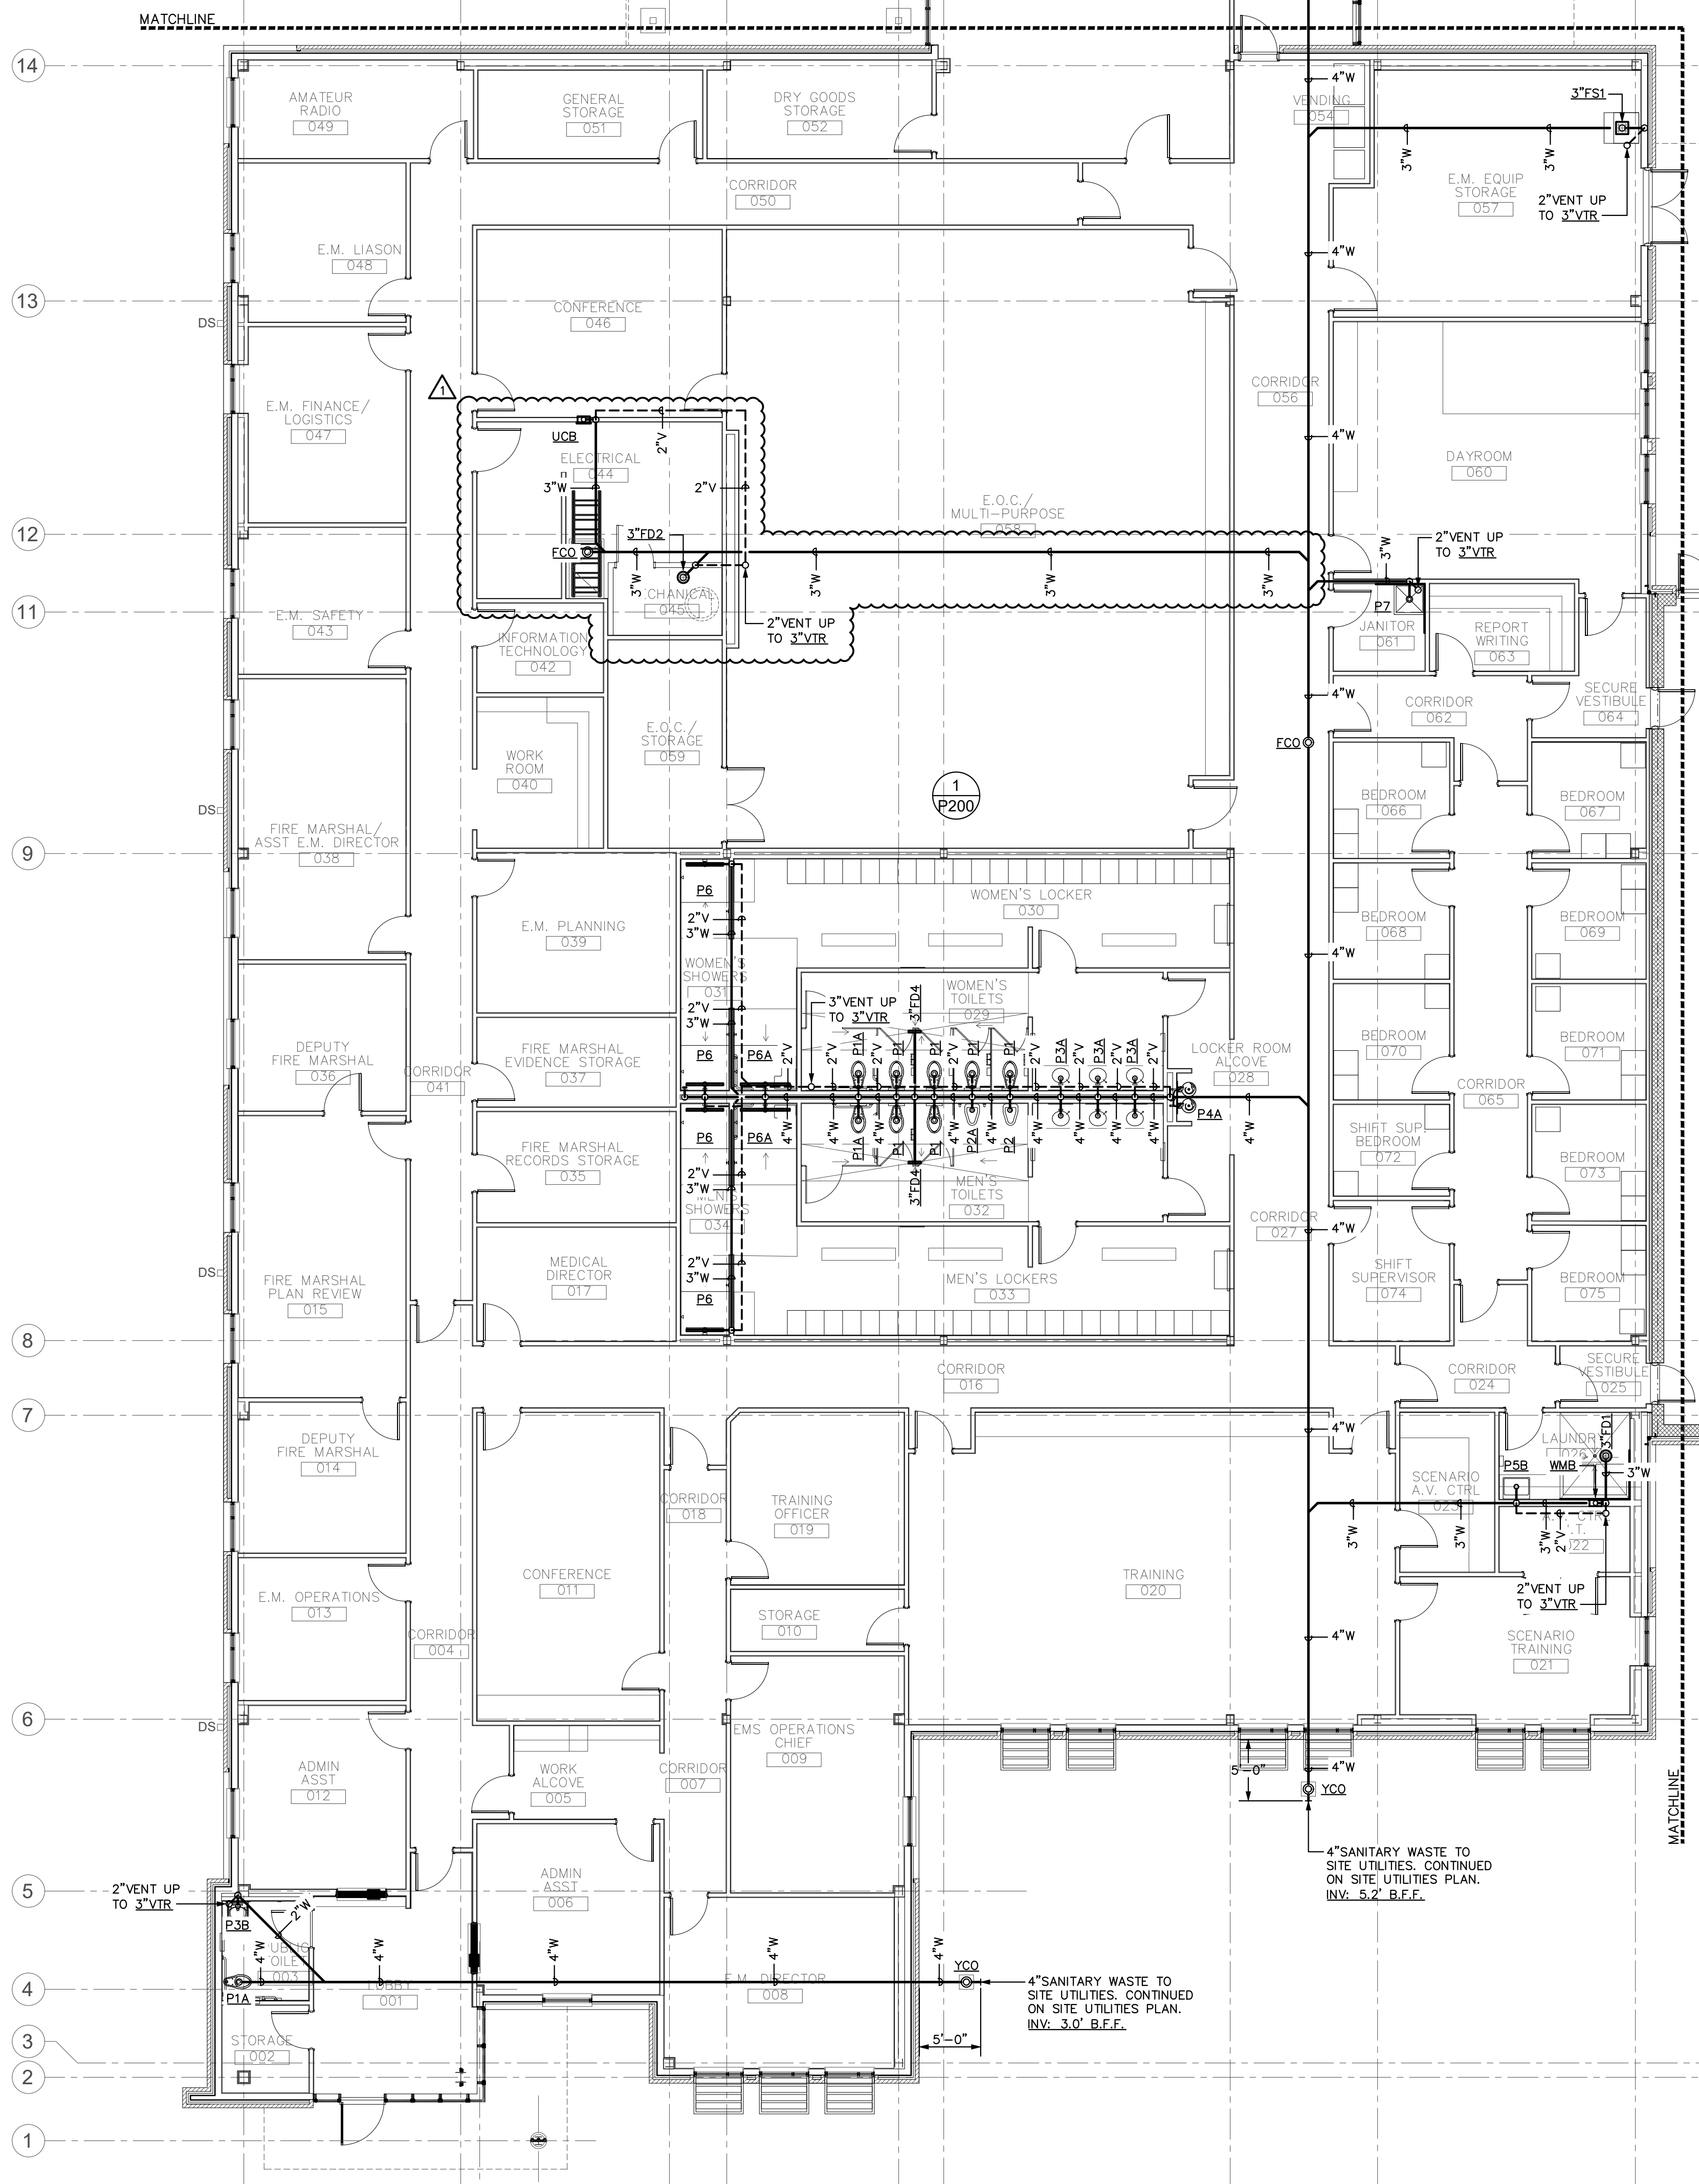

② AREA 2 DRAINAGE FLOOR PLAN - PLUMBING  
1/8" = 1'-0"

