

A

ROOM NUMBER	TYPE	QUANTITY
101	FPD-C	1
102	FPD-C	1
200A	FPD-C	1
200B	FPD-C	1
200C	FPD-C	1
202	FPD-B	2
207	FPD-B	2
209	FPD-B	1
300A	FPD-C	1
300B	FPD-C	1
300C	FPD-C	1
300X	FPD-C	1
300Y	FPD-C	1
300Z	FPD-C	1
301A	FPD-C	1
301B	FPD-C	1
303B	FPD-B	2
L010	FPD-A	1

SCALE:	AS NOTED
EPROJECT NO.:	
CONSTR. CONTR. NO.	N40085-20-C-0059
NAVFAC DRAWING NO.	
SHEET	OF
TA002	

PRE-17

FILE NAME: BIM 360/HF PACKAGE 3P1338_MEF SIM CTR-150082-T.v4
PLOTTED: 6/9/2021 6:52:12 AM

DEPARTMENT OF THE NAVY
NAVAL FACILITIES ENGINEERING COMMAND ~ MID-ATLANTIC
ROICC FLORENCE CAMP LEJEUNE
MCB CAMP LEJEUNE
P1338F II MEF SIMULATION/TRAINING CENTER
REPLACEMENT
AUDIOVISUAL - FLOOR PLAN - AREA A
DP2 SUBMISSION - P1338 BUILDING PRE-FINAL SUBMISSION

D

C

B

A

UNCLASSIFIED

UNCLASSIFIED



AUDIOVISUAL - FLOOR PLAN - AREA A


SCALE: 1/8" = 1'-0"

A4


KEYNOTE LEGEND

1 PROVIDE FSR PWB-100-WHT-C USED TO COVER FSR PWB-100-B.

KEYPLAN

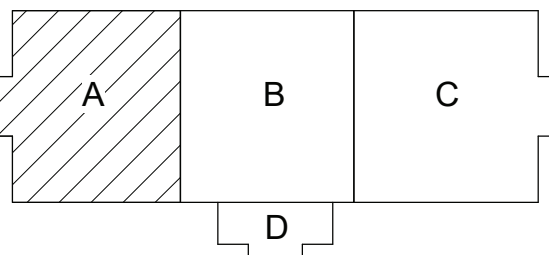

0 48" 96" 192"
SCALE: 1/8" = 12"

 

PRELIMINARY
Not for construction



Michael Baker
INTERNATIONAL
100 AIRSIDE DRIVE
MOON TOWNSHIP, PA 15108
APPROVED

FOR COMMANDER NAVFAC
ACTIVITY
MARINE CORPS BASE
CAMP LEJEUNE
SATISFACTORY TO DATE
DES AS DRW AV CHK BM
PM
BRANCH MANAGER
CHIEF ENGINEER
FIRE PROTECTION

NAVAL FACILITIES ENGINEERING COMMAND
NAVAL FACILITIES ENGINEERING COMMAND ~ MID-ATLANTIC
ROICC FLORENCE CAMP LEJEUNE
MCB CAMP LEJEUNE
P1338F II MEF SIMULATION/TRAINING CENTER
REPLACEMENT
AUDIOVISUAL - FLOOR PLAN - AREA A

SCALE: AS NOTED
EPROJECT NO.:
CONSTR. CONTR. NO.
N40085-20-C-0059
NAVFAC DRAWING NO.

SHEET OF

TA111

D

C

B

A

UNCLASSIFIED

FILE NAME: BIM 360/HF PACKAGE 3P1338_MEF SIM CTR-150082-T.v4
PLOTTED: 6/9/2021 6:52:15 AM

UNCLASSIFIED


1

2

3

4

5

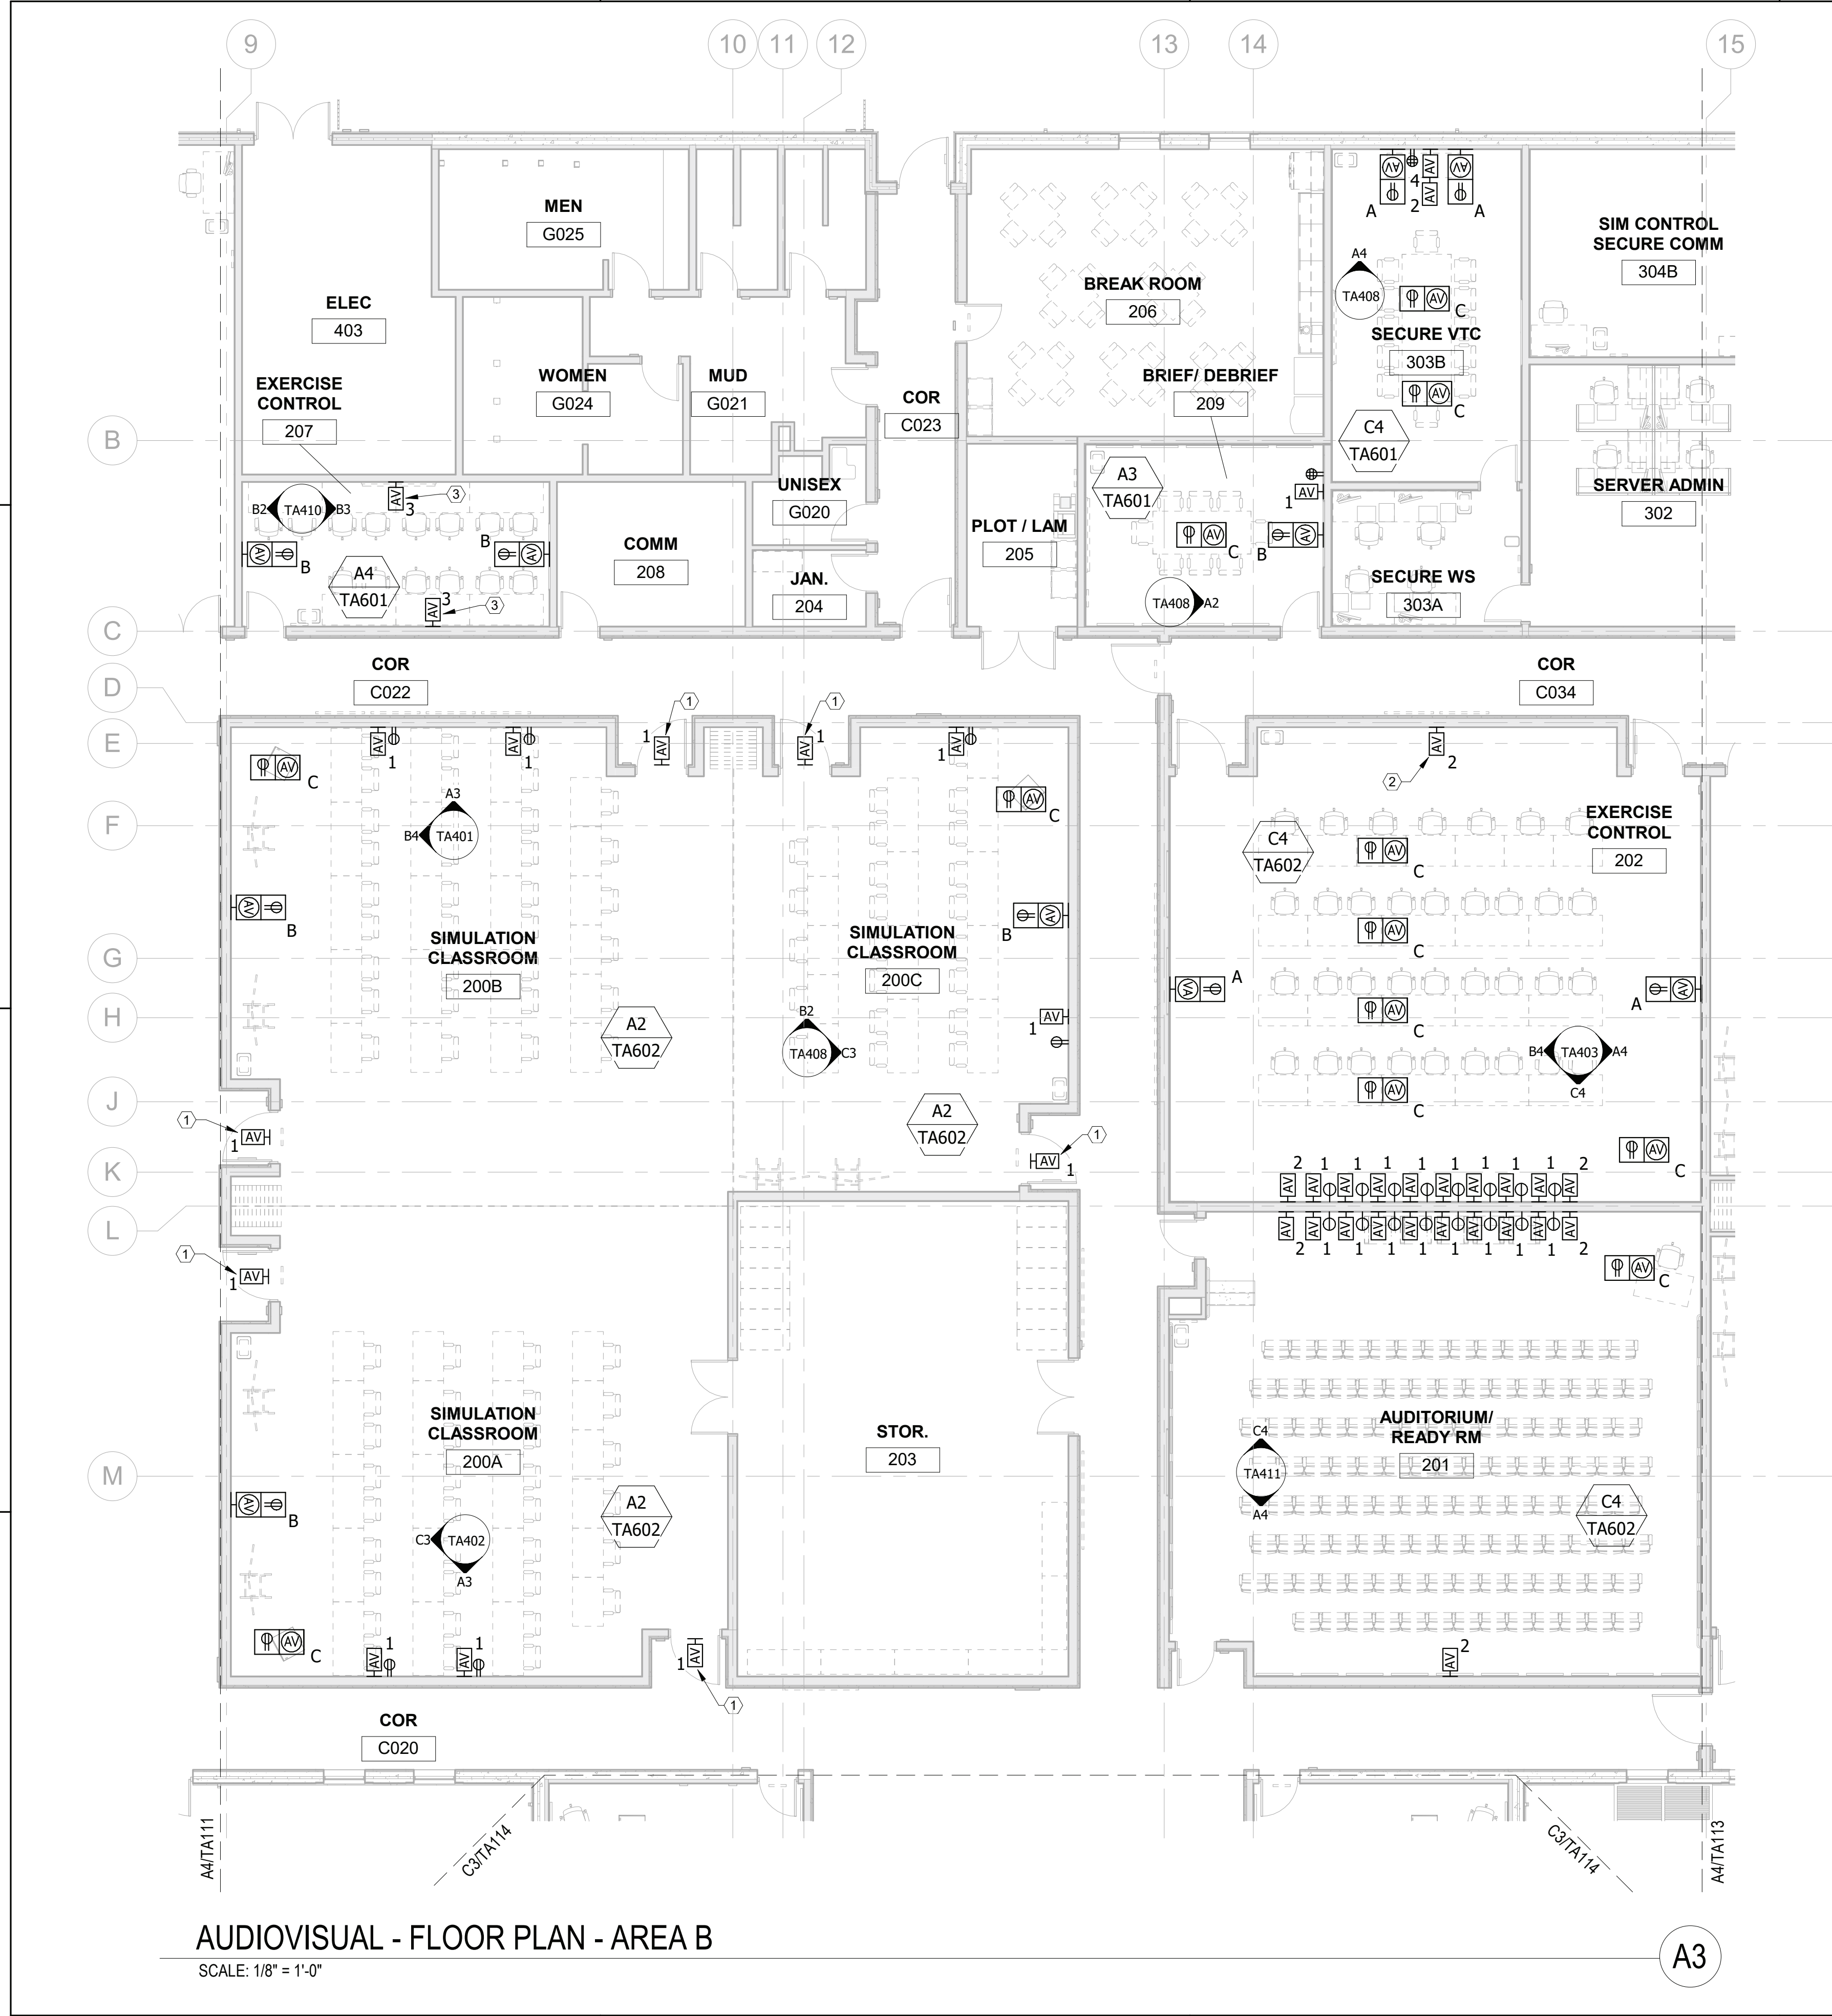


AUDIOVISUAL - FLOOR PLAN - AREA B
SCALE: 1/8" = 1'-0"

KEYNOTE LEGEND

- | | |
|---|---|
| 1 | ONE GANG AV BACK BOX FOR ROOM AVAILABILITY SIGNAGE. MOUNT CENTERED ON DOOR, AT 92" AFF. |
| 2 | 114" AFF |
| 3 | 18" AFF, COORDINATE FINAL LOCATION WITH ELECTRICAL AND TELECOM PRIOR TO INSTALLATION. |

KEYPLAN

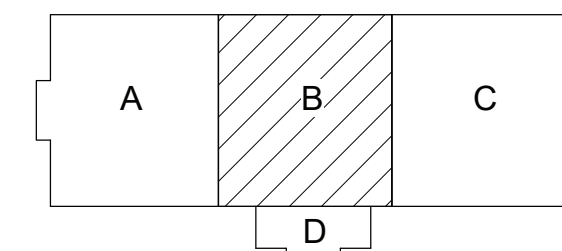

0 48" 96" 192"
SCALE: 1/8" = 12"


--	--	
DP2 SUBMISSION - P1338 BUILDING PRE-FINAL SUBMISSION

UNCLASSIFIED

FILE NAME: BIM 360/HF PACKAGE 3P1338_MEF SIM CTR-1500802-T-14
PLOTTED: 09/20/21 6:52:17 AM




DP2 SUBMISSION - P1338 BUILDING PRE-FINAL SUBMISSION

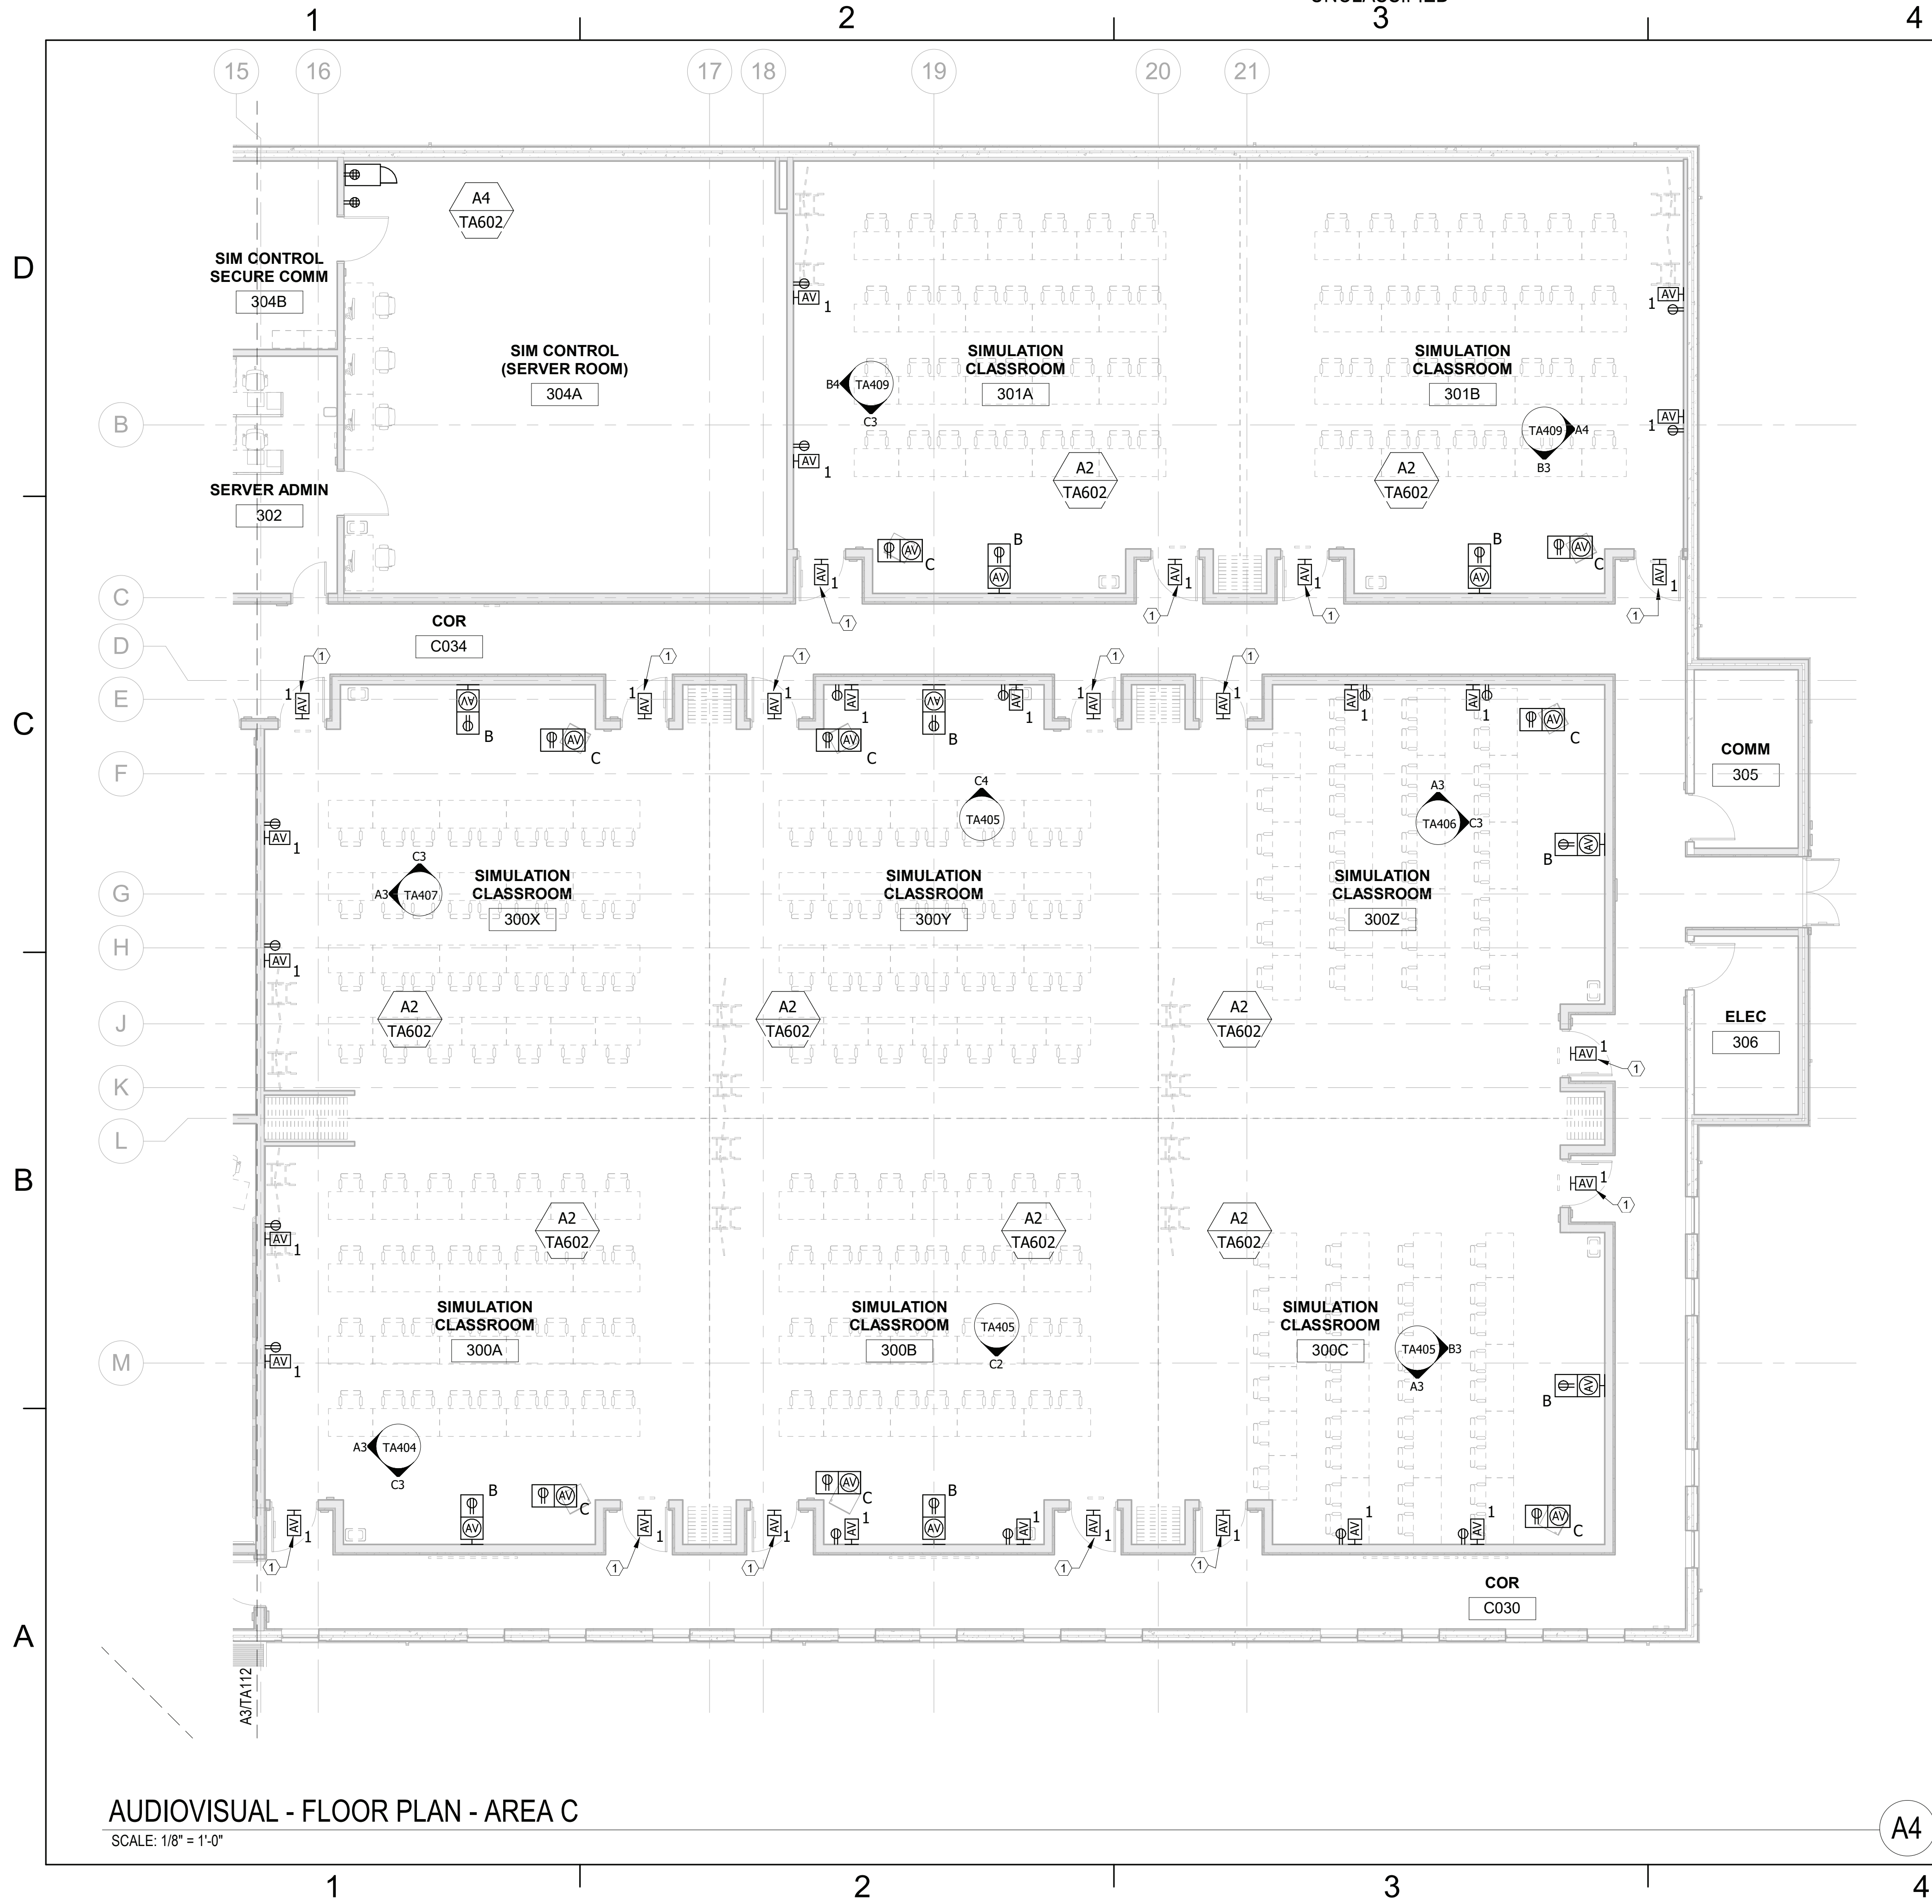

AUDIOVISUAL - FLOOR PLAN - AREA C
SCALE: 1/8" = 1'-0"

KEYNOTE LEGEND	
1	ONE GANG AV BACK BOX FOR ROOM AVAILABILITY SIGNAGE. MOUNT CENTERED ON DOOR, AT 92" AFF.

 KEYPLAN

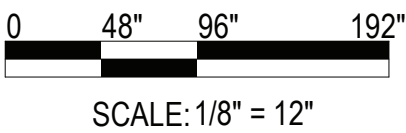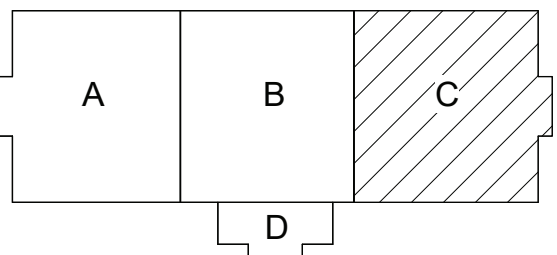

UNCLASSIFIED	
NAVFAC	
PRELIMINARY NOT FOR CONSTRUCTION	
RQ WJM Jordan COMPANY - A JOINT VENTURE -	
Michael Baker INTERNATIONAL 100 AIRSIDE DRIVE MOON TOWNSHIP, PA 15108 APPROVED	
FOR COMMANDER NAVFAC	
ACTIVITY MARINE CORPS BASE CAMP LEJEUNE	
SATISFACTORY TO DATE	
DES AS	DRW AV
CHK BM	
PM	
BRANCH MANAGER	
CHIEF ENGINEER	
FIRE PROTECTION	
NAVAL FACILITIES ENGINEERING COMMAND NAVAL FACILITIES ENGINEERING COMMAND ~ MID-ATLANTIC ROIC FLORENCE CAMP LEJEUNE MOB CAMP LEJEUNE JACKSONVILLE, NC P1338F II MEF SIMULATION/TRAINING CENTER REPLACEMENT AUDIOVISUAL - FLOOR PLAN - AREA C	
SCALE: AS NOTED	
EPROJECT NO.:	
CONSTR. CONTR. NO. N400085-20-C-0059	
NAVFAC DRAWING NO.	
SHEET OF	
TA113	

FILE NAME: BIM 360//HF PACKAGE 3P1338_MEF SIM CTR-1500892-T.v4
PLOTTED: 6/9/2021 6:52:18 AM

D


C

B

A

UNCLASSIFIED

UNCLASSIFIED

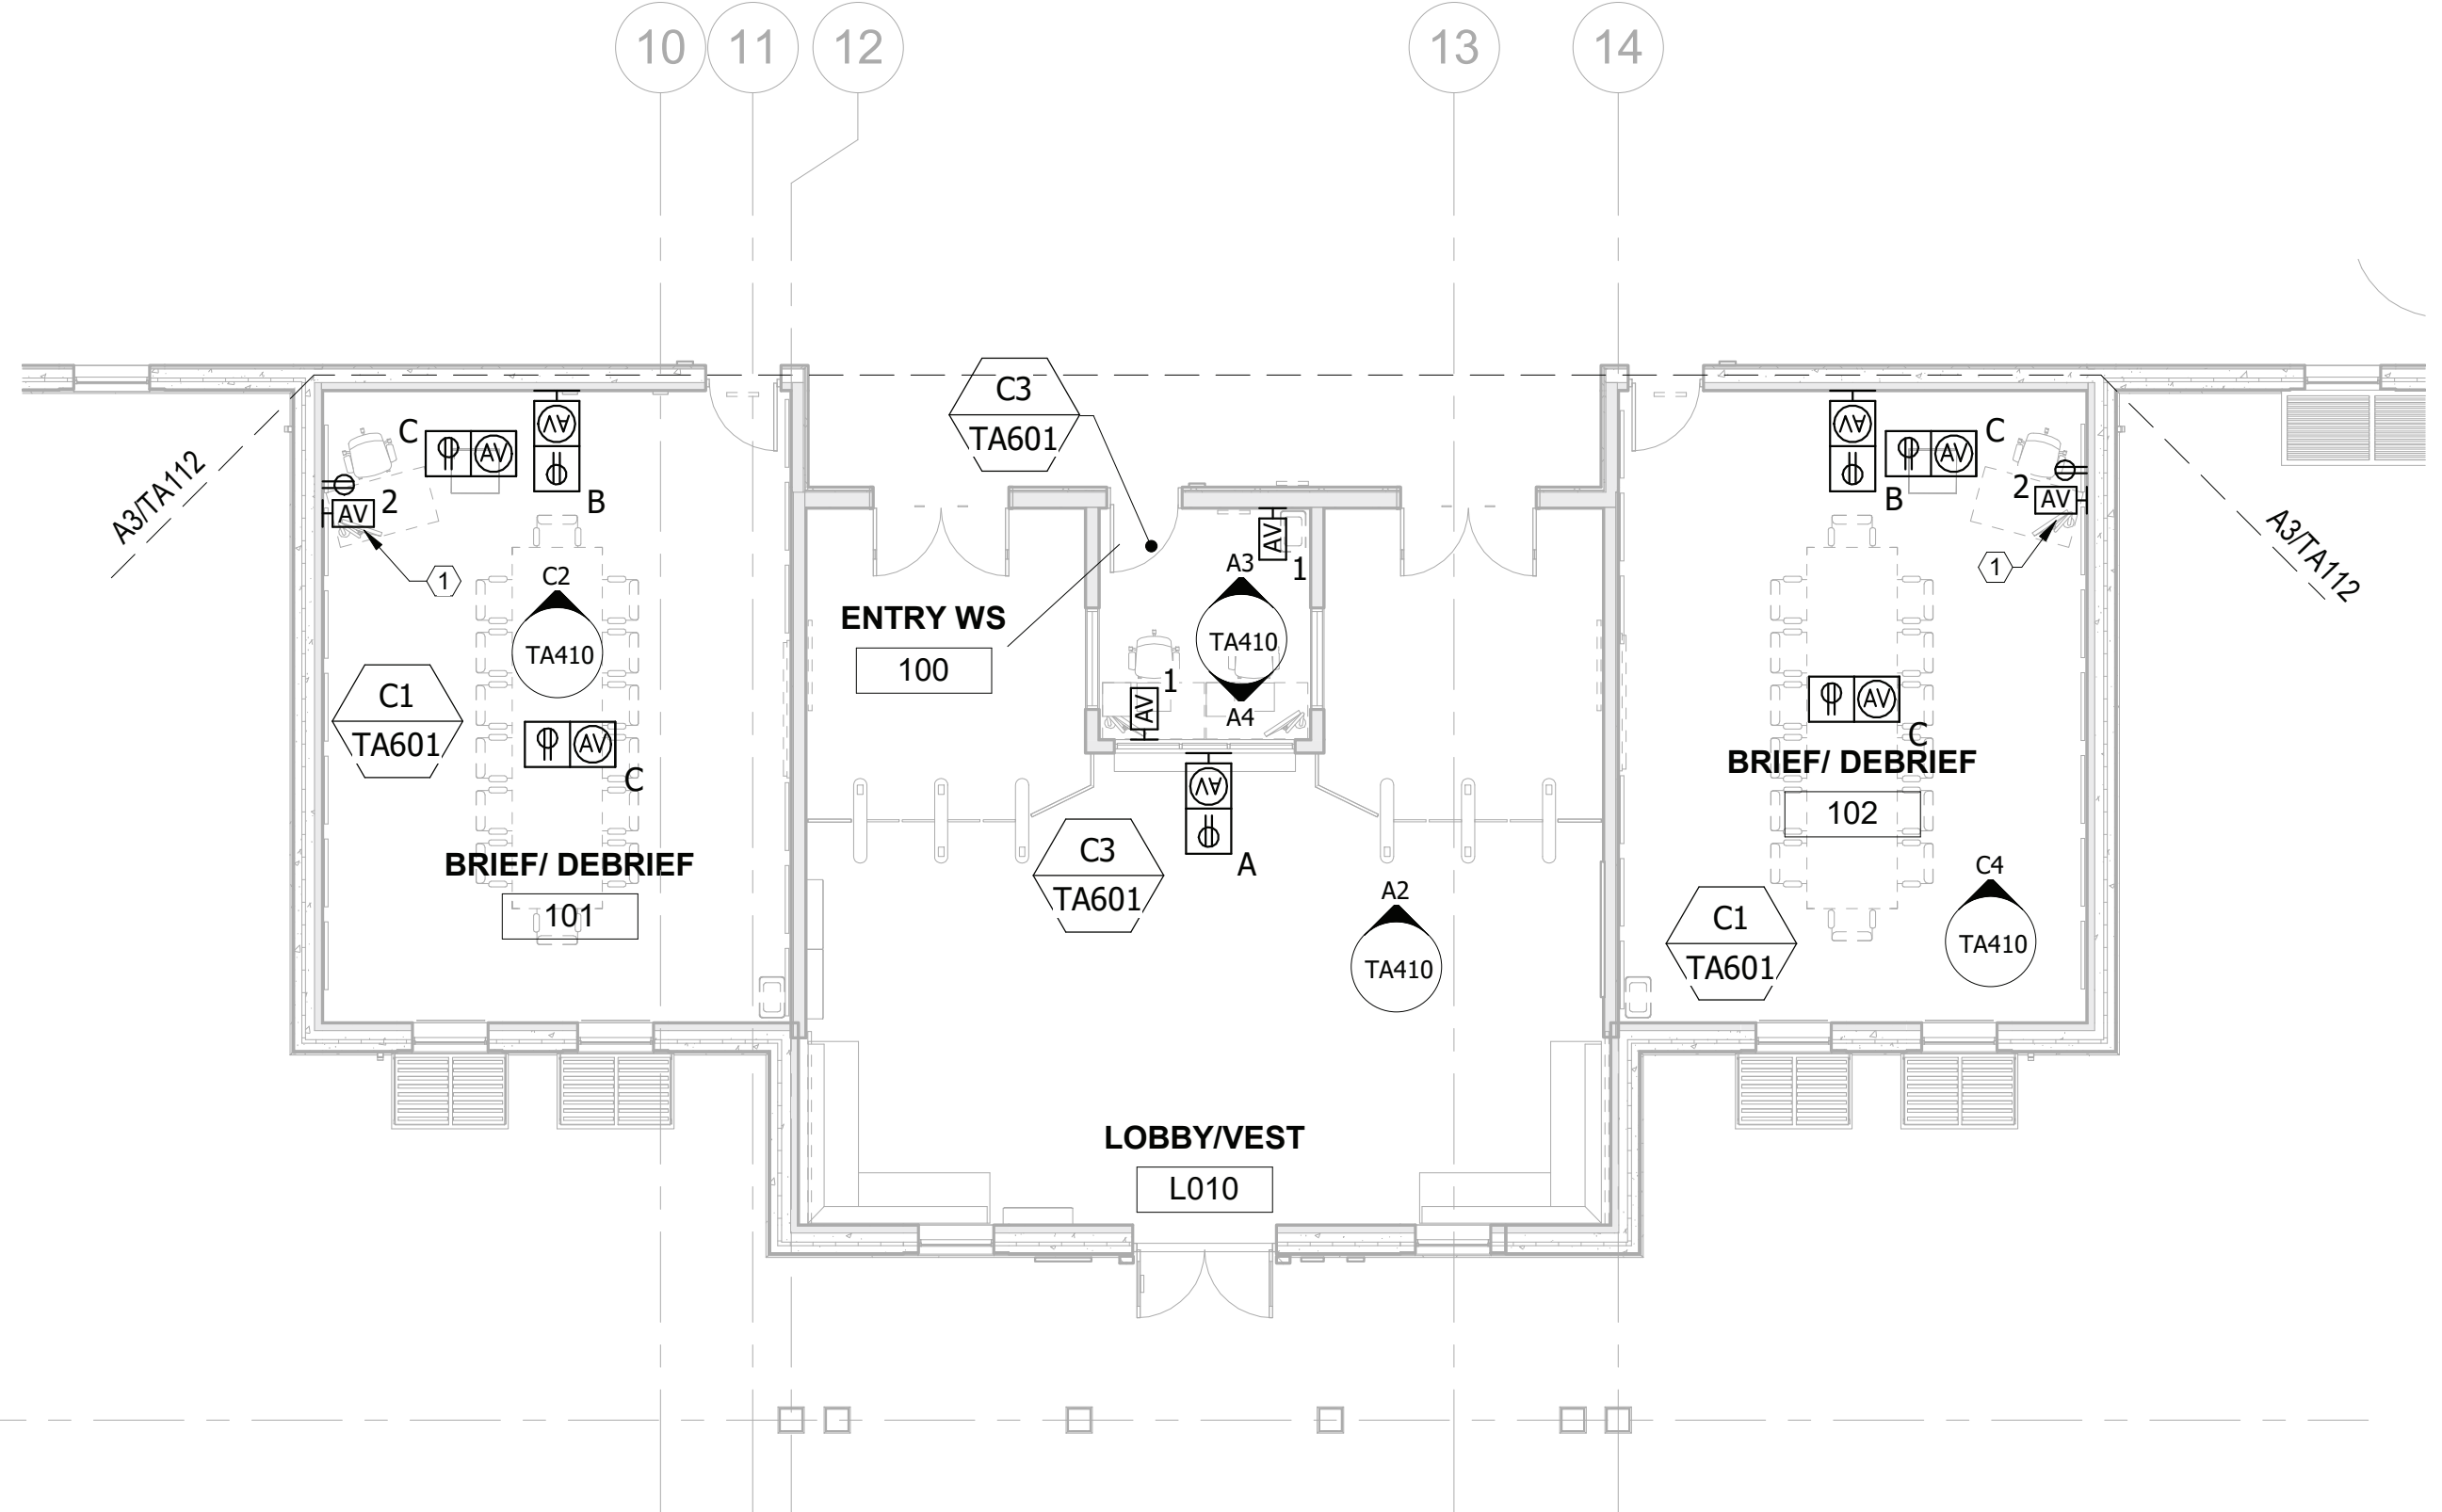

AUDIOVISUAL - FLOOR PLAN - AREA D

SCALE: 1/8" = 1'-0"

C3

KEYNOTE LEGEND

1 18" AFF, COORDINATE FINAL LOCATION WITH ELECTRICAL AND TELECOM PRIOR TO INSTALLATION.



PRELIMINARY
NOT FOR CONSTRUCTION



Michael Baker
INTERNATIONAL

100 AIRSIDE DRIVE
MOON TOWNSHIP, PA 15108
APPROVED

FOR COMMANDER NAVFAC

ACTIVITY
MARINE CORPS BASE
CAMP LEJEUNE

SATISFACTORY TO DATE

DES AS DRW AV CHK BM

PM

BRANCH MANAGER

CHIEF ENGINEER

FIRE PROTECTION

NAVAL FACILITIES ENGINEERING COMMAND
NAVAL FACILITIES ENGINEERING COMMAND ~ MID-ATLANTIC
ROICC FLORENCE CAMP LEJEUNE
MOB CAMP LEJEUNE
JACKSONVILLE, NC
P1338F II MEF SIMULATION/TRAINING CENTER
REPLACEMENT
AUDIOVISUAL - FLOOR PLAN - AREA D

DEPARTMENT OF THE NAVY

NAVAL FACILITIES ENGINEERING COMMAND ~ MID-ATLANTIC
ROICC FLORENCE CAMP LEJEUNE
MOB CAMP LEJEUNE
JACKSONVILLE, NC
P1338F II MEF SIMULATION/TRAINING CENTER
REPLACEMENT
AUDIOVISUAL - FLOOR PLAN - AREA D

NAVAL FACILITIES ENGINEERING COMMAND ~ MID-ATLANTIC
ROICC FLORENCE CAMP LEJEUNE
MOB CAMP LEJEUNE
JACKSONVILLE, NC
P1338F II MEF SIMULATION/TRAINING CENTER
REPLACEMENT
AUDIOVISUAL - FLOOR PLAN - AREA D

NAVAL FACILITIES ENGINEERING COMMAND ~ MID-ATLANTIC
ROICC FLORENCE CAMP LEJEUNE
MOB CAMP LEJEUNE
JACKSONVILLE, NC
P1338F II MEF SIMULATION/TRAINING CENTER
REPLACEMENT
AUDIOVISUAL - FLOOR PLAN - AREA D

NAVAL FACILITIES ENGINEERING COMMAND ~ MID-ATLANTIC
ROICC FLORENCE CAMP LEJEUNE
MOB CAMP LEJEUNE
JACKSONVILLE, NC
P1338F II MEF SIMULATION/TRAINING CENTER
REPLACEMENT
AUDIOVISUAL - FLOOR PLAN - AREA D

NAVAL FACILITIES ENGINEERING COMMAND ~ MID-ATLANTIC
ROICC FLORENCE CAMP LEJEUNE
MOB CAMP LEJEUNE
JACKSONVILLE, NC
P1338F II MEF SIMULATION/TRAINING CENTER
REPLACEMENT
AUDIOVISUAL - FLOOR PLAN - AREA D

NAVAL FACILITIES ENGINEERING COMMAND ~ MID-ATLANTIC
ROICC FLORENCE CAMP LEJEUNE
MOB CAMP LEJEUNE
JACKSONVILLE, NC
P1338F II MEF SIMULATION/TRAINING CENTER
REPLACEMENT
AUDIOVISUAL - FLOOR PLAN - AREA D

NAVAL FACILITIES ENGINEERING COMMAND ~ MID-ATLANTIC
ROICC FLORENCE CAMP LEJEUNE
MOB CAMP LEJEUNE
JACKSONVILLE, NC
P1338F II MEF SIMULATION/TRAINING CENTER
REPLACEMENT
AUDIOVISUAL - FLOOR PLAN - AREA D

NAVAL FACILITIES ENGINEERING COMMAND ~ MID-ATLANTIC
ROICC FLORENCE CAMP LEJEUNE
MOB CAMP LEJEUNE
JACKSONVILLE, NC
P1338F II MEF SIMULATION/TRAINING CENTER
REPLACEMENT
AUDIOVISUAL - FLOOR PLAN - AREA D

NAVAL FACILITIES ENGINEERING COMMAND ~ MID-ATLANTIC
ROICC FLORENCE CAMP LEJEUNE
MOB CAMP LEJEUNE
JACKSONVILLE, NC
P1338F II MEF SIMULATION/TRAINING CENTER
REPLACEMENT
AUDIOVISUAL - FLOOR PLAN - AREA D

NAVAL FACILITIES ENGINEERING COMMAND ~ MID-ATLANTIC
ROICC FLORENCE CAMP LEJEUNE
MOB CAMP LEJEUNE
JACKSONVILLE, NC
P1338F II MEF SIMULATION/TRAINING CENTER
REPLACEMENT
AUDIOVISUAL - FLOOR PLAN - AREA D

NAVAL FACILITIES ENGINEERING COMMAND ~ MID-ATLANTIC
ROICC FLORENCE CAMP LEJEUNE
MOB CAMP LEJEUNE
JACKSONVILLE, NC
P1338F II MEF SIMULATION/TRAINING CENTER
REPLACEMENT
AUDIOVISUAL - FLOOR PLAN - AREA D

NAVAL FACILITIES ENGINEERING COMMAND ~ MID-ATLANTIC
ROICC FLORENCE CAMP LEJEUNE
MOB CAMP LEJEUNE
JACKSONVILLE, NC
P1338F II MEF SIMULATION/TRAINING CENTER
REPLACEMENT
AUDIOVISUAL - FLOOR PLAN - AREA D

NAVAL FACILITIES ENGINEERING COMMAND ~ MID-ATLANTIC
ROICC FLORENCE CAMP LEJEUNE
MOB CAMP LEJEUNE
JACKSONVILLE, NC
P1338F II MEF SIMULATION/TRAINING CENTER
REPLACEMENT
AUDIOVISUAL - FLOOR PLAN - AREA D

NAVAL FACILITIES ENGINEERING COMMAND ~ MID-ATLANTIC
ROICC FLORENCE CAMP LEJEUNE
MOB CAMP LEJEUNE
JACKSONVILLE, NC
P1338F II MEF SIMULATION/TRAINING CENTER
REPLACEMENT
AUDIOVISUAL - FLOOR PLAN - AREA D

NAVAL FACILITIES ENGINEERING COMMAND ~ MID-ATLANTIC
ROICC FLORENCE CAMP LEJEUNE
MOB CAMP LEJEUNE
JACKSONVILLE, NC
P1338F II MEF SIMULATION/TRAINING CENTER
REPLACEMENT
AUDIOVISUAL - FLOOR PLAN - AREA D


NAVAL FACILITIES ENGINEERING COMMAND ~ MID-ATLANTIC
ROICC FLORENCE CAMP LEJEUNE
MOB CAMP LEJEUNE
JACKSONVILLE, NC
P1338F II MEF SIMULATION/TRAINING CENTER
REPLACEMENT
AUDIOVISUAL - FLOOR PLAN - AREA D

NAVAL FACILITIES ENGINEERING COMMAND ~ MID-ATLANTIC
ROICC FLORENCE CAMP LEJEUNE
MOB CAMP LEJEUNE
JACKSONVILLE, NC
P1338F II MEF SIMULATION/TRAINING CENTER
REPLACEMENT
AUDIOVISUAL - FLOOR PLAN - AREA D


NAVAL FACILITIES ENGINEERING COMMAND ~ MID-ATLANTIC
ROICC FLORENCE CAMP LEJEUNE
MOB CAMP LEJEUNE
JACKSONVILLE, NC
P1338F II MEF SIMULATION/TRAINING CENTER
REPLACEMENT
AUDIOVISUAL - FLOOR PLAN - AREA D

TA114

KEYPLAN

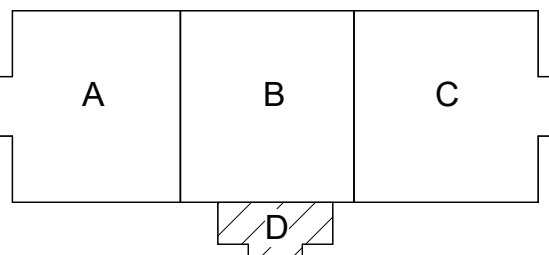

0 48" 96" 192"
SCALE: 1/8" = 12"

 

DP2 SUBMISSION - P1338 BUILDING PRE-FINAL SUBMISSION

UNCLASSIFIED

FILE NAME: BIM 360/HF PACKAGE 3P1338_MEF SIM CTR-1500802-T.rvt
PLOTTED: 6/9/2021 6:52:39 AM


UNCLASSIFIED




AUDIOVISUAL - REFLECTED CEILING PLAN - AREA B

SCALE: 1/8" = 1'-0"

KEYPLAN

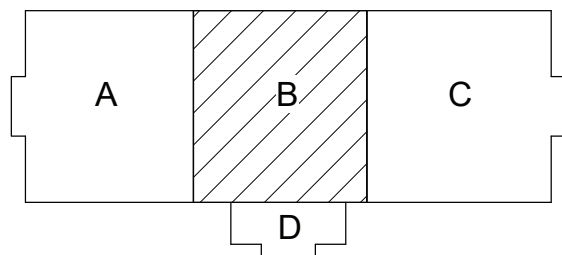

0 48" 96" 192"
SCALE: 1/8" = 12"

 


DATE	APPR
DESCRIPTION	SYN
PRELIMINARY Not for construction	
Michael Baker INTERNATIONAL 100 AIRSIDE DRIVE MOON TOWNSHIP, PA 15108 APPROVED	
FOR COMMANDER NAVFAC	
ACTIVITY MARINE CORPS BASE CAMP LEJEUNE	
SATISFACTORY TO DATE	
DES AS	DRW AV
PM	
BRANCH MANAGER	
CHIEF ENGINEER	
FIRE PROTECTION	
NAVAL FACILITIES ENGINEERING COMMAND NAVAL FACILITIES ENGINEERING COMMAND ~ MID-ATLANTIC ROICC FLORENCE CAMP LEJEUNE MCB CAMP LEJEUNE JACKSONVILLE, NC P1338F II MEF SIMULATION/TRAINING CENTER REPLACEMENT AUDIOVISUAL - REFLECTED CEILING PLAN - AREA B	
SCALE: AS NOTED	
EPROJECT NO.:	
CONSTR. CONTR. NO. N40085-20-C-0059	
NAVFAC DRAWING NO.	
SHEET	OF
TR112	


DP2 SUBMISSION - P1338 BUILDING PRE-FINAL SUBMISSION

UNCLASSIFIED

FILE NAME: BIM 360/HF PACKAGE 3P1338_MEF SIM CTR-1500822.Txd PLOTTED: 6/9/2021 6:52:40 AM

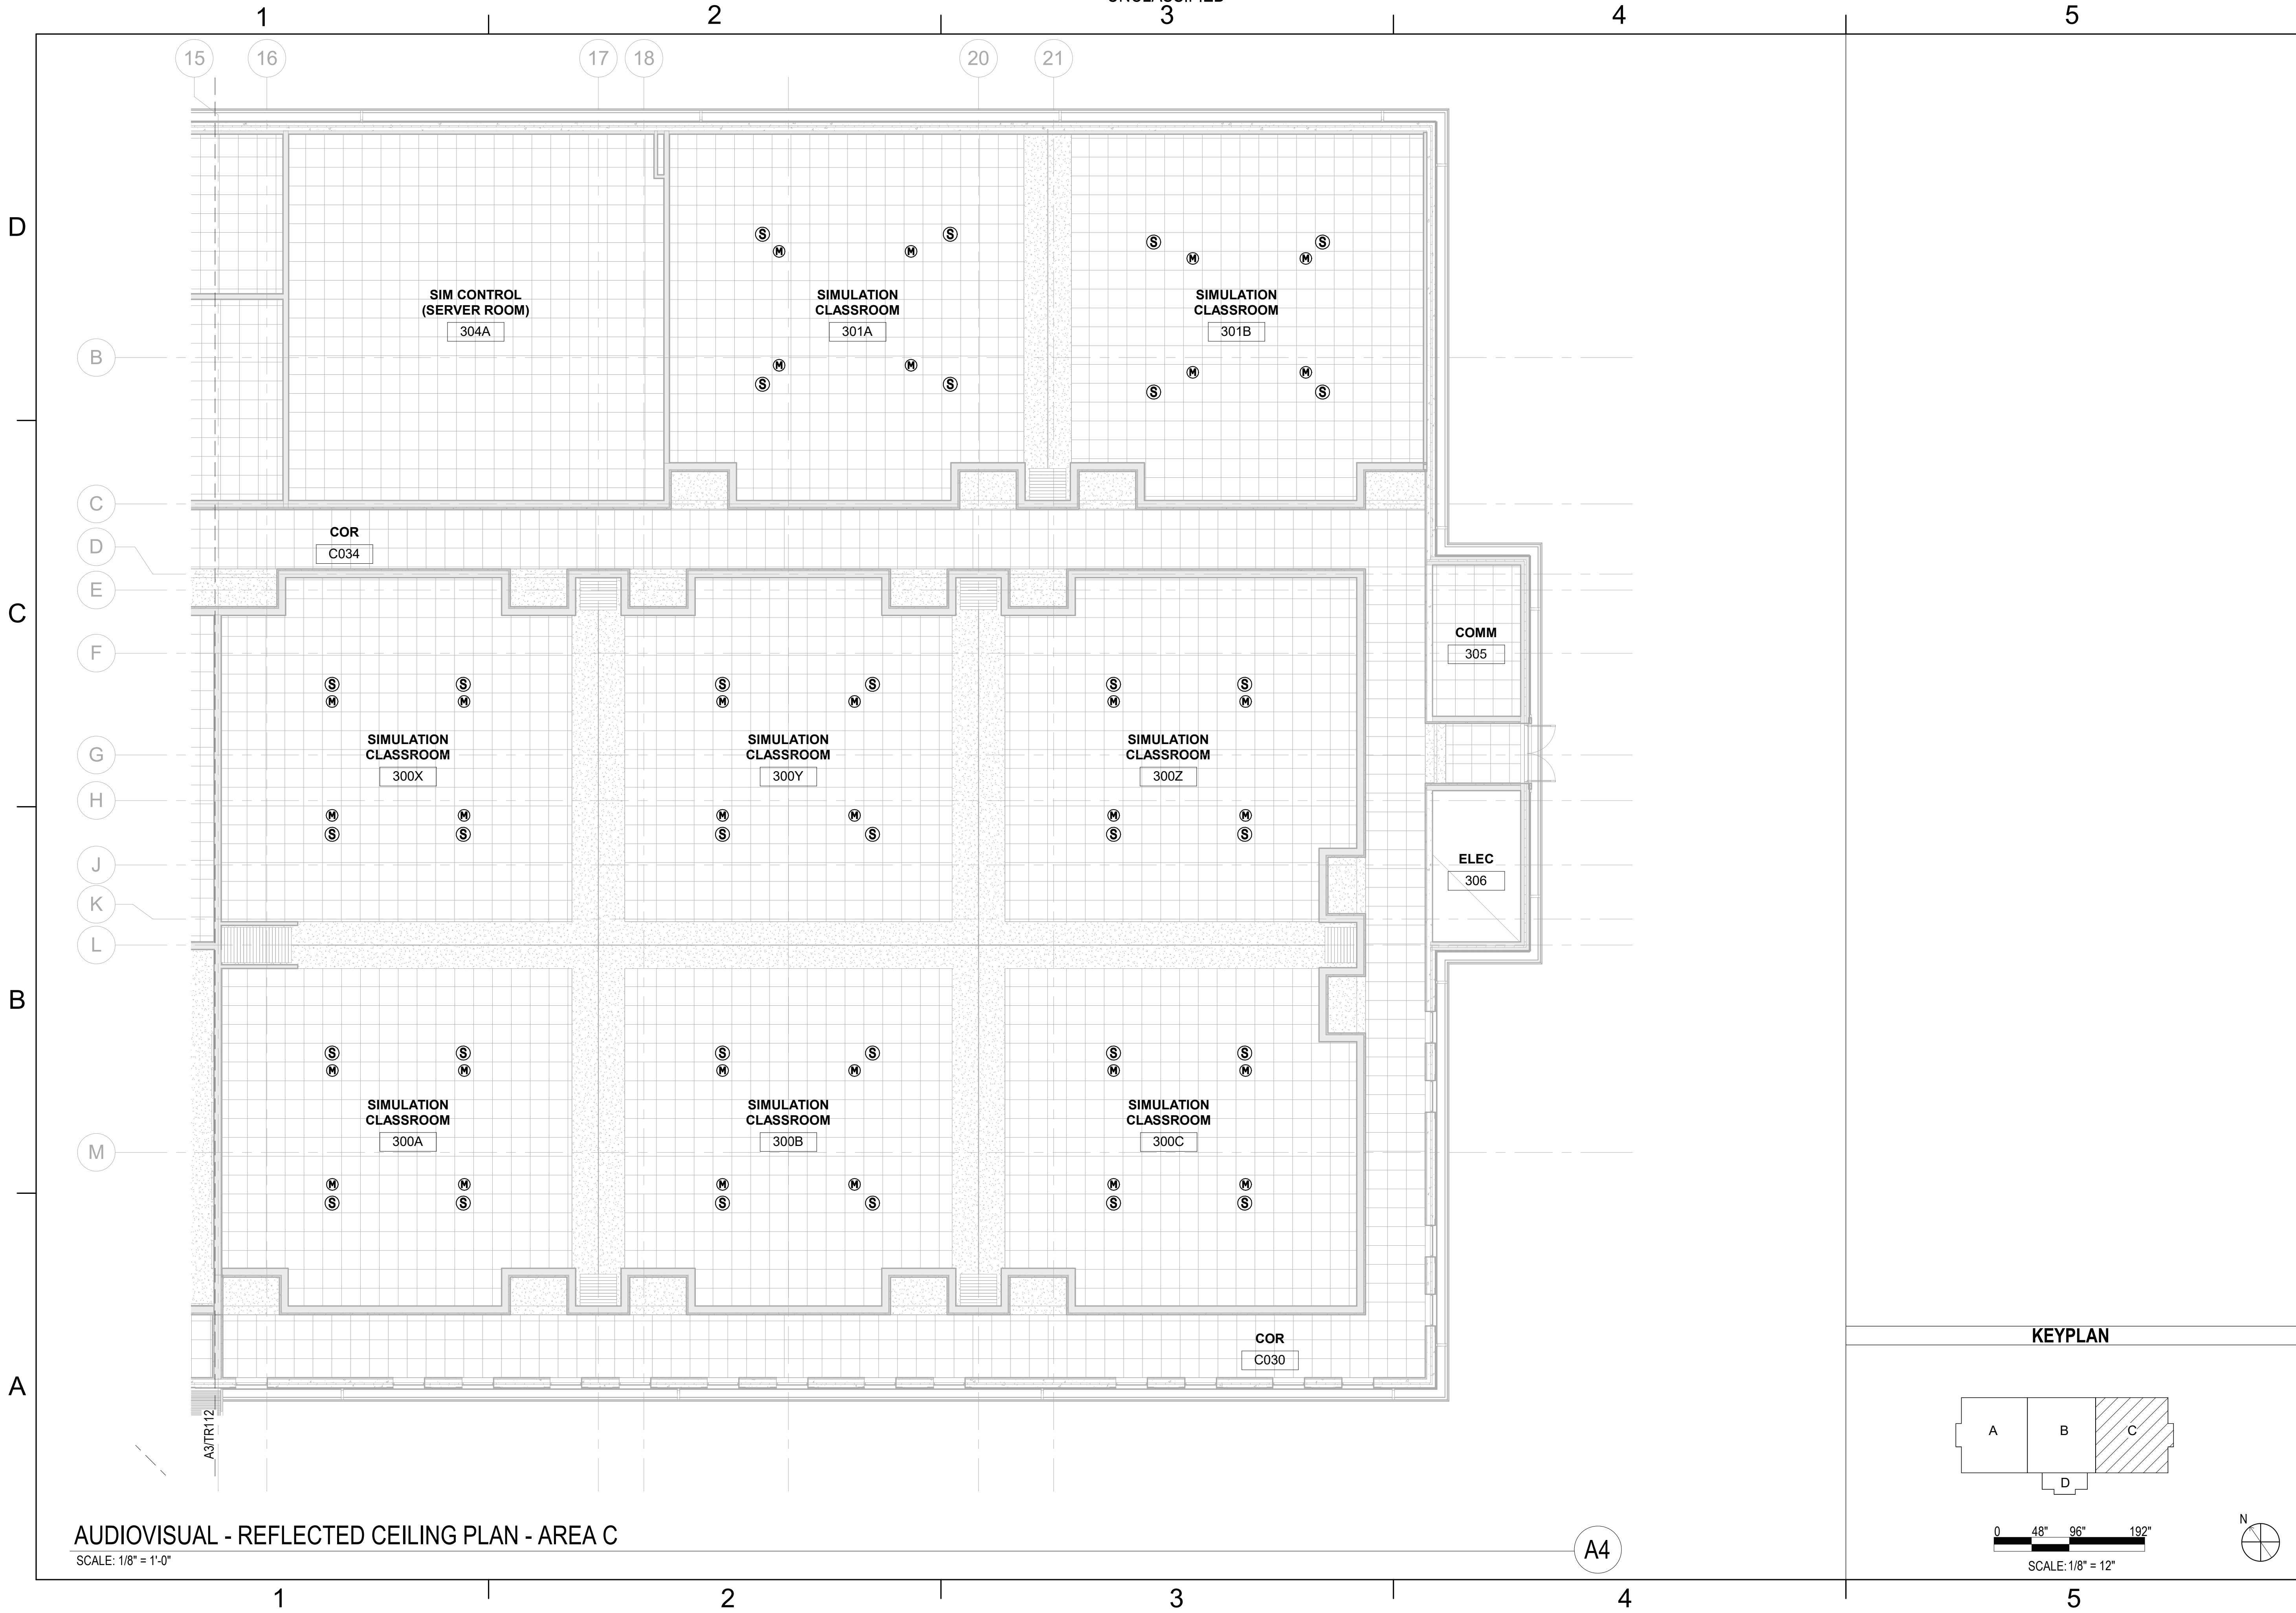


AUDIOVISUAL - REFLECTED CEILING PLAN - AREA C
SCALE: 1/8" = 1'-0"

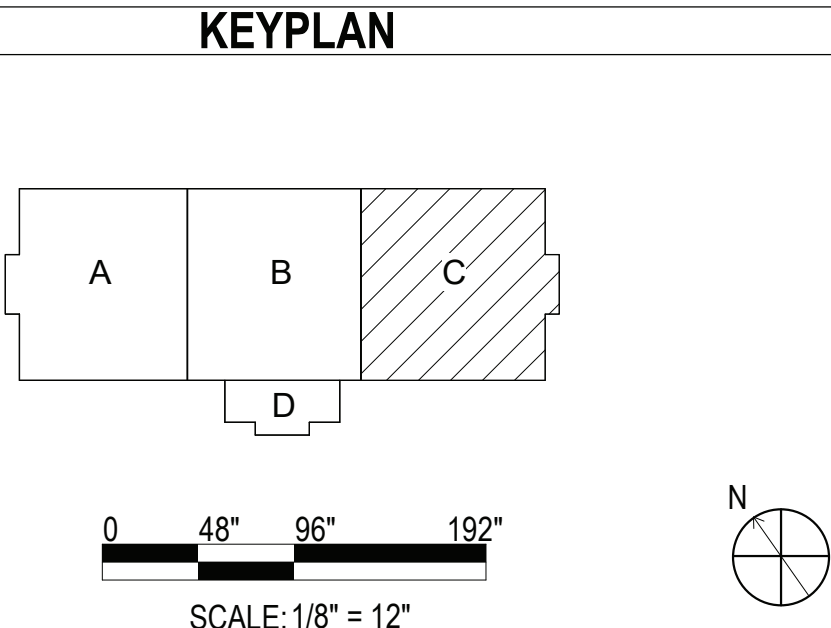


UNCLASSIFIED	
DATE	
SYN DESCRIPTION	
SEAL	
	
PRELIMINARY NOT FOR CONSTRUCTION	
	
Michael Baker INTERNATIONAL 100 AIRSIDE DRIVE MOON TOWNSHIP, PA 15108 APPROVED	
FOR COMMANDER NAVFAC	
ACTIVITY MARINE CORPS BASE CAMP LEJEUNE	
SATISFACTORY TO DATE	
DES AS	DRW AV
CHK BM	
PM	
BRANCH MANAGER	
CHIEF ENGINEER	
FIRE PROTECTION	
NAVAL FACILITIES ENGINEERING COMMAND NAVAL FACILITIES ENGINEERING COMMAND ~ MID-ATLANTIC ROSC FLORENCE CAMP LEJEUNE JACKSONVILLE, NC	
P1338F II MEF SIMULATION/TRAINING CENTER REPLACEMENT	
AUDIOVISUAL - REFLECTED CEILING PLAN - AREA C	
SCALE: AS NOTED	
EPROJECT NO.:	
CONSTR. CONTR. NO. N40085-20-C-0059	
NAVFAC DRAWING NO.	
SHEET	OF
TR113	

 
DP2 SUBMISSION - P1338 BUILDING PRE-FINAL SUBMISSION




SCALE: 1/8" = 1'-0"

 [illegible]

FILE NAME: BIM 360//HF PACKAGE 3P1338_MEF SIM CTR-1500802-T.v4
PLOTTED: 6/9/2021 6:52:22 AM

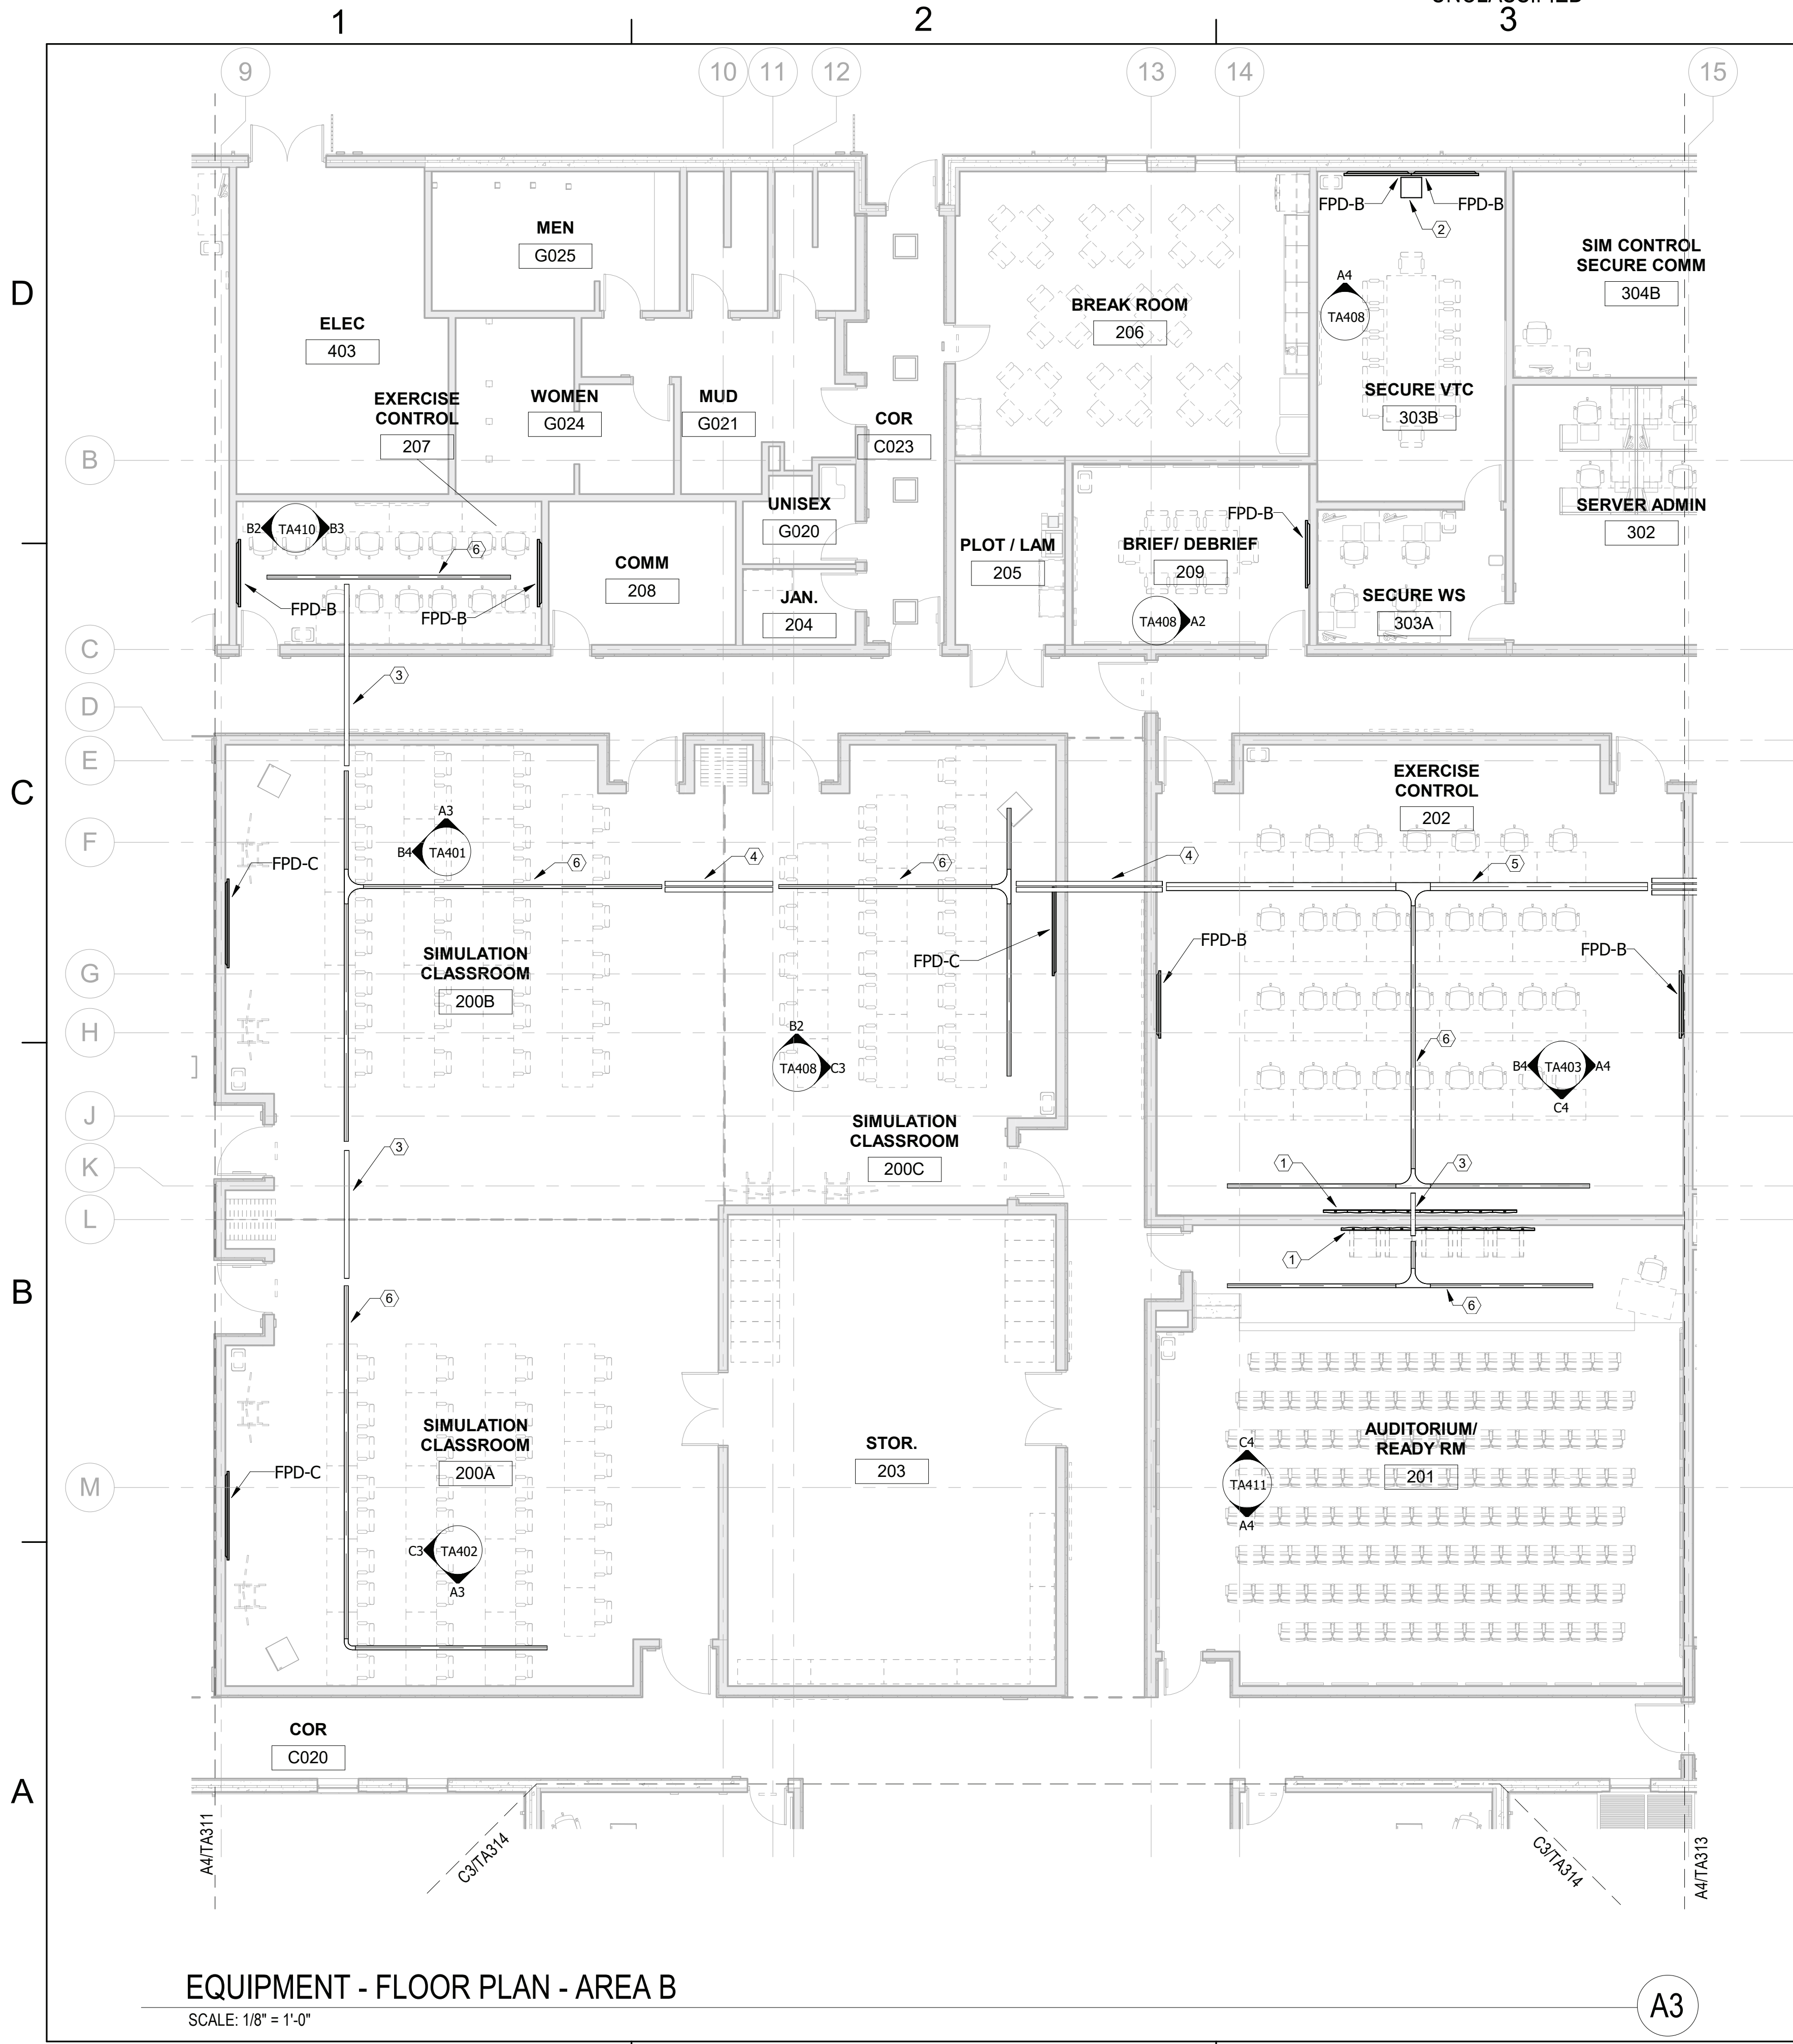


KEYNOTE LEGEND	
1	LED VIDEO WALL, PROVIDED BY AVC.
2	AUDIOVISUAL EQUIPMENT RACK, PROVIDED BY AVC.
3	PROVIDE ONE (1) 4" CONDUIT SLEEVES FOR HORIZONTAL CABLE DISTRIBUTION, REFER TO TELECOM DRAWINGS FOR INSTALLATION DETAILS.
4	PROVIDE TWO (2) 4" CONDUIT SLEEVES FOR HORIZONTAL CABLE DISTRIBUTION, REFER TO TELECOM DRAWINGS FOR INSTALLATION DETAILS.
5	PROVIDE 8" X 4" WIRE-BASKET TYPE CABLE TRAY MOUNTED ABOVE ACCESSIBLE CEILING; COORDINATE TRAY PLACEMENT WITH OTHER TRADES.
6	PROVIDE 4" X 4" WIRE-BASKET TYPE CABLE TRAY MOUNTED ABOVE ACCESSIBLE CEILING; COORDINATE TRAY PLACEMENT WITH OTHER TRADES.

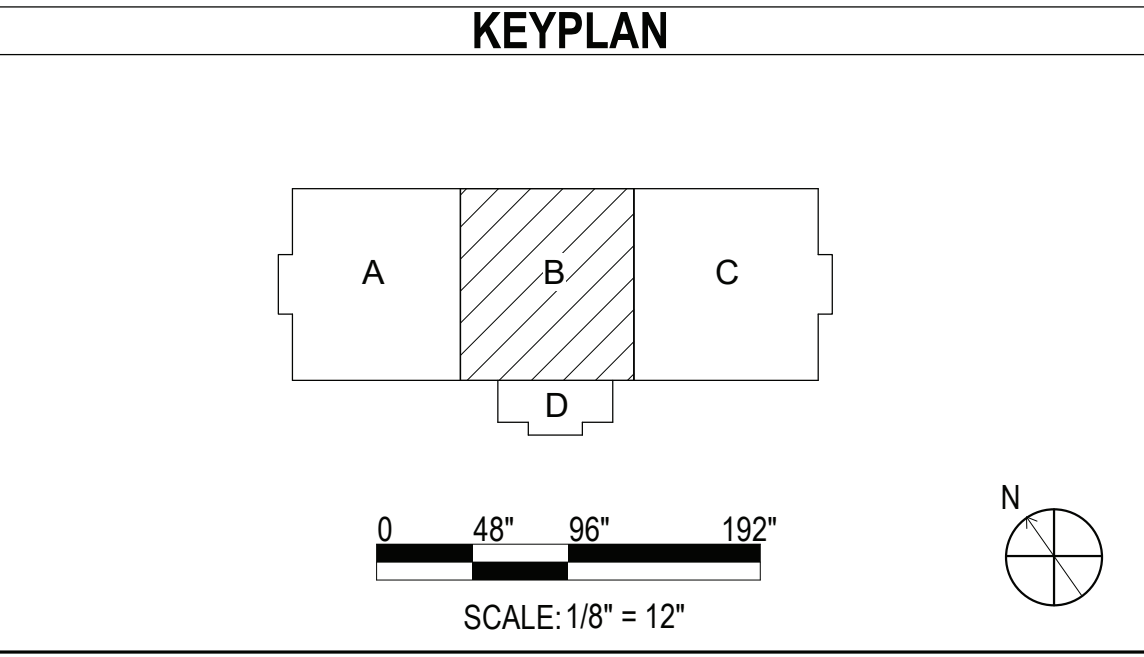

APPROVED	DATE	APPROVED
SYMBOL	DESCRIPTION	SYMBOL
PRELIMINARY NOT FOR CONSTRUCTION		
Michael Baker INTERNATIONAL 100 AIRSIDE DRIVE MOON TOWNSHIP, PA 15108 APPROVED		
FOR COMMANDER NAVFAC		
ACTIVITY MARINE CORPS BASE CAMP LEJEUNE		
SATISFACTORY TO DATE		
DES AS	DRW AV	CHK BM
PM		
BRANCH MANAGER		
CHIEF ENGINEER		
FIRE PROTECTION		
DEPARTMENT OF THE NAVY NAVAL FACILITIES ENGINEERING COMMAND ~ MID-ATLANTIC ROSC FLORENCE CAMP LEJEUNE MOB CAMP LEJEUNE JACKSONVILLE, NC P1338F II MEF SIMULATION/TRAINING CENTER REPLACEMENT EQUIPMENT - FLOOR PLAN - AREA B		
SCALE: AS NOTED		
EPROJECT NO.:		
CONSTR. CONTR. NO. N400085-20-C-0059		
NAVFAC DRAWING NO.		
SHEET OF		
TA312		

 DP2 SUBMISSION - P1338 BUILDING PRE-FINAL SUBMISSION



SCALE: 1/8" = 1'-0"

[illegible]

DP2 SUBMISSION - P1338 BUILDING PRE-FINAL SUBMISSION

UNCLASSIFIED


FILE NAME: BIM 360/HF PACKAGE 3P1338_MEF SIM CTR-1500802-T-01
PLOTTED: 6/9/2021 6:52:24 AM

D

C

B


A

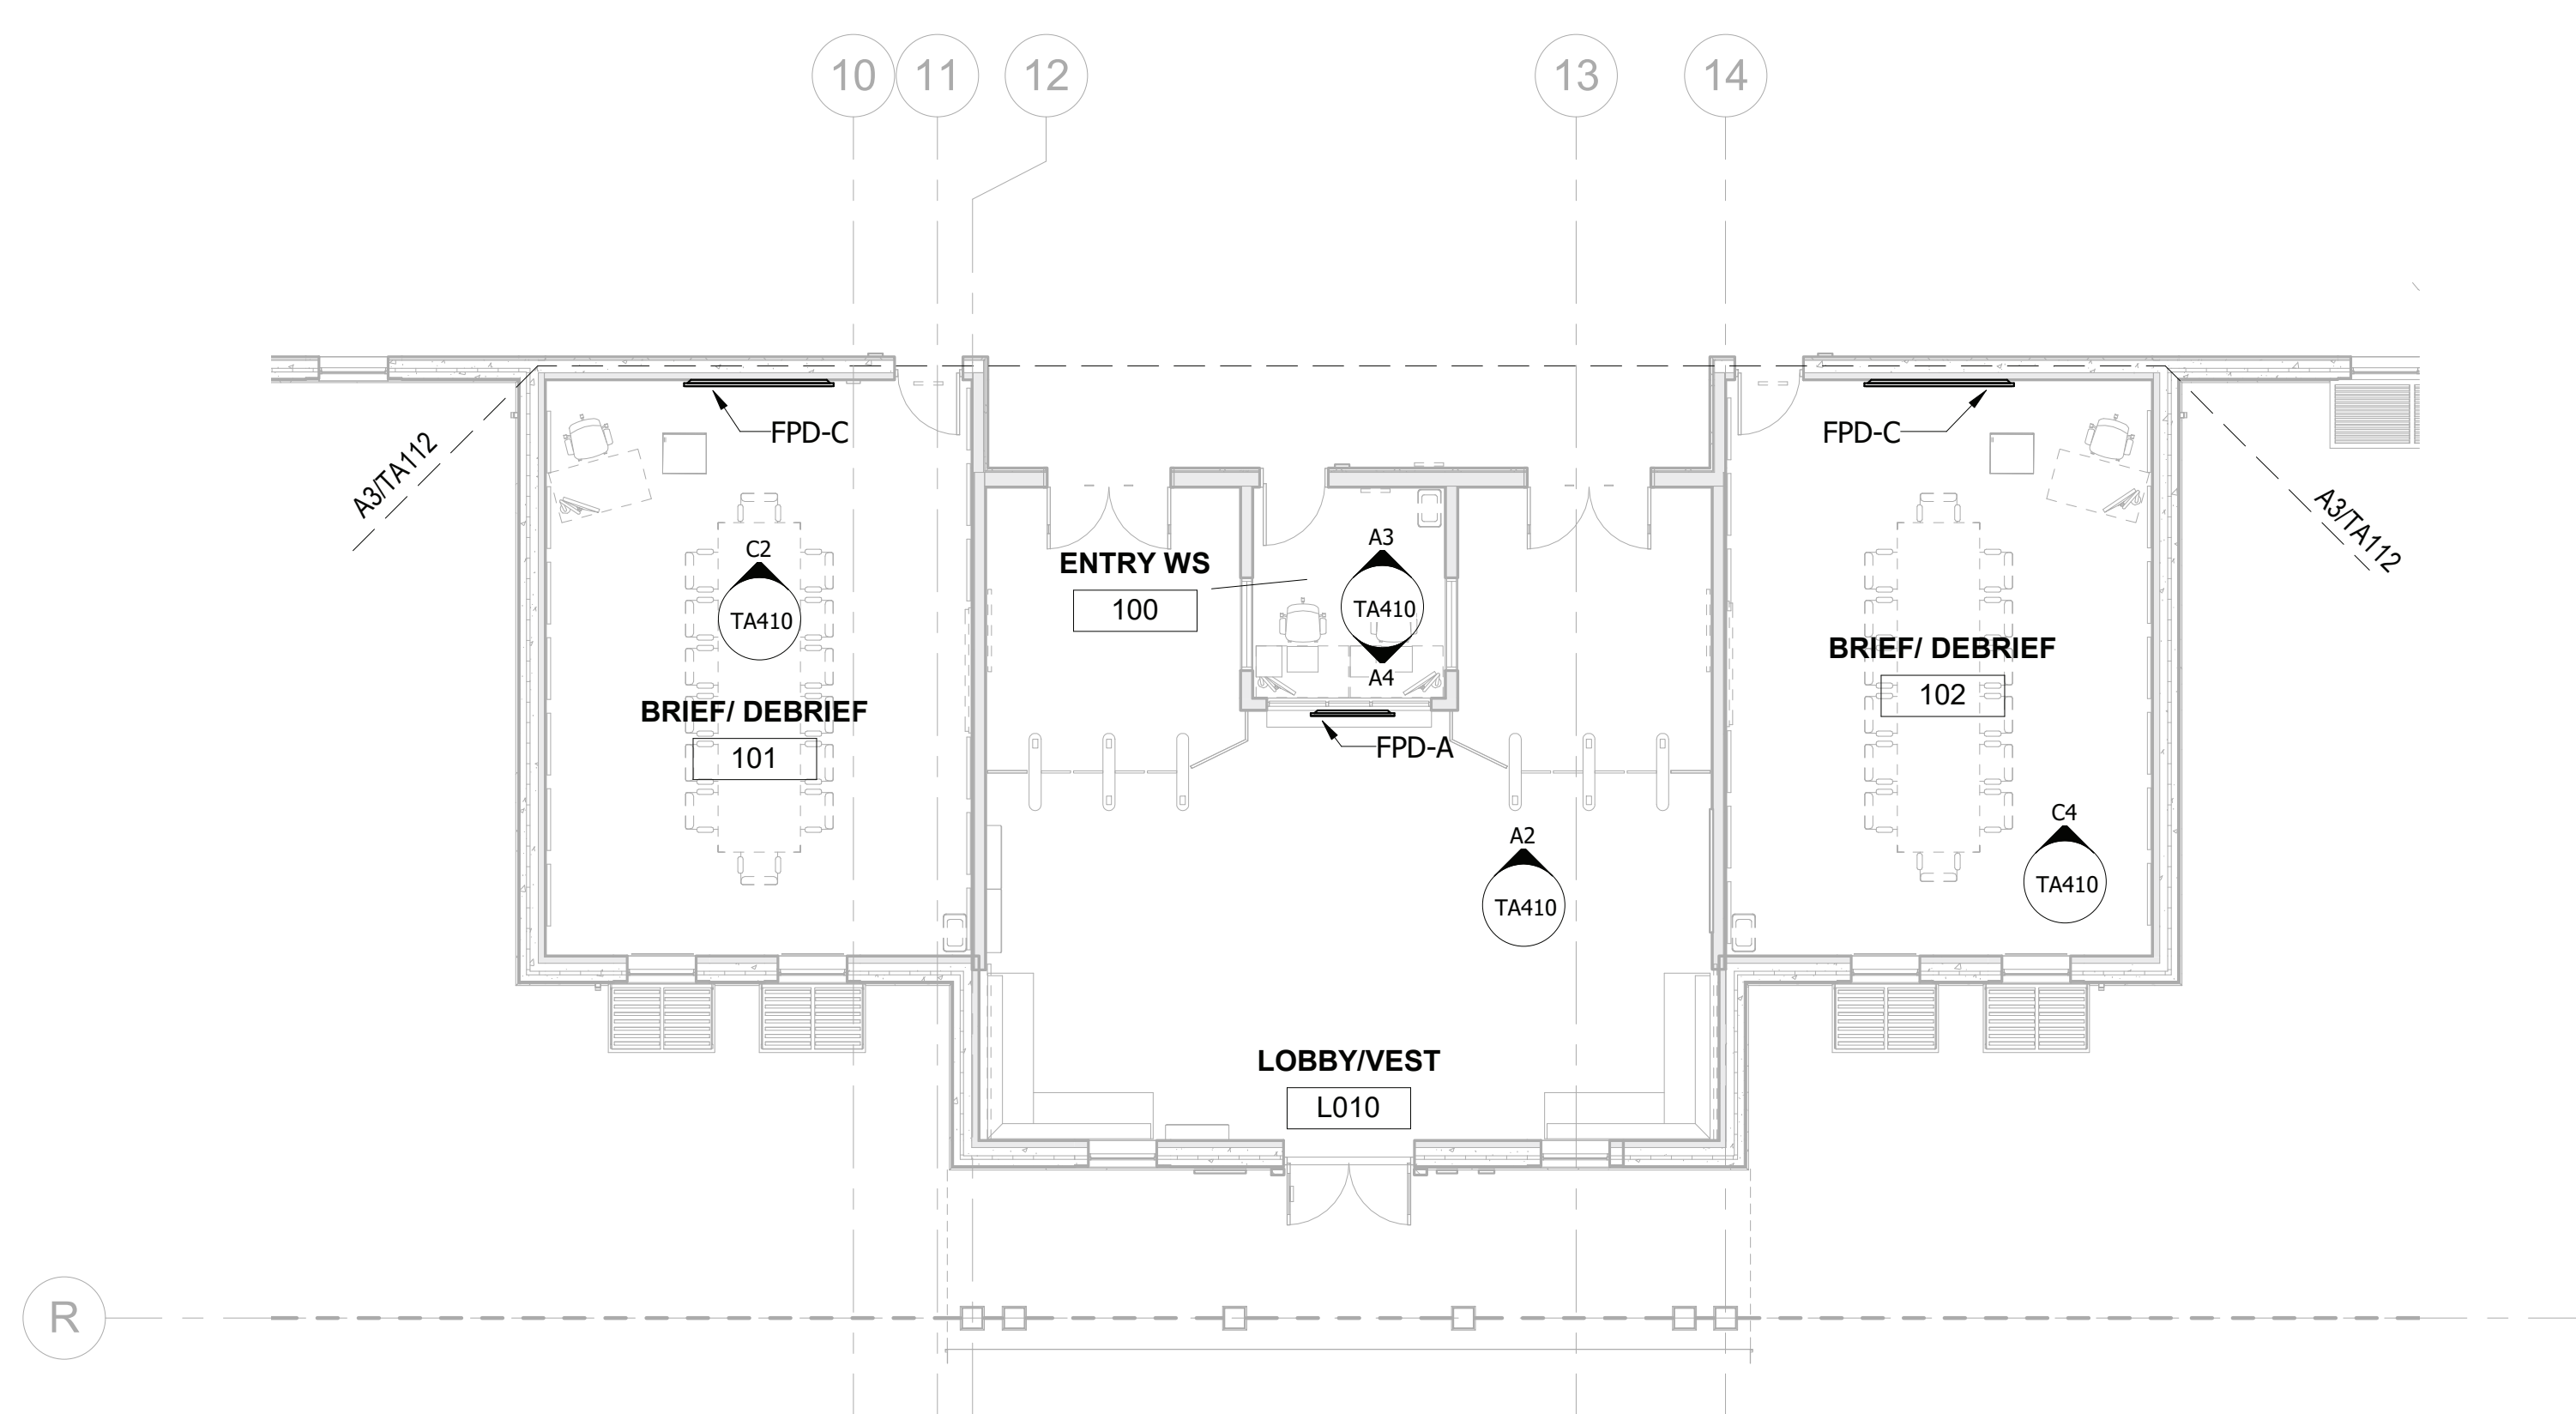

EQUIPMENT - FLOOR PLAN - AREA D
SCALE: 1/8" = 1'-0"

UNCLASSIFIED

UNCLASSIFIED

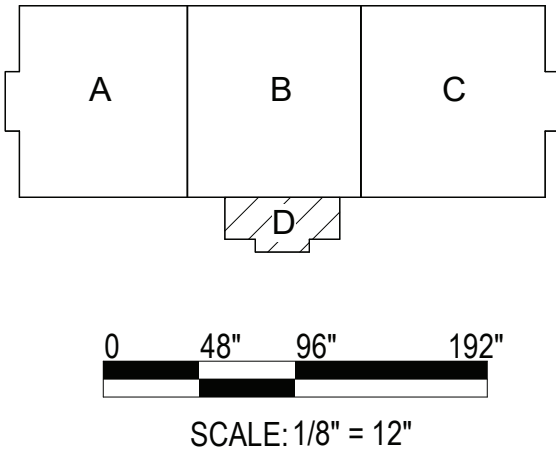

KEYPLAN

TA314

SHEET OF

NAVAC DRAWING NO.

N40085-20-C-0059

CONSTR. CONTR. NO.

EPROJECT NO.:

SCALE: AS NOTED

DEPARTMENT OF THE NAVY
NAVAL FACILITIES ENGINEERING COMMAND ~ MID-ATLANTIC
ROICC FLORENCE CAMP LEJEUNE
MOB CAMP LEJEUNE
JACKSONVILLE, NC
P1338F II MEF SIMULATION/TRAINING CENTER
REPLACEMENT
EQUIPMENT - FLOOR PLAN - AREA D
DP2 SUBMISSION - P1338 BUILDING PRE-FINAL SUBMISSION

FIRE PROTECTION
CHIEF ENGINEER
BRANCH MANAGER
PM
DES AS DRW AV CHK BM
SATISFACTORY TO DATE
MARINE CORPS BASE
CAMP LEJEUNE
ACTIVITY
FOR COMMANDER NAVFAC

APPROVED
100 AIRSIDE DRIVE
MOON TOWNSHIP, PA 15108
A/E INFO
Michael Baker
INTERNATIONAL
- A JOINT VENTURE -
WM Jordan
RQ COMPANY

PRELIMINARY
NOT FOR CONSTRUCTION
SEAL



SYN	DESCRIPTION	DATE	APPR

DP2 SUBMISSION - P1338 BUILDING PRE-FINAL SUBMISSION

UNCLASSIFIED

B

C

D

5

4

3

2

1

5

4

3

2

1


FILE NAME: BIM 360/HF PACKAGE 3P1338_MEF SIM CTR-1500B02-T.v4
PLOTTED: 6/9/2021 6:52:26 AM

D

C


B

A

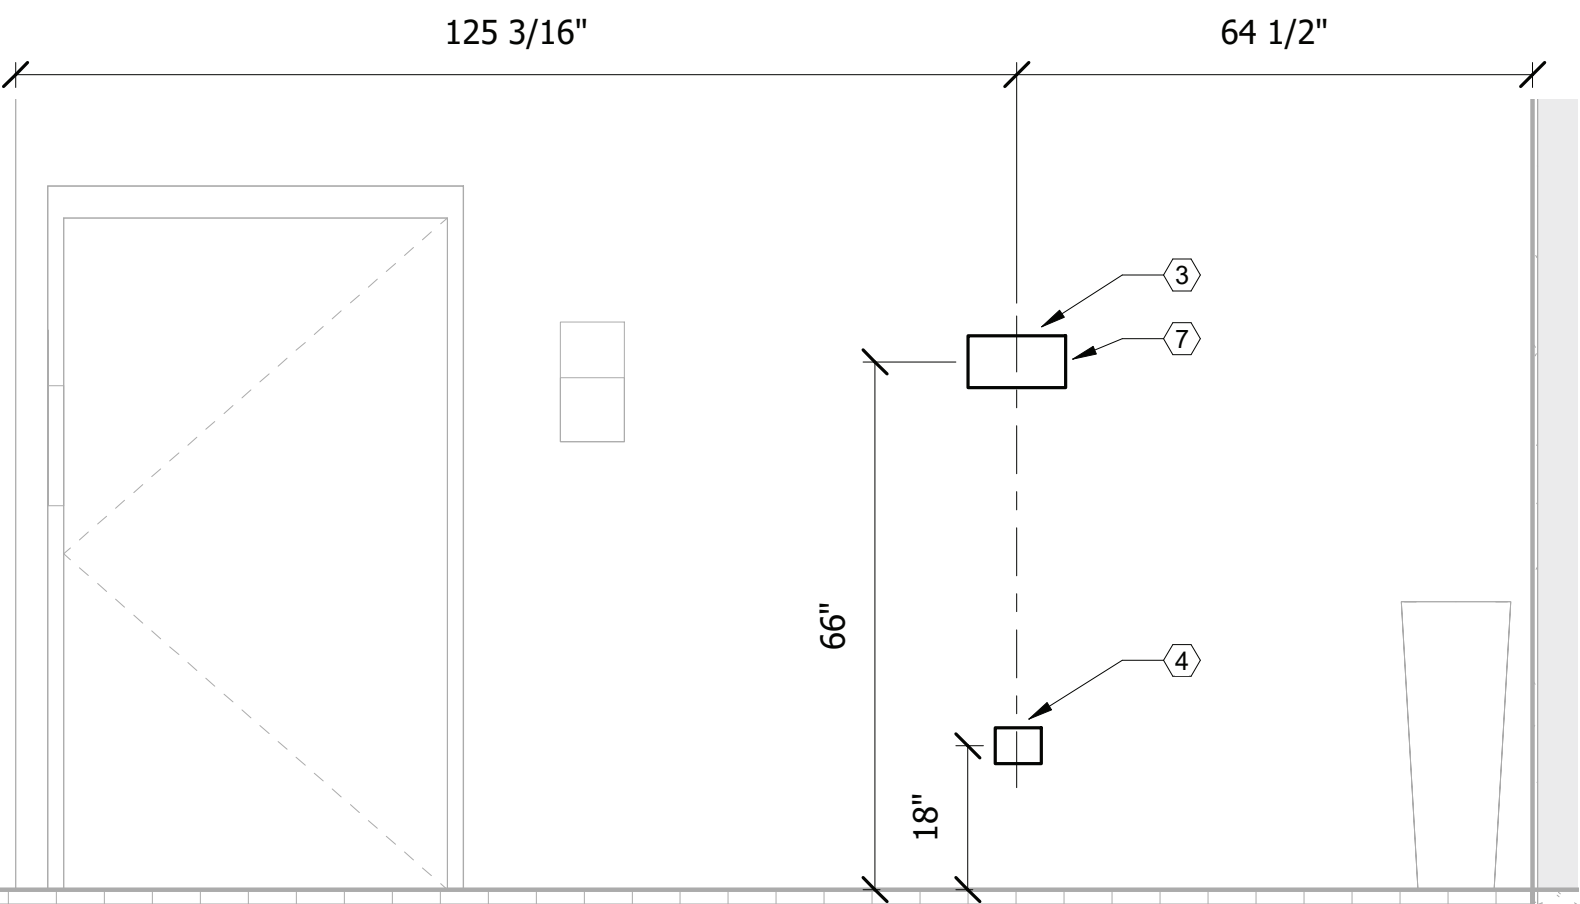


FIRE ROOM 104B
SCALE: 1/2" = 1'-0"

C2

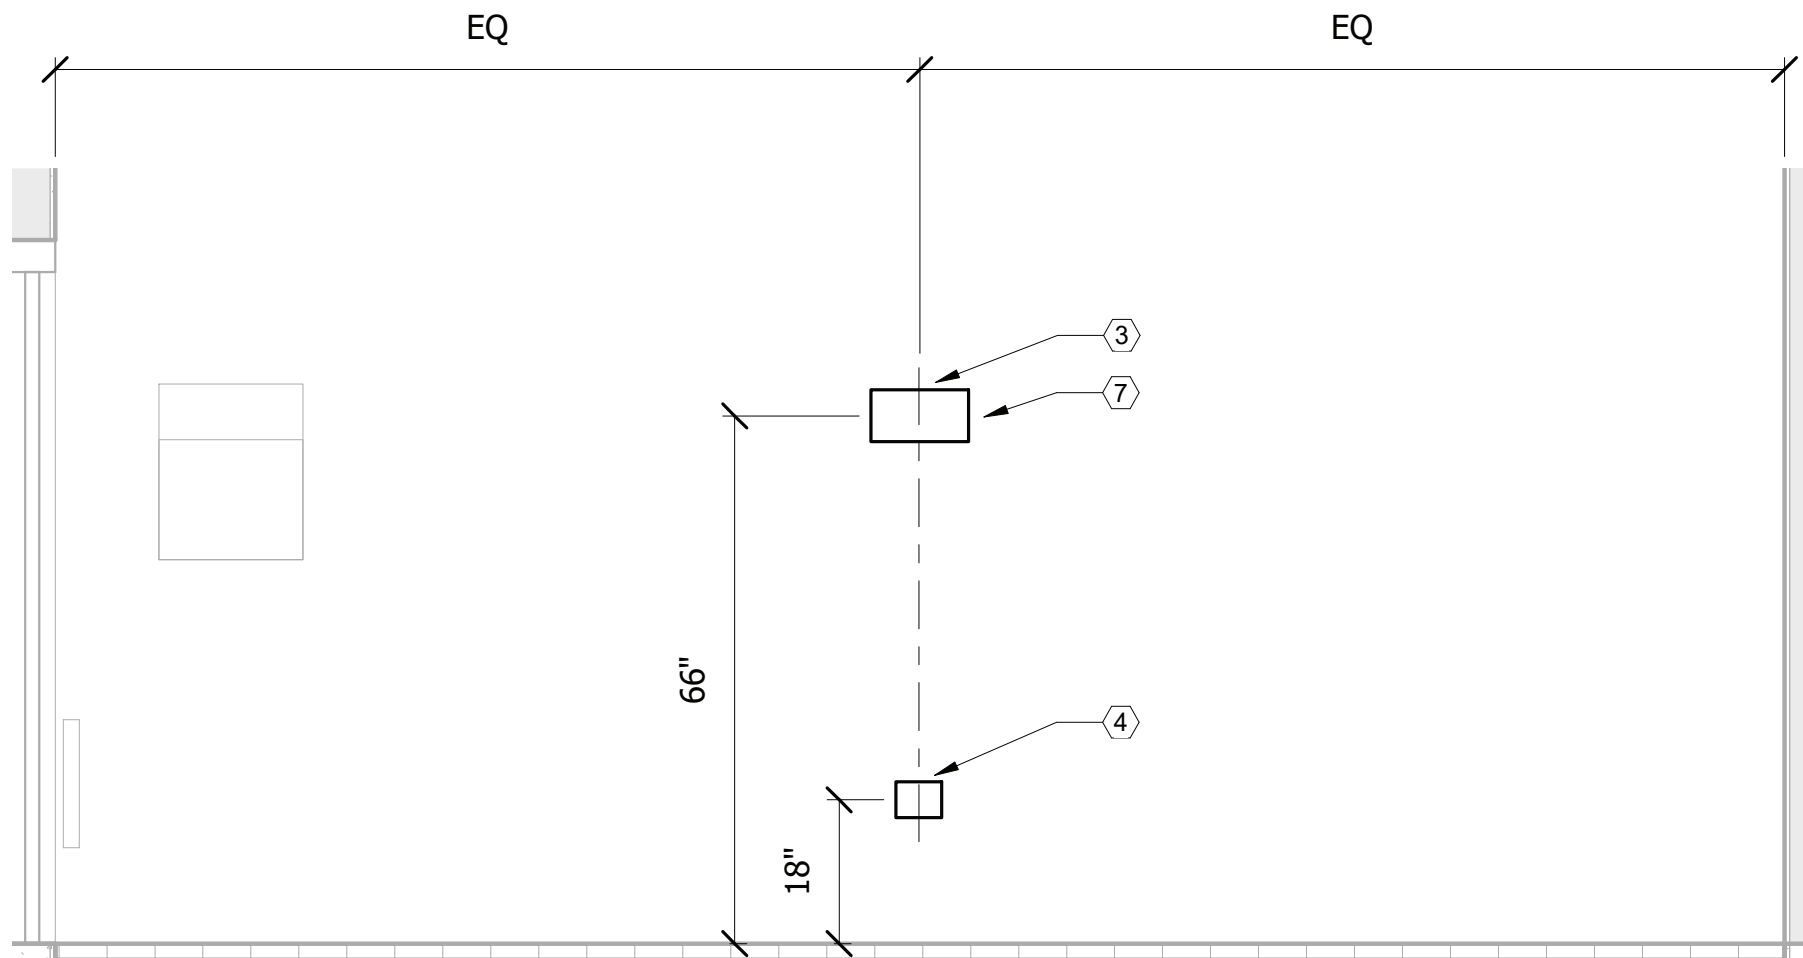


FIRE ROOM 104C
SCALE: 1/2" = 1'-0"

C4

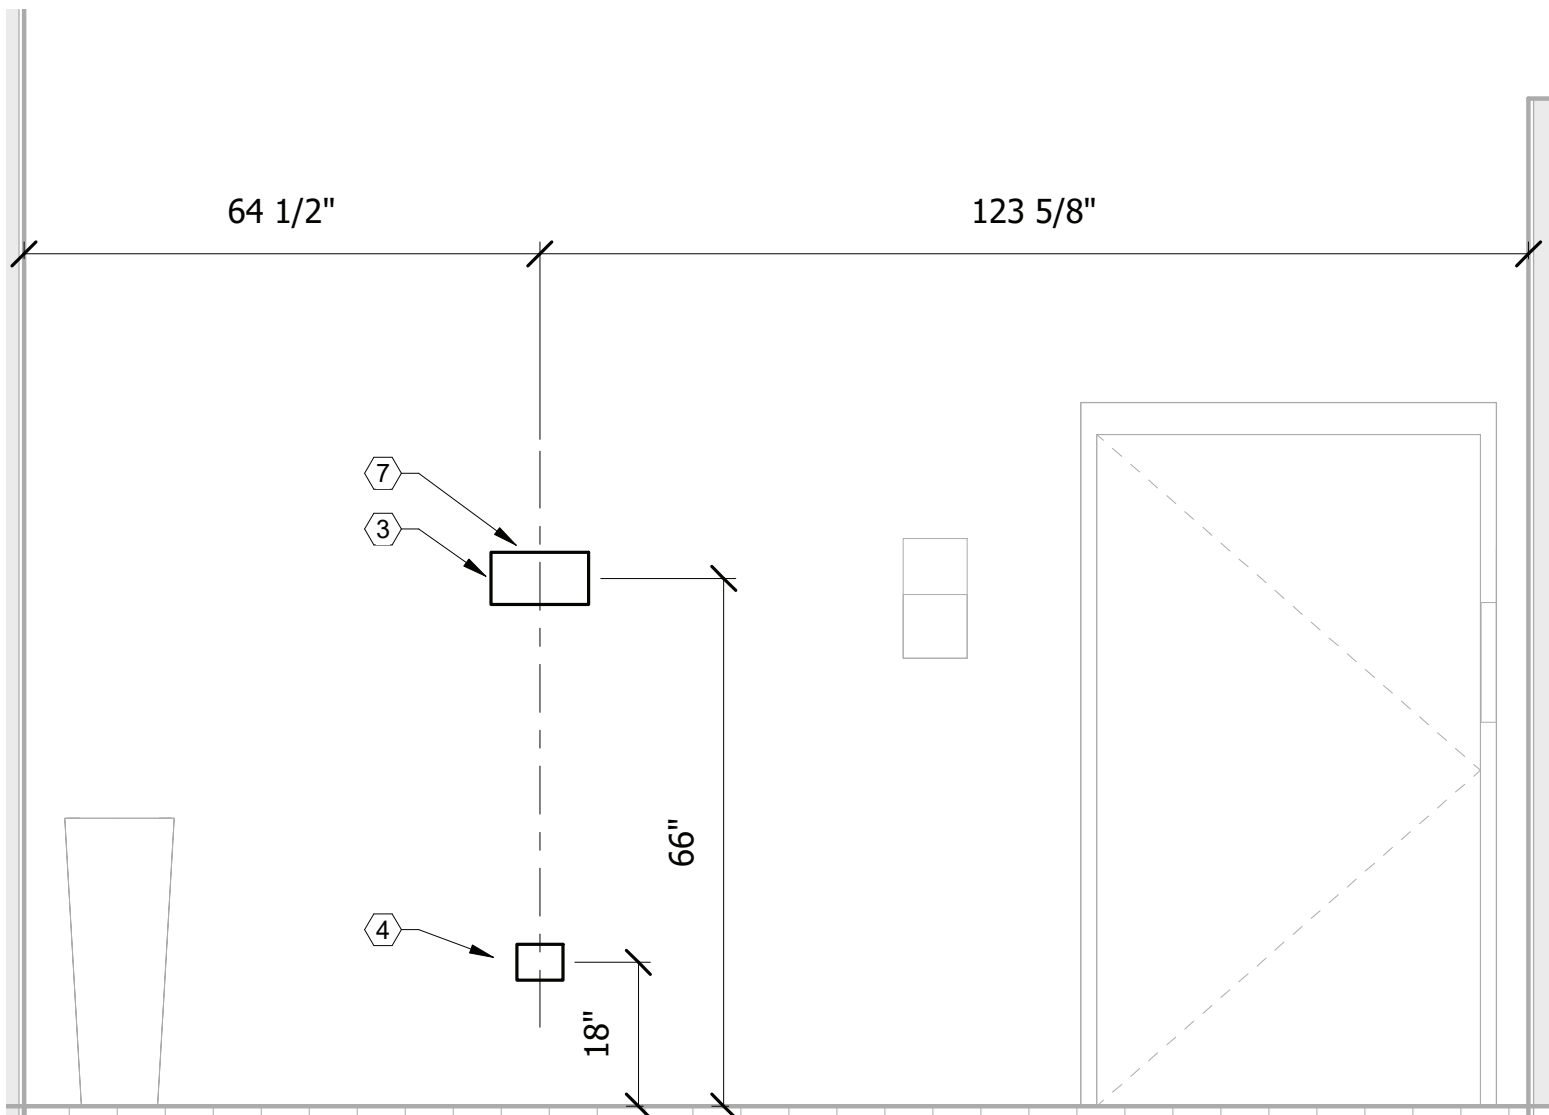

FIRE ROOM 104A
SCALE: 1/2" = 1'-0"


B2

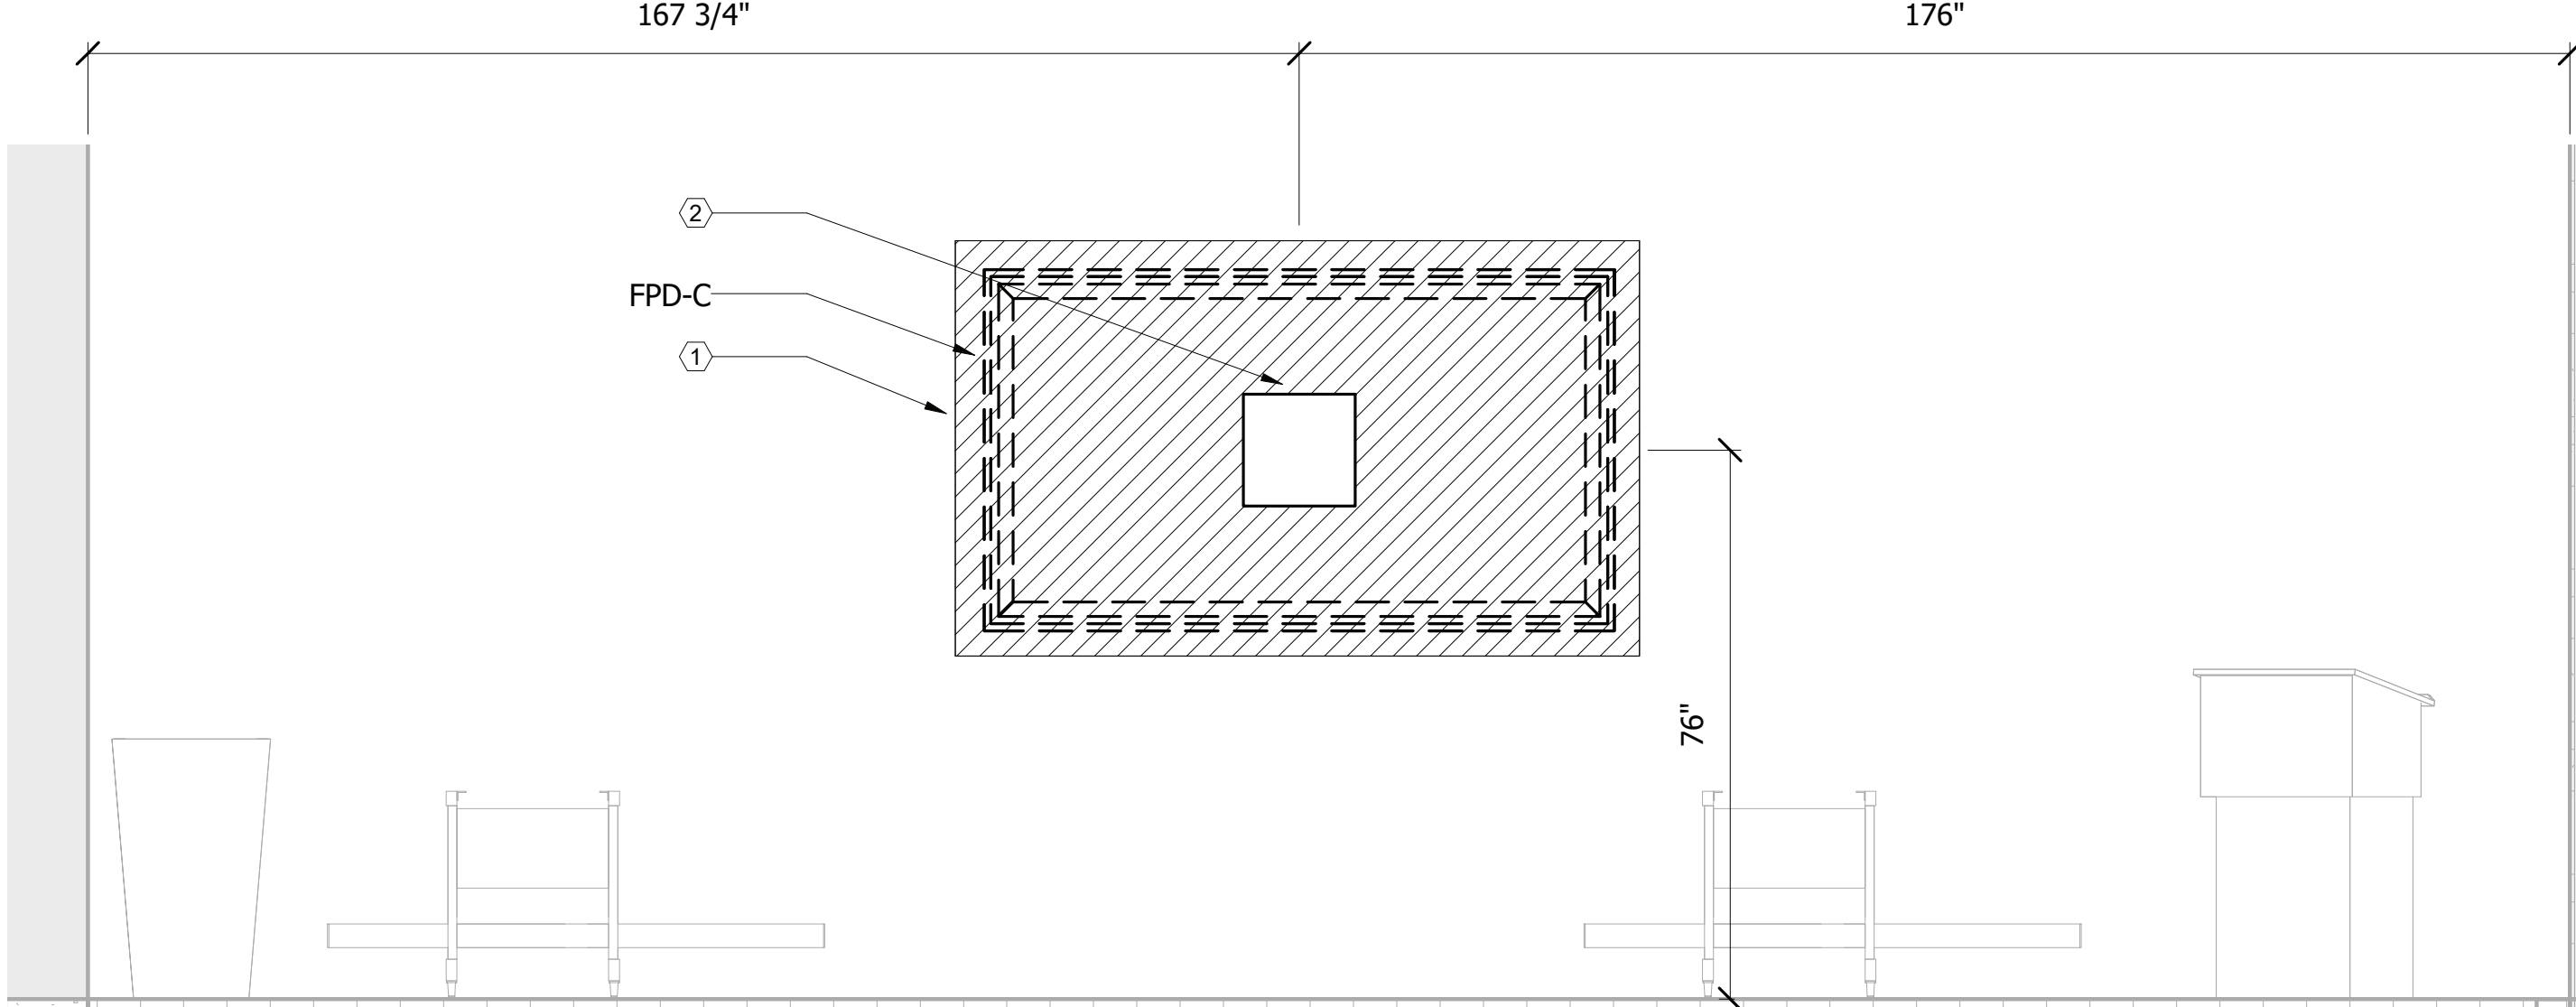

SIMULATION CLASSROOM 200B
SCALE: 1/2" = 1'-0"

TA112

B4

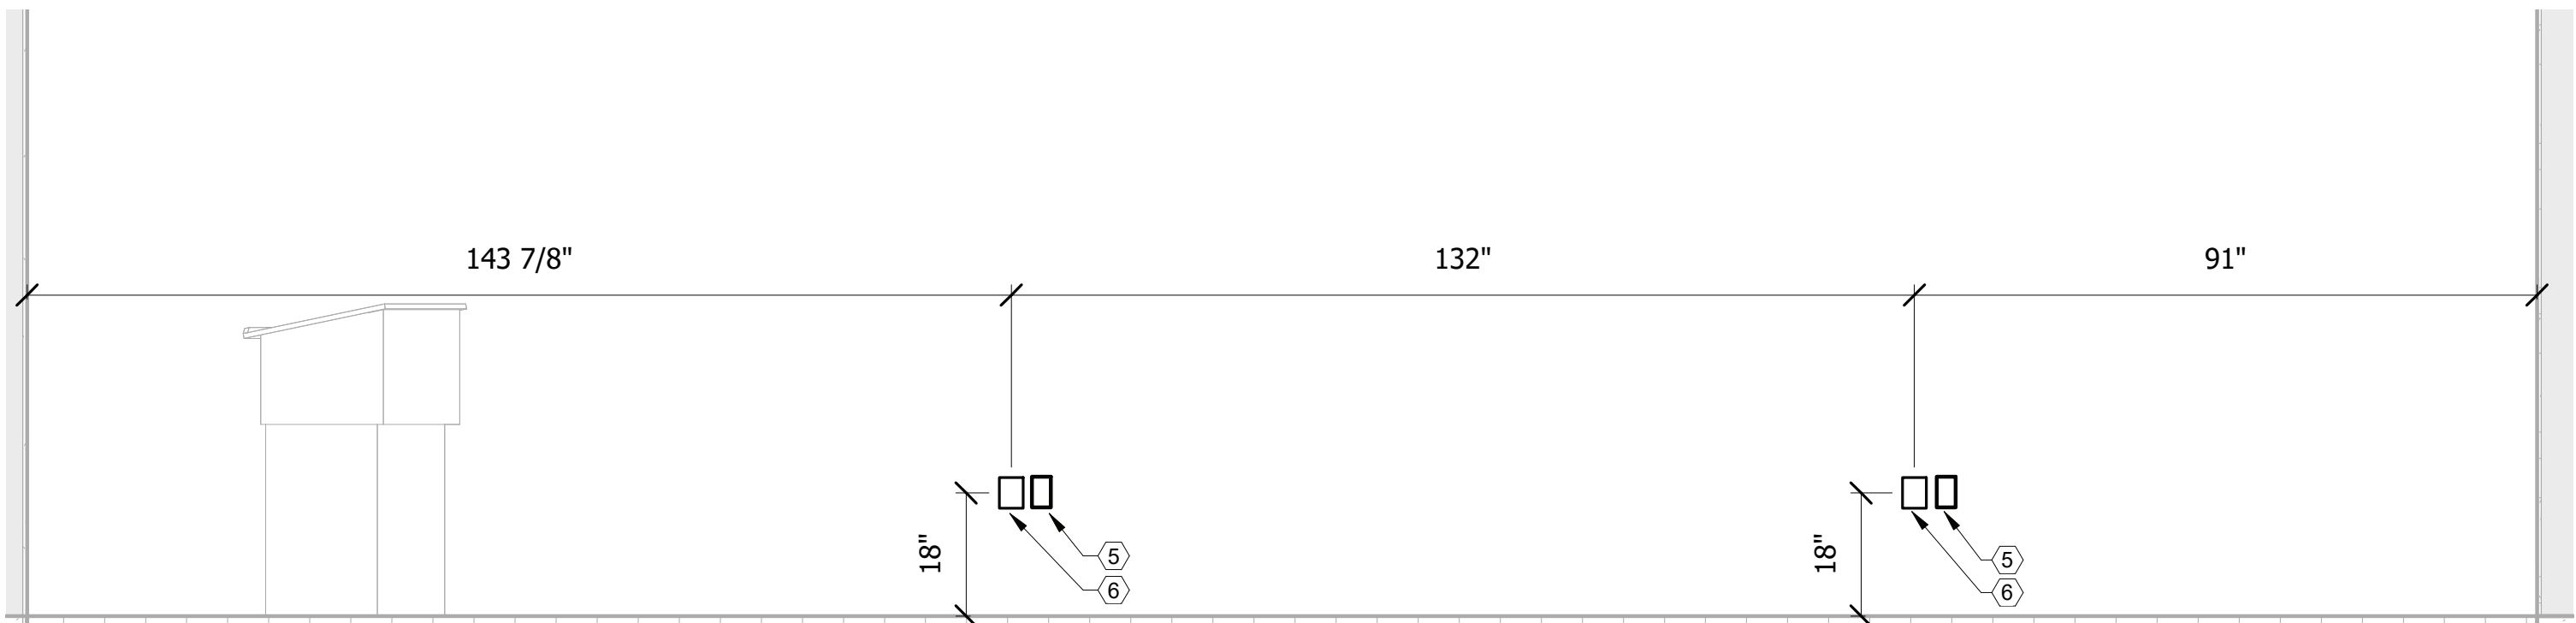

SIMULATION CLASSROOM 200B
SCALE: 1/2" = 1'-0"

A3

UNCLASSIFIED

KEYNOTE LEGEND

1	BACKING TO SUPPORT FIVE TIMES WEIGHT OF DISPLAY AND MOUNT
2	CHIEF PAC 526 (DUPLEX, 2D) SEE DETAIL A2/TA501
3	FSR PWB-100 (DUPLEX, 2D) SEE DETAIL A3/TA502
4	TWO GANG AV BACK BOX
5	DUPLEX RECEPTACLE
6	ONE GANG AV BACK BOX
7	PROVIDE FSR PWB-100-WHT-C USED TO COVER FSR PWB-100-B.



PRELIMINARY
NOT FOR CONSTRUCTION



Michael Baker
INTERNATIONAL
100 AIRSIDE DRIVE
MOON TOWNSHIP, PA 15108
APPROVED

FOR COMMANDER NAVFAC
ACTIVITY
MARINE CORPS BASE
CAMP LEJEUNE
SATISFACTORY TO DATE
DES AS DRW AV CHK BM
PM
BRANCH MANAGER
CHIEF ENGINEER
FIRE PROTECTION

DEPARTMENT OF THE NAVY
NAVAL FACILITIES ENGINEERING COMMAND ~ MID-ATLANTIC
ROICC FLORENCE CAMP LEJEUNE
MOB CAMP LEJEUNE
JACKSONVILLE, NC
P1338F II MEF SIMULATION/TRAINING CENTER
REPLACEMENT
AUDIOVISUAL - ELEVATIONS

SCALE: AS NOTED
EPROJECT NO.:
CONSTR. CONTR. NO.:
N400085-20-C-0059
NAVFAC DRAWING NO.:
SHEET OF

TA401

0 12" 24" 48"
SCALE: 1/2" = 12"

DP2 SUBMISSION - P1338 BUILDING PRE-FINAL SUBMISSION

UNCLASSIFIED


FILE NAME: BIM 360/HF PACKAGE 3P1338_MEF SIM CTR-150082-T.rvt
PLOTTED: 6/9/2021 6:52:26 AM

D

C

B


A

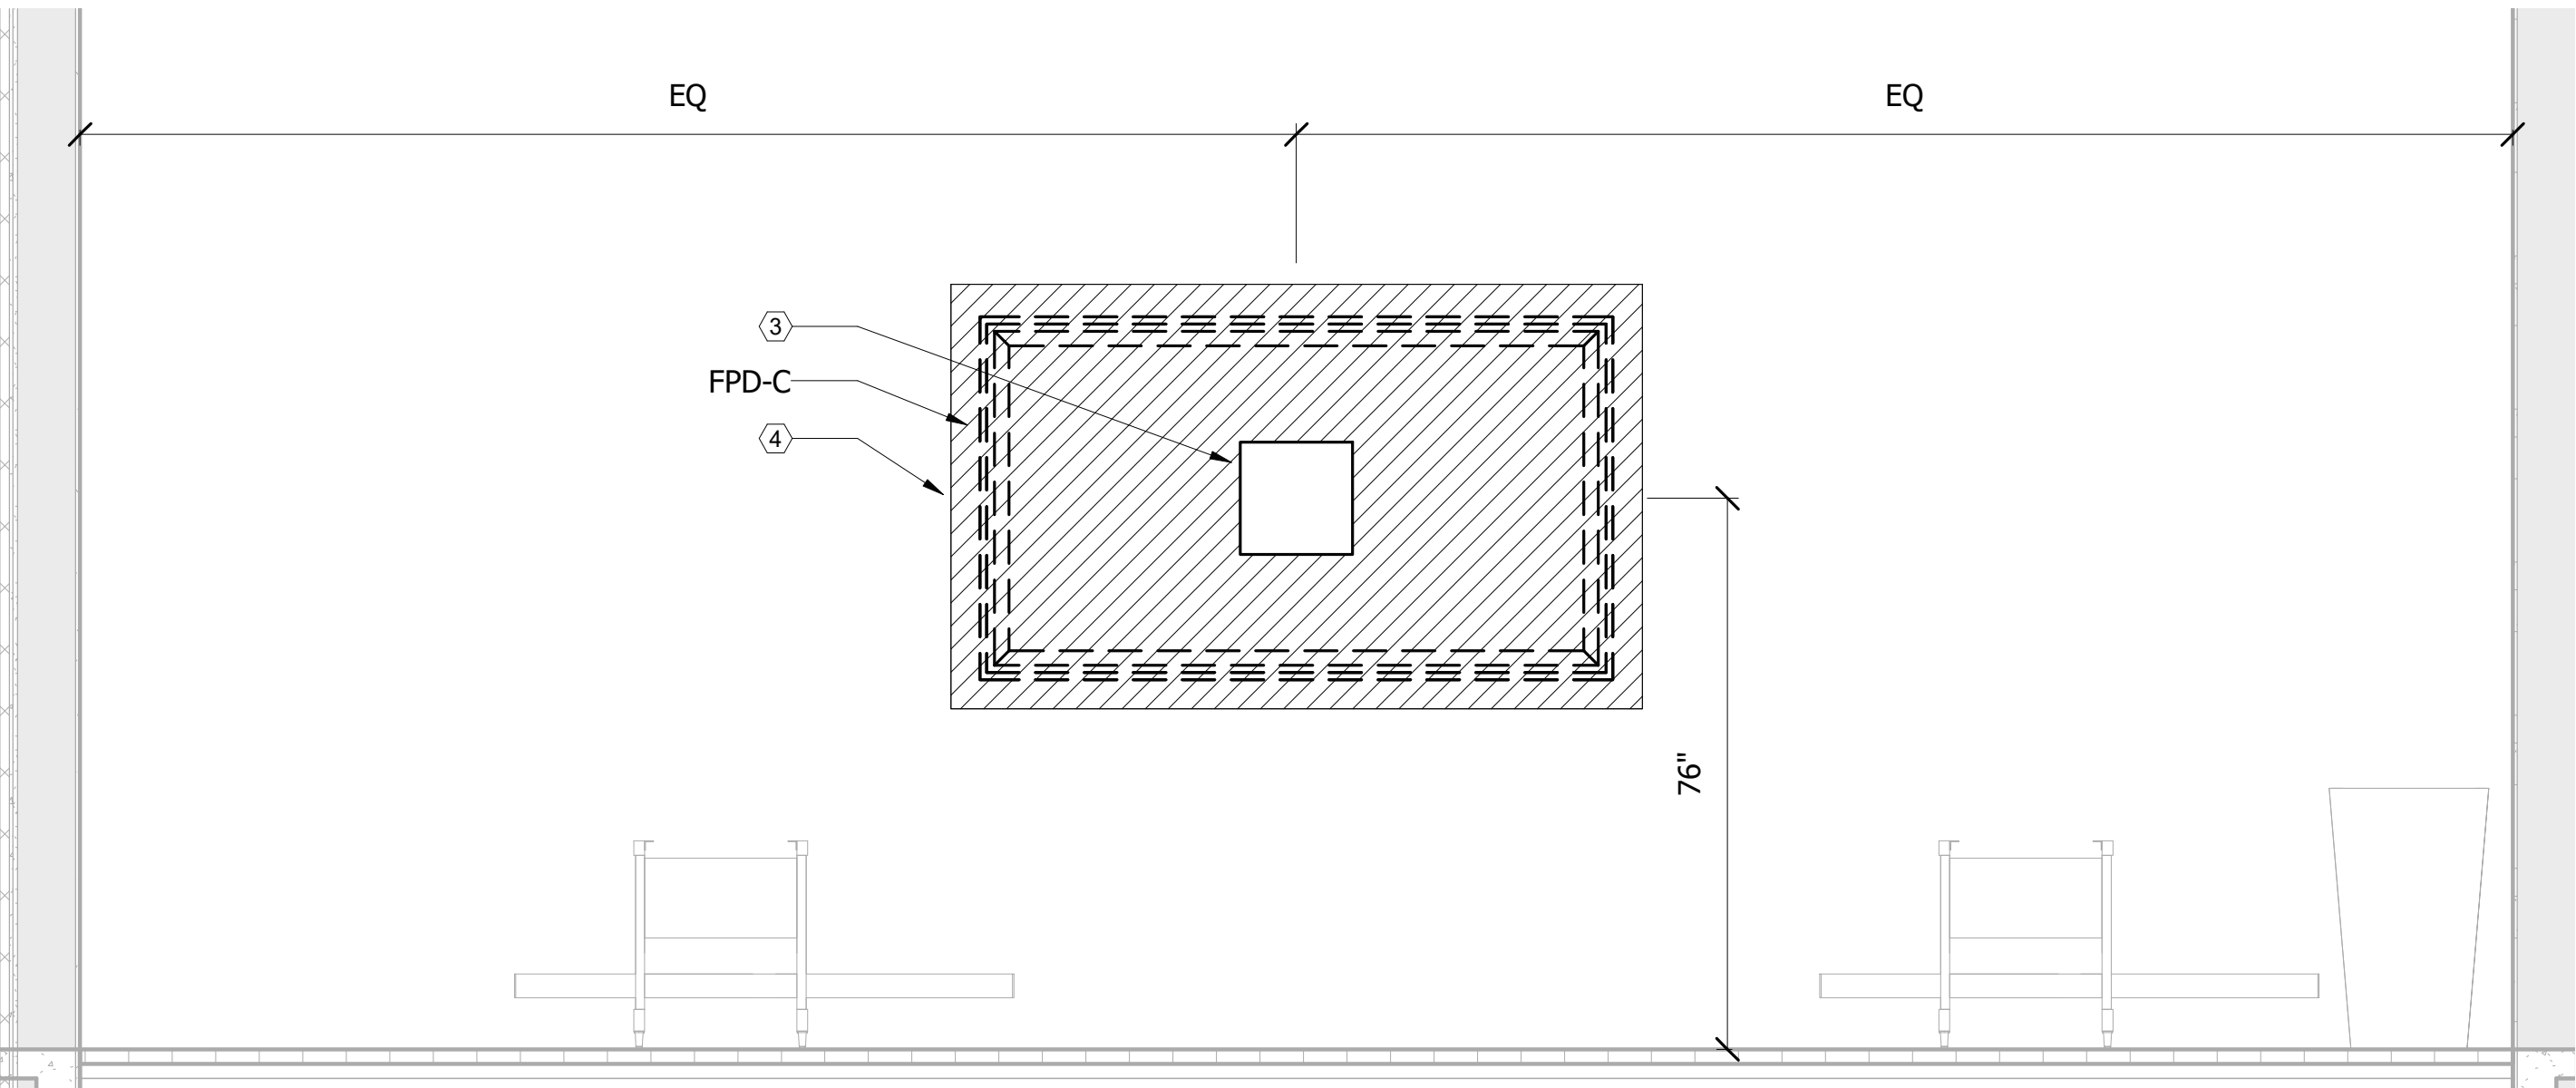

SIMULATION CLASSROOM 200A

SCALE: 1/2" = 1'-0"

C3

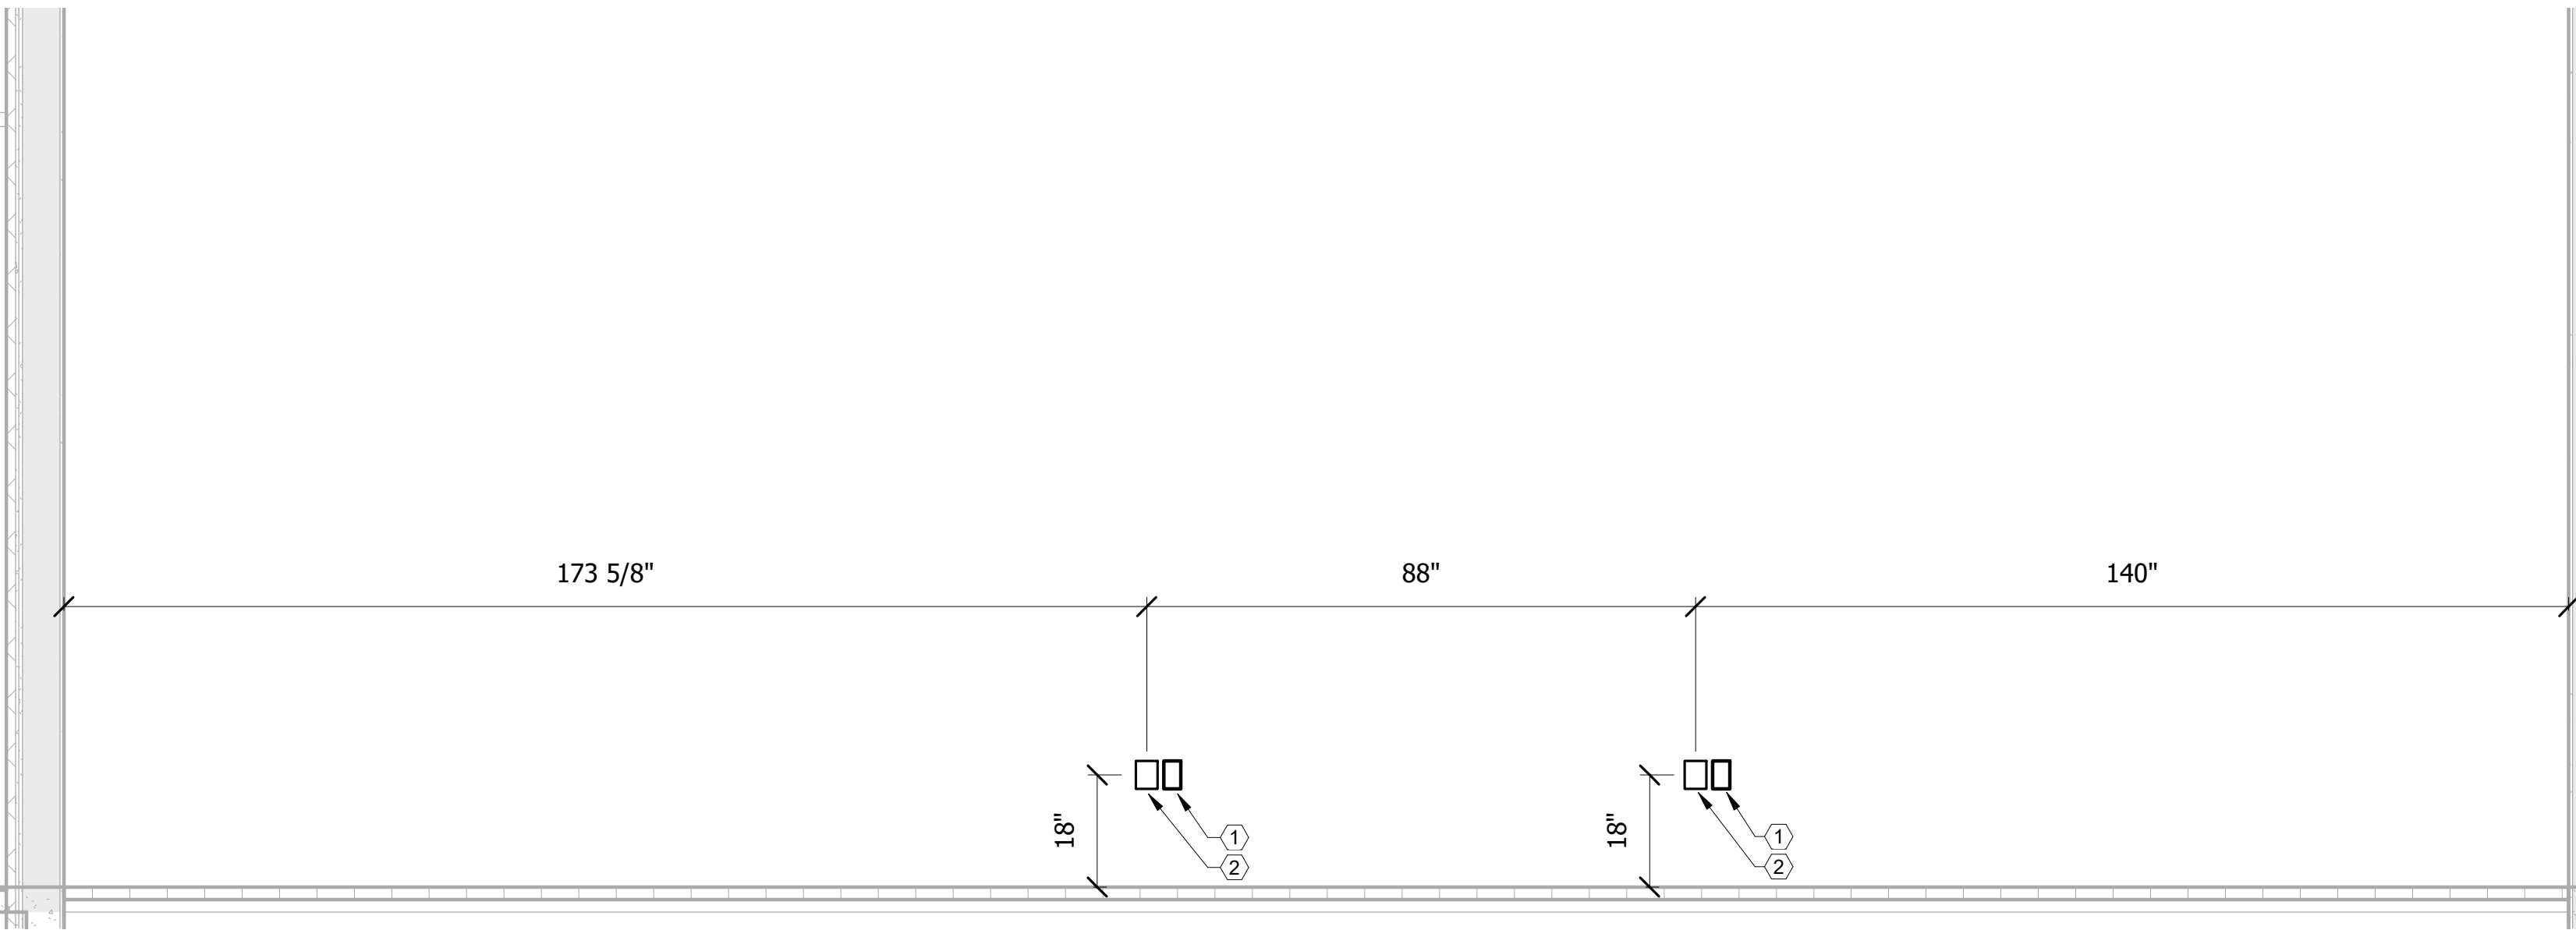

SIMULATION CLASSROOM 200A

SCALE: 1/2" = 1'-0"

A3

UNCLASSIFIED

KEYNOTE LEGEND

1	DUPLEX RECEPTACLE
2	ONE GANG AV BACK BOX
3	CHIEF PAC 526 (DUPLEX, 2D) SEE DETAIL A2/TA501
4	BACKING TO SUPPORT FIVE TIMES WEIGHT OF DISPLAY AND MOUNT



100 AIRSIDE DRIVE
MOON TOWNSHIP, PA 15108
APPROVED

FOR COMMANDER NAVFAC

ACTIVITY
MARINE CORPS BASE
CAMP LEJEUNE

SATISFACTORY TO DATE

DES AS DRW AV CHK BM

PM

BRANCH MANAGER

CHIEF ENGINEER

FIRE PROTECTION

DEPARTMENT OF THE NAVY
NAVAL FACILITIES ENGINEERING COMMAND
NAVAL FACILITIES ENGINEERING COMMAND ~ MID-ATLANTIC
ROICC FLORENCE CAMP LEJEUNE
MOB CAMP LEJEUNE
JACKSONVILLE, NC
P1338F II MEF SIMULATION/TRAINING CENTER
REPLACEMENT
AUDIOVISUAL - ELEVATIONS

SCALE: AS NOTED

EPROJECT NO.:


CONSTR. CONTR. NO.

N400085-20-C-0059

NAVFAC DRAWING NO.

SHEET OF


TA402

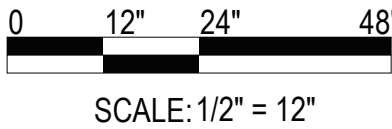


DP2 SUBMISSION - P1338 BUILDING PRE-FINAL SUBMISSION

UNCLASSIFIED

FILE NAME: BIM 360/HF PACKAGE 3P1338_MEF SIM CTR-150082-T.rvt
PLOTTED: 6/9/2021 6:52:27 AM

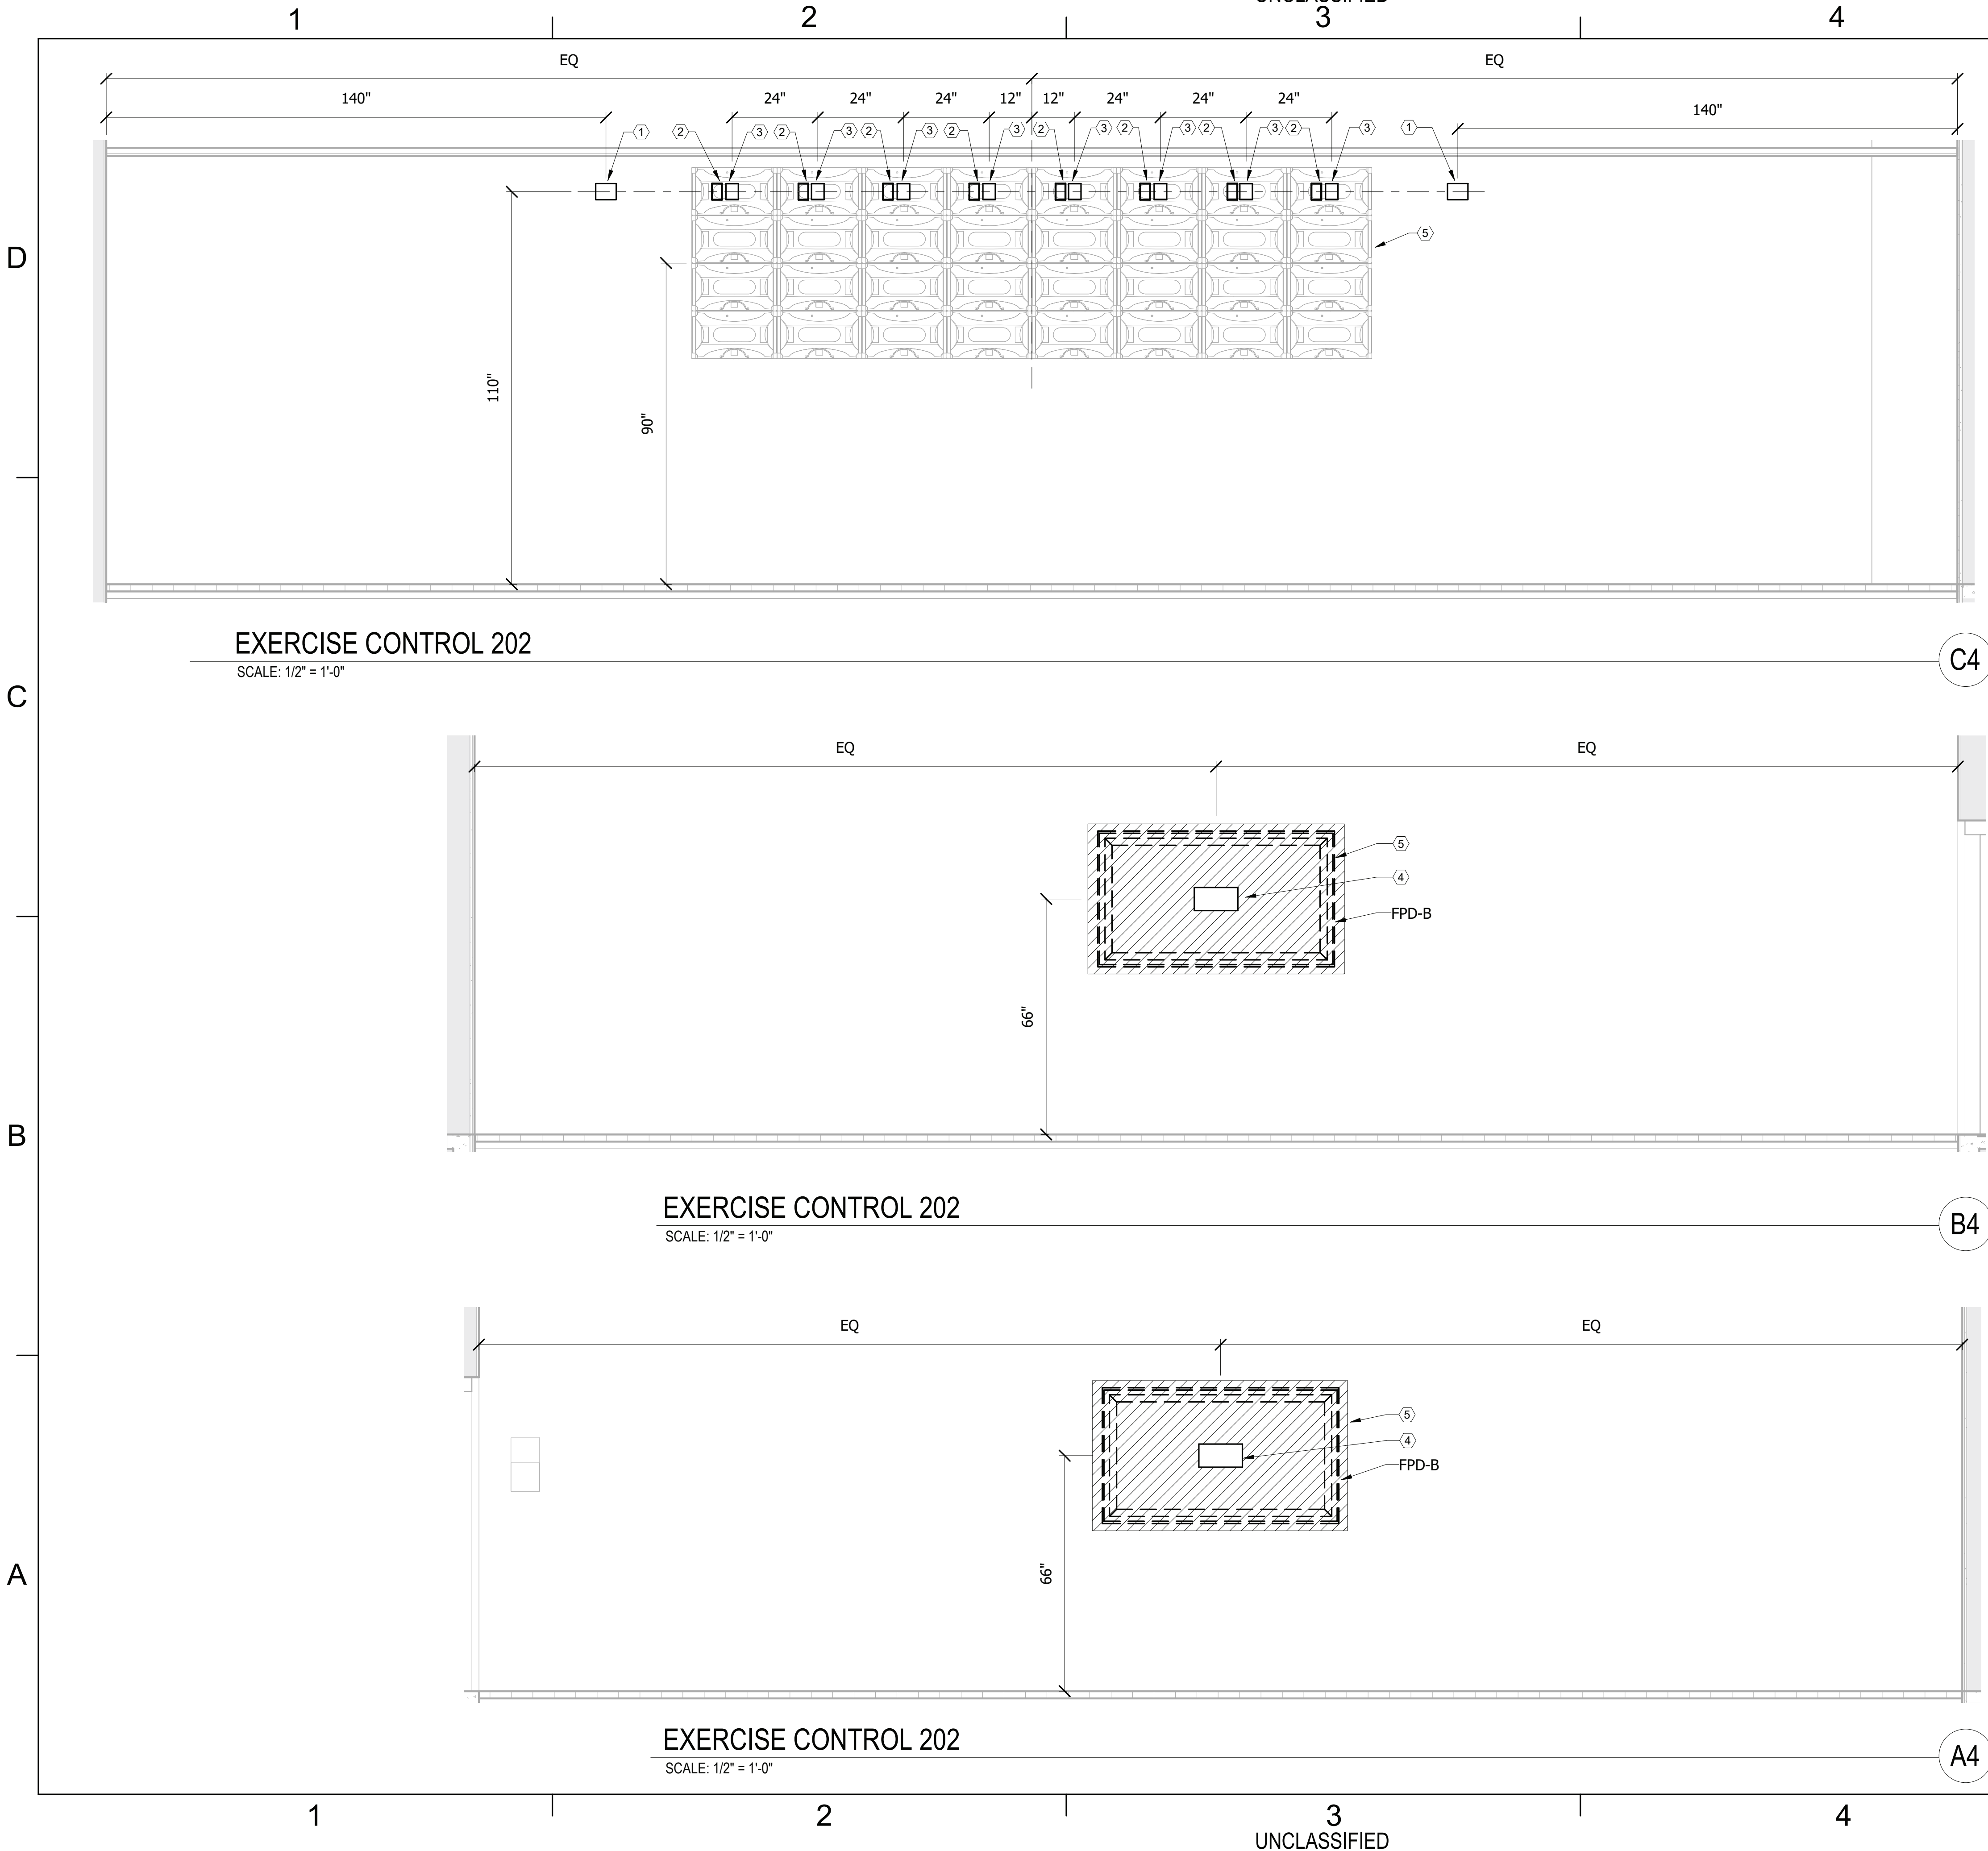

KEYNOTE LEGEND	
1	TWO GANG AV BACK BOX FOR WALL MOUNTED CAMERAS
2	RECESSED CLOCK RECEPTACLE
3	ONE GANG AV BACK BOX
4	FSR PWB-100 (DUPLEX, 2D) SEE DETAIL A3/TA502
5	BACKING TO SUPPORT FIVE TIMES WEIGHT OF DISPLAY AND MOUNT

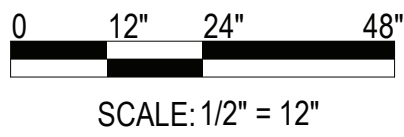

APPR	DATE	DESCRIPTION	SYM
PRELIMINARY NOT FOR CONSTRUCTION			
Michael Baker INTERNATIONAL 100 AIRSIDE DRIVE MOON TOWNSHIP, PA 15108 APPROVED			
FOR COMMANDER NAVFAC			
ACTIVITY MARINE CORPS BASE CAMP LEJEUNE			
SATISFACTORY TO DATE			
DES AS	DRW AV	CHK BM	
PM			
BRANCH MANAGER			
CHIEF ENGINEER			
FIRE PROTECTION			
NAVAL FACILITIES ENGINEERING COMMAND NAVAL FACILITIES ENGINEERING COMMAND ~ MID-ATLANTIC ROSC FLORENCE CAMP LEJEUNE MOB CAMP LEJEUNE JACKSONVILLE, NC P1338F II MEF SIMULATION/TRAINING CENTER REPLACEMENT AUDIOVISUAL - ELEVATIONS			
SCALE: AS NOTED			
EPROJECT NO.:			
CONSTR. CONTR. NO. N40085-20-C-0059			
NAVFAC DRAWING NO.			
SHEET OF			
TA403			


FILE NAME: BIM 360/HF PACKAGE 3P1338_MEF SIM CTR-1500822.Txd
PLOTTED: 6/9/2021 6:52:29 AM

D

C


B

A

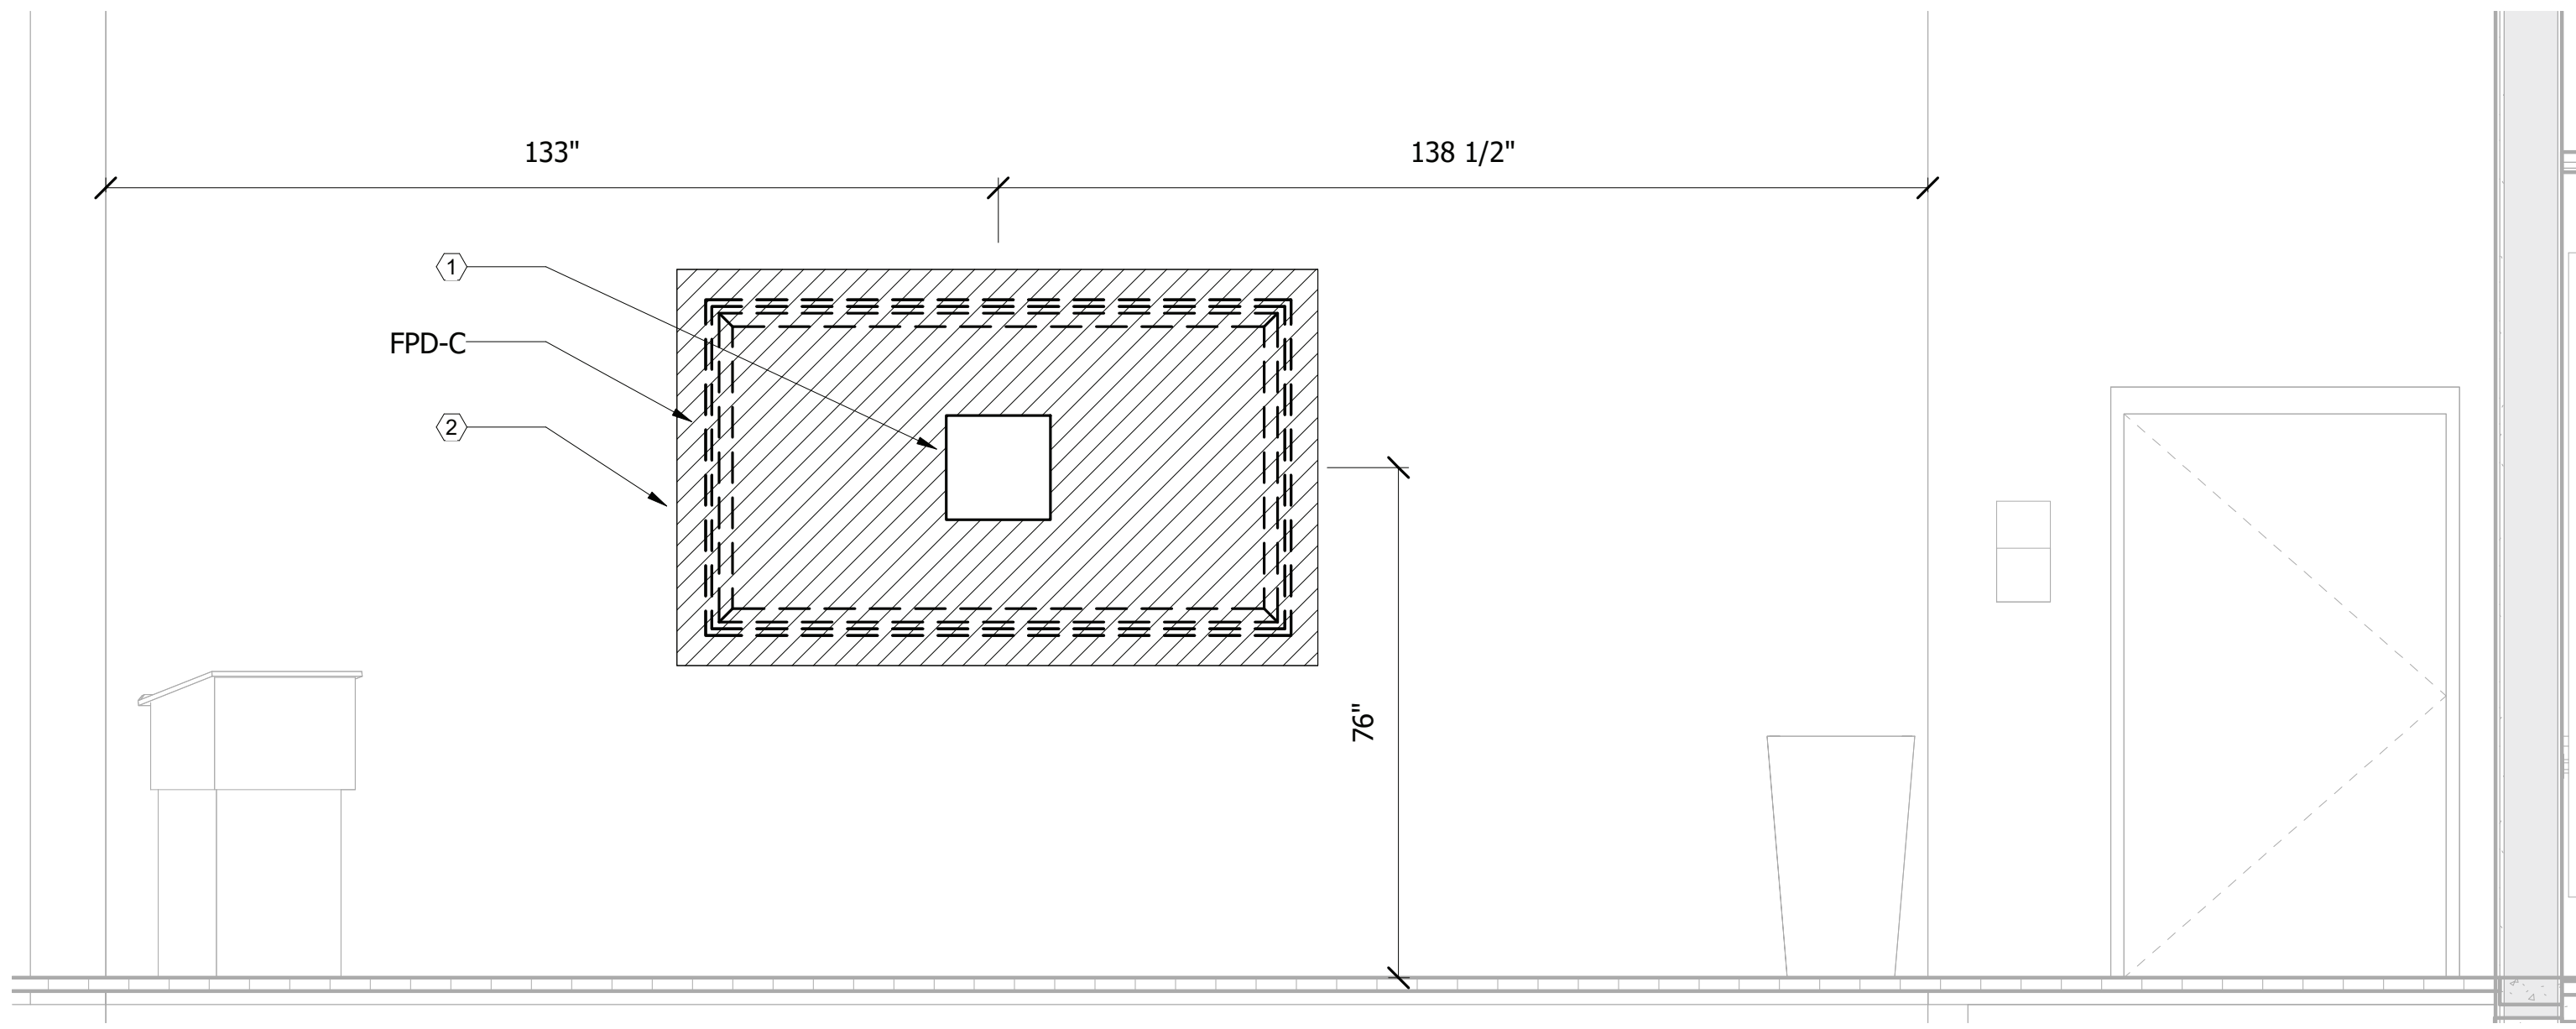

SIMULATION CLASSROOM 300A
SCALE: 1/2" = 1'-0"

C3

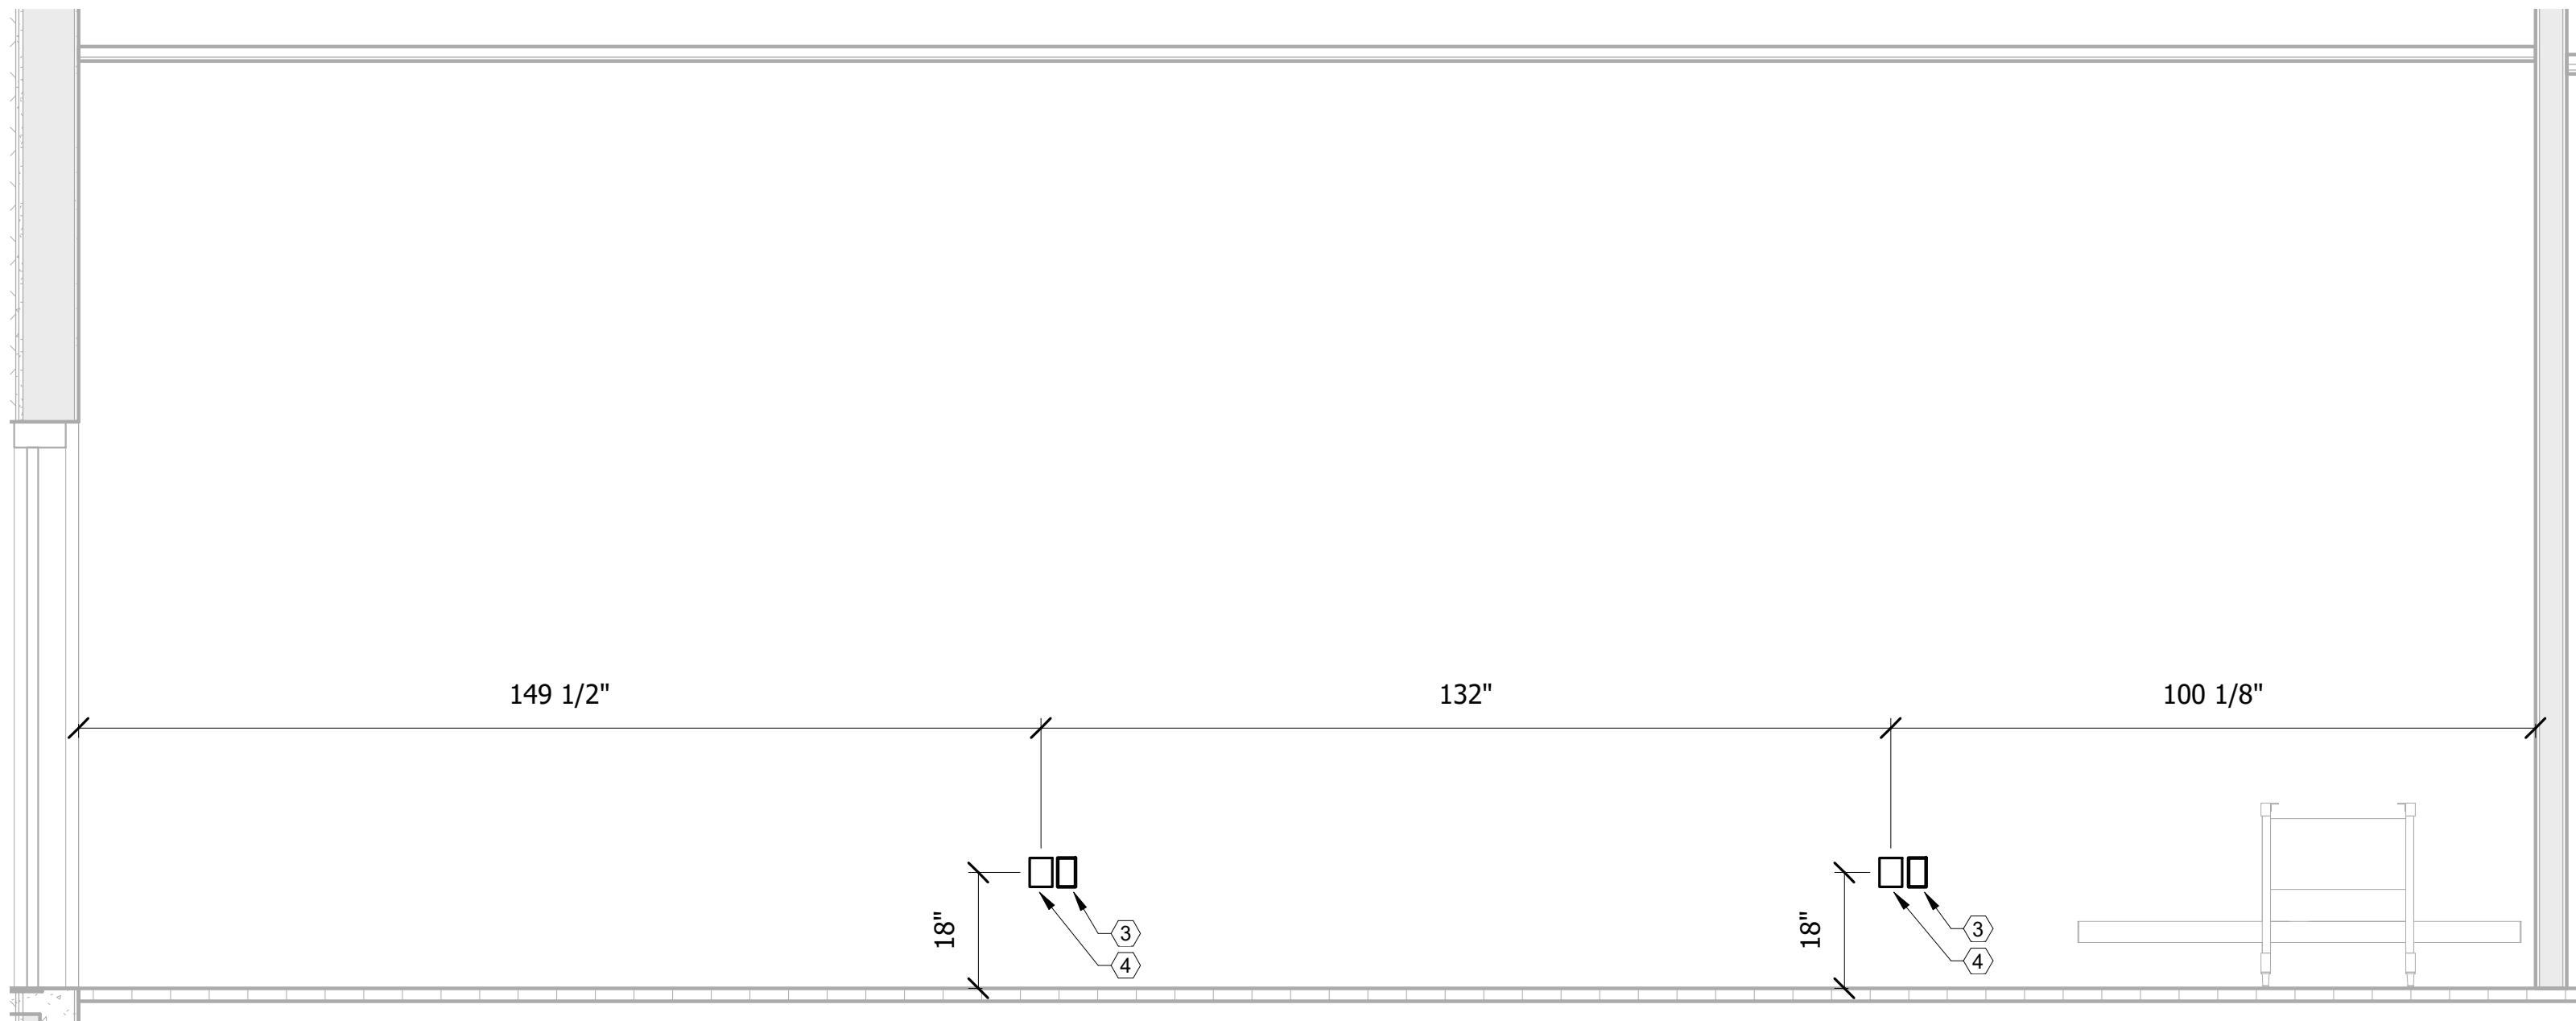

SIMULATION CLASSROOM 300A
SCALE: 1/2" = 1'-0"


A3

UNCLASSIFIED

UNCLASSIFIED

KEYNOTE LEGEND

1	CHIEF PAC 526 (DUPLEX, 2D) SEE DETAIL A2/TA501
2	BACKING TO SUPPORT FIVE TIMES WEIGHT OF DISPLAY AND MOUNT
3	DUPLEX RECEPTACLE
4	ONE GANG AV BACK BOX

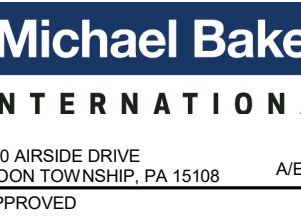

FOR COMMANDER NAVFAC

ACTIVITY
MARINE CORPS BASE
CAMP LEJEUNE

SATISFACTORY TO DATE

DES AS DRW AV CHK BM

PM

BRANCH MANAGER

CHIEF ENGINEER

FIRE PROTECTION

NAVFAC DRAWING NO.

PROJECT NO.

CONSTR. CONTR. NO.

SCALE: AS NOTED

NAVFAC DRAWING NO.

PROJECT NO.

CONSTR. CONTR. NO.

SCALE: AS NOTED

NAVFAC DRAWING NO.

PROJECT NO.

CONSTR. CONTR. NO.

TA404

DP2 SUBMISSION - P1338 BUILDING PRE-FINAL SUBMISSION


UNCLASSIFIED

D


C

B


A

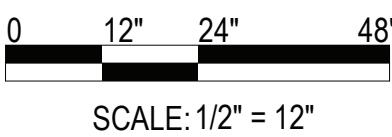

FILE NAME: BIM 360/HF PACKAGE 3/P1338_MEF SIM CTR-1500B02-T.rvt
PLOTTED: 6/9/2021 6:52:29 AM

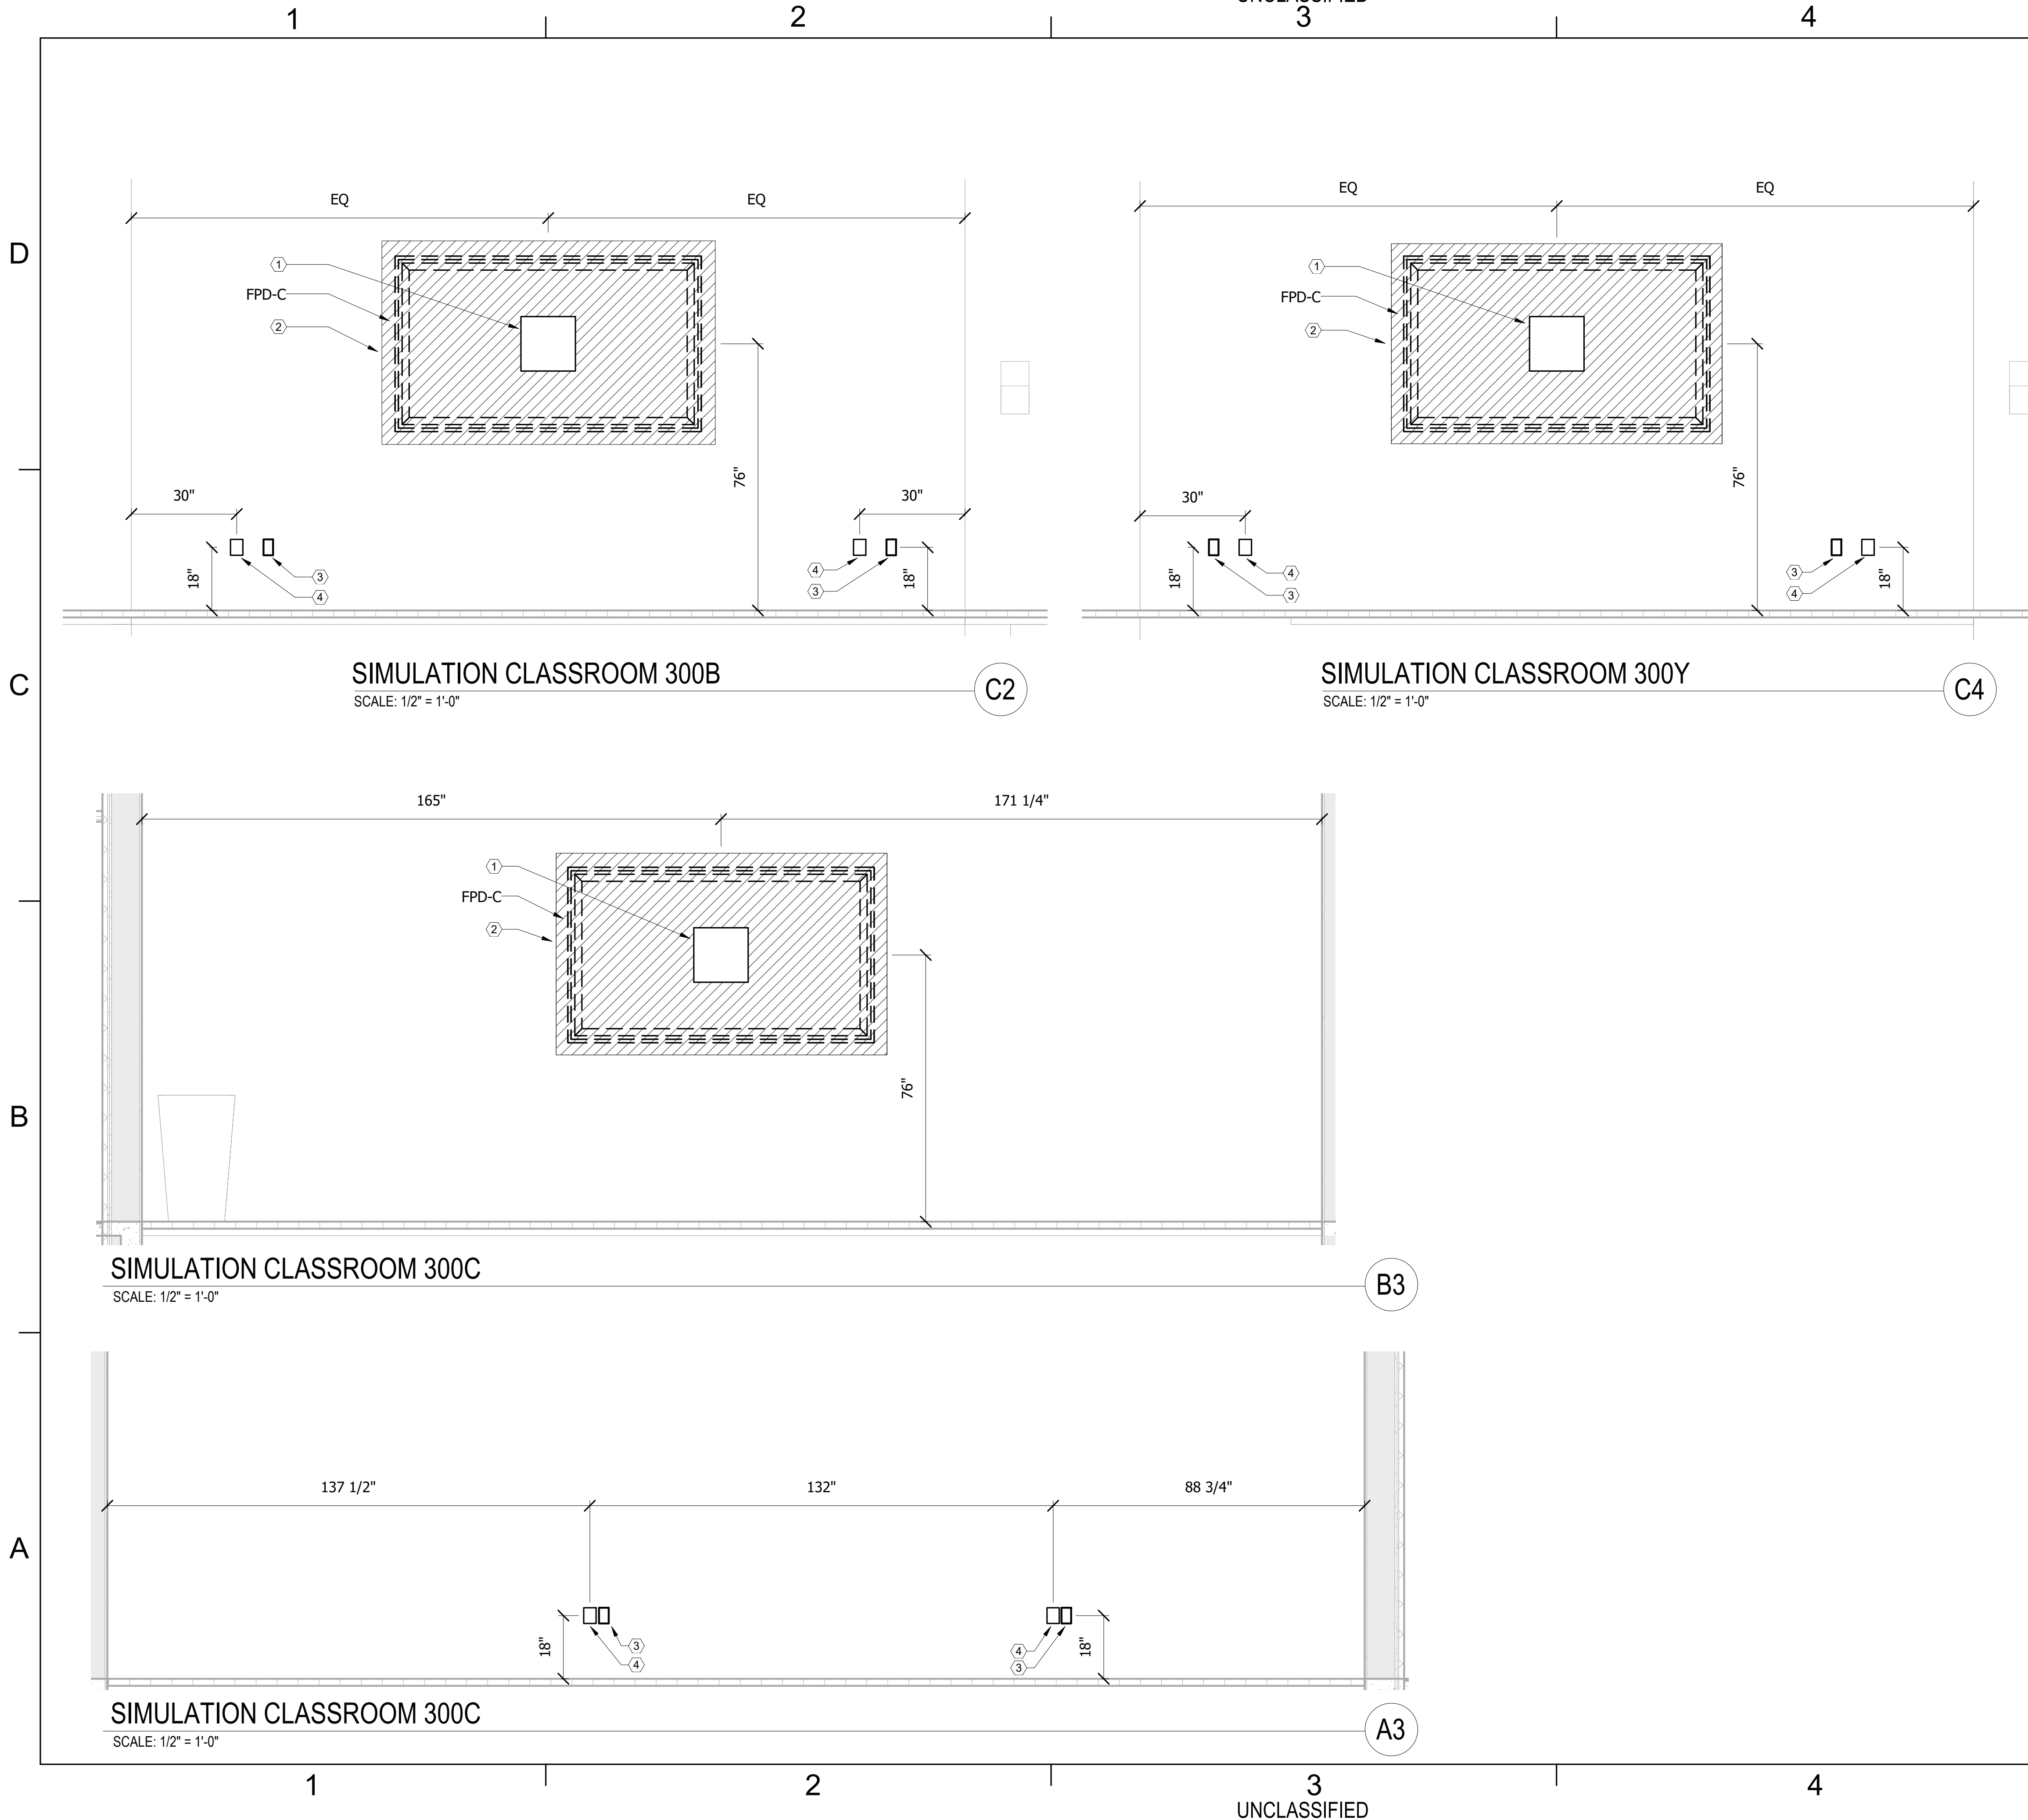

KEYNOTE LEGEND	
1	CHIEF PAC 526 (DUPLEX, 2D) SEE DETAIL A2/TA501
2	BACKING TO SUPPORT FIVE TIMES WEIGHT OF DISPLAY AND MOUNT
3	DUPLEX RECEPTACLE
4	ONE GANG AV BACK BOX

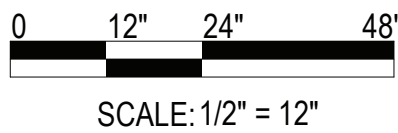

APPR
DATE

SYN
DESCRIPTION

PRELIMINARY
NOT FOR CONSTRUCTION

A JOINT VENTURE

Michael Baker INTERNATIONAL
100 AIRSIDE DRIVE
MOON TOWNSHIP, PA 15108
APPROVED

FOR COMMANDER NAVFAC
ACTIVITY
MARINE CORPS BASE
CAMP LEJEUNE
SATISFACTORY TO DATE
DES AS DRW AV CHK BM
PM
BRANCH MANAGER
CHIEF ENGINEER
FIRE PROTECTION

DEPARTMENT OF THE NAVY
NAVAL FACILITIES ENGINEERING COMMAND ~ MID-ATLANTIC
ROICC FLORENCE CAMP LEJEUNE
MOB CAMP LEJEUNE
P1338F II MEF SIMULATION/TRAINING CENTER
REPLACEMENT
AUDIOVISUAL - ELEVATIONS

SCALE: AS NOTED
EPROJECT NO.:
CONSTR. CONTR. NO.
N40085-20-C-0059
NAVFAC DRAWING NO.
SHEET OF

TA405

DP2 SUBMISSION - P1338 BUILDING PRE-FINAL SUBMISSION

UNCLASSIFIED


FILE NAME: BIM 360/HF PACKAGE 3P1338_MEF SIM CTR-1500802-T-01
PLOTTED: 6/9/2021 6:52:30 AM

D

C

B


A

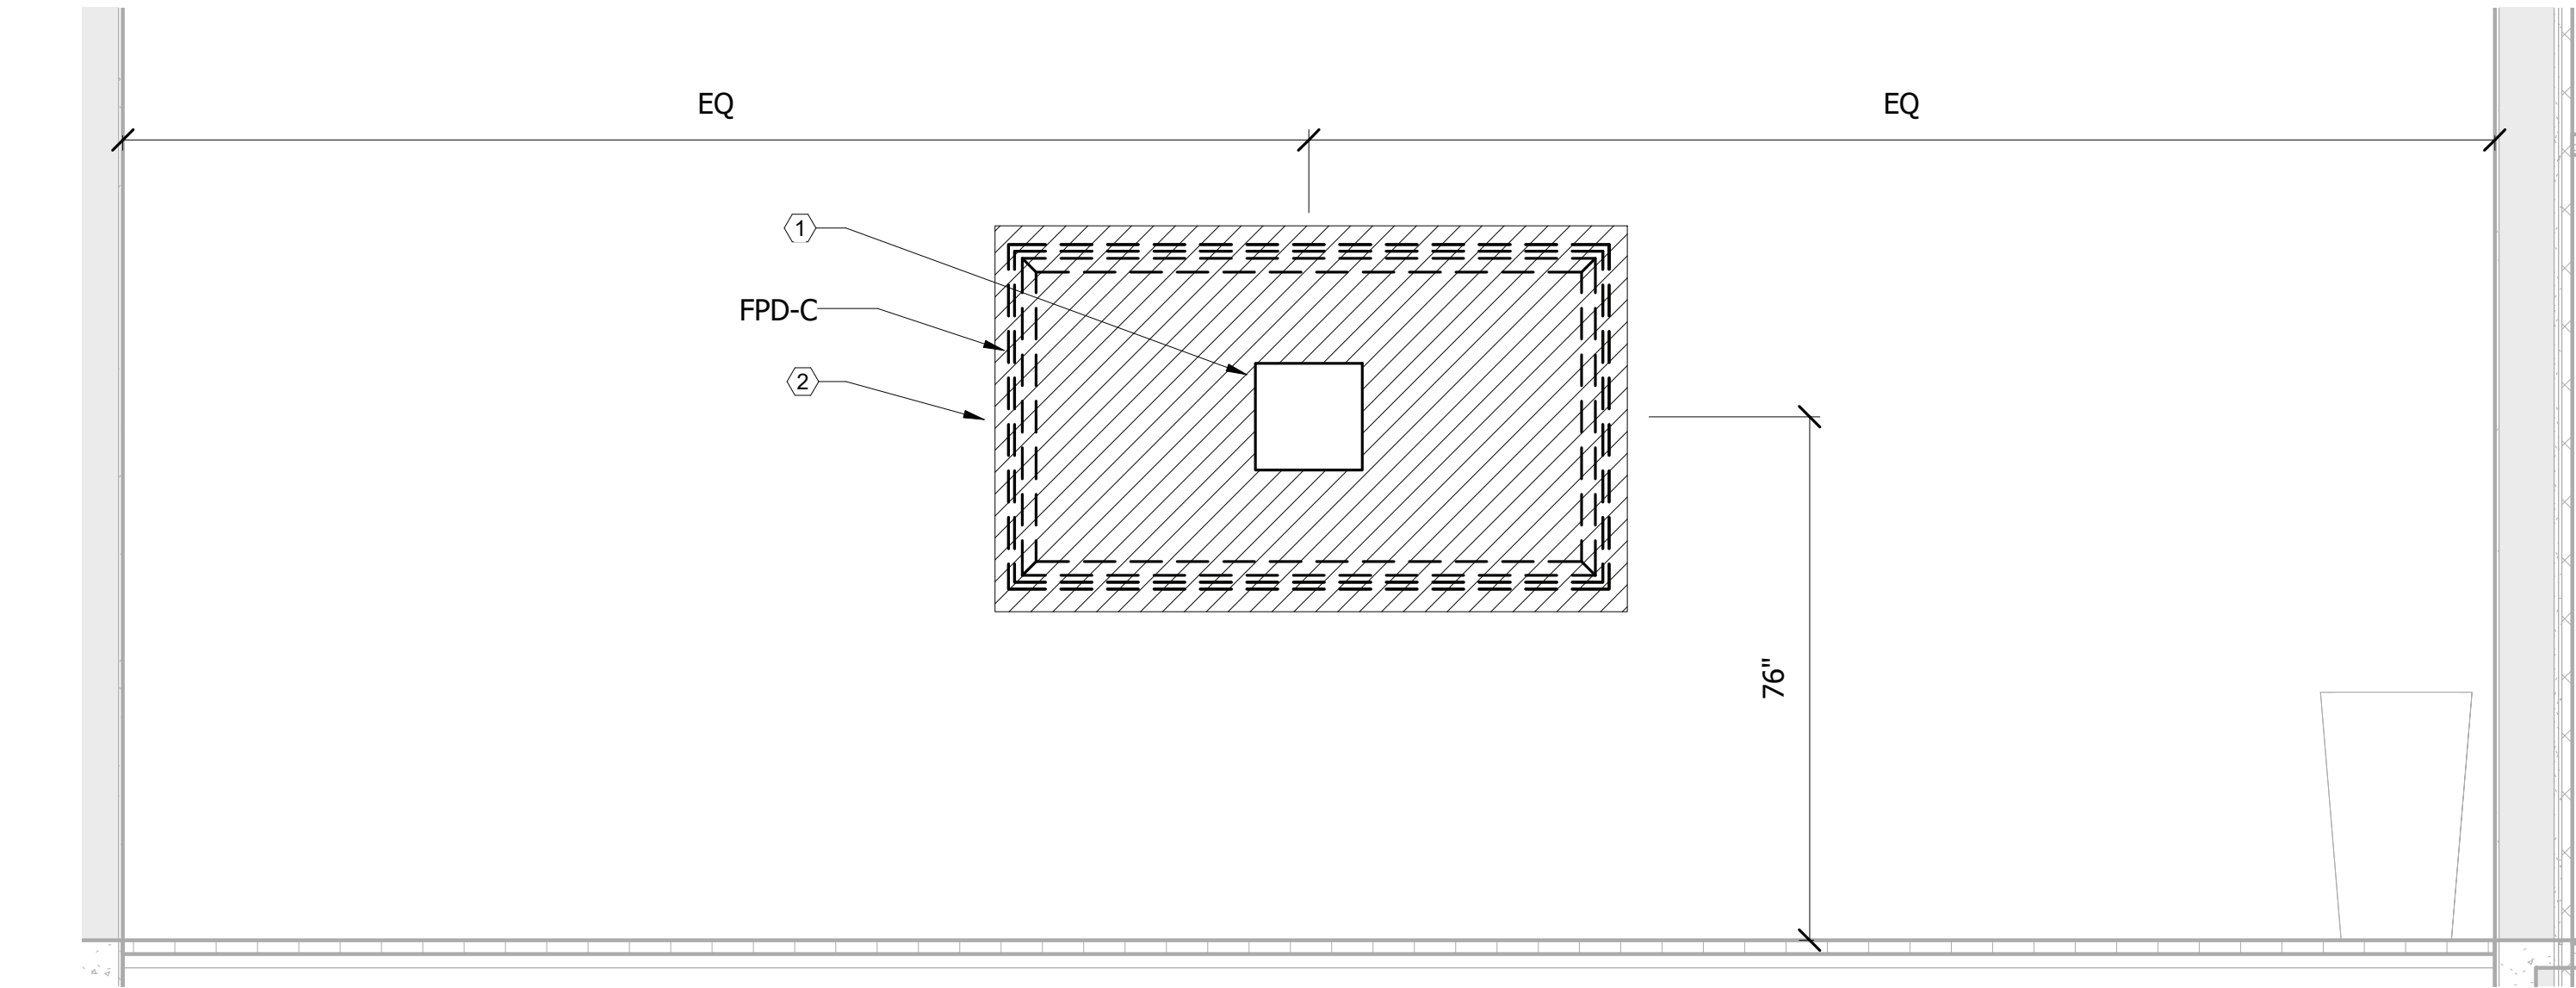

SIMULATION CLASSROOM 300Z

SCALE: 1/2" = 1'-0"

C3

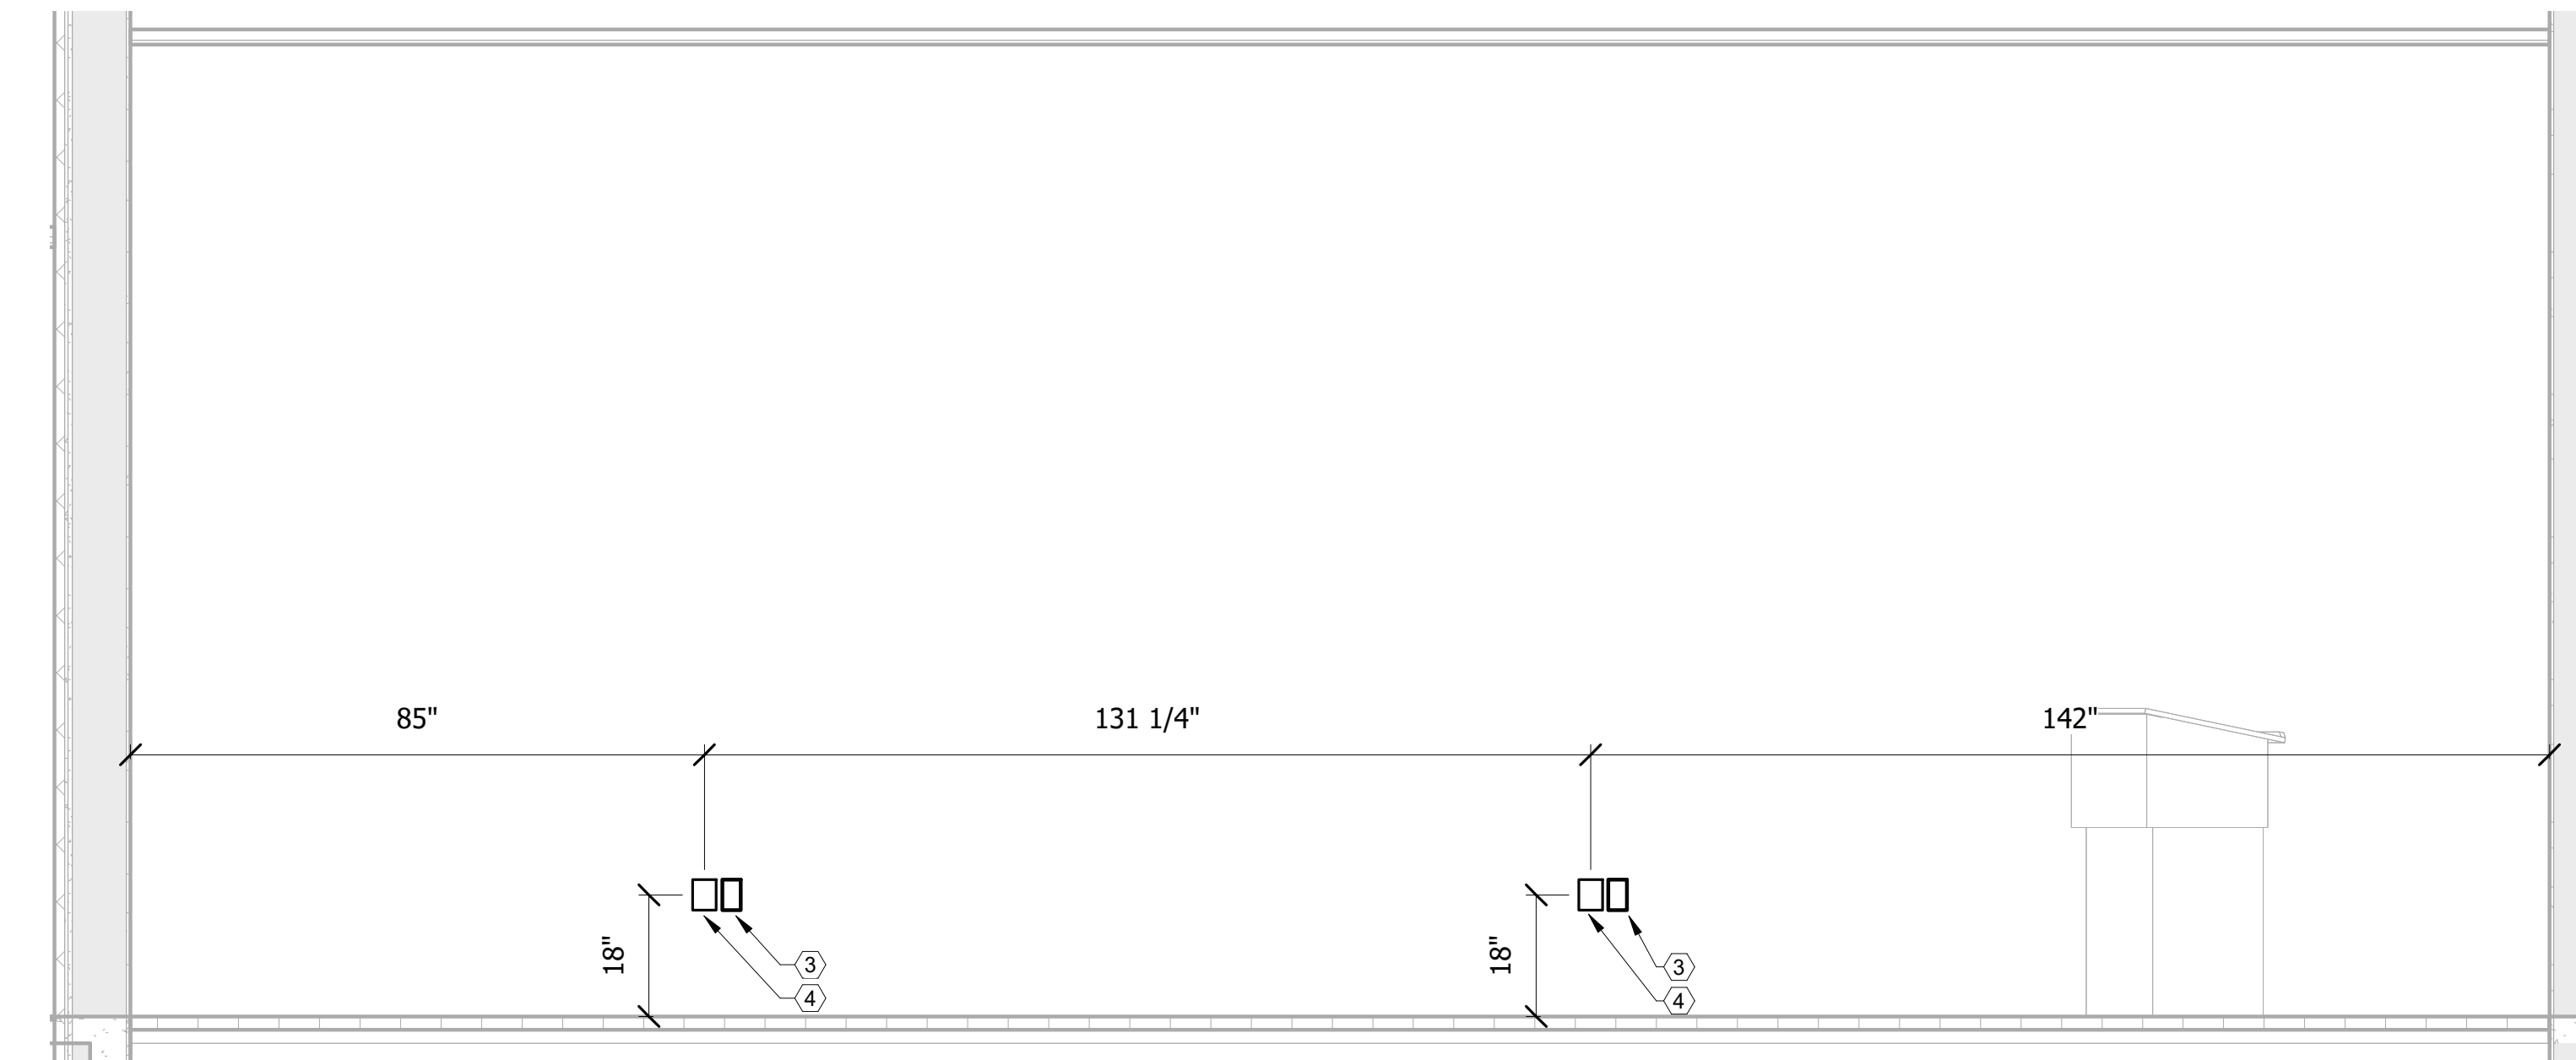

SIMULATION CLASSROOM 300Z

SCALE: 1/2" = 1'-0"

A3

UNCLASSIFIED

KEYNOTE LEGEND

1	CHIEF PAC 526 (DUPLEX, 2D) SEE DETAIL A2/TA501
2	BACKING TO SUPPORT FIVE TIMES WEIGHT OF DISPLAY AND MOUNT
3	DUPLEX RECEPTACLE
4	ONE GANG AV BACK BOX



FOR COMMANDER NAVFAC

ACTIVITY
MARINE CORPS BASE
CAMP LEJEUNE

SATISFACTORY TO DATE

DES AS DRW AV CHK BM

PM

BRANCH MANAGER

CHIEF ENGINEER

FIRE PROTECTION

NAVAL FACILITIES ENGINEERING COMMAND

NAVAL FACILITIES ENGINEERING COMMAND ~ MID-ATLANTIC

ROCC FLORENCE CAMP LEJEUNE

MOB CAMP LEJEUNE

P1338F II MEF SIMULATION/TRAINING CENTER

REPLACEMENT

AUDIOVISUAL - ELEVATIONS

SCALE: AS NOTED

EPROJECT NO.:


CONSTR. CONTR. NO.

N40085-20-C-0059

NAVFAC DRAWING NO.

SHEET OF

TA406

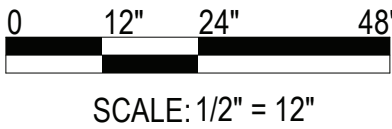

DP2 SUBMISSION - P1338 BUILDING PRE-FINAL SUBMISSION

UNCLASSIFIED



PRE-17





FILE NAME: BIM 360/HF PACKAGE 3P1338_MEF SIM CTR-1500802-T.rvt
PLOTTED: 6/9/2021 6:52:31 AM

A

B


C

D

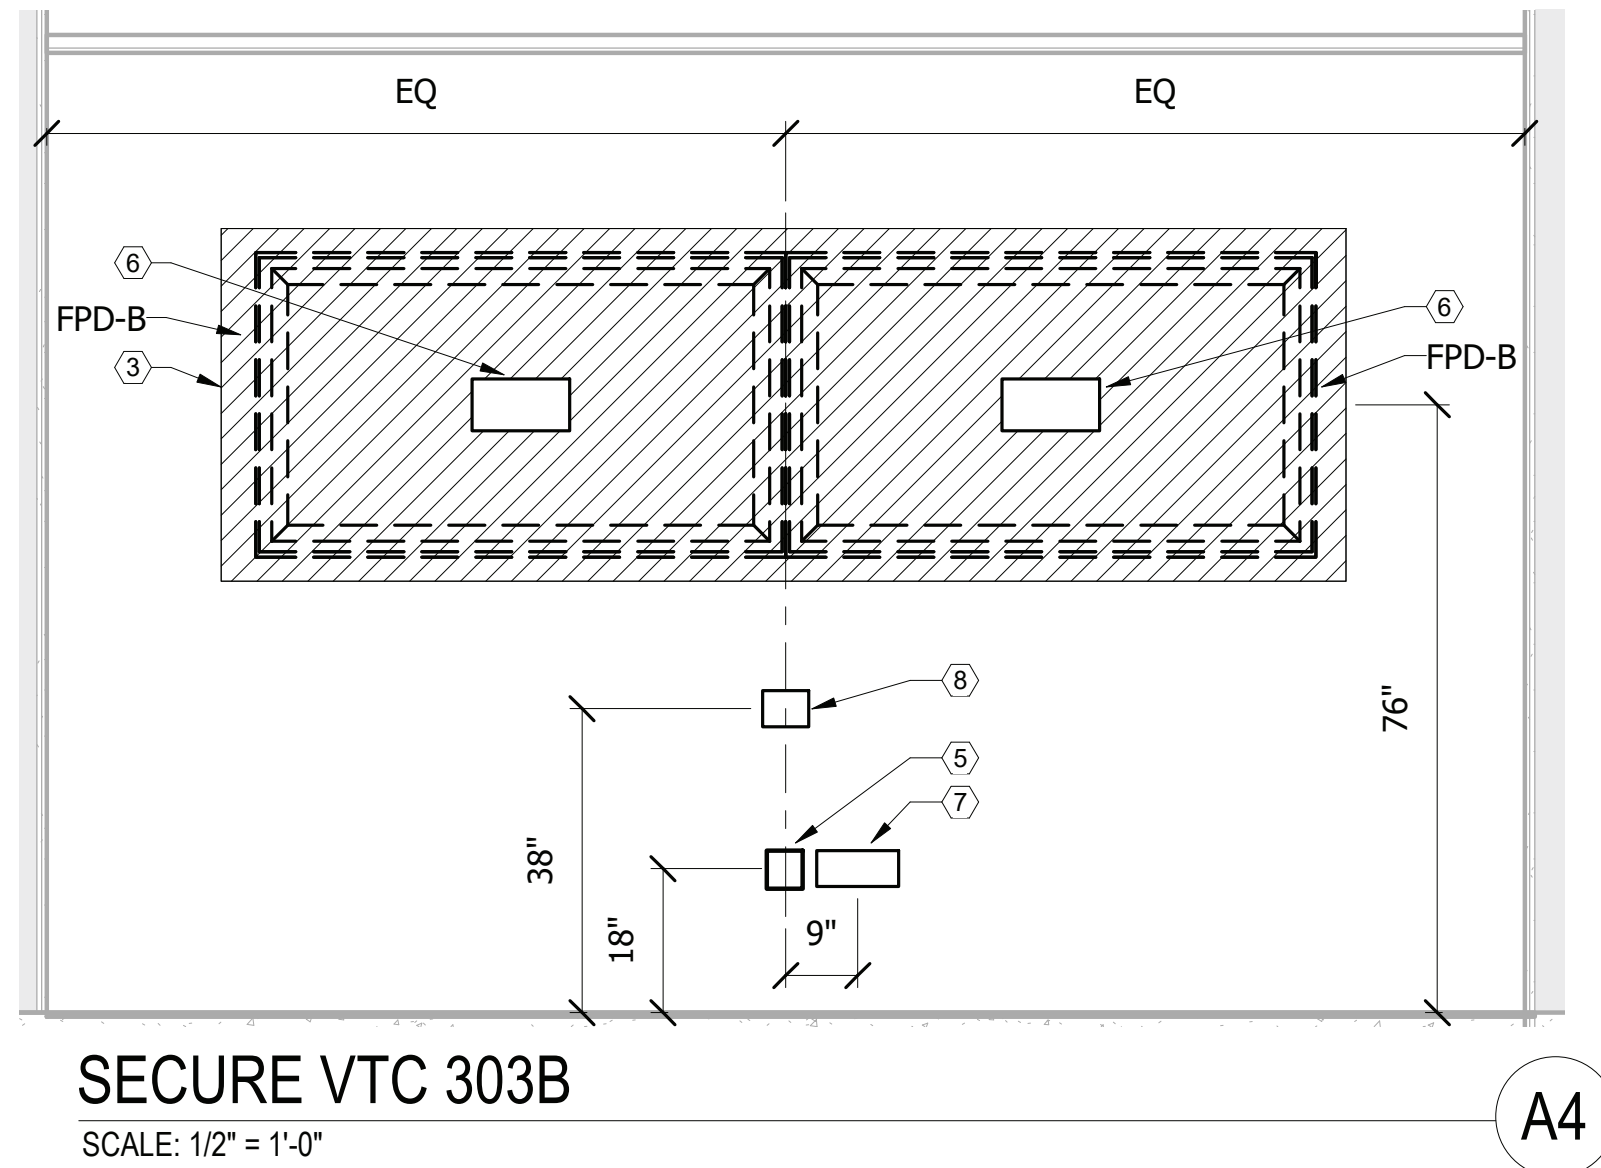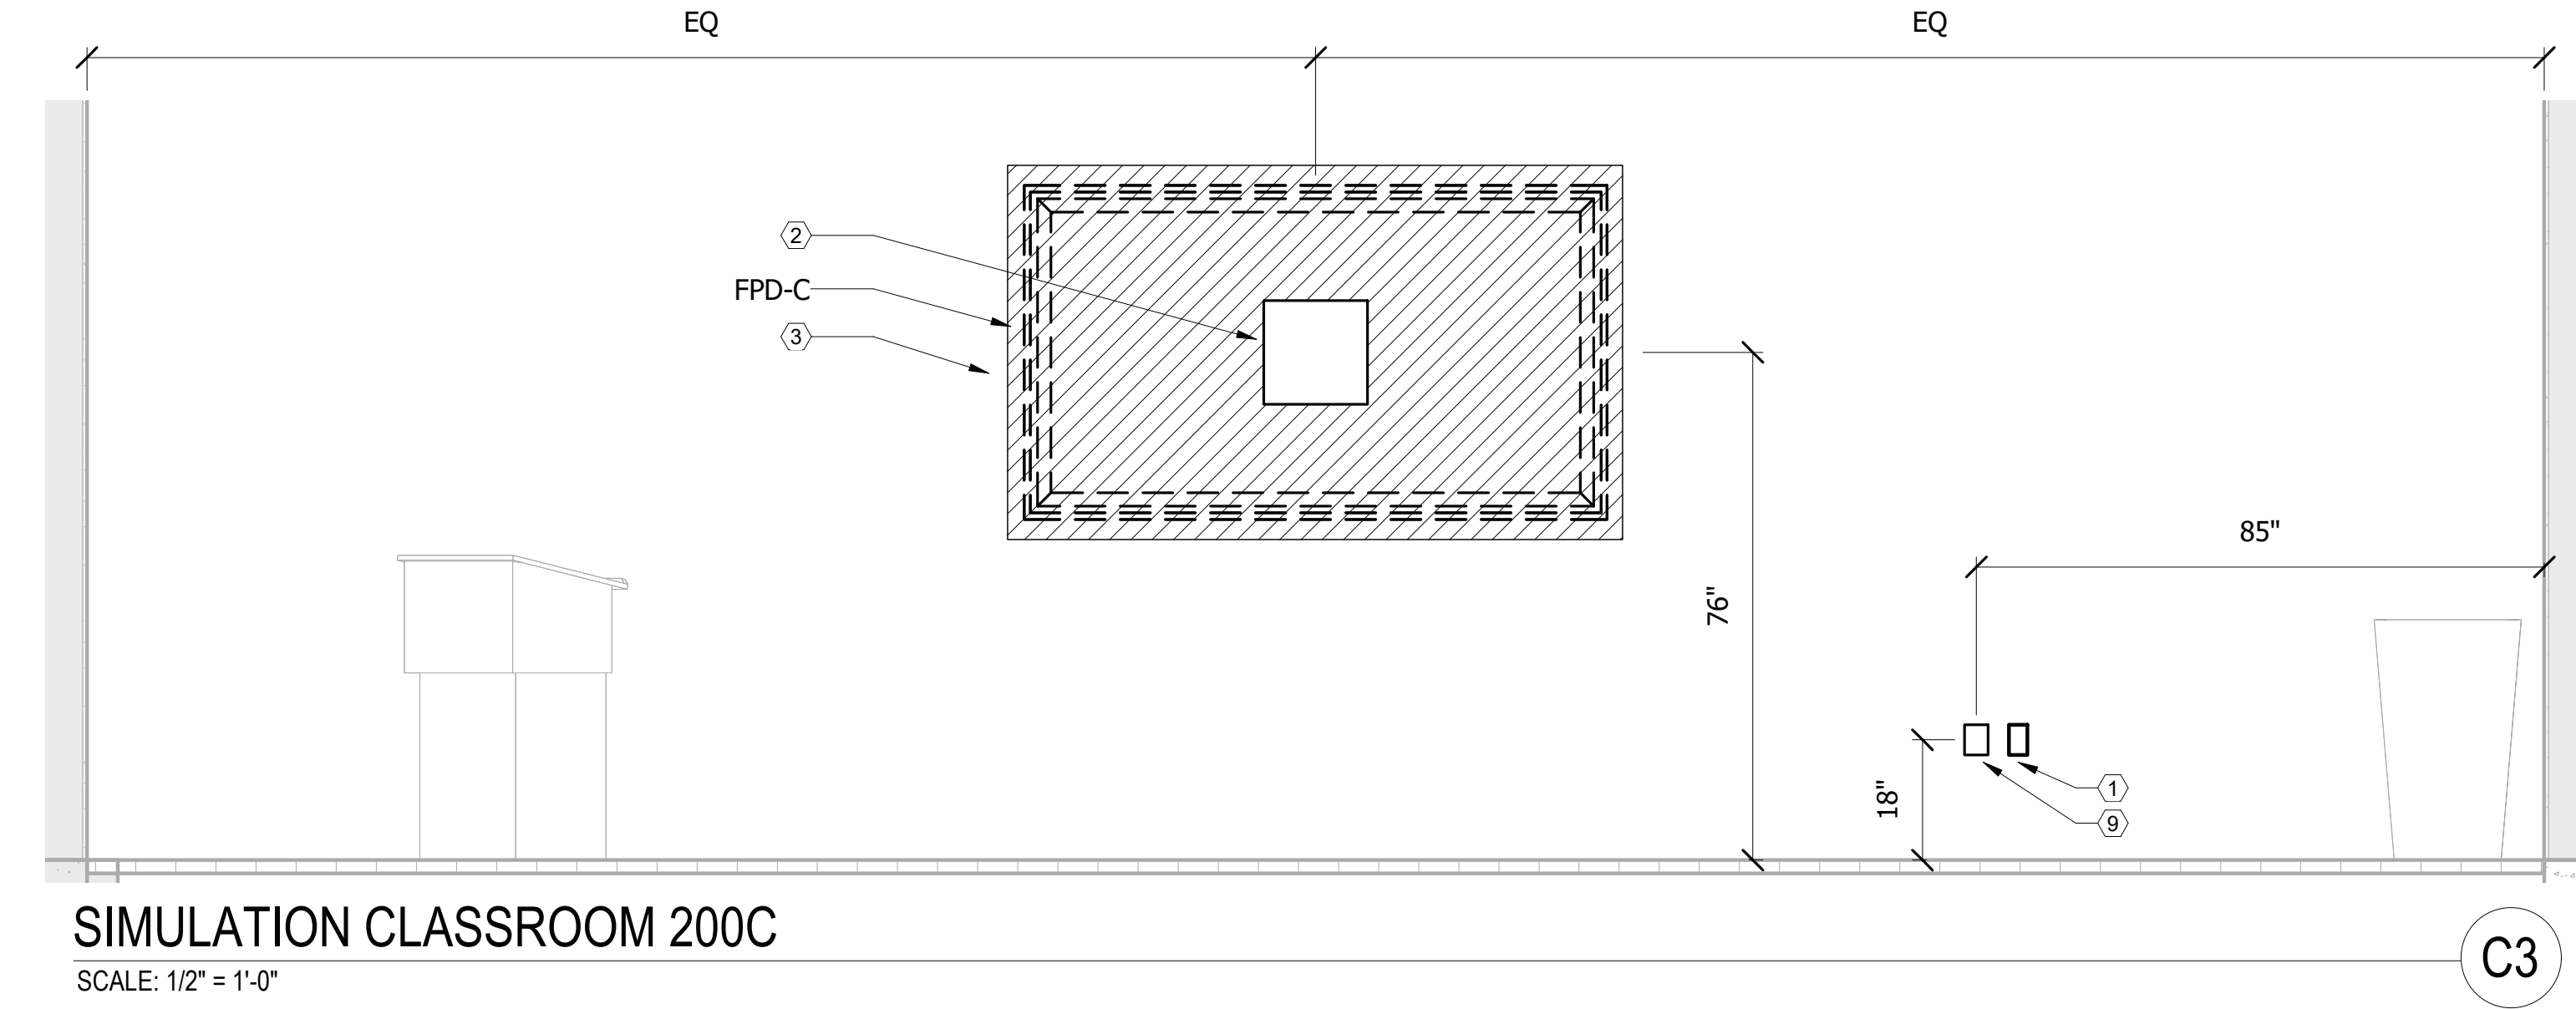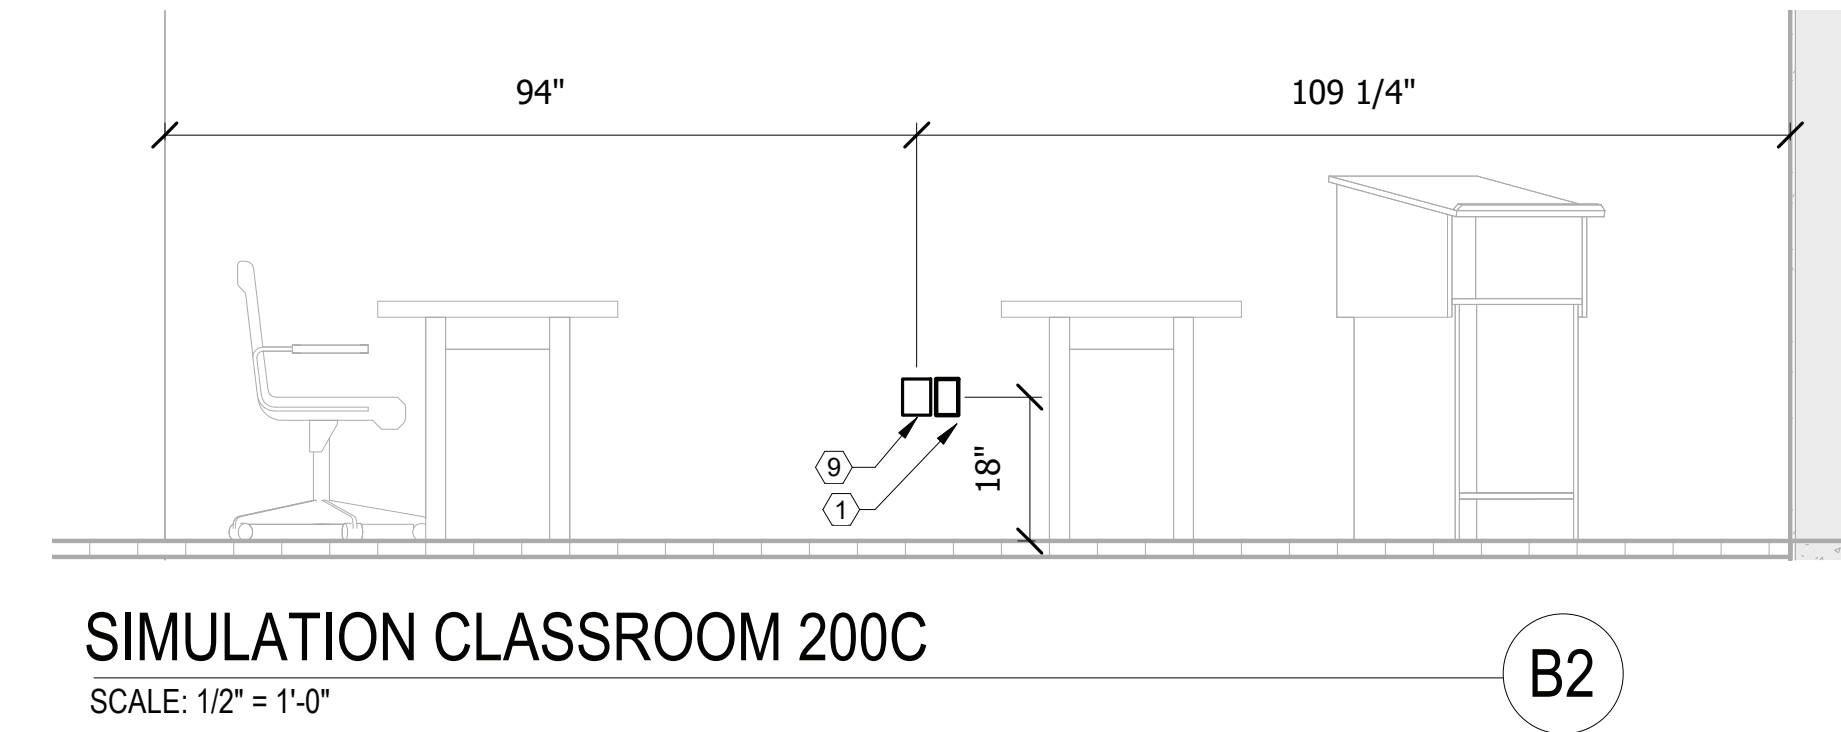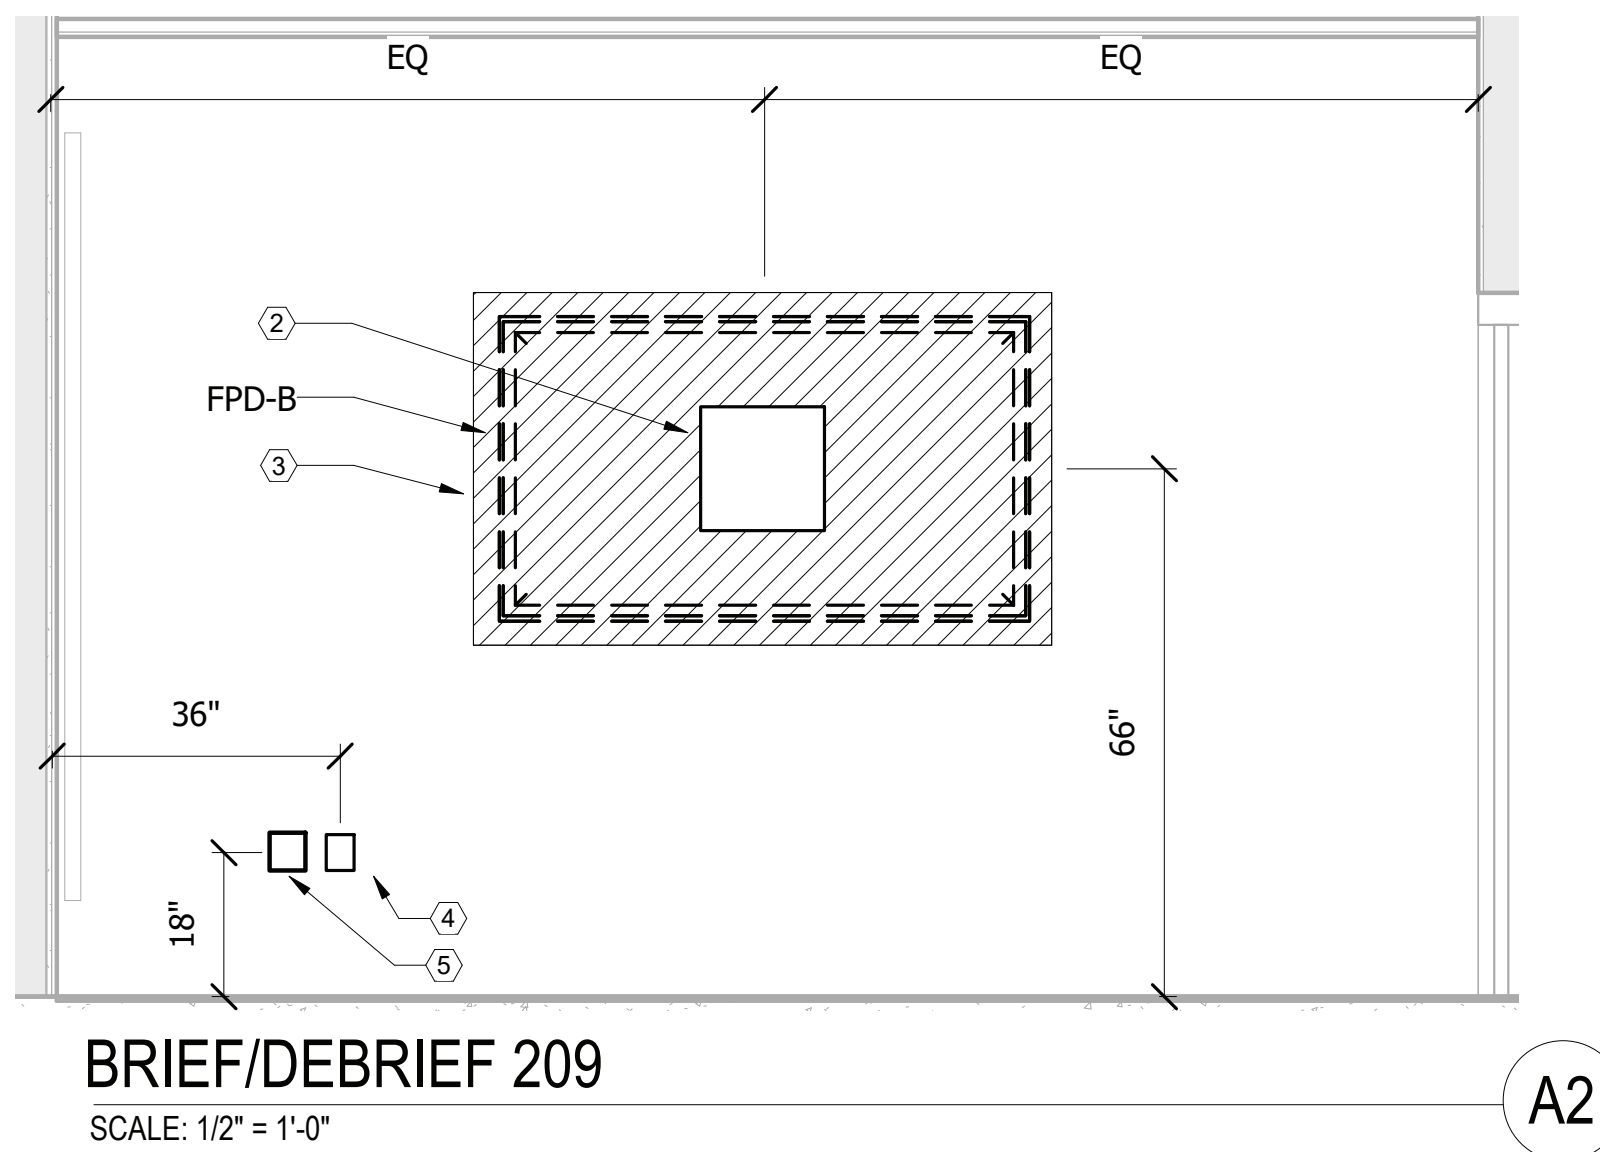

KEYNOTE LEGEND

1	DUPLEX RECEPTACLE
2	CHIEF PAC 526 (DUPLEX, 2D) SEE DETAIL A2/TA501
3	BACKING TO SUPPORT FIVE TIMES WEIGHT OF DISPLAY AND MOUNT
4	ONE GANG AV BACK BOX
5	QUAD RECEPTACLE
6	FSR PWB-100 (DUPLEX, 2D) SEE DETAIL A3/TA502
7	FOUR GANG AV BACK BOX
8	TWO GANG AV BACK BOX FOR WALL MOUNTED CAMERAS
9	ONE GANG AV BACK BOX

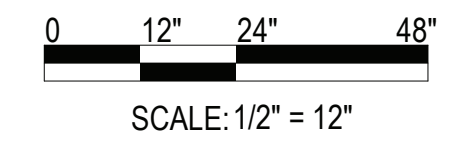

APPR	DATE	SYN	DESCRIPTION
PRELIMINARY NOT FOR CONSTRUCTION			
Michael Baker INTERNATIONAL 100 AIRSIDE DRIVE MOON TOWNSHIP, PA 15108 APPROVED			
FOR COMMANDER NAVFAC			
ACTIVITY MARINE CORPS BASE CAMP LEJEUNE			
SATISFACTORY TO DATE			
DES AS	DRW AV	CHK BM	
PM			
BRANCH MANAGER			
CHIEF ENGINEER			
FIRE PROTECTION			
NAVAL FACILITIES ENGINEERING COMMAND NAVFAC NAVFAC ENGINEERING COMMAND ~ MID-ATLANTIC JACKSONVILLE, NC ROICC FLORENCE CAMP LEJEUNE MOB CAMP LEJEUNE P1338F II MEF SIMULATION/TRAINING CENTER REPLACEMENT AUDIOVISUAL - ELEVATIONS			
SCALE: AS NOTED			
EPROJECT NO.:			
CONSTR. CONTR. NO. N400085-20-C-0059			
NAVFAC DRAWING NO.			
SHEET OF			
TA408			

DP2 SUBMISSION - P1338 BUILDING PRE-FINAL SUBMISSION

UNCLASSIFIED

D

C

B

A

UNCLASSIFIED

PLOTTED: 6/9/2021 6:52:32 AM


FILE NAME: BIM 360//HF PACKAGE 3P1338_MEF SIM CTR-1500892-T.rvt

D

C

B

A

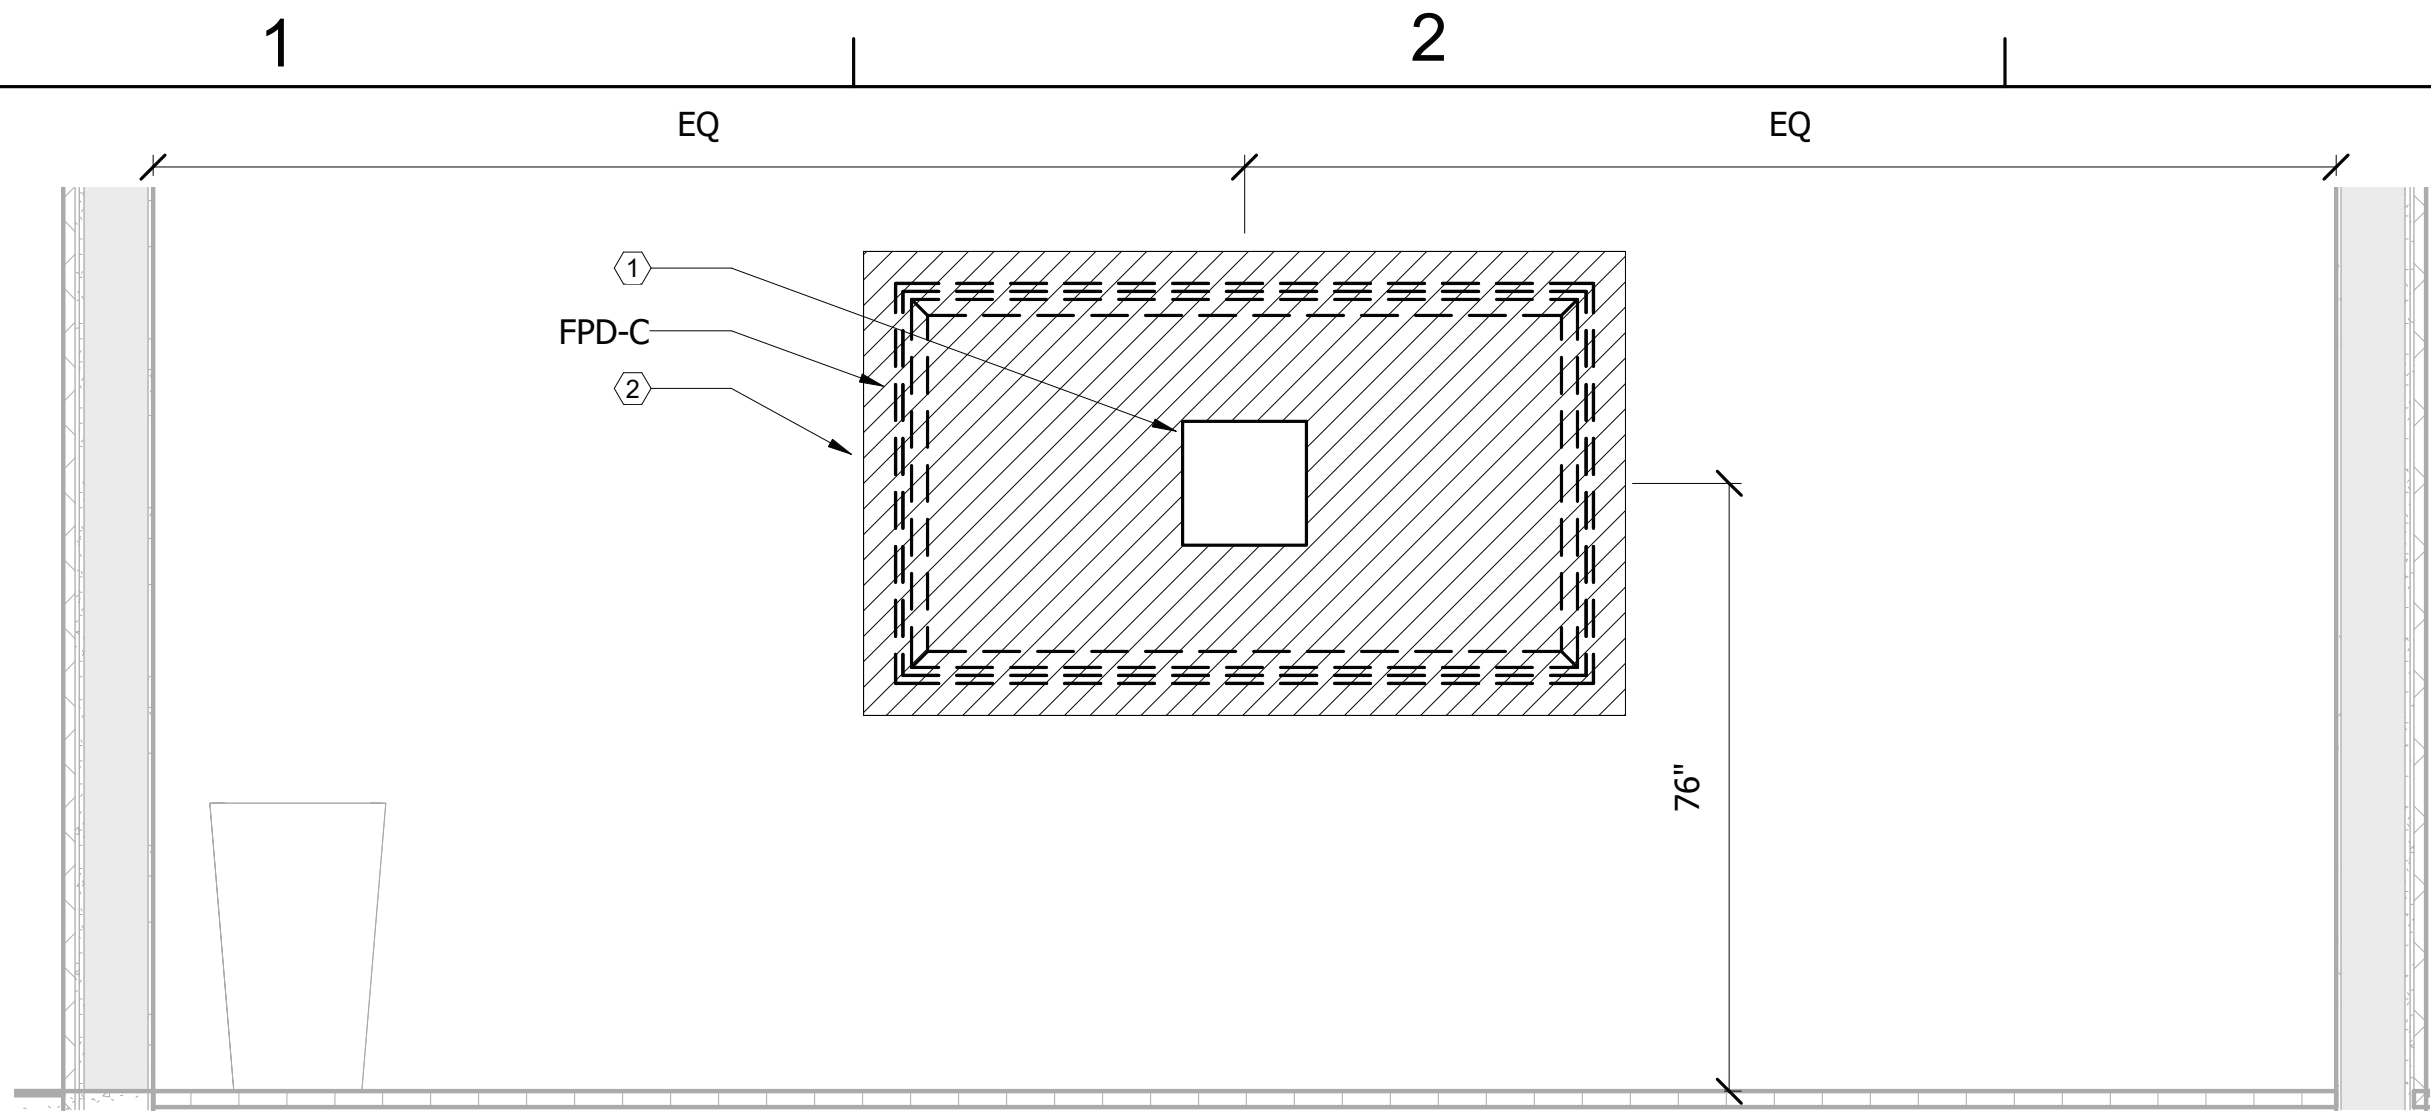


SIMULATION CLASSROOM 301A

SCALE: 1/2" = 1'-0"

TA113

C3

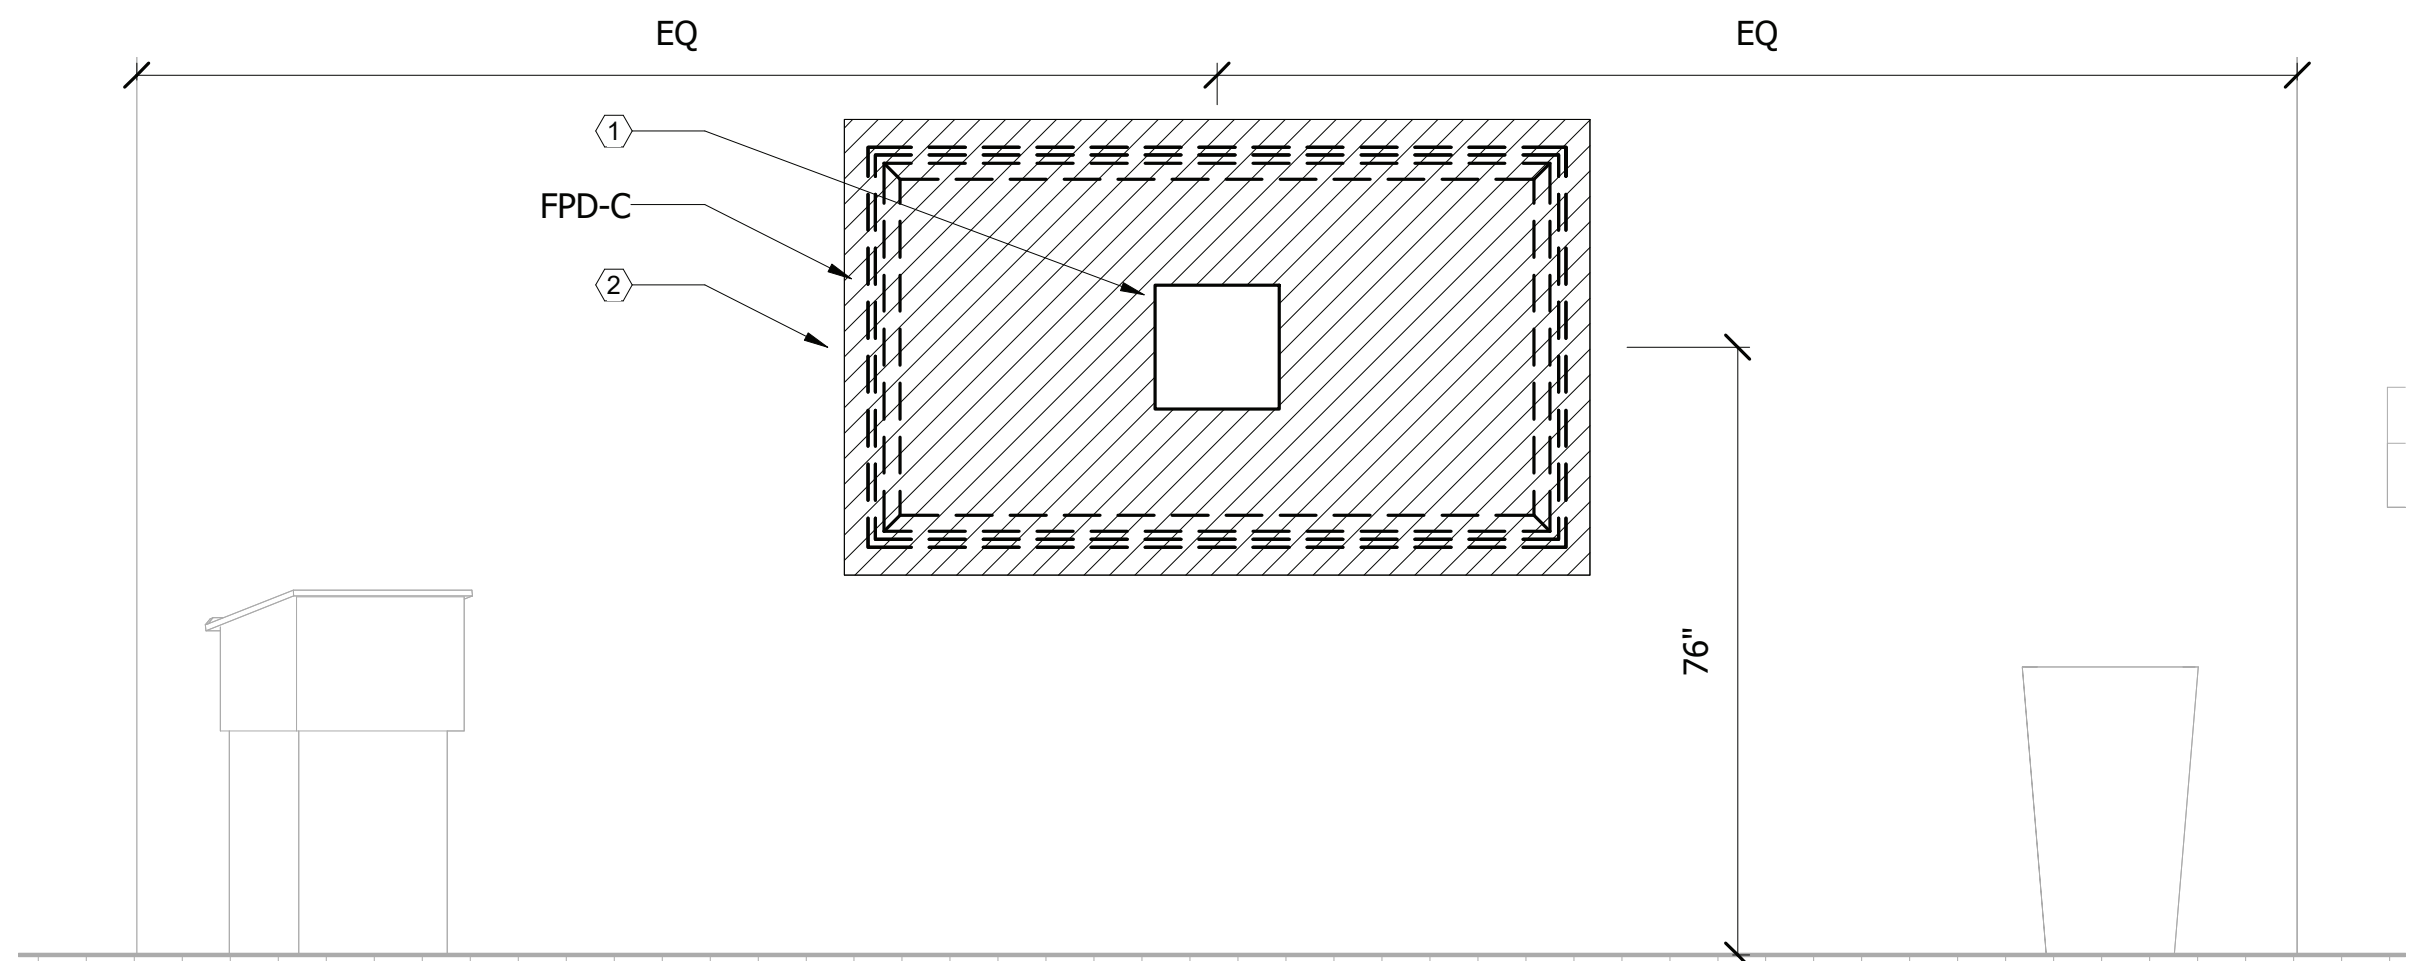


SIMULATION CLASSROOM 301B

SCALE: 1/2" = 1'-0"

TA113


B3

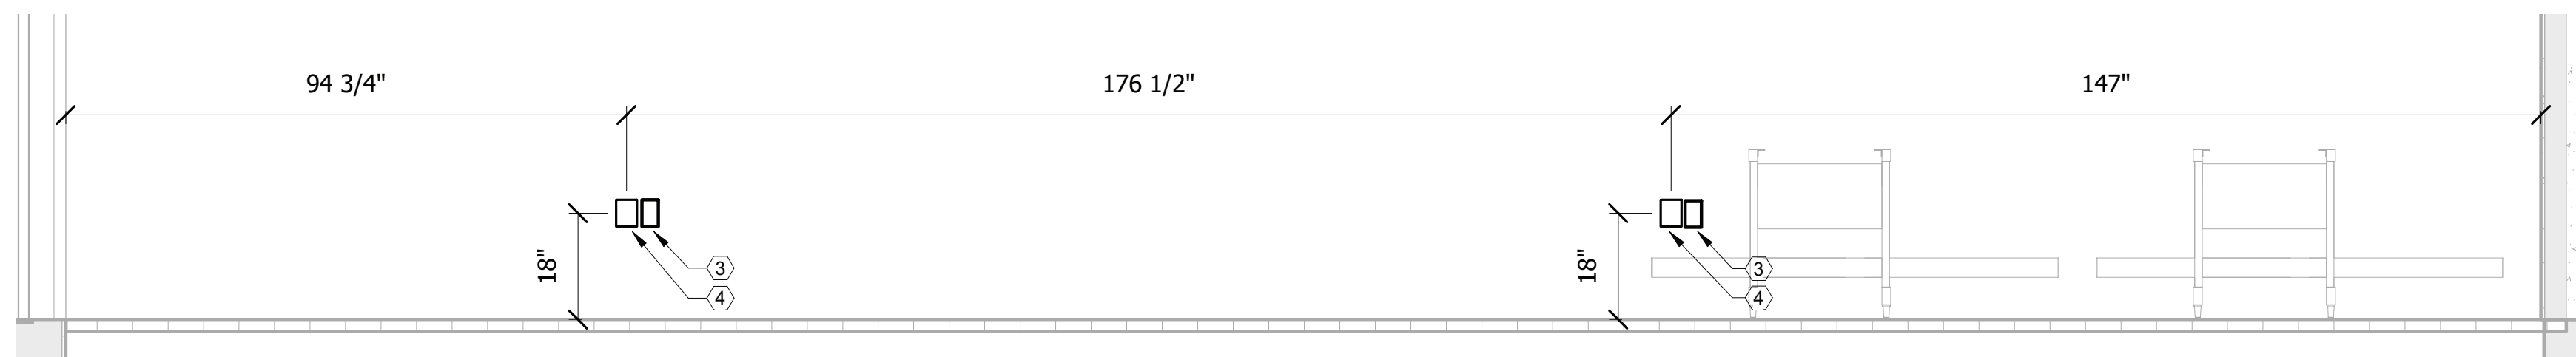

SIMULATION CLASSROOM 301A

SCALE: 1/2" = 1'-0"

B4

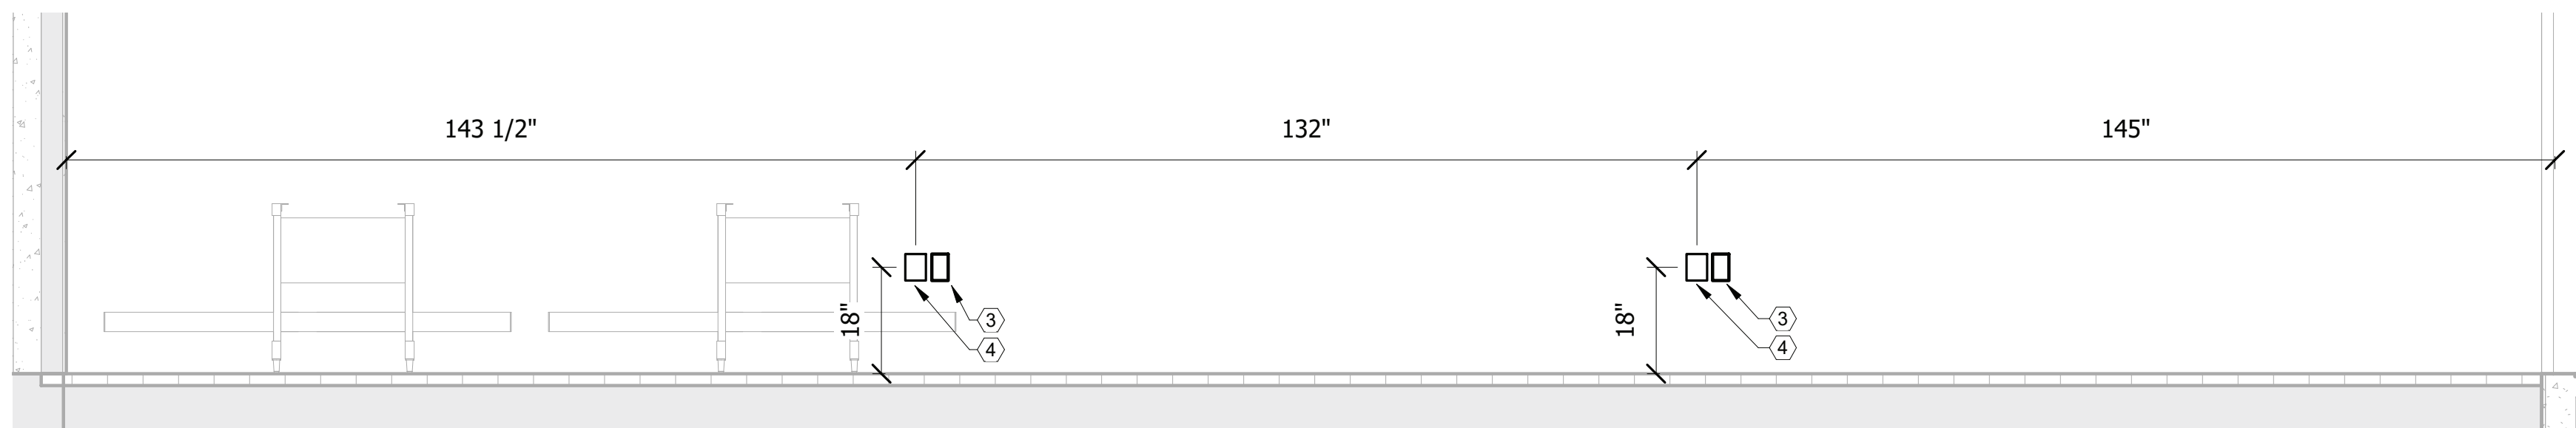

SIMULATION CLASSROOM 301B

SCALE: 1/2" = 1'-0"

A4

UNCLASSIFIED

KEYNOTE LEGEND

1	CHIEF PAC 526 (DUPLEX, 2D) SEE DETAIL A2/TA501
2	BACKING TO SUPPORT FIVE TIMES WEIGHT OF DISPLAY AND MOUNT
3	DUPLEX RECEPTACLE
4	ONE GANG AV BACK BOX



FOR COMMANDER NAVFAC

ACTIVITY
MARINE CORPS BASE
CAMP LEJEUNE

SATISFACTORY TO DATE

DES AS DRW AV CHK BM

PM

BRANCH MANAGER

CHIEF ENGINEER

FIRE PROTECTION

NAVAL FACILITIES ENGINEERING COMMAND

NAVAL FACILITIES ENGINEERING COMMAND ~ MID-ATLANTIC

ROICC FLORENCE CAMP LEJEUNE JACKSONVILLE, NC

MOB CAMP LEJEUNE JACKSONVILLE, NC

P1338F II MEF SIMULATION/TRAINING CENTER

REPLACEMENT

AUDIOVISUAL - ELEVATIONS

DP2 SUBMISSION - P1338 BUILDING PRE-FINAL SUBMISSION

SCALE: AS NOTED

EPROJECT NO.:


CONSTR. CONTR. NO.

N40085-20-C-0059

NAVFAC DRAWING NO.

SHEET OF

TA409

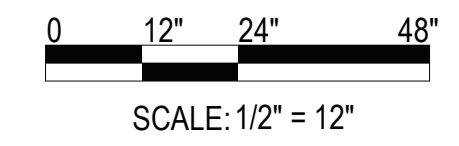

SCALE: 1/2" = 12"

SCALE: 1/2" = 12"

UNCLASSIFIED

DP2 SUBMISSION - P1338 BUILDING PRE-FINAL SUBMISSION


FILE NAME: BIM 360/HF PACKAGE 3P1338_MEF SIM CTR-1500892-T.rvt
PLOTTED: 6/9/2021 6:52:35 AM

D

C

B


A

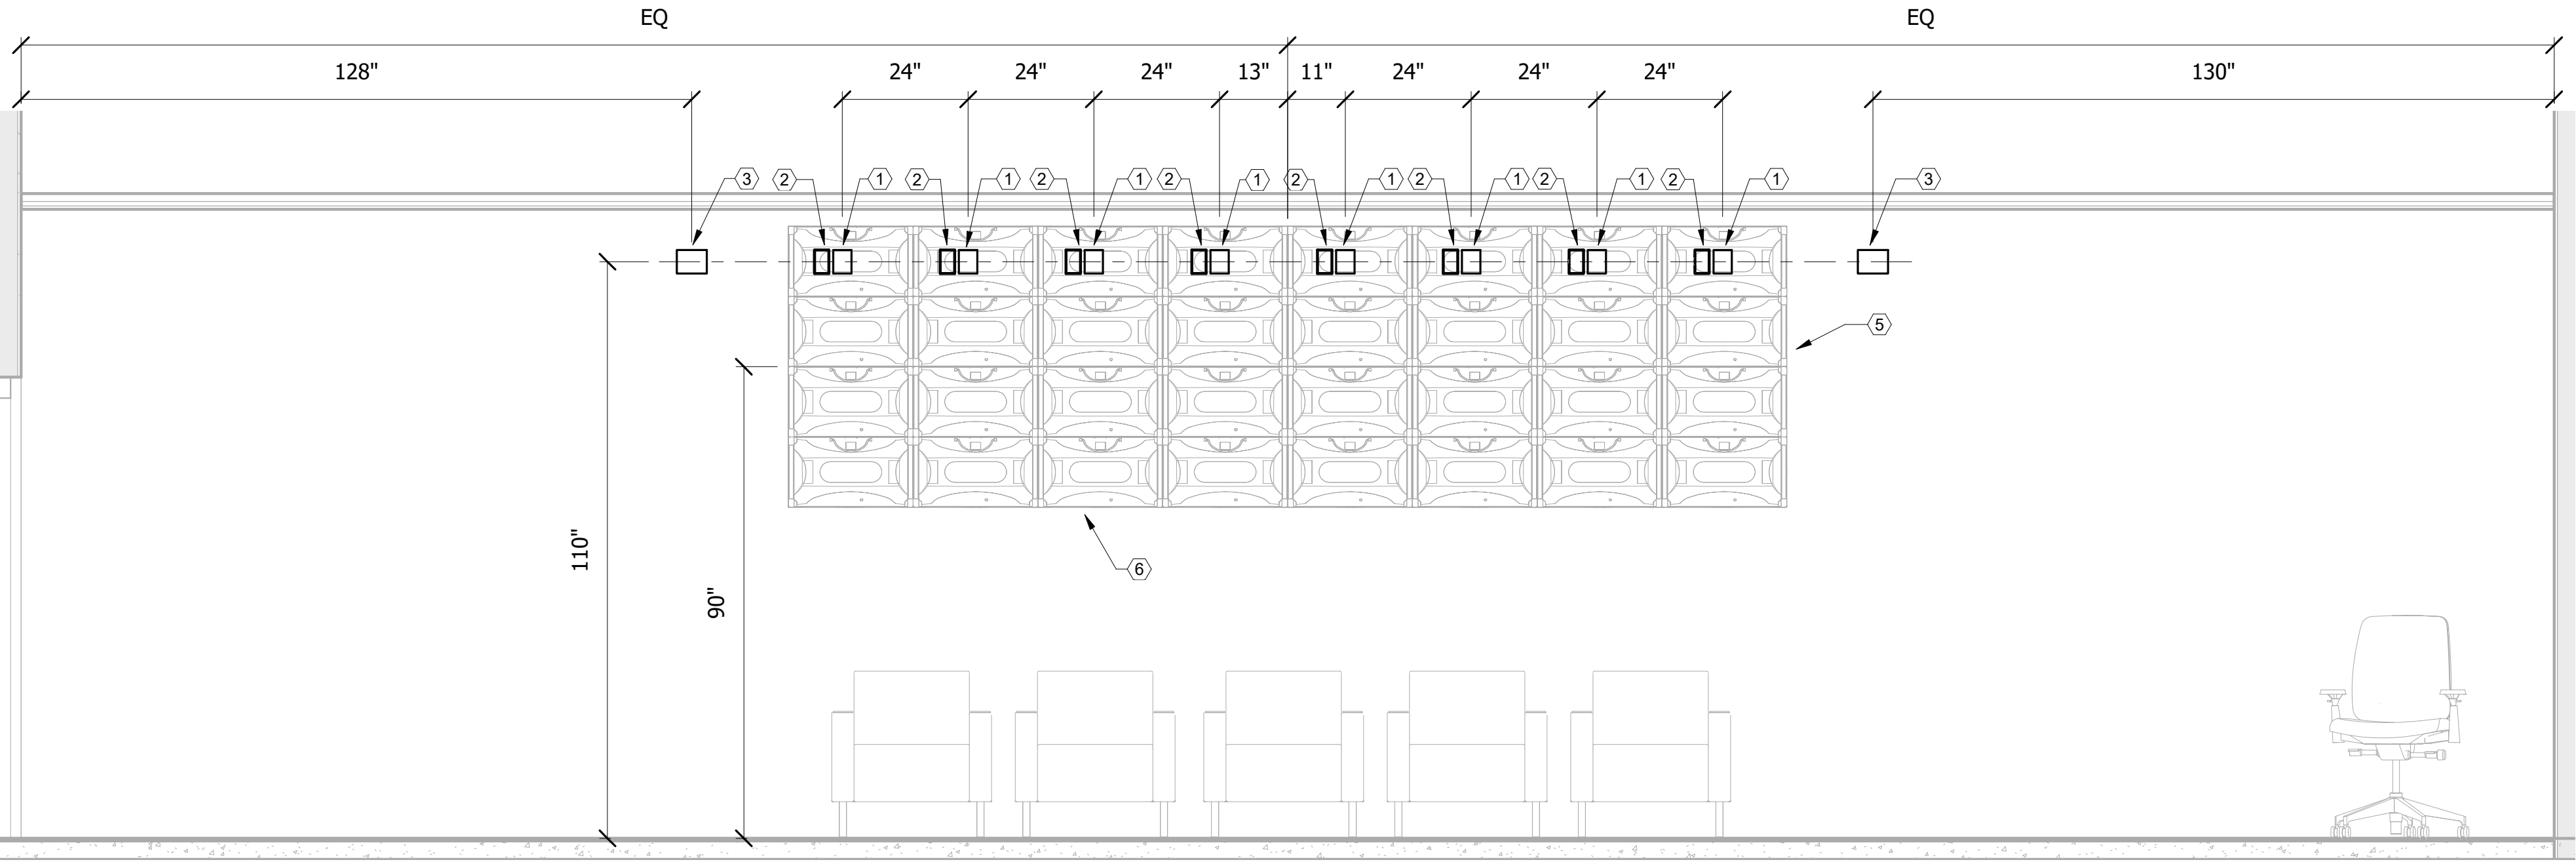

AUDITORIUM/READY ROOM 201

SCALE: 1/2" = 1'-0"

C4

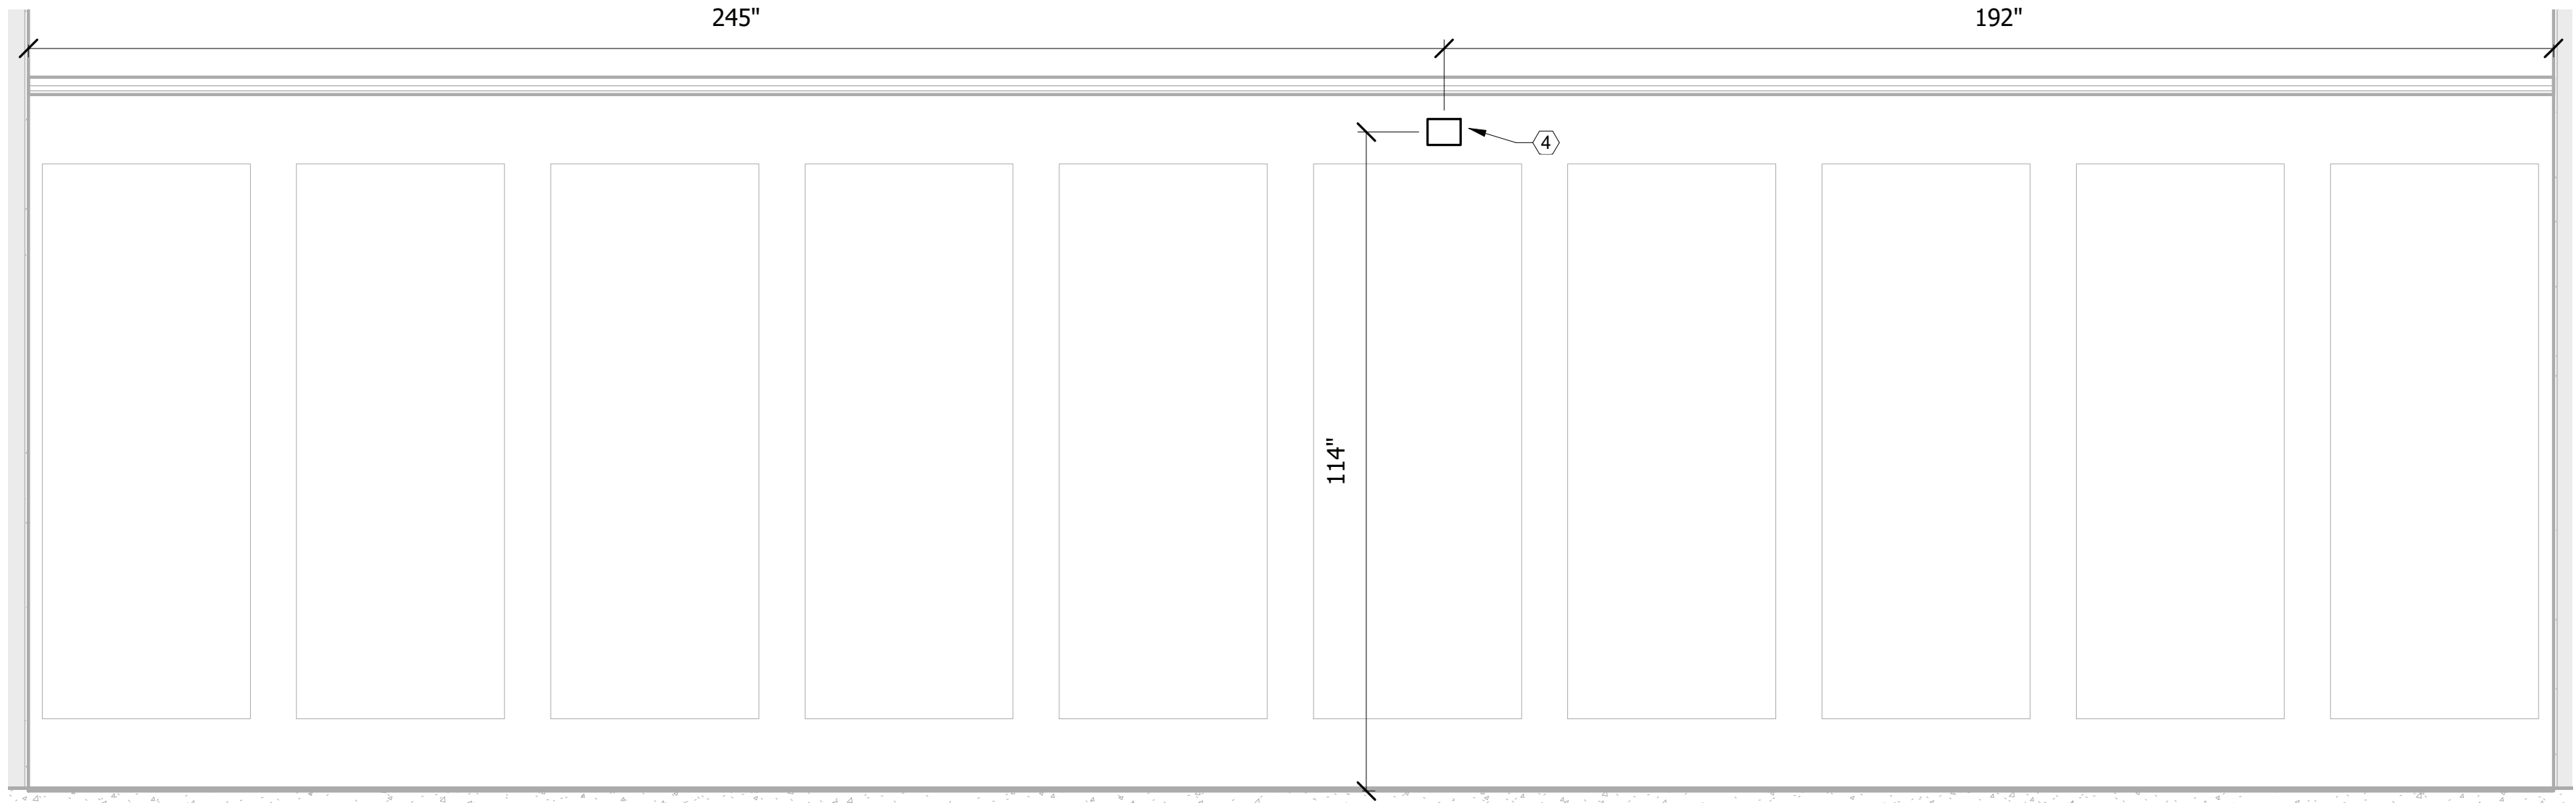

AUDITORIUM/READY ROOM 201

SCALE: 1/2" = 1'-0"

A4

UNCLASSIFIED

KEYNOTE LEGEND

1	ONE GANG AV BACK BOX
2	RECESSED CLOCK RECEPTACLE
3	TWO GANG AV BACK BOX FOR WALL MOUNTED CAMERAS
4	TWO GANG AV BACK BOX
5	BACKING TO SUPPORT FIVE TIMES WEIGHT OF DISPLAY AND MOUNT
6	COORDINATE FINAL LOCATION WITH INTERIORS PRIOR TO INSTALLATION



100 AIRSIDE DRIVE
MOON TOWNSHIP, PA 15108
APPROVED

FOR COMMANDER NAVFAC

ACTIVITY
MARINE CORPS BASE
CAMP LEJEUNE

SATISFACTORY TO DATE

DES DRW CHK

PM

BRANCH MANAGER

CHIEF ENGINEER

FIRE PROTECTION

NAVAL FACILITIES ENGINEERING COMMAND
JACKSONVILLE, NC

NAVAL FACILITIES ENGINEERING COMMAND ~ MID-ATLANTIC
JACKSONVILLE, NC

ROCC FLORENCE CAMP LEJEUNE
MOB CAMP LEJEUNE

P1338F II MEF SIMULATION/TRAINING CENTER
REPLACEMENT

AUDIOVISUAL - ELEVATIONS

SCALE: AS NOTED


EPROJECT NO.: 1590892

CONSTR. CONTR. NO.
N40085-20-C-0059

NAVFAC DRAWING NO.

SHEET OF

TA411


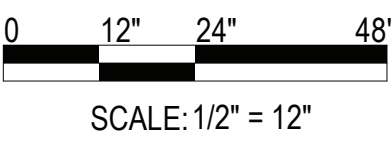


DP2 SUBMISSION - P1338 BUILDING - PRE-FINAL SUBMISSION

UNCLASSIFIED




  DP2 SUBMISSION – P1338 BUILDING PRE-FINAL SUBMISSION




5


5

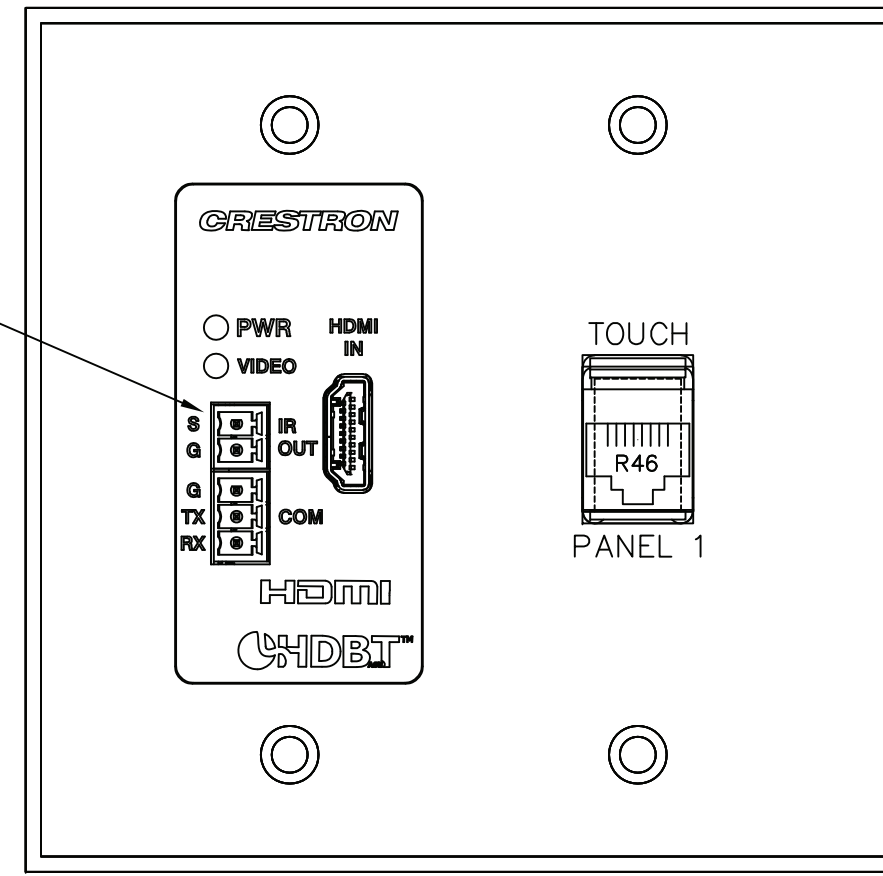


3 TWO GANG FACE PLATE
Scale: NTS

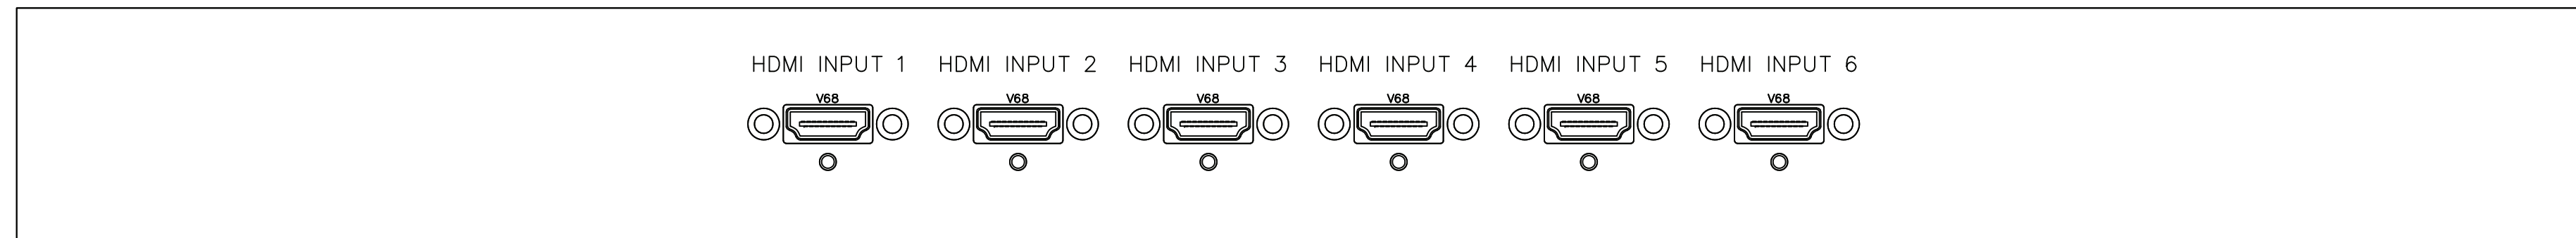

5 HDMI RACK PANEL

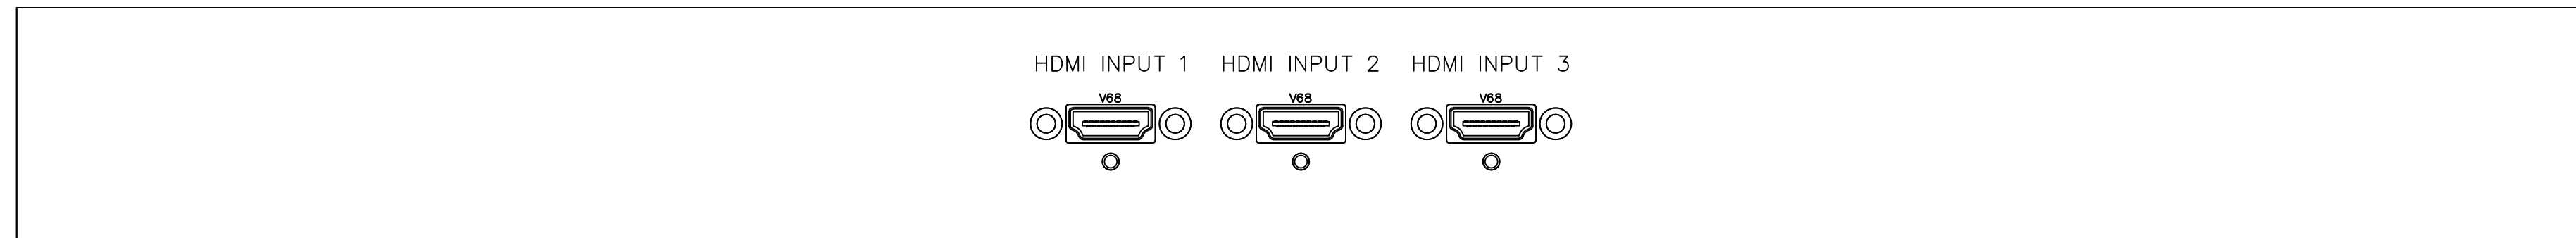

6 HDMI RACK PANEL

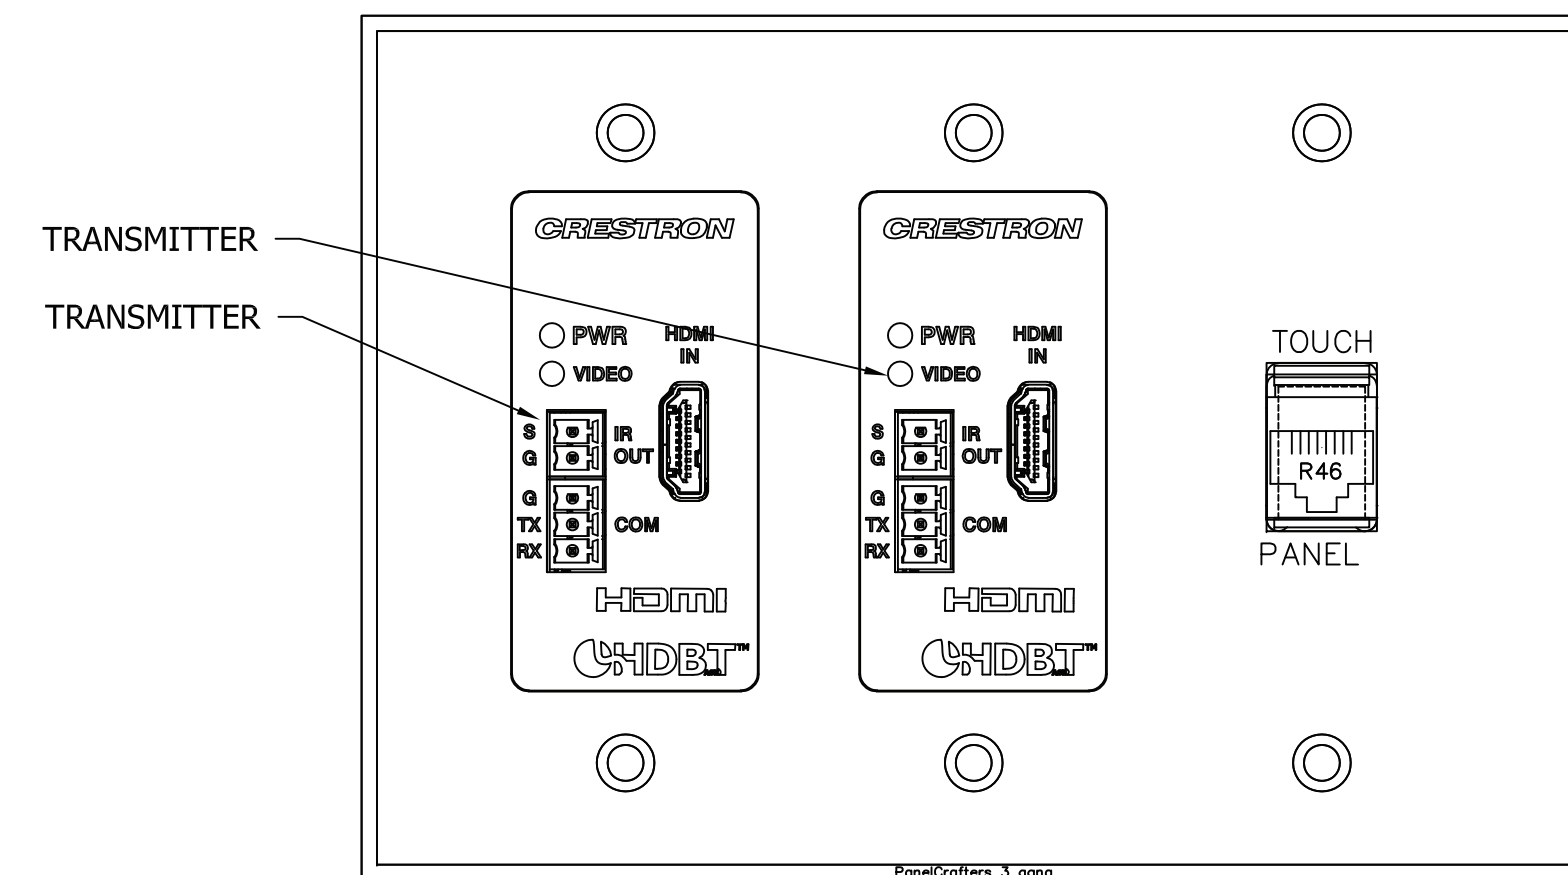

7 EXERCISE CONTROL 207 (QTY 2)

FOR COMMANDER NAVAC			
ACTIVITY			
MARINE CORPS BASE CAMP LEJEUNE			
SATISFACTORY TO DATE			DD/MM/YY
DES AS	DRW AV	CHK	BM
PM		XXX	
BRANCH MANAGER		XXX	
CHIEF ENG/ARCH		XXX	
FIRE PROTECTION		XXX	


SCALE:	NTS
EPROJECT NO.:	
CONSTR. CONTR. NO.	N40085-20-C-0059
NAVFAC DRAWING NO.	
SHEET	OF

TA503

UNCI ASSIEN

DP2 SUBMISSION – P1338 BUILDING PRE-FINAL SUBMISSION

FILE NAME: BIM 360/HF PACKAGE 3P1338_MEF SIM CTR-150082-T.v4
PLOTTED: 6/9/2021 6:52:37 AM

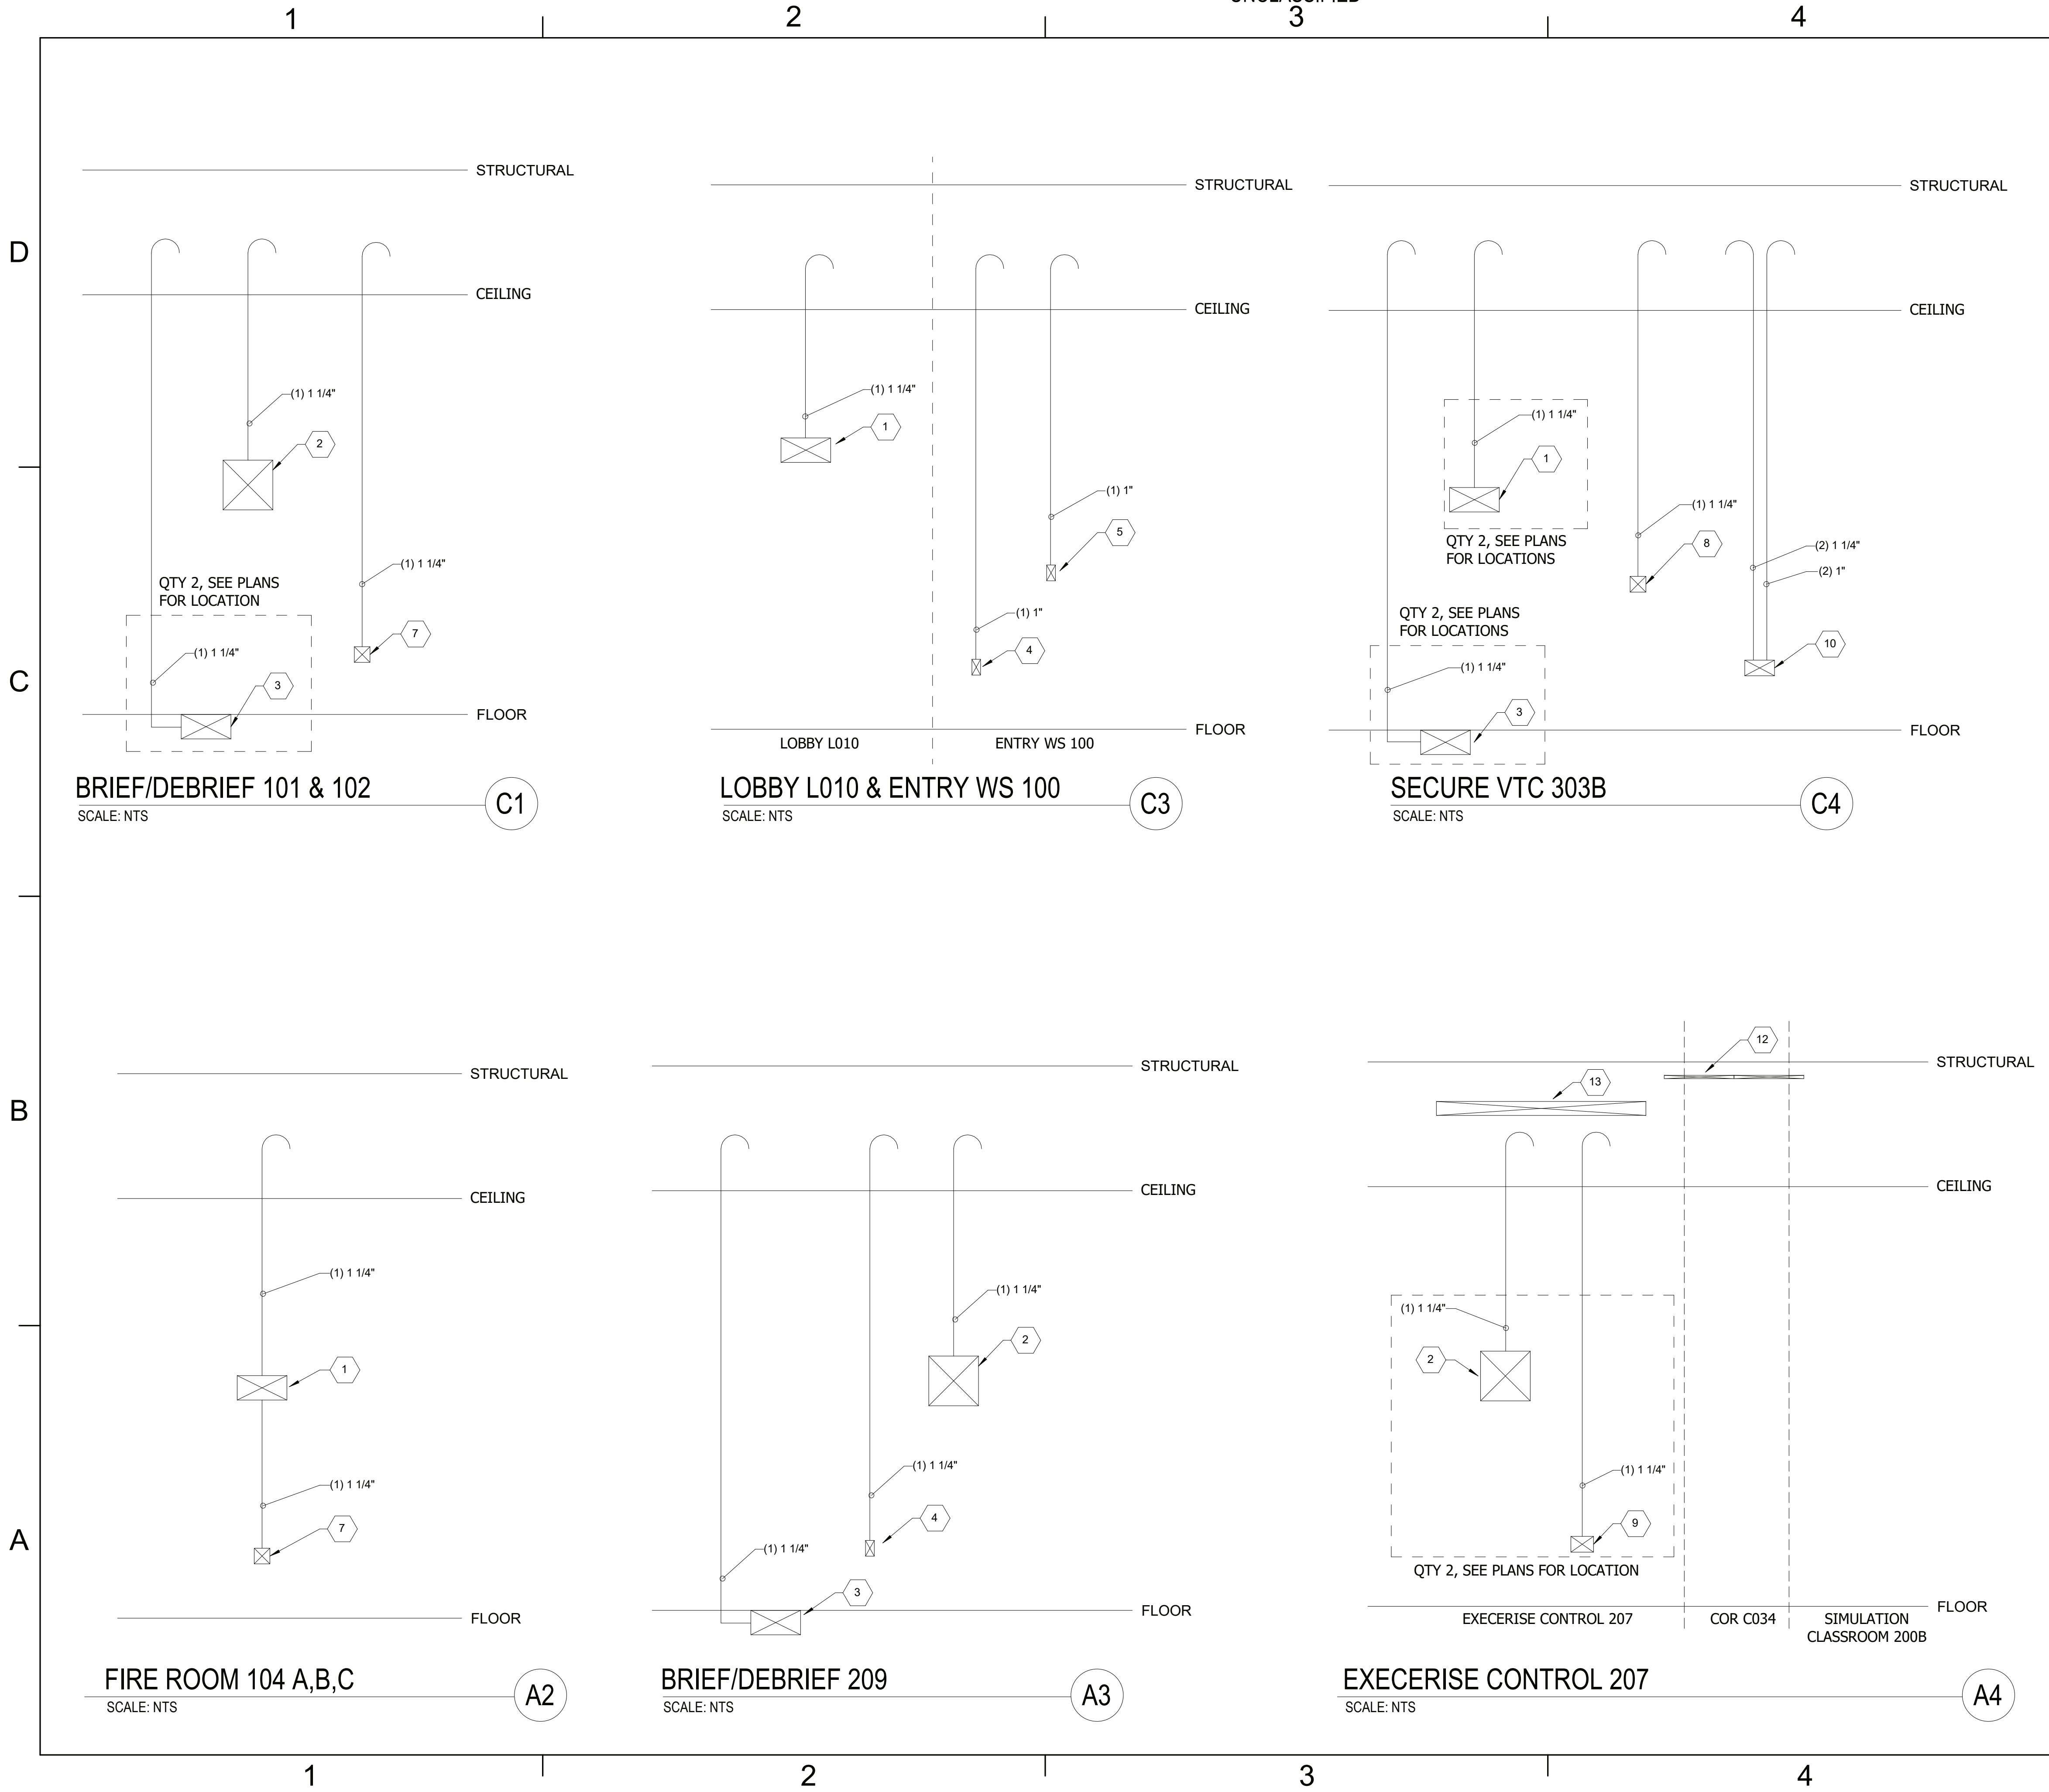

DEVICE SCHEDULE	
TAG	DESCRIPTION
1	FSR PWB-100
2	CHIEF PAC BOX 526
3	FLOOR BOX, REFER TO ELECTRICAL
4	ONE GANG AV BACK BOX
5	ONE GANG AV BACK BOX FOR AV KEYPAD
6	ONE GANG AV BACK BOX FOR ROOM AVAILABILITY SIGN
7	TWO GANG AV BACK BOX
8	TWO GANG AV BACK BOX FOR WALL MOUNTED CAMERA
9	THREE GANG AV BACK BOX
10	FOUR GANG AV BACK BOX
11	AV EQUIPMENT RACK PROVIDED BY AVC
12	CONDUIT, REFER TO EQUIPMENT PLANS FOR SIZE AND LOCATION
13	WIRE-BASKET, REFER TO EQUIPMENT PLANS FOR SIZE AND LOCATION



FOR COMMANDER NAVFAC

ACTIVITY
MARINE CORPS BASE
CAMP LEJEUNE

SATISFACTORY TO DATE

DES AS DRW AV CHK BM

PM

BRANCH MANAGER

CHIEF ENGINEER

FIRE PROTECTION

NAVAL FACILITIES ENGINEERING COMMAND ~ MID-ATLANTIC
JACKSONVILLE, NC

ROCC FLORENCE CAMP LEJEUNE
MOB CAMP LEJEUNE

P1338F II MEF SIMULATION/TRAINING CENTER
REPLACEMENT

AUDIOVISUAL - RISER DIAGRAMS

SCALE: AS NOTED

PROJECT NO.: N40085-20-C-0059

CONSTR. CONTR. NO.

NAVFAC DRAWING NO.


SHEET OF

TA601

DP2 SUBMISSION - P1338 BUILDING PRE-FINAL SUBMISSION

UNCLASSIFIED

FILE NAME: BIM 360/HF PACKAGE 3P1338_MEF SIM CTR-1500802-T.v4
PLOTTED: 6/9/2021 6:52:37 AM

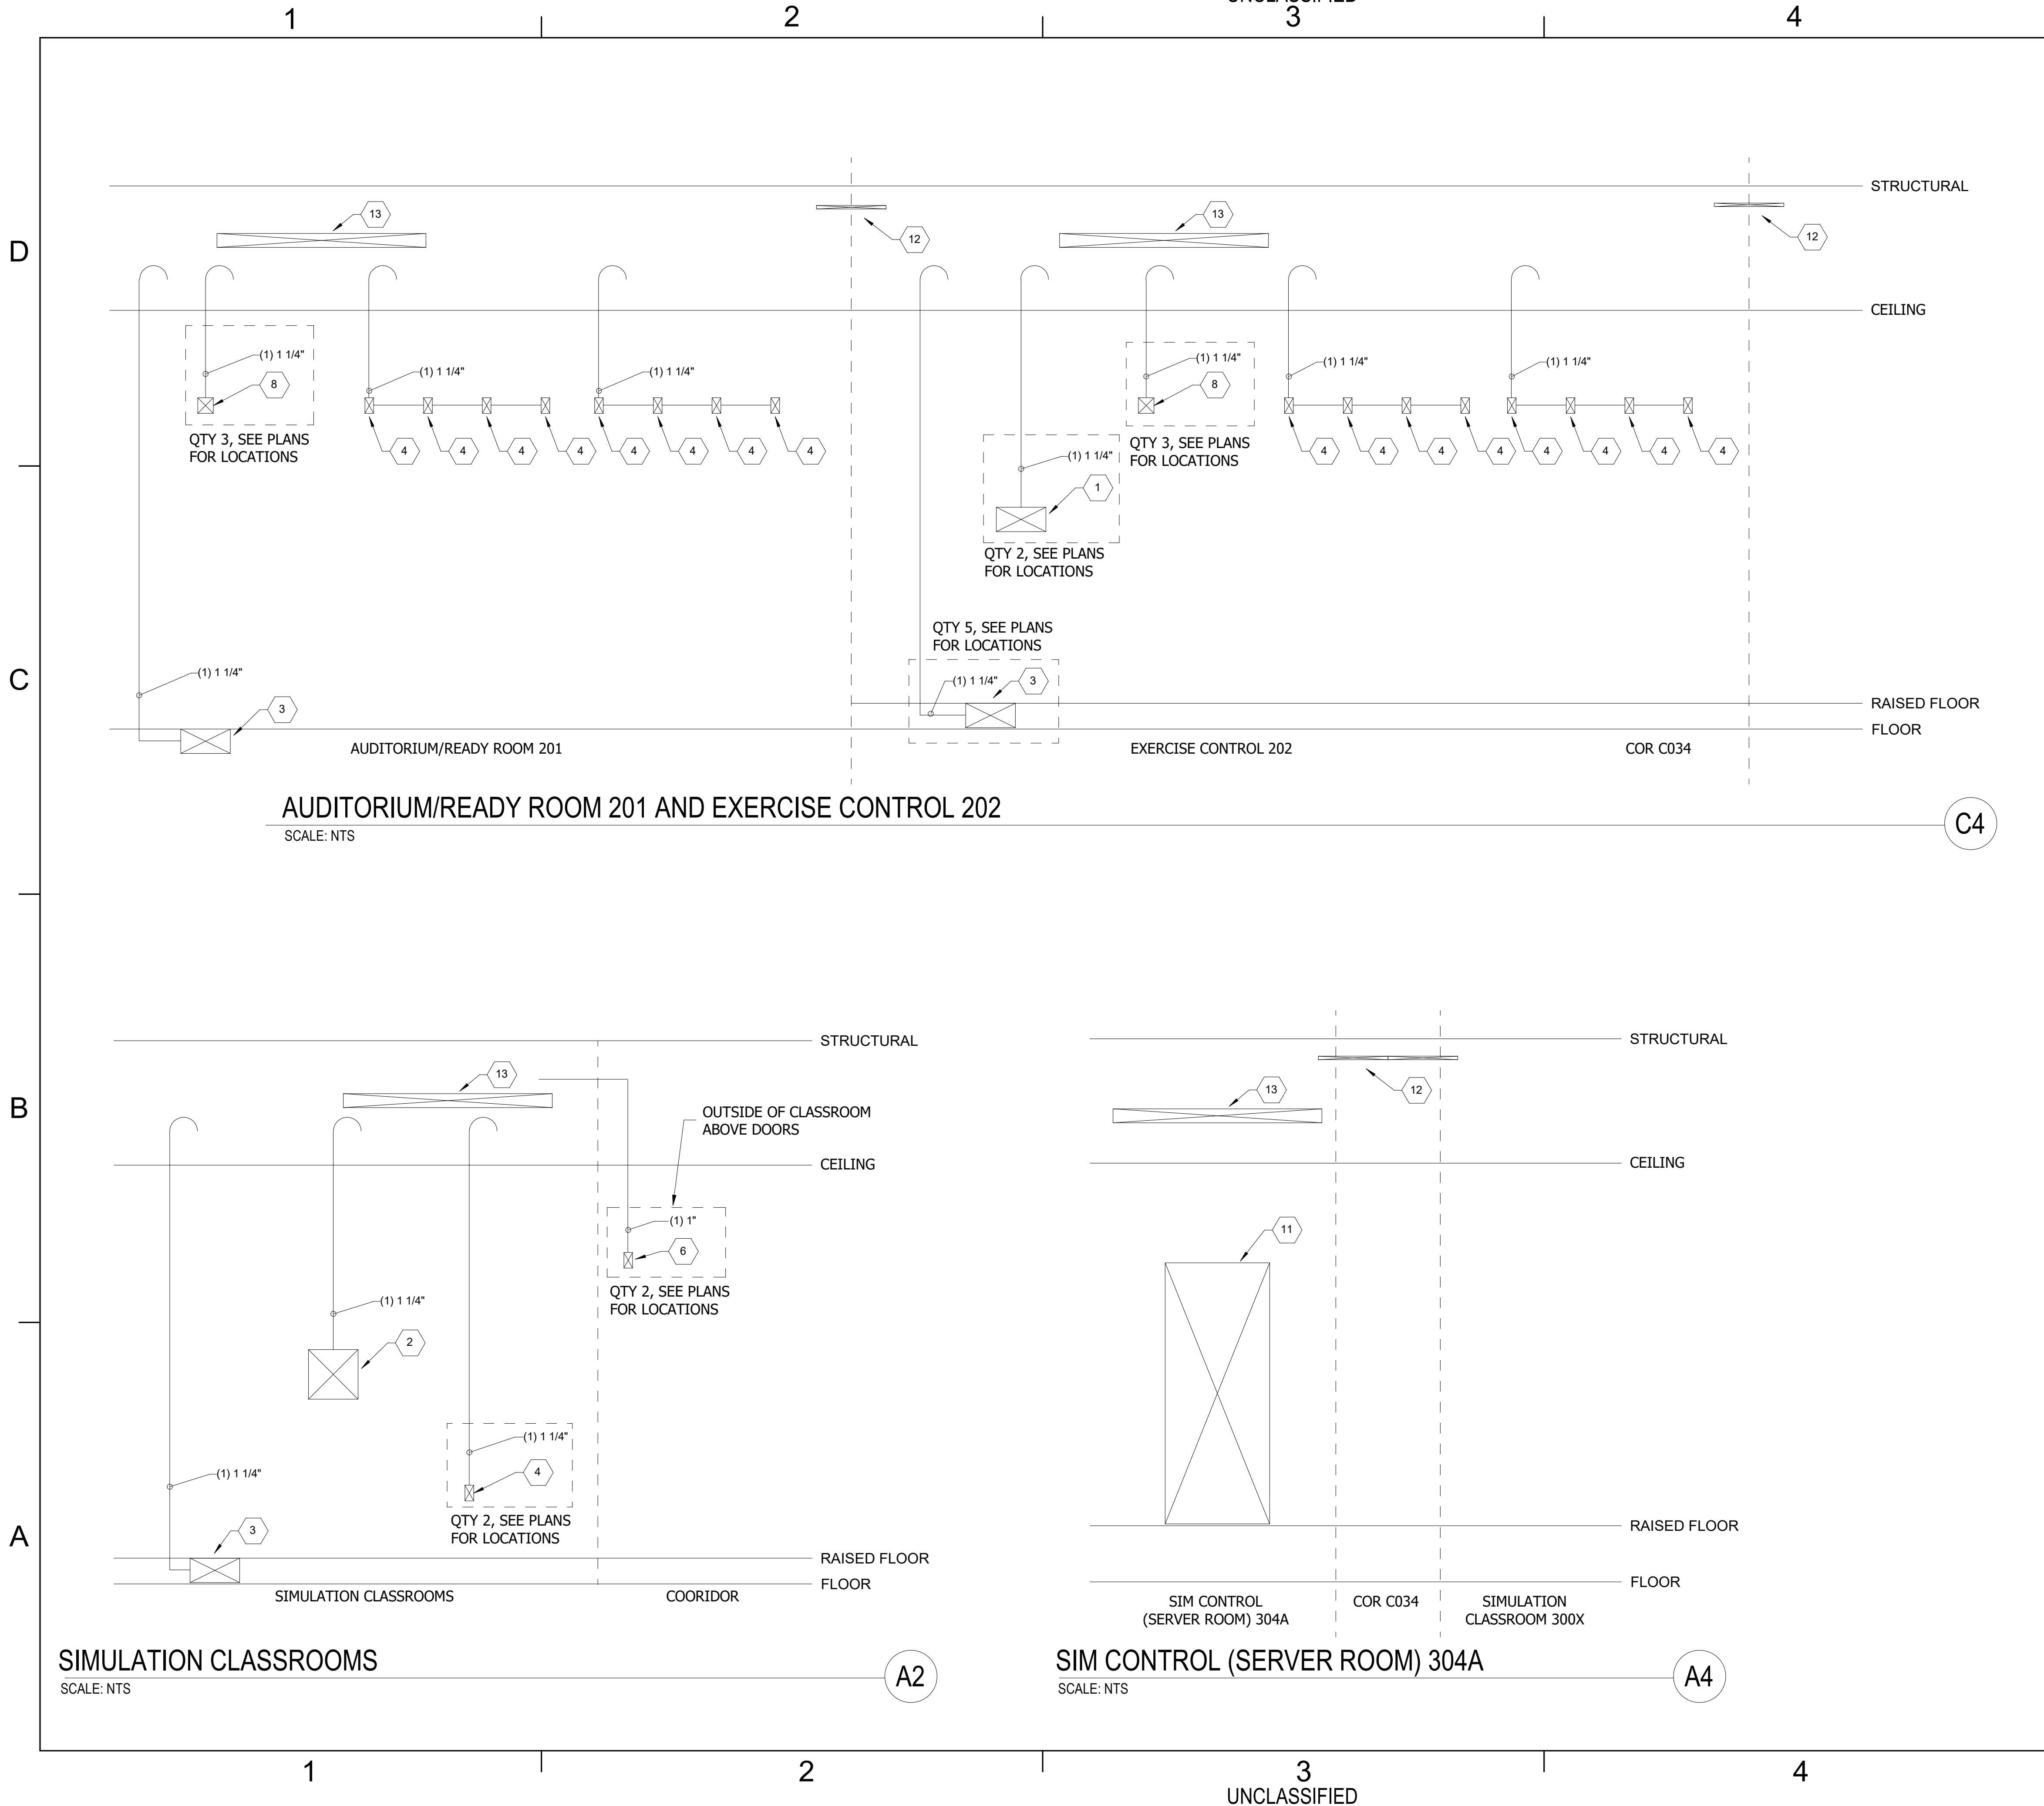

DEVICE SCHEDULE	
TAG	DESCRIPTION
1	FSR PWB-100
2	CHIEF PAC BOX 526
3	FLOOR BOX, REFER TO ELECTRICAL
4	ONE GANG AV BACK BOX
5	ONE GANG AV BACK BOX FOR AV KEYPAD
6	ONE GANG AV BACK BOX FOR ROOM AVAILABILITY SIGN
7	TWO GANG AV BACK BOX
8	TWO GANG AV BACK BOX FOR WALL MOUNTED CAMERA
9	THREE GANG AV BACK BOX
10	FOUR GANG AV BACK BOX
11	AV EQUIPMENT RACK PROVIDED BY AVC
12	CONDUIT, REFER TO EQUIPMENT PLANS FOR SIZE AND LOCATION
13	WIRE-BASKET, REFER TO EQUIPMENT PLANS FOR SIZE AND LOCATION

FOR COMMANDER NAVFAC

ACTIVITY

MARINE CORPS BASE
CAMP LEJEUNE

SATISFACTORY TO DATE

DES AS	DRW AV	CHK BM
--------	--------	--------

PM

BRANCH MANAGER

CHIEF ENGINEER

FIRE PROTECTION

DEPARTMENT OF THE NAVY

NAVAL FACILITIES ENGINEERING COMMAND ~ MID-ATLANTIC

ROICC FLORENCE CAMP LEJEUNE

MOB CAMP LEJEUNE

JACKSONVILLE, NC

P1338F II MEF SIMULATION/TRAINING CENTER REPLACEMENT

AUDIOVISUAL - RISER DIAGRAMS

SCALE: AS NOTED

PROJECT NO.:


CONSTR. CONTR. NO. N40085-20-C-0059

NAVFAC DRAWING NO.

SHEET OF

TA602

DP2 SUBMISSION - P1338 BUILDING PRE-FINAL SUBMISSION

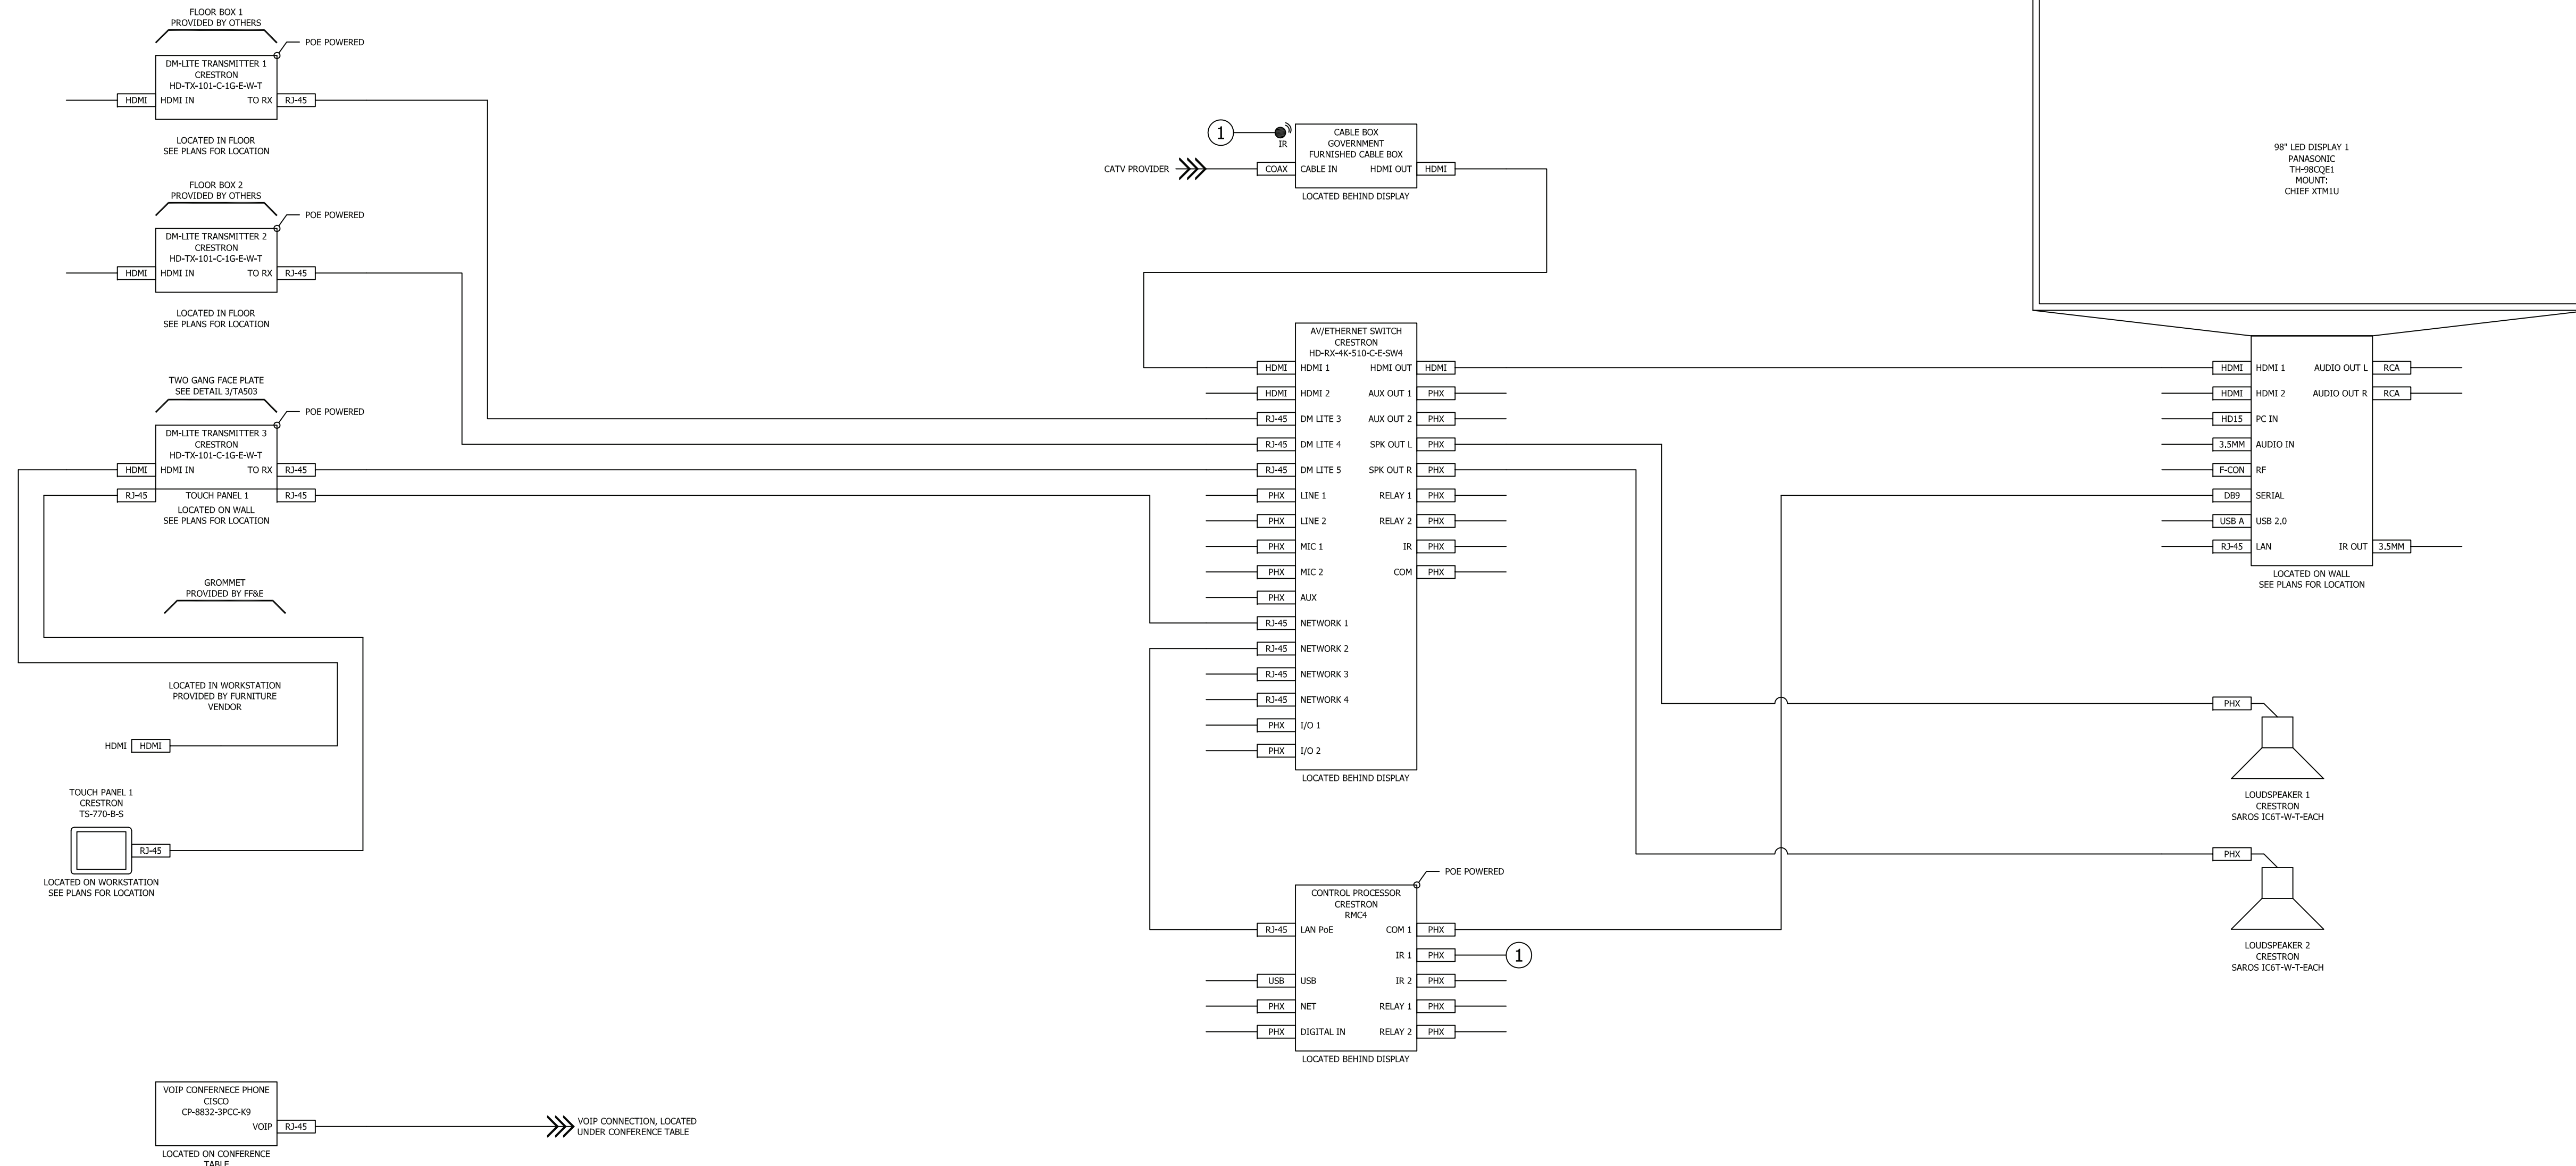[illegible]

PRELIMINARY
NOT FOR CONSTRUCTION





Michael Baker
INTERNATIONAL
100 AIRSIDE DRIVE
MOON TOWNSHIP, PA 15108 A/E INFO
APPROVED


FOR COMMANDER NAVFAC		
ACTIVITY		
MARINE CORPS BASE CAMP LEJEUNE		
SATISFACTORY TO DATE		DD/MM/YY
DES AS	DRW AV	CHK BM
PM		XXX
BRANCH MANAGER		XXX
CHIEF ENG/ARCH		XXX
FIRE PROTECTION		XXX

DEPARTMENT OF THE NAVY
NAVAL FACILITIES ENGINEERING COMMAND ~ MID-ATLANTIC
RDTCC FLORENCE CAMP LEJEUNE JACKSONVILLE, NC
MCB CAMP LEJEUNE JACKSONVILLE, NC
P1338F II MEF SIMULATION/TRAINING CENTER
REPLACEMENT
BRIEF/DEBRIEF 101 SYSTEM DRAWING



SCALE:	NTS
EPROJECT NO.:	
CONSTR. CONTR. NO.	N40085-20-C-0059
NAVFAC DRAWING NO.	
SHEET	OF
TA801	

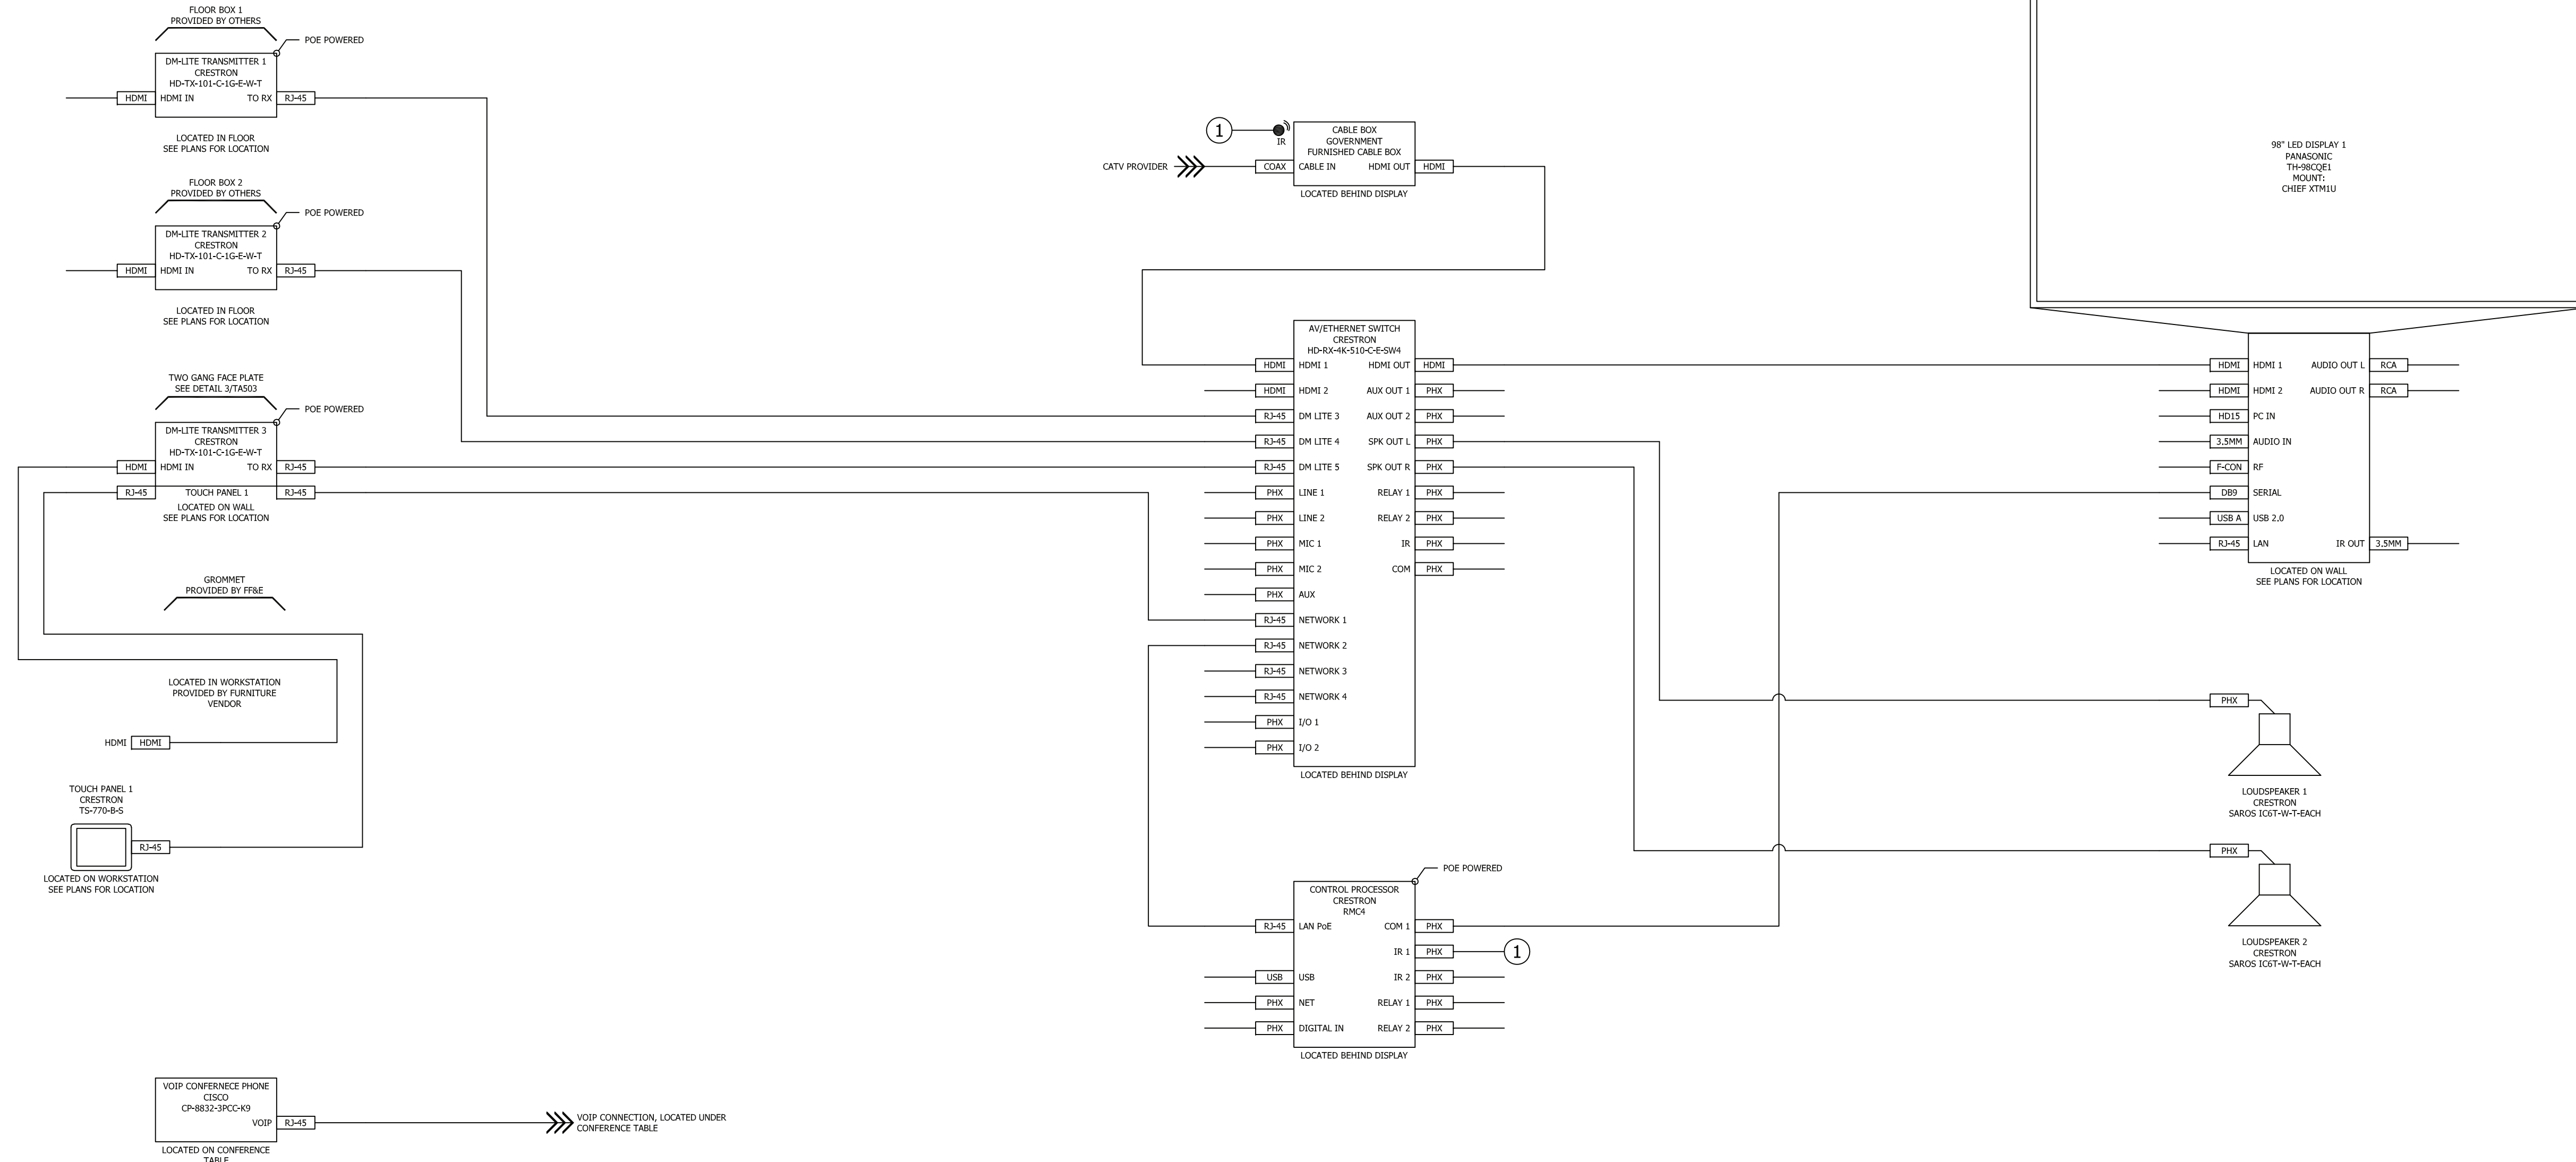

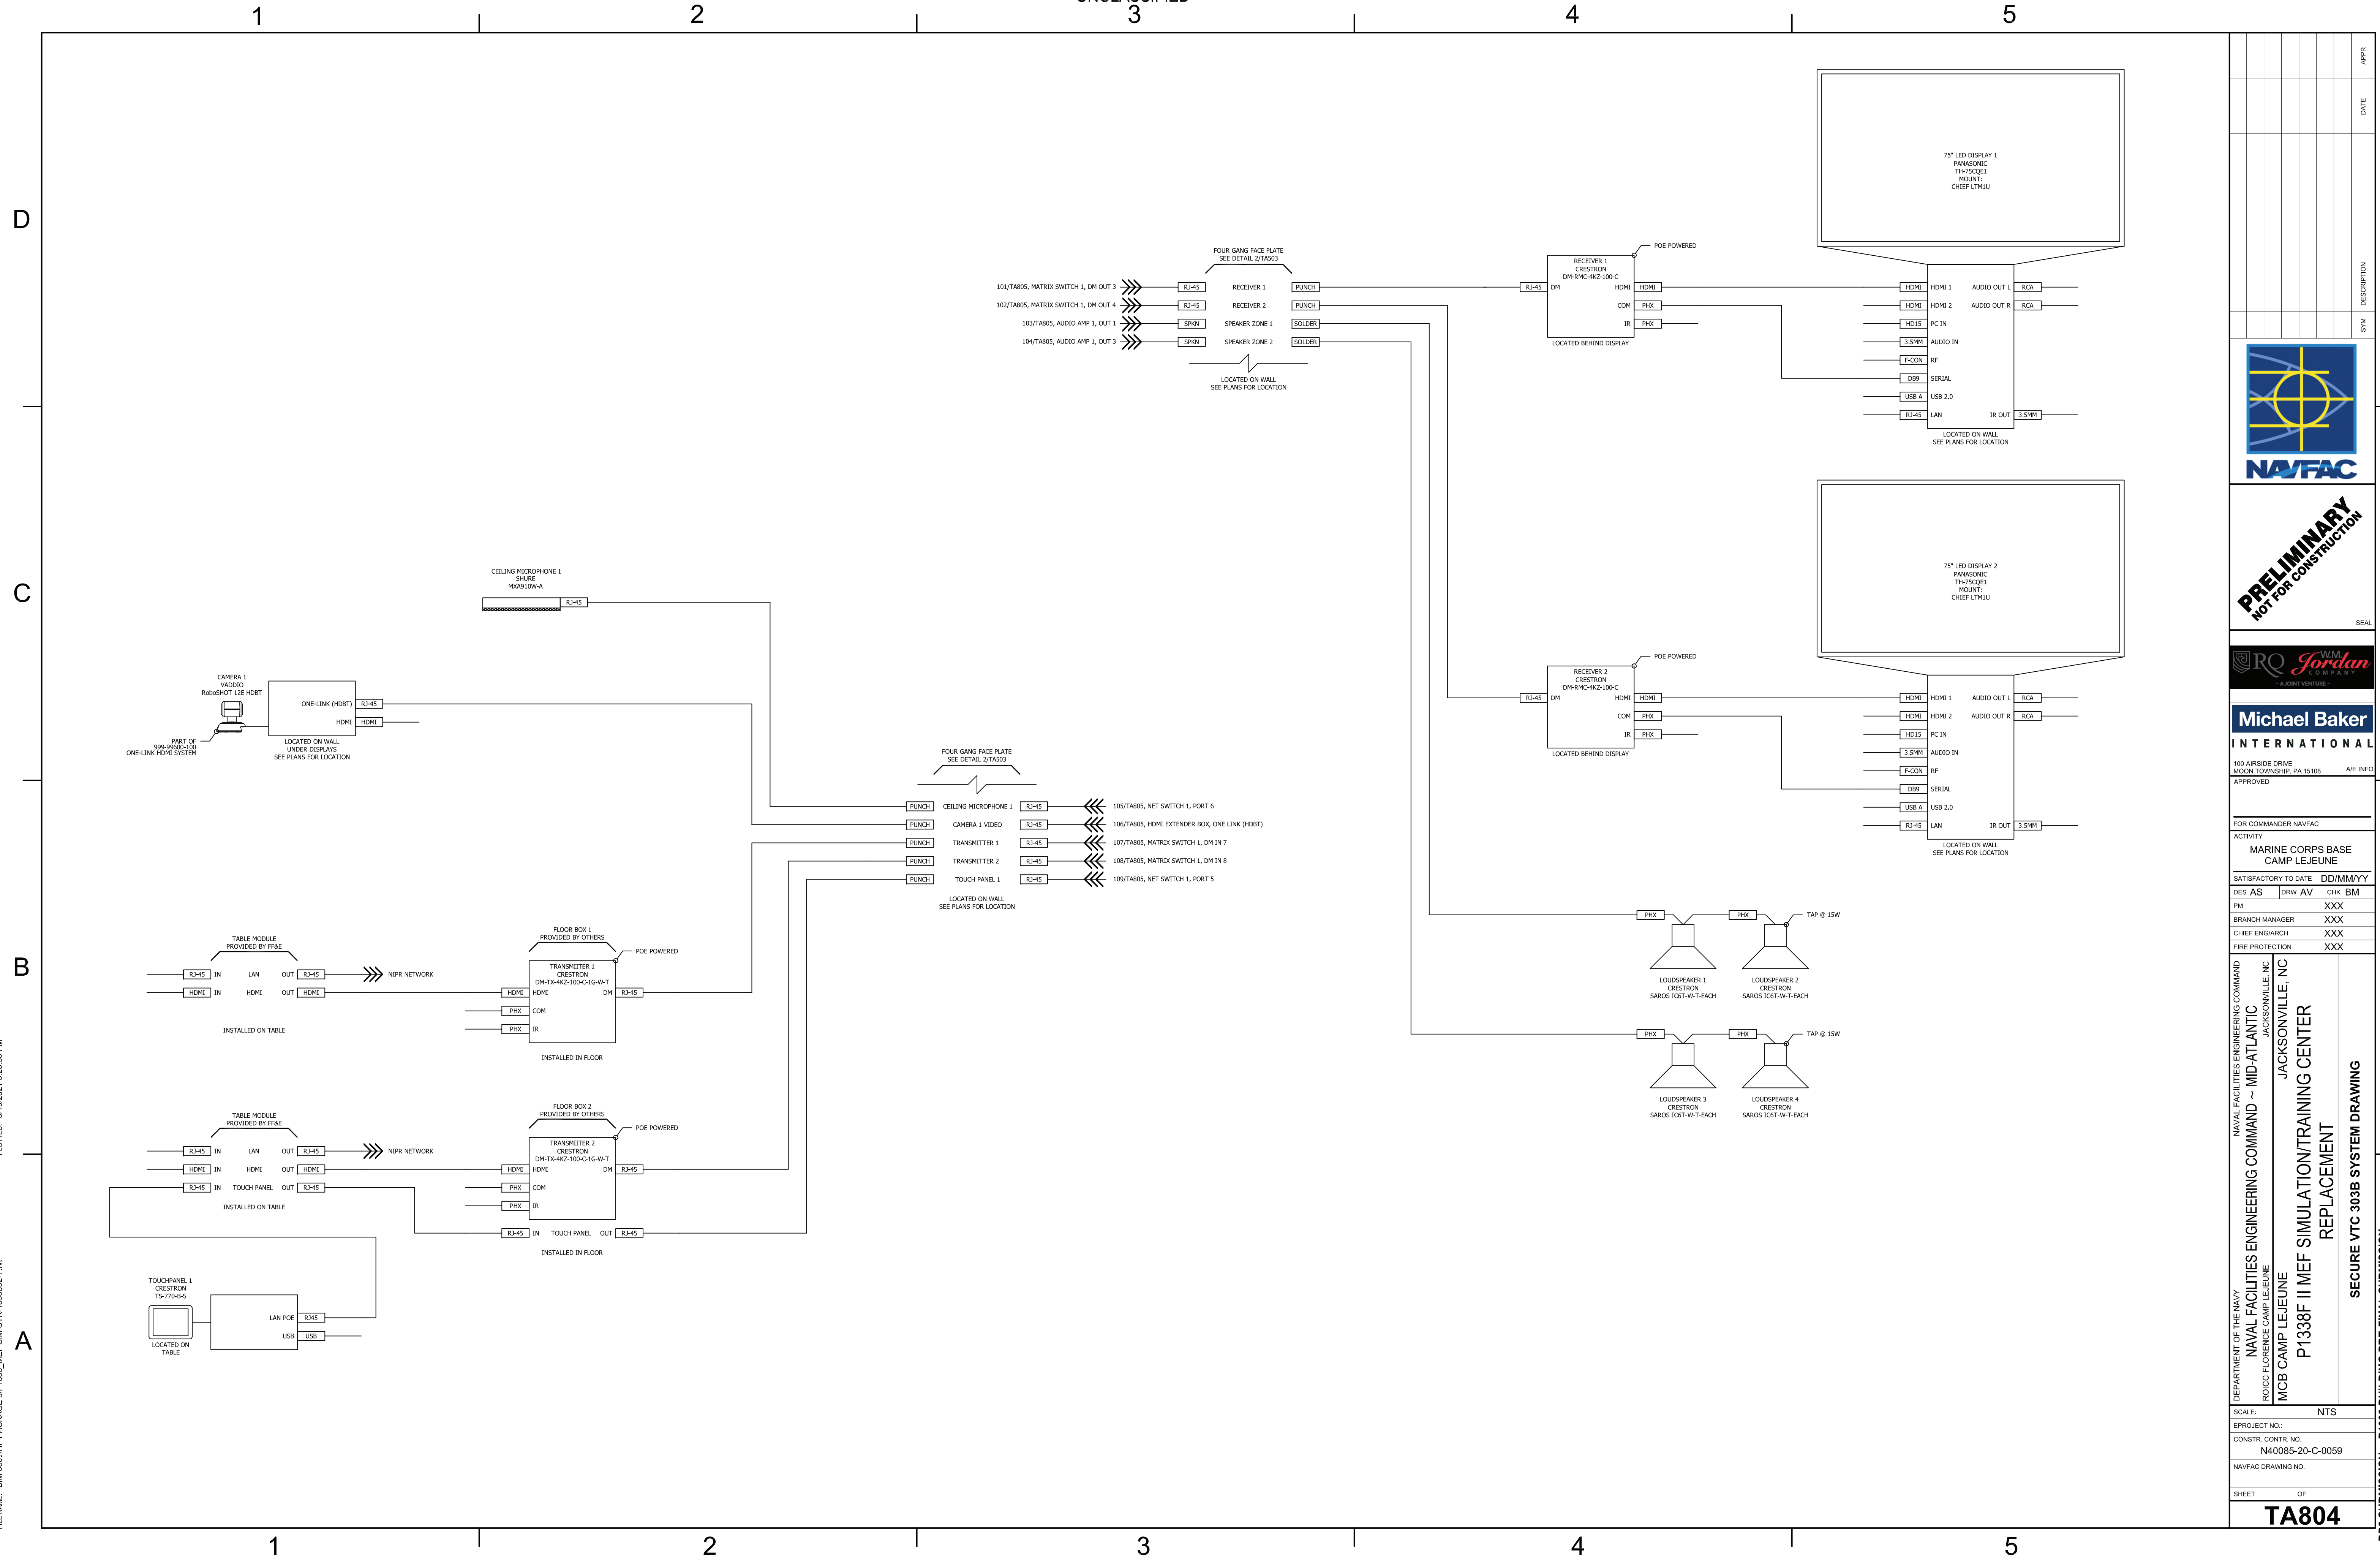


 

A

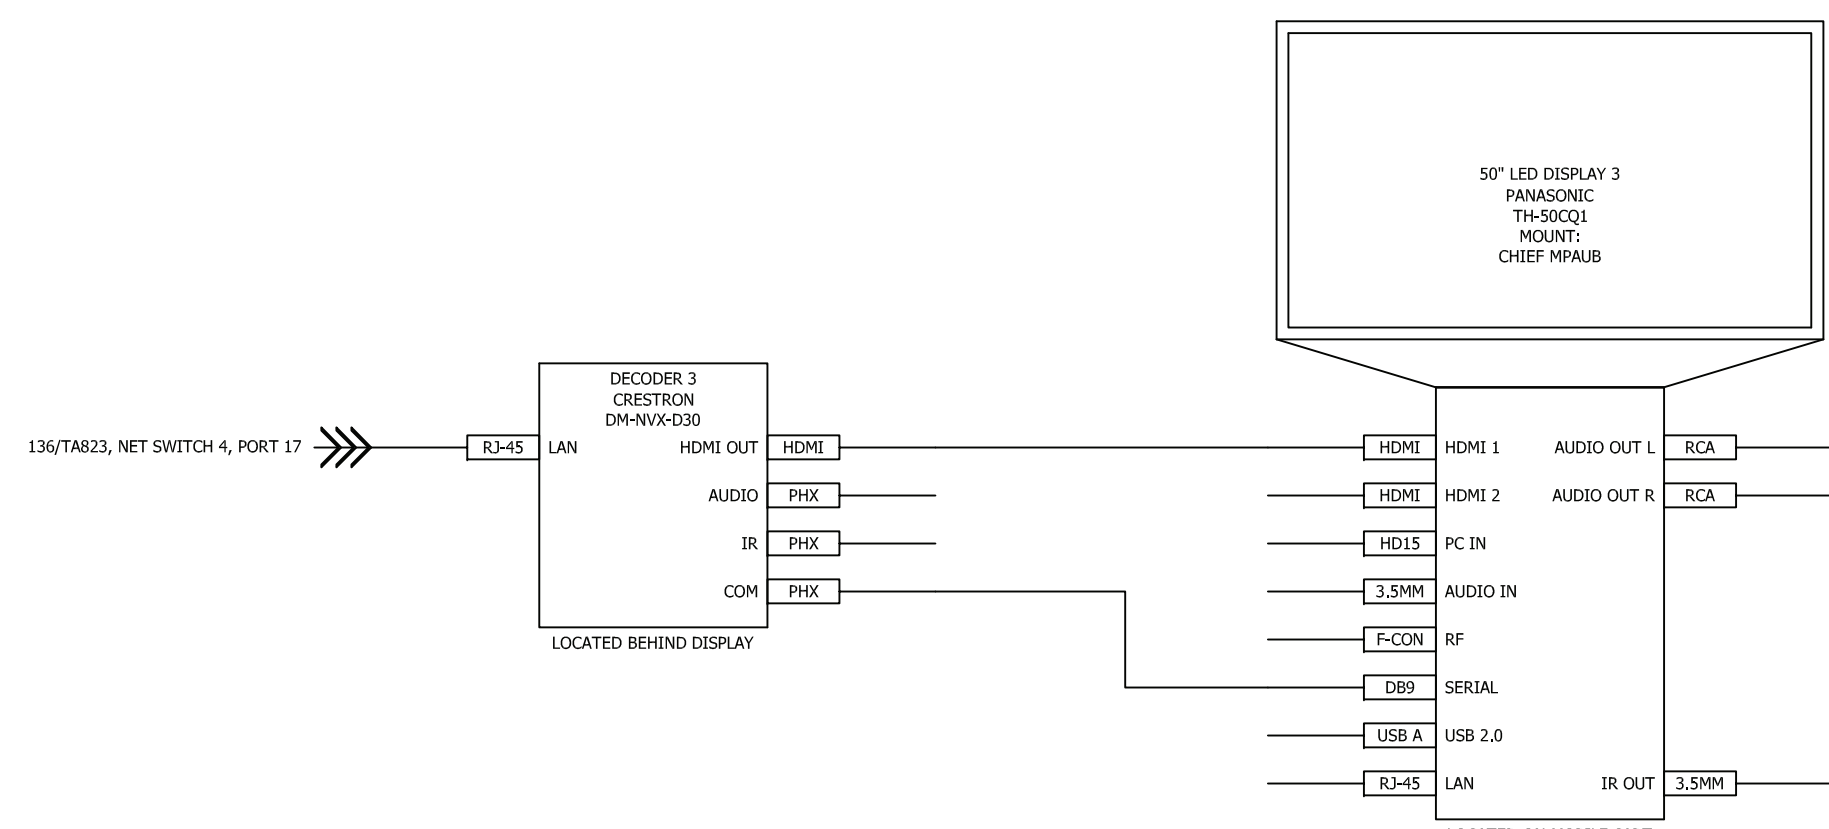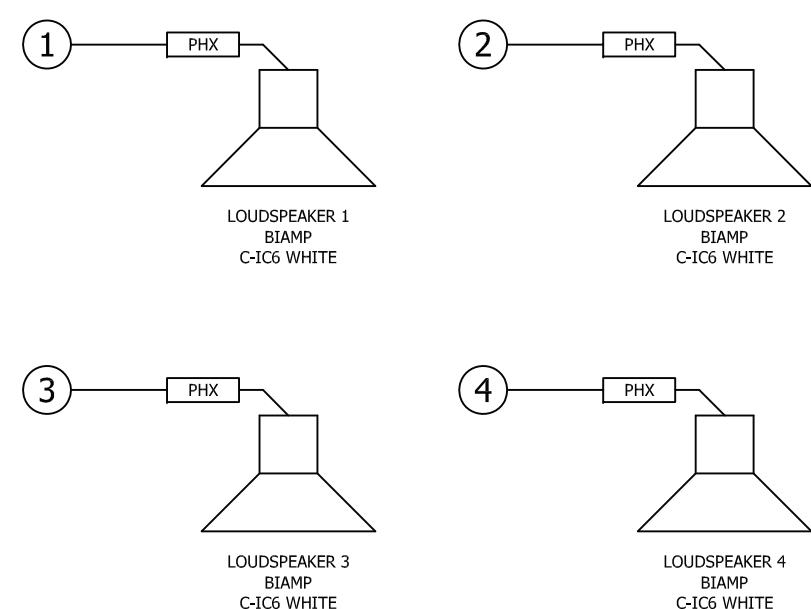


FILE NAME: BIM 360://HF PACKAGE 3/P1338_MEF SIM CTR-1590892-T.rvt

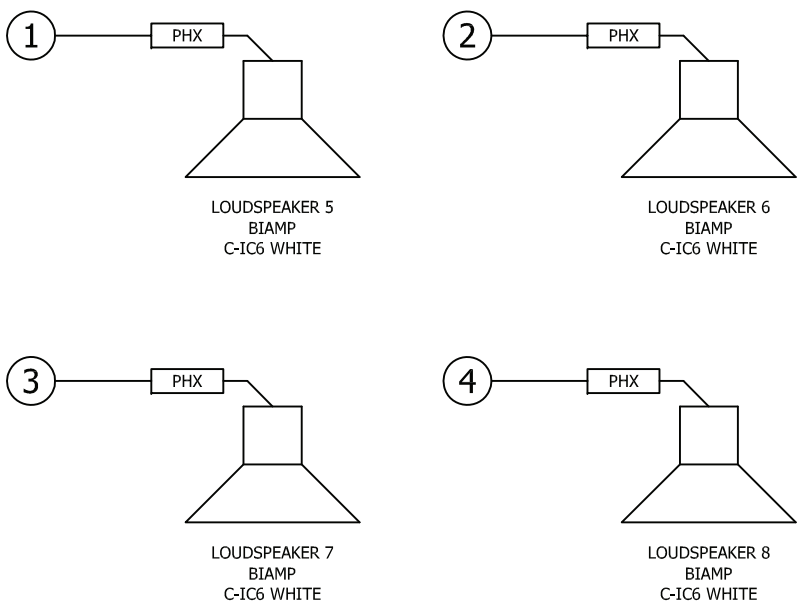


SCALE:	NTS
EPROJECT NO.:	
CONSTR. CONTR. NO.	N40085-20-C-0059
NAVFAC DRAWING NO.	
SHEET	OF
TA808	

DP2 SUBMISSION – P1338 BUILDING PRE-FINAL SUBMISSION


D

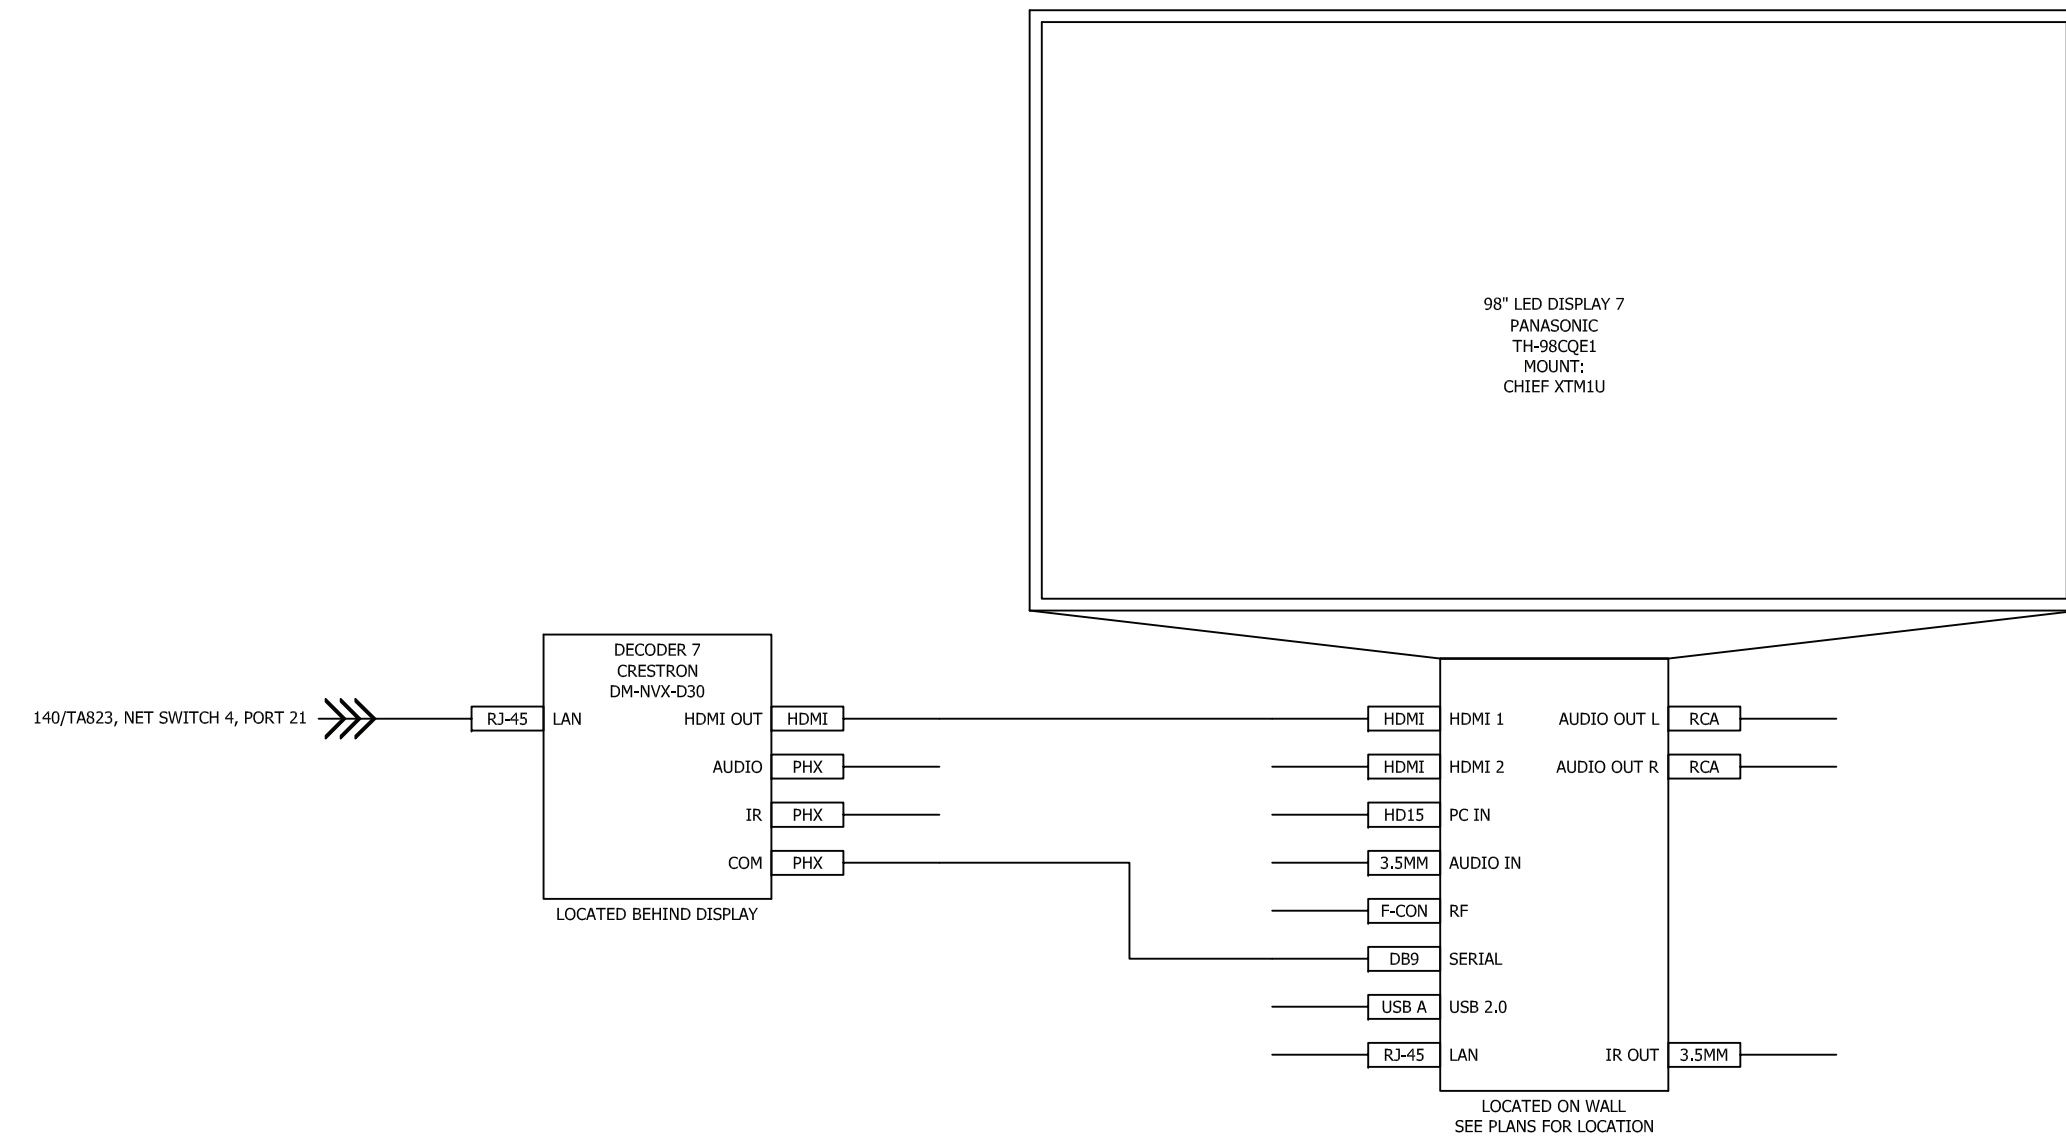


C

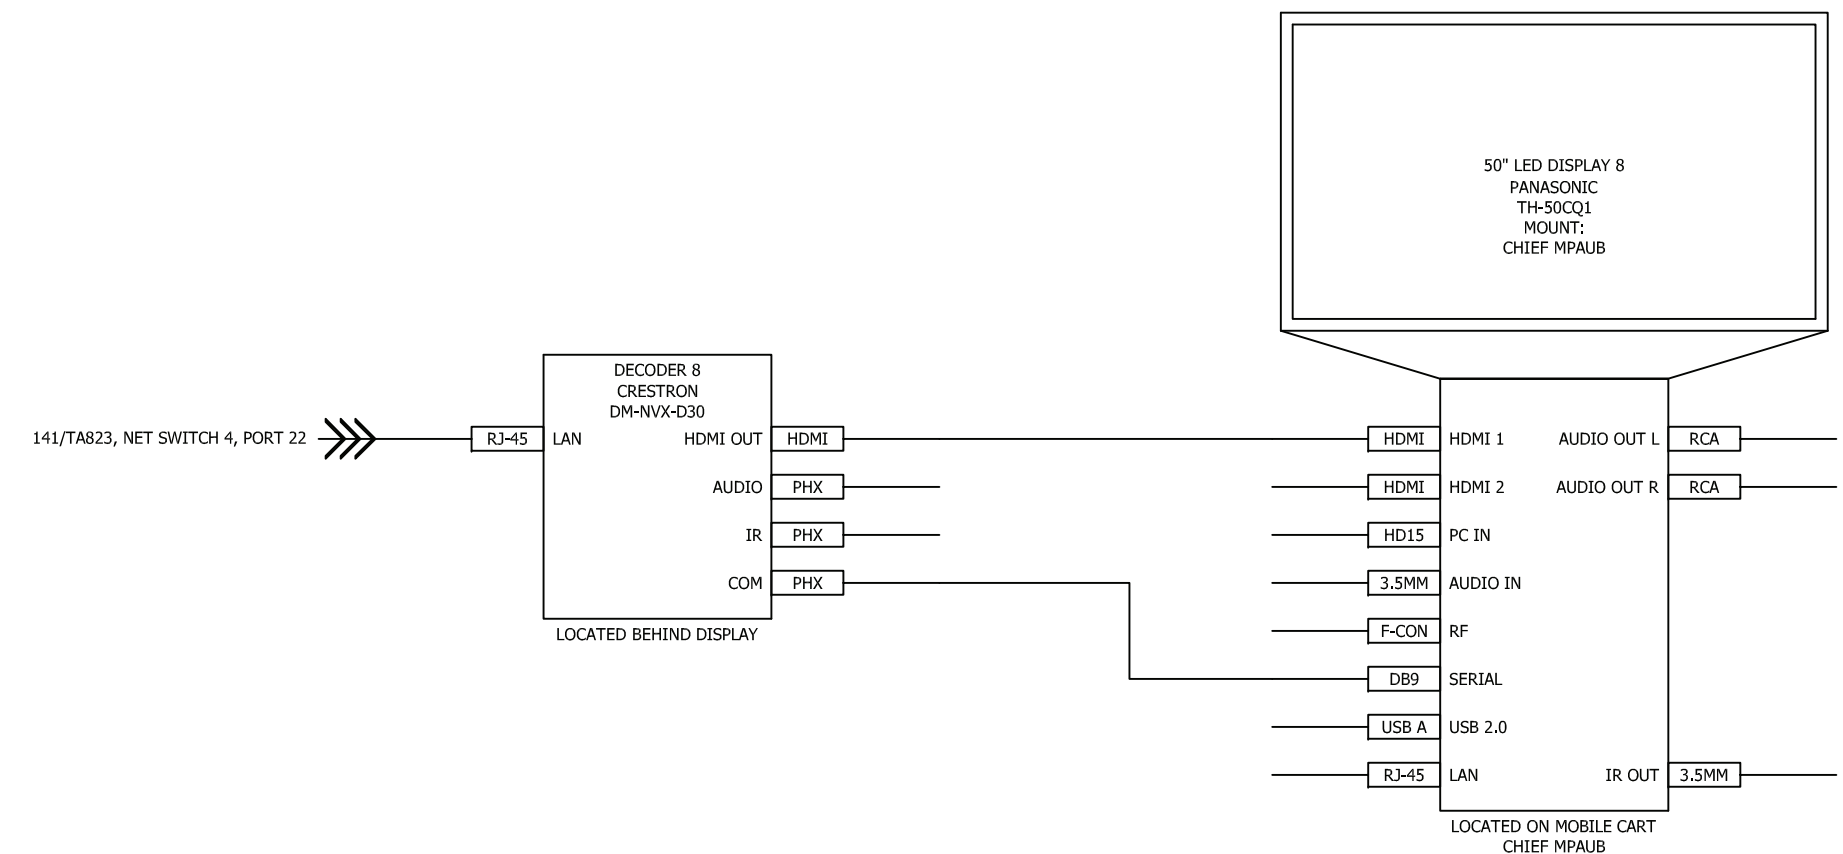


B

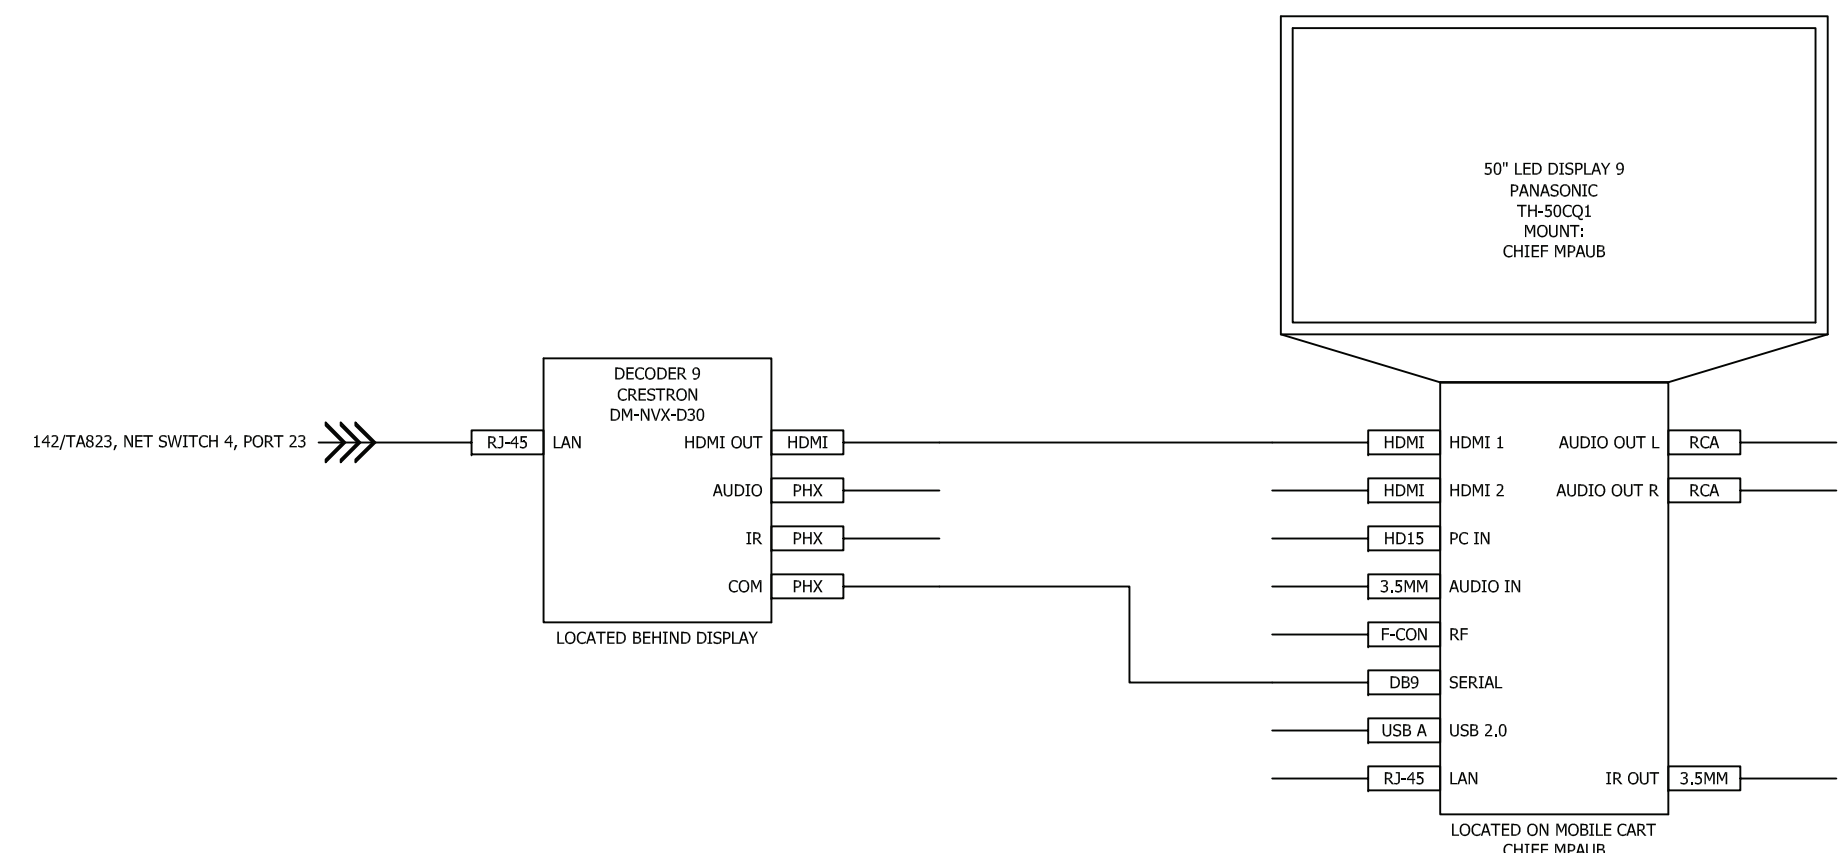


PRE-1A

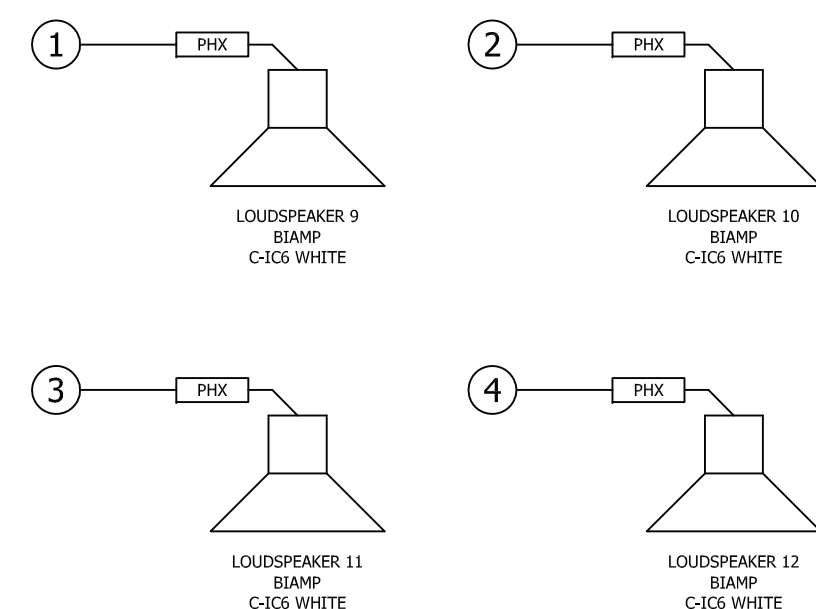


5

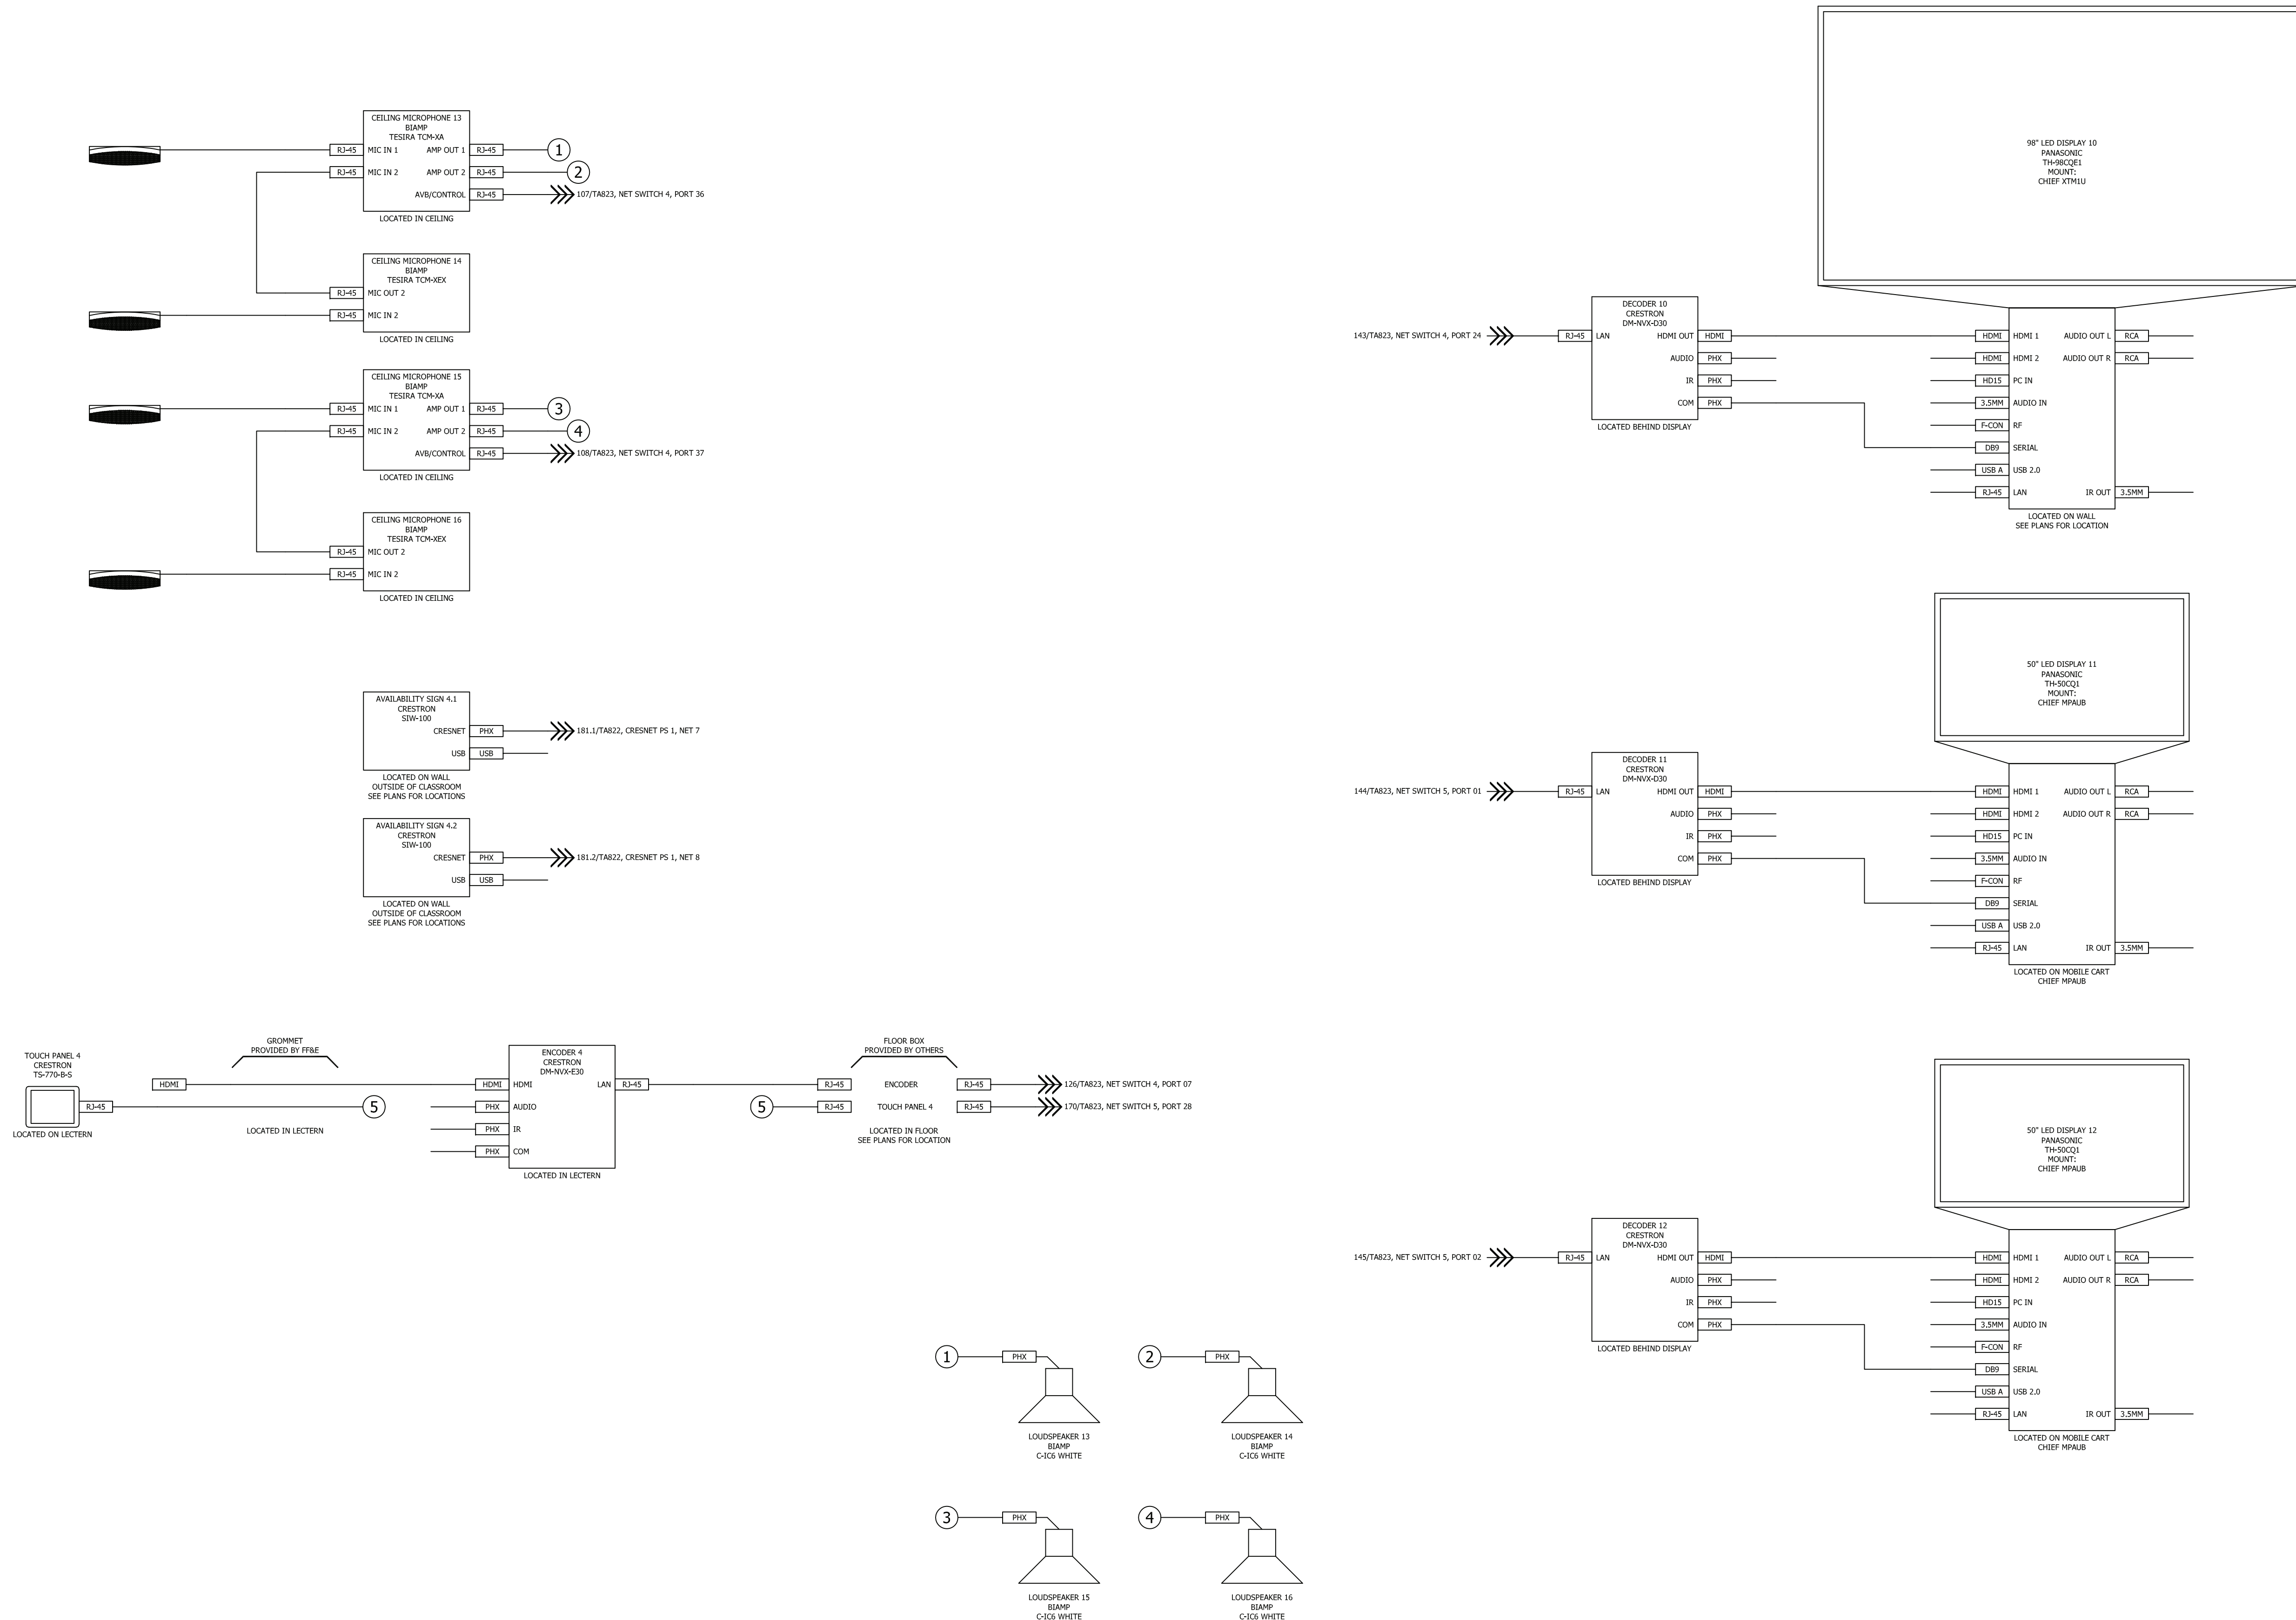[illegible]


FILE NAME: BIM 360://HF PACKAGE 3/P1338_MEF SIM CTR-1590892-T.rvt

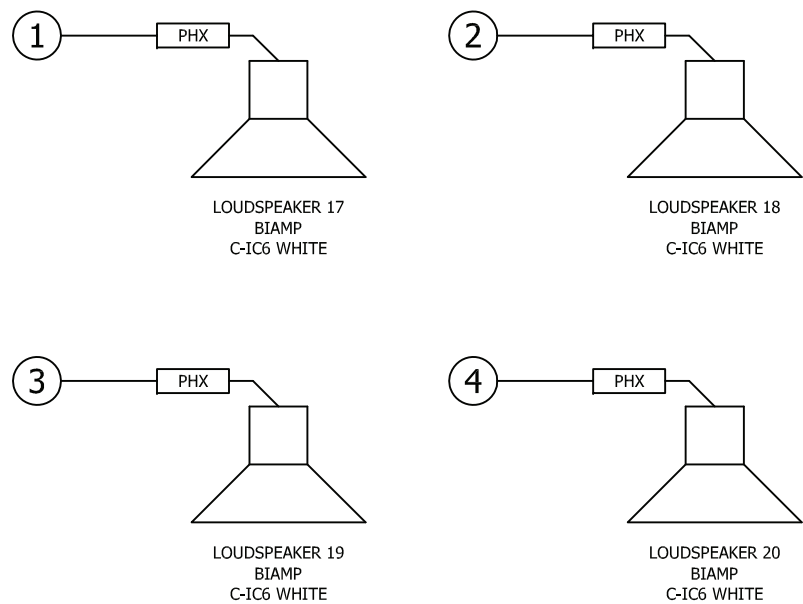


D

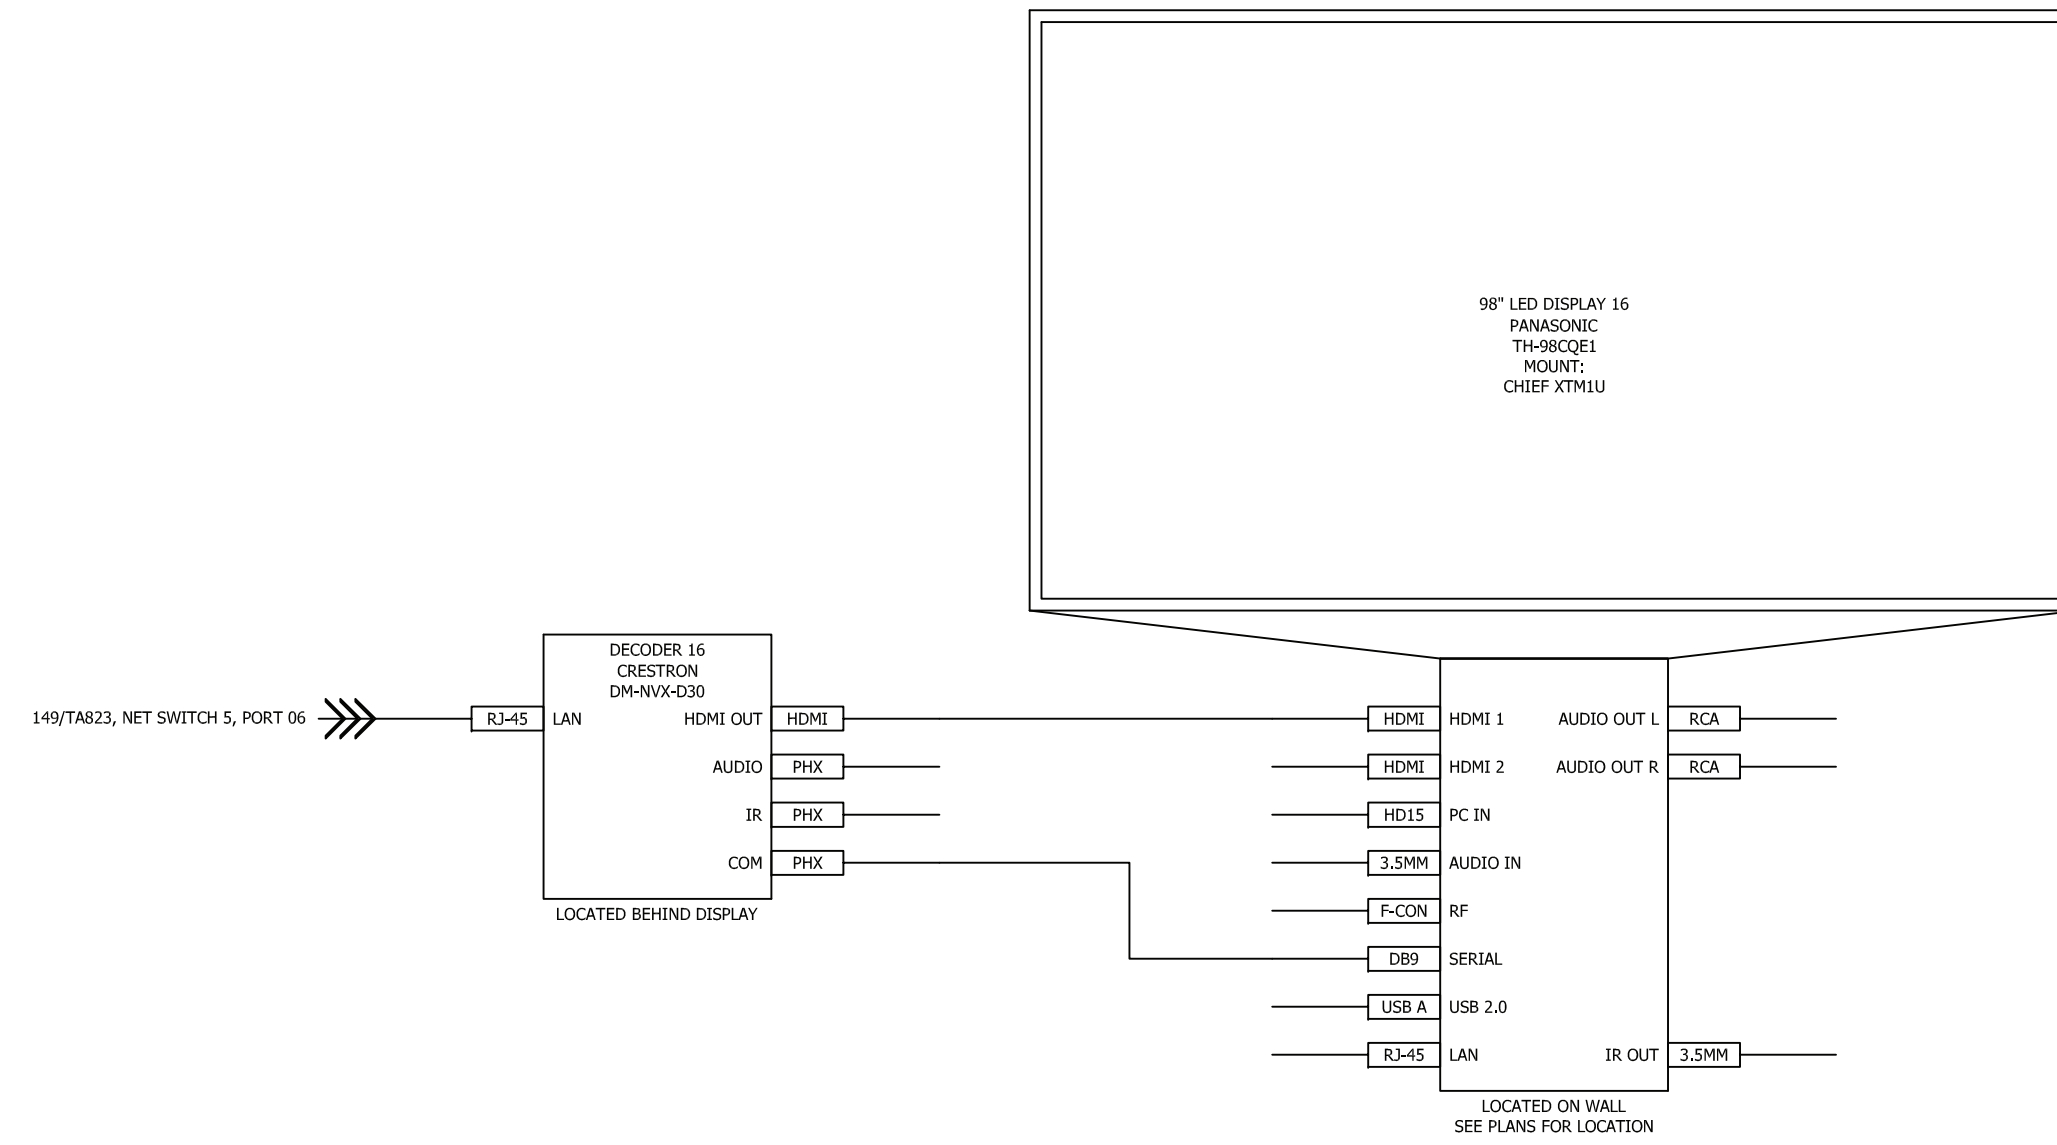


C

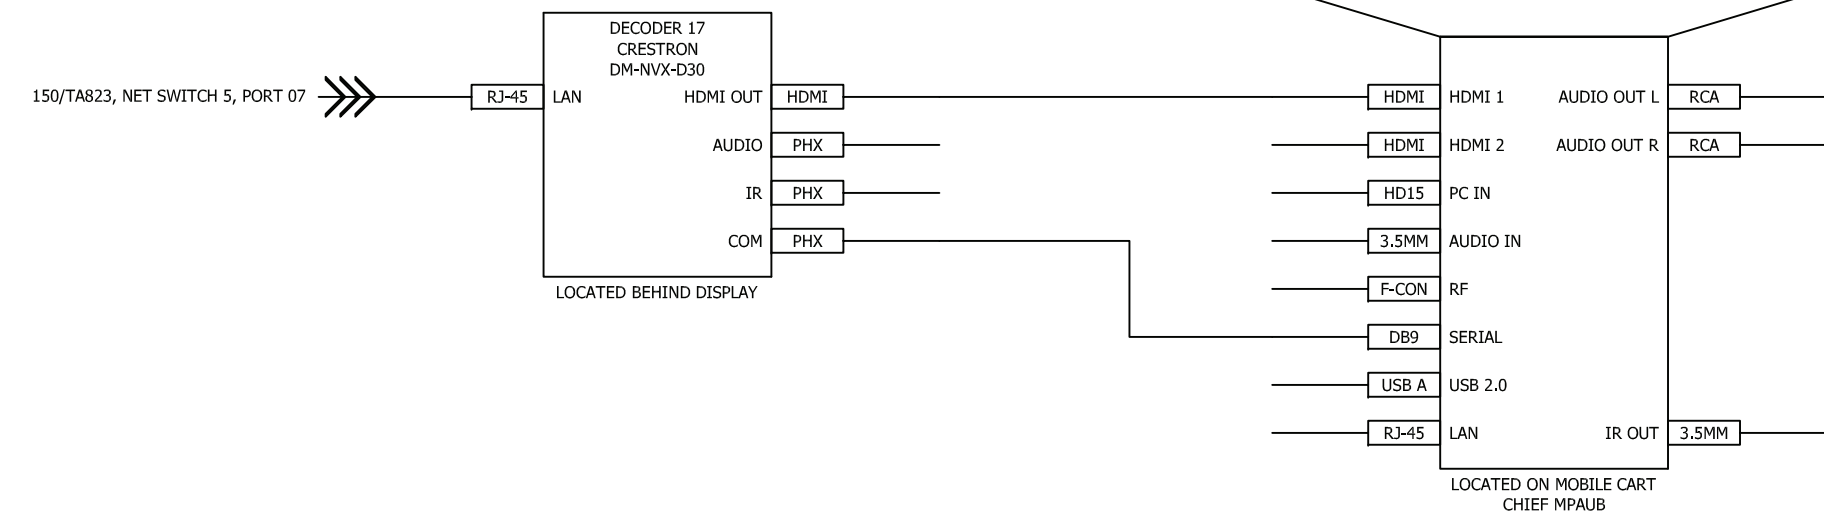

B

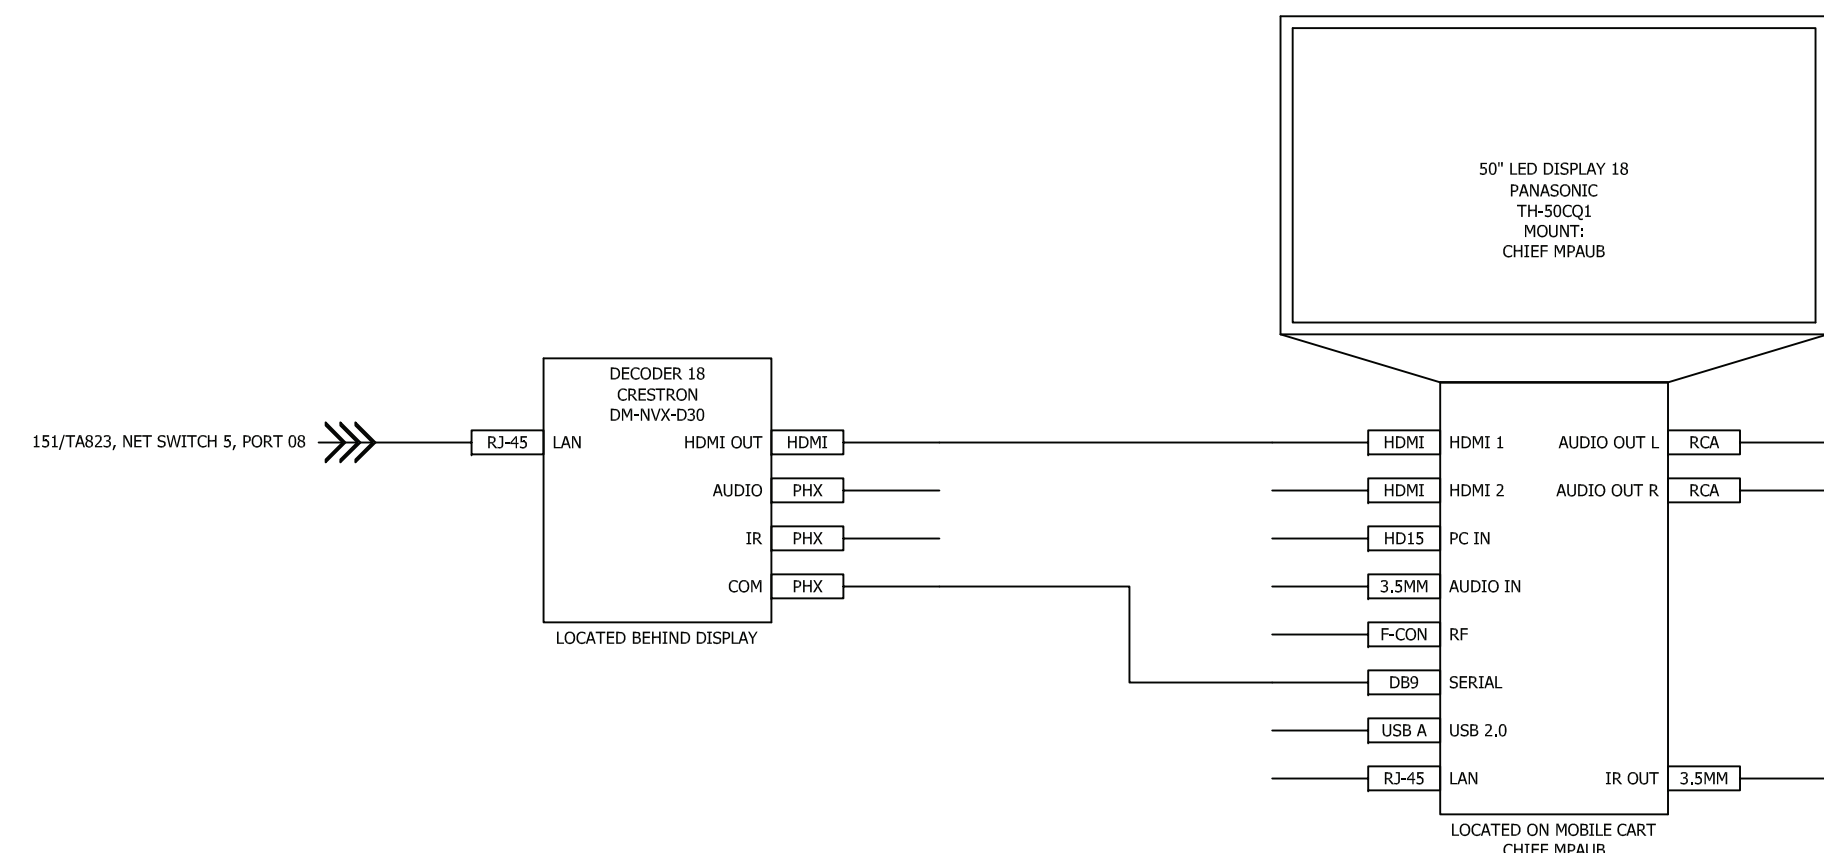


PRE-1A

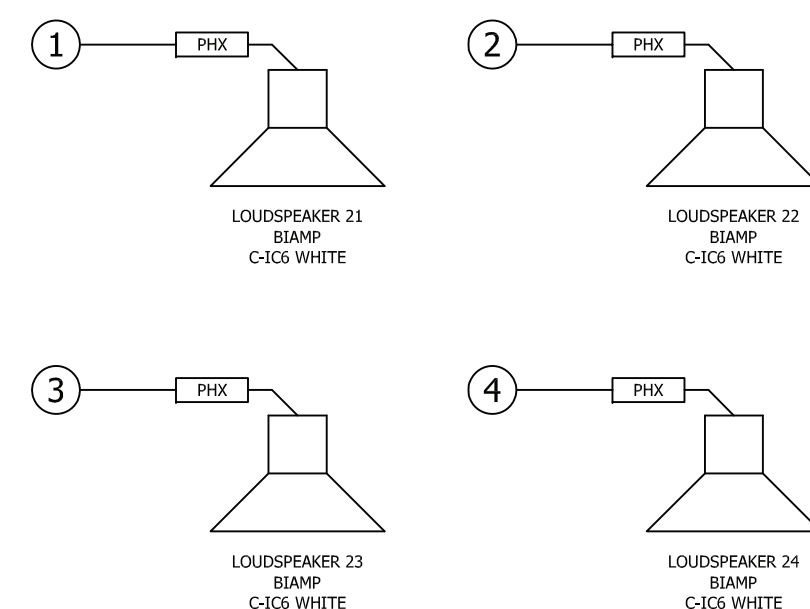


5


D

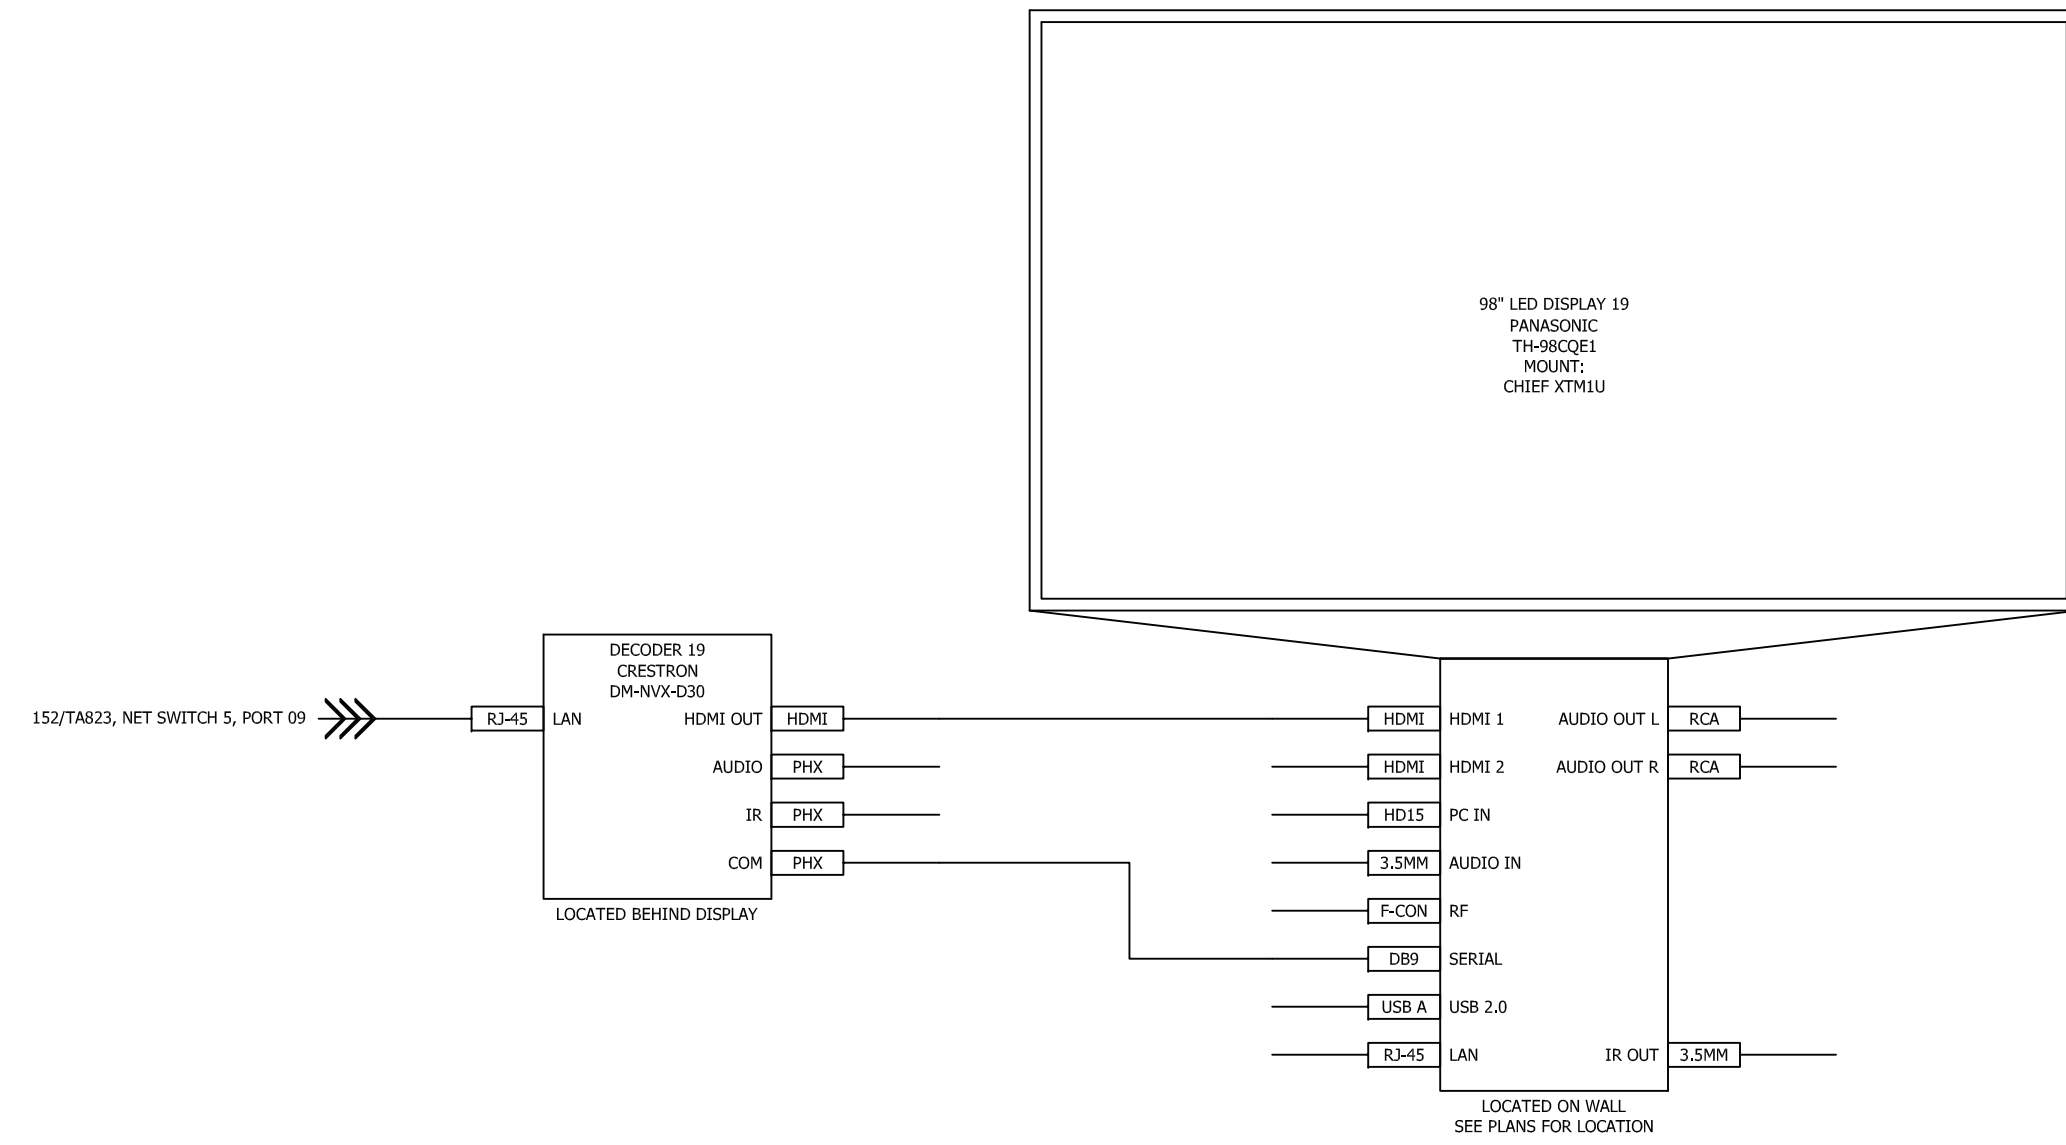

C

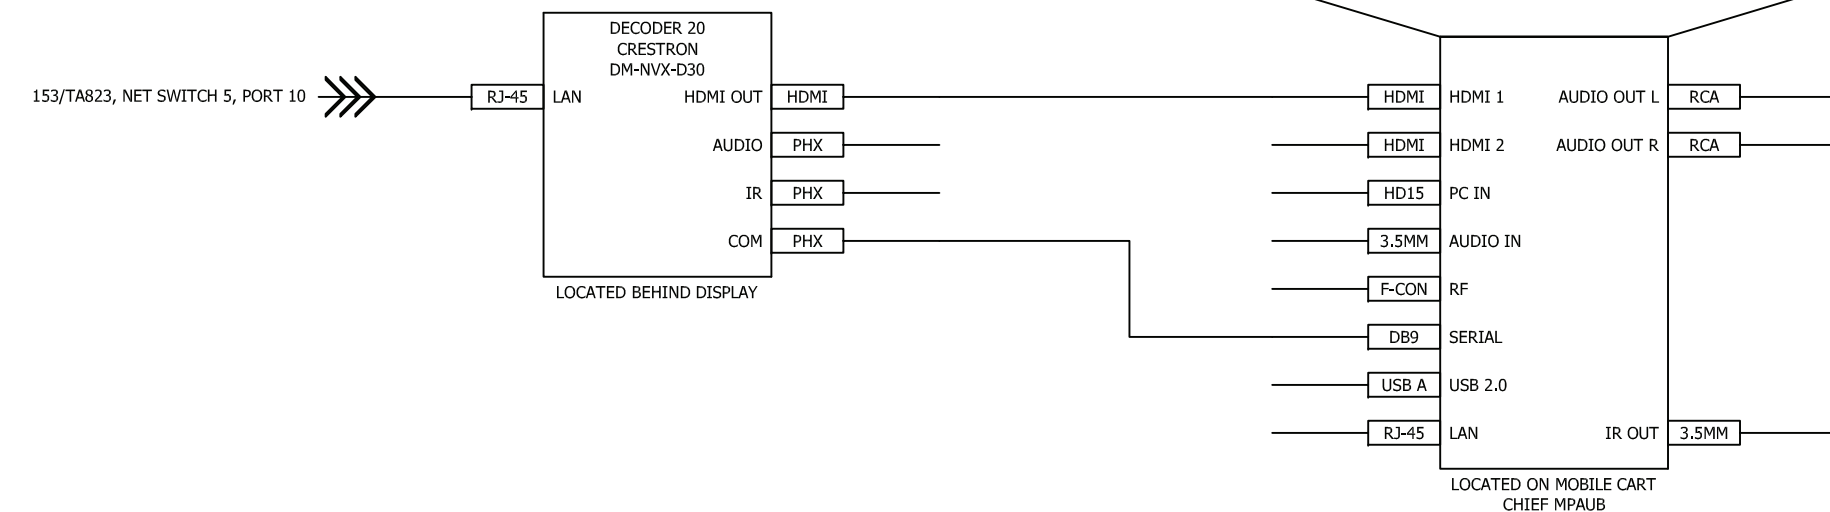


B

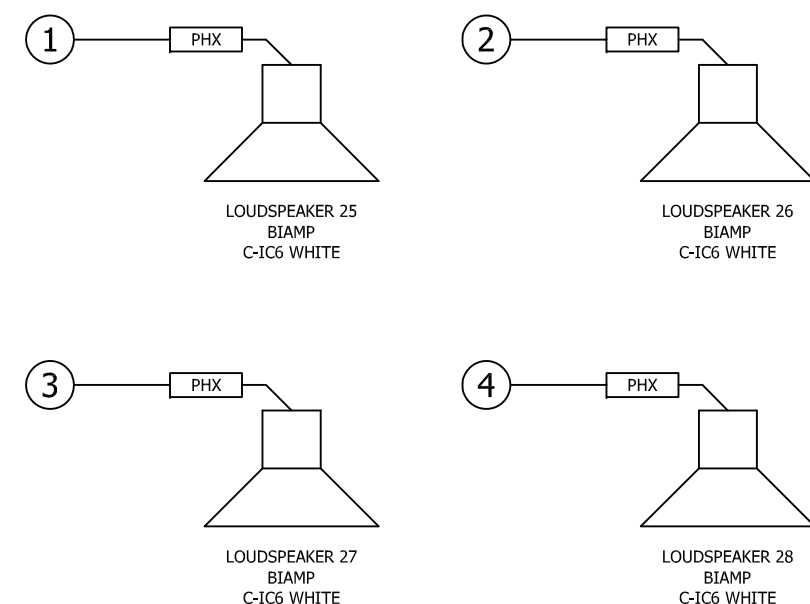


PRE-1A


D

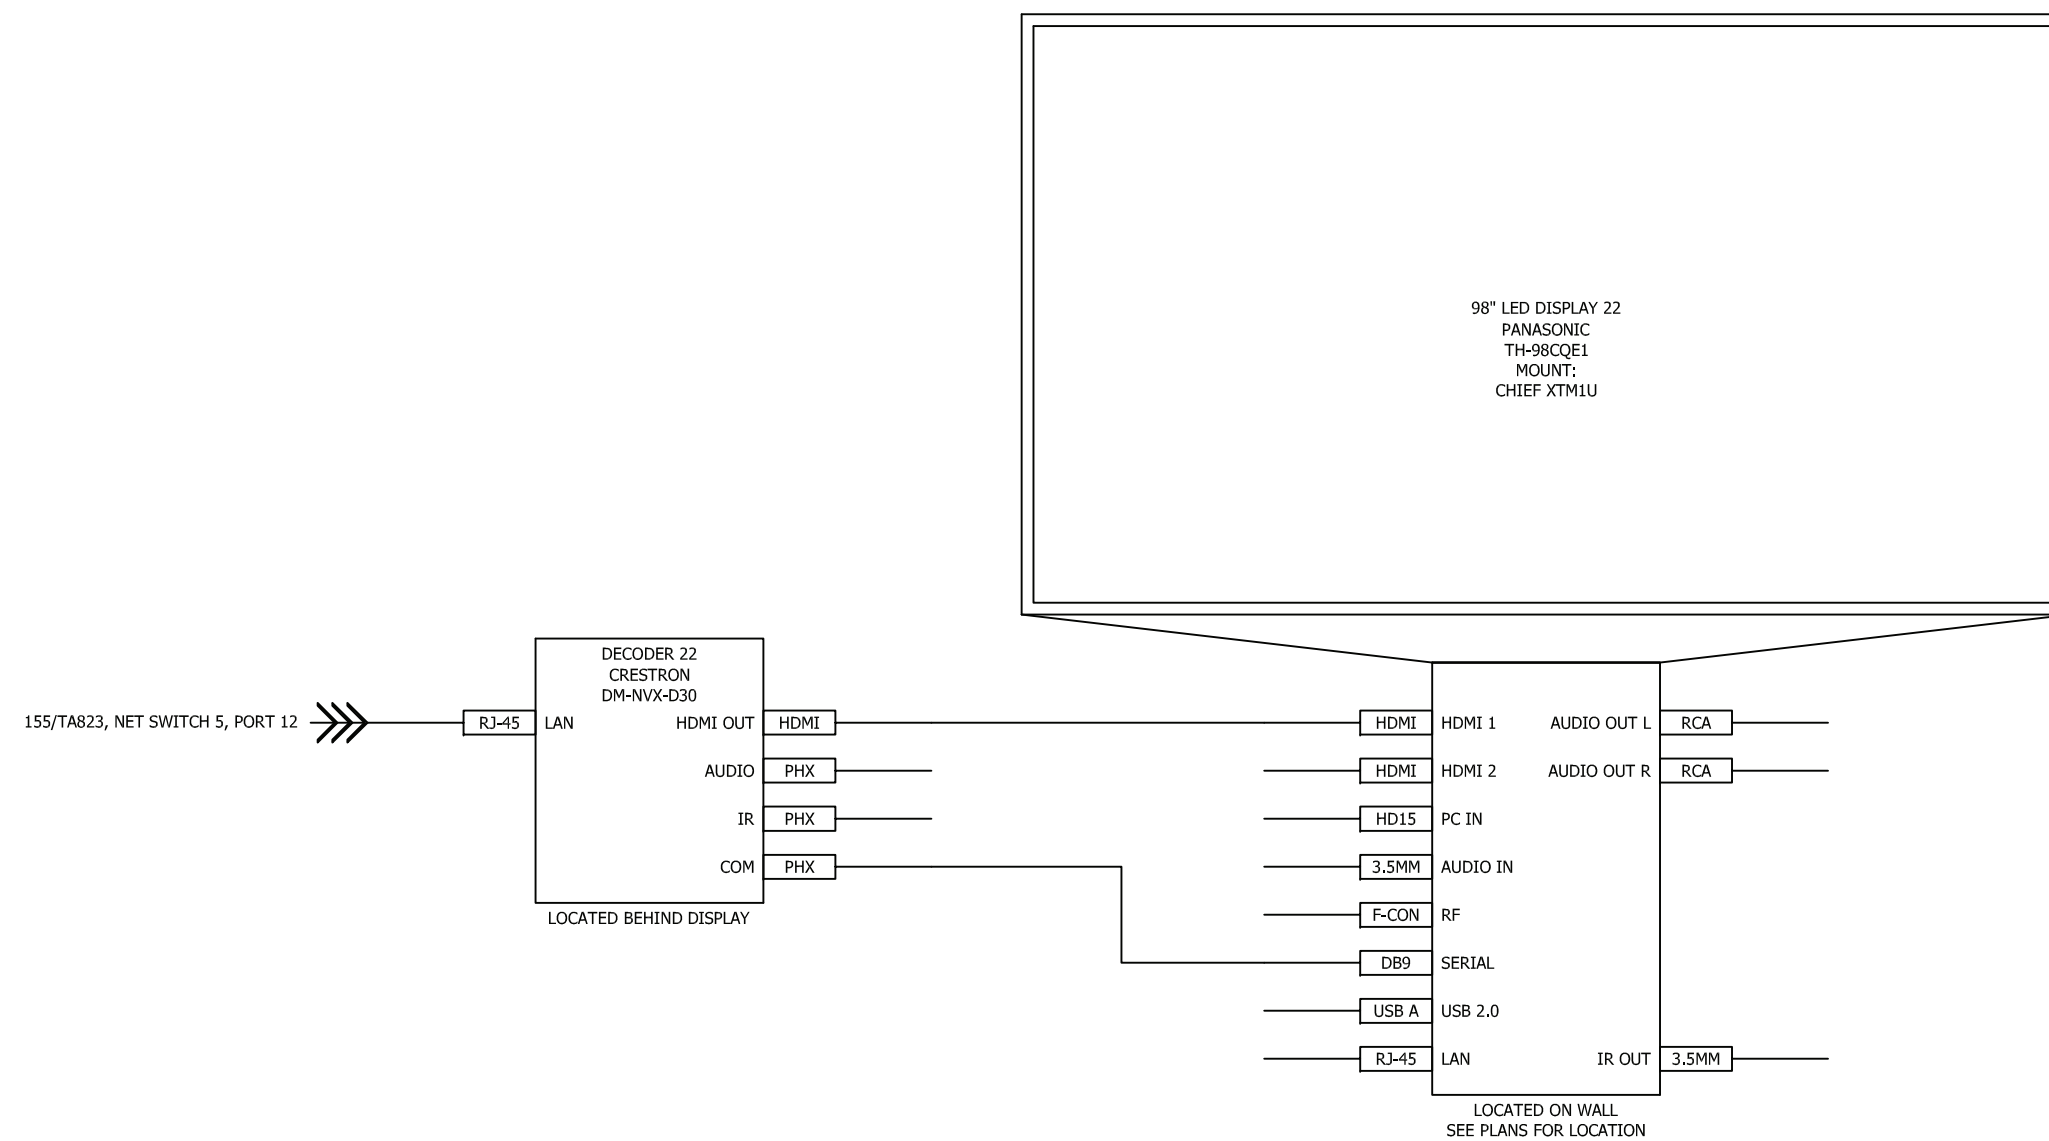

C


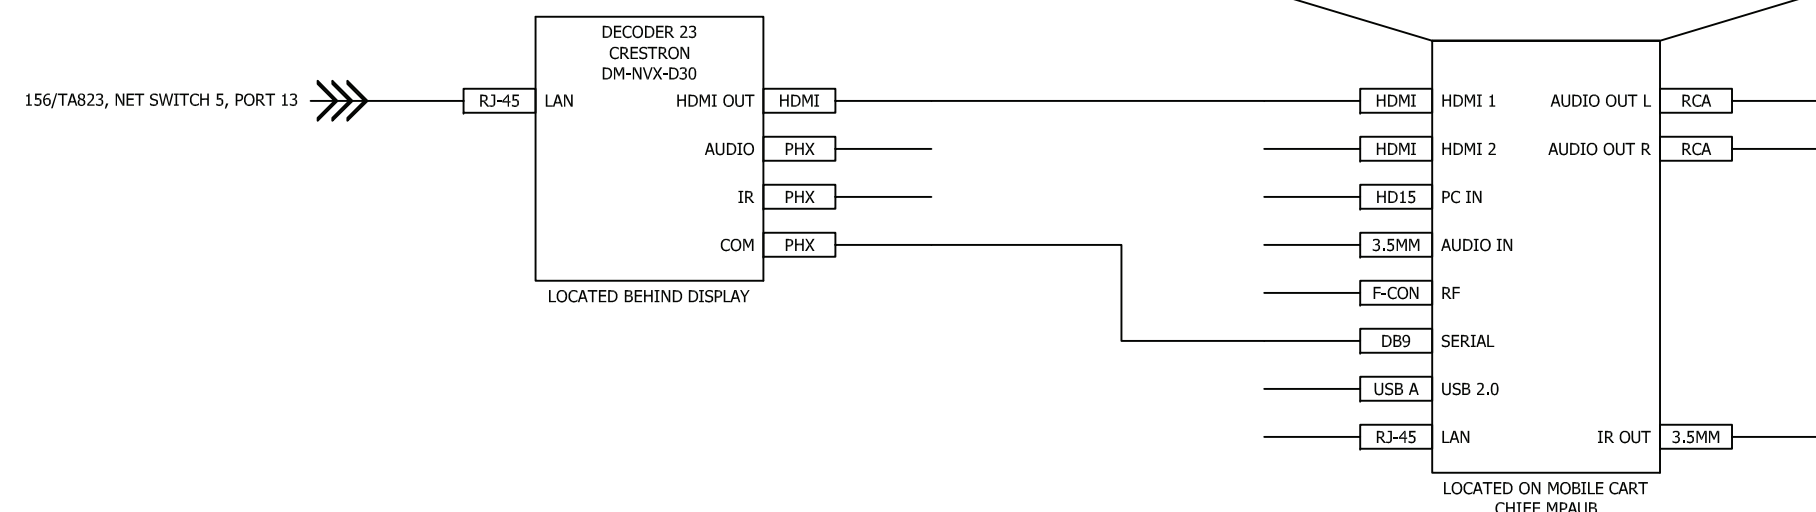


B

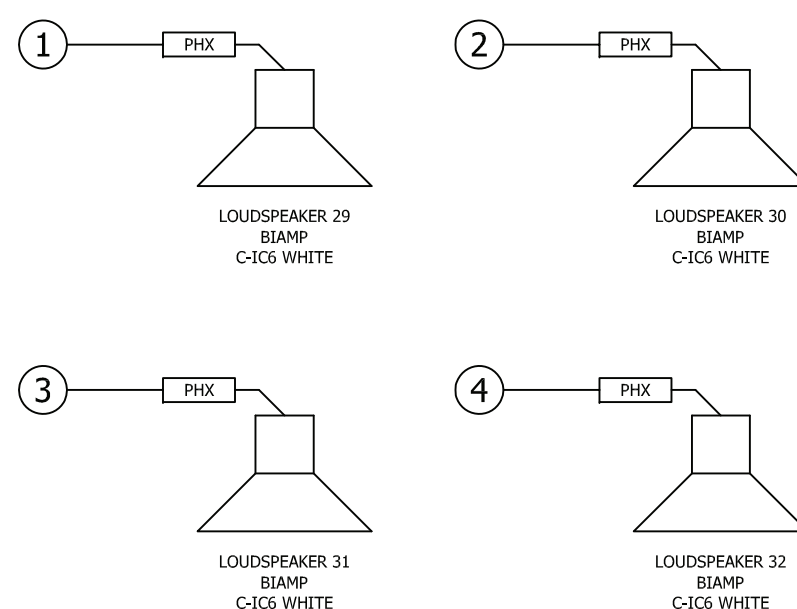

PRE-1A


A

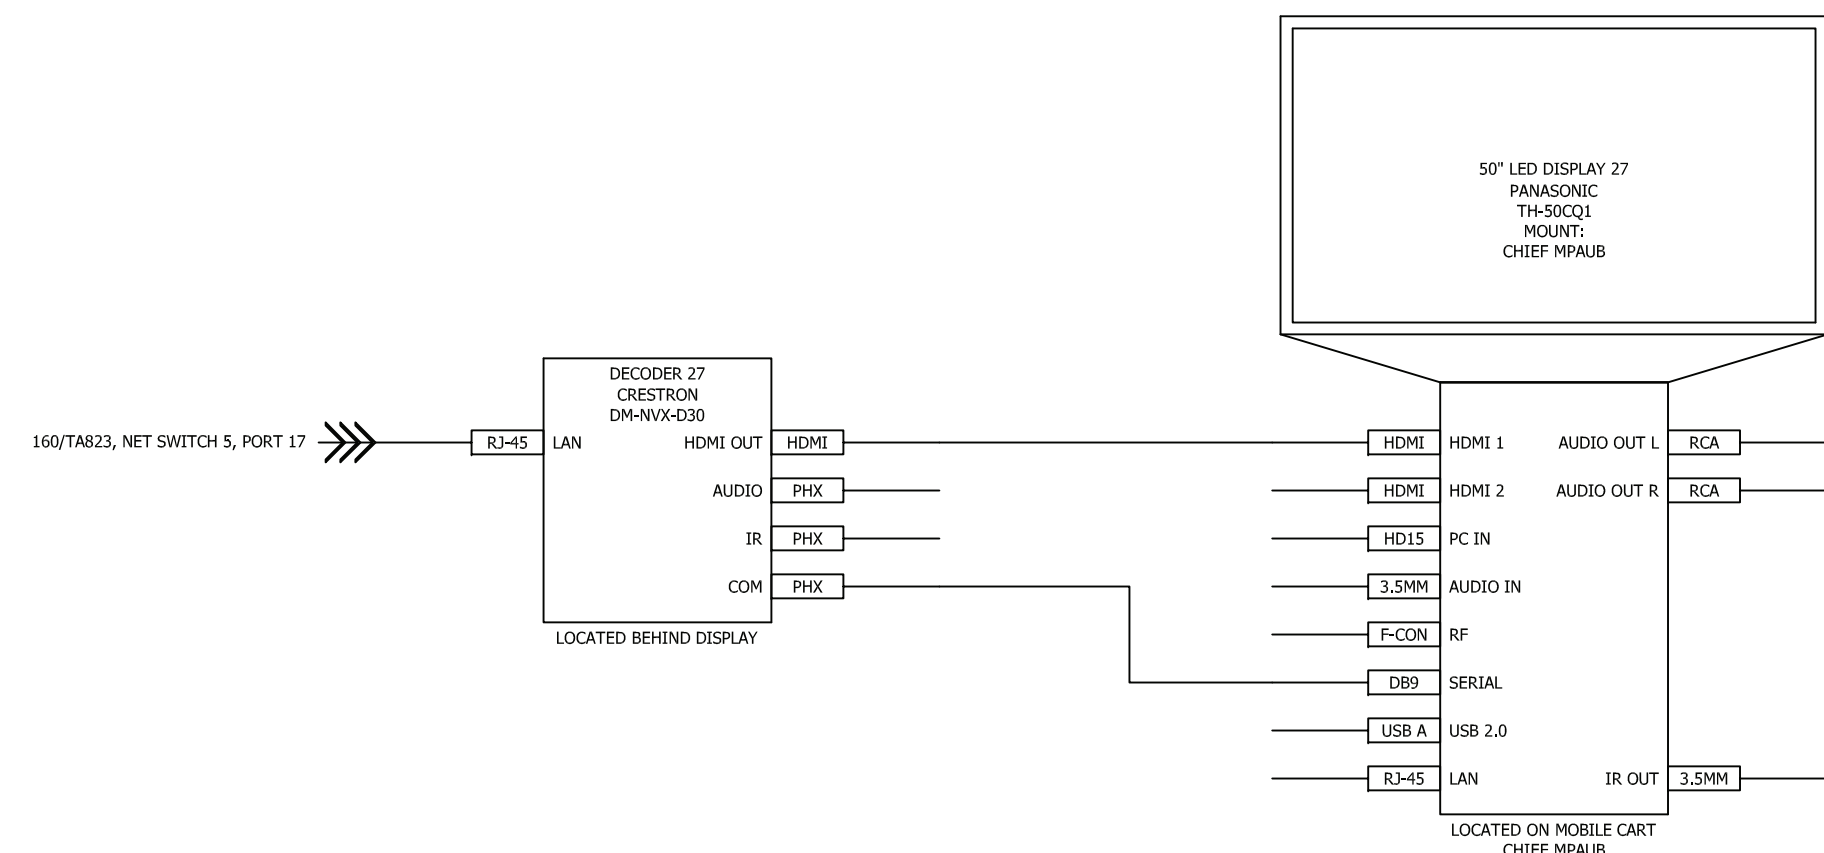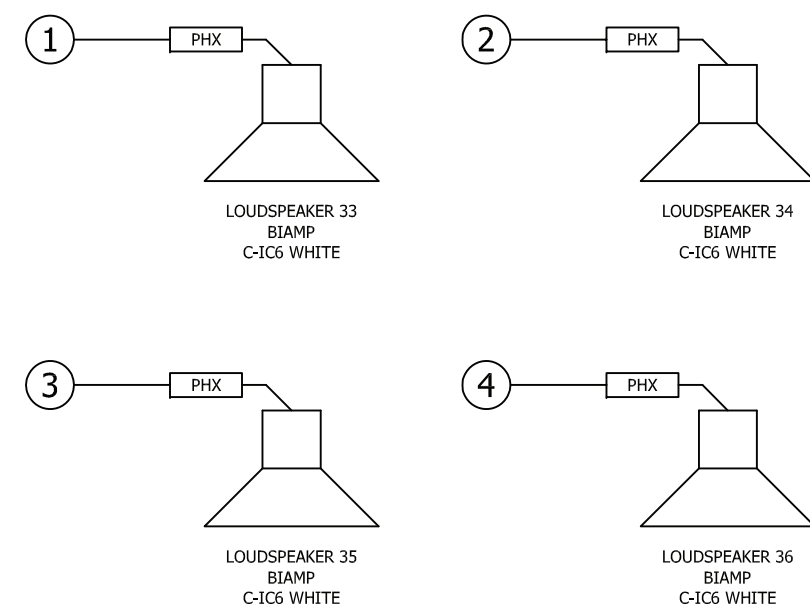


SCALE:	NTS
EPROJECT NO.:	
CONSTR. CONTR. NO.	N40085-20-C-0059
NAVFAC DRAWING NO.	
SHEET	OF
TA815	

DP2 SUBMISSION – P1338 BUILDING PRE-FINAL SUBMISSION


D

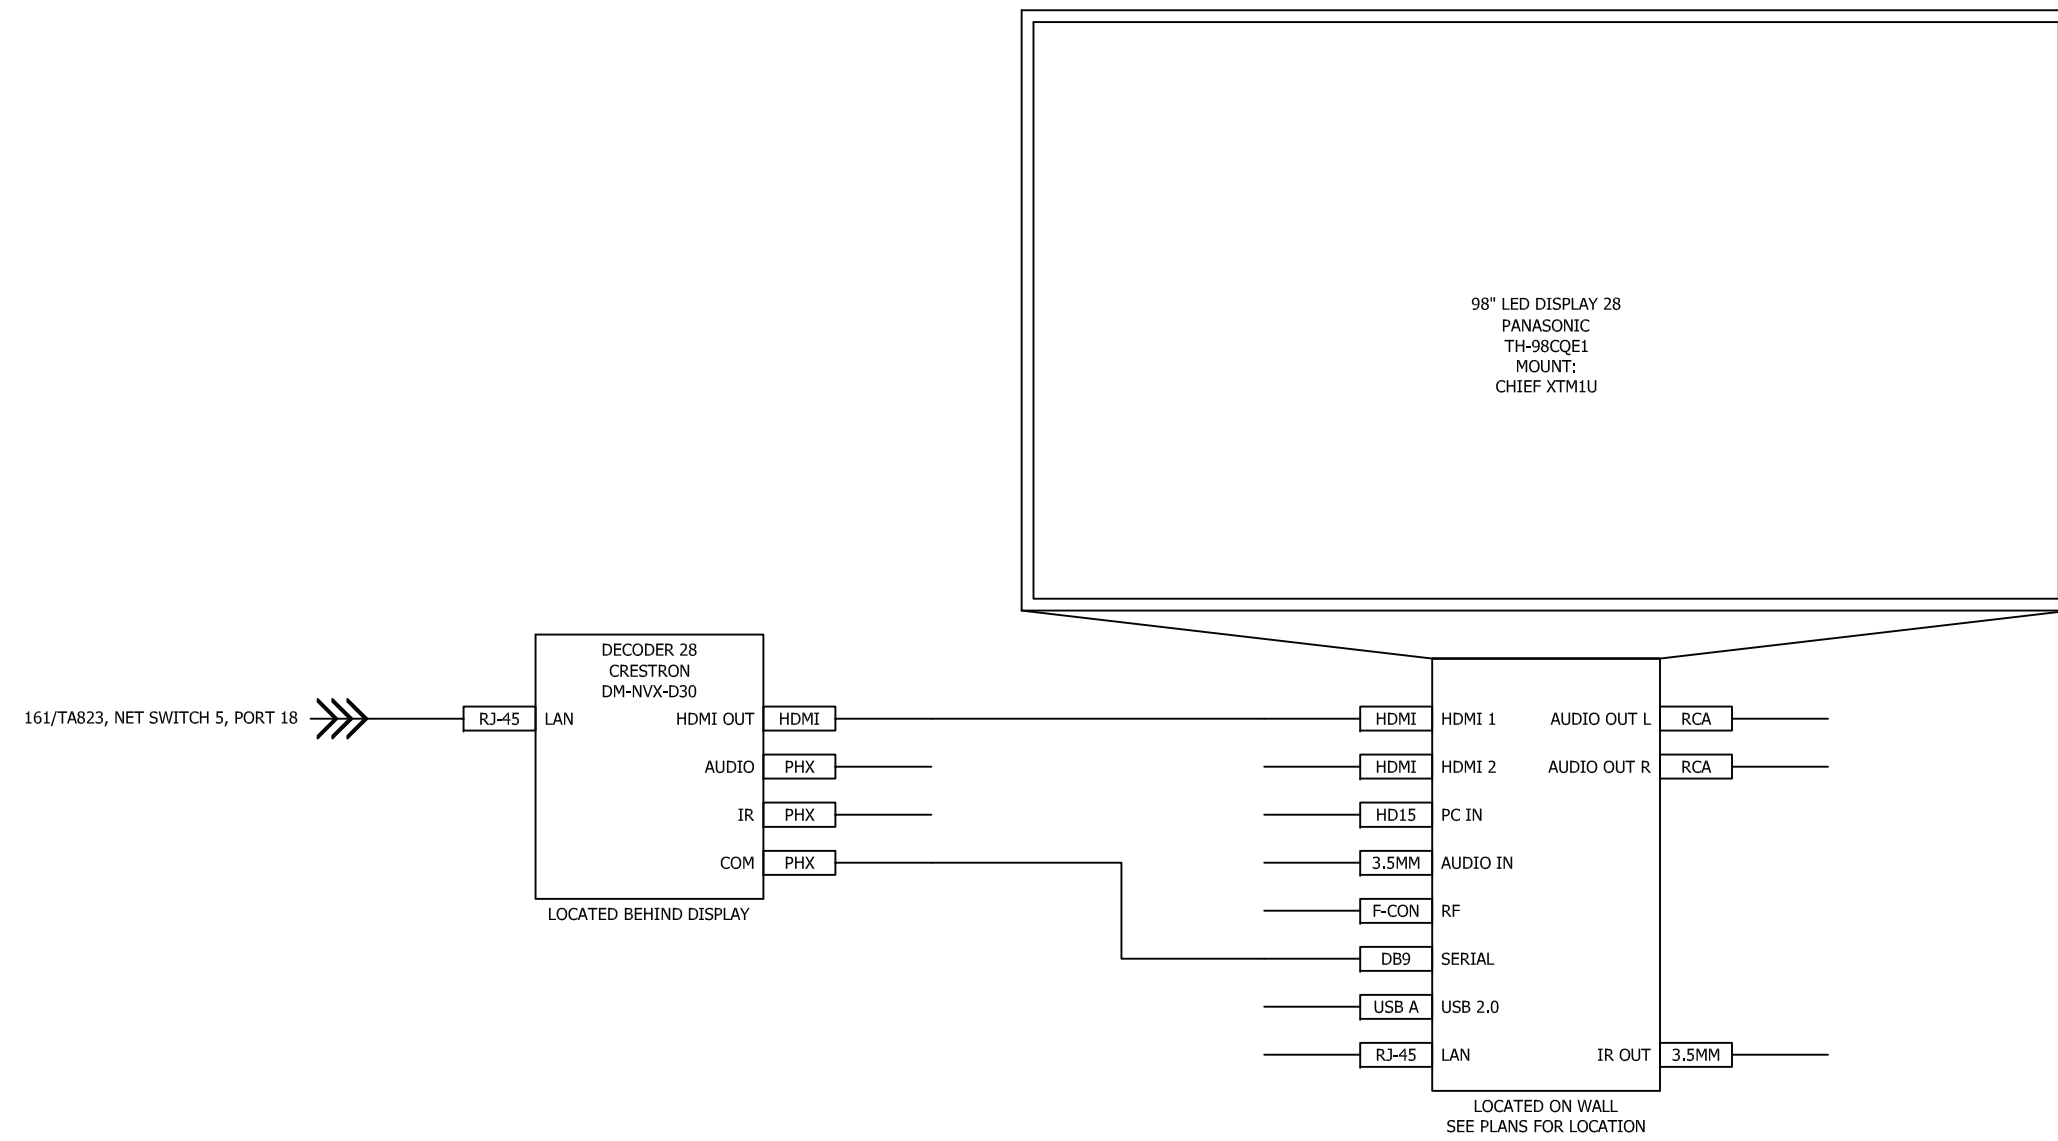


C

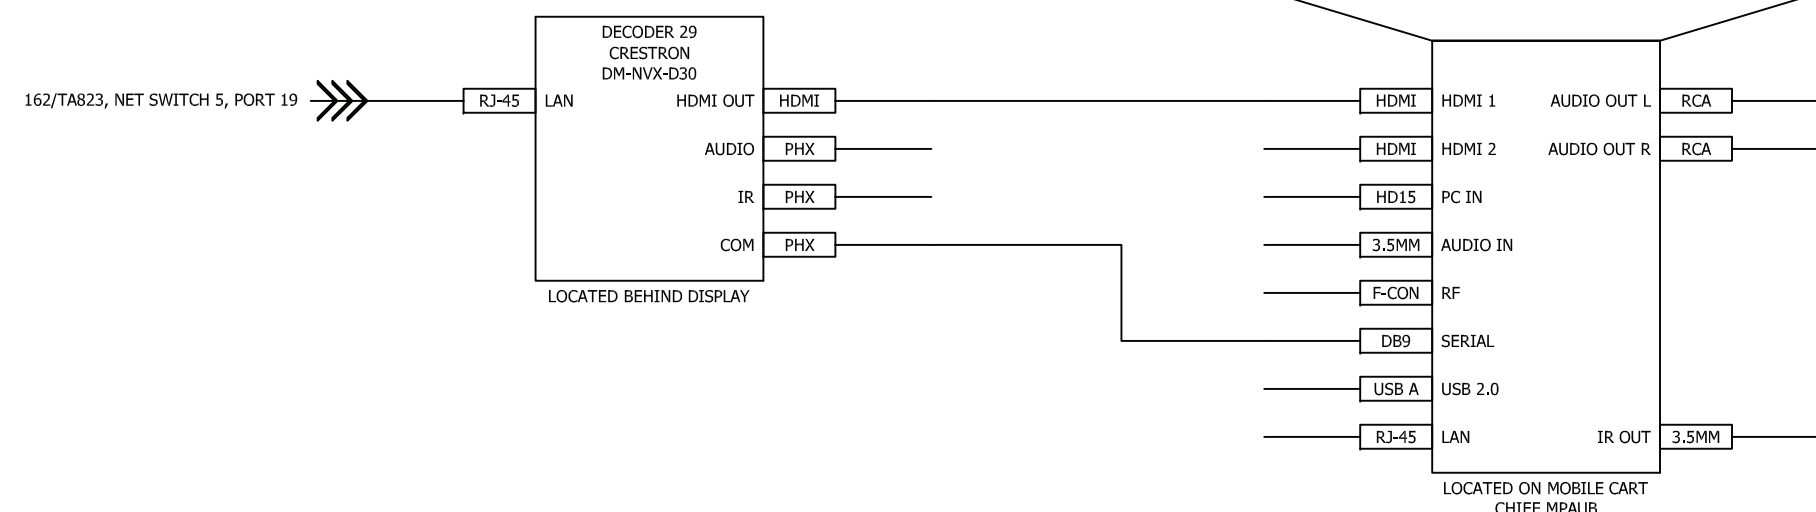



B

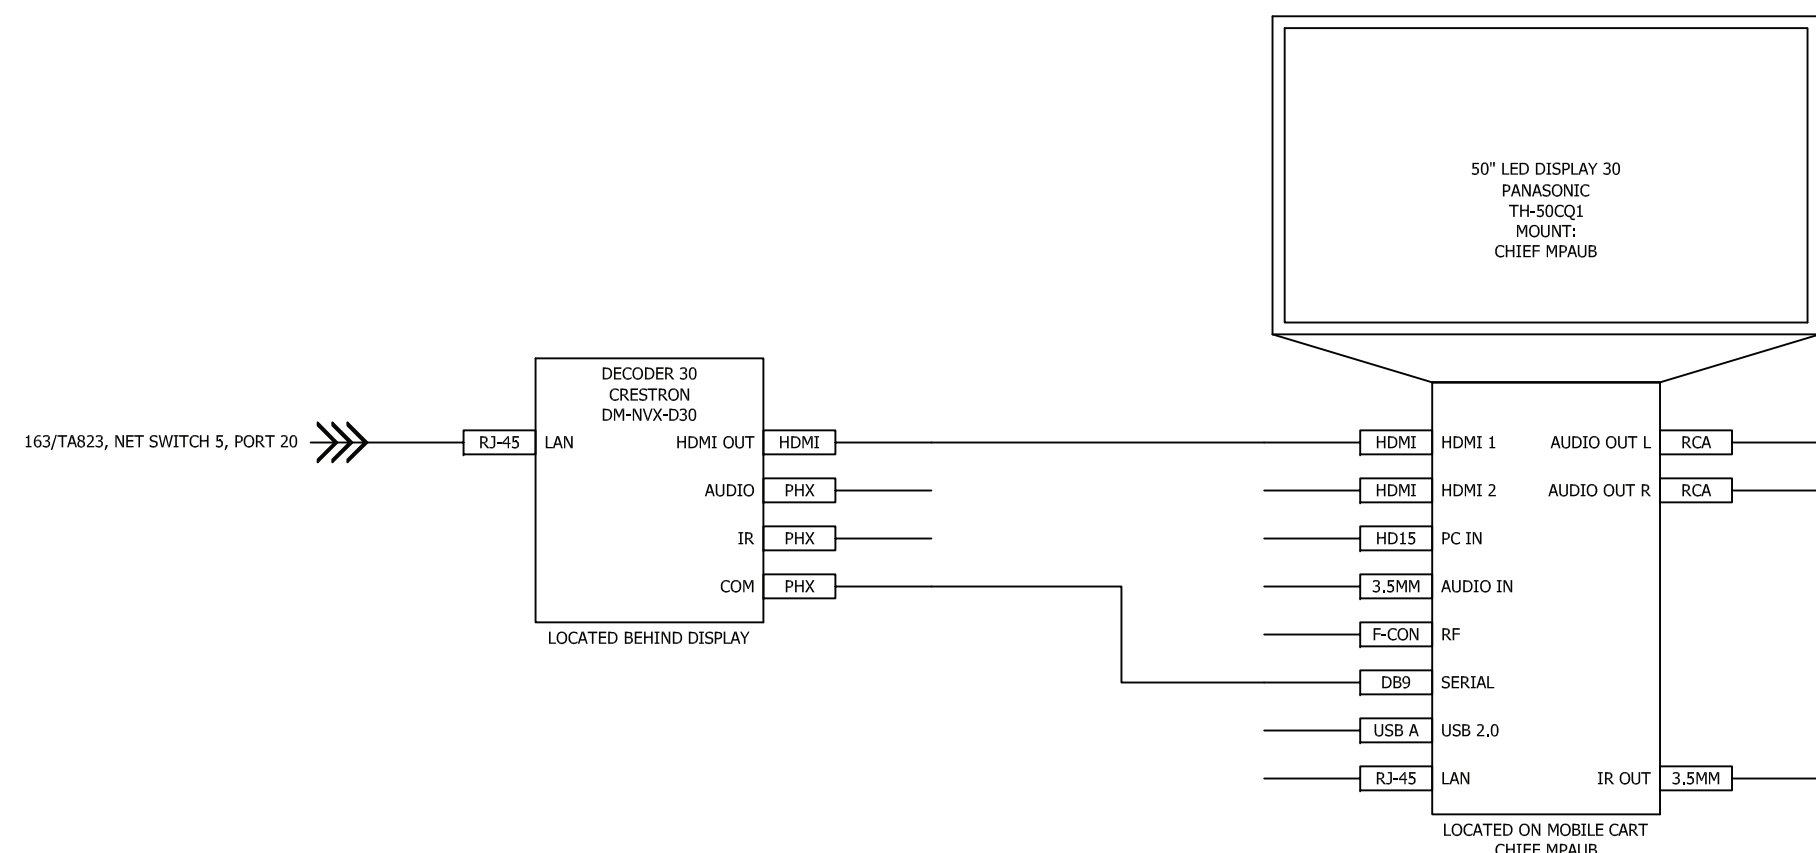

PRE-A



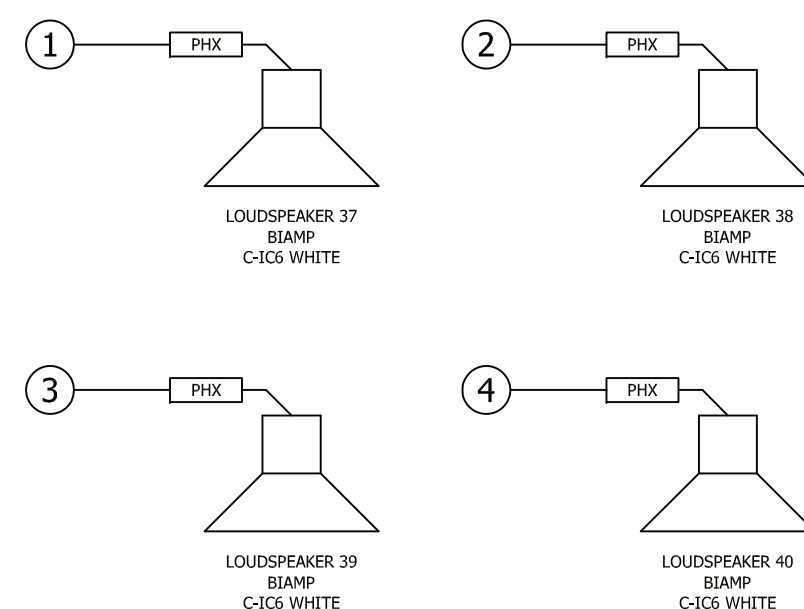


A

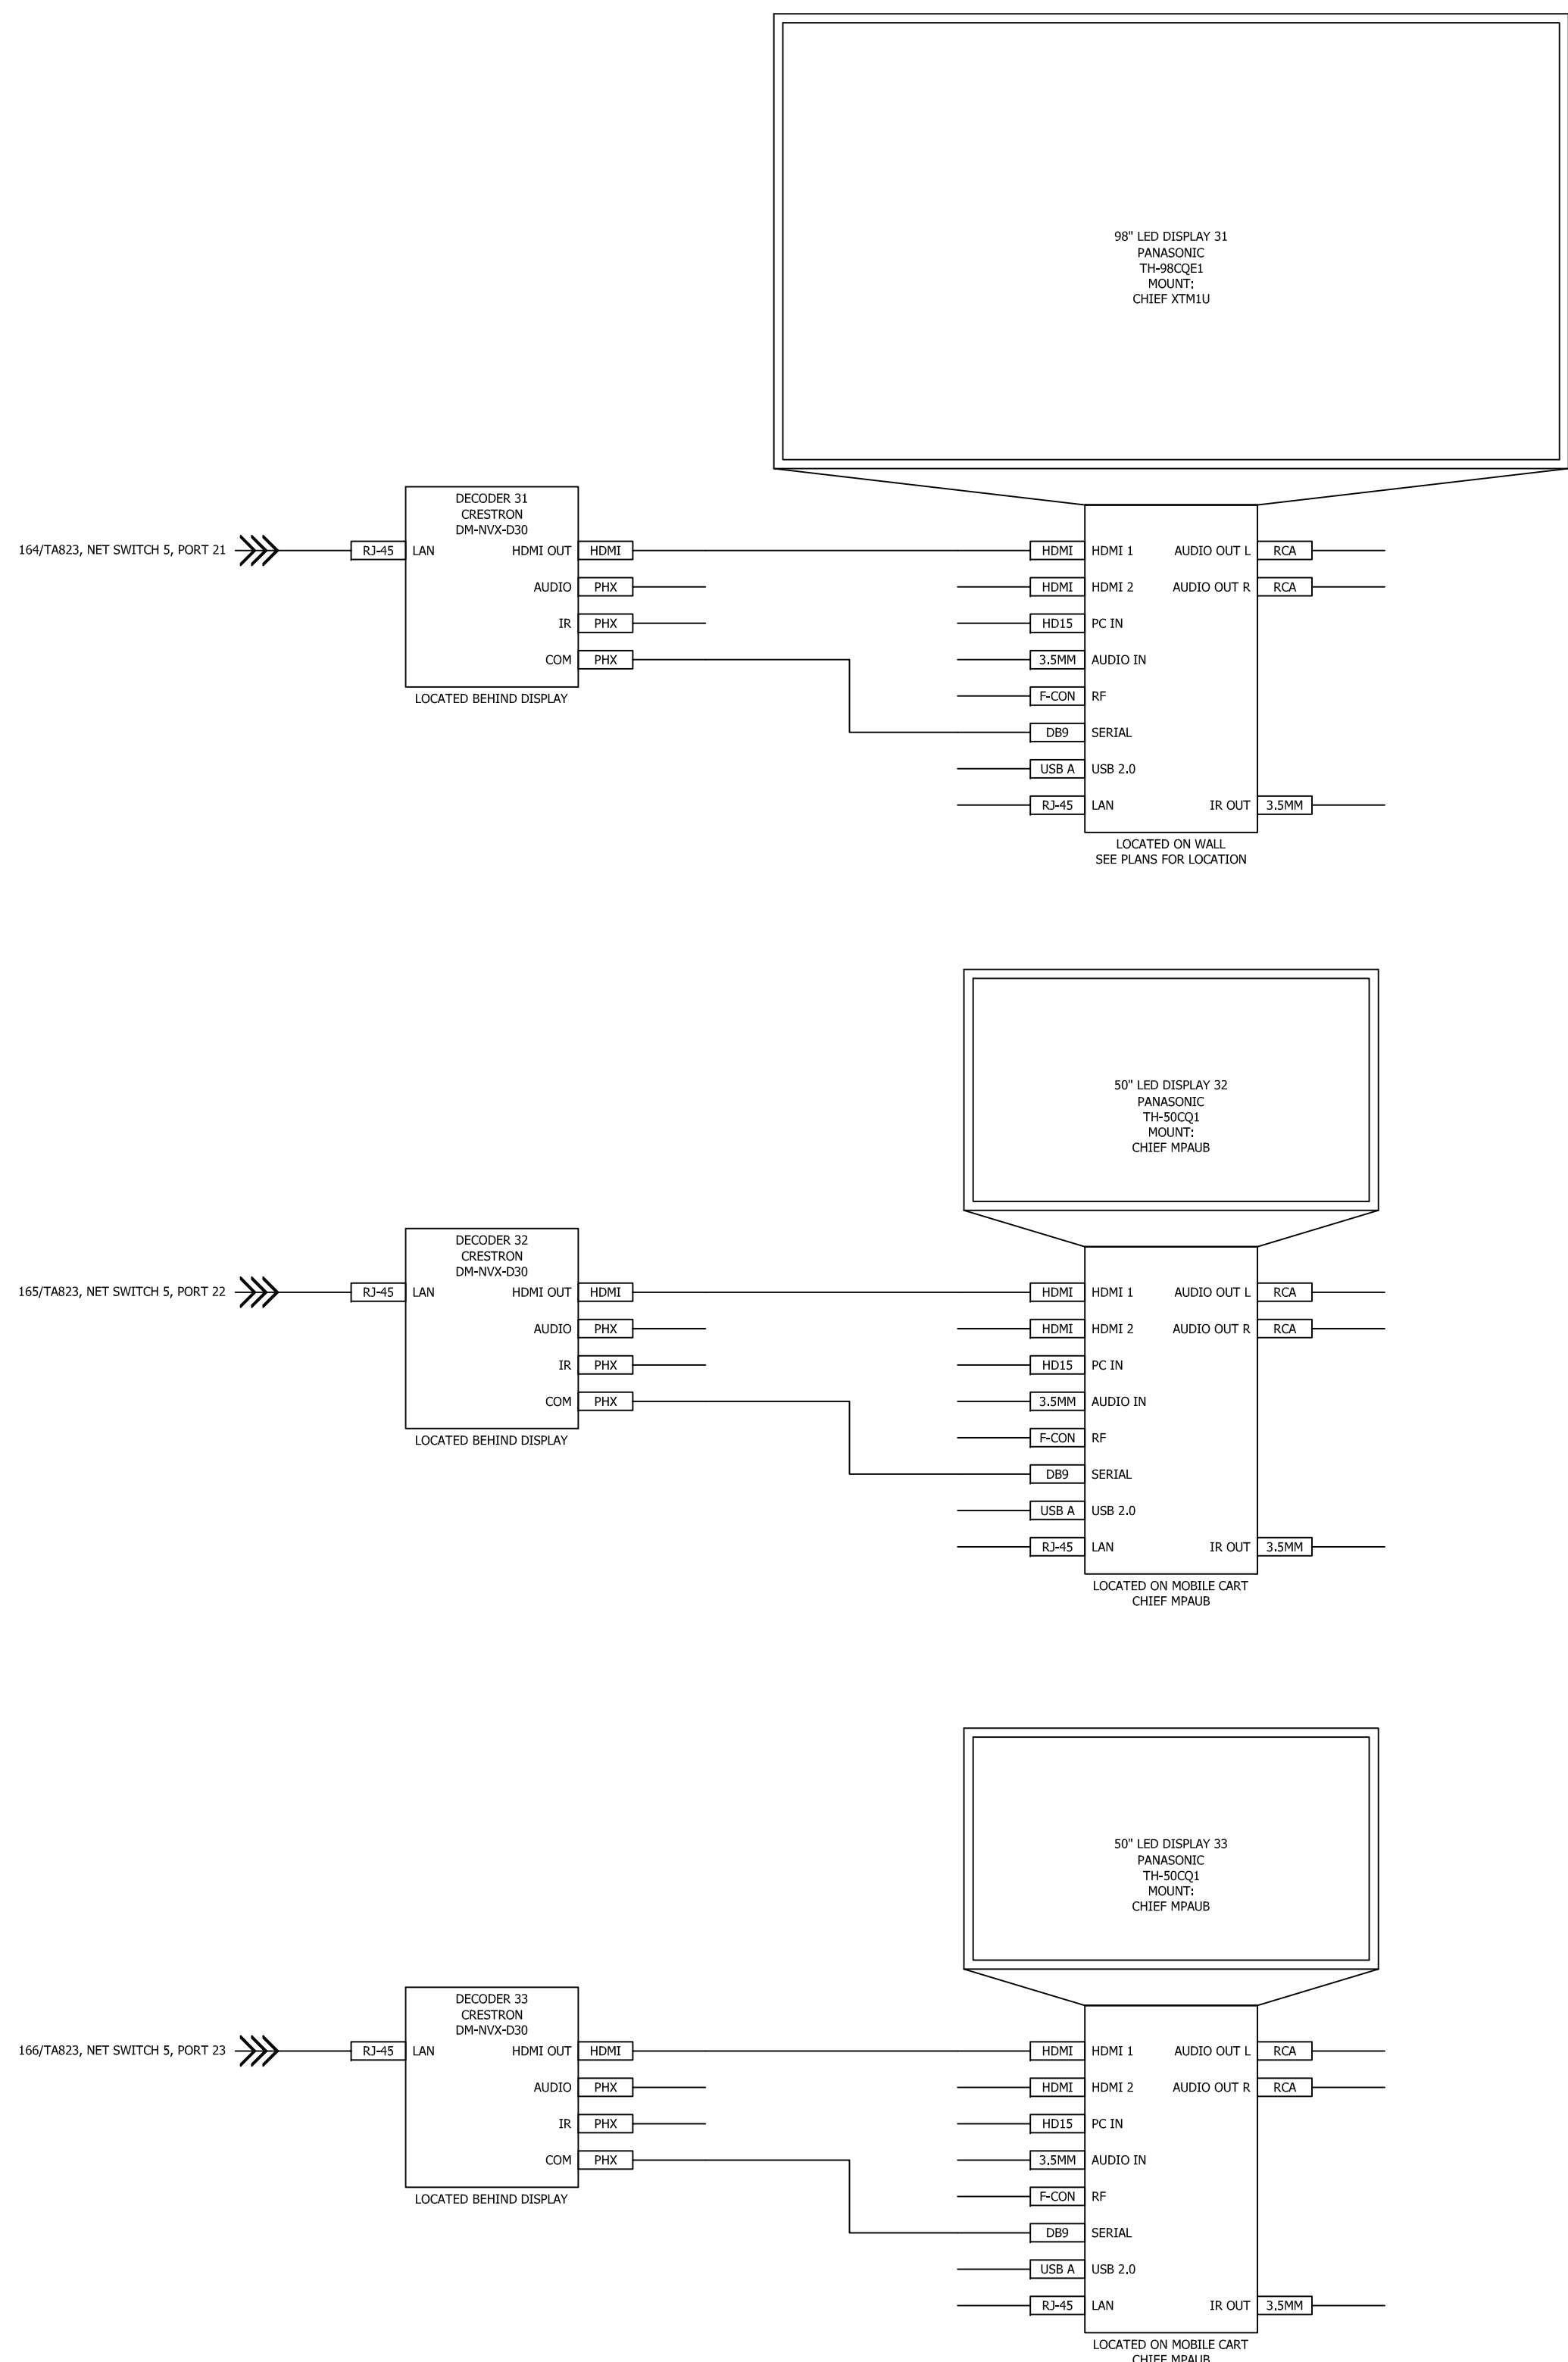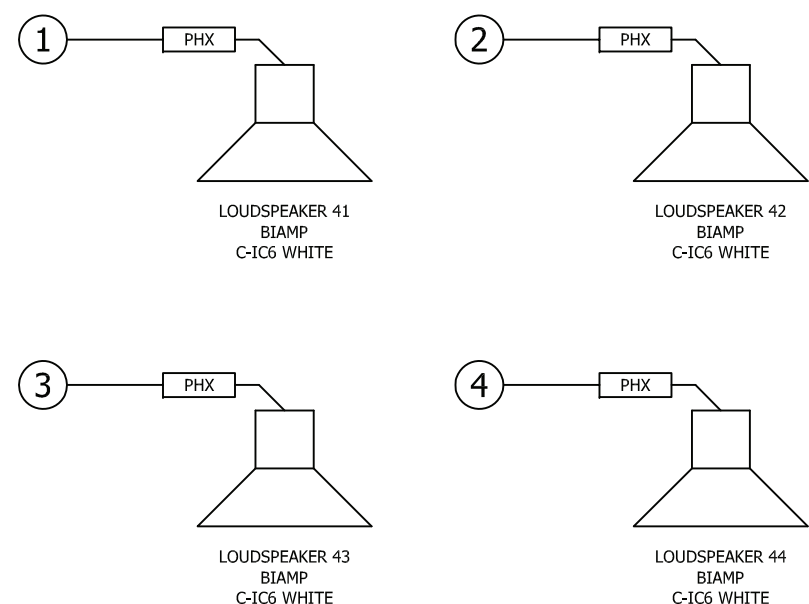

SCALE:	NTS
EPROJECT NO.:	
CONSTR. CONTR. NO. N40085-20-C-0059	
NAVFAC DRAWING NO.	
SHEET	OF
TA817	

DP2 SUBMISSION - P1338 BUILDING PRE-FINAL SUBMISSION

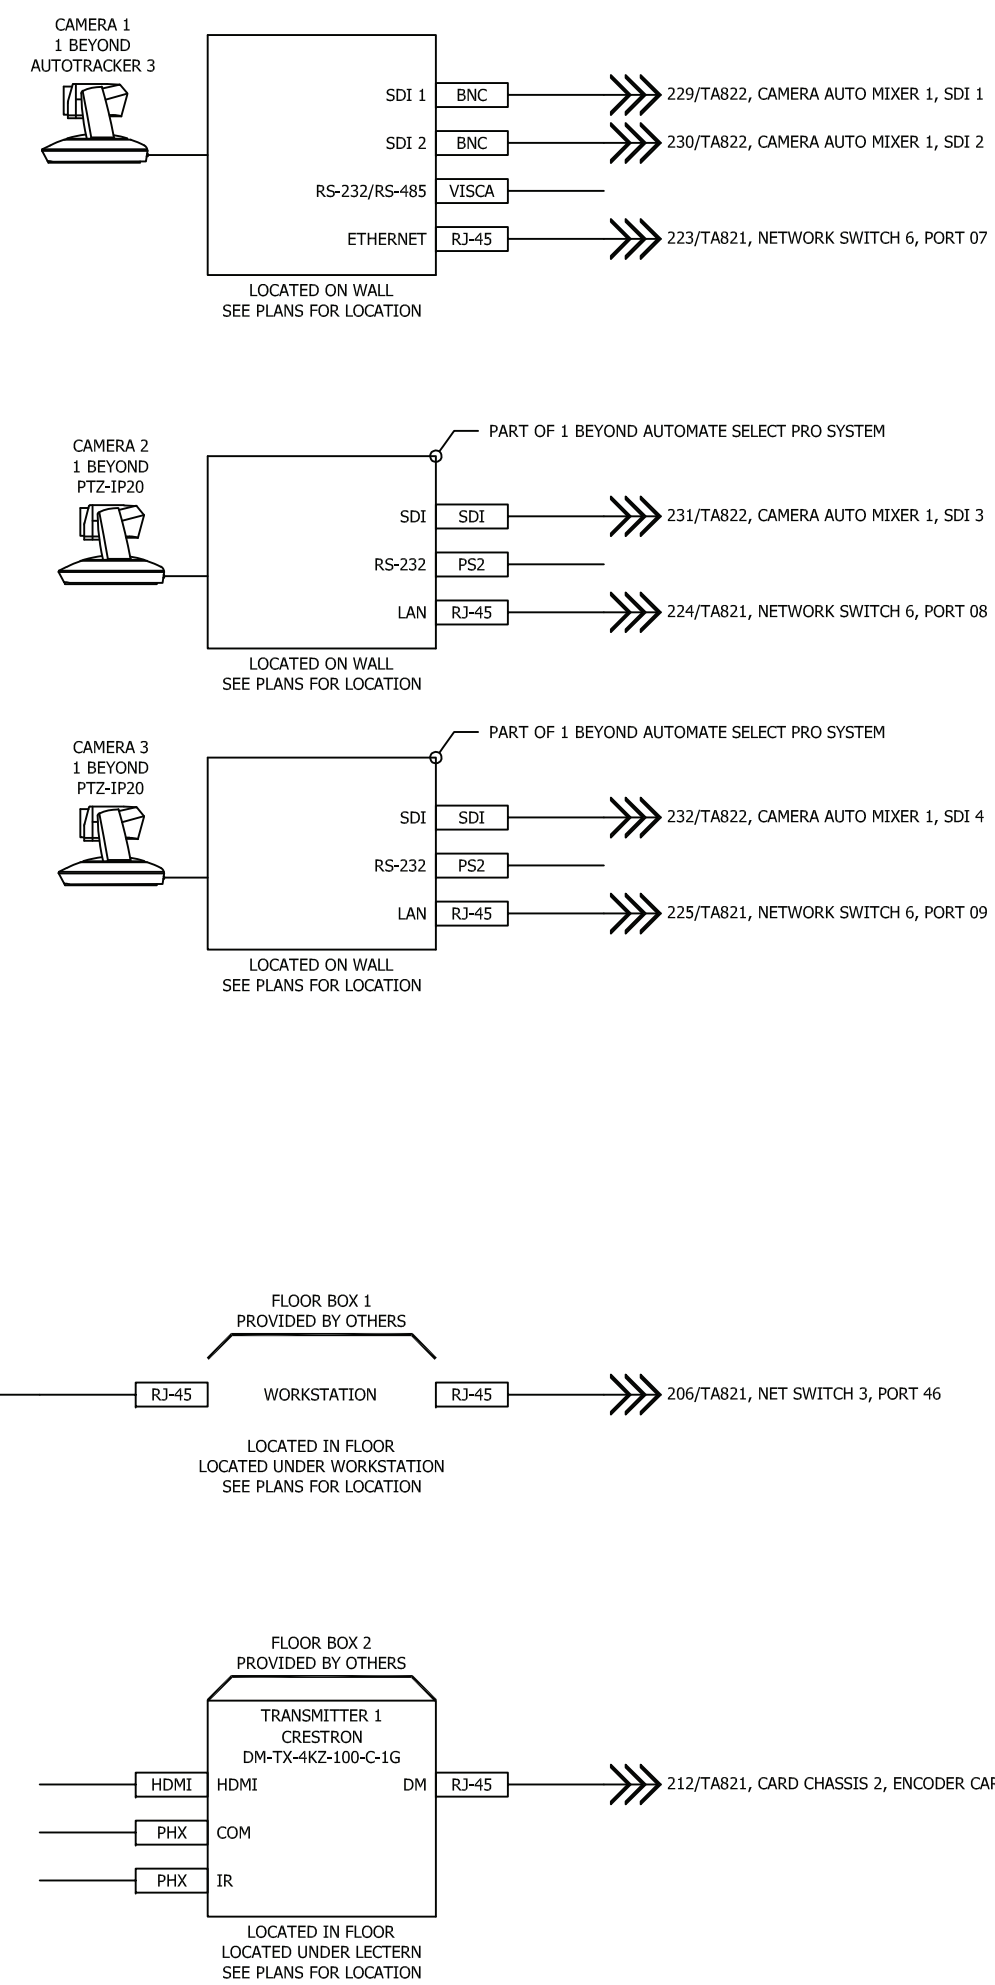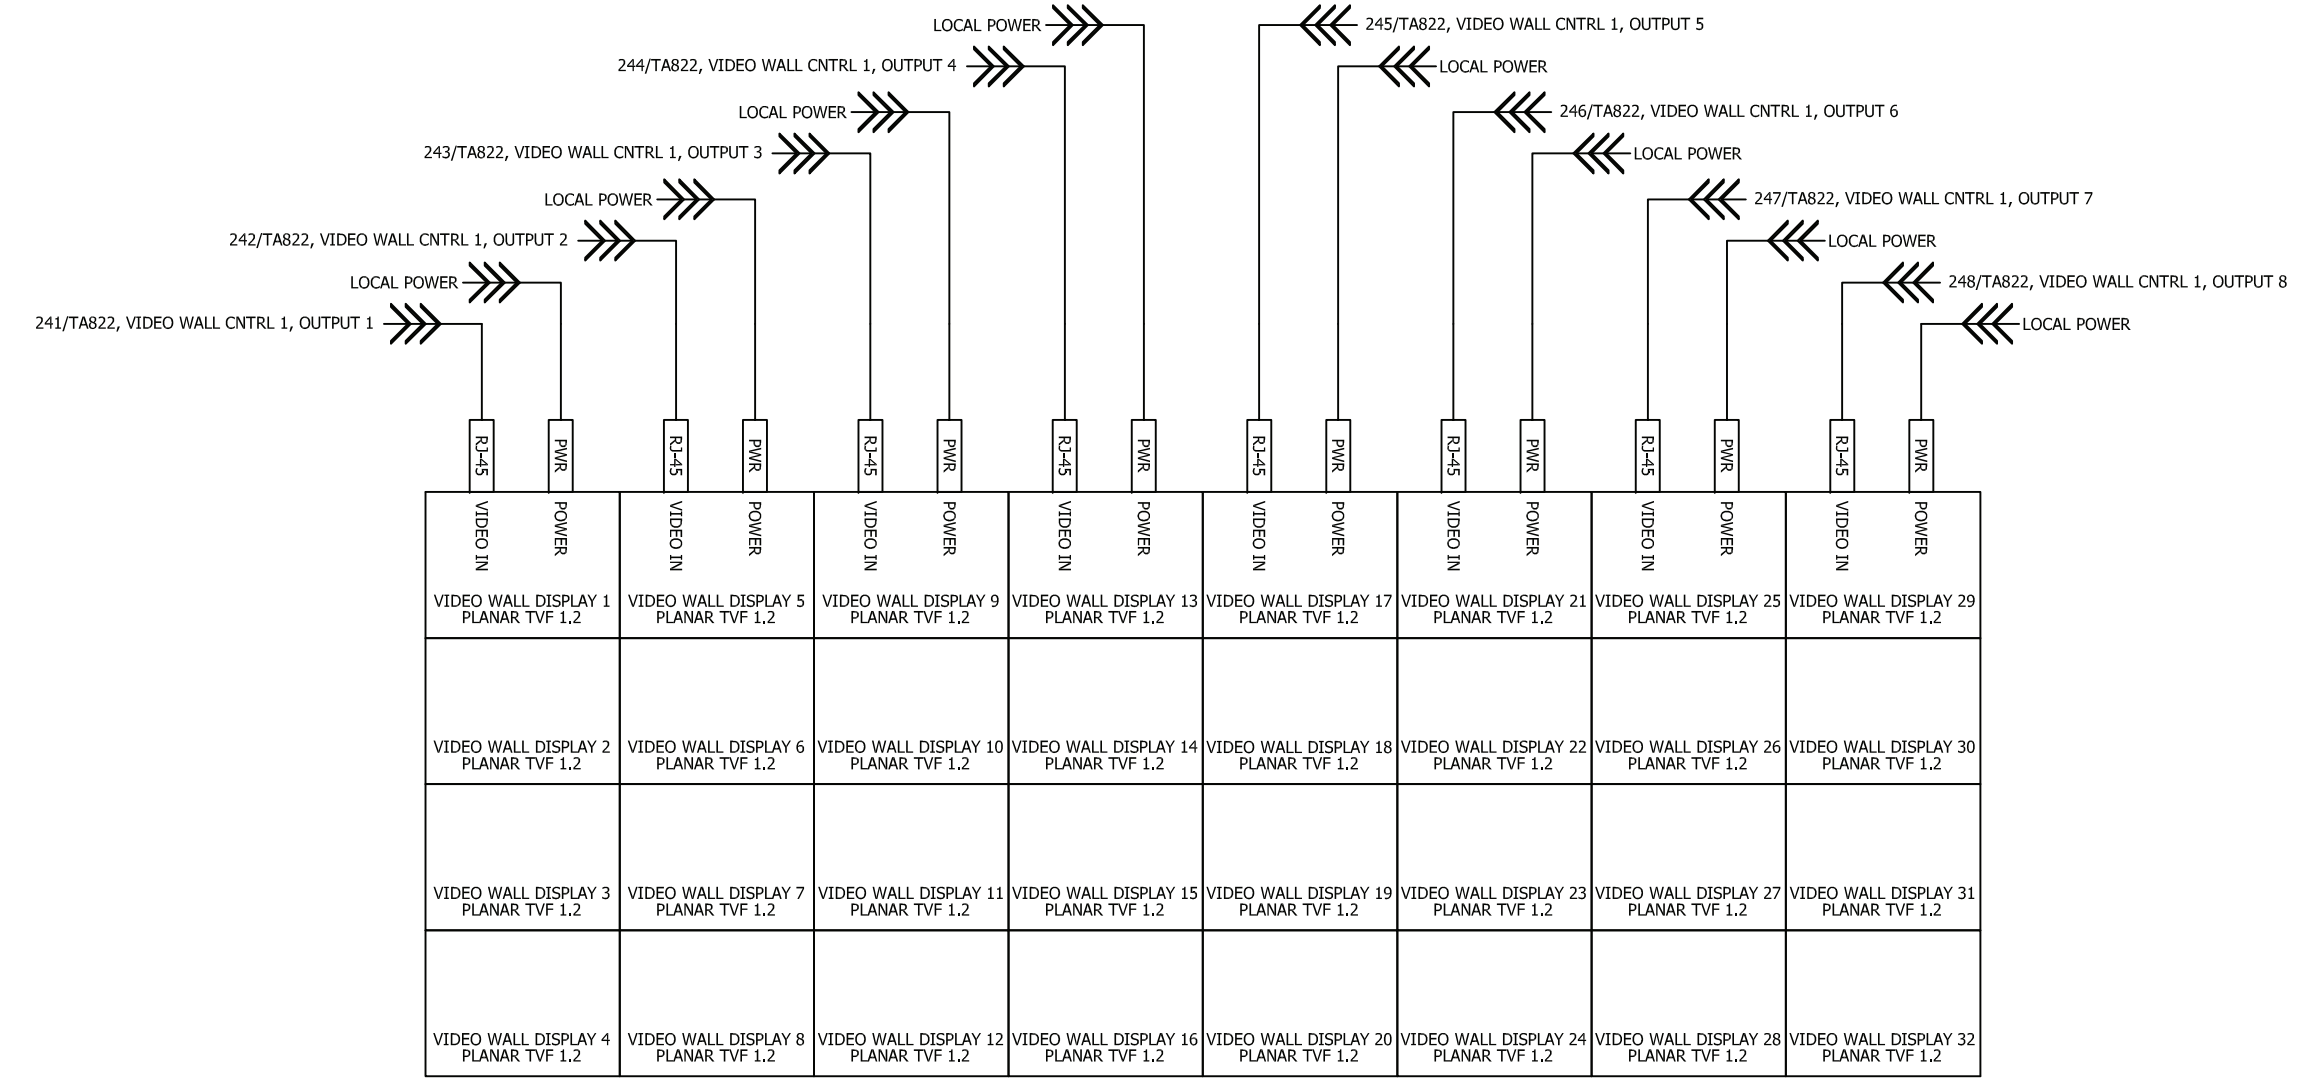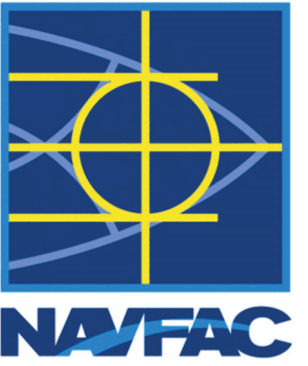[illegible]

PRELIMINARY
NOT FOR CONSTRUCTION





Michael Baker
INTERNATIONAL
100 AIRSIDE DRIVE
MOON TOWNSHIP, PA 15108 A/E INFO
APPROVED

FOR COMMANDER NAVFAC			
ACTIVITY			
MARINE CORPS BASE CAMP LEJEUNE			
SATISFACTORY TO DATE		DD/MM/YY	
DES AS	DRW AV	CHK	BM
PM		XXX	
BRANCH MANAGER		XXX	
CHIEF ENG/ARCH		XXX	
FIRE PROTECTION		XXX	

AUDITORIUM/ READY ROOM 201 SYSTEM DRAWING

SCALE:	NTS
EPROJECT NO.:	
CONSTR. CONTR. NO.	N40085-20-C-0059
NAVFAC DRAWING NO.	
SHEET	OF
TA818	

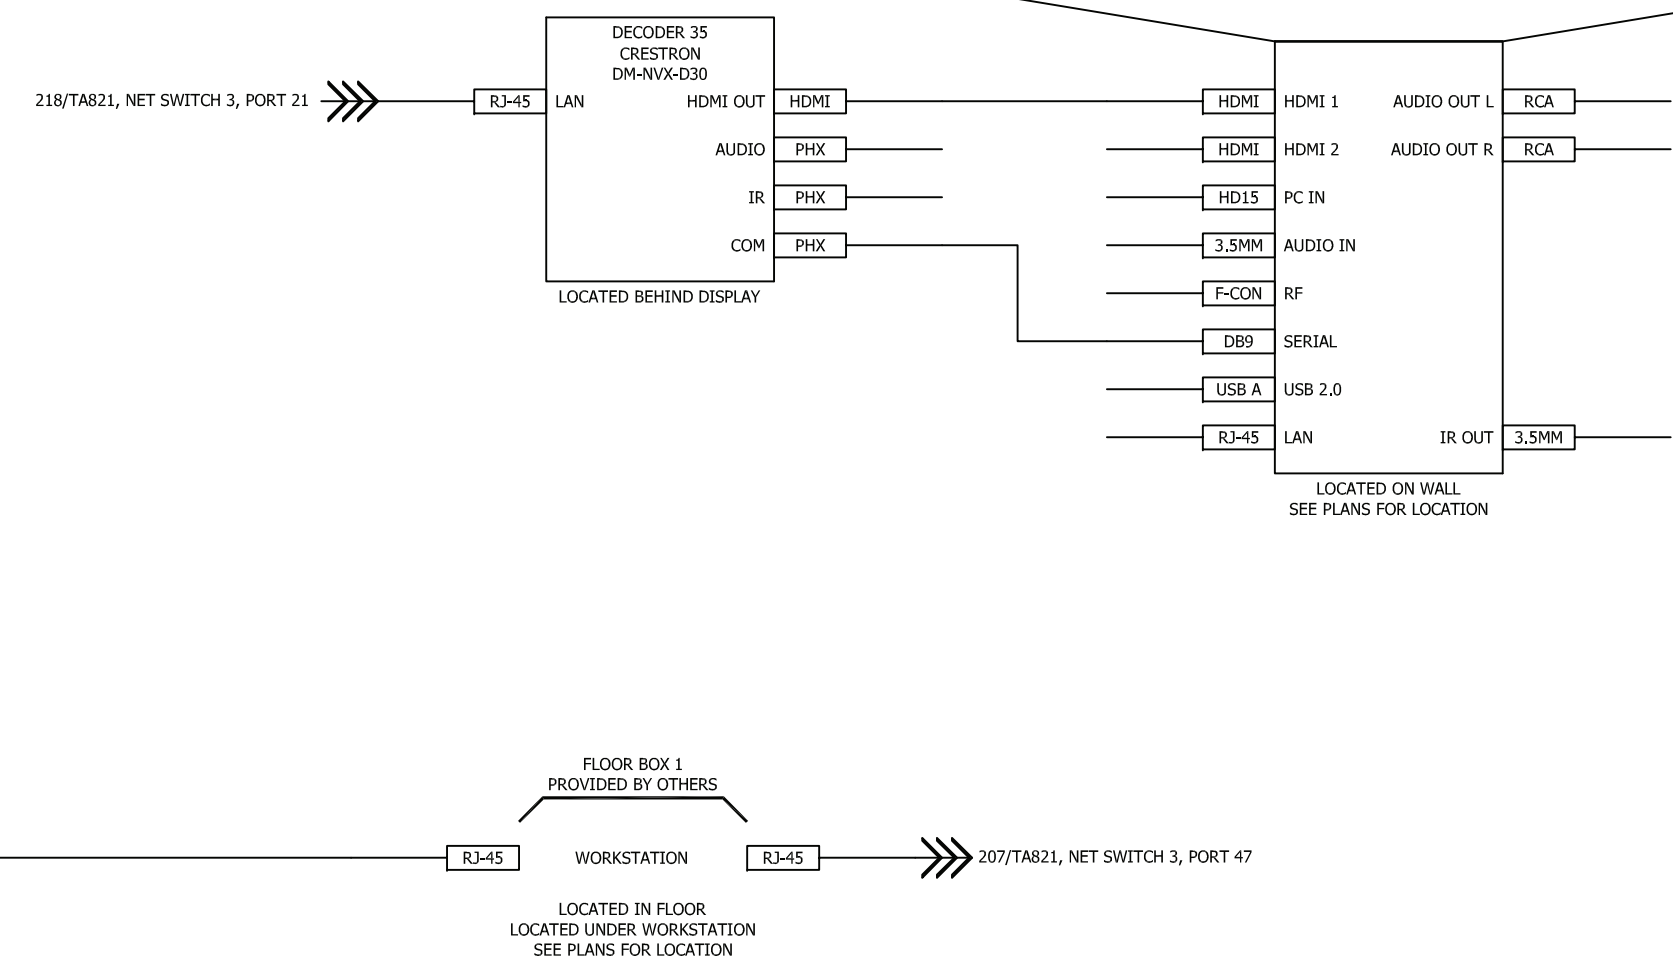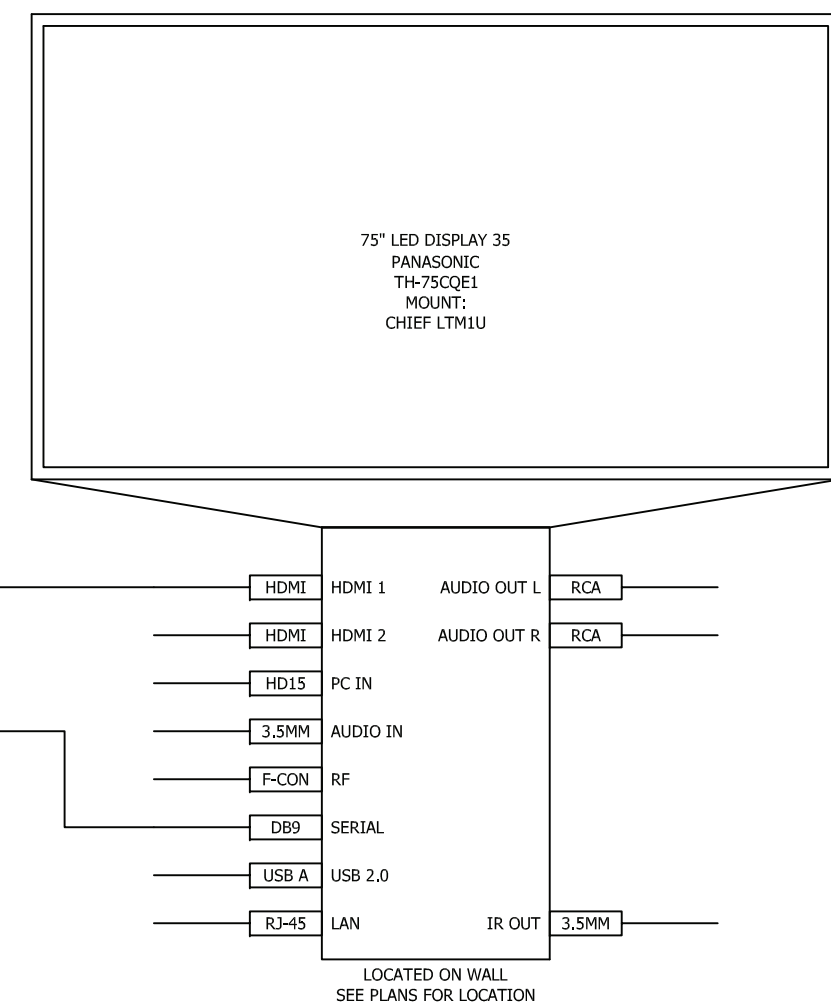

SCALE:	NTS
EPROJECT NO.:	
CONSTR. CONTR. NO.	N40085-20-C-0059
NAVFAC DRAWING NO.	
SHEET	OF
TA819	



FILE NAME: BIM 360/HF PACKAGE 3P1338_MEF SIM CTR-1500892.rvt
PLOTTED: 5/19/2021 3:26:30 PM

D

C

B

A

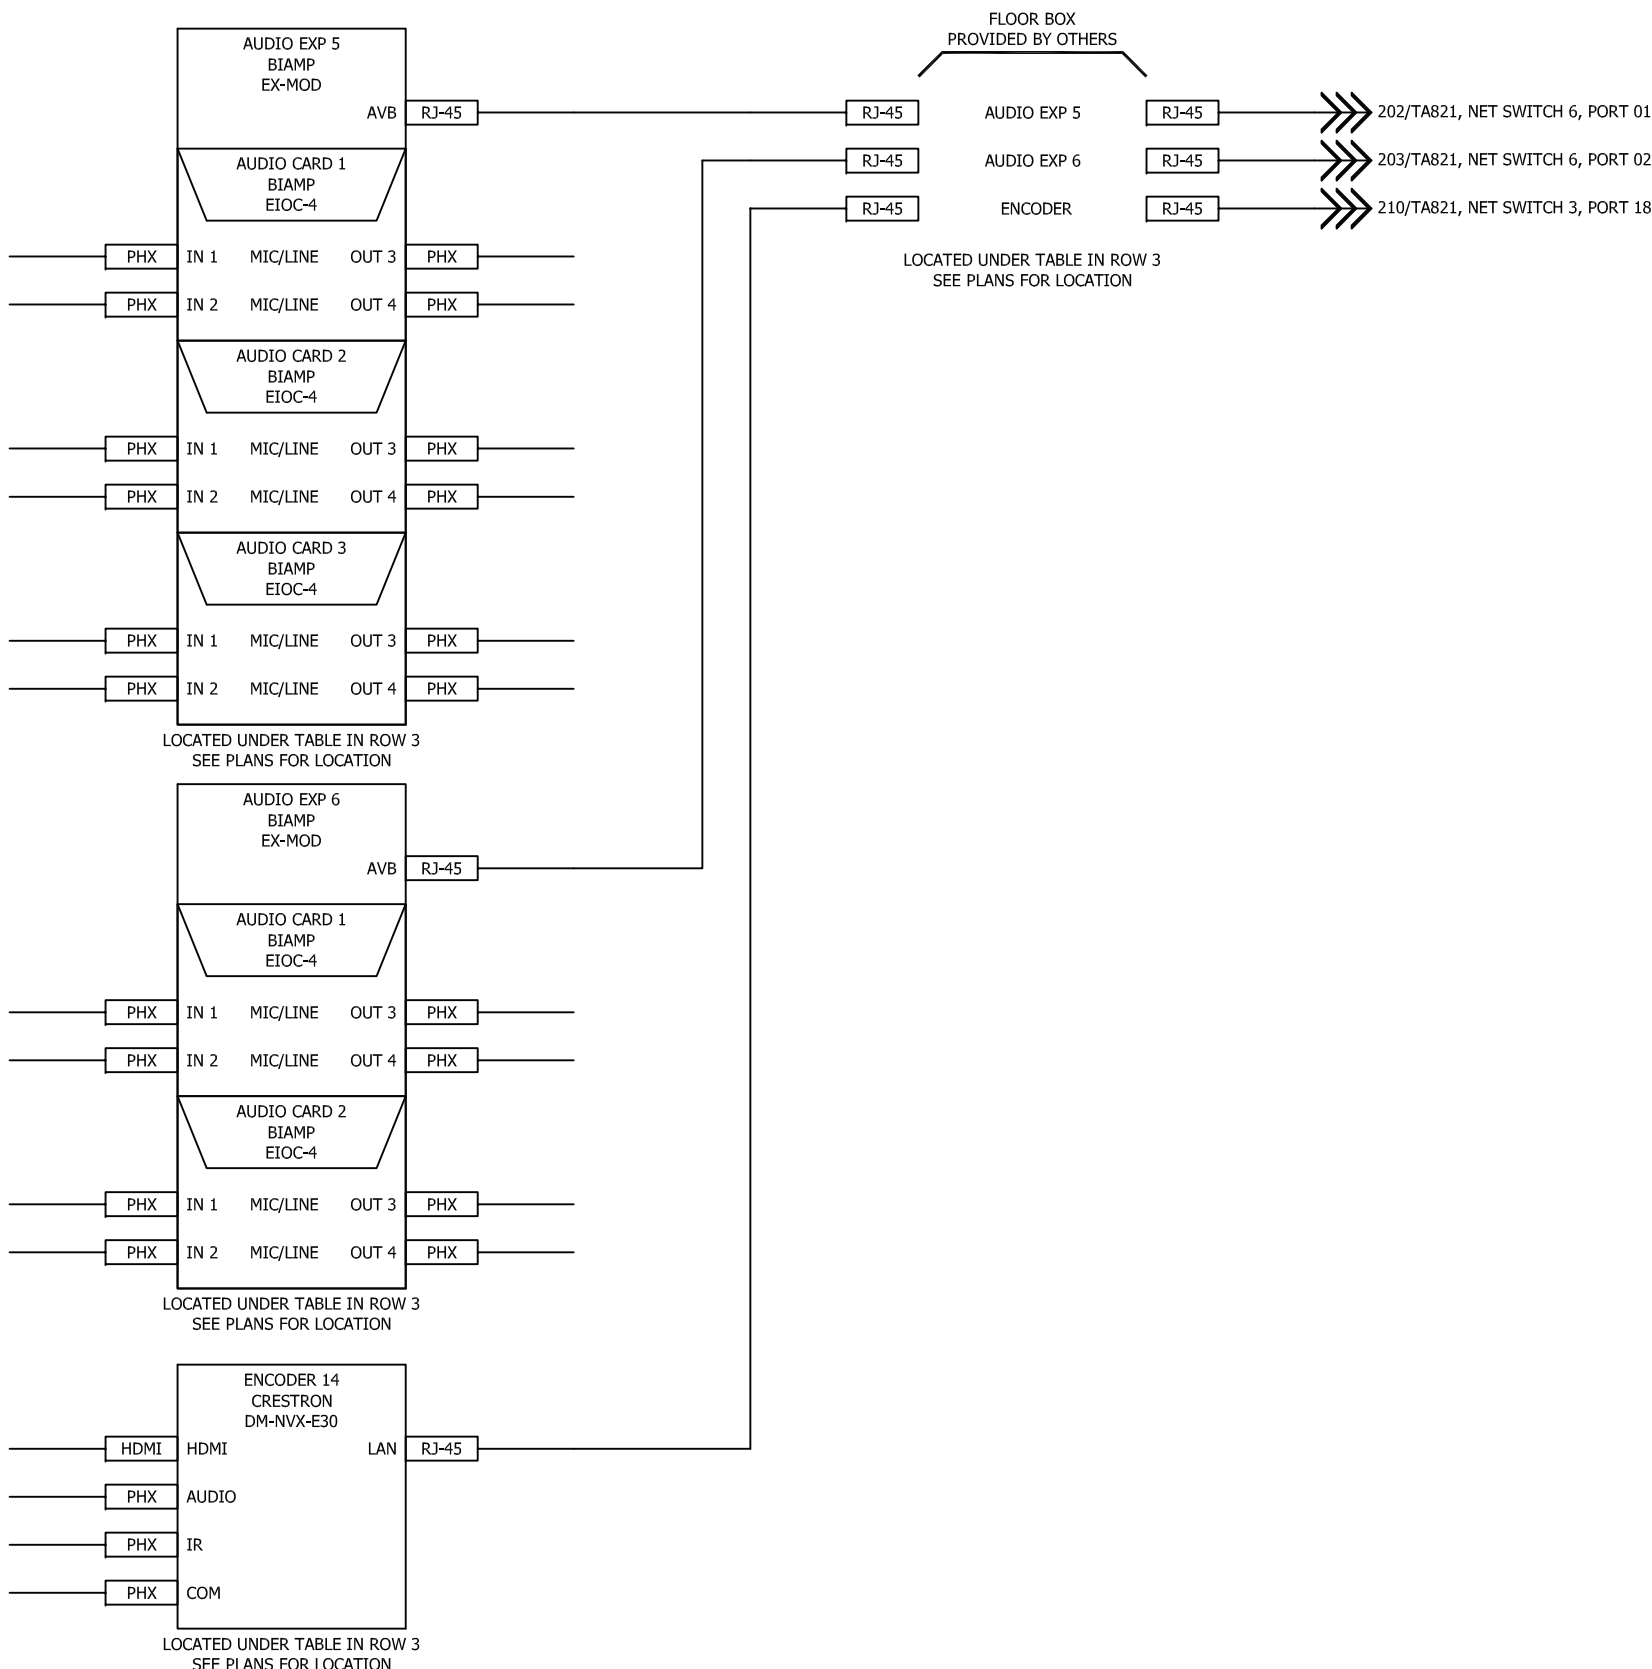
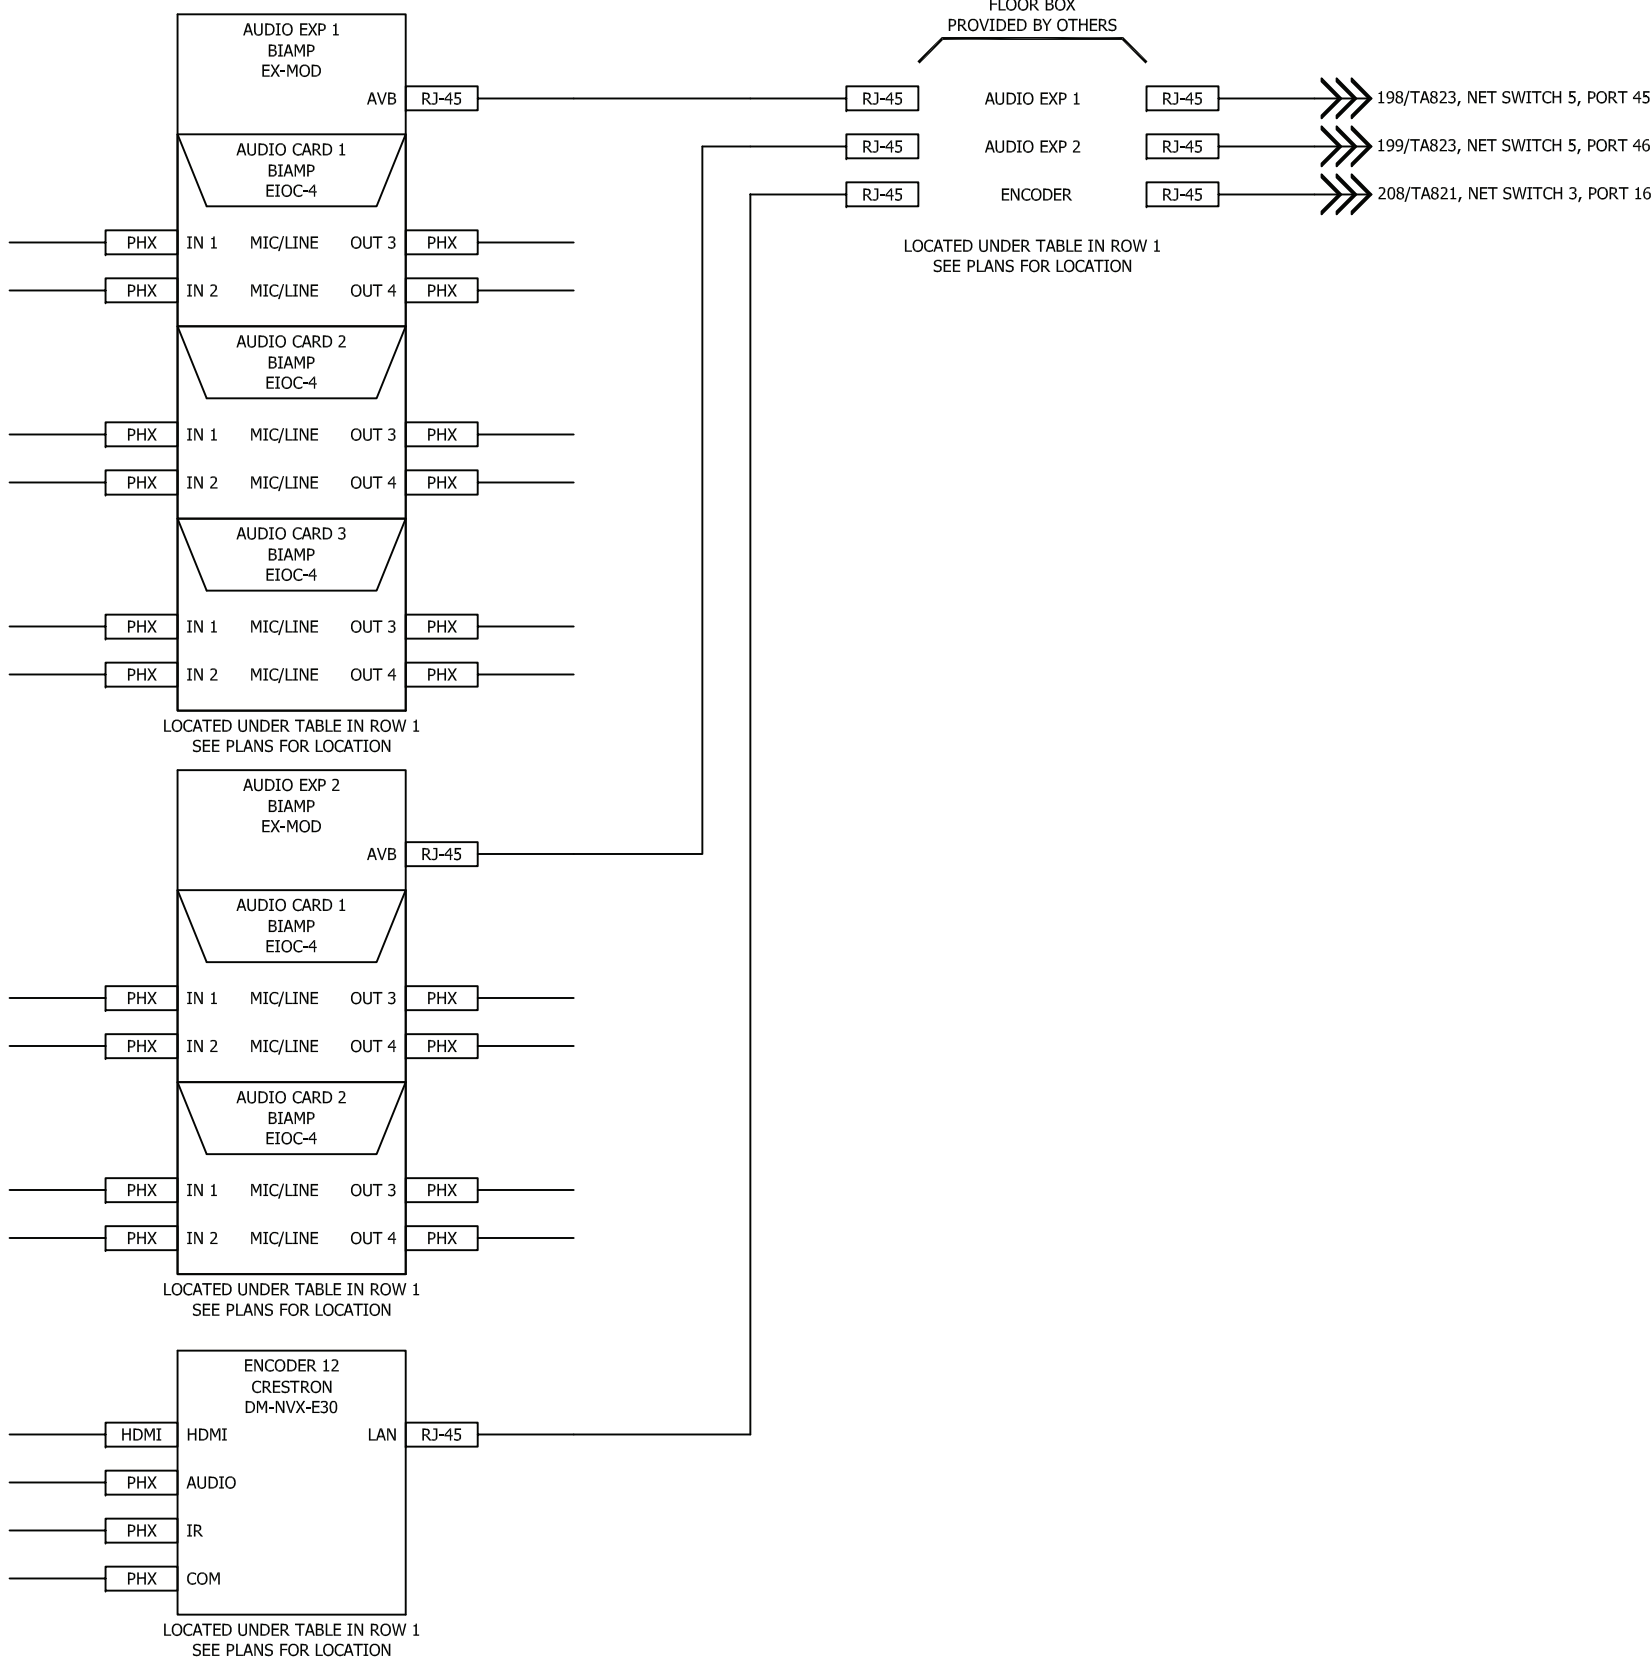


UNCLASSIFIED

UNCLASSIFIED

4

4

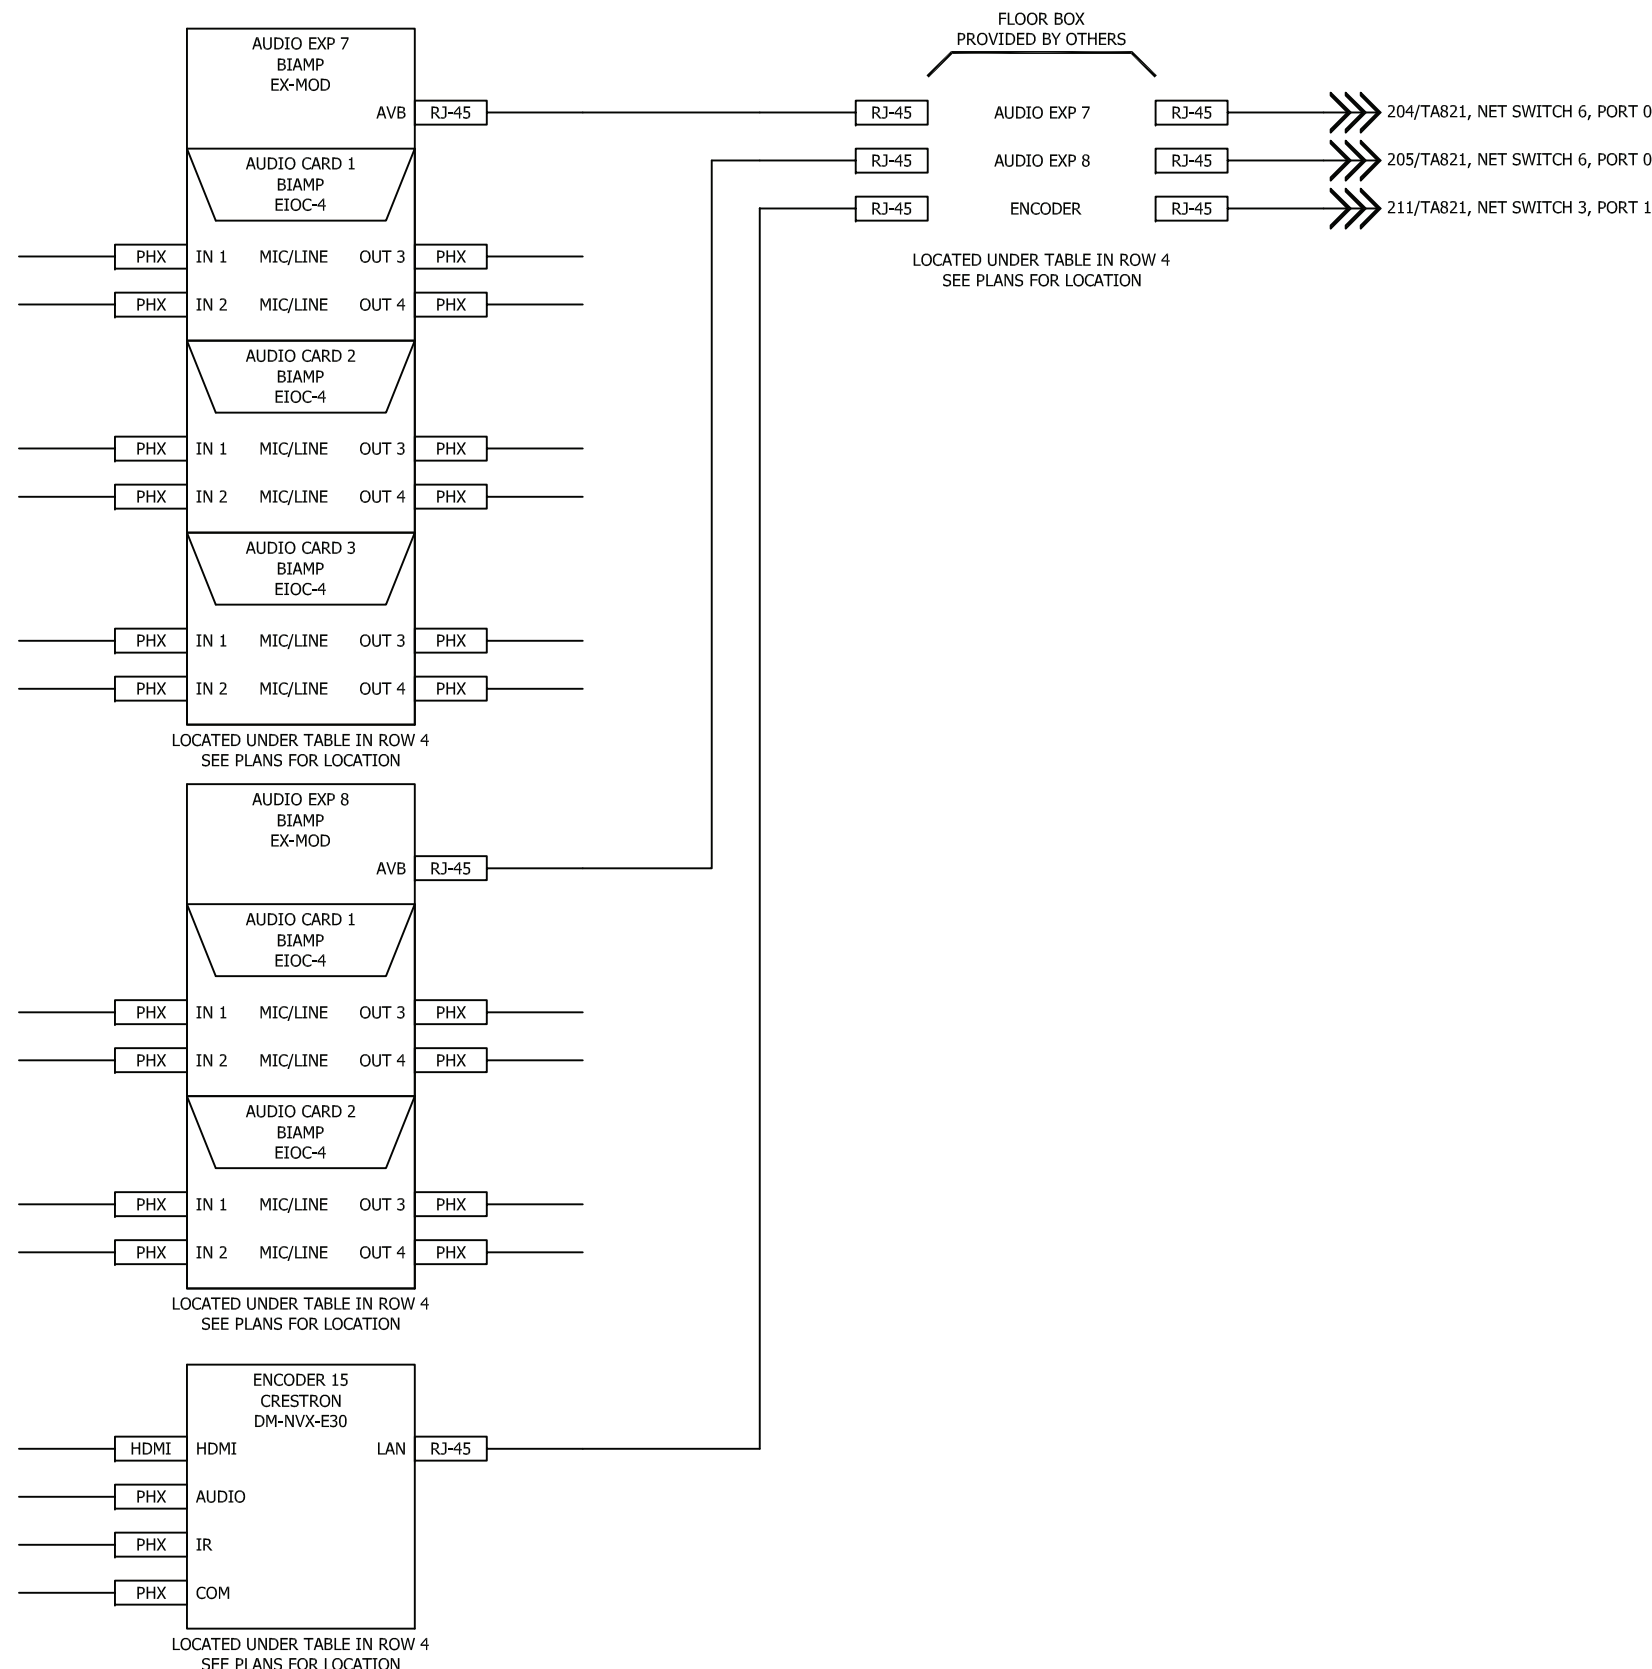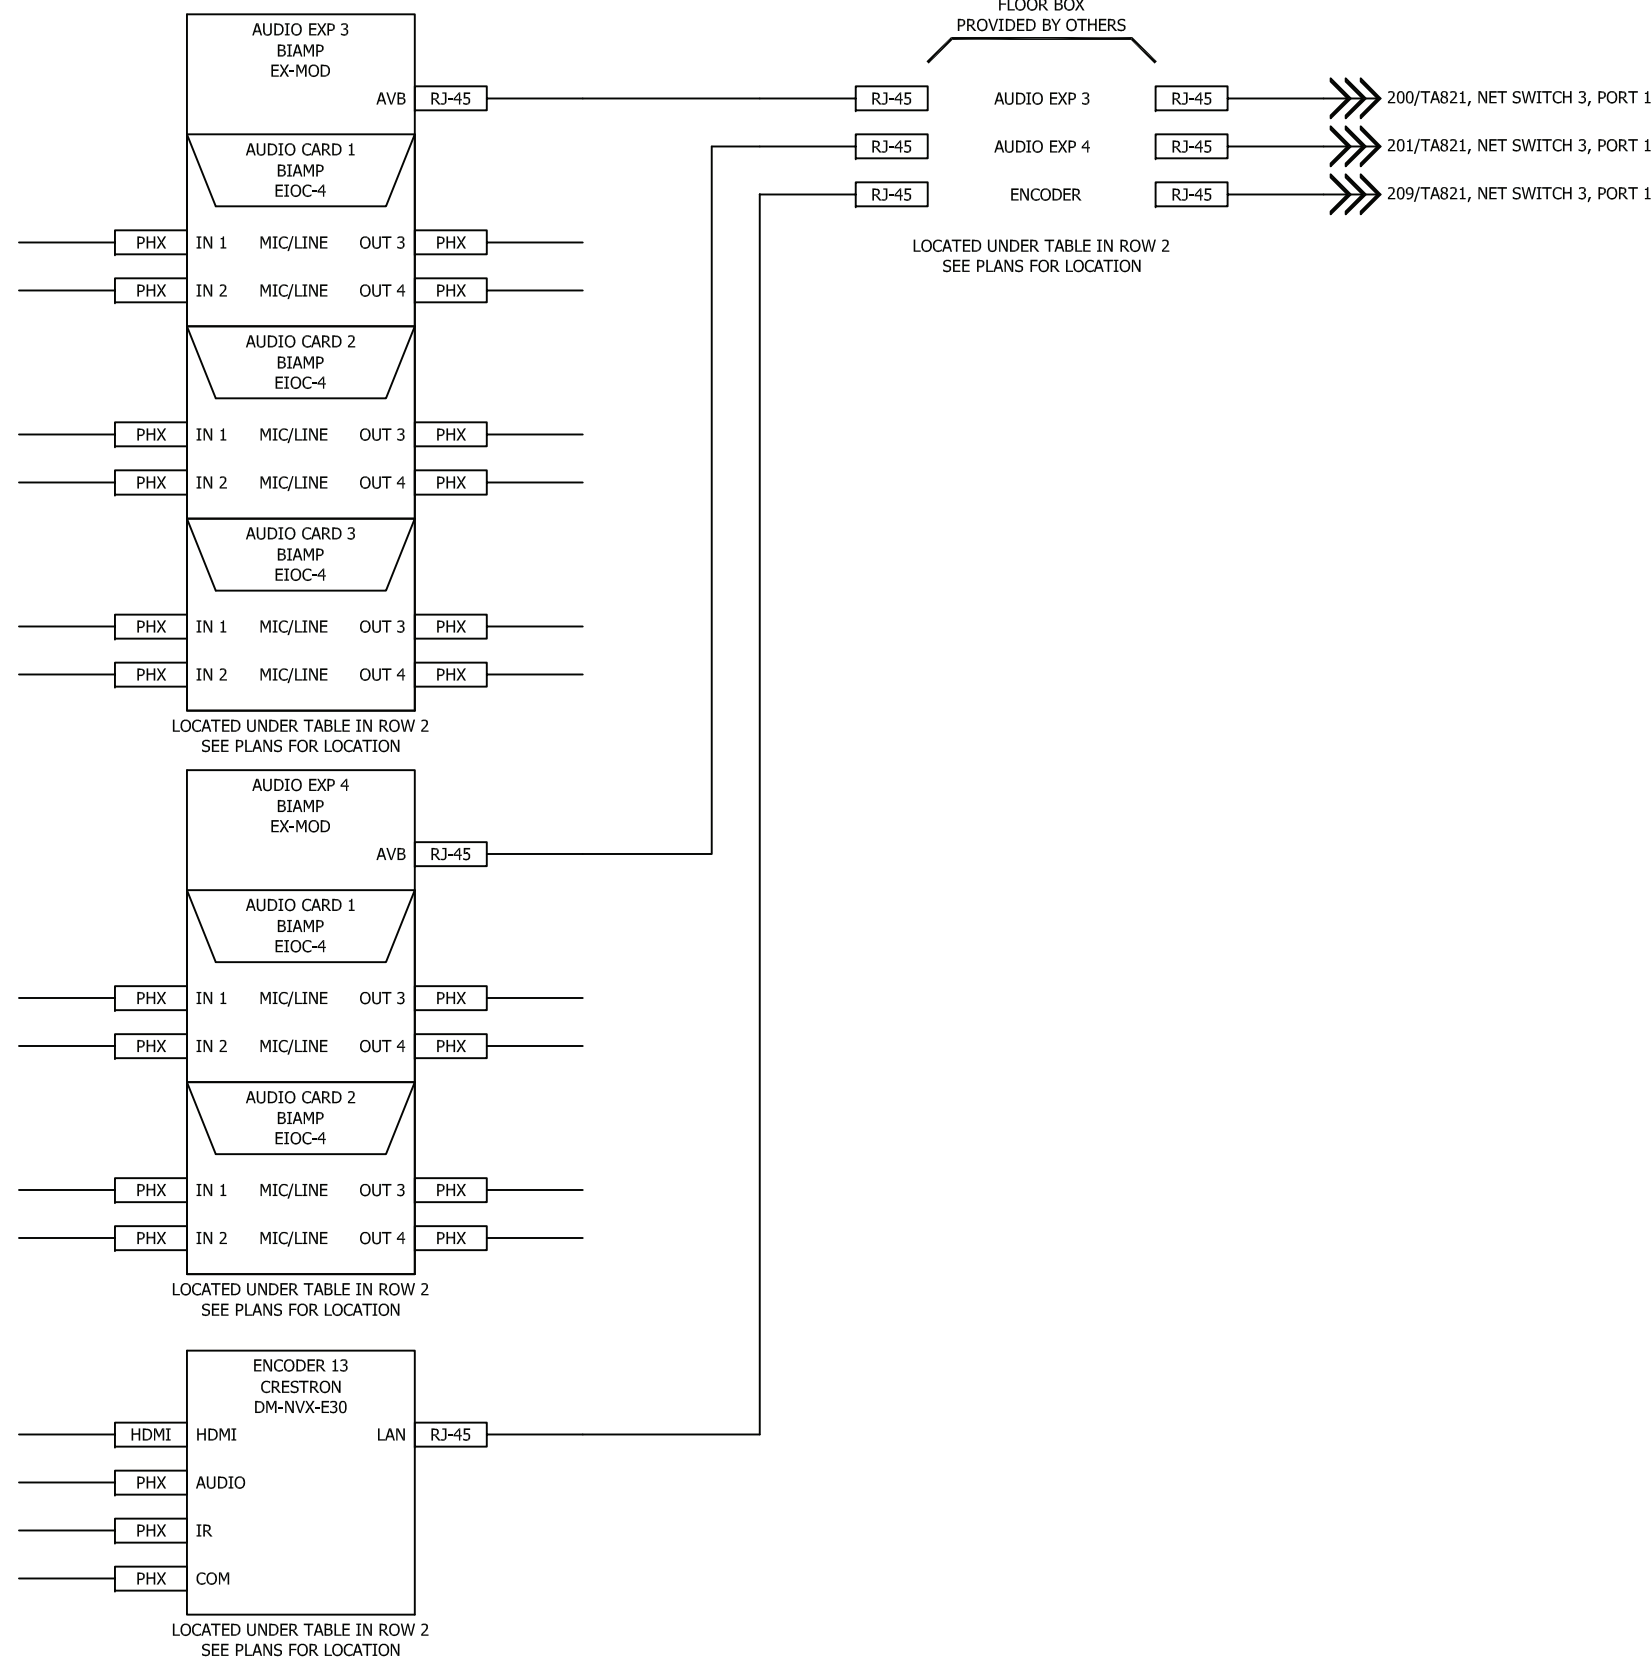

5

SYN	DESCRIPTION	DATE	APPR



PRELIMINARY
Not for construction



Michael Baker
INTERNATIONAL
100 AIRSIDE DRIVE
MOON TOWNSHIP, PA 15108
APPROVED

FOR COMMANDER NAVFAC
ACTIVITY
**MARINE CORPS BASE
CAMP LEJEUNE**
SATISFACTORY TO DATE DD/MM/YY
DES AS DRW AV CHK BM
PM XXX
BRANCH MANAGER XXX
CHIEF ENGINEER XXX
FIRE PROTECTION XXX

DEPARTMENT OF THE NAVY
NAVAL FACILITIES ENGINEERING COMMAND ~ MID-ATLANTIC
ROCCC FLORENCE CAMP LEJEUNE
JACKSONVILLE, NC
JACKSONVILLE, NC
P1338F II MEF SIMULATION/TRAINING CENTER
REPLACEMENT
EXERCISE CONTROL 202 SYSTEM DRAWING
RE-FINAL SUBMISSION

SCALE: NTS
EPROJECT NO.:
CONSTR. CONTR. NO.: N40085-20-C-0059
NAVFAC DRAWING NO.:
SHEET OF


TA820

DP2 SUBMISSION - P1338 BUILDING RE-FINAL SUBMISSION

UNCLASSIFIED





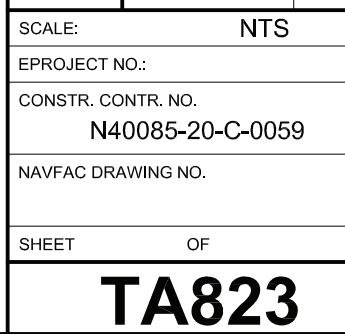

5

5

A

DP2 SUBMISSION – P1338 BUILDING PRE-FINAL SUBMISSION

[illegible]

PRELIMINARY
NOT FOR CONSTRUCTION




Michael Baker
INTERNATIONAL
100 AIRSIDE DRIVE
MOON TOWNSHIP, PA 15106
APPROVED

FOR COMMANDER NAVFAC			
ACTIVITY			
MARINE CORPS BASE CAMP LEJEUNE			
SATISFACTORY TO DATE		DD/MM/YY	
DES AS	DRW AV	CHK	BM
PM		XXX	
BRANCH MANAGER		XXX	
CHIEF ENGI/ARCH		XXX	
FIRE PROTECTION		XXX	

DEPARTMENT OF THE NAVY NAVAL FACILITIES ENGINEERING COMMAND ~ MID-ATLANTIC ROICC FLORENCE CAMP LEJEUNE MCB CAMP LEJEUNE JACKSONVILLE, NC	NAVAL FACILITIES ENGINEERING COMMAND JACKSONVILLE, NC
--	--

SCALE:	NTS
EPROJECT NO.:	
CONSTR. CONTR. NO. N40085-20-C-0059	
NAVFAC DRAWING NO.	
SHEET	OF
TA824	

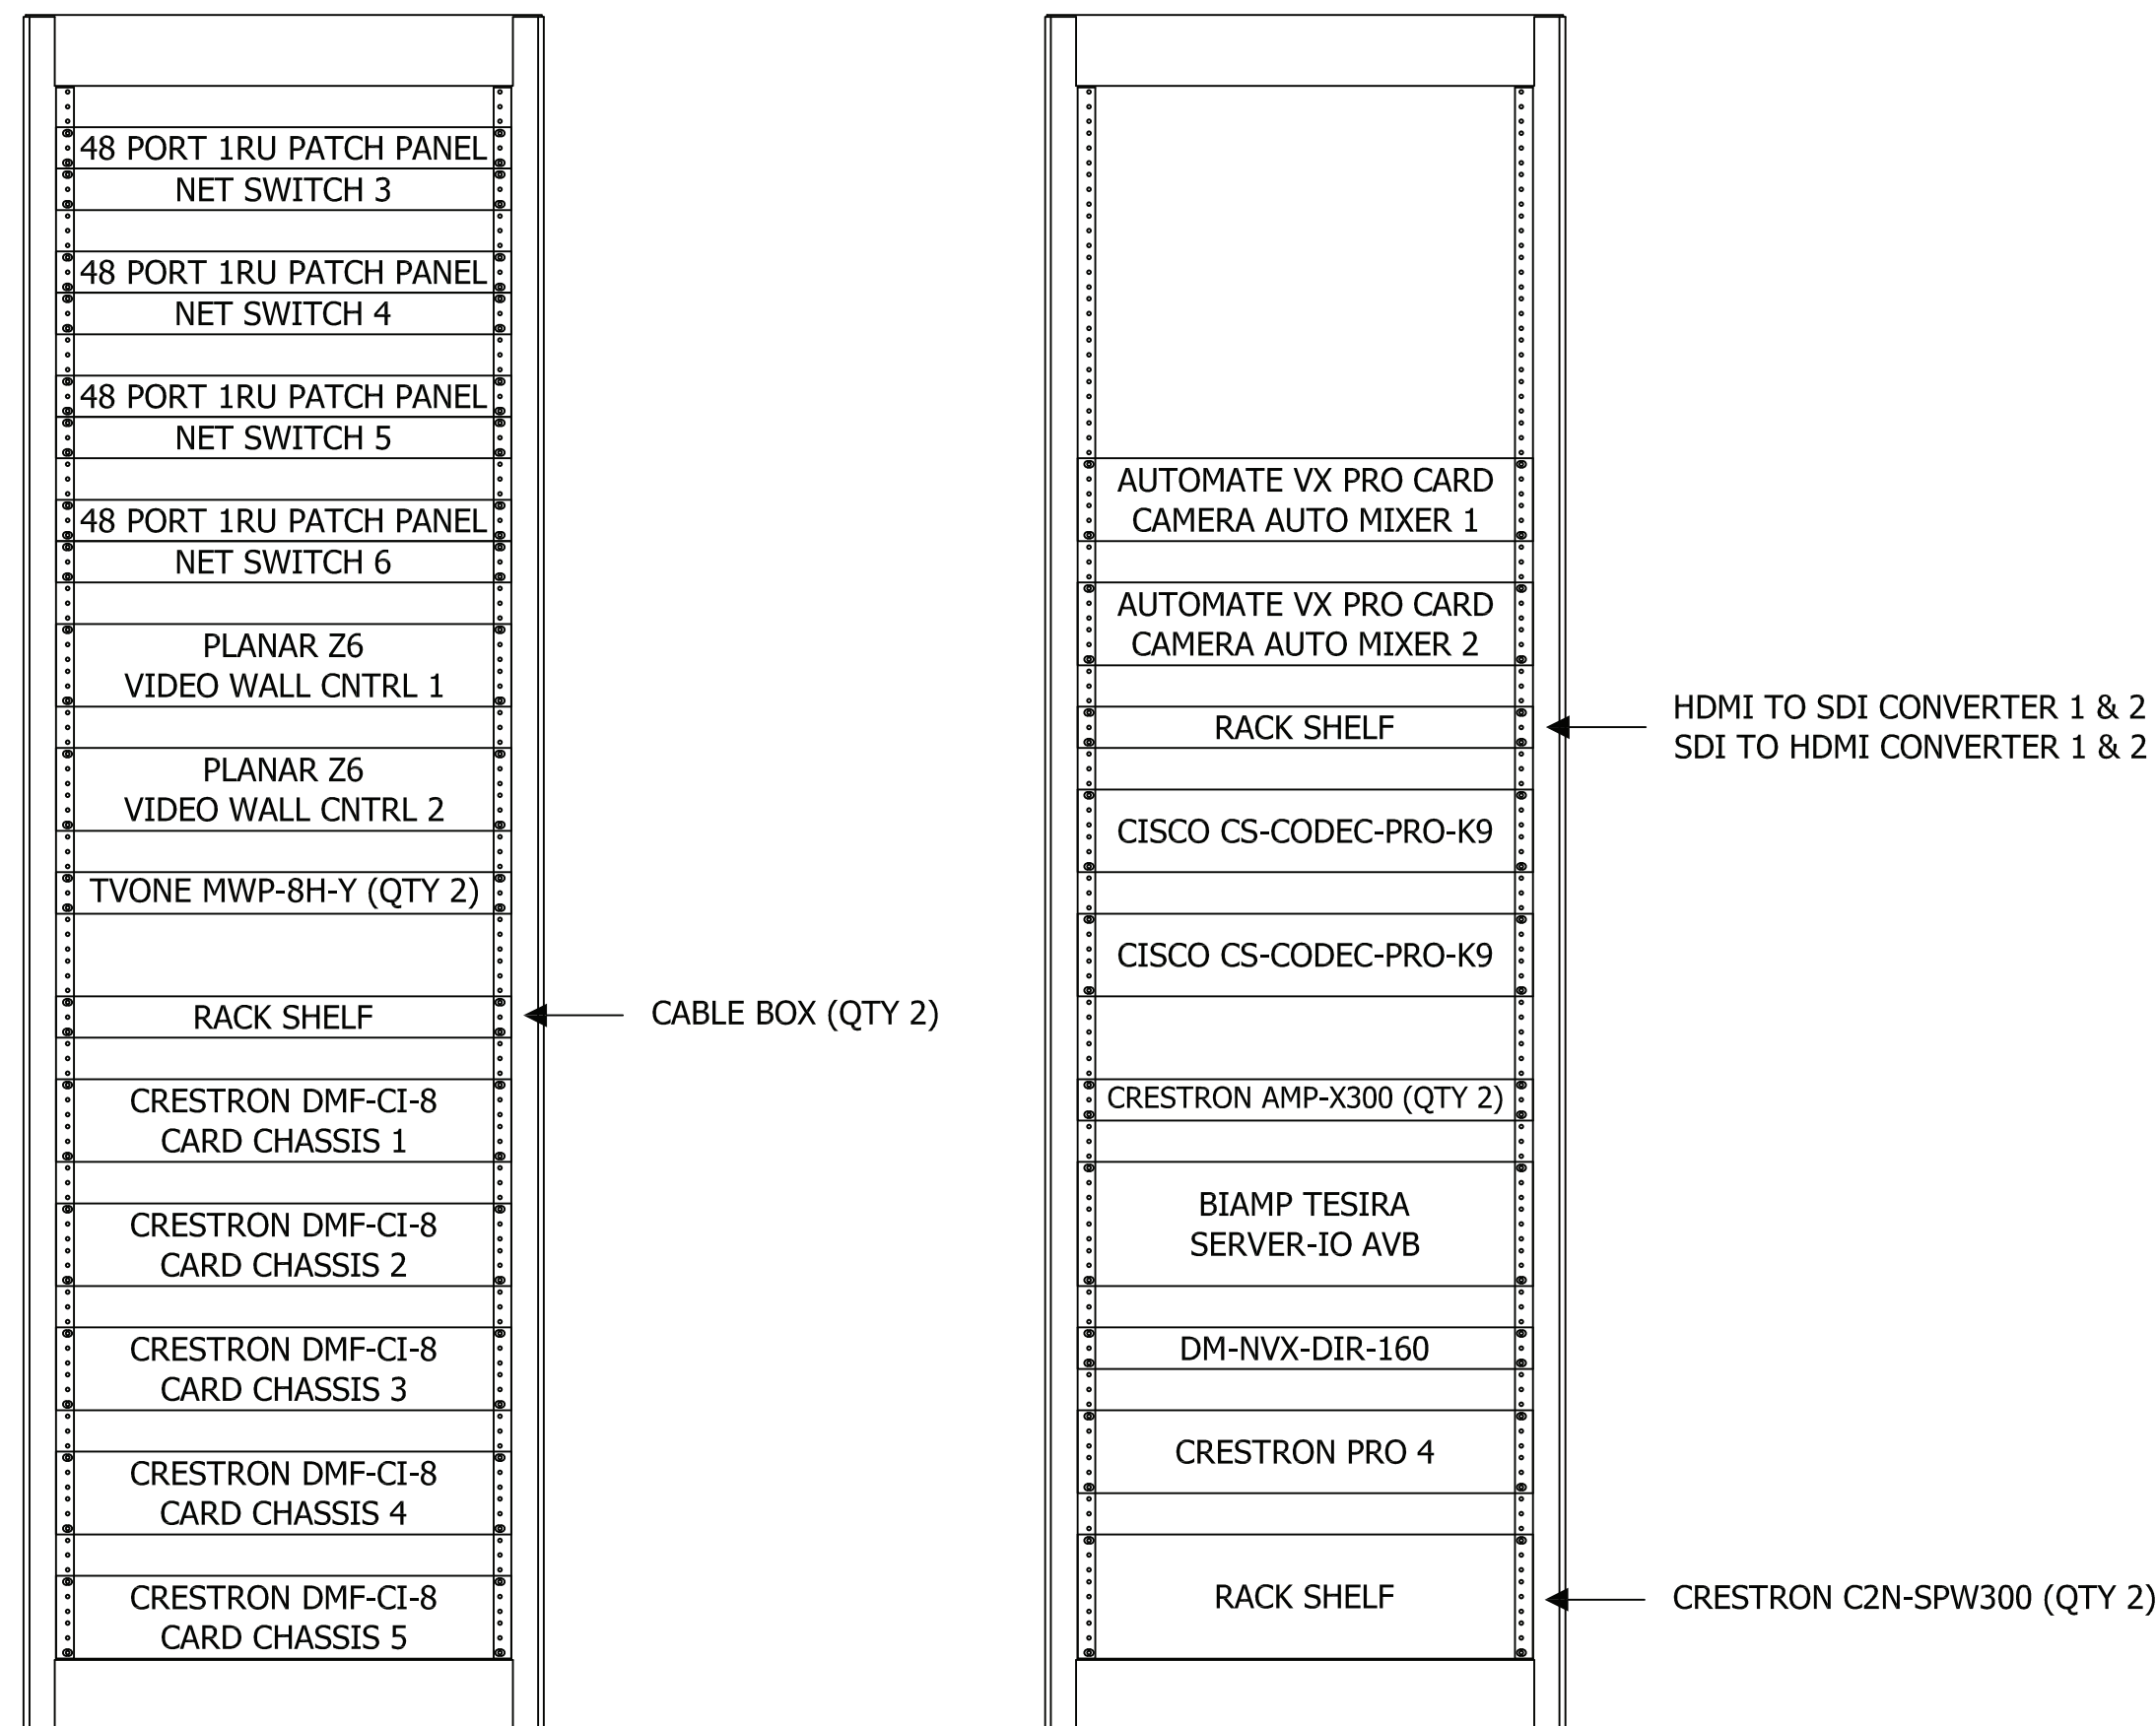

1 SIM CONTROL 304A
Scale: 1 1/2"=1'-0"


5

D

C

B

PRE-1A

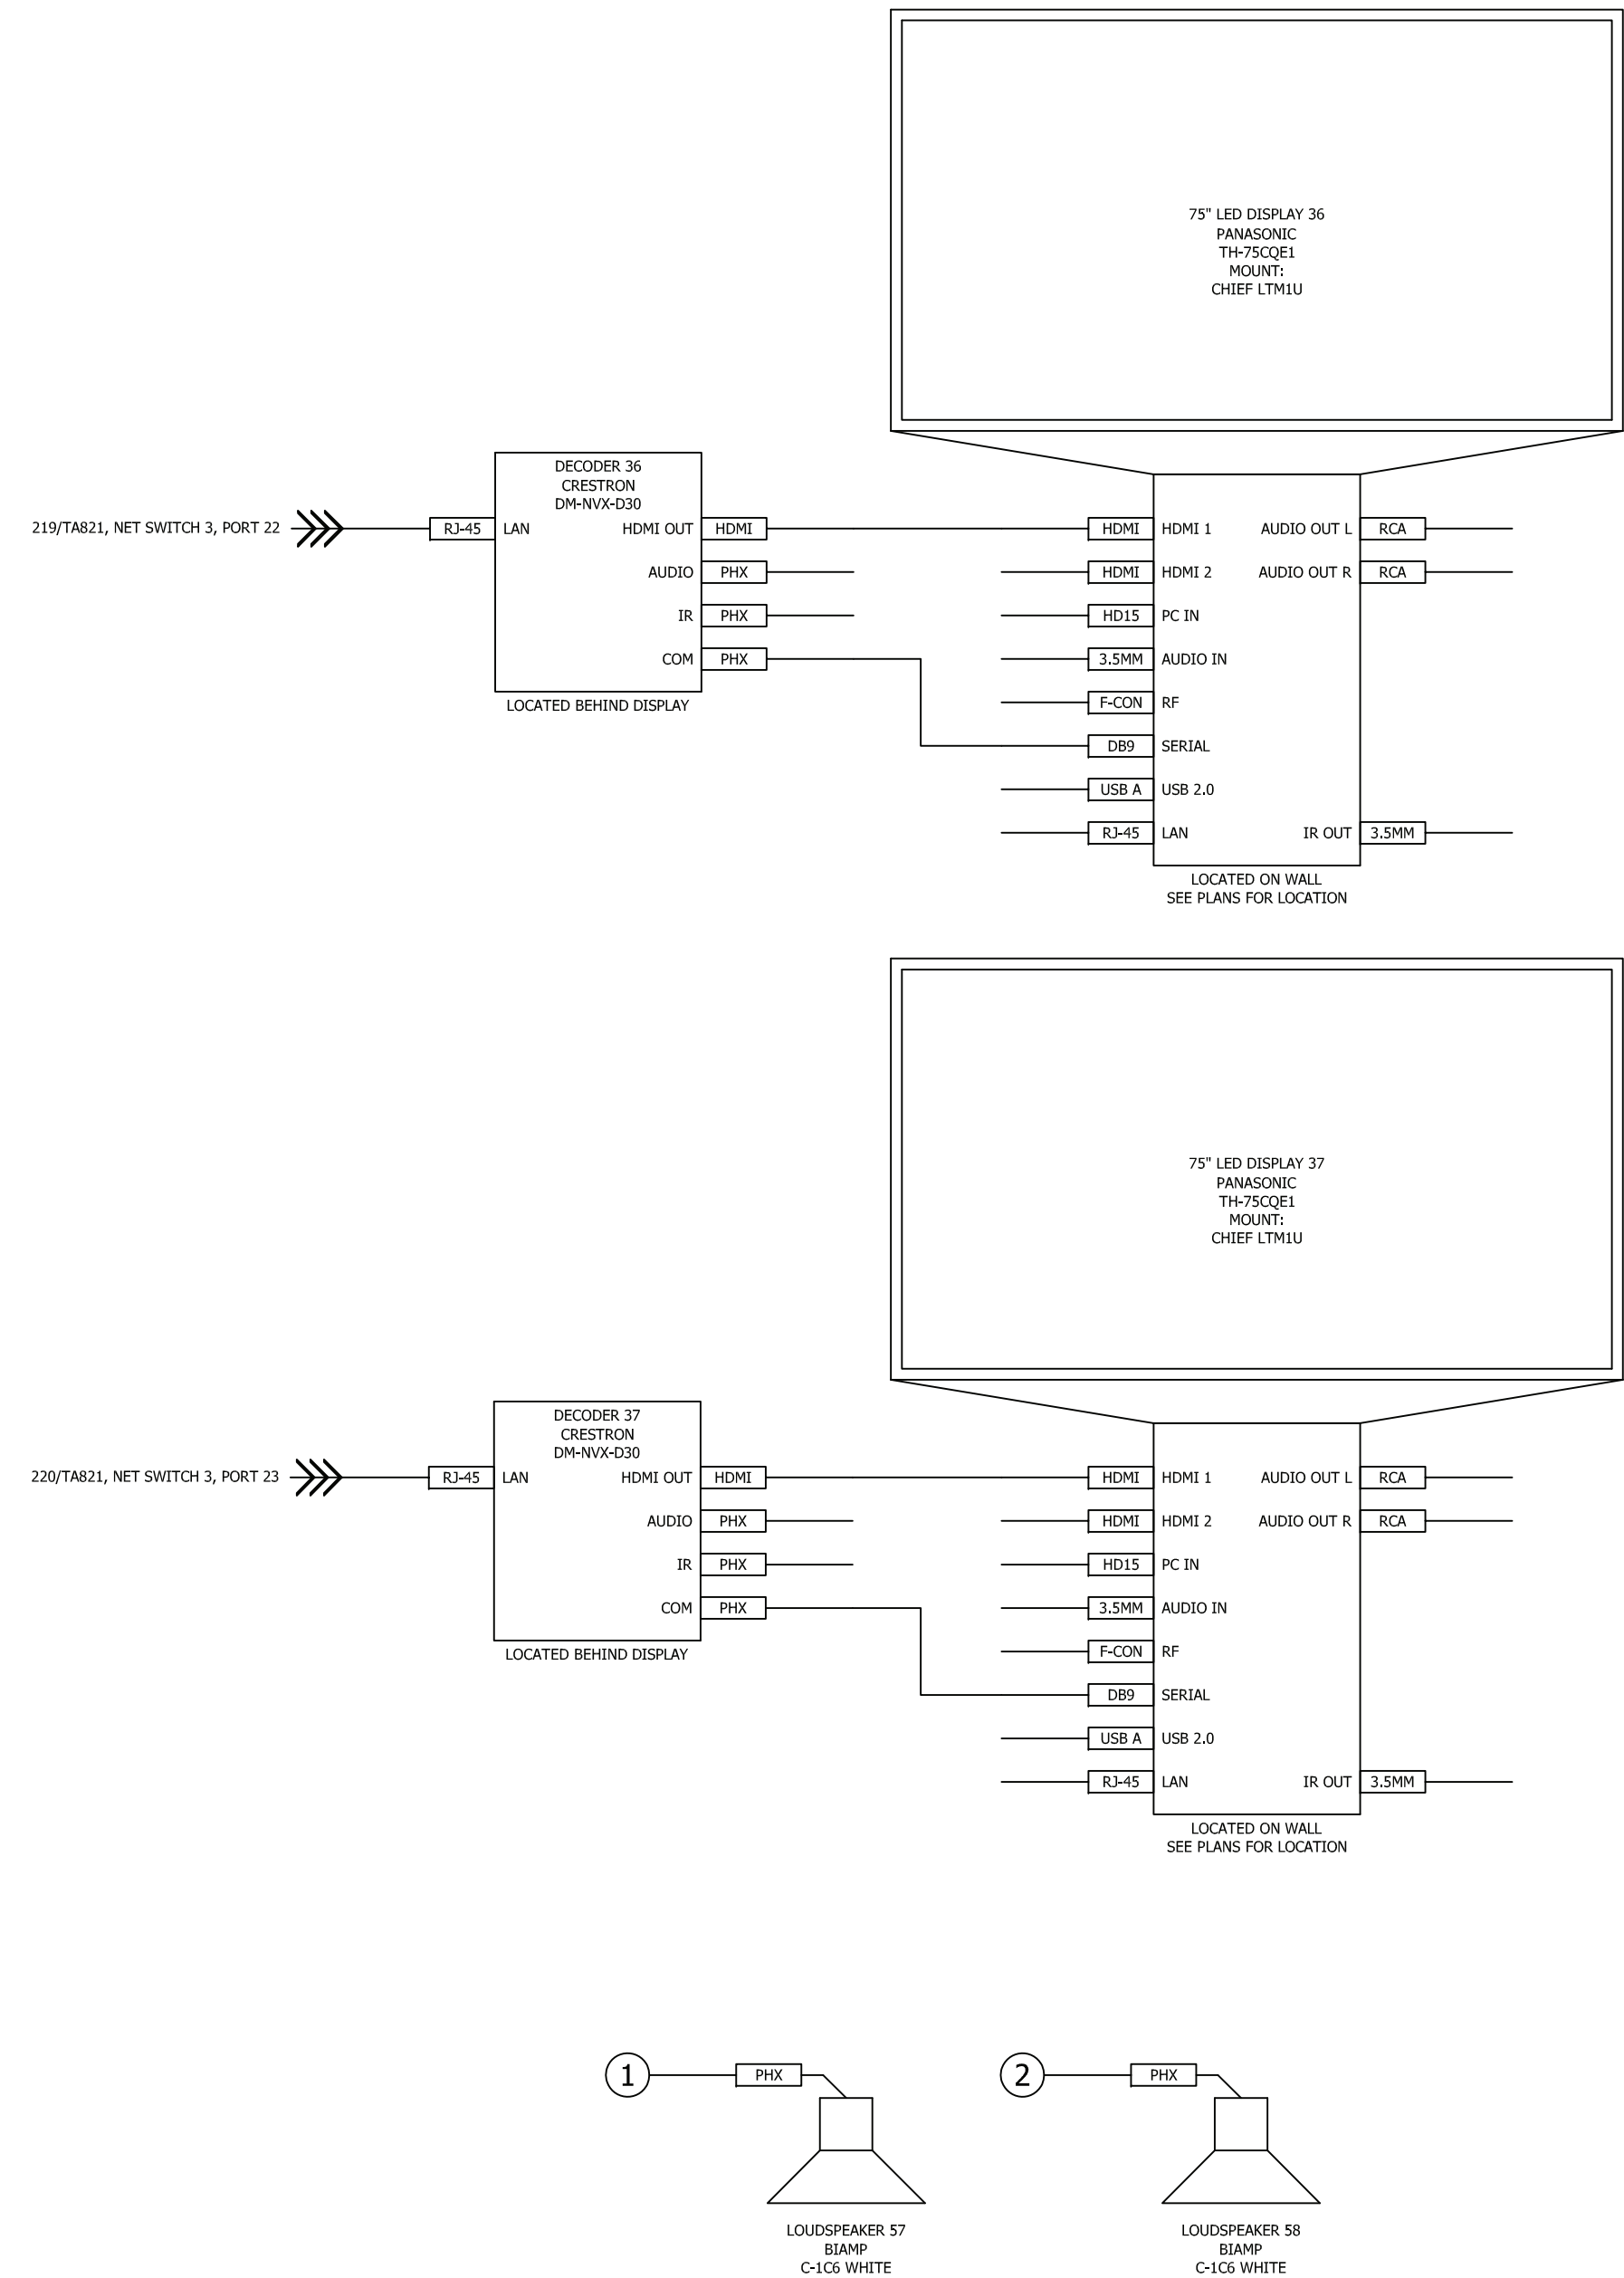[illegible]